


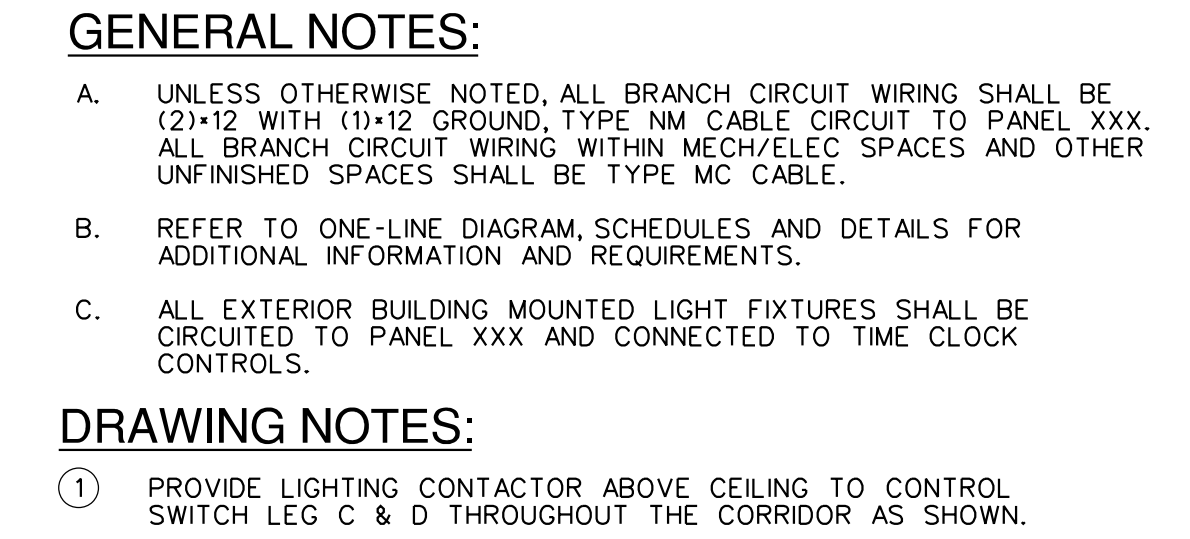

INTRODUCTION:

DESIGNED BY: CJE
DRAWN BY: CJE
CHECKED BY: RSA
SCALE: AS NOTED
NOTES:

FIRST FLOOR ELECTRICAL LIGHTING PLAN

ARCHITECTS, P.C.
252 WASHINGTON AVENUE, ALBANY, NEW YORK 12210

ELDOR ADULT CARE FACILITY
156 WEST CLARKSTOWN ROAD
NEW CITY N.Y. 10956



NO₂

E202

BID SET 9-18-20	OF:
-----------------	-----

CIRCUIT DEVICES ON THIS SIDE TO PANEL 'P1-1' UNLESS OTHERWISE NOTED	CIRCUIT DEVICES ON THIS SIDE TO PANEL 'P1-3' UNLESS OTHERWISE NOTED
---	---

FIRST FLOOR PLAN
SCALE: 1/8"=1'-0"

