


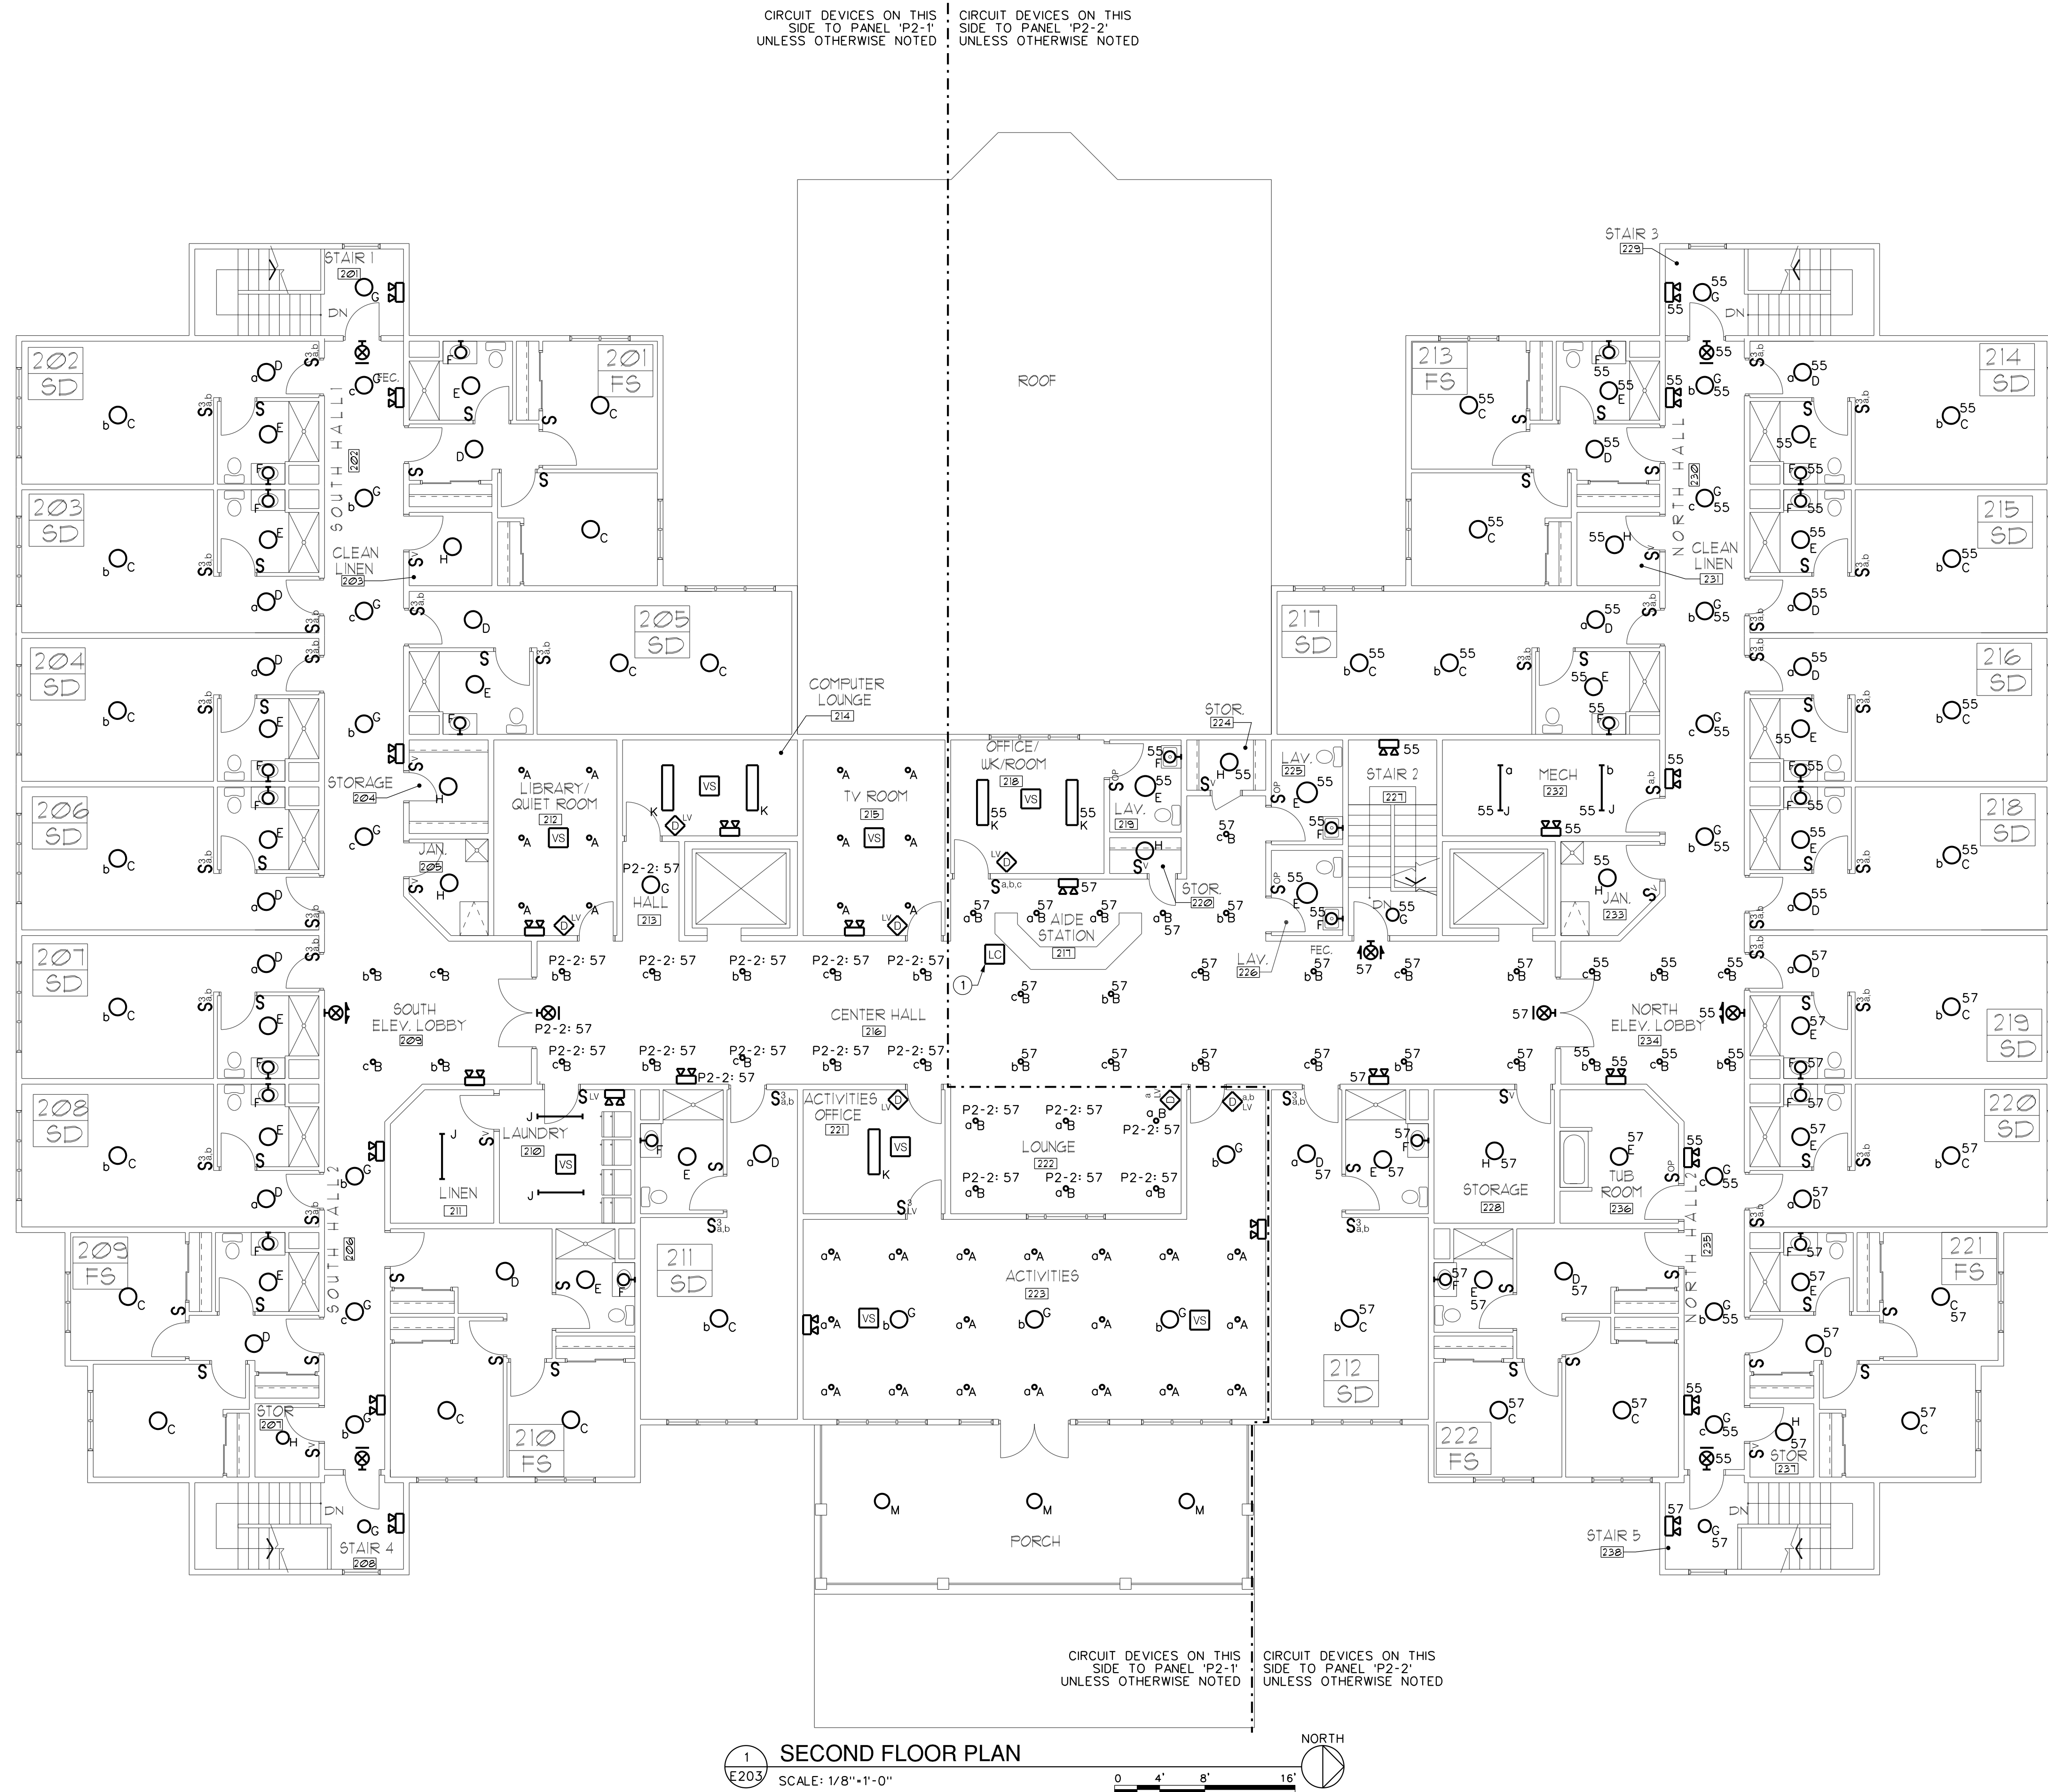


GENERAL NOTES:

- A. UNLESS OTHERWISE NOTED, ALL BRANCH CIRCUIT WIRING SHALL BE (2)X12 WITH (1)X12 GROUND, TYPE NM CABLE CIRCUIT TO PANEL XXX. ALL BRANCH CIRCUIT WIRING WITHIN MECH/ELEC SPACES AND OTHER UNFINISHED SPACES SHALL BE TYPE MC CABLE.
- B. REFER TO ONE-LINE DIAGRAM, SCHEDULES AND DETAILS FOR ADDITIONAL INFORMATION AND REQUIREMENTS.
- C. ALL EXTERIOR BUILDING MOUNTED LIGHT FIXTURES SHALL BE CIRCUITED TO PANEL XXX AND CONNECTED TO TIME CLOCK CONTROLS.

DRAWING NOTES:

- 1 PROVIDE LIGHTING CONTACTOR ABOVE CEILING TO CONTROL SWITCH LEG C & D THROUGHOUT THE CORRIDOR AS SHOWN.

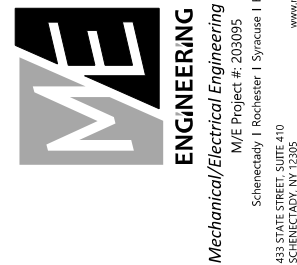

DATE: 9/18/2020
REVISION:

PROJECT NO. 200095
DESIGNED BY: CUE
DRAWN BY: CUE
CHECKED BY: RSA
SCALE: AS NOTED
NOTES:

SECOND FLOOR PLAN
ELECTRICAL LIGHTING PLAN

HARRIS A. SANDERS
ARCHITECTS, P.C.
252 WASHINGTON AVENUE, ALBANY, NEW YORK 12210

L'DOR ADULT CARE FACILITY
156 WEST CLARKSTOWN ROAD
NEW CITY, N.Y. 10956



SHEET NO.

E203