


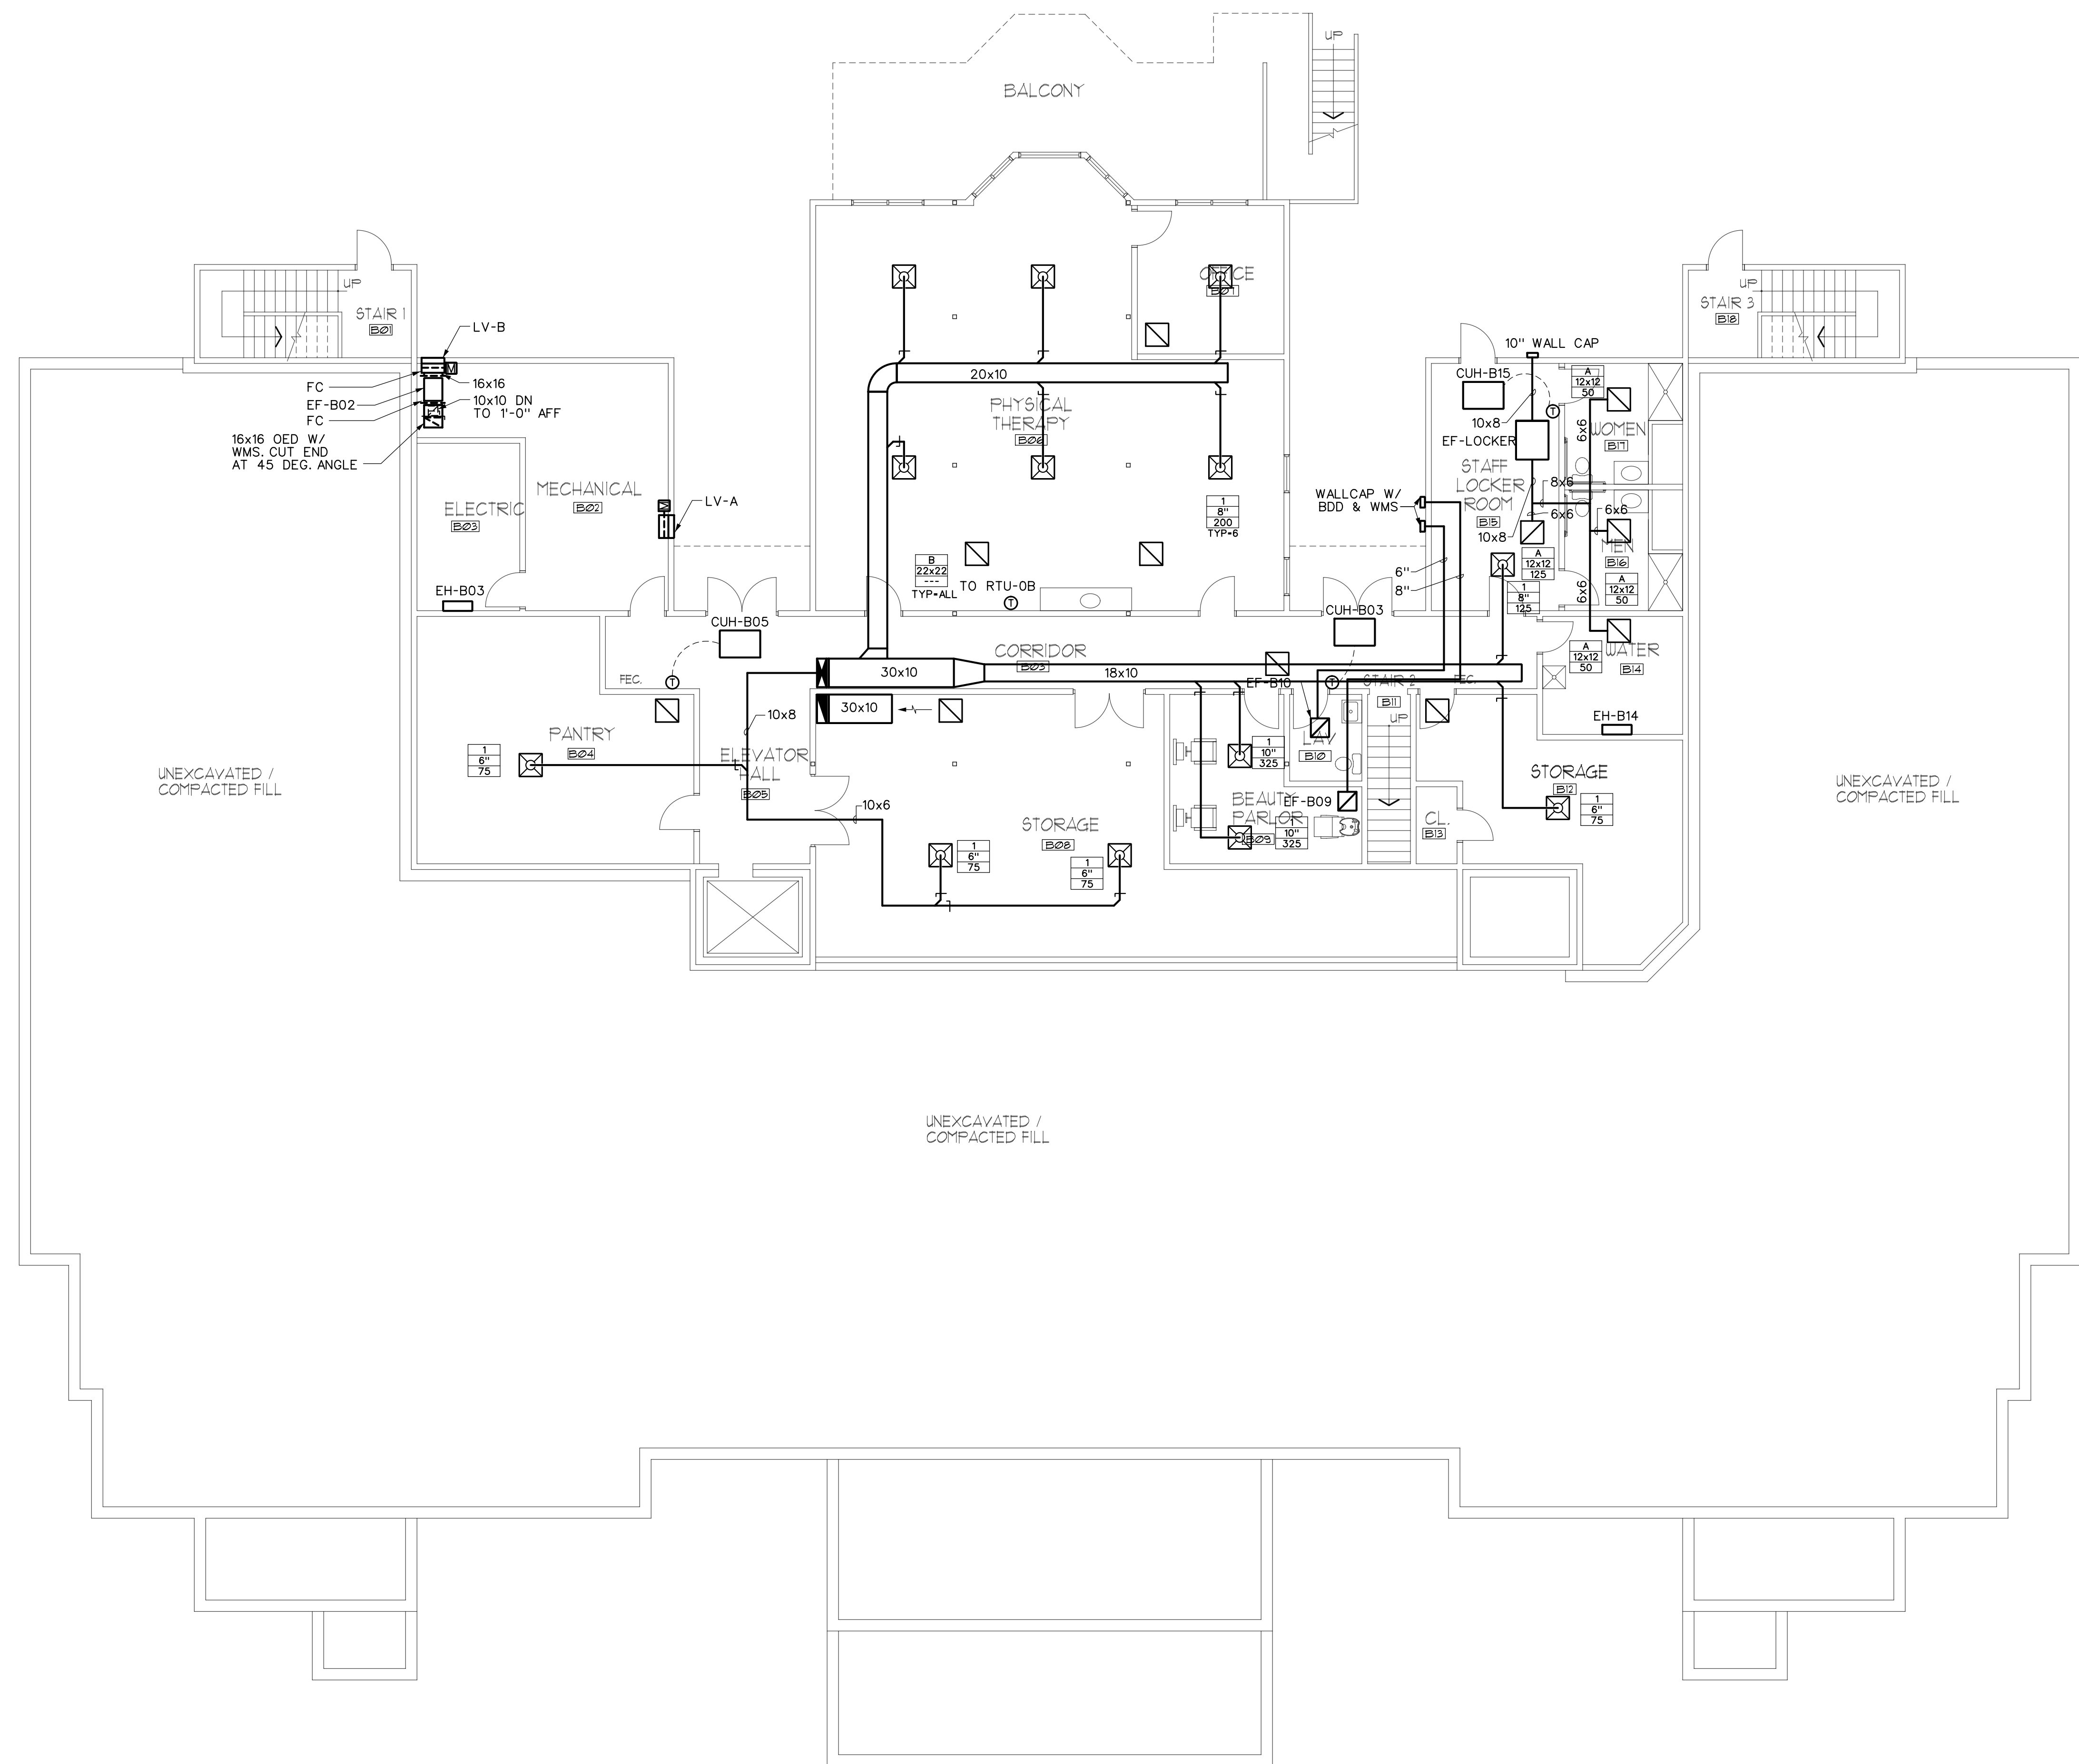

- GENERAL NOTES:
- A. BALANCE OUTSIDE AIR CONNECTION TO ALL FAN COILS AT 50 CFM.
 - B. PROVIDE CEILING RADIATION DAMPERS WHERE PENETRATING FIRE RATED ASSEMBLY.



DATE: 8/18/2000
REVISION:

PROJECT NO.	200095
DESIGNED BY	CUE
DRAWN BY	CUE
CHECKED BY	RSA
SCALE	AS NOTED
NOTES	

BASEMENT DUCTWORK PLAN

HARRIS A. SANDERS
ARCHITECTS, P.C.
252 WASHINGTON AVENUE, ALBANY, NEW YORK 12210
L'DOR ADULT CARE FACILITY
156 WEST CLARKSTOWN ROAD
NEW CITY, N.Y. 10956



SHEET NO.

M101

1 BASEMENT FLOOR PLAN
SCALE: 1/8"=1'-0" NORTH