



GENERAL NOTES:
A. BALANCE OUTSIDE AIR CONNECTION TO ALL FAN COILS AT 50 CFM.
B. PROVIDE CEILING RADIATION DAMPERS WHERE PENETRATING FIRE RATED ASSEMBLY.

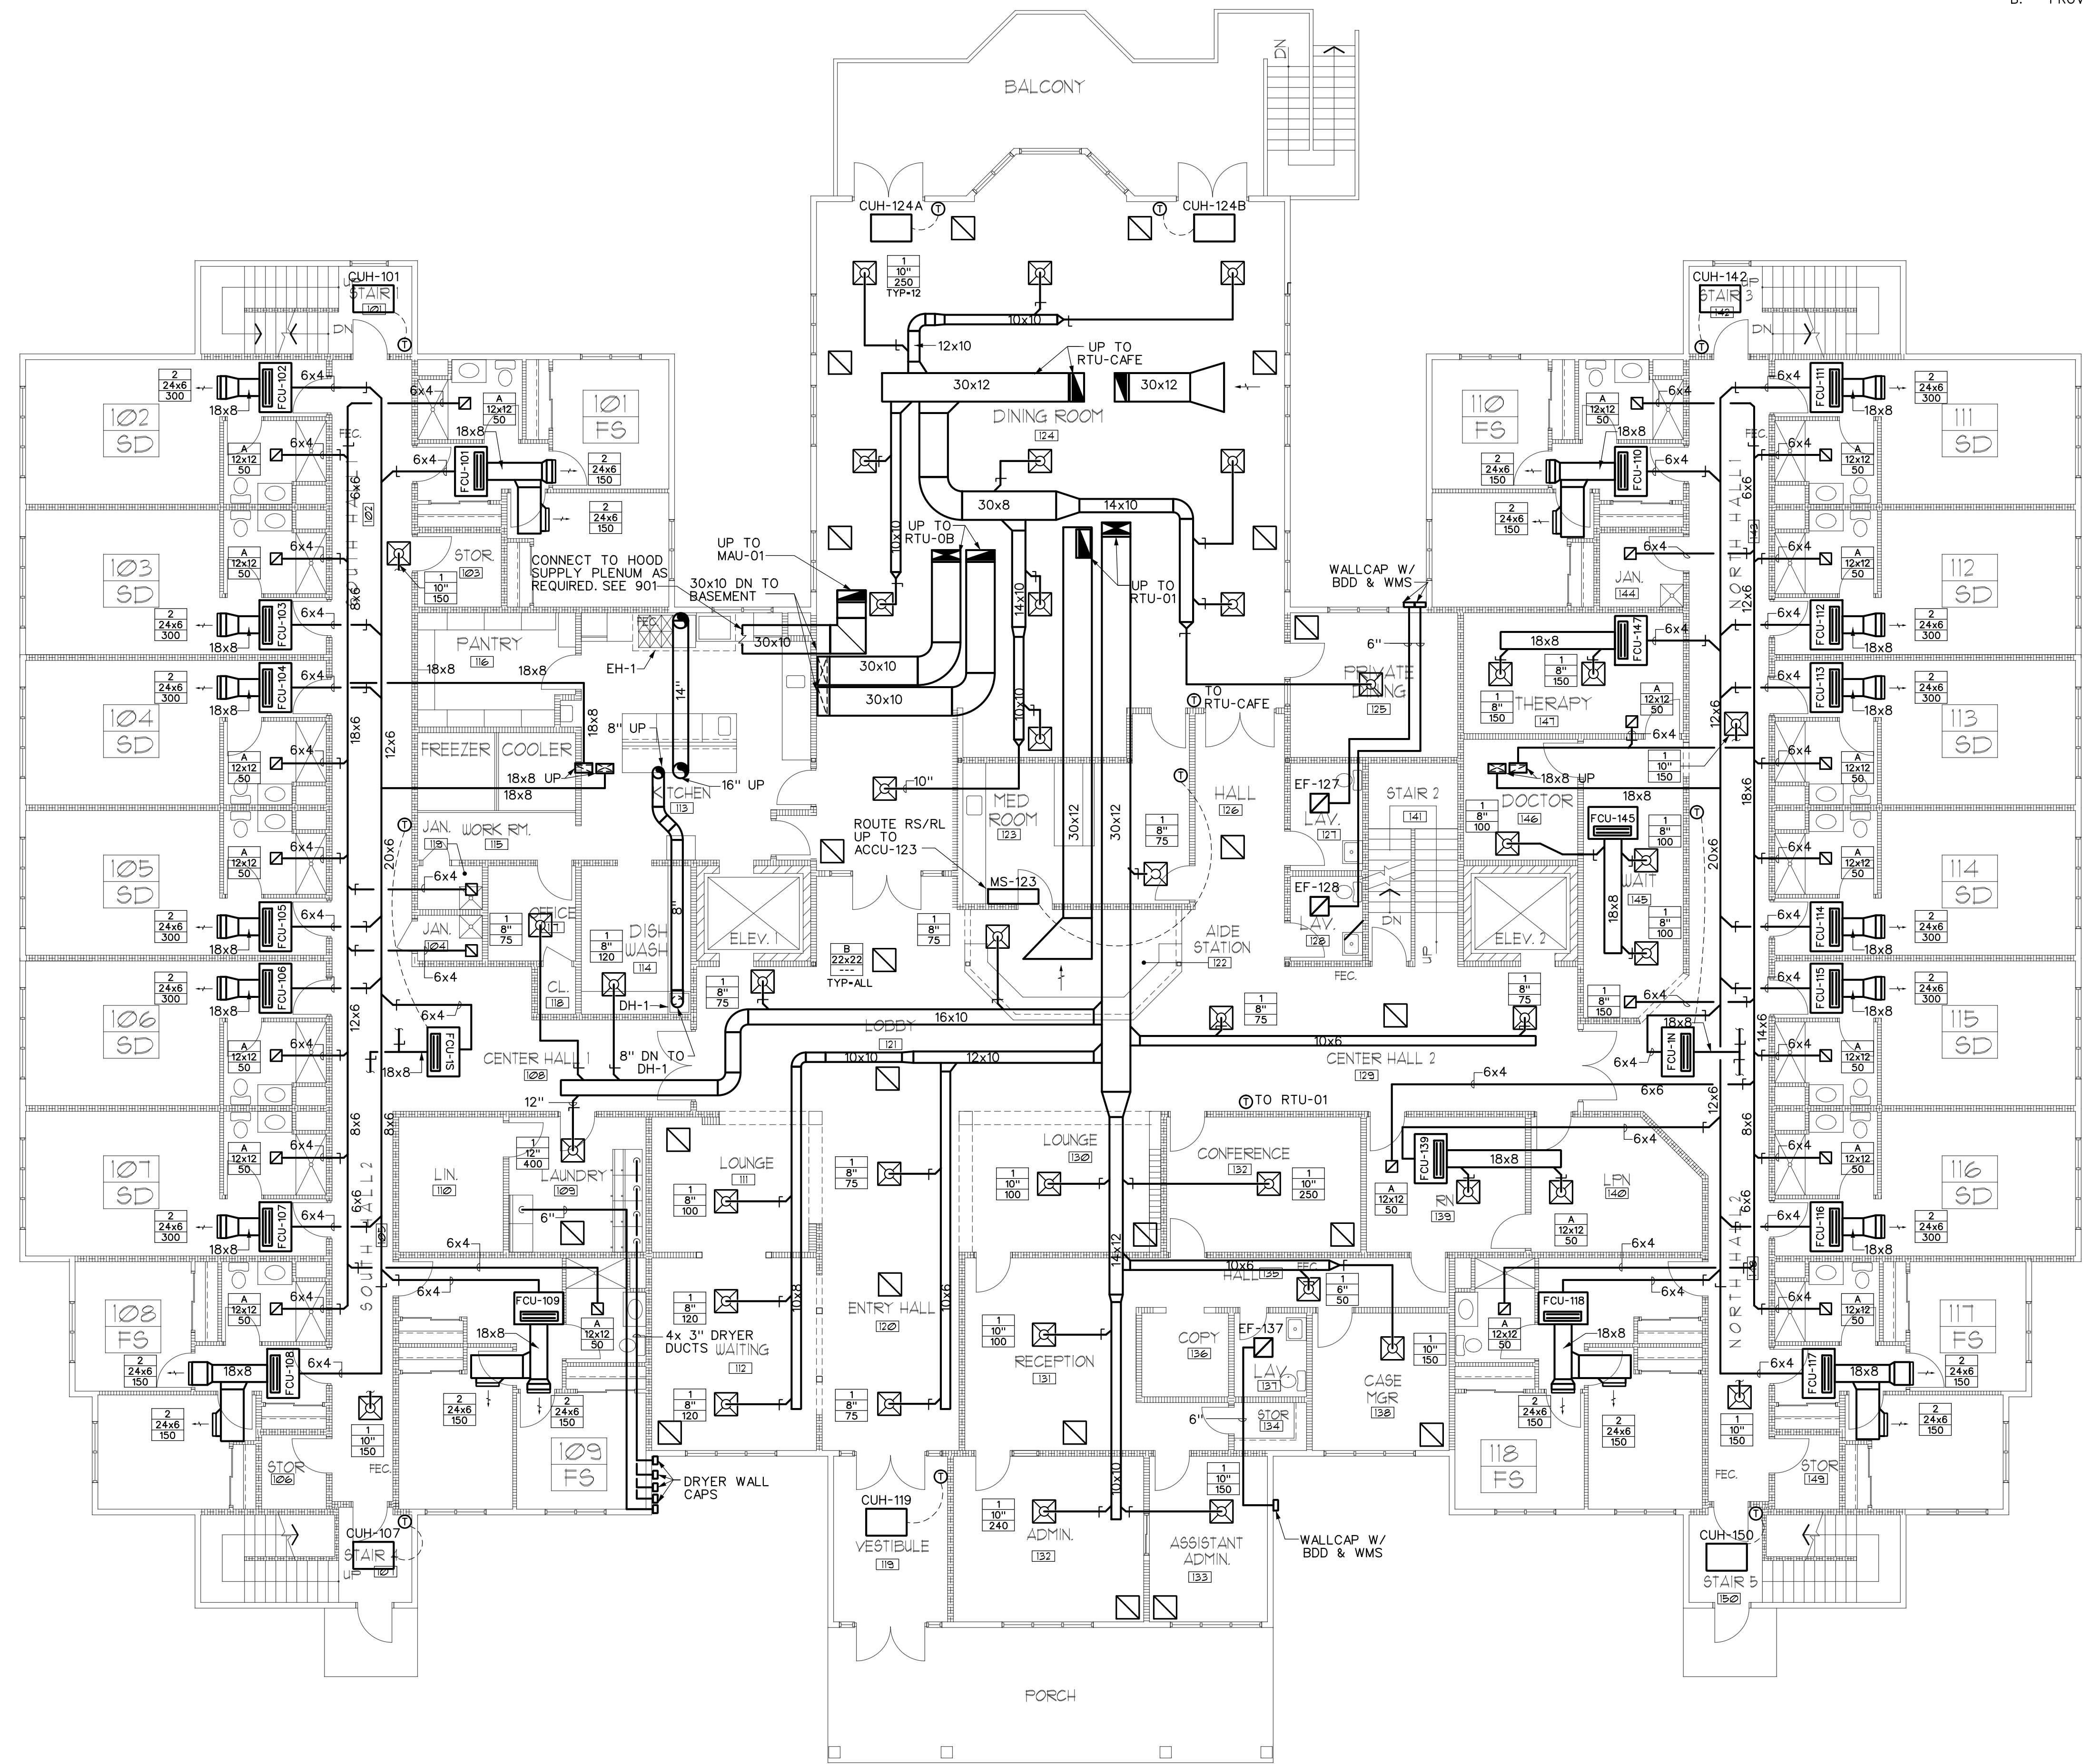

1 FIRST FLOOR PLAN
M102 SCALE: 1/8"=1'-0"

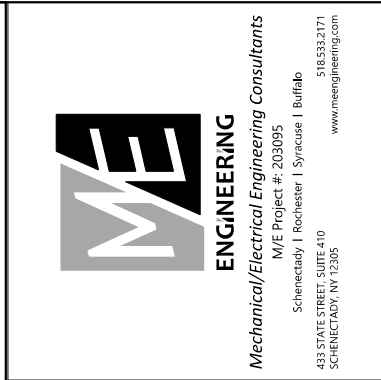

DATE: 9/17/2000
REVISION:

PROJECT NO. 200005
DESIGNED BY: CUE
DRAWN BY: CUE
CHECKED BY: RSA
SCALE: AS NOTED
NOTES:

FIRST FLOOR
DUCTWORK PLAN

HARRIS A. SANDERS
ARCHITECTS, P.C.
252 WASHINGTON AVENUE, ALBANY, NEW YORK 12210
L'DOR ADULT CARE FACILITY
156 WEST CLARKSTOWN ROAD
NEW CITY, N.Y. 10956



SHEET NO.

M102