



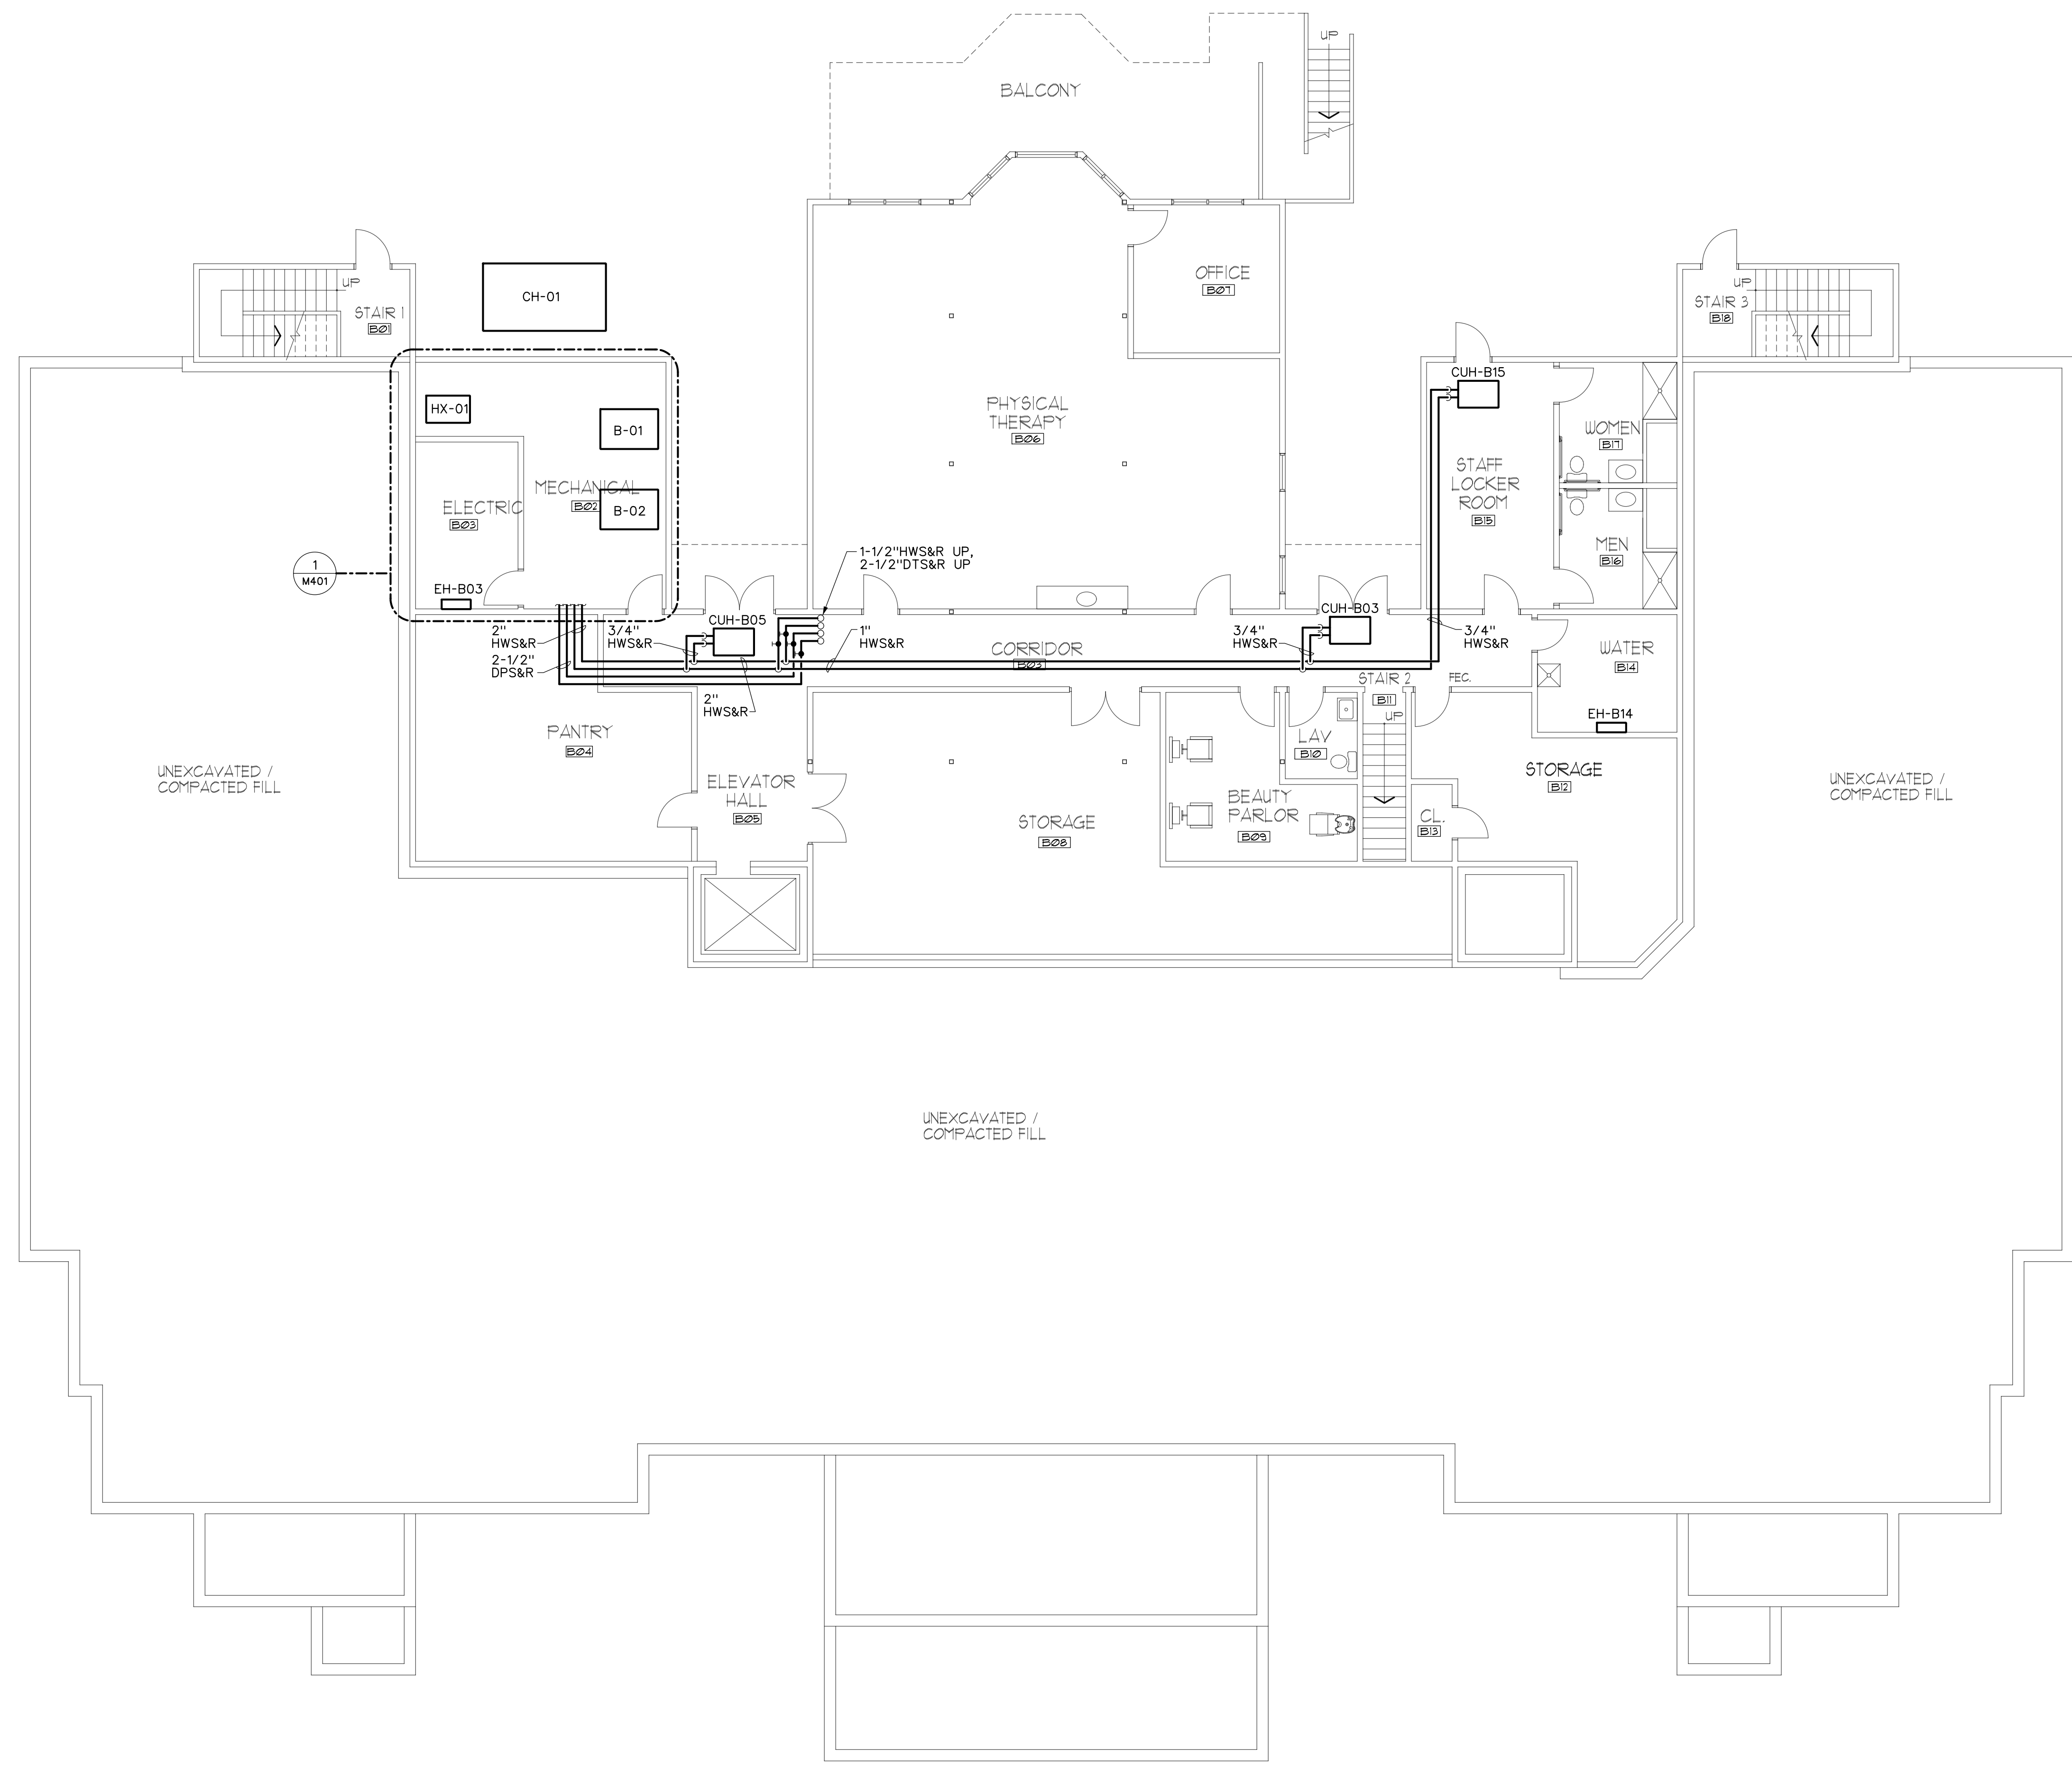

1 BASEMENT MECHANICAL PIPING PLAN
M201 SCALE: 1/8"=1'-0"

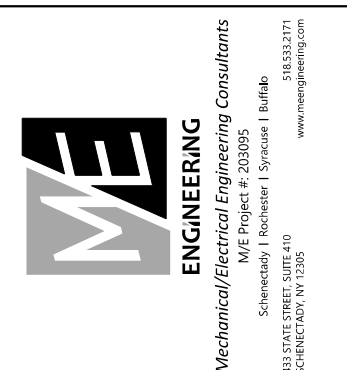

DATE: 8/18/2000
REVISION:

PROJECT NO.	DESIGNED BY	DRAWN BY	CHECKED BY	SCALE	AS NOTED
200005	CUE	CUE	PSA		

BASEMENT MECHANICAL PIPING PLAN

HARRIS A. SANDERS
ARCHITECTS, P.C.
252 WASHINGTON AVENUE, ALBANY, NEW YORK 12210

L'DOR ADULT CARE FACILITY
156 WEST CLARKSTOWN ROAD
NEW CITY, N.Y. 10956



SHEET NO.
M201