

GENERAL NOTES:
A. ROUTE 3/4" CONDENSATE FROM EACH FAN COIL TO NEAREST JANITOR CLOSET.



DATE: 9/19/2020
REVISION:

PROJECT NO. 2020095
DESIGNED BY: CUE
DRAWN BY: CUE
CHECKED BY: PCA
SCALE: AS NOTED
NOTES:


SECOND FLOOR
MECHANICAL PIPING PLAN

HARRIS A. SANDERS
ARCHITECTS, P.C.
252 WASHINGTON AVENUE, ALBANY, NEW YORK 12210
L'DOR ADULT CARE FACILITY
156 WEST CLARKSTOWN ROAD
NEW CITY, N.Y. 10956



SHEET NO.

M203

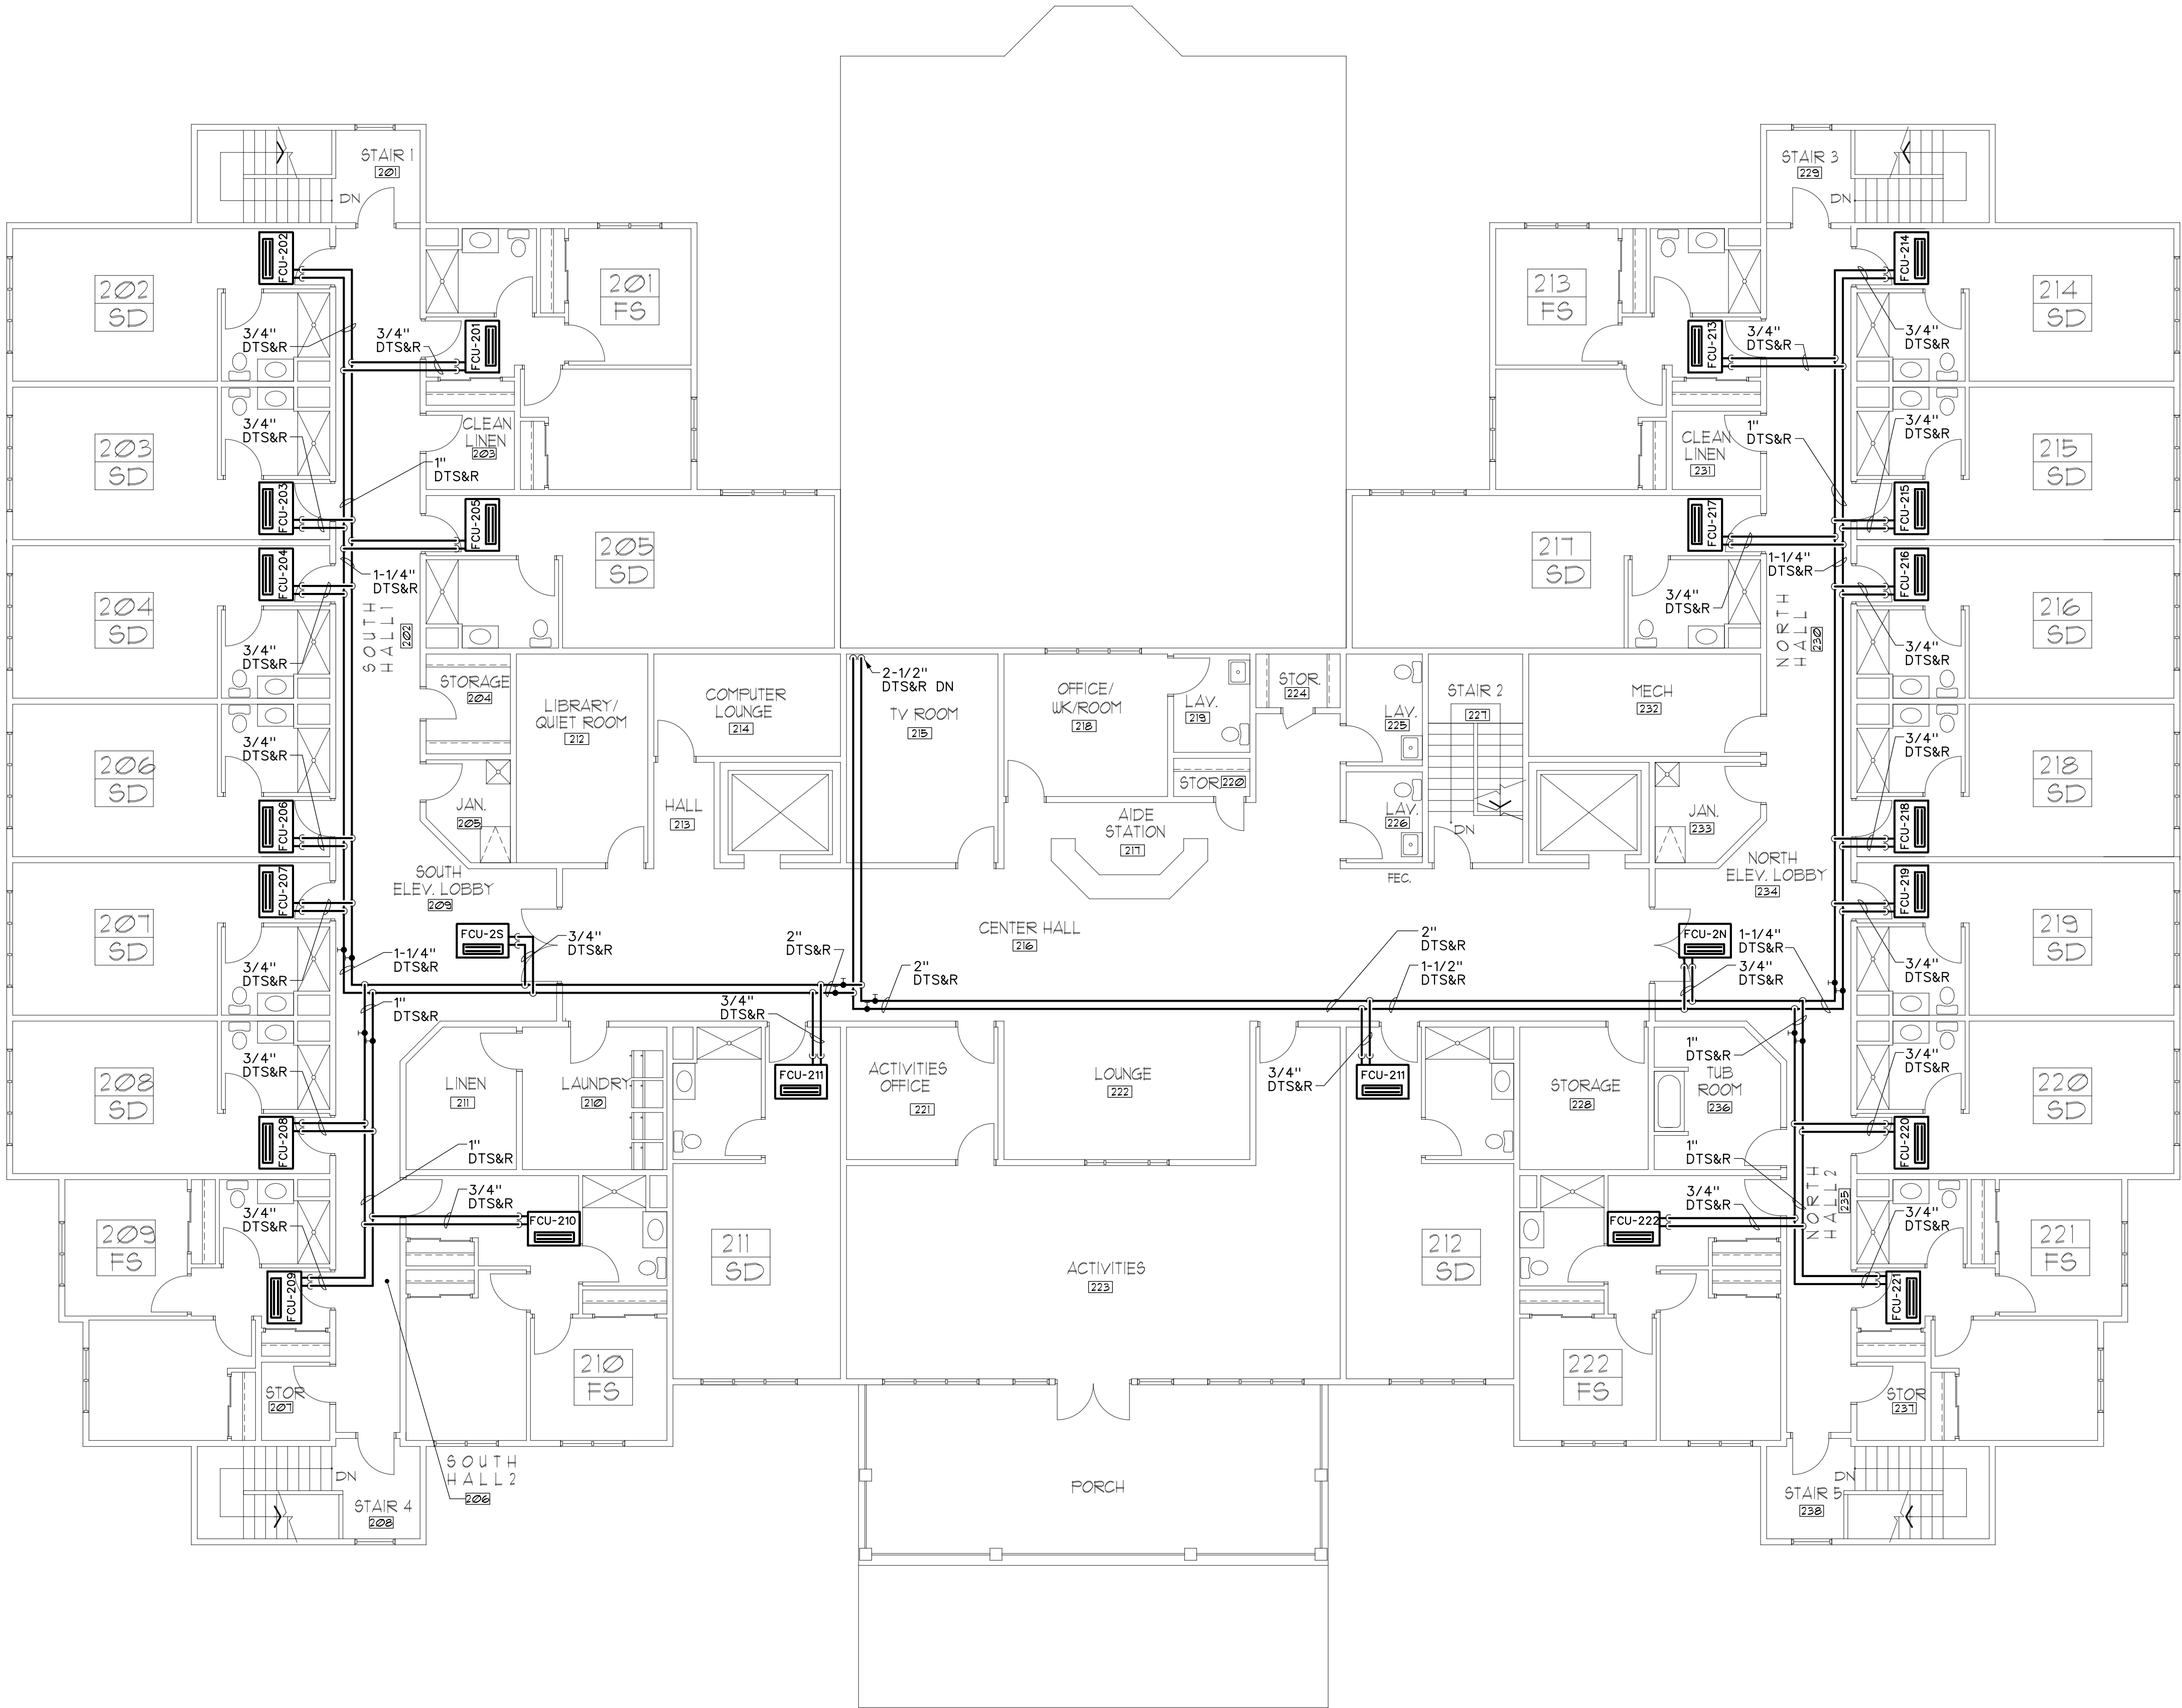

1 SECOND FLOOR MECHANICAL PIPING PLAN
SCALE: 1/8"=1'-0" NORTH