



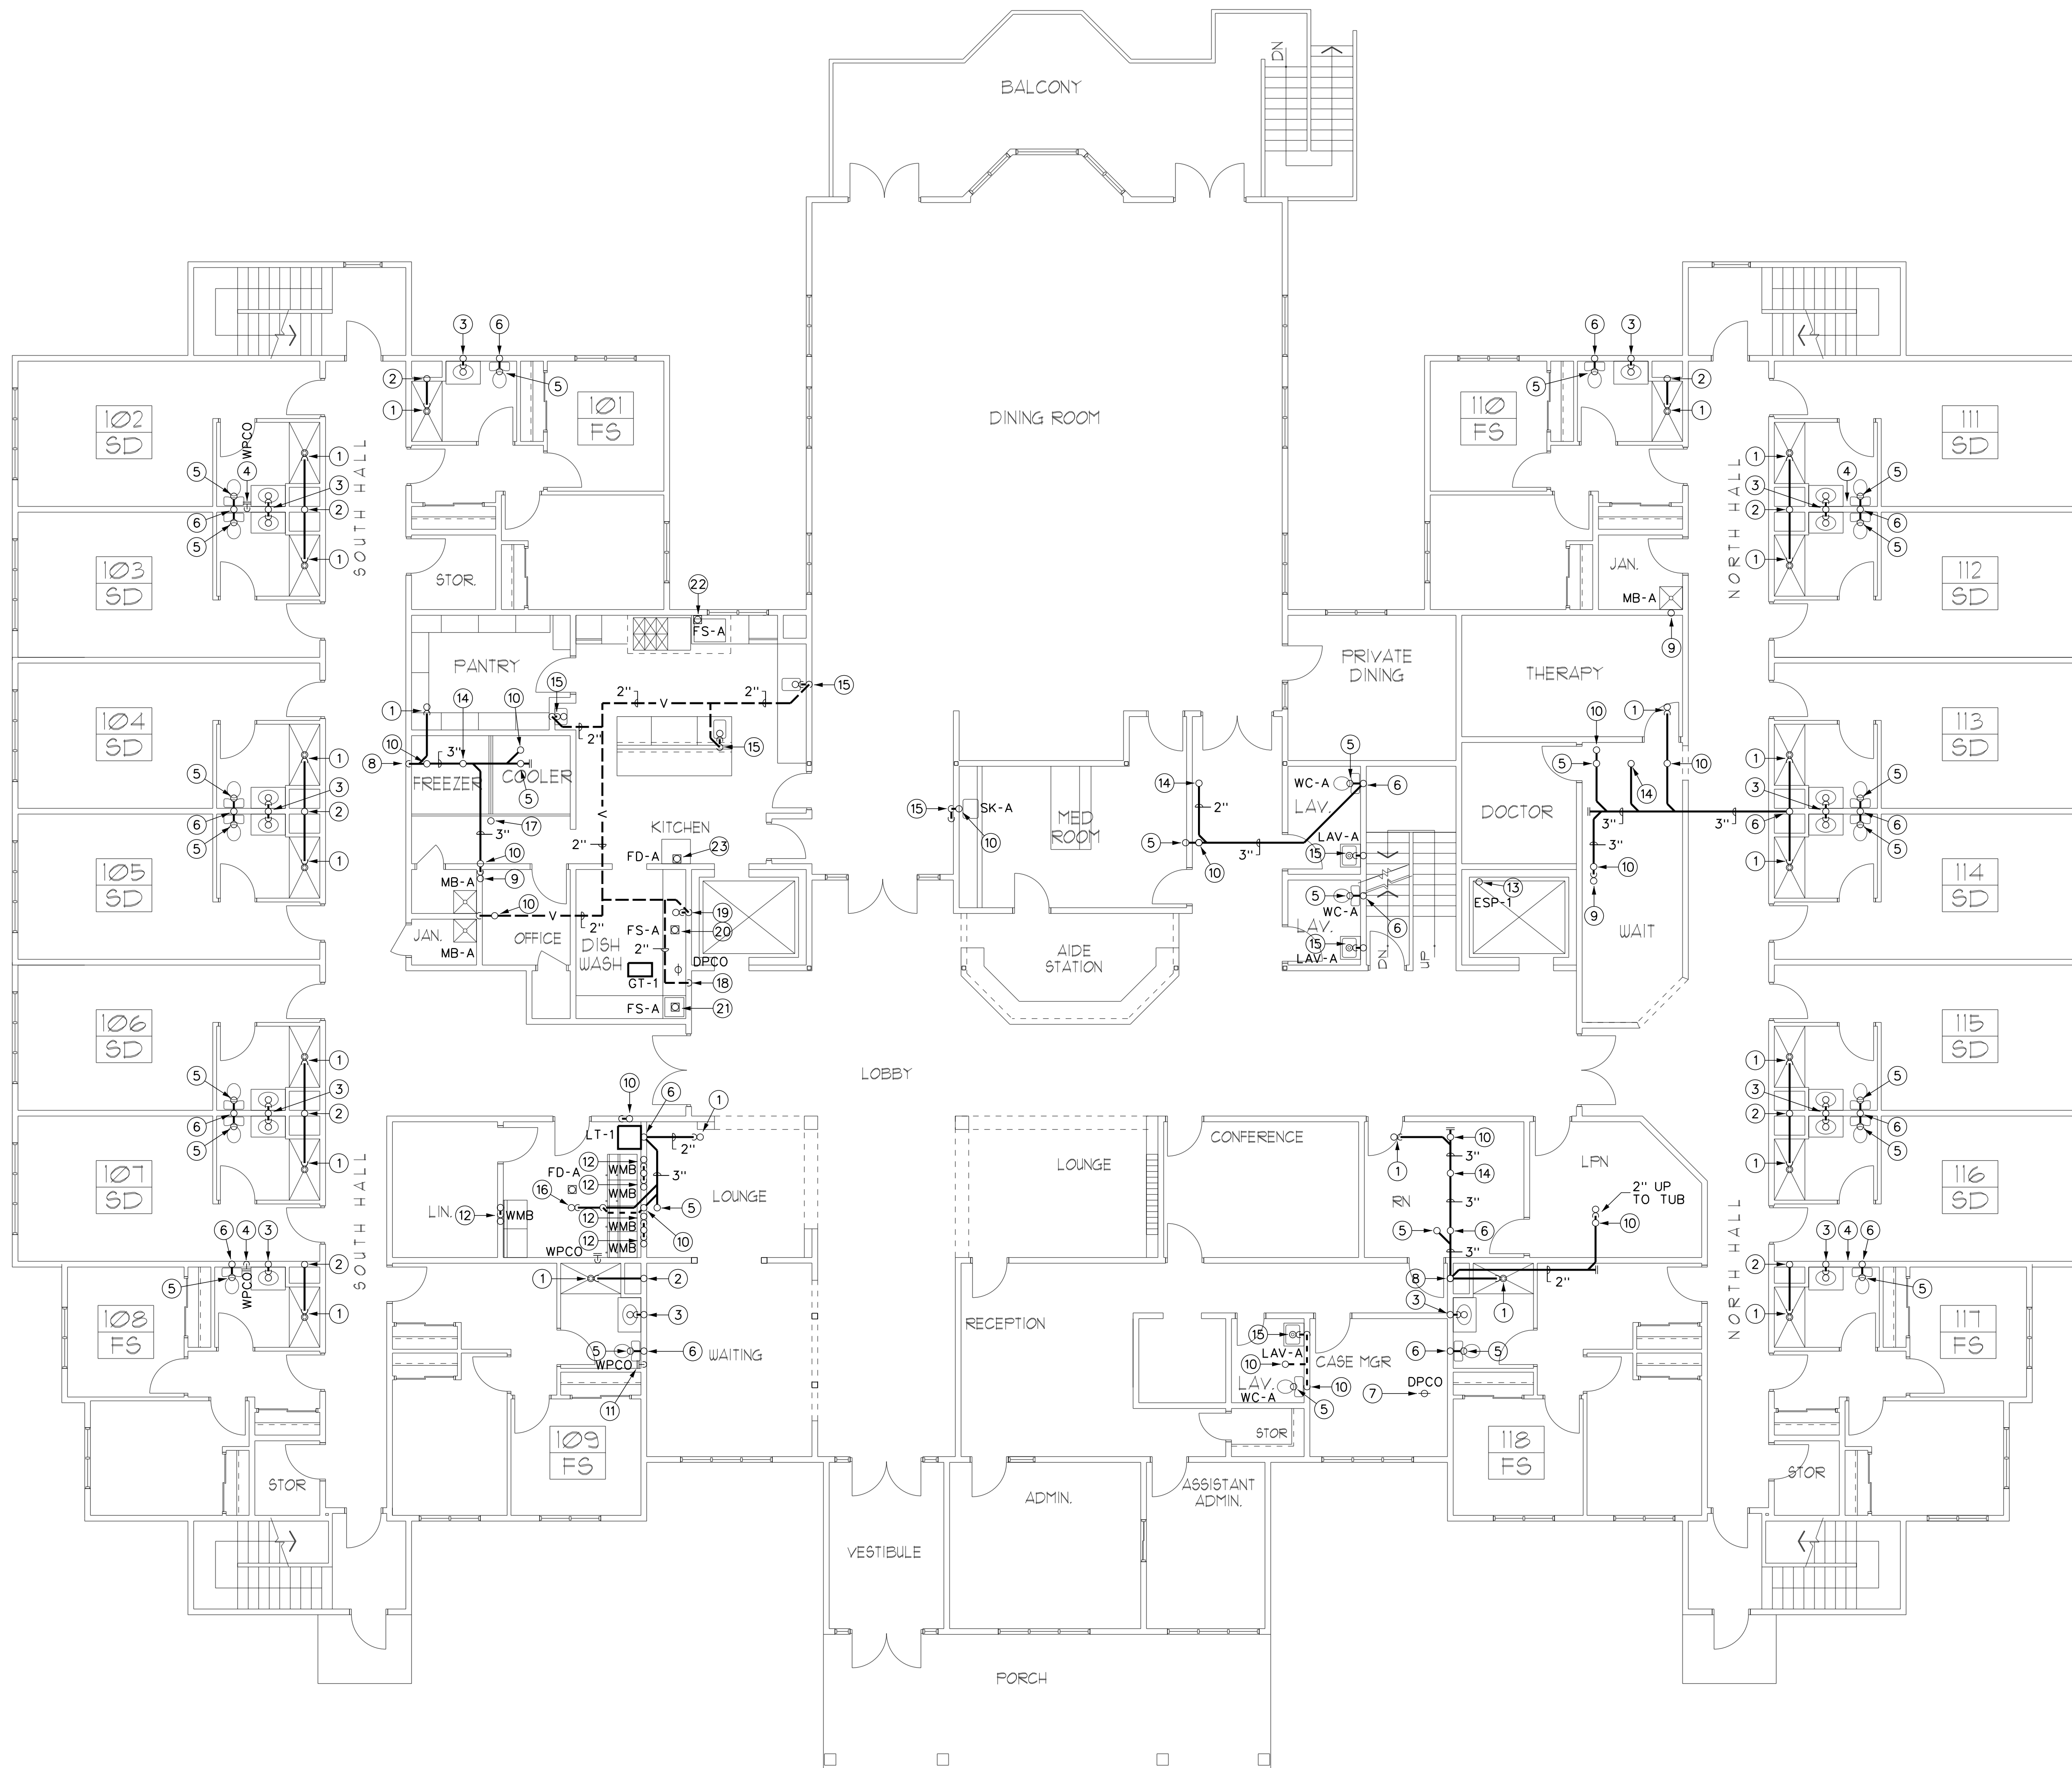

1 FIRST FLOOR PLAN
P102 SCALE: 1/8"=1'-0"

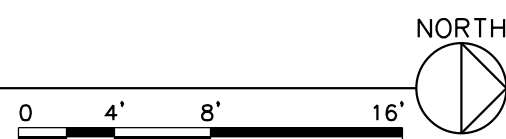

GENERAL NOTES:

- ALL PIPING IS ABOVE THE CEILING UNLESS OTHERWISE INDICATED.
- EXISTING PIPING SHOWN HAS BEEN TAKEN FROM AVAILABLE REFERENCE DRAWINGS AND LIMITED SITE VISITS. CONTRACTOR IS ADVISED TO VISIT SITE BEFORE BIDDING, STARTING WORK, OR ORDERING MATERIALS.
- ALL PIPING SHALL BE INSTALLED CONCEALED UNLESS OTHERWISE INDICATED.
- COORDINATE ALL WORK WITH OTHER TRADES PRIOR TO BEGINNING WORK.
- ALL SANITARY PIPING SHALL SLOPE AT MINIMUM 1%.
- ALL STORM PIPING SHALL SLOPE AT MINIMUM 2% UNLESS OTHERWISE NOTED.
- PROVIDE LINK SEAL SEALING SLEEVES AT ALL LOCATIONS WHERE PIPING PENETRATES EXTERIOR WALLS AND FLOOR SLABS ON GRADE.

DRAWING NOTES:

- 2" P-TRAP UP TO SHOWER.
- 2" WET VENT UP.
- 2" WASTE DOWN, 2" WET VENT UP, 1-1/2" CONN. TO VANITY SINK.
- 4" WALL CLEANOUT, OFFSET IN WALL TO AVOID VANITY.
- 3" SANITARY UP TO TOILET.
- 3" WET VENT UP.
- 4" DECK PLATE CLEANOUT.
- 3" SANITARY UP TO 2ND FLOOR.
- 3" P-TRAP UP TO MOP SINK.
- 2" VENT UP.
- 3" WALL CLEANOUT.
- 2" P-TRAP TO WASHING MACHINE BOX, 2" WASTE DOWN, 2" VENT UP. SEE 3/P602 FOR DETAIL.
- 4" STANDPIPE FOR ELEVATOR SUMP PUMP DISCHARGE, SEE 1/P601.
- 2" WASTE UP TO SINK.
- 2" WASTE DOWN, 2" VENT UP, 1-1/2" TO SINK.
- 3" P-TRAP UP TO FLOOR DRAIN ON 2ND FL.
- 3" STANDPIPE FOR COOLER AND FREEZER CONDENSATE.
- 2" VENT UP FROM GREASE TRAP, ADD VENT LIMITER IN VERTICAL.
- 2" VENT UP, 2" WASTE DOWN, 1-1/2" TO GARBAGE DISPOSAL.
- 2" INDIRECT WASTE FROM SINKS TO FLOOR SINK.
- 2" INDIRECT WASTE FROM DISHWASHER TO FLOOR SINK.
- 3/4" DRAIN FROM VEGETABLE STEAMER TO FLOOR SINK.
- 3/4" DRAIN FROM ICE MACHINE TO FLOOR DRAIN.



DATE: 9/18/2020
REVISION:

PROJECT NO. 2020095
DESIGNED BY: MUC
DRAWN BY: MUC
CHECKED BY: RSA
SCALE: AS NOTED
NOTES:

FIRST FLOOR SANITARY PLAN

HARRIS A. SANDERS
ARCHITECTS, P.C.
252 WASHINGTON AVENUE, ALBANY, NEW YORK 12210

L'DOR ADULT CARE FACILITY
156 WEST CLARKSTOWN ROAD
NEW CITY, N.Y. 10956



SHEET NO.

P102

BID SET 9-18-20