



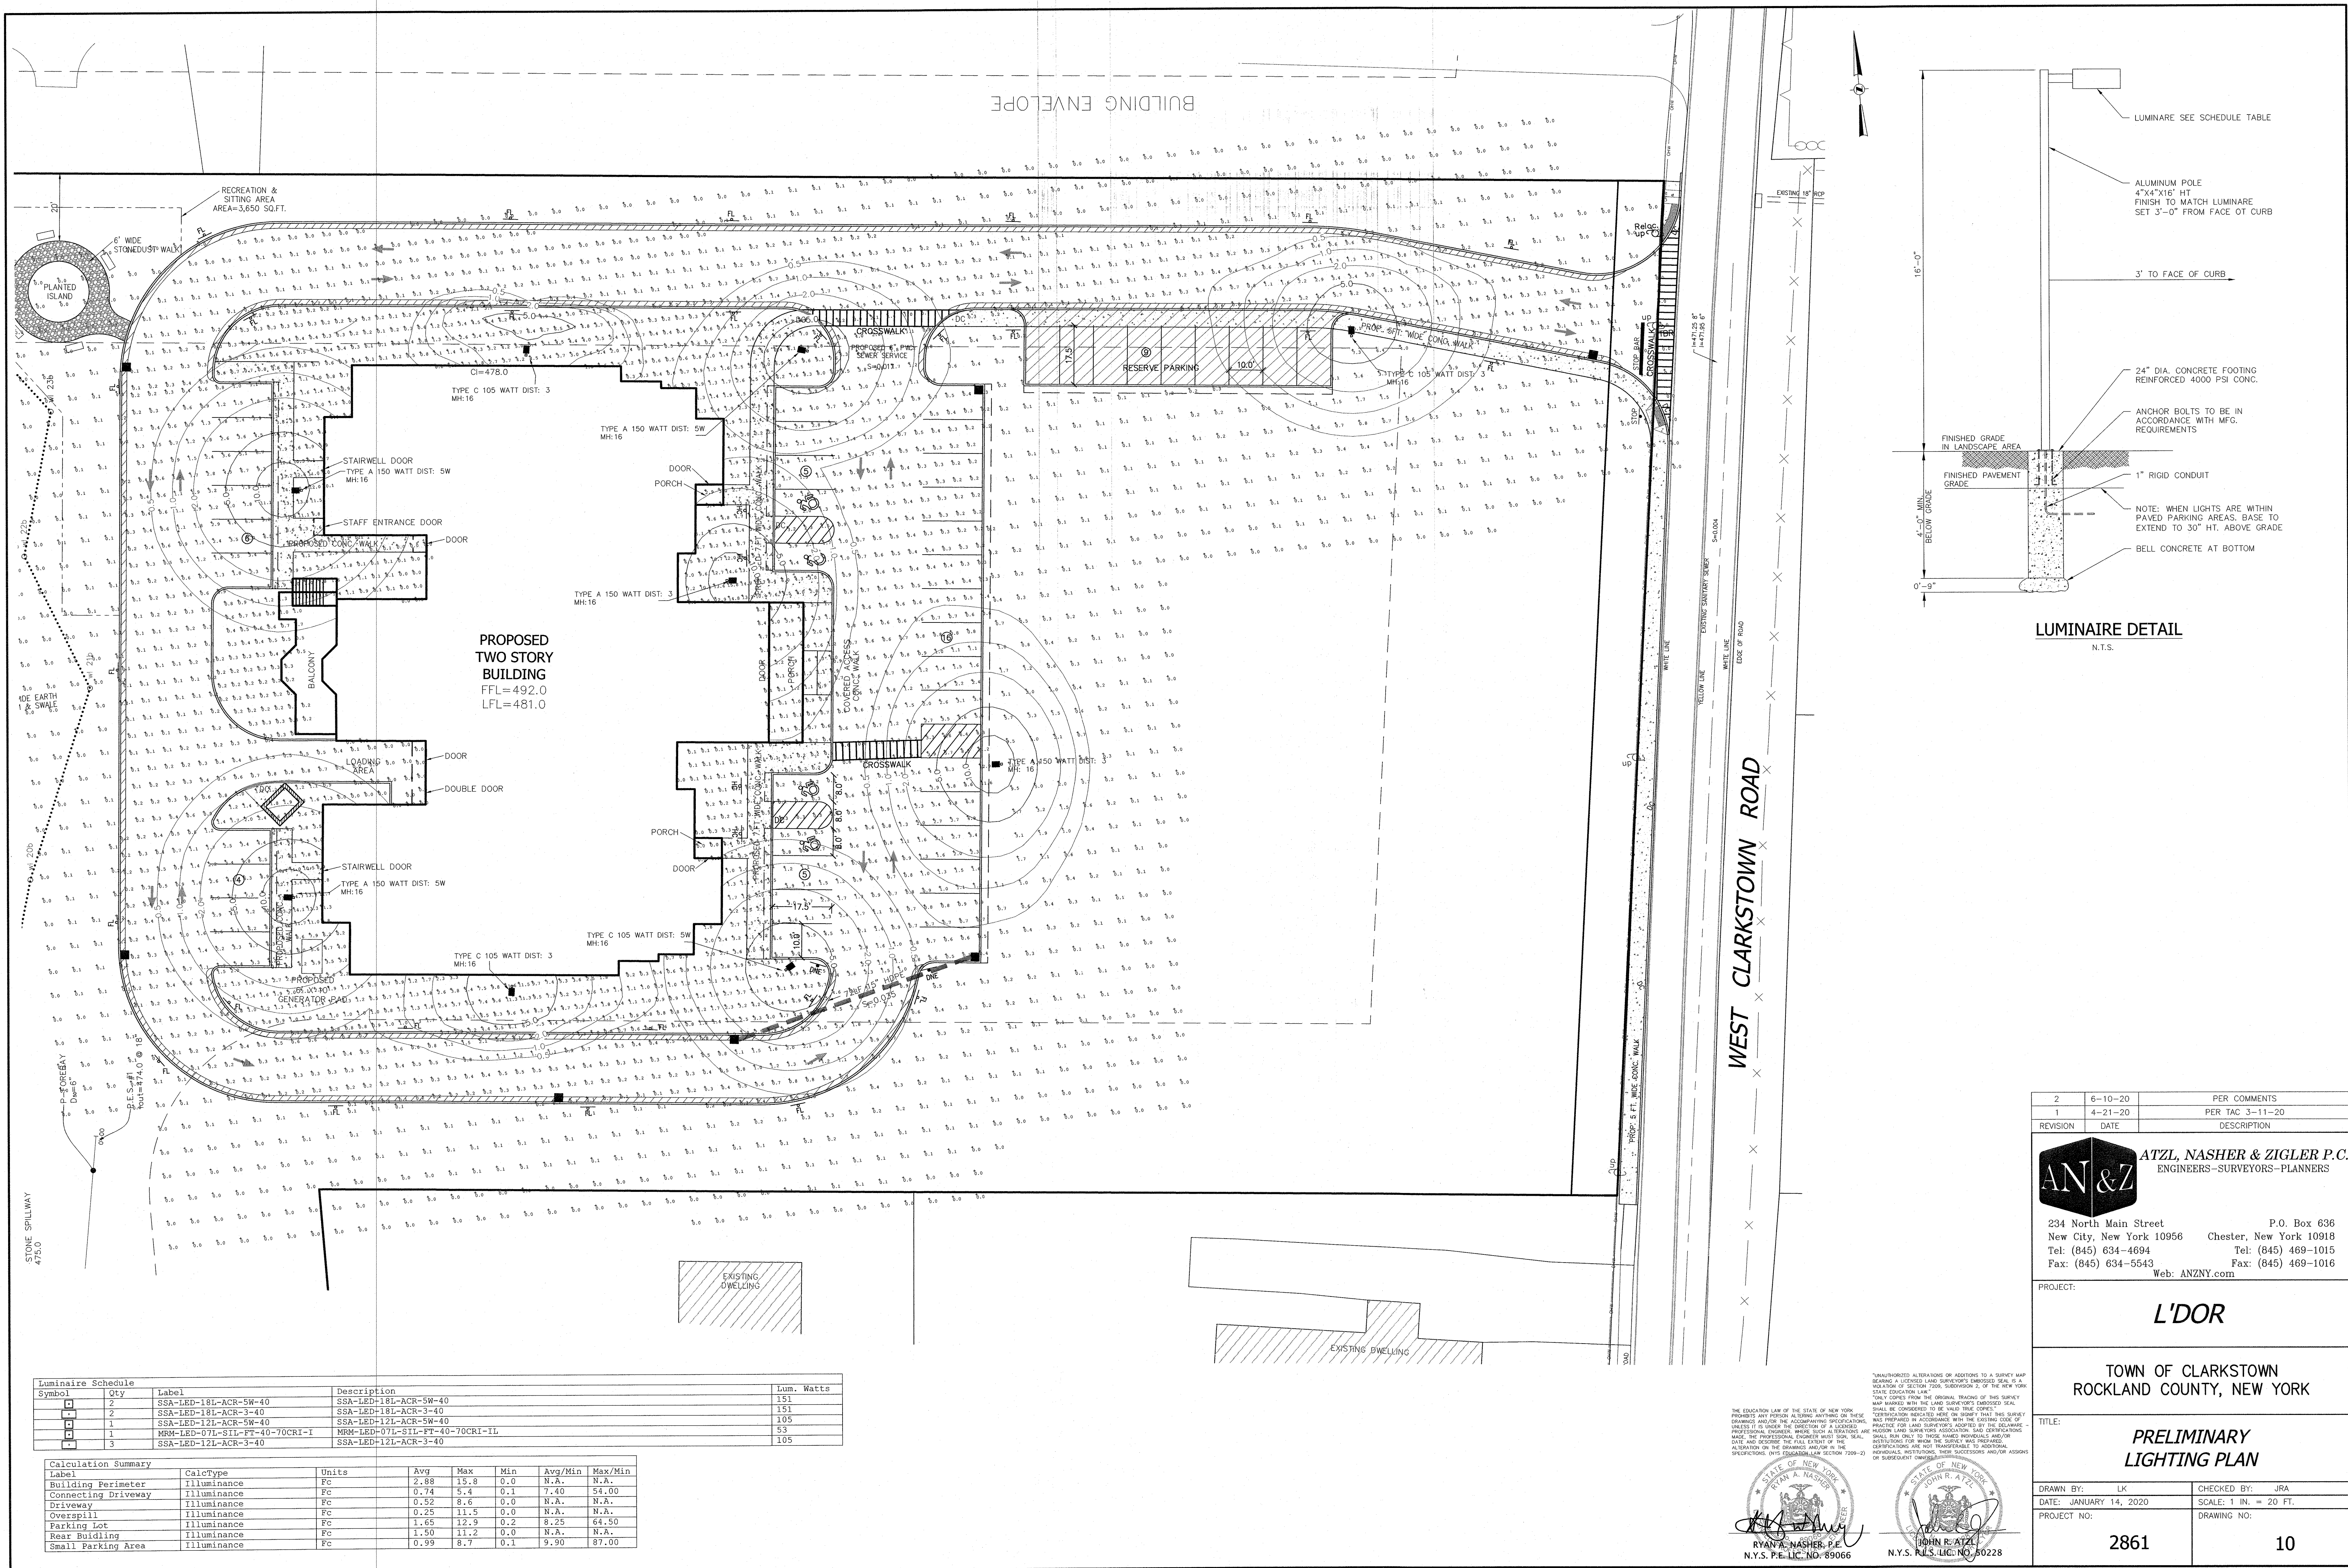

2	6-10-20	PER COMMENTS
1	4-21-20	PER TAC 3-11-20
REVISION	DATE	DESCRIPTION

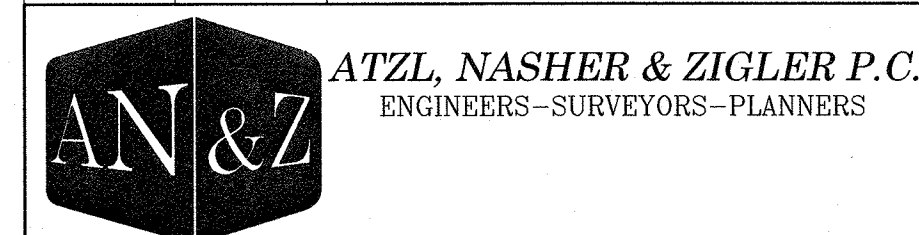

234 North Main Street P.O. Box 636
New City, New York 10956 Chester, New York 10918
Tel: (845) 634-4694 Tel: (845) 469-1015
Fax: (845) 634-5543 Fax: (845) 469-1016
Web: ANZNY.com

PROJECT: *L'DOR*

TOWN OF CLARKSTOWN
ROCKLAND COUNTY, NEW YORK

TITLE: *PRELIMINARY
LIGHTING PLAN*

DRAWN BY: LK	CHECKED BY: JRA
DATE: JANUARY 14, 2020	SCALE: 1 IN. = 20 FT.
PROJECT NO:	DRAWING NO:

2861	10
------	----