


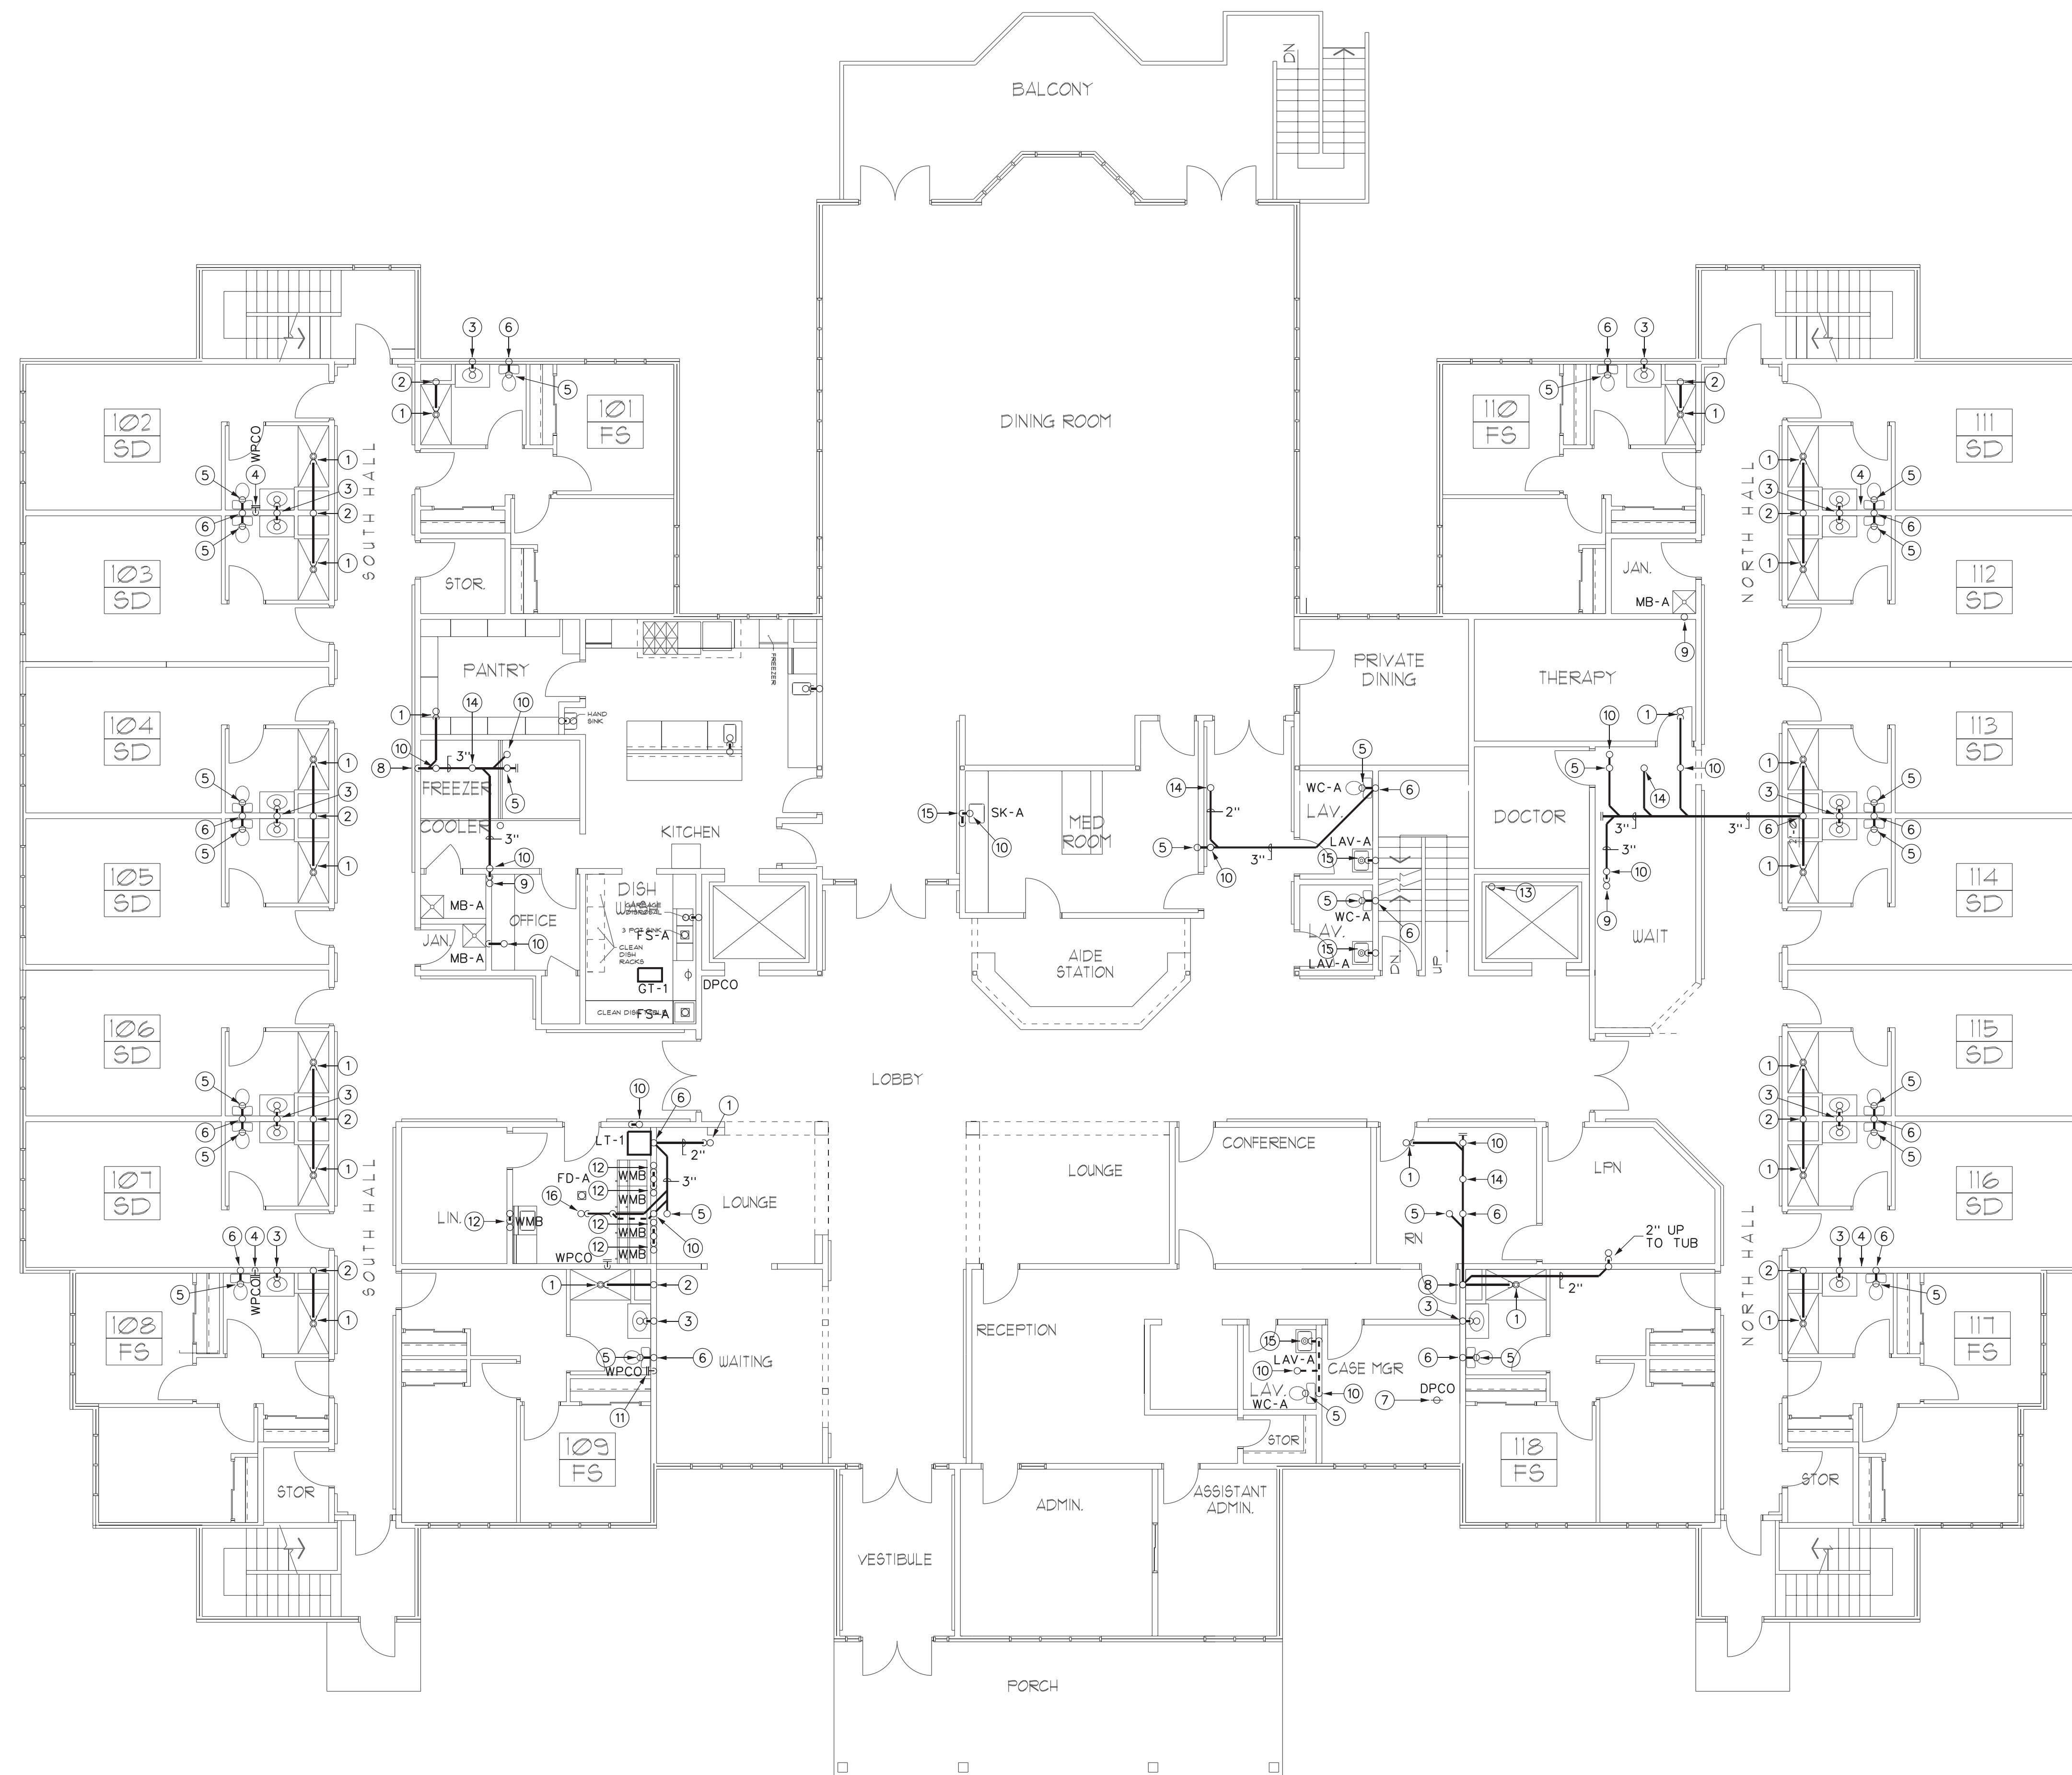

- 1" P-TRAP UP TO SHOWER.
- 2" WET VENT UP.
- 3" WASTE UP TO VANITY SINK.
- 4" ELBOW UP TO WALL CLEANOUT.
- 3" SANITARY UP TO TOILET.
- 3" WET VENT UP.
- 4" UP TO DECK PLATE CLEANOUT.
- 4" 45° ELBOWS, DROP DOWN BELOW BASEMENT FLOOR.
- 3" SANITARY UP TO 2ND FLOOR.
- 3" P-TRAP UP TO MOP SINK.
- 2" VENT UP.
- 3" P-TRAP UP TO FLOOR DRAIN.
- 3" ELBOW UP, TRANSITION TO 2" ABOVE SLAB.
- 3" ELBOW UP TO WALL CLEANOUT.
- 4" INLET AND OUTLET AT LINT TRAP, PROVIDE EXTENSION AS NECESSARY TO MAKE LID FLUSH WITH FINISH FLOOR SURFACE. SEE X/PX FOR DETAIL.
- 4" STANDPIPE FOR ELEVATOR SUMP PUMP DISCHARGE, SEE X/PX.
- 2" WASTE UP TO SINK.
- 4" P-TRAP UP TO FLOOR DRAIN, 2" VENT UP.
- 6" UP TO YARD CLEANOUT, SEE X/PX FOR DETAIL.
- 6" SANITARY OUT 5' FROM FOUNDATION, CONTINUED BY SITE CONTRACTOR. SEE SITE PLANS FOR CONTINUATION.
- 4" P-TRAP UP TO HUB DRAIN FOR DISHWASHER.
- 4" P-TRAP UP TO HUB DRAIN FOR 3 BAY SINK.
- GREASE TRAP RECESSED IN FLOOR. PROVIDE LID EXTENSION AS NECESSARY.
- 2" WASTE UP TO GARBAGE DISPOSAL.



GENERAL NOTES:

- ALL PIPING IS ABOVE THE CEILING UNLESS OTHERWISE INDICATED.
- EXISTING PIPING SHOWN HAS BEEN TAKEN FROM AVAILABLE REFERENCE DRAWINGS AND LIMITED SITE VISITS. CONTRACTOR IS ADVISED TO VISIT SITE BEFORE BIDDING, STARTING WORK, OR ORDERING MATERIALS.
- ALL PIPING SHALL BE INSTALLED CONCEALED UNLESS OTHERWISE INDICATED.
- COORDINATE ALL WORK WITH OTHER TRADES PRIOR TO BEGINNING WORK.
- ALL SANITARY PIPING SHALL SLOPE AT MINIMUM 1%.
- ALL STORM PIPING SHALL SLOPE AT MINIMUM 2% UNLESS OTHERWISE NOTED.
- PROVIDE LINK SEAL SEALING SLEEVES AT ALL LOCATIONS WHERE PIPING PENETRATES EXTERIOR WALLS AND FLOOR SLABS ON GRADE.

DRAWING NOTES:


- 2" P-TRAP UP TO SHOWER.
- 2" WET VENT UP.
- 2" WASTE DOWN, 2" WET VENT UP, 1-1/2" CONN. TO VANITY SINK.
- 4" WALL CLEANOUT, OFFSET IN WALL TO AVOID VANITY.
- 3" SANITARY UP TO TOILET.
- 3" WET VENT UP.
- 4" DECK PLATE CLEANOUT.
- 3" SANITARY UP TO 2ND FLOOR.
- 3" P-TRAP UP TO MOP SINK.
- 2" VENT UP.
- 3" WALL CLEANOUT.
- 2" P-TRAP TO WASHING MACHINE BOX, 2" WASTE DOWN, 2" WET VENT UP. SEE X/PX FOR DETAIL.
- 4" STANDPIPE FOR ELEVATOR SUMP PUMP DISCHARGE, SEE X/PX.
- 2" WASTE UP TO SINK.
- 2" WASTE DOWN, 2" VENT UP, 1-1/2" TO SINK.
- 3" P-TRAP UP TO FLOOR DRAIN ON 2ND FL.

FIRST FLOOR SANITARY PLAN

**HARRIS A. SANDERS
ARCHITECTS, P.C.**
252 WASHINGTON AVENUE, ALBANY, NEW YORK 12210

L'DOR ADULT CARE FACILITY
156 WEST CLARKSTOWN ROAD
NEW CITY, N.Y. 10956

PROGRESS PRINT
DO NOT USE FOR CONSTRUCTION
08/11/20

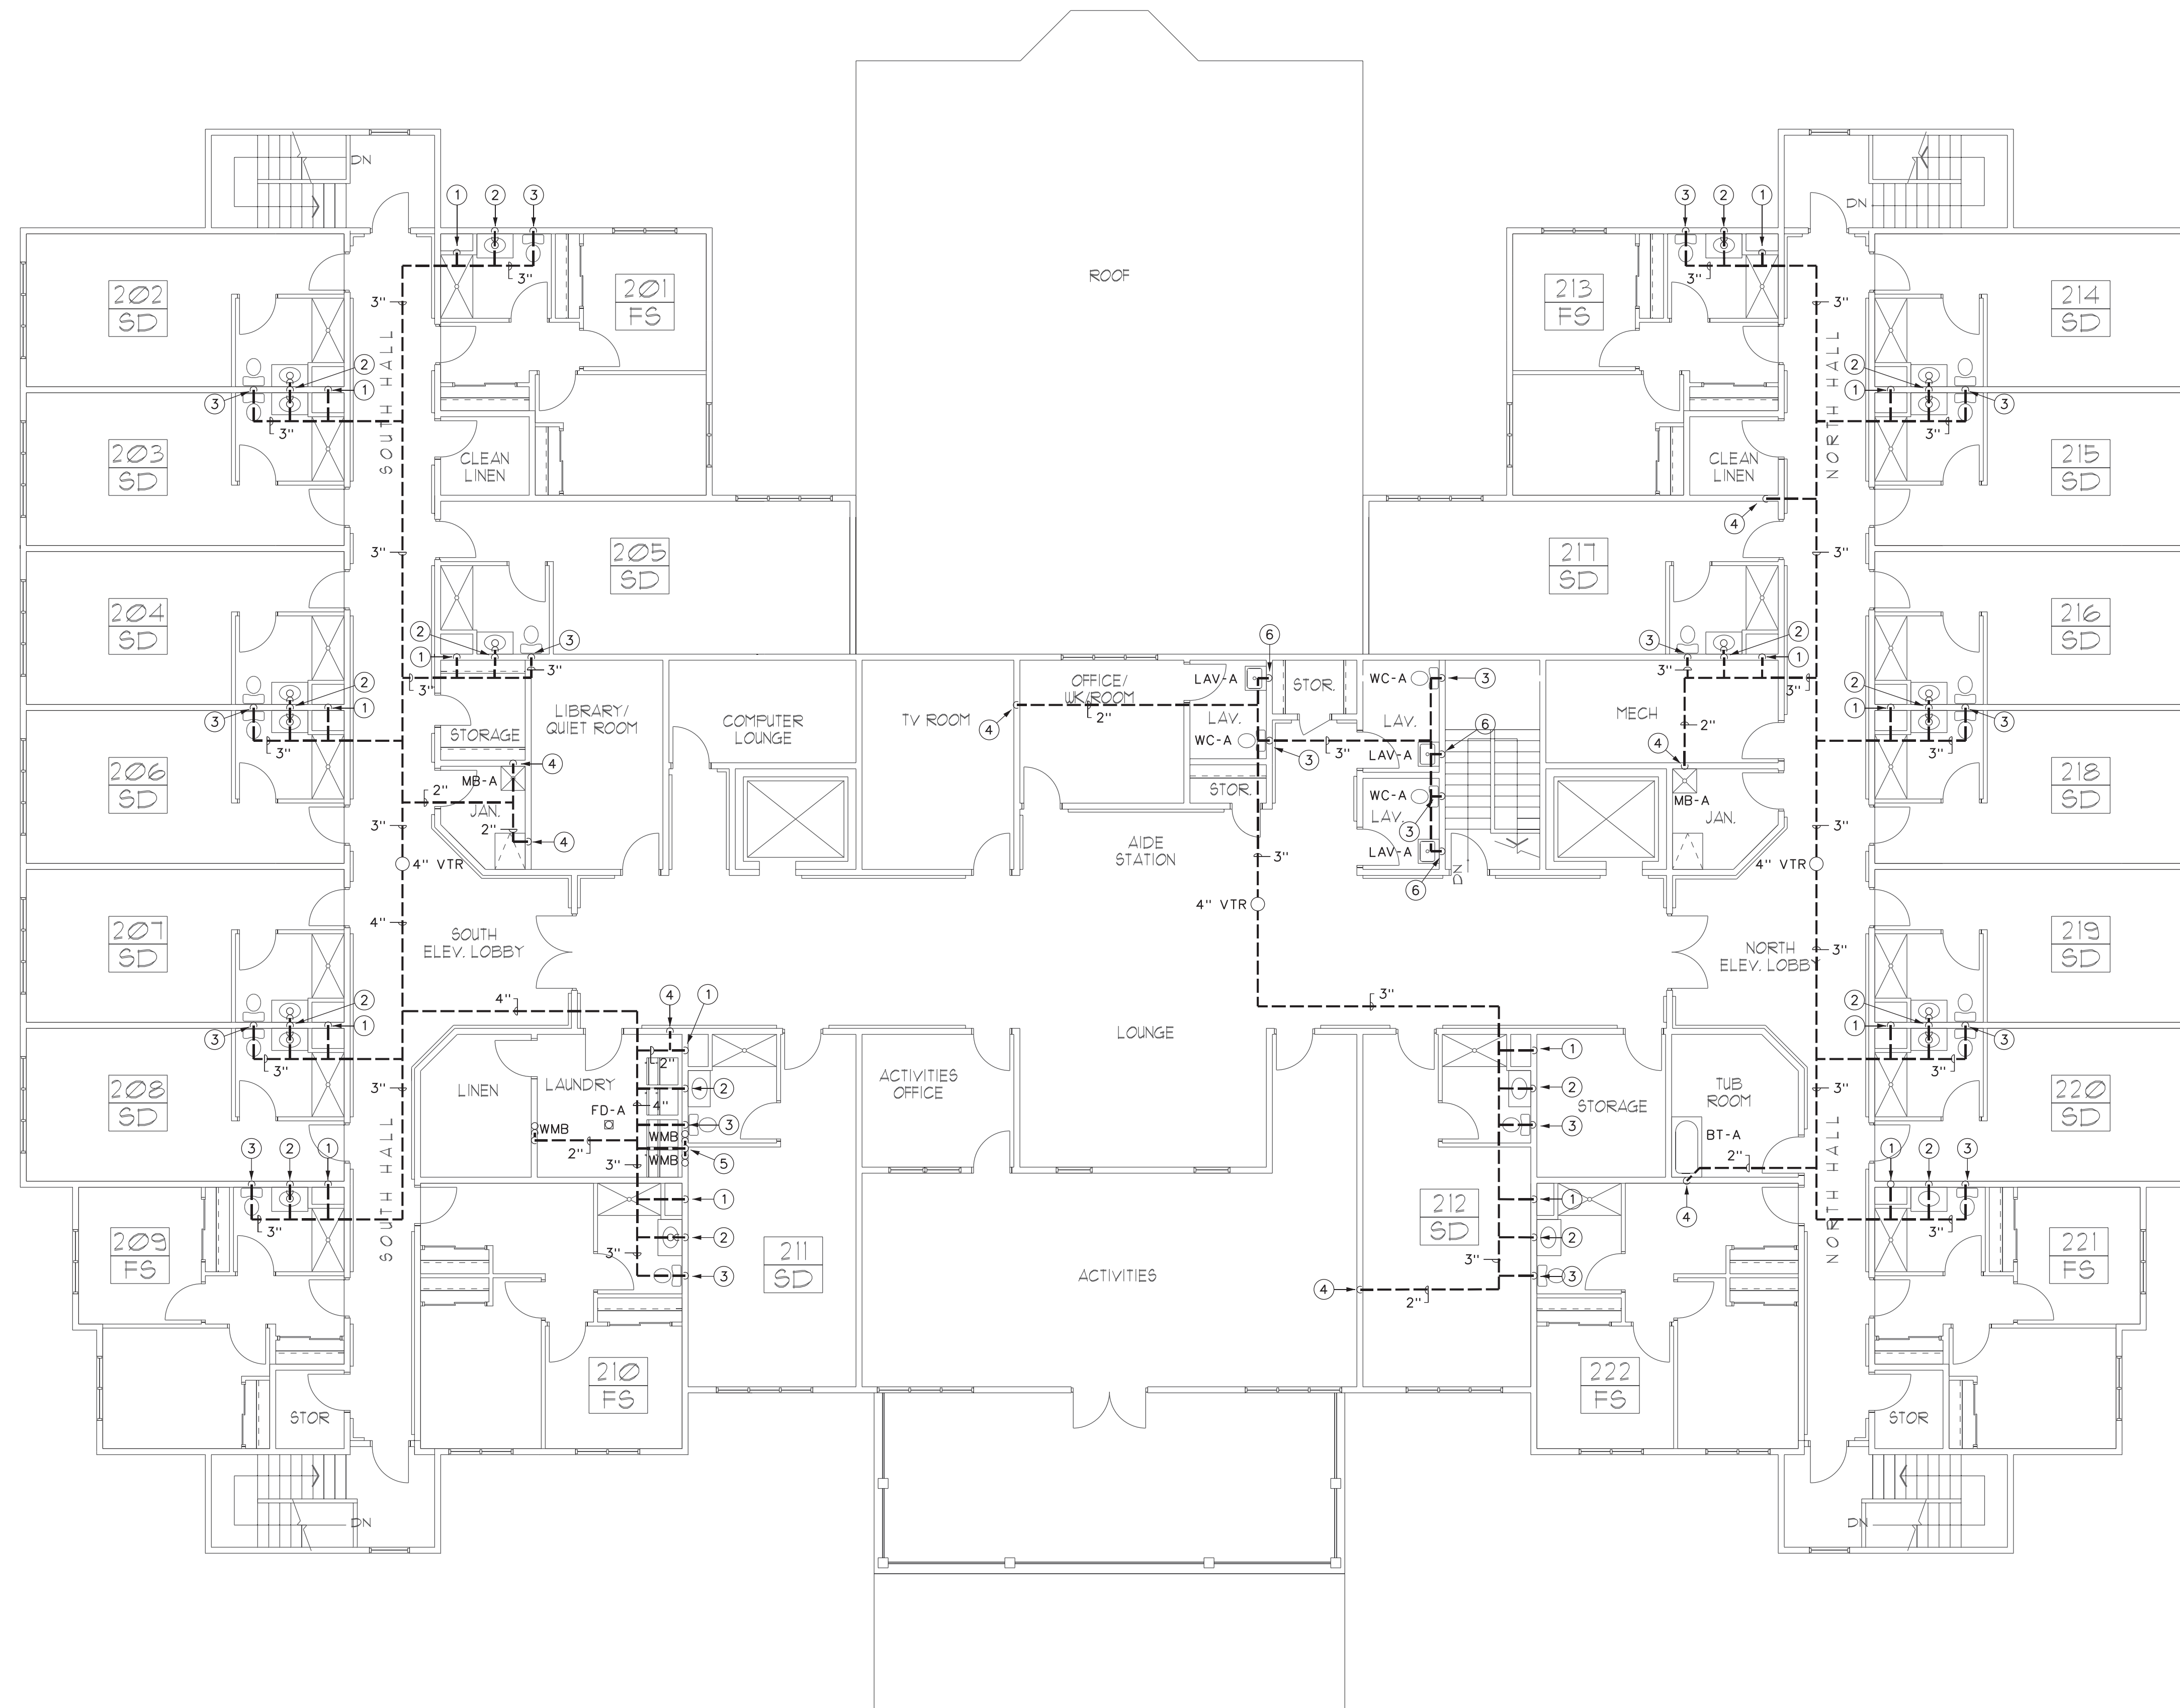

1 SECOND FLOOR PLAN
P103 SCALE: 1/8"=1'-0" NORTH

- GENERAL NOTES:**
- A. ALL PIPING IS ABOVE THE CEILING UNLESS OTHERWISE INDICATED.
 - B. EXISTING PIPING SHOWN HAS BEEN TAKEN FROM AVAILABLE REFERENCE DRAWINGS AND LIMITED SITE VISITS. CONTRACTOR IS ADVISED TO VISIT SITE BEFORE BIDDING, STARTING WORK, OR ORDERING MATERIALS.
 - C. ALL PIPING SHALL BE INSTALLED CONCEALED UNLESS OTHERWISE INDICATED.
 - D. COORDINATE ALL WORK WITH OTHER TRADES PRIOR TO BEGINNING WORK.
 - E. ALL SANITARY PIPING SHALL SLOPE AT MINIMUM 1%.
 - F. ALL STORM PIPING SHALL SLOPE AT MINIMUM 2% UNLESS OTHERWISE NOTED.
 - G. PROVIDE LINK SEAL SEALING SLEEVES AT ALL LOCATIONS WHERE PIPING PENETRATES EXTERIOR WALLS AND FLOOR SLABS ON GRADE.

- DRAWING NOTES:**
- ① 2" WET VENT UP AND DOWN FROM SHOWERS.
 - ② 2" WASTE DOWN, 2" VENT UP, 1-1/2" CONN. TO VANITY SINK(S).
 - ③ 3" VENT UP FROM TOILET STACK.
 - ④ 2" VENT UP.
 - ⑤ 2" P-TRAP TO WASHING MACHINE BOX, 2" WASTE DOWN, 2" VENT UP. SEE X/PX FOR DETAIL.
 - ⑥ 2" WASTE DOWN, 2" VENT UP, 1-1/2" TO SINK.



ME
ENGINEERING
Mechanical/Electrical Engineering Consultants
ME Project # 20095
Schenectady, NY 12307
518.352.1777
www.meengr.com

DATE: 8/11/2020
REVISIONS:

PROJECT NO.	DESIGNED BY	DRAWN BY	CHECKED BY	SCALE	NOTES
200905	MUC	MUC	PSA	AS NOTED	


**HARRIS A. SANDERS
ARCHITECTS, P.C.**
252 WASHINGTON AVENUE, ALBANY, NEW YORK 12210

L'DOR ADULT CARE FACILITY
156 WEST CLARKSTOWN ROAD
NEW CITY, N.Y. 10956

PROGRESS PRINT
DO NOT USE FOR CONSTRUCTION
08/11/20



SHEET NO.
P103

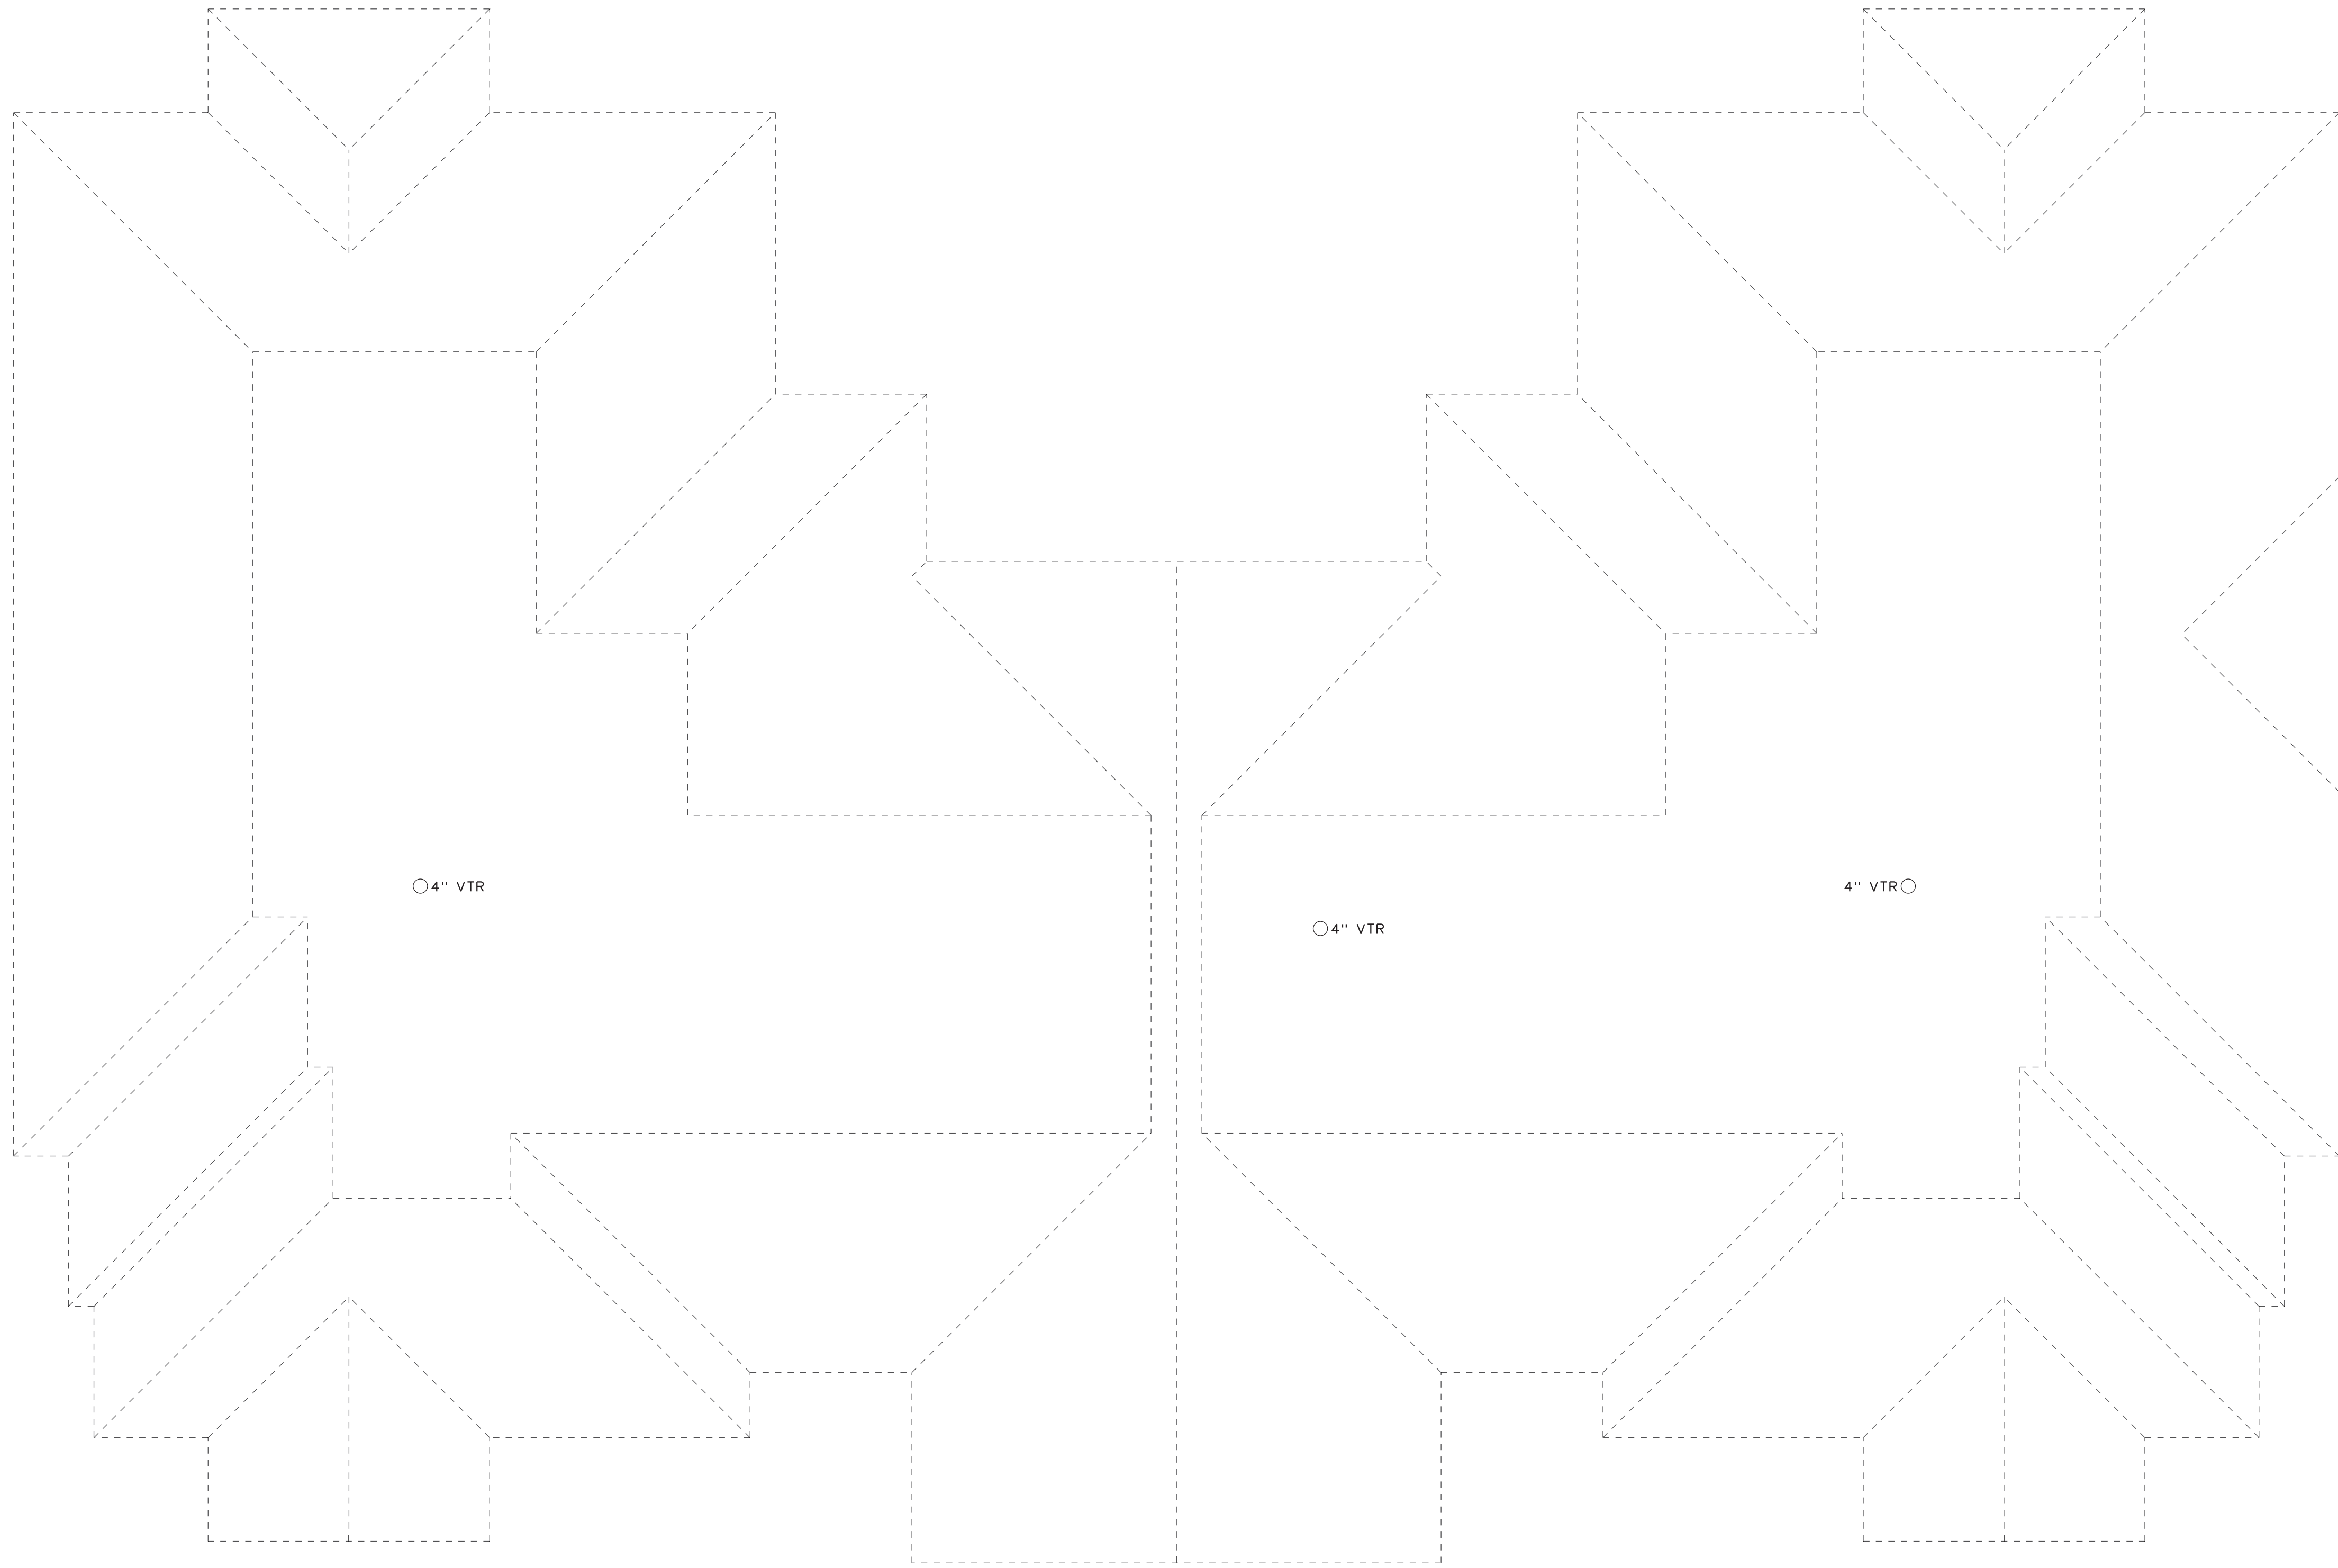

GENERAL NOTES:

- A. ALL PIPING IS ABOVE THE CEILING UNLESS OTHERWISE INDICATED.
- B. ALL PIPING SHALL BE INSTALLED CONCEALED UNLESS OTHERWISE INDICATED.
- C. COORDINATE ALL WORK WITH OTHER TRADES PRIOR TO BEGINNING WORK.
- D. ALL SANITARY PIPING SHALL SLOPE AT MINIMUM 1%.
- E. ALL STORM PIPING SHALL SLOPE AT MINIMUM 2% UNLESS OTHERWISE NOTED.
- F. PROVIDE LINK SEAL SEALING SLEEVES AT ALL LOCATIONS WHERE PIPING PENETRATES EXTERIOR WALLS AND FLOOR SLABS ON GRADE.

DRAWING NOTES:

- 1 2" WET VENT
- 2



ENGINEERING
Mechanical/Electrical Engineering Consultants
MEP Design & Construction
1000 West 10th Street, Suite 100
Albany, NY 12206
518.263.1177
www.meengineering.com

DATE: 8/11/2020
REVISION:

PROJECT NO: 200095
DESIGNED BY: MJC
DRAWN BY: MJC
CHECKED BY: RSA
SCALE: AS NOTED
NOTES:


ROOF PLAN

HARRIS A. SANDERS
ARCHITECTS, P.C.
252 WASHINGTON AVENUE, ALBANY, NEW YORK 12210

L'DOR ADULT CARE FACILITY
156 WEST CLARKSTOWN ROAD
NEW CITY, N.Y. 10956

PROGRESS PRINT
DO NOT USE FOR CONSTRUCTION
08/11/20



SHEET NO:
P104

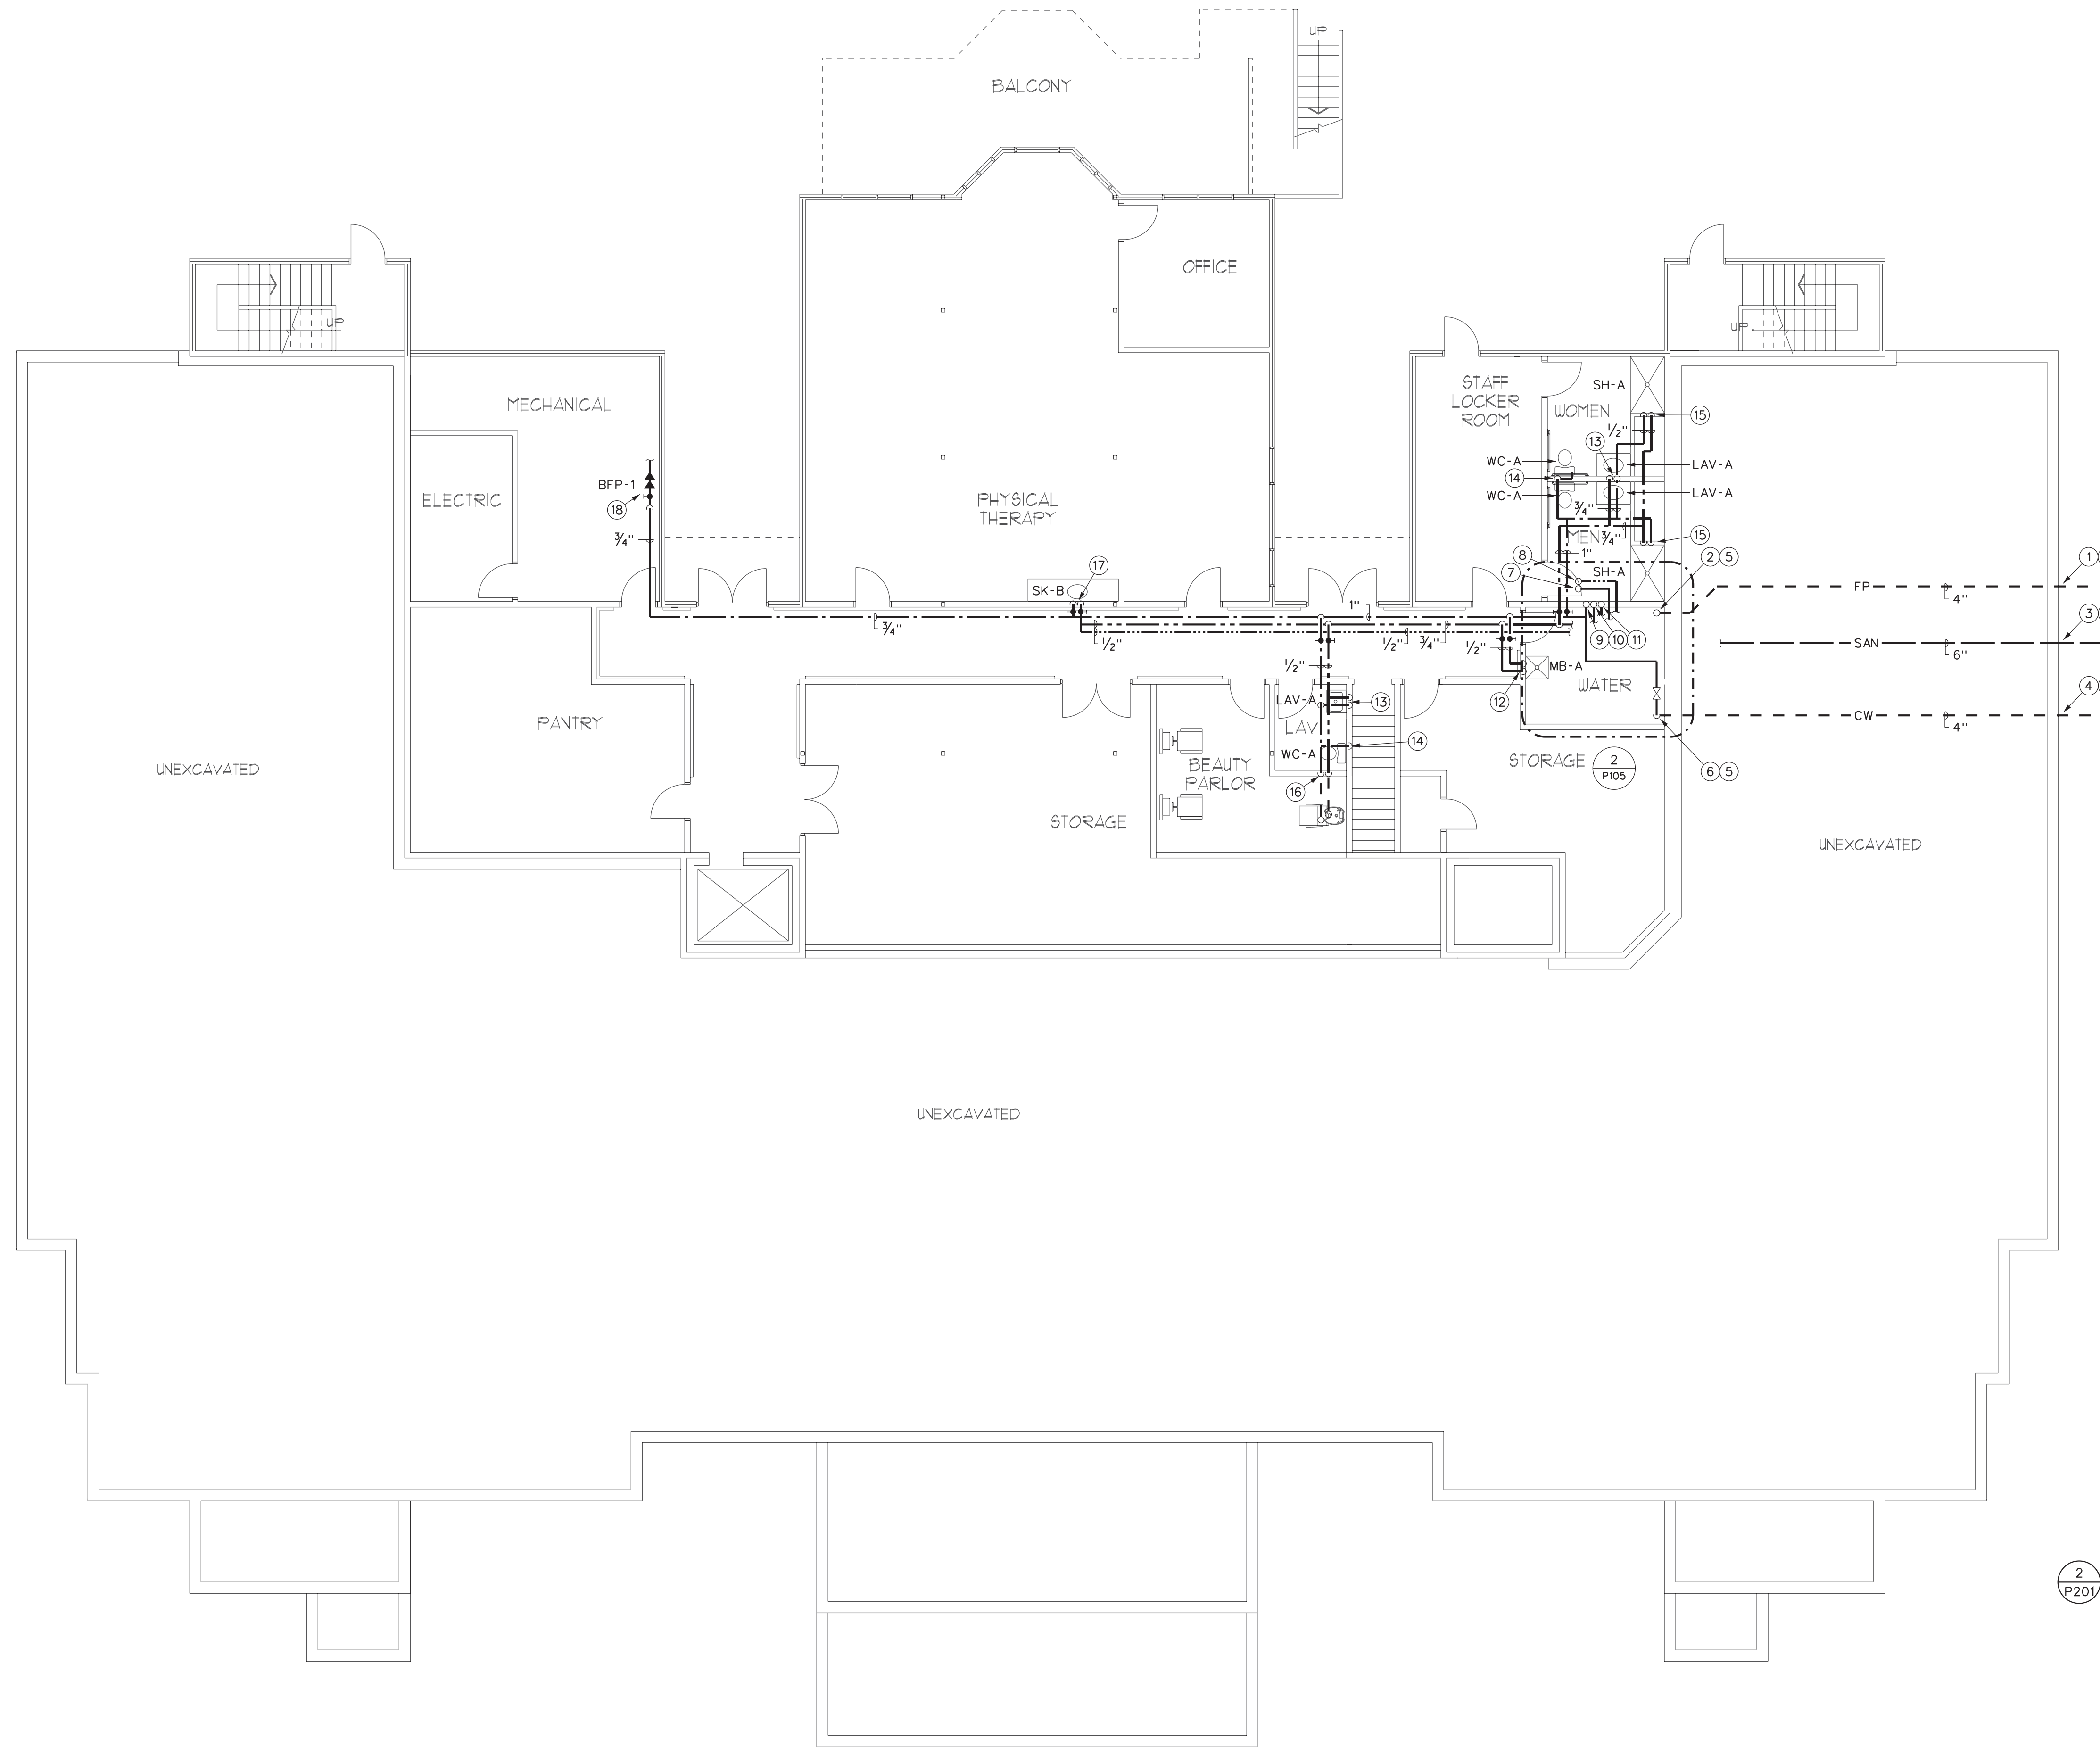

1 BASEMENT FLOOR PLAN
SCALE: 1/8"=1'-0"

- GENERAL NOTES:**
- A. ALL PIPING IS ABOVE THE CEILING UNLESS OTHERWISE INDICATED.
 - B. ALL PIPING SHALL BE INSTALLED CONCEALED UNLESS OTHERWISE INDICATED.
 - C. COORDINATE ALL WORK WITH OTHER TRADES PRIOR TO BEGINNING WORK.
 - D. ALL SANITARY PIPING SHALL SLOPE AT MINIMUM 1%.
 - E. ALL STORM PIPING SHALL SLOPE AT MINIMUM 2% UNLESS OTHERWISE NOTED.
 - F. PROVIDE LINK SEAL SEALING SLEEVES AT ALL LOCATIONS WHERE PIPING PENETRATES EXTERIOR WALLS AND FLOOR SLABS ON GRADE.

- DRAWING NOTES:**
- 1 4" FIRE PROTECTION MAIN, MAINTAIN 5' LATERAL SEPERATION FROM SEWER.
 - 2 4" FIRE PROTECTION MAIN RISER UP, PROVIDE GATE VALVE IN RISER. CONTINUED BY FP CONTRACTOR.
 - 3 6" SANITARY MAIN, MAINTAIN 5' LATERAL SEPERATION FROM WATER.
 - 4 4" DOMESTIC WATER MAIN, MAINTAIN 5' LATERAL SEPERATION FROM SEWER.
 - 5 SEAL PENETRATION WATERTIGHT.
 - 6 4" WATER MAIN RISER UP, PROVIDE GATE VALVE.
 - 7 X" 140° HOT WATER UP.
 - 8 X" 140° HOT WATER RETURN UP.
 - 9 4" DOMESTIC COLD WATER UP.
 - 10 X" 125° HOT WATER UP.
 - 11 X" 125° HOT WATER RETURN UP.
 - 12 1/2" CW, 1/2" HW DROP DOWN TO MOP SINK.
 - 13 1/2" CW, 1/2" HW DROP DOWN TO LAVATORY.
 - 14 1/2" CW DROP DOWN TO TOILET.
 - 15 1/2" CW, 1/2" HW DROP DOWN TO SHOWER MIX VALVE.
 - 16 1/2" CW, 1/2" HW DROP DOWN BELOW SLAB TO HAIR SINK. INSULATE PIPING BELOW SLAB WITH 1" WALL CLOSED CELL INSULATION.
 - 17 1/2" CW, 1/2" HW DROP DOWN TO SINK.
 - 18 3/4" CW BOILER MAKEUP WATER WITH DOUBLE CHECK BACKFLOW PREVENTER.
 - 19 PP-1 140° HOT WATER RETURN PUMP.
 - 20 PP-2 120° HOT WATER RETURN PUMP.

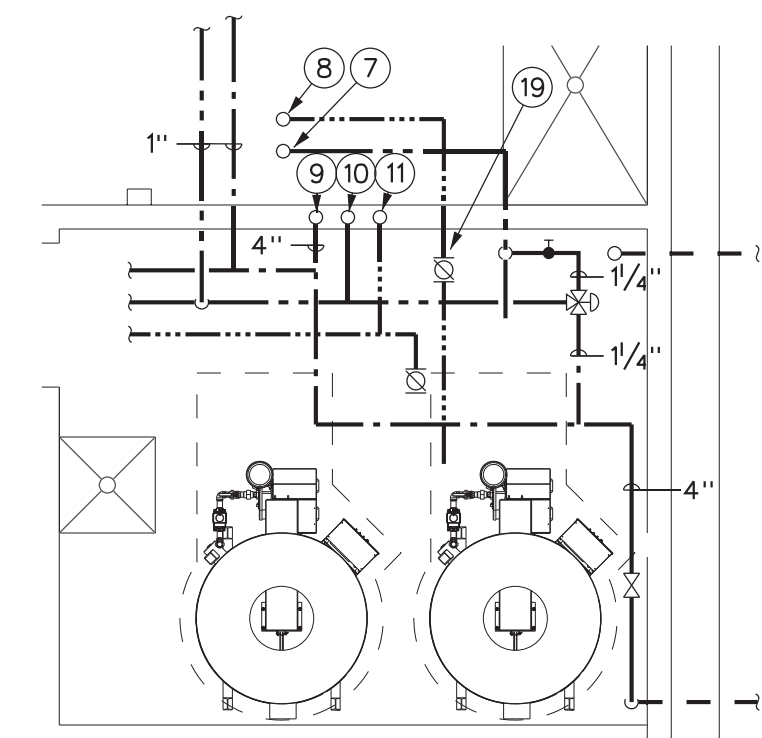

2 ENLARGED WATER ROOM
SCALE: 1/4"=1'-0"



ME ENGINEERING
Mechanical/Electrical Engineering Consultants
NY State License # 00000000000000000000
Schenectady, NY 12301
518.537.1177
www.me-engineering.com

DATE: 8/11/2020
REVISION:

PROJECT NO: 200095
DESIGNED BY: MUC
DRAWN BY: MUC
CHECKED BY: RSA
SCALE: AS NOTED
NOTES:

**BASEMENT DOMESTIC WATER
AND NATURAL GAS PLAN**

**HARRIS A. SANDERS
ARCHITECTS, P.C.**
252 WASHINGTON AVENUE, ALBANY, NEW YORK 12210

L'DOR ADULT CARE FACILITY
156 WEST CLARKSTOWN ROAD
NEW CITY, N.Y. 10956

PROGRESS PRINT
DO NOT USE FOR CONSTRUCTION
08/11/20



ENGINEERING

SHEET NO:


P201



SCALE: 1/8"=1'-0"



P202

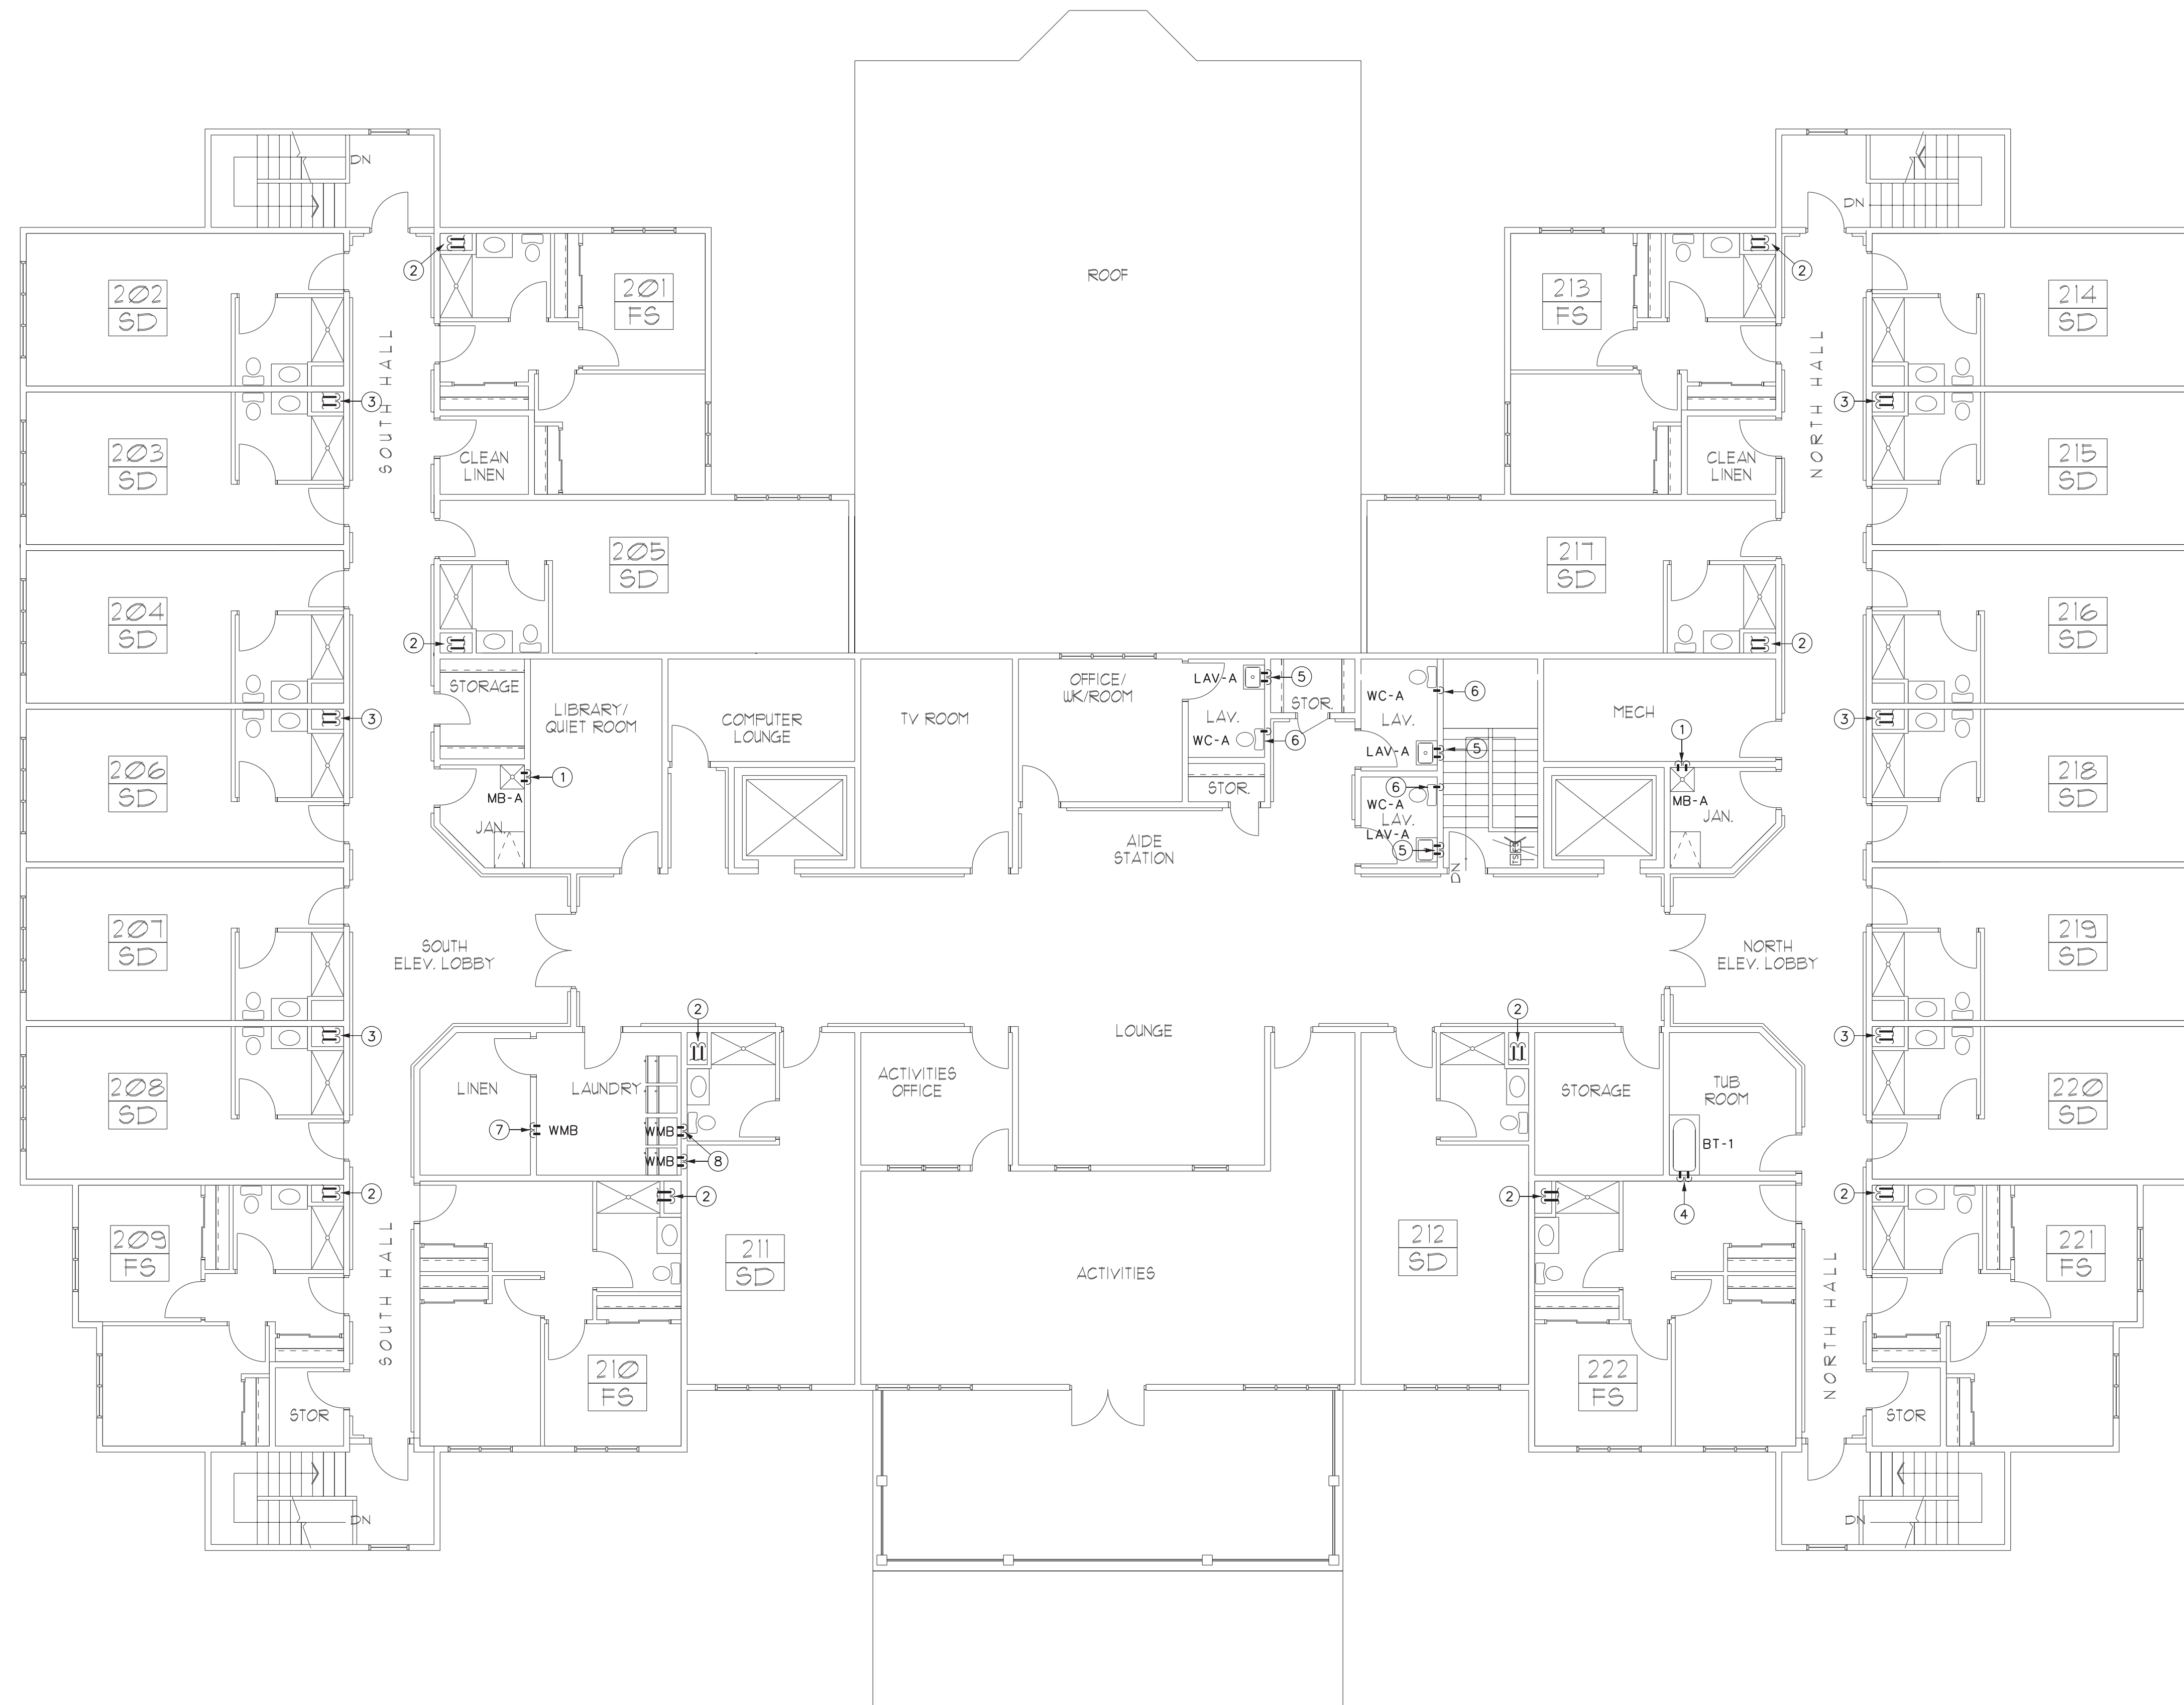


1
P203
SECOND FLOOR PLAN
SCALE: 1/8"=1'-0"
0 4' 8' 16'
NORTH

GENERAL NOTES:

- ALL PIPING IS ABOVE THE CEILING UNLESS OTHERWISE INDICATED.
- ALL PIPING SHALL BE INSTALLED CONCEALED UNLESS OTHERWISE INDICATED.
- COORDINATE ALL WORK WITH OTHER TRADES PRIOR TO BEGINNING WORK.
- ALL SANITARY PIPING SHALL SLOPE AT MINIMUM 1%.
- ALL STORM PIPING SHALL SLOPE AT MINIMUM 2% UNLESS OTHERWISE NOTED.
- PROVIDE LINK SEAL SEALING SLEEVES AT ALL LOCATIONS WHERE PIPING PENETRATES EXTERIOR WALLS AND FLOOR SLABS ON GRADE.

DRAWING NOTES:

- 1/2" CW AND 1/2" HW UP FROM BELOW TO MOP SINK.
- 3/4" CW AND 3/4" HW UP FROM BELOW INTO 2ND FL UNIT. SEE ENLARGED PLANS FOR CONTINUATION.
- 1" CW AND 1" HW UP FROM BELOW. PROVIDE 1" X 3/4" X 3/4" TEES INTO 2ND FL UNITS. SEE ENLARGED PLANS FOR CONTINUATION.
- 1/2" CW AND 1/2" HW UP FROM BELOW TO TUB.
- 1/2" CW AND 1/2" HW UP FROM BELOW TO SINK.
- 1/2" CW UP FROM BELOW TO TOILET.
- 3/4" CW AND 3/4" HW UP FROM BELOW TO WASHING MACHINE BOX.
- 1/2" CW AND 1/2" HW UP FROM BELOW TO WASHING MACHINE BOX.

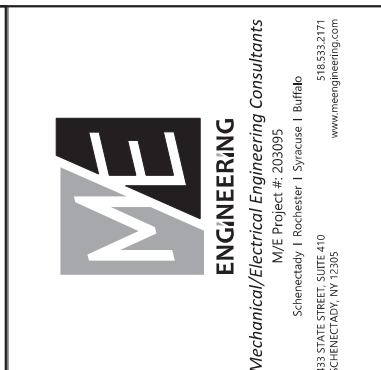

DATE: 8/11/2020
REVISION:

PROJECT NO.	202095
DESIGNED BY:	MUC
DRAWN BY:	MUC
CHECKED BY:	PSA
SCALE:	AS NOTED
NOTES:	

SECOND FLOOR DOMESTIC WATER
AND NATURAL GAS PLAN

HARRIS A. SANDERS
ARCHITECTS, P.C.
252 WASHINGTON AVENUE, ALBANY, NEW YORK 12210
L'DOR ADULT CARE FACILITY
156 WEST CLARKSTOWN ROAD
NEW CITY, N.Y. 10956


PROGRESS PRINT
DO NOT USE FOR CONSTRUCTION
08/11/20



SHEET NO.
P203




- ① 1-1/4" CW AND HW FROM 1ST FL CORRIDOR.
- ② 1/2" CW AND HW UP AND DOWN TO SHOWER.
- ③ 1/2" CW AND HW UP AND DOWN TO VANITY.
- ④ 1/2" CW UP AND DOWN TO TOILET.
- ⑤ 3/4" CW AND HW UP FROM 1ST FL.

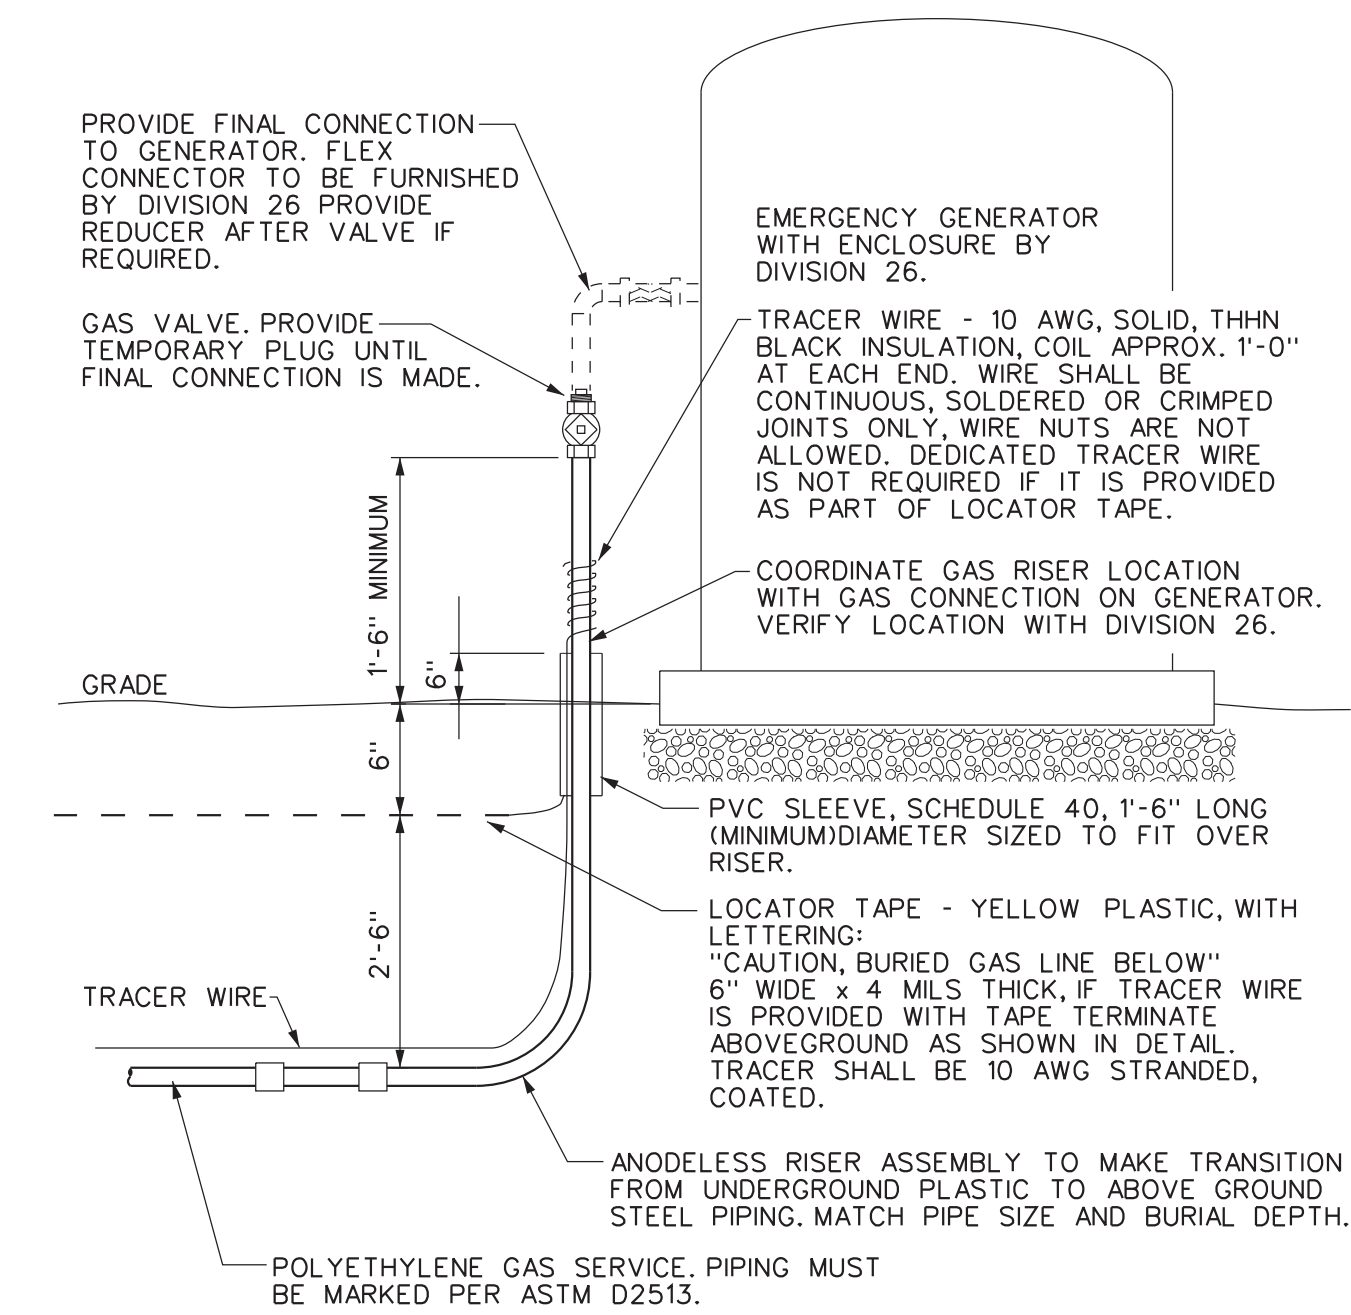


DETAIL NOTES:

- PROVIDE AN ANODELESS RISER AT EACH LOCATION WHERE THE GAS PIPING PENETRATES THE SURFACE. EXTEND TRACER TO THE SURFACE AT EACH RISER.
- COORDINATE PIPE AND CONDUIT ROUTING TO MINIMIZE TRENCHING.
- PAINT ALL EXTERIOR GAS PIPING WITH ONE(1) PRIMER AND TWO(2) FINISH COATS OF COLOR SELECTED, AS SPECIFIED.

4
P601
GENERATOR, EXTERIOR - NATURAL GAS PIPING DETAIL
SCALE: NONE

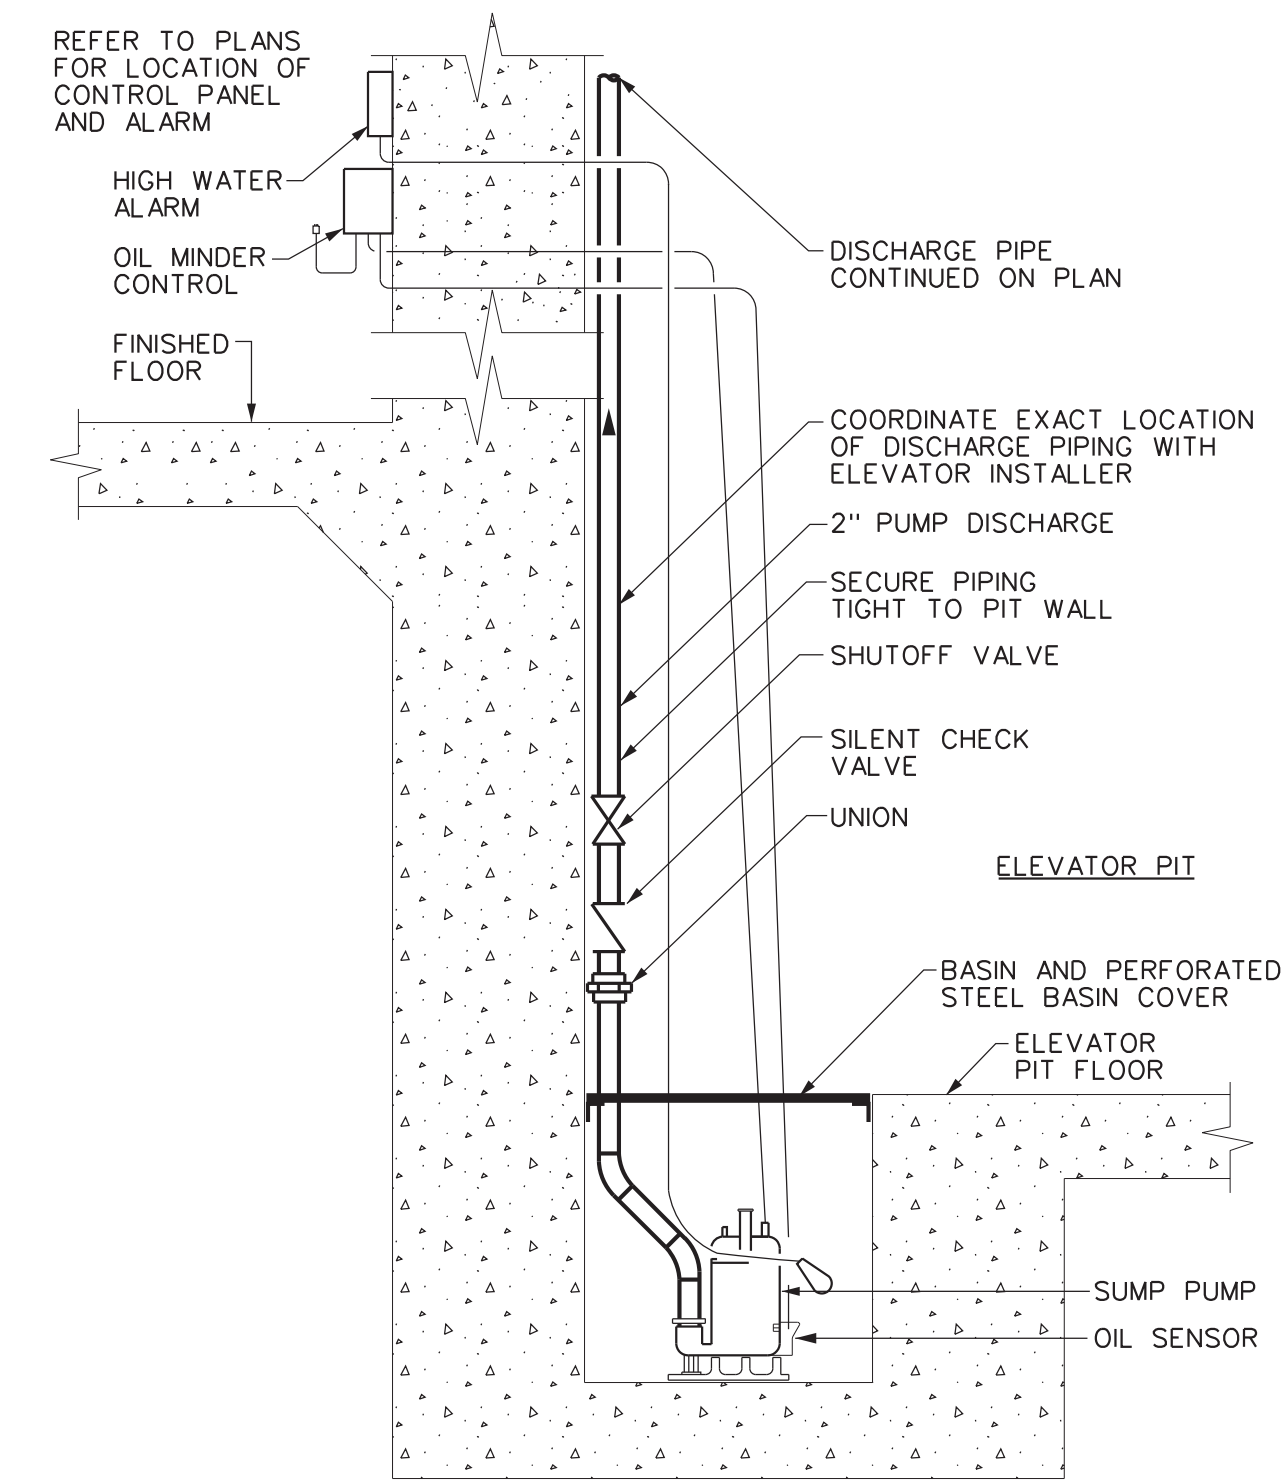


1
P601
ELEVATOR SUMP PUMP DETAIL
SCALE: NONE
BASIN IN SHAFT

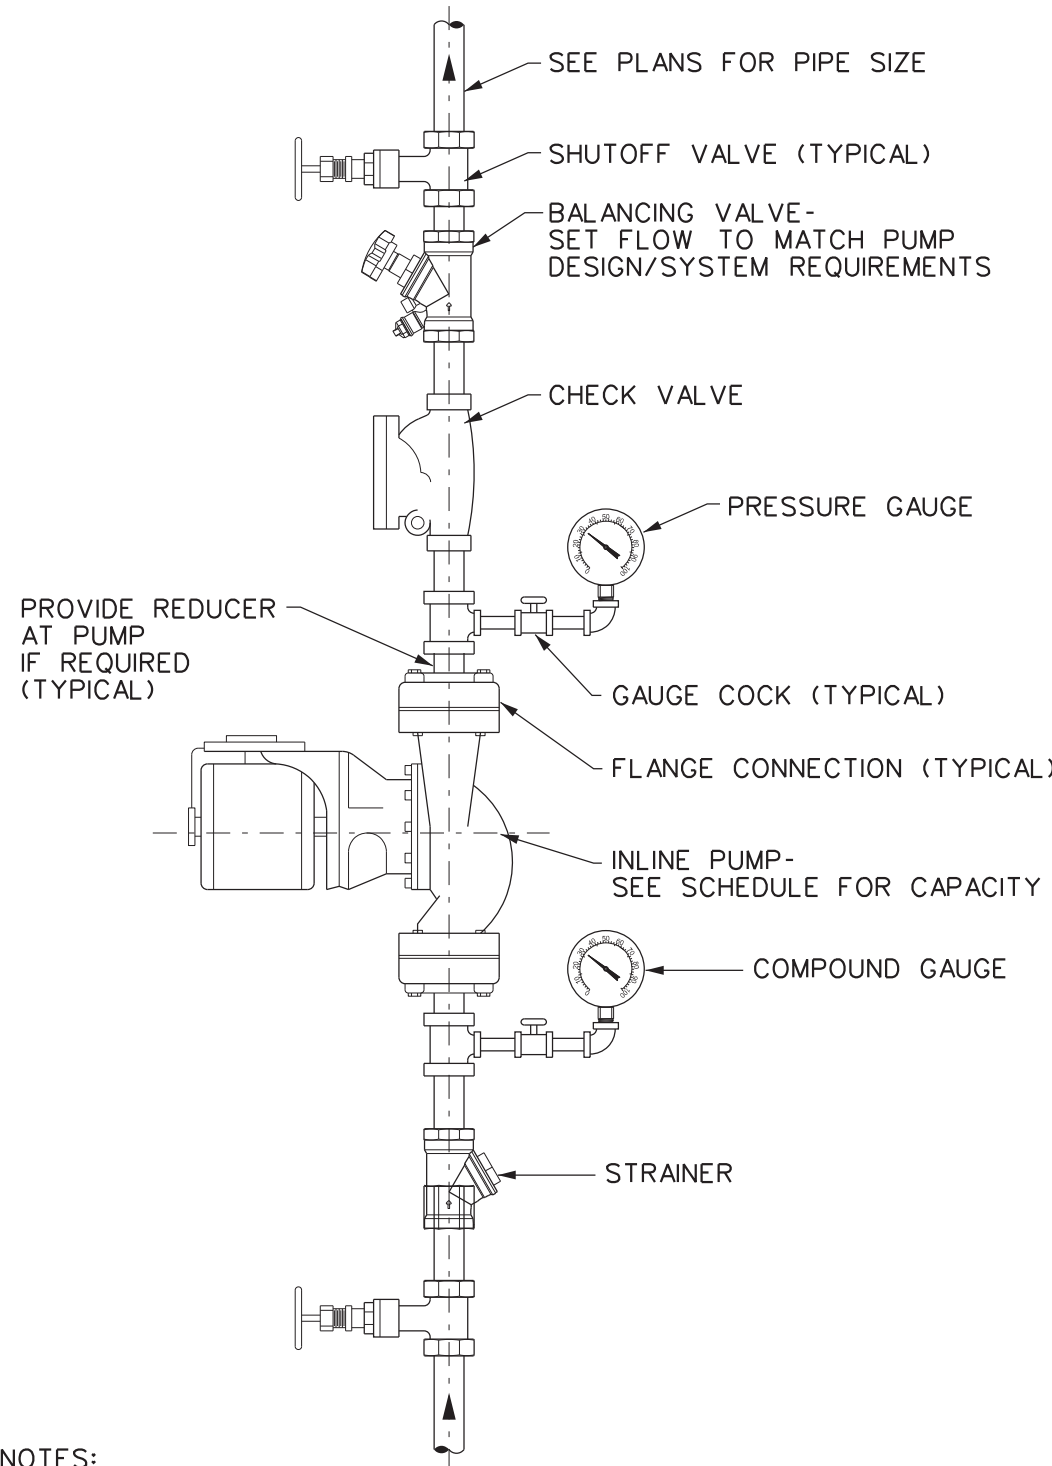

DETAIL NOTES:

- PRESSURE GAUGES - SELECT GAUGE RANGE TO PLACE MAXIMUM SYSTEM OPERATING PRESSURE IN MIDDLE THIRD OF RANGE.
- PROVIDE UNION ON PUMP INLET AND OUTLET IF PUMP IS NOT FLANGED.
- INSTALL PUMP WITH SHAFT HORIZONTAL. PIPING MAY BE INSTALLED VERTICAL, AS SHOWN, OR HORIZONTAL DEPENDING ON SITE CONDITIONS.
- INSTALL CHECK VALVE HORIZONTALLY OR VERTICALLY WITH FLOW UPWARD.


5
P601
INLINE PUMP DETAIL
SCALE: NONE

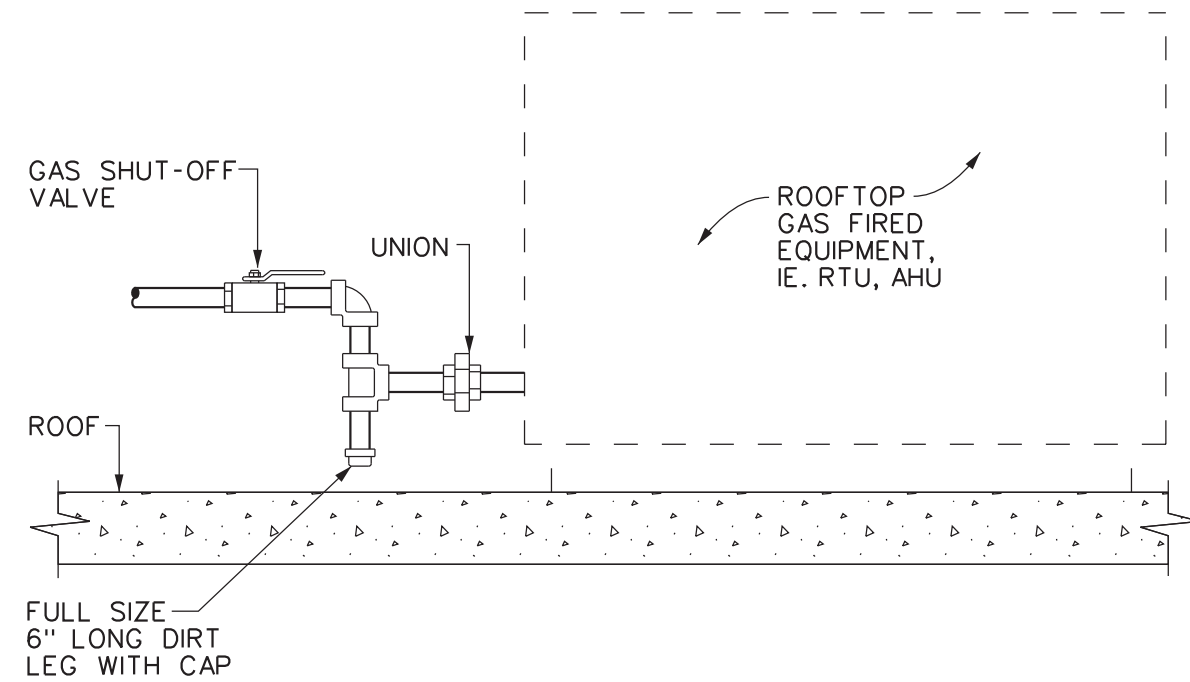

DETAIL NOTES:

- PROVIDE SHUT-OFF VALVE, DIRT LEG AND UNION AT EACH GAS CONNECTION ON EACH PIECE OF EQUIPMENT.
- VERIFY CONNECTION SIZES, QUANTITIES AND LOCATIONS WITH M.C.
- PLUMBING CONTRACTOR IS RESPONSIBLE FOR FINAL CONNECTION.
- REFER TO DRAWING, --- FOR GAS PIPING SUPPORT DETAIL.


2
P601
GAS EQUIPMENT CONNECTION DETAIL - ROOFTOP
SCALE: NONE

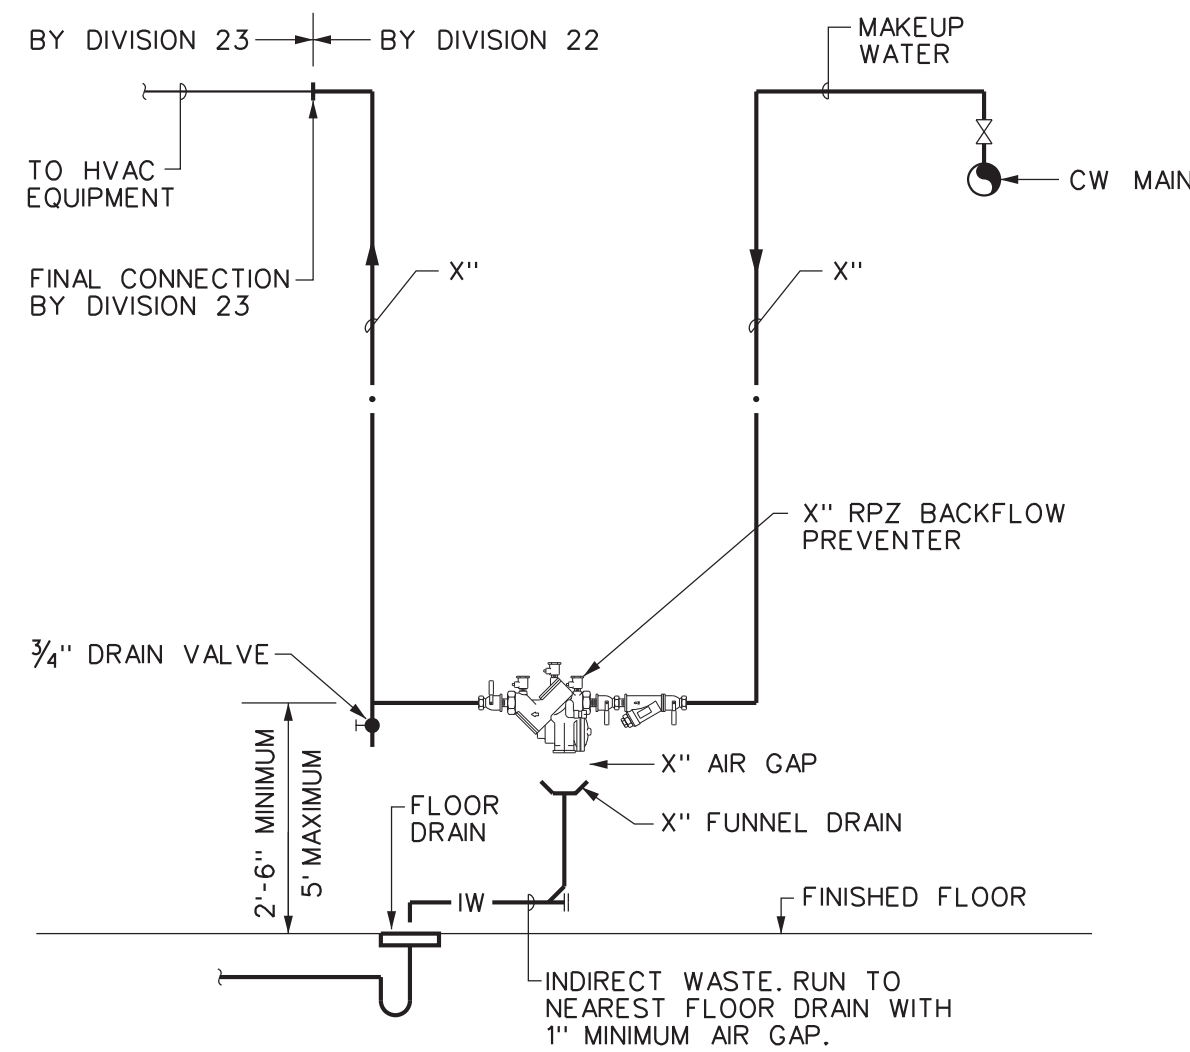

DETAIL NOTES:

- BACKFLOW PREVENTER SHALL BE LOCATED UPSTREAM OF ALL CONNECTIONS TO HVAC EQUIPMENT.
- PROVIDE PROPER SUPPORTS FOR BACKFLOW PREVENTER AND PIPING.
- PROVIDE 8" CLEARANCE BEHIND BACKFLOW PREVENTER, 1'-0" ABOVE AND 2'-6" CLEARANCE IN FRONT OF DEVICE.
- THE INSTALLATION OF A FIXED AIR GAP FITTING IS NOT ACCEPTABLE FOR USE ON DRAIN LINE. PROVIDE FUNNEL DRAIN AS INDICATED.
- PAINT SUPPORTS WITH ONE(1) PRIMER AND TWO(2) FINISH COATS OF COLOR AS SPECIFIED.

6
P601
MAKE-UP WATER BACKFLOW PREVENTER DETAIL
SCALE: NONE

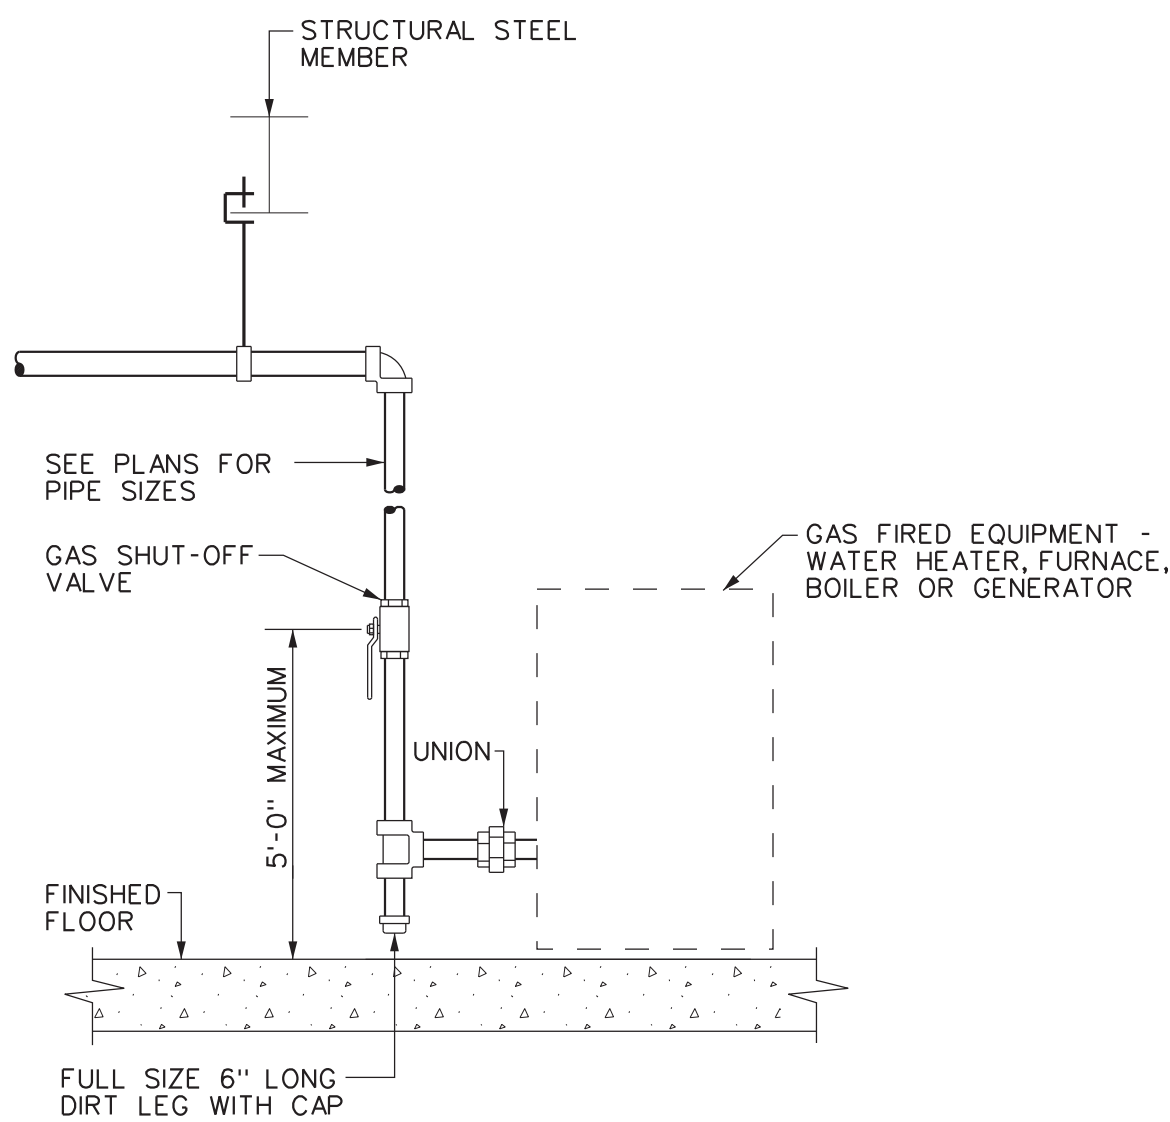

DETAIL NOTES:

- PROVIDE SHUT-OFF VALVE, DIRT LEG AND UNION AT EACH GAS CONNECTION ON EACH PIECE OF EQUIPMENT.
- VERIFY CONNECTION SIZES, QUANTITIES AND LOCATIONS WITH M.C.
- P.C. IS RESPONSIBLE FOR FINAL CONNECTION.

3
P601
GAS EQUIPMENT CONNECTION DETAIL
SCALE: NONE

DATE: 8/11/2020
REVISION


PROJECT NO. 200095
DESIGNED BY: MUC
DRAWN BY: MUC
CHECKED BY: RSA
SCALE: AS NOTED
NOTES:

DETAILS


**HARRIS A. SANDERS
ARCHITECTS, P.C.**
252 WASHINGTON AVENUE, ALBANY, NEW YORK 12210
L'DOR ADULT CARE FACILITY
156 WEST CLARKSTOWN ROAD
NEW CITY, N.Y. 10956


SHEET NO.

P601

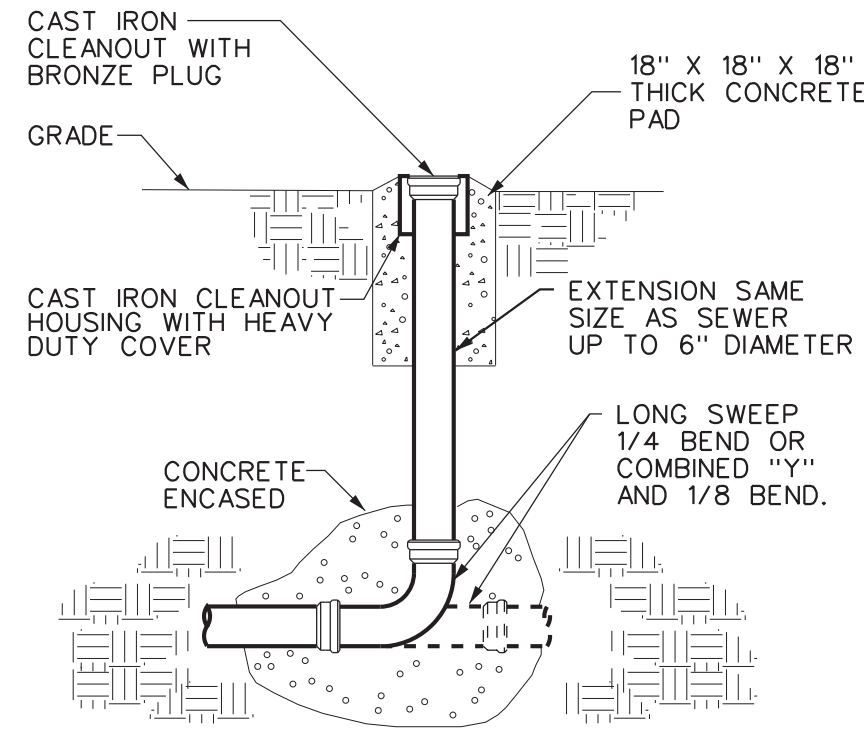


 DETAIL NOTE:
A. EXTENSION AND BASE FITTINGS SHALL BE SERVICE WEIGHT CAST IRON.

 **YARD CLEANOUT DETAIL**
SCALE: NONE

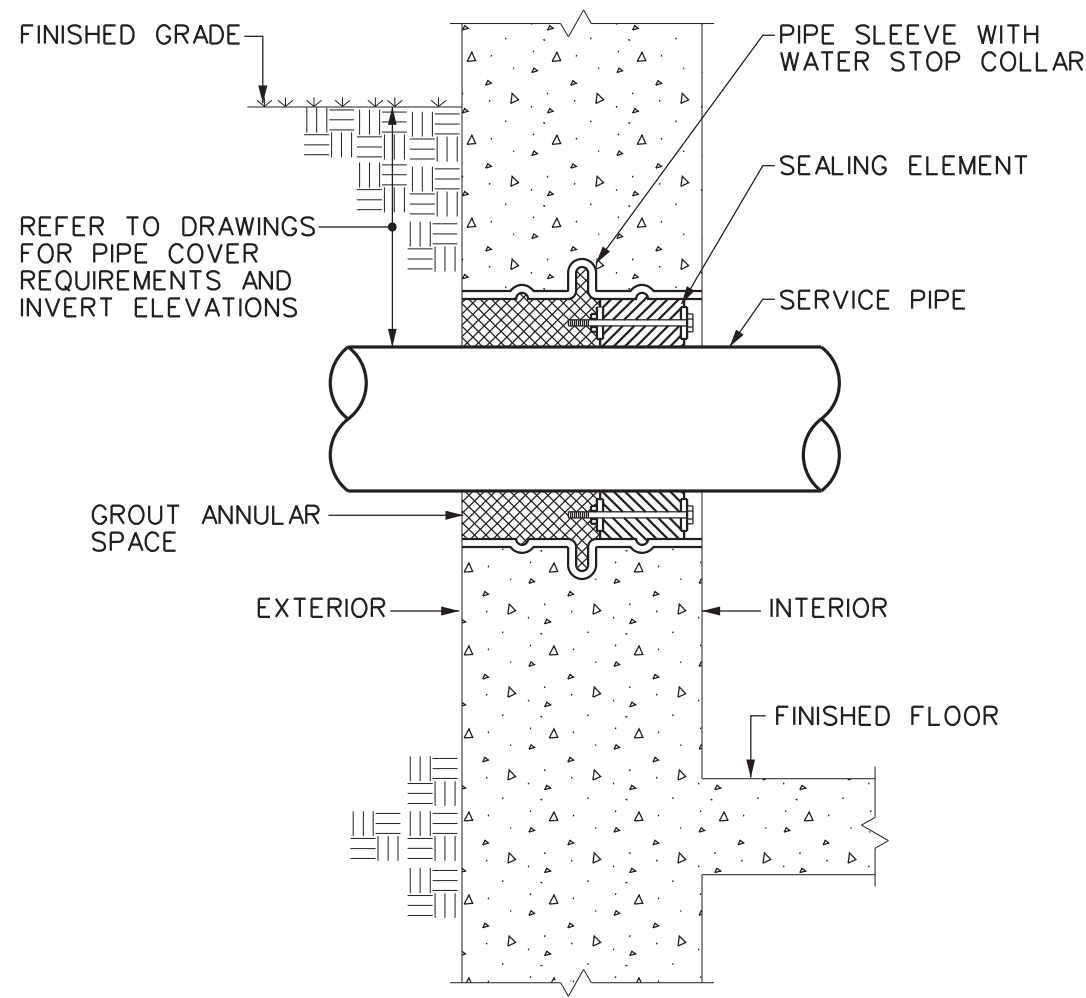

 **PIPE THRU NEW EXTERIOR WALL DETAIL**
SCALE: NONE

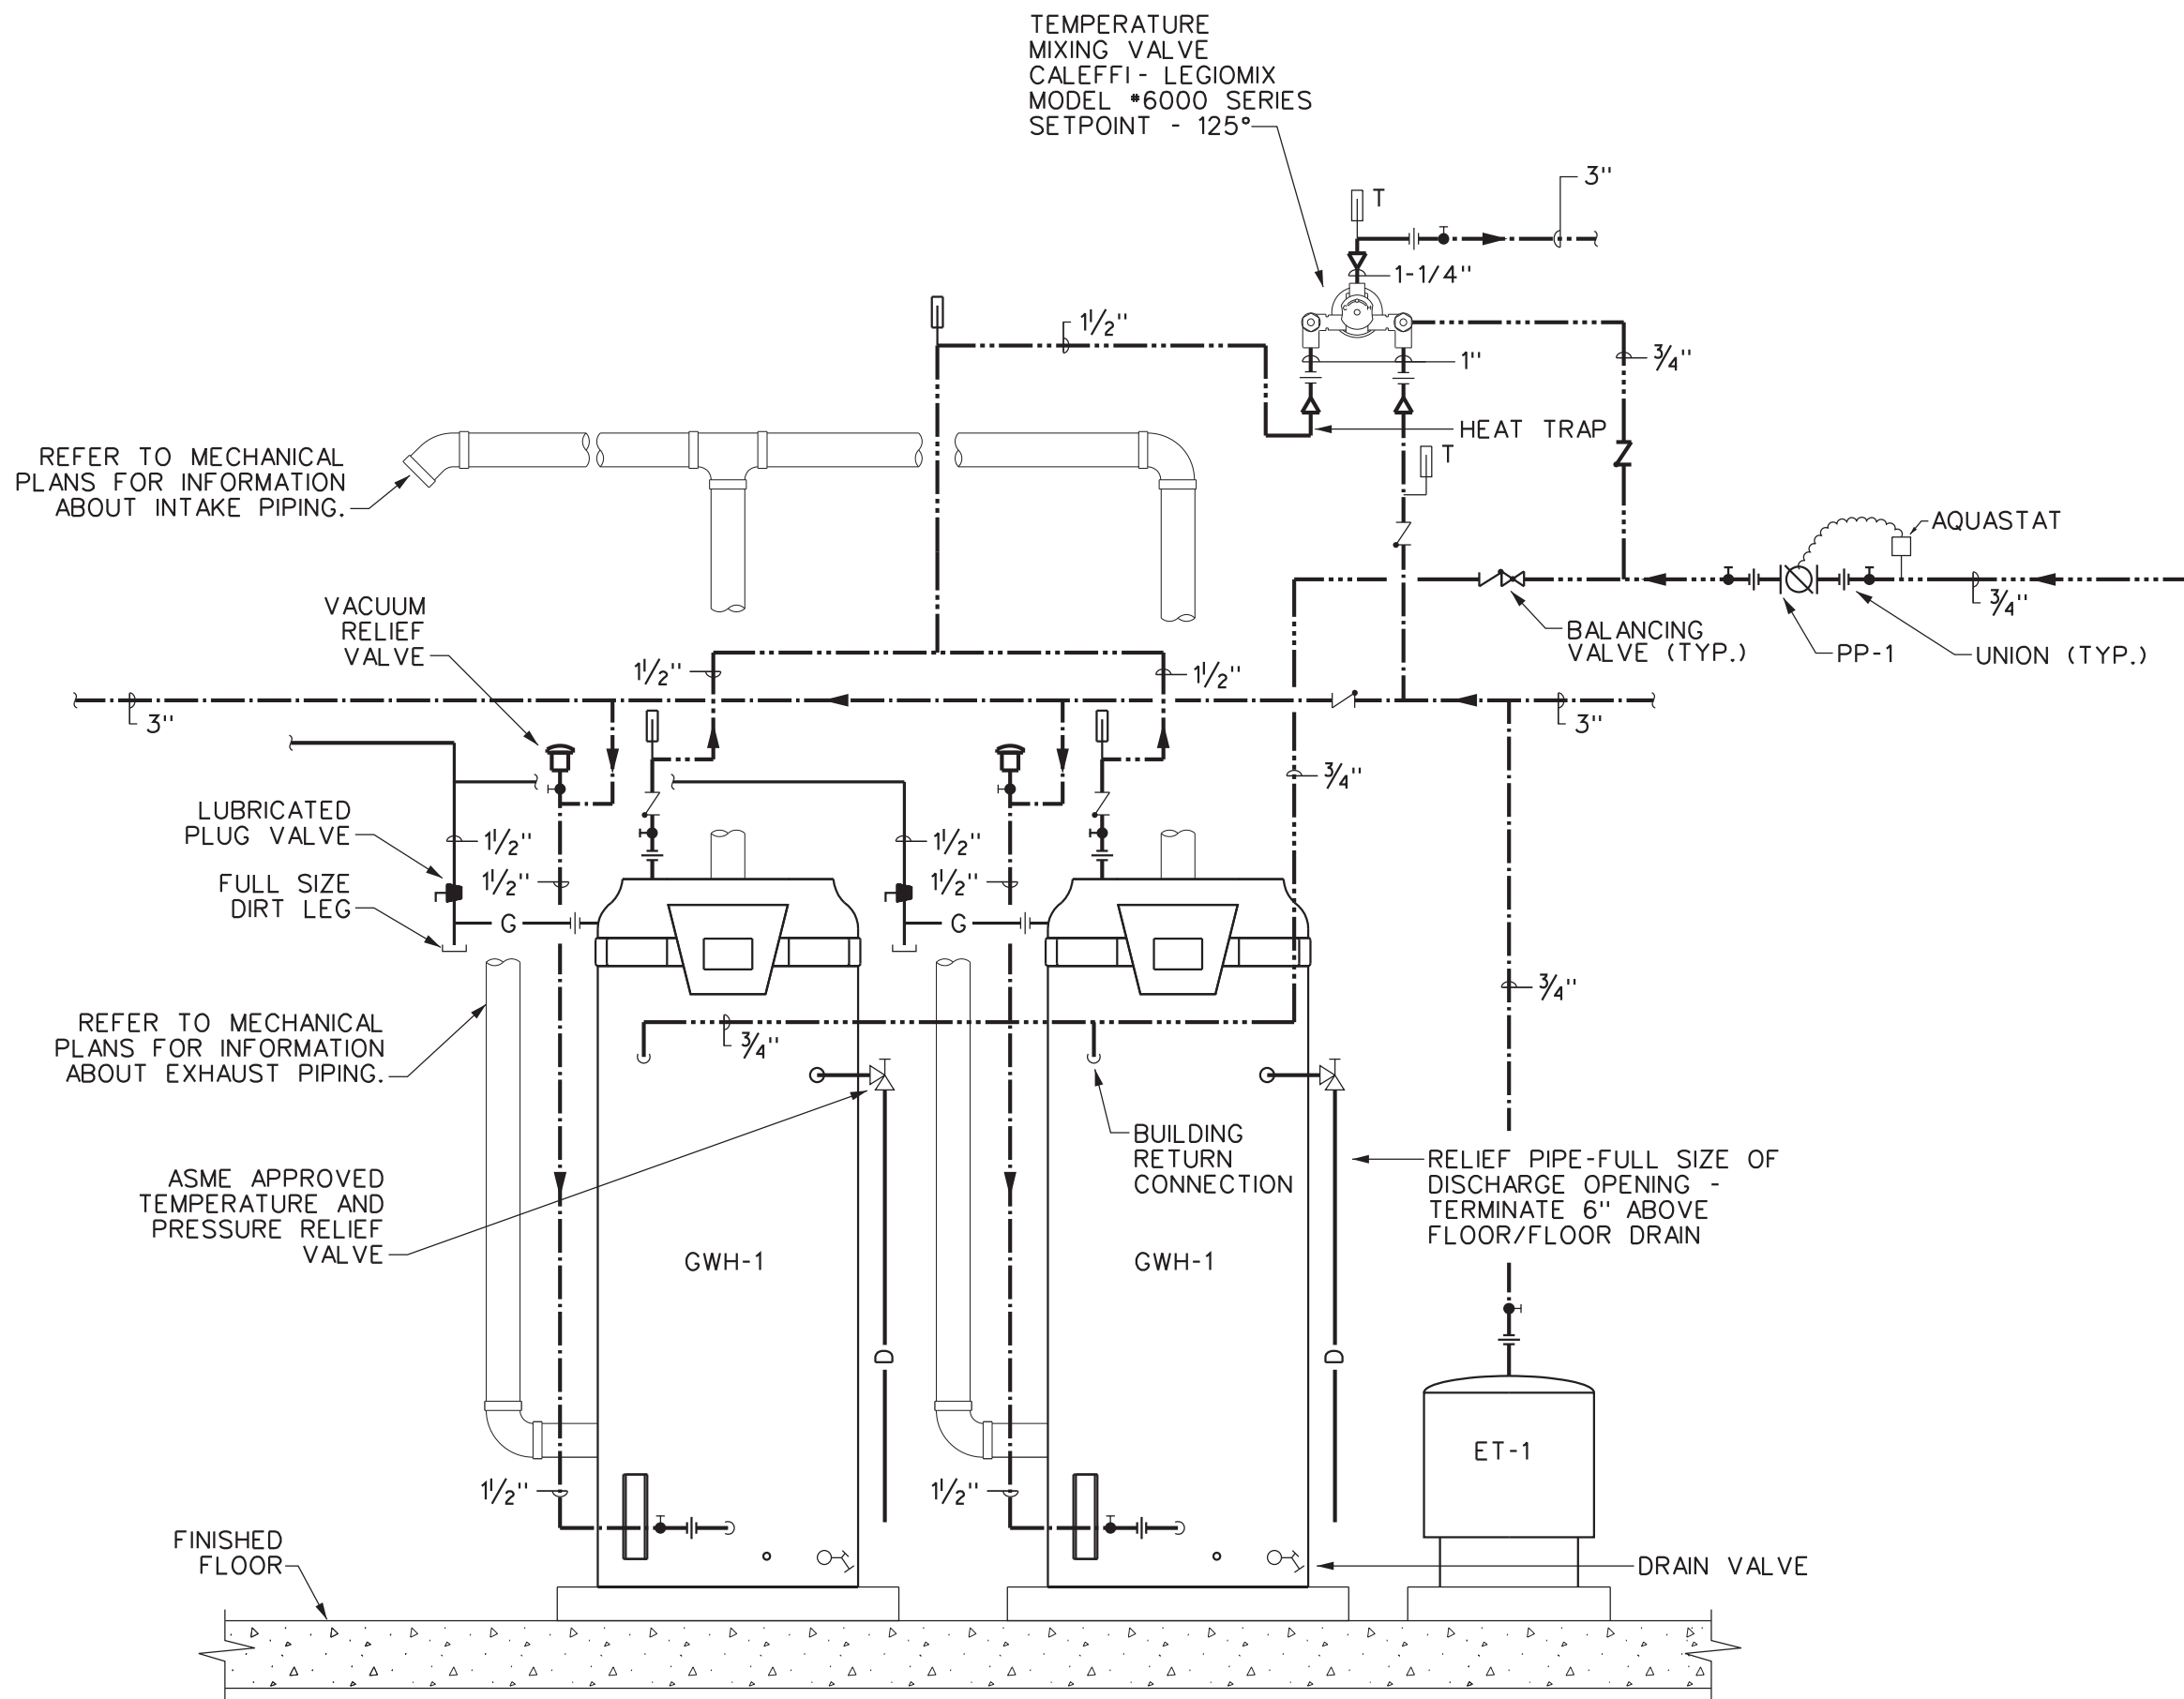

- DETAIL NOTES:
- A. PROVIDE PIPE NIPPLE THRU EQUIPMENT CASE. CSST & FLEX CONNECTORS SHALL NOT EXTEND THRU EQUIPMENT CASE.
 - B. PROVIDE SHUT-OFF VALVE AND UNION AT EACH SUPPLY PIPING CONNECTION.
 - C. P.C. IS RESPONSIBLE FOR FINAL CONNECTIONS
 - D. THIS DETAIL IS GENERIC. WATER HEATER MFRS. INSTRUCTIONS ARE TO BE FOLLOWED WHERE THEY DIFFER FROM THESE INSTRUCTIONS.
 - E. COORDINATE WITH STRUCTURAL FOR EQUIPMENT PAD SIZES.

 **GWH-1&2 WATER HEATER DETAIL**
SCALE: NONE

DATE: 8/11/2020
REVISION:

PROJECT NO: 200095
DESIGNED BY: MJC
DRAWN BY: MJC
CHECKED BY: RSA
SCALE: AS NOTED
NOTES:

DETAILS

**HARRIS A. SANDERS
ARCHITECTS, P.C.**
252 WASHINGTON AVENUE, ALBANY, NEW YORK 12210

L'DOR ADULT CARE FACILITY
156 WEST CLARKSTOWN ROAD
NEW CITY, N.Y. 10956

SHEET NO: