




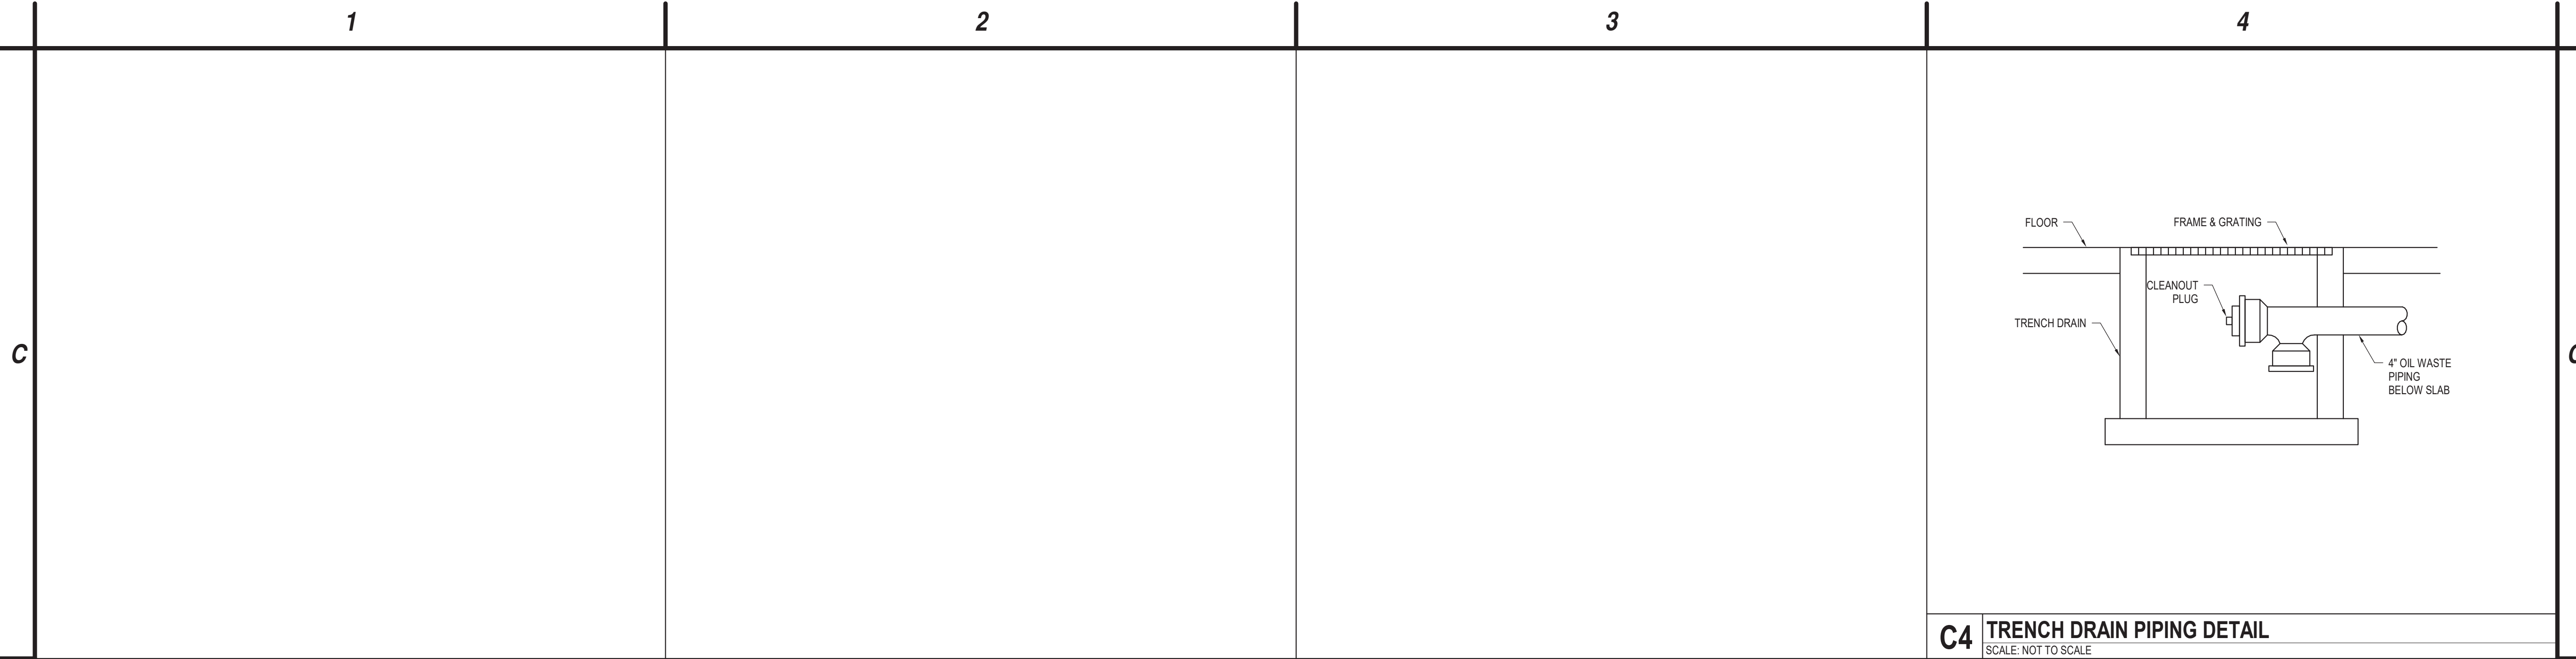


C4 TRENCH DRAIN PIPING DETAIL
SCALE: NOT TO SCALE

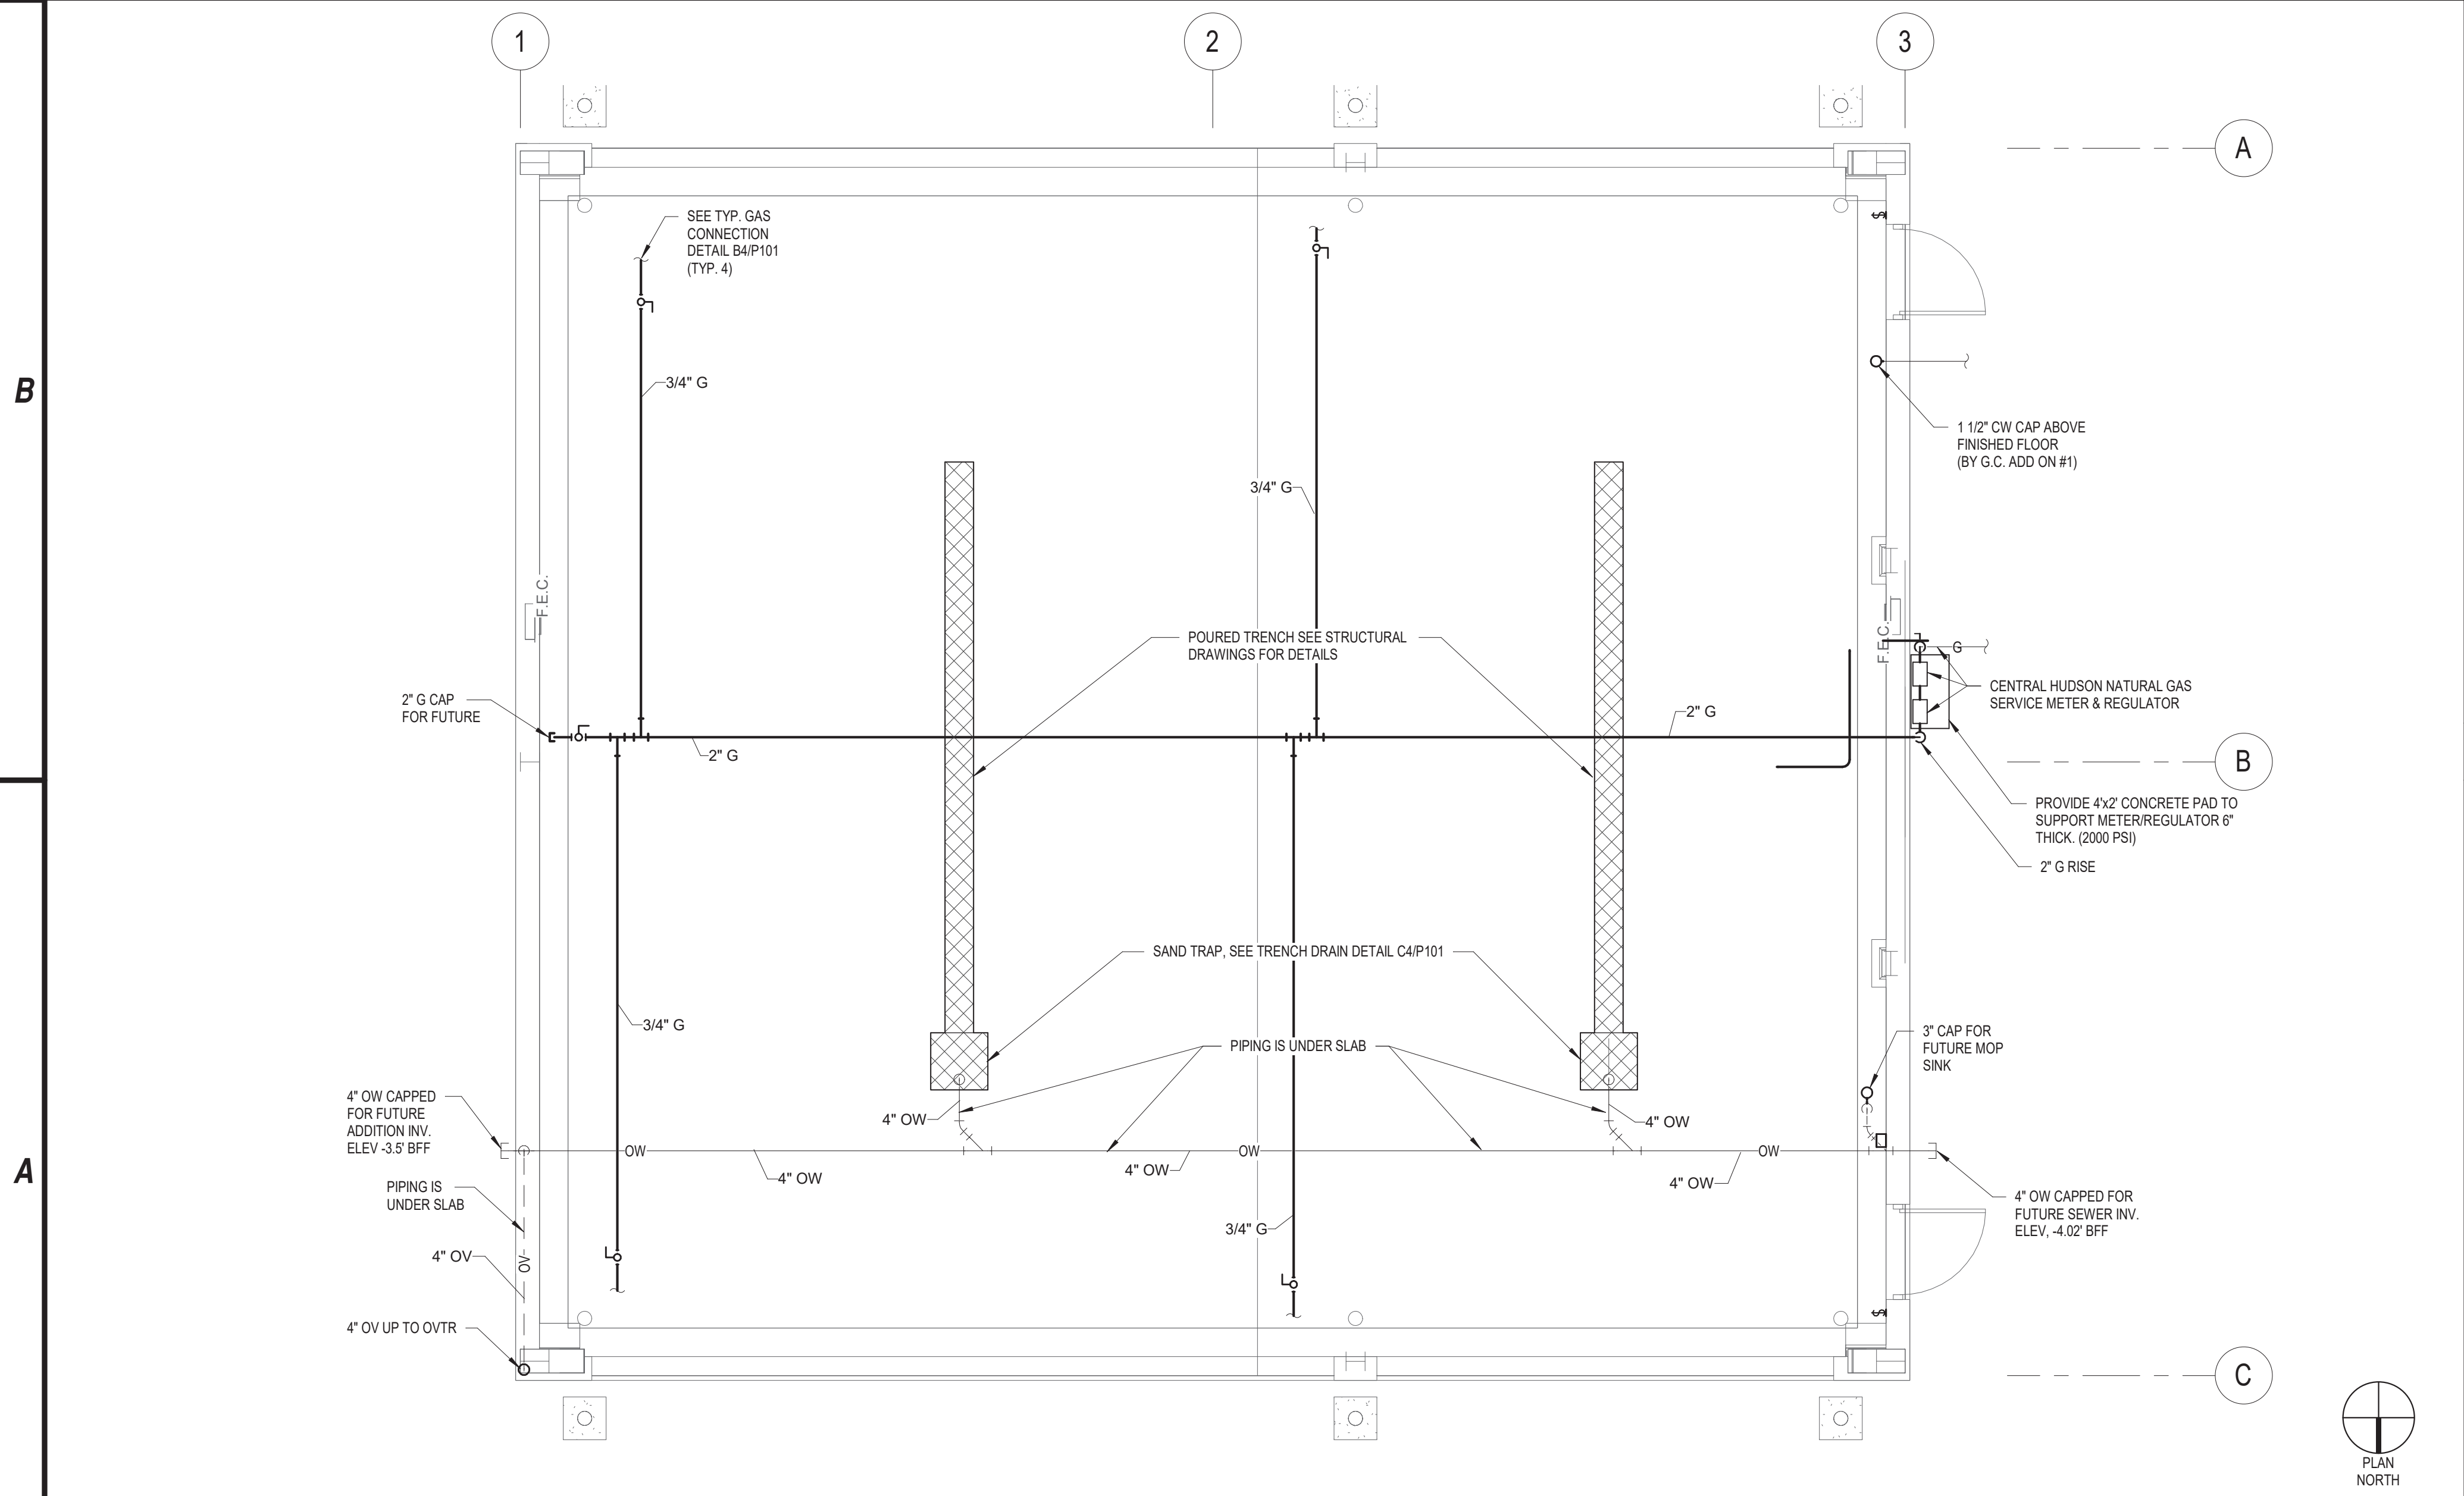

A1 PLUMBING FLOOR PLAN
SCALE: 1/4" = 1'-0"

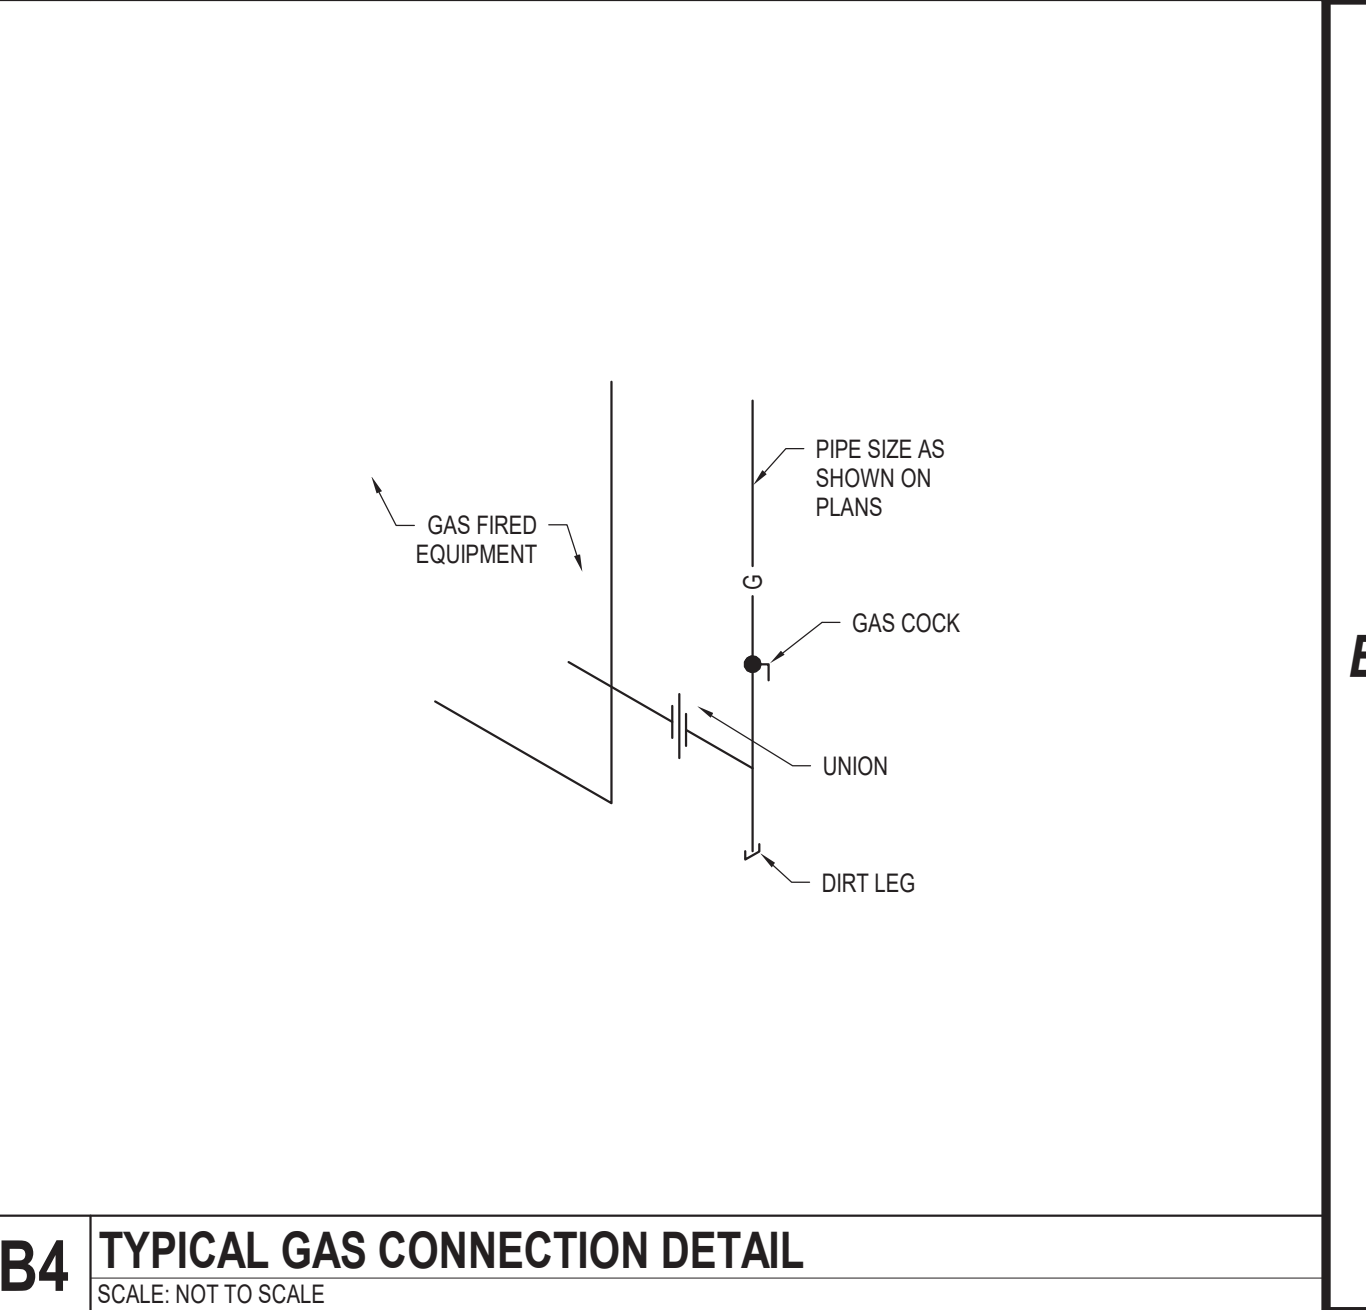


B4 TYPICAL GAS CONNECTION DETAIL
SCALE: NOT TO SCALE

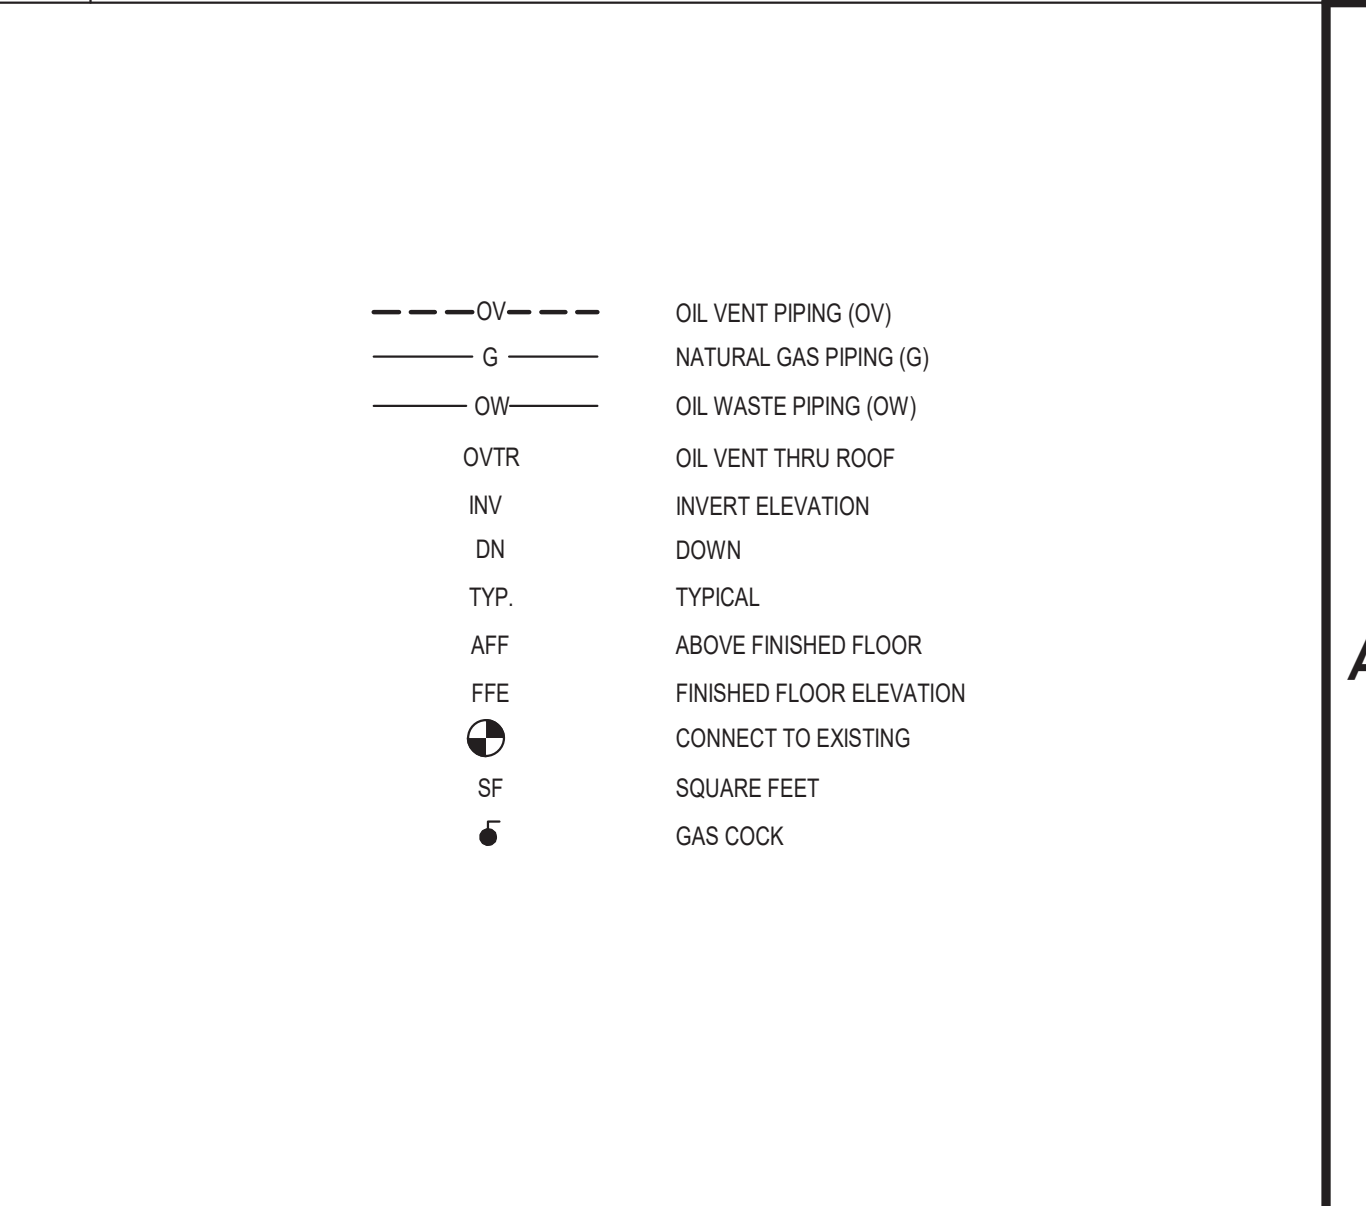

A4 LEGEND
SCALE: NOT TO SCALE



C&S Engineers, Inc.
499 Col. Eileen Collins Blvd.
Syracuse, New York 13212
Phone: 315-455-2000
Fax: 315-455-9667
www.cscos.com

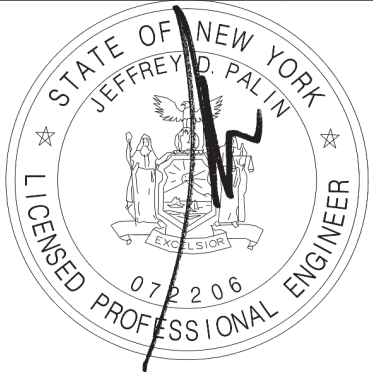

SRE BUILDING
ORANGE COUNTY AIRPORT
500 DUNN ROAD
MONTGOMERY NY 12549

MARK	DATE	DESCRIPTION
REVISIONS		
PROJECT NO: 104120001		
DATE: FEBRUARY 2021		
DRAWN BY: E. LUKOWSKI		
DESIGNED BY: D. CHAMBERS		
CHECKED BY: J. PALIN, P.E.		
NO ALTERATION PERMITTED HEREON EXCEPT AS PROVIDED UNDER SECTION 7209 SUBDIVISION 2 OF THE NEW YORK EDUCATION LAW		

PLUMBING FLOOR PLAN
& DETAILS

P-101