



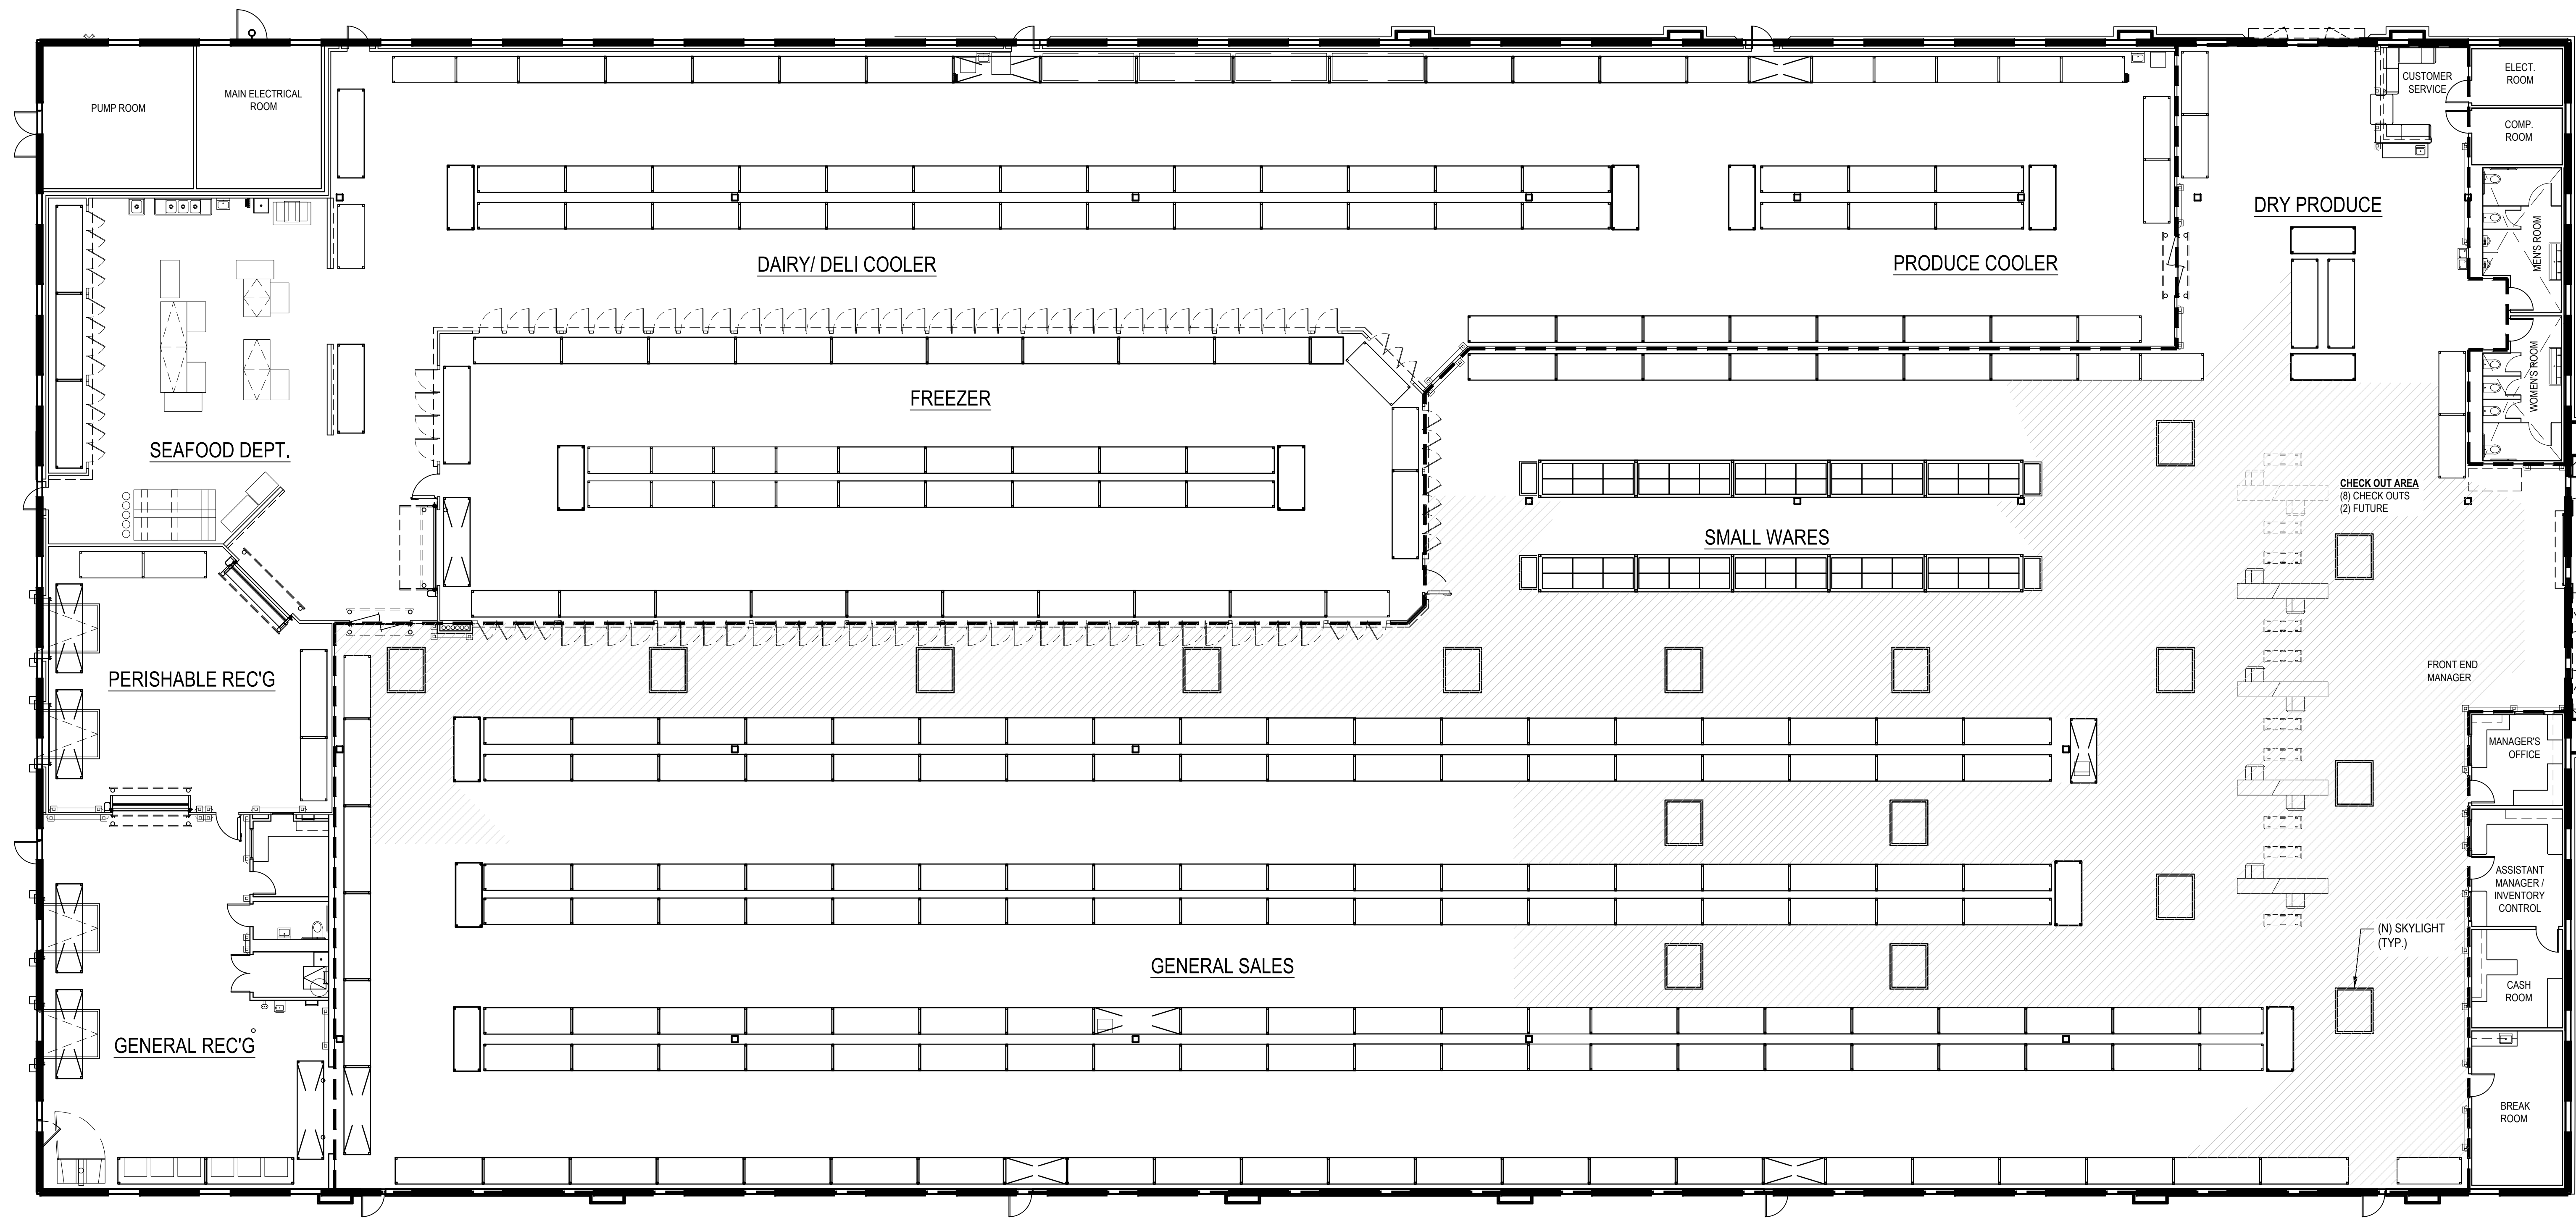

DAYLIGHTING REQUIREMENTS			
QUALIFIED SPACES: GENERAL SALES, SMALL WARES, DRY PRODUCE, CHECKOUT AREA			
AREA:			
TOTAL SF:	19,663 SF		
REQUIRED TOPLIT DAYLIGHT ZONE (50%):	9,832 SF		
ACTUAL:	10,443 SF		
MIN. EFFECTIVE APERTURE > 1%			
ACTUAL:	85 (33.6 SF x 17') (7') (9)		
	10,443 S.F.	=	2.9%

LEGEND	
	EXTENT OF THERMAL ENVELOPE
	QUALIFIED DAYLIGHT AREAS
	DENOTES "TOPLIT DAYLIGHT AREA"

DAYLIGHTING PLAN
SCALE: 3/32"=1'-0"

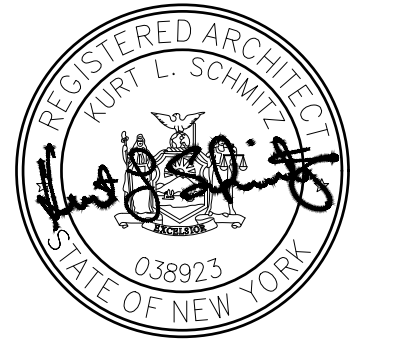

KLS
ARCHITECT
Kurt L. Schmitz, Architect
17710 Queens Blvd., Suite 407
Flushing, NY 11355
Phone (718) 521-5134 • Fax (718) 521-4824 • www.klsarchitects.com

Restaurant Depot / BREWSTER, NY
DANBURY ROAD (LOT 48 | BLOCK 0002) BREWSTER, NY 10509
THESE DOCUMENTS CONTAIN INFORMATION PROPRIETARY TO ADA ARCHITECTS, INC.
UNAUTHORIZED USE OF THESE DOCUMENTS IS EXPRESSLY PROHIBITED UNLESS AGREED UPON IN WRITING.

#	DATE	TYPE
1		
2		
3		
4		
5		
6		
7		
8		
9		
10		

DAY LIGHTING
PLAN

DATE: 9/10/2020
JOB NO. 19230

A-0.3
SHEET NO.