


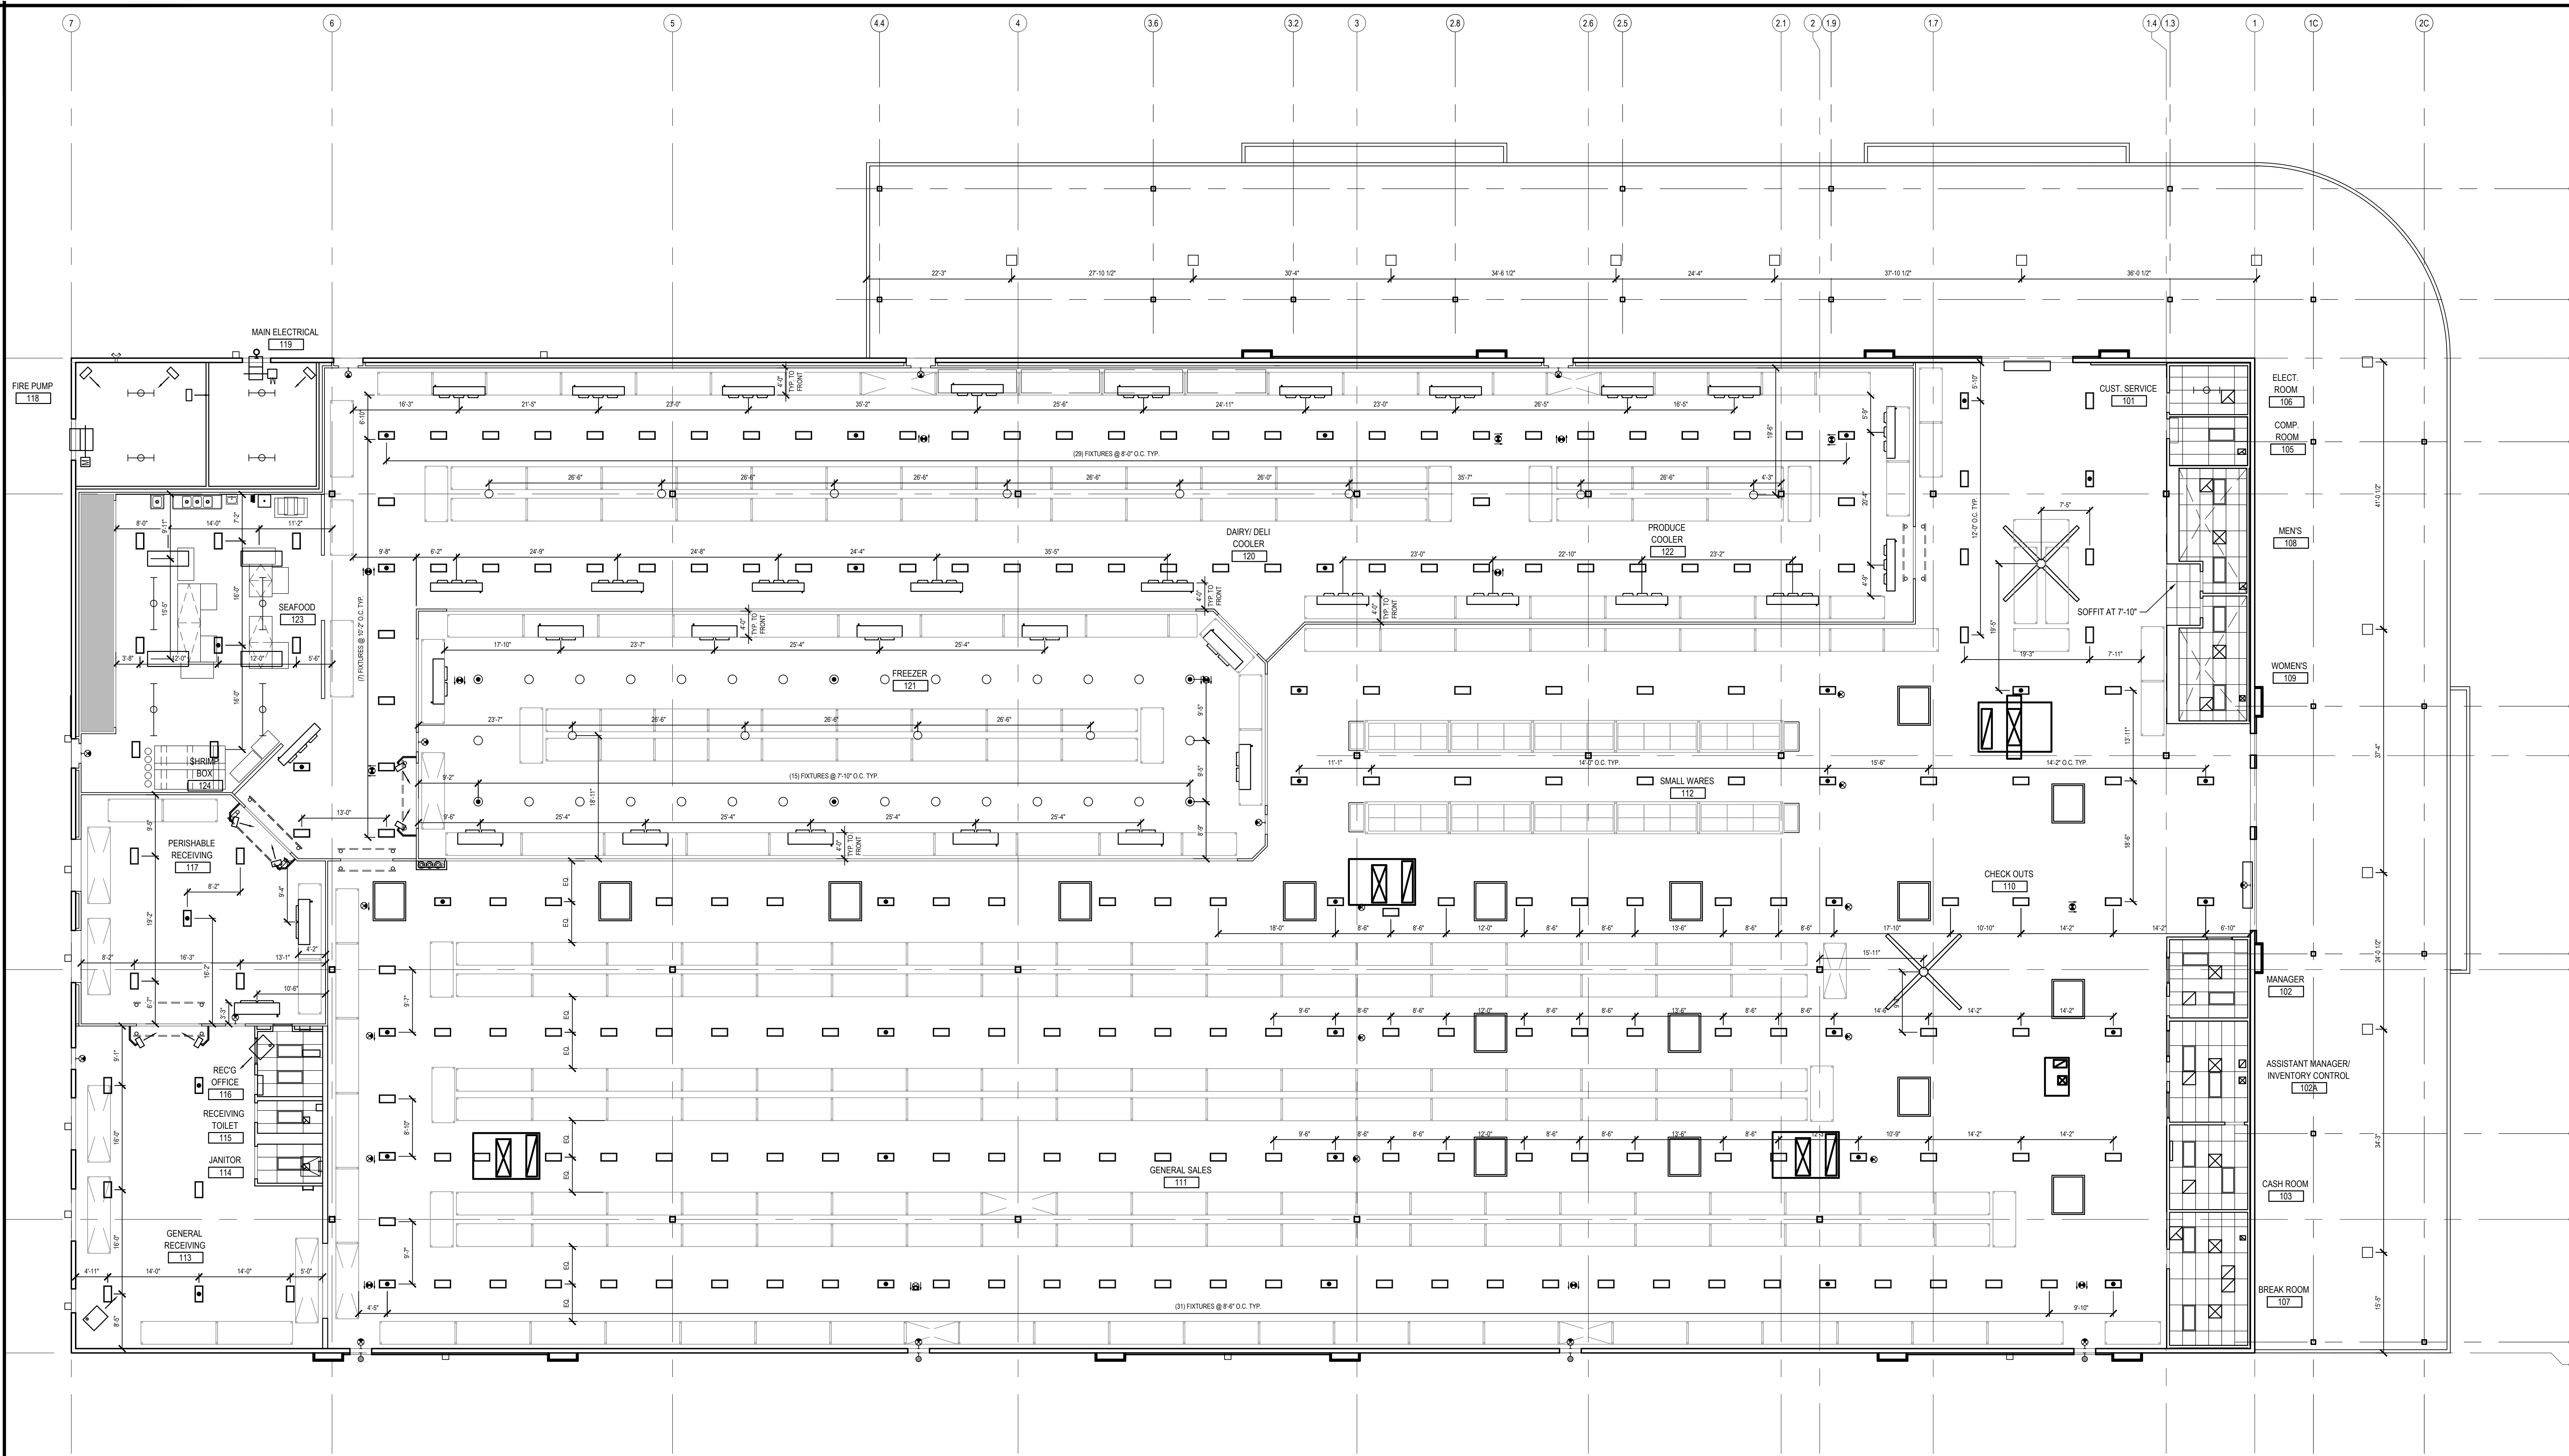

DENOTES TUNNEL RACKS
12'-0" CLEAR OPENING @ MAIN DOORS & 12'-0" CLEAR
@ OTHER LOCATIONS UNLESS NOTED OTHERWISE

DIRECTIONAL EXIT SIGN

EXIT SIGN

EXTERIOR LIGHT

SUSPEND 2x4 LIGHT FIXTURE IN SUSPENDED
CEILING GRID. SEE CEILING NOTES AND ELECTRICAL
DRAWINGS FOR MORE INFORMATION

5'-0" x 8'-0" SKYLIGHTS

DENOTES REFRIGERATED AREA W/ CEILING HEIGHT
@ 10'-6 1/2" A.F.F. (SHRIMP BOX)

SUSPEND 2x4 LIGHT FIXTURE. SEE ELECTRICAL
DRAWINGS FOR MORE INFORMATION

SUSPENDED STRIP LIGHT FIXTURE. SEE ELECTRICAL
DRAWINGS FOR MORE INFORMATION

SURFACE MOUNTED STRIP LIGHT FIXTURE. SEE
ELECTRICAL DRAWINGS FOR MORE INFORMATION

SURFACE MOUNTED COOLER LIGHT FIXTURE. SEE
ELECTRICAL DRAWINGS FOR MORE INFORMATION

SURFACE MOUNTED CANOPY LIGHT. SEE ELECTRICAL
DRAWINGS FOR MORE INFORMATION

ROOF TOP HVAC UNITS. SEE MECHANICAL DRAWINGS
FOR MORE INFORMATION

DENOTES REFRIGERATED AREA W/ CEILING HEIGHT
@ 23'-3" A.F.F.

MECHANICAL DIFFUSERS, RETURN AIR GRILLES. SEE
MECHANICAL DRAWINGS FOR MORE INFORMATION

CEILING FAN. SEE MECHANICAL DRAWINGS FOR MORE
INFORMATION

UNIT HEATERS. SEE MECHANICAL DRAWINGS FOR MORE
INFORMATION

REFRIGERATION EVAPORATORS. SEE REFRIGERATION
DRAWINGS FOR MORE INFORMATION

REFLECTED CEILING PLAN
SCALE: 3/32"=1'-0"

GENERAL CEILING NOTES:

1. SEE ROOM FINISH SCHEDULE, SHEET A-8.1, FOR ALL CEILING FINISHES.
2. UNLESS OTHERWISE NOTED, ALL SUSPENDED ACOUSTICAL PANEL CEILING HEIGHTS
ARE 8'-0" A.F.F.
3. SEE SHEET A-2.2 FOR DIMENSIONS OF RACKING.
4. SEE ELEC. DWGS. FOR ADDITIONAL INFORMATION.
5. SEE MECH. DWGS. FOR ADDITIONAL INFORMATION.
6. ANY TRADE, CONTRACTOR, OR SUB CONTRACTOR THAT PENETRATES THE COOLER
CEILING PANELS SHALL FULLY SEAL AND CAULK THE PENETRATIONS WITH
EXPANDABLE FOAM, FULL DEPTH OF CEILING PANEL.
7. COORDINATE OVERHEAD DOOR CHAIN AND TRUCK CAB LIGHT FIXTURES. VERIFY
THAT CHAIN AND LIGHTS ARE ON OPPOSITE SIDES.
8. ALL DIMENSIONS ARE TO CENTERLINE OF LIGHT FIXTURE.

Restaurant Depot / BREWSTER, NY
DANBURY ROAD (LOT 48 | BLOCK 0002)
BREWSTER, NY 10509
Kurt L. Schmitz, Architect
17110 Old Country Road, Suite 4407
Phone (216) 521-5134 • Fax (216) 521-4824 • www.klsarchitects.com

REVISIONS

#	DATE	TYPE
1		
2		
3		
4		
5		
6		
7		
8		
9		
10		

REFLECTED CEILING PLAN

DATE: 9/10/2020
JOB NO. 19230
A-3.1
SHEET NO.