
 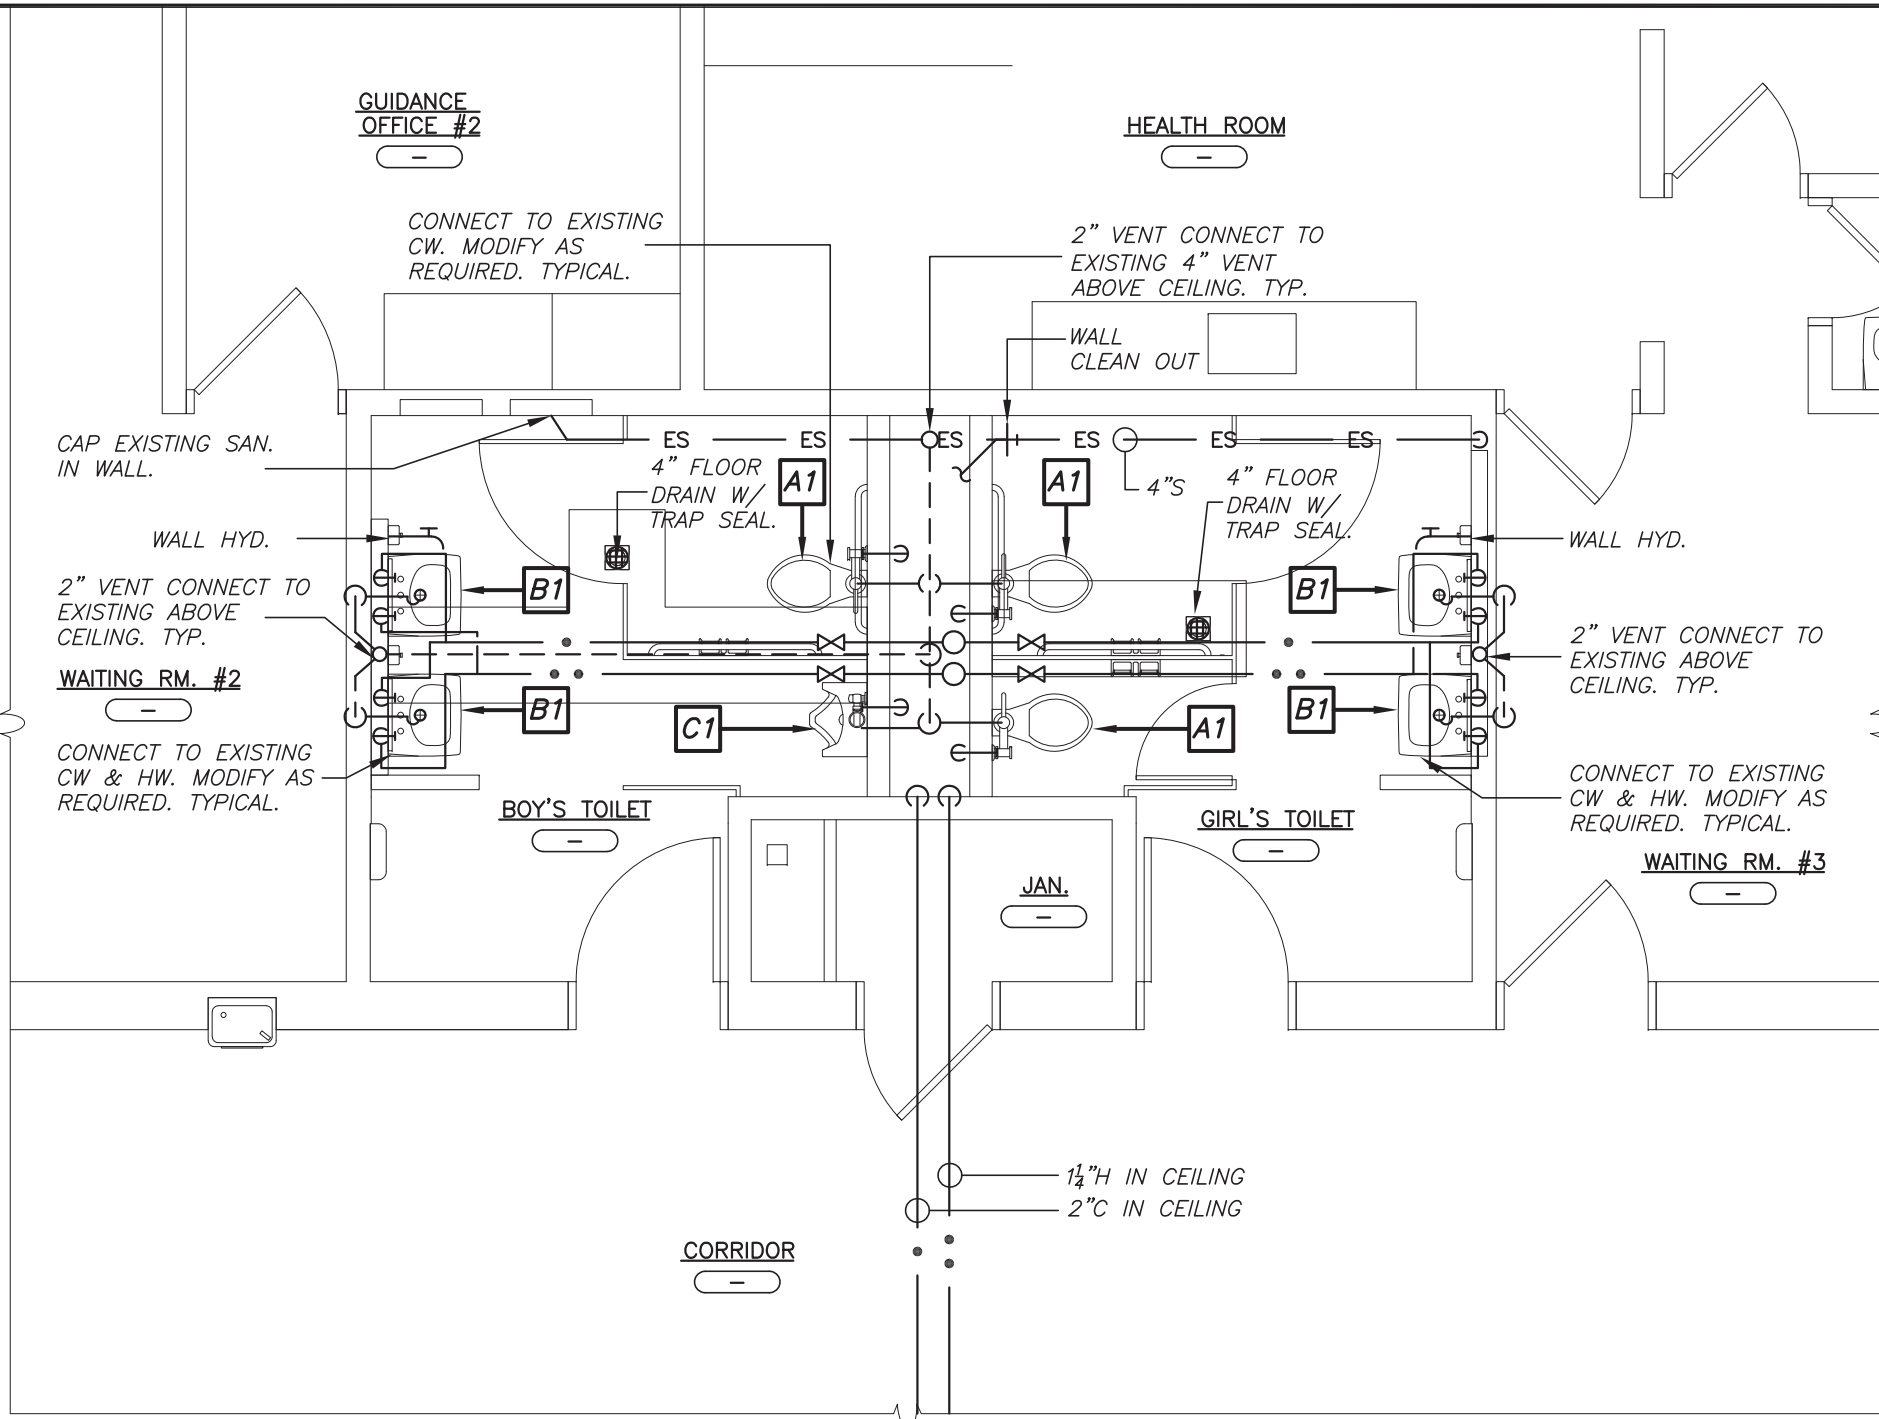



1 FIRST FLOOR PLUMBING REMOVAL PLAN

SCALE: 1/4" = 1'-0"




2 FIRST FLOOR PLUMBING PLAN

SCALE: 1/4" = 1'-0"

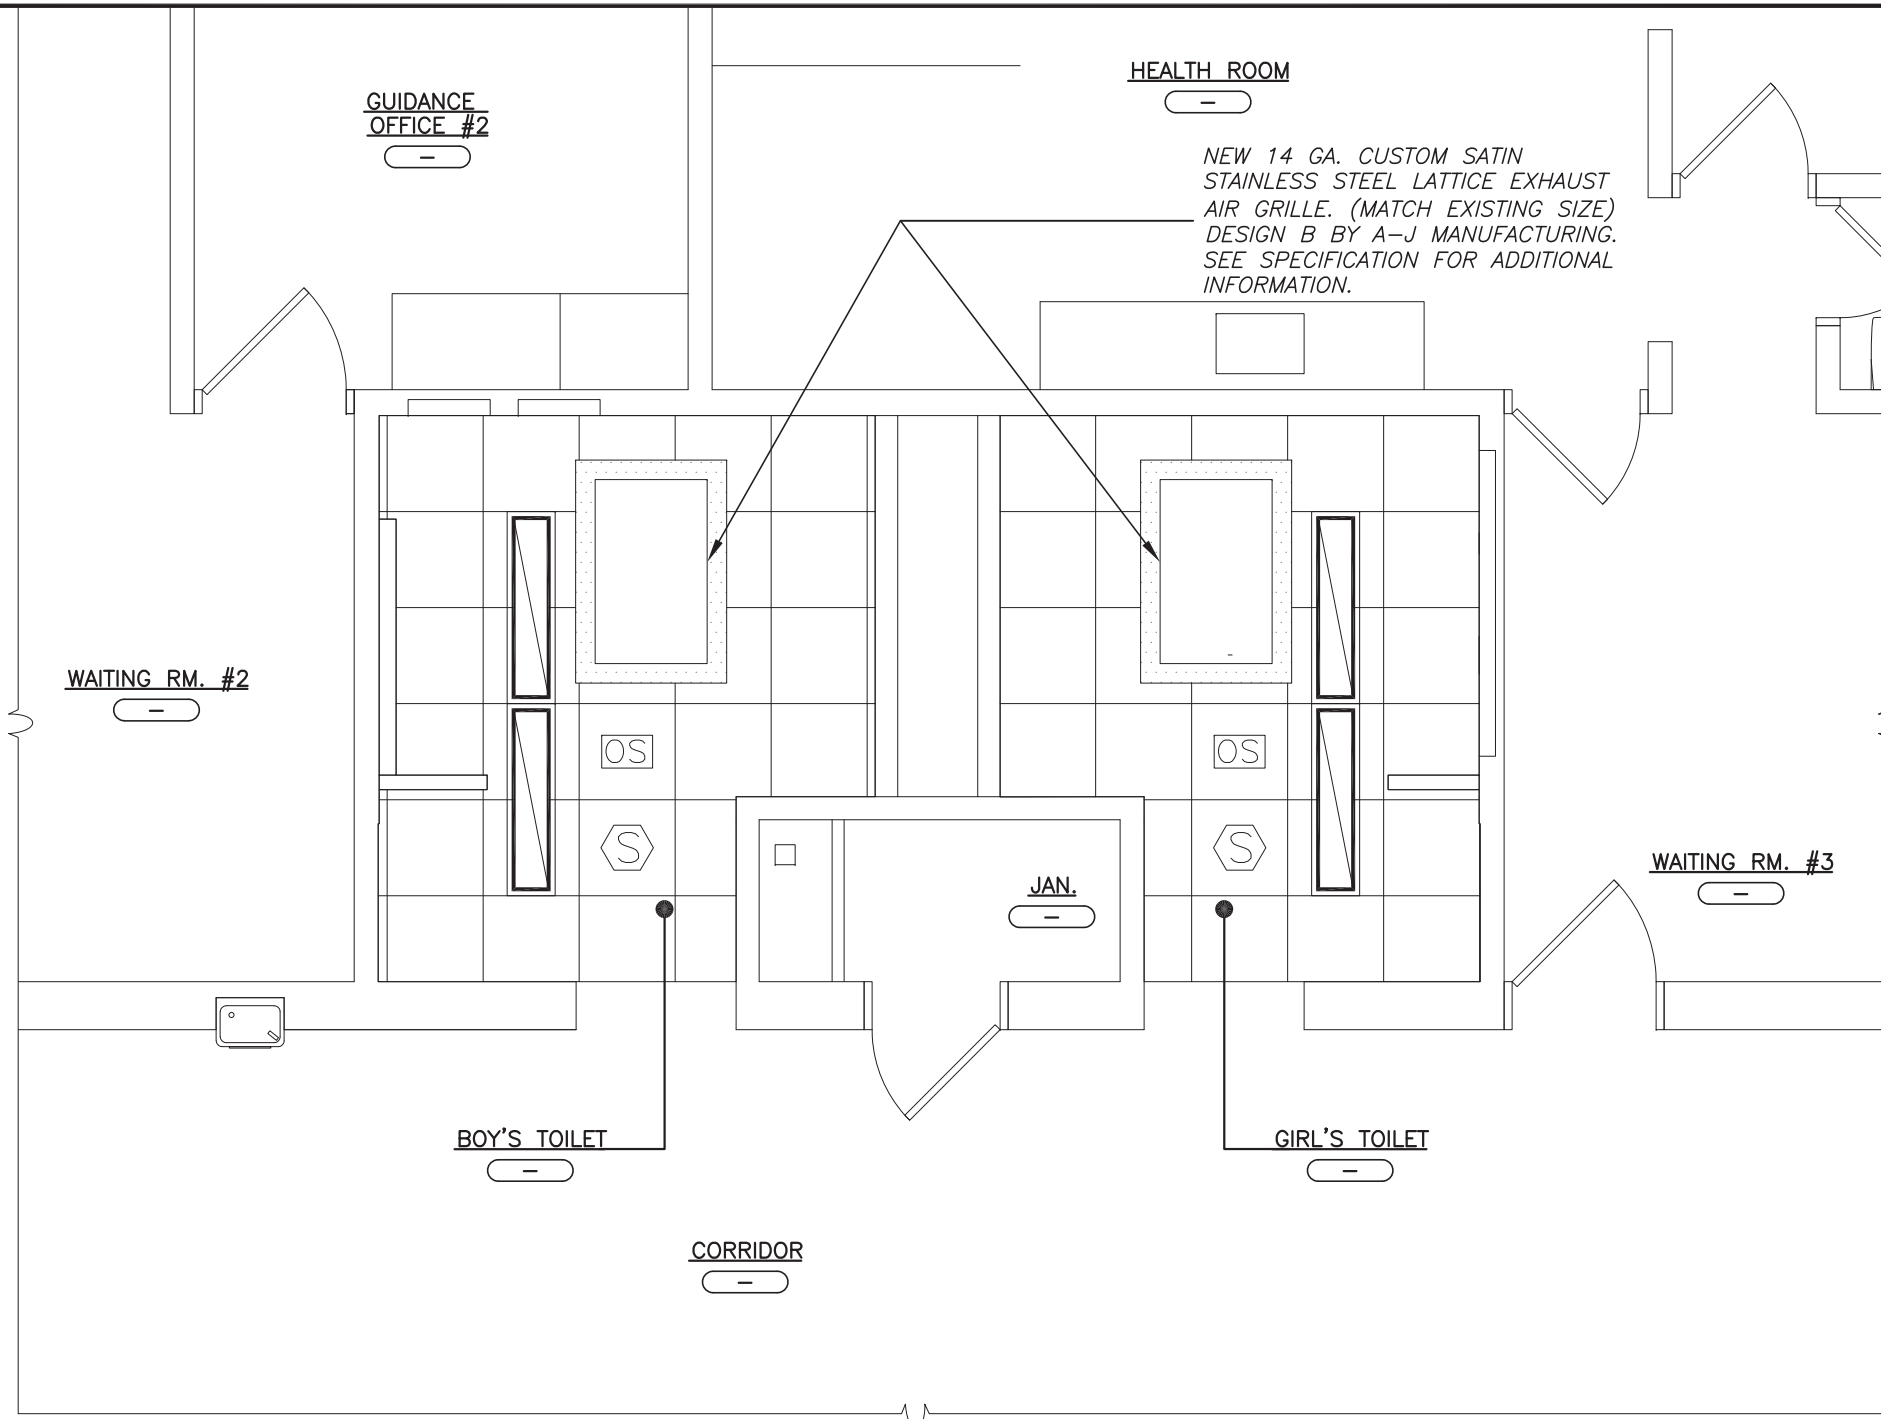


5 FIRST FLOOR MECHANICAL PLAN

SCALE: 1/4" = 1'-0"

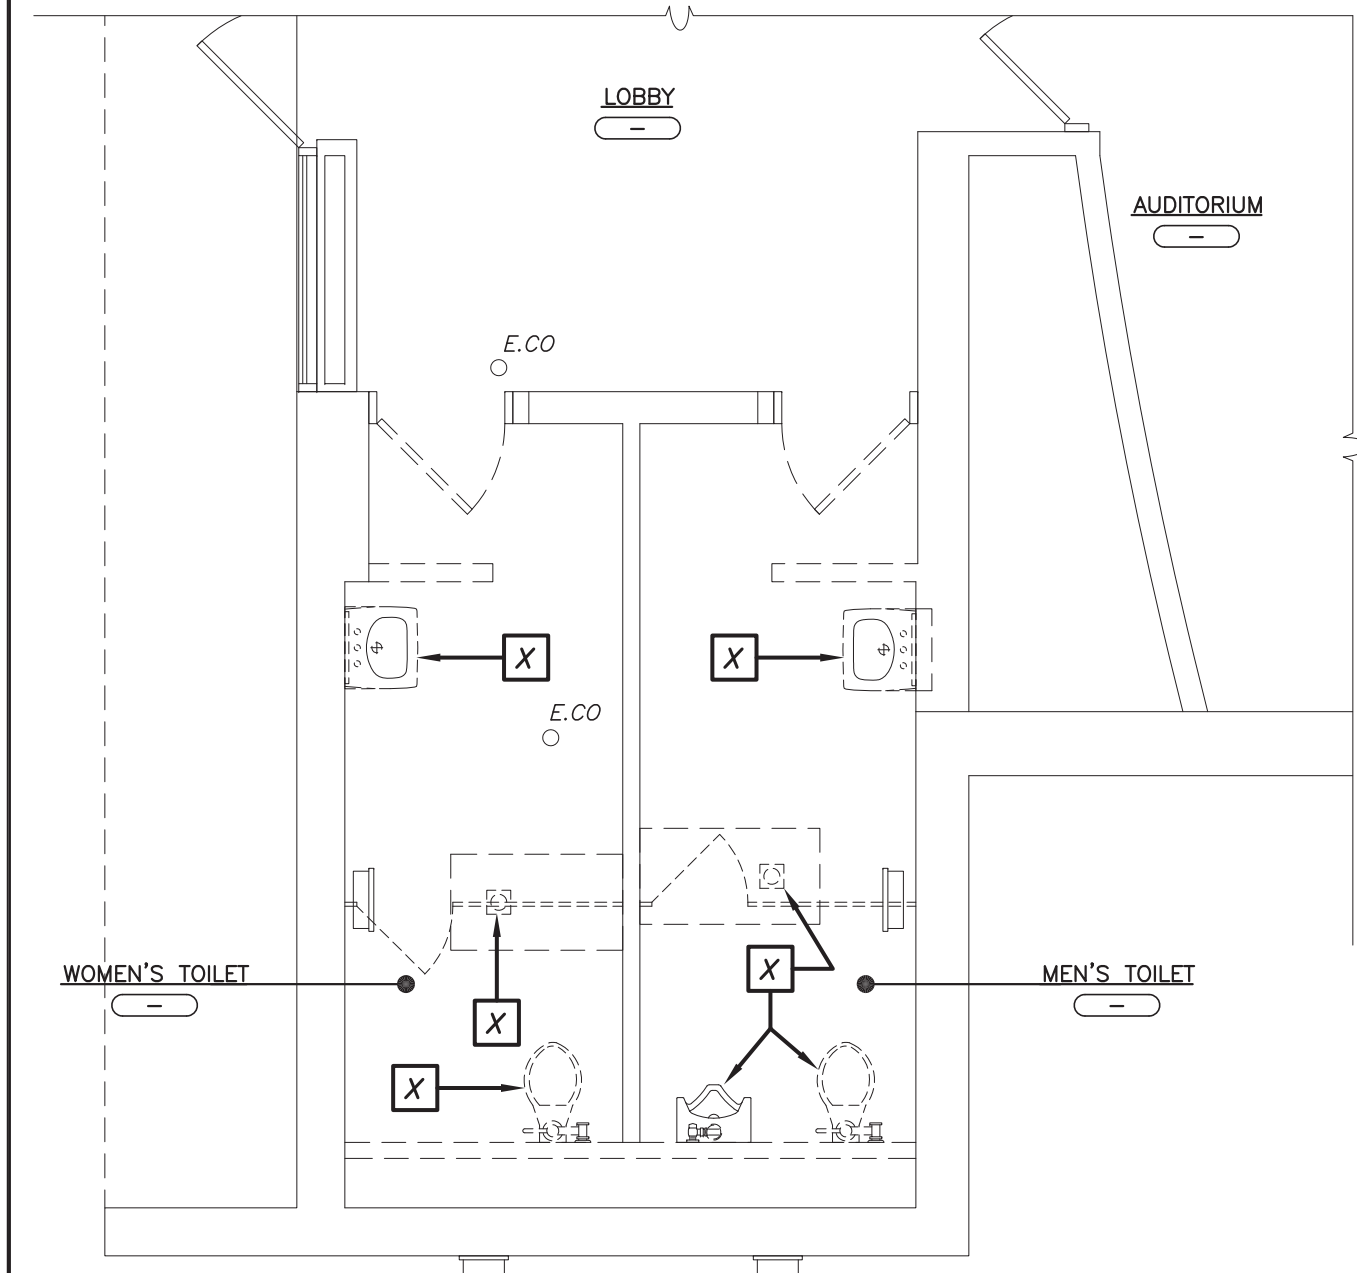

3 FIRST FLOOR PLUMBING REMOVAL PLAN

SCALE: 1/4" = 1'-0"

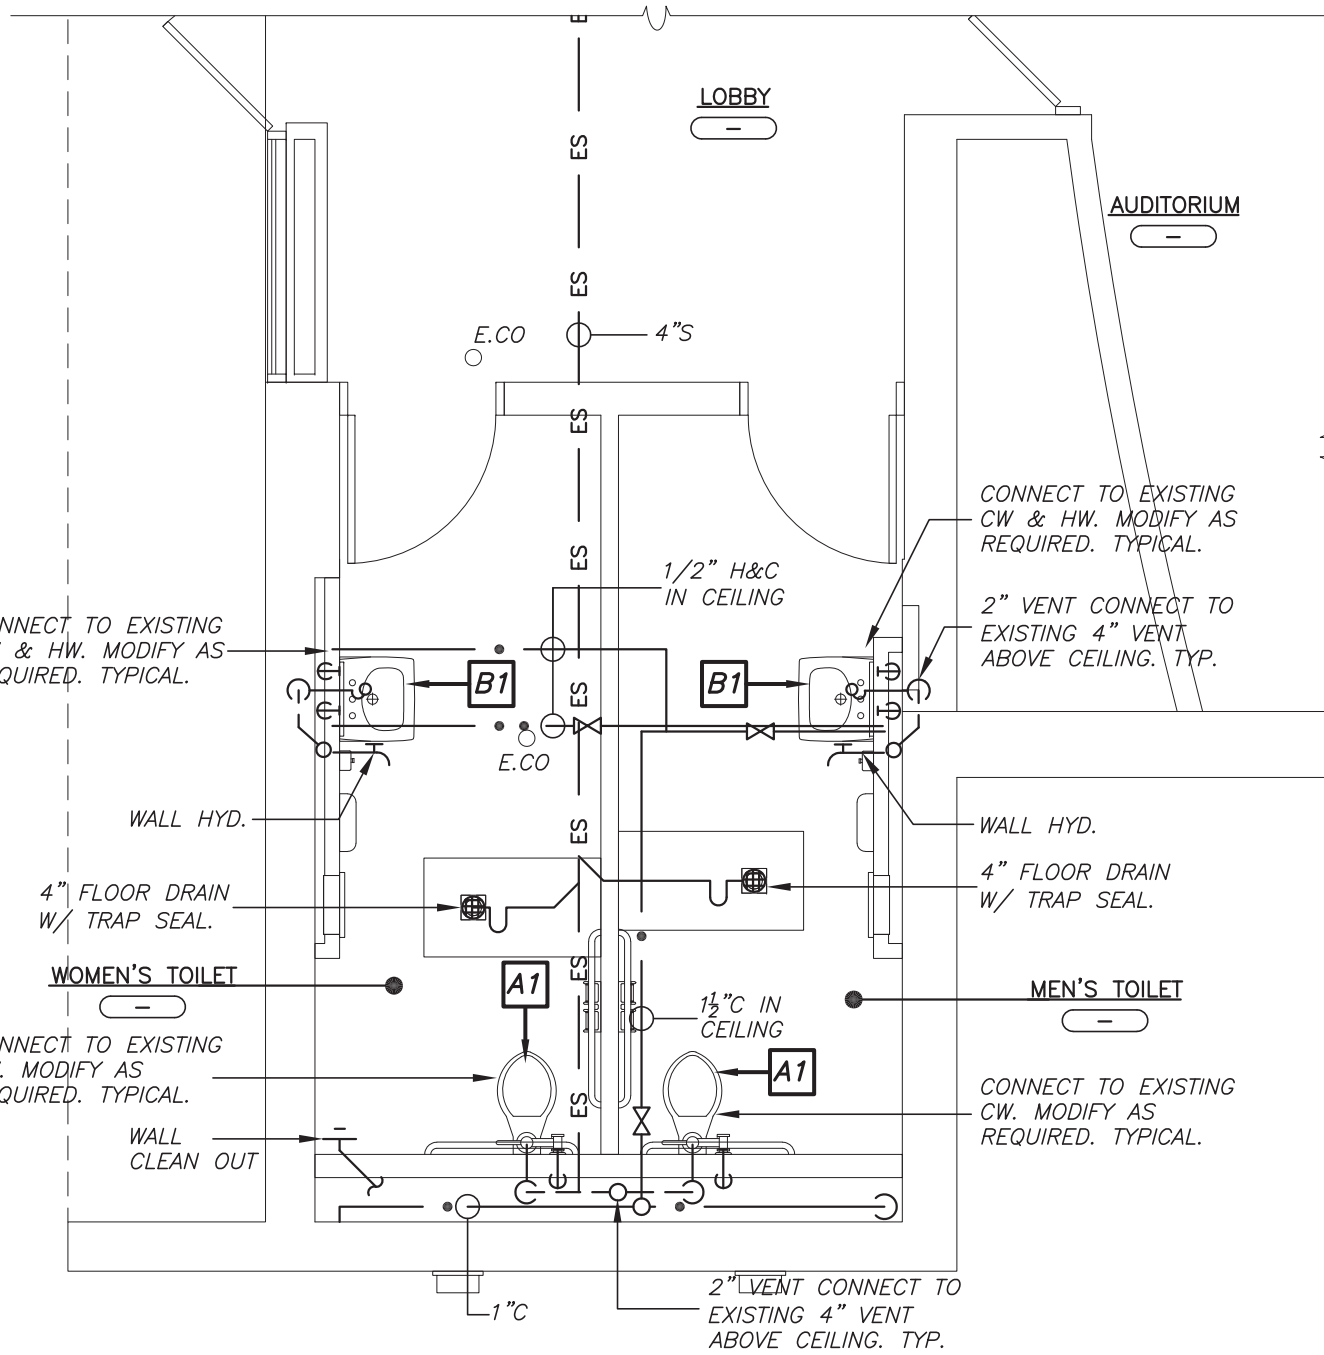

4 FIRST FLOOR PLUMBING PLAN


SCALE: 1/4" = 1'-0"



IMPORTANT NOTICE:

THE EXISTING CONDITIONS REPRESENTED HEREON ARE BASED ON THE EXISTING DRAWINGS. THEY ARE INCLUDED FOR CONTRACTORS REFERENCE ONLY. ACTUAL LOCATION OF PIPING AND UTILITIES MAY VARY IN FIELD. PIPING CONTRACTOR SHALL VERIFY LOCATIONS IN FIELD AND MAKE ALLOWANCE IN BID FOR LOCATIONS AND ARRANGEMENTS OTHER THAN SHOWN.

F&D CANNOT GUARANTEE THE CORRECTNESS OF THE EXISTING CONDITIONS SHOWN AND ASSUMES NO RESPONSIBILITY THEREFORE. INCLUSION OF THESE EXISTING CONDITIONS HEREON SHALL IN NO WAY ALLEVIATE THE CONTRACTOR(S) OF THEIR RESPONSIBILITY TO VISIT THE SITE TO VERIFY ALL EXISTING CONDITIONS.

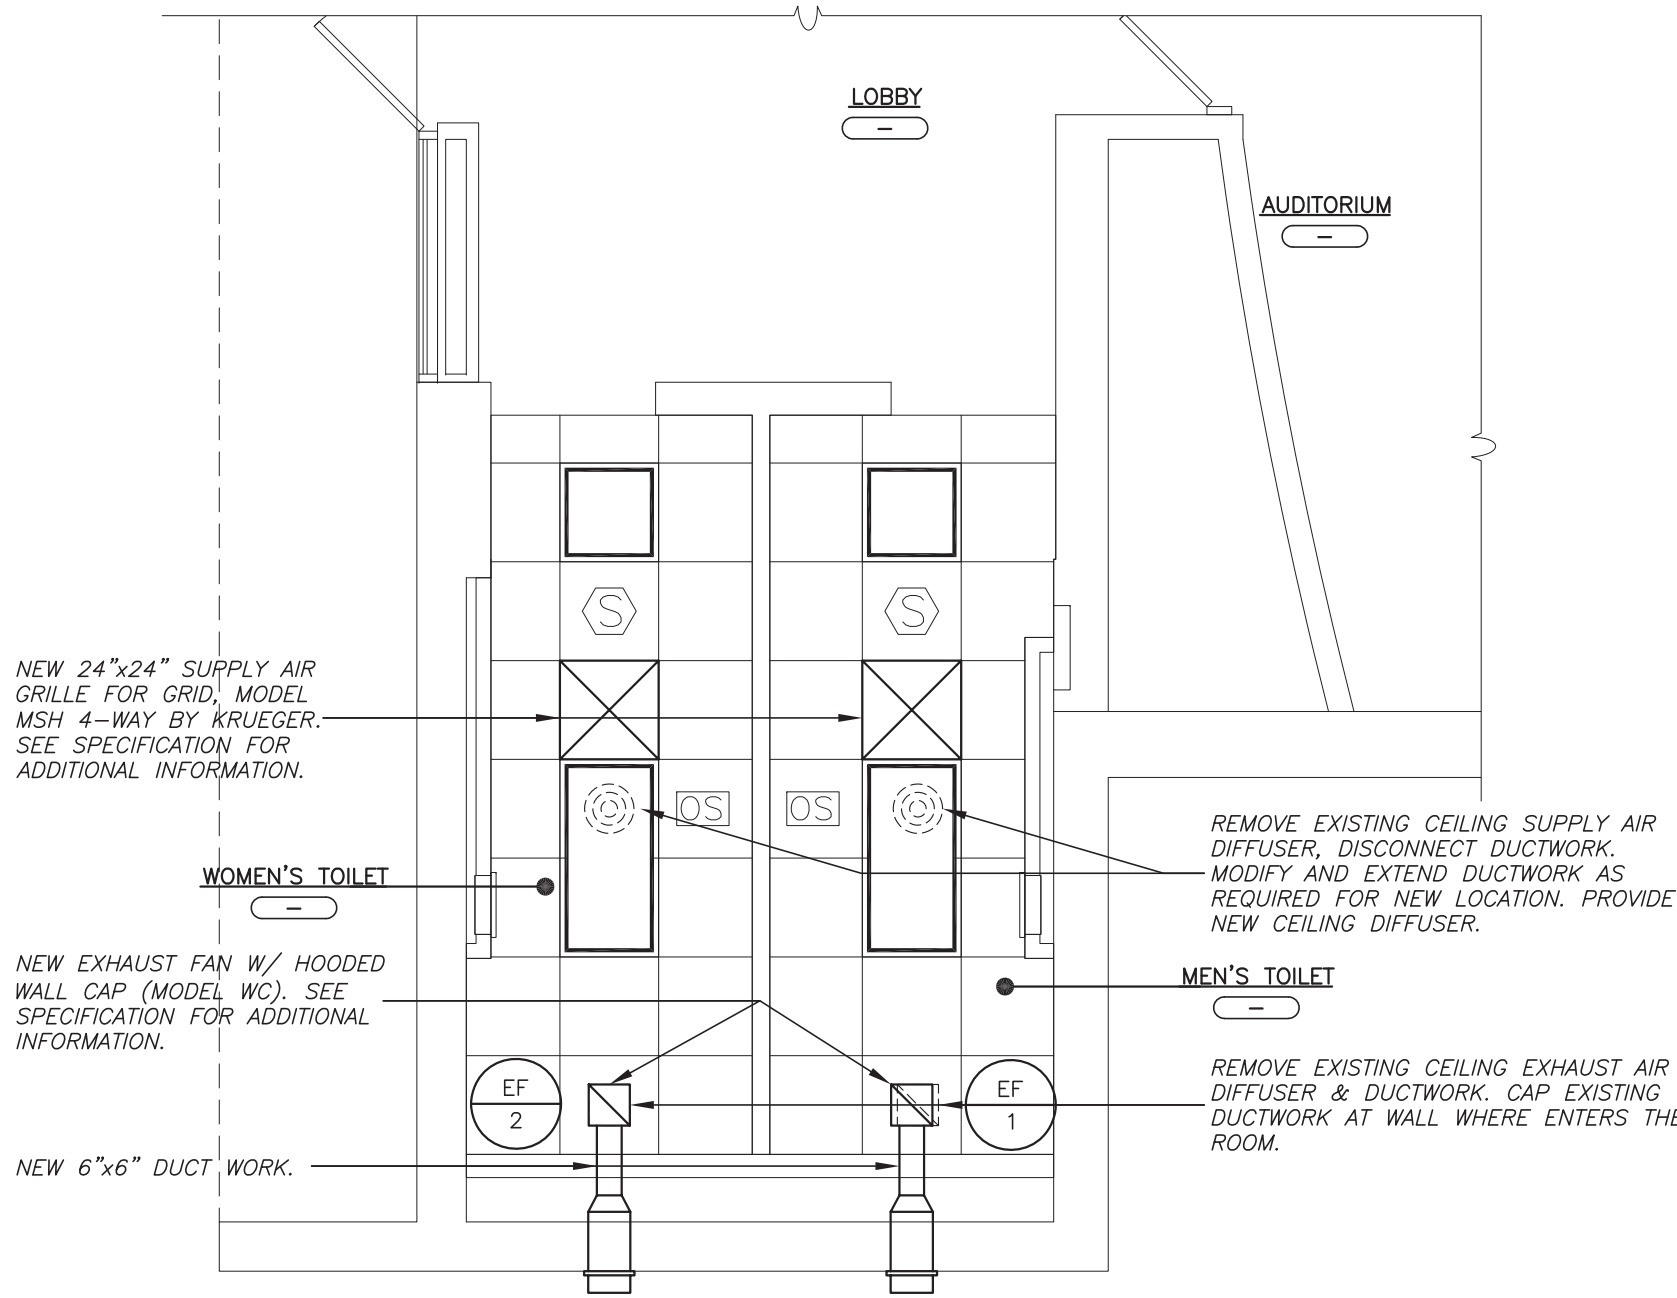

6 FIRST FLOOR MECHANICAL PLAN

SCALE: 1/4" = 1'-0"



AS PER USA CONGRESS ARCHITECTURAL WORKS COPYRIGHT PROTECTION ACT OF 1990 ALL IDEAS AND DESIGNS INCLUDING DERIVATIVES THEREOF, ALL DRAWINGS AND SPECIFICATIONS CONSTITUTE THE ORIGINAL COPYRIGHT WORK BY FULLER AND DANSELO, P.C. (F&D). THE DRAWINGS AND SPECIFICATIONS FOR INSTRUMENTS OF SERVICE BY F&D ARE CREATED BY F&D FOR THIS PROJECT ONLY AND REMAIN THE PROPERTY OF F&D. ANY REPRODUCTION WITHOUT THE PRIOR CONSENT OF F&D IS PROHIBITED.

48 KNOXWOOD ROAD ELMSFORD NEW YORK 10523
TEL 914.899.4444 FAX 914.899.1717
FULLER & DANSELO, P.C.
Copyright 2021 All Rights Reserved By FULLER & DANSELO, P.C.

FULLER
DANSELO
P.C.
ARCHITECTS
PLANNERS

S.E.D. CONTROL NUMBER
HIGH SCHOOL ADMINISTRATION BUILDING
66-04-05-03-011-012

PROJECT NAME
EDGEMONT SCHOOL DISTRICT
ADMINISTRATION BUILDING
TOILET RENOVATIONS AND RELATED WORK
300 WHITE OAK LANE, EDGEMONT, NY 10523

DRAWING TITLE
PLUMBING REMOVAL, PROPOSED PLUMBING
PLANS

02-24-2021	BID
07-01-2015	S.E.D. SUBMISSION
DATE	ISSUED TO
SHEET SIZE 30"x42"	DRAWING NO.
SCALE AS NOTED	MP101
DRAWN BY F & D	FILE NO. 20381.00