


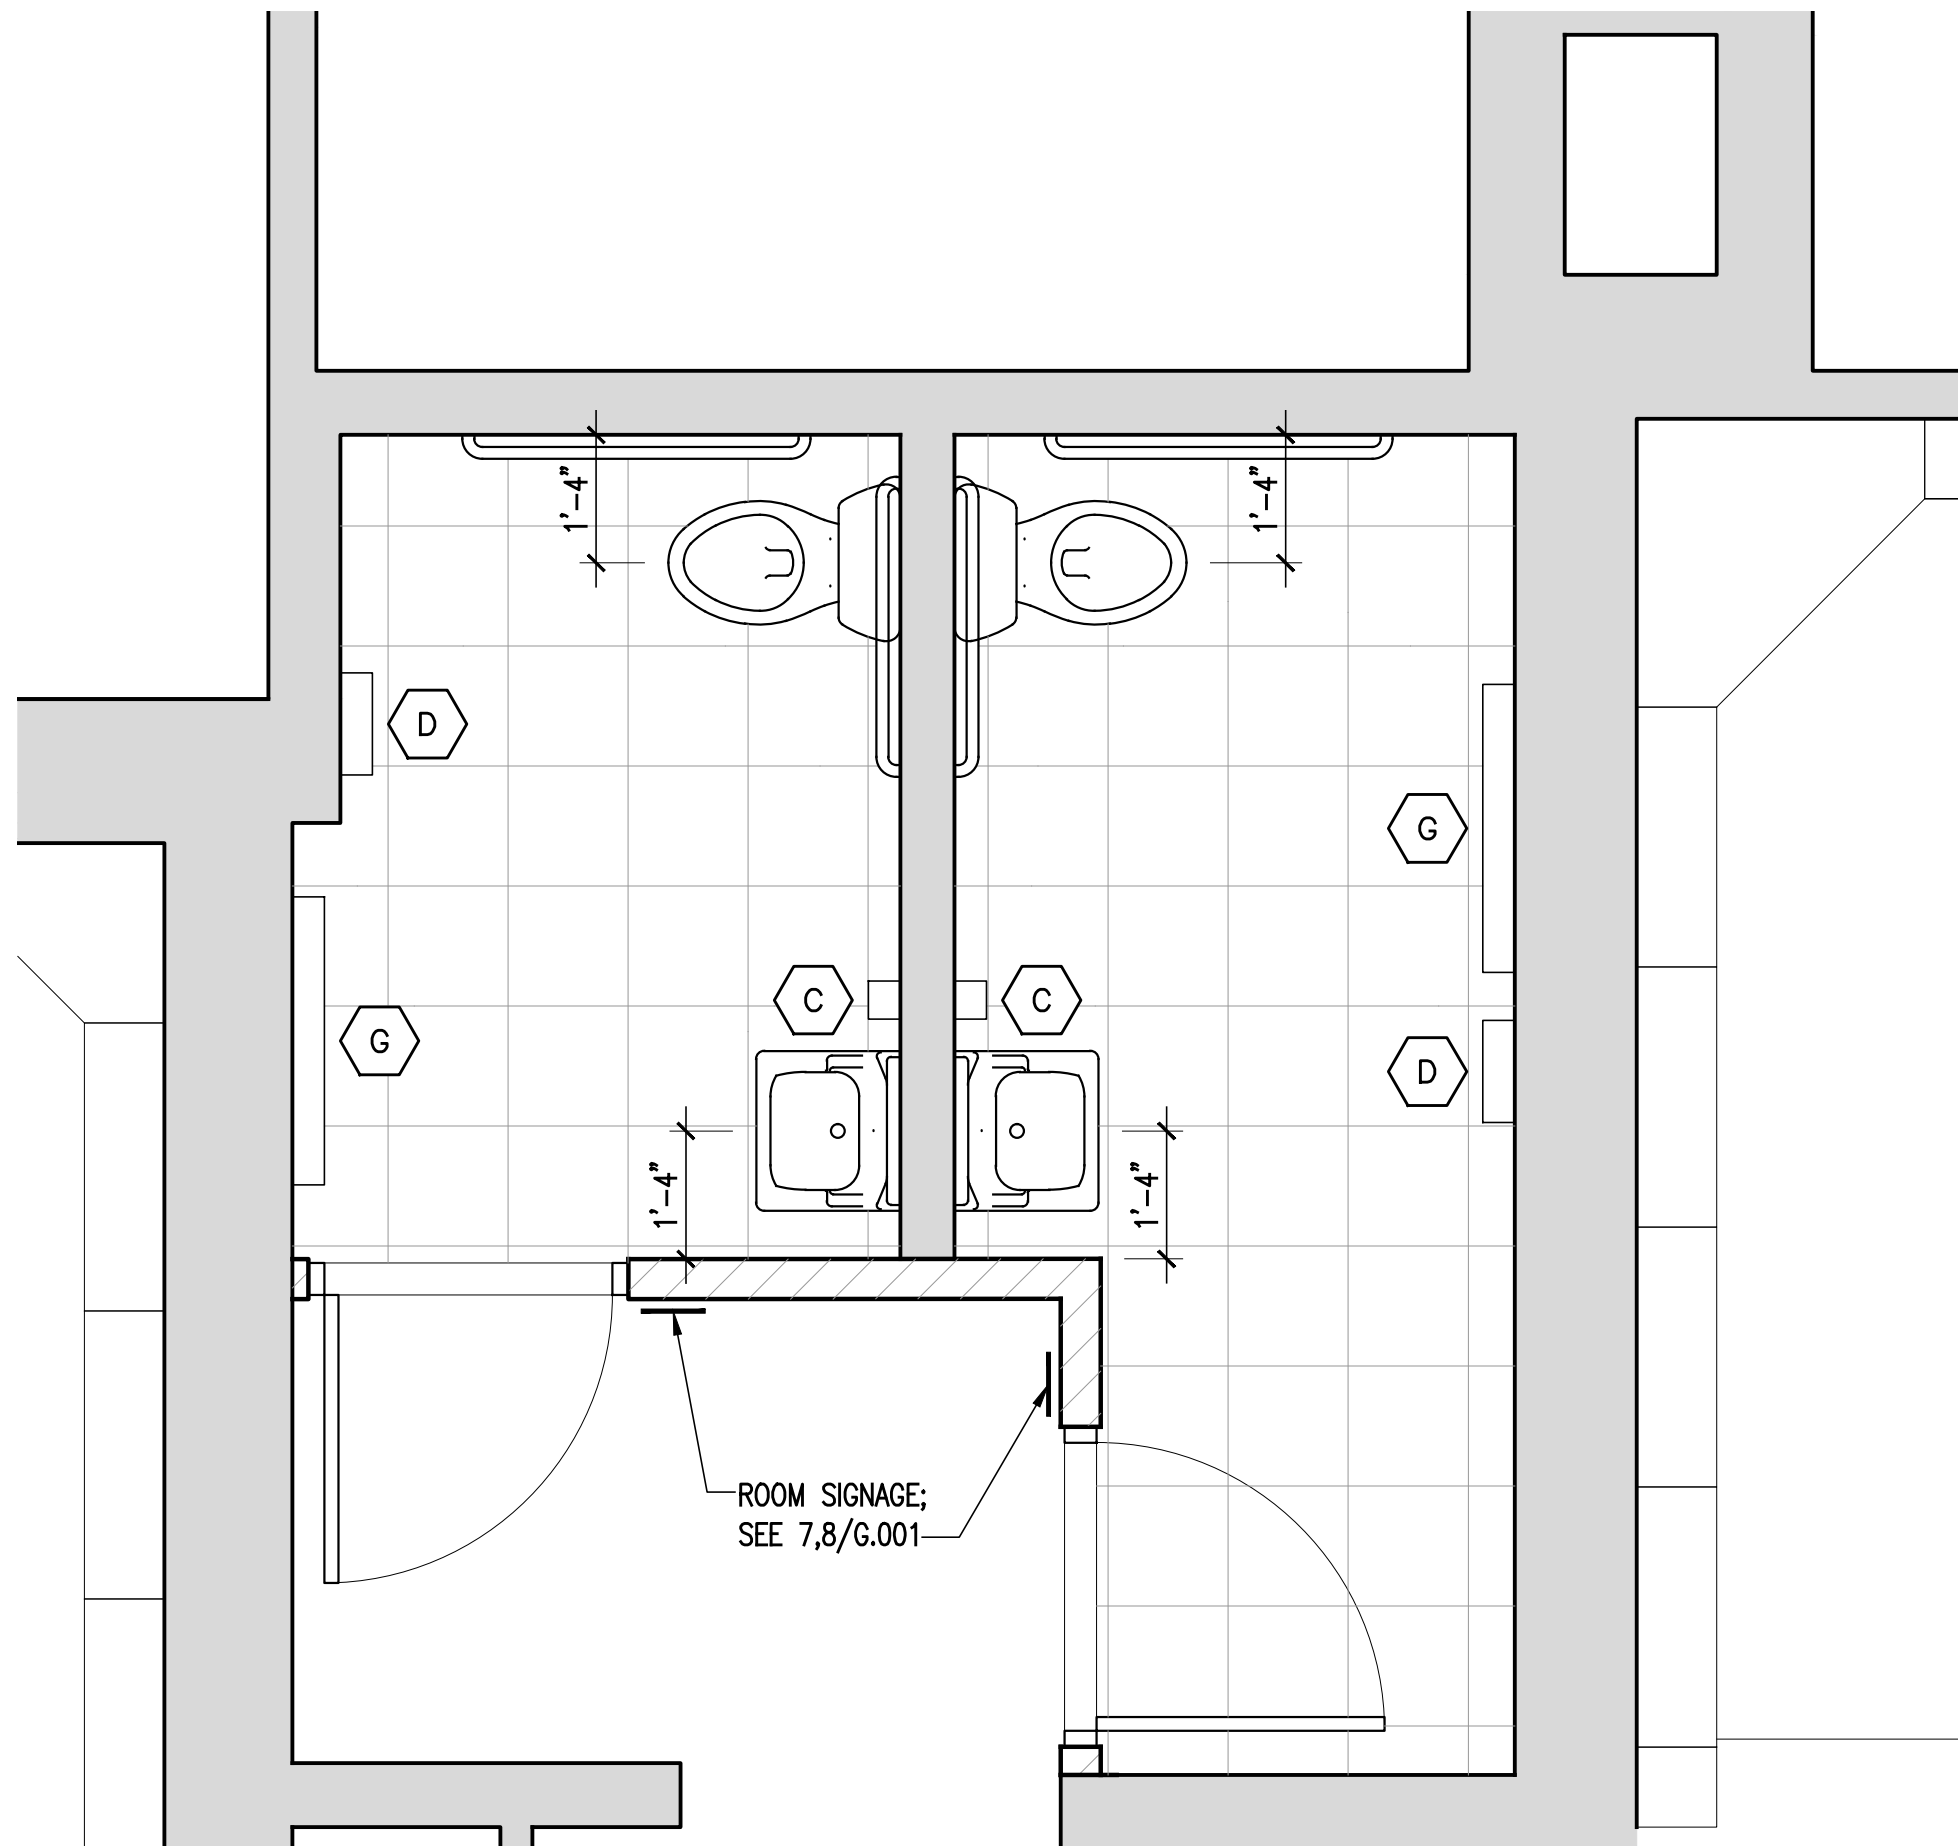


1 ENLARGED RESTROOM PLAN
1/2" = 1'-0"


ACCESSORY SCHEDULE			
ITEM	MOUNTING	DESCRIPTION	BASIS OF DESIGN MODEL NO. NOTES
A1		1-1/4"Ø STAINLESS STEEL GRAB BAR WITH SNAP FLANGE, 42" LONG	BOBRICK B-5806 SATIN FINISH STAINLESS STEEL
A2		1-1/4"Ø STAINLESS STEEL GRAB BAR WITH SNAP FLANGE, 36" LONG	BOBRICK B-5806 SATIN FINISH STAINLESS STEEL
A3		1-1/4"Ø STAINLESS STEEL GRAB BARS WITH SNAP FLANGE, 18" LONG	BOBRICK B-5806 SATIN FINISH STAINLESS STEEL
B	S	ADA MIRROR	BOBRICK B-165 18X30
C	S	SURFACE-MOUNTED SOAP DISPENSER	GOJO LTX-12 PLASTIC BATTERY POWERED
D	S	PAPER TOWEL/TRASH RECEPTACLE	BOBRICK B-3699 SATIN FINISH STAINLESS STEEL
E	S	JUMBO-ROLL TOILET TISSUE DISPENSER	BOBRICK B-2890 SATIN FINISH STAINLESS STEEL
F	S	SANITARY NAPKIN DISPOSAL	BOBRICK B-254 SATIN FINISH STAINLESS STEEL
G	S	BABY CHANGING STATION	KOALA KARE KB310-SSWM SATIN FINISH STAINLESS STEEL
H	S	PIPING COVERS	TRUEBRO LAU GUARD 2 XXXX

PLUMBING FIXTURE SCHEDULE		
DESCRIPTION	BASIS OF DESIGN MODEL NO.	NOTES
TOILET	AMERICAN STANDARD, CHAMPION 4 RIGHT HEIGHT ELONGATED TOILET 731AA.001 COLOR: WHITE	FLOOR MOUNTED, 1.6 GPF 4" WASTE, 2" VENT, 1/2" COLD WATER
SINK	AMERICAN STANDARD, LUCERNE 0356.421 COLOR: WHITE	ADA WALL MOUNTED 1-1/2" WASTE, 1-1/2" VENT, 1/2" COLD WATER, 1/2" HOT WATER PROVIDE: GRID DRAIN AND JR SMITH CARRIER SUPPORT UNDER LAVATORY GUARD: SEE SPEC, COLOR: WHITE
FAUCET	SLOAN OPTIMA SENSOR FAUCET	EAF-250-BAT-ISM-CP-0.5GPM-AER-IR-IQ-FCT


NOTES: MODIFY SUPPLY, DRAIN, AND VENT PIPING AS REQUIRED PER PLAN. PROVIDE ALL NECESSARY PLUMBING, TRAPS, STRAINERS, SHUT-OFF, ETC., FOR A COMPLETE AND FULLY FUNCTIONAL PLUMBING SYSTEM.

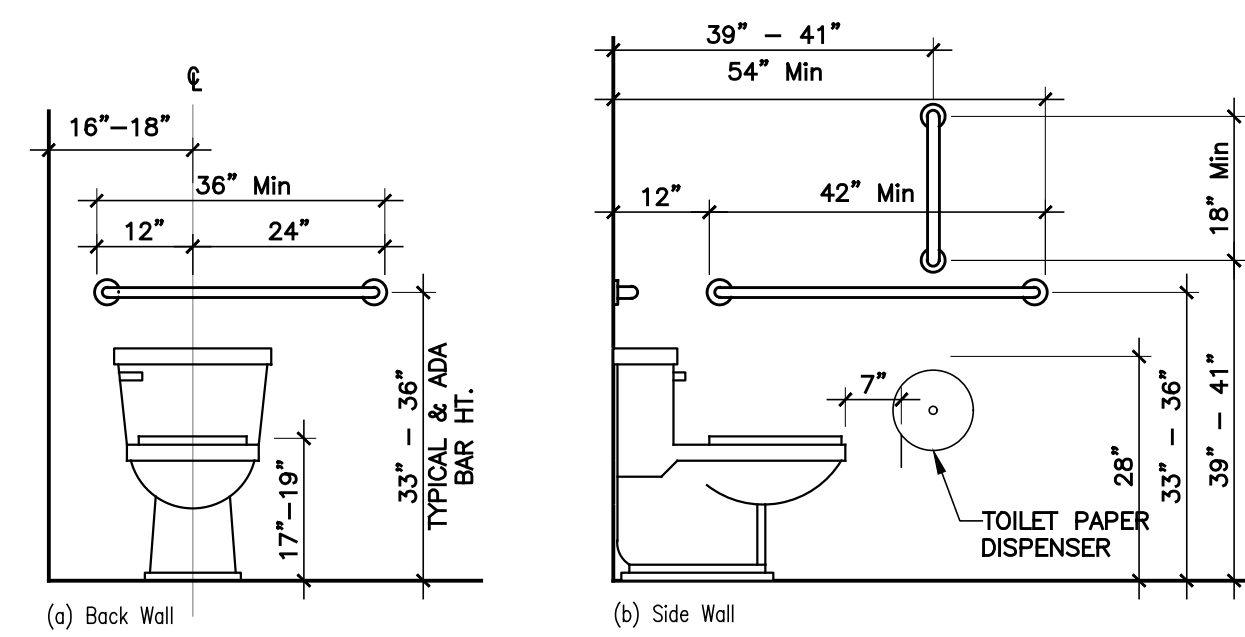


4 TOILET HEIGHT
1/4" = 1'-0"

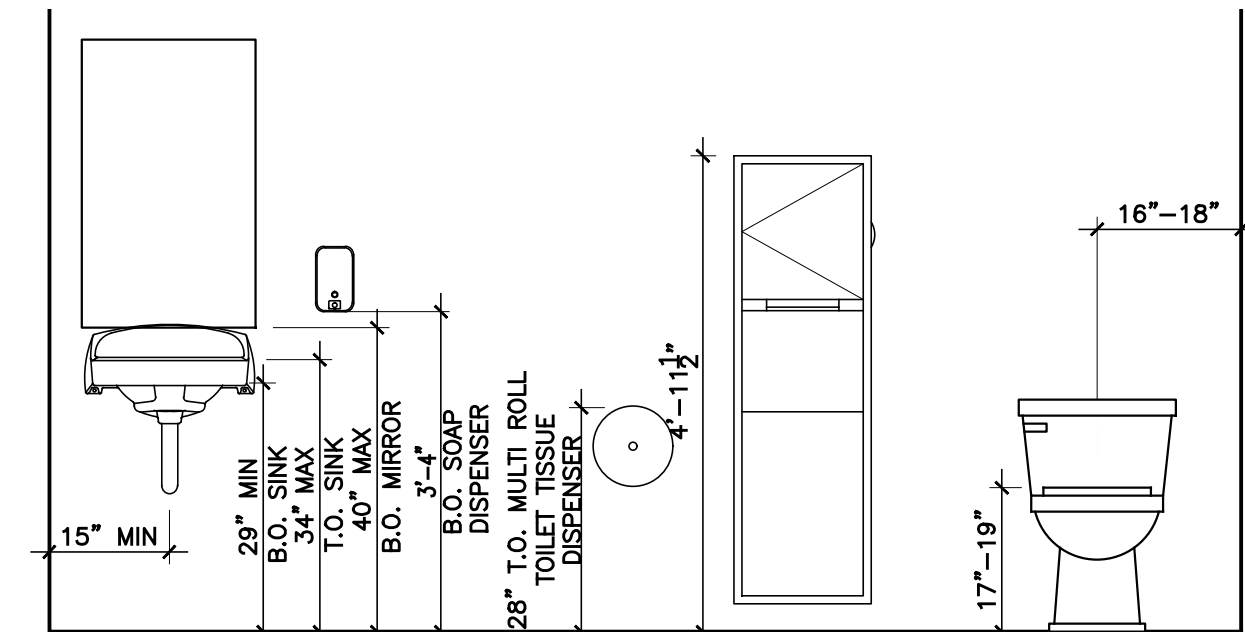


5 ADA MOUNTING HEIGHTS
1/4" = 1'-0"

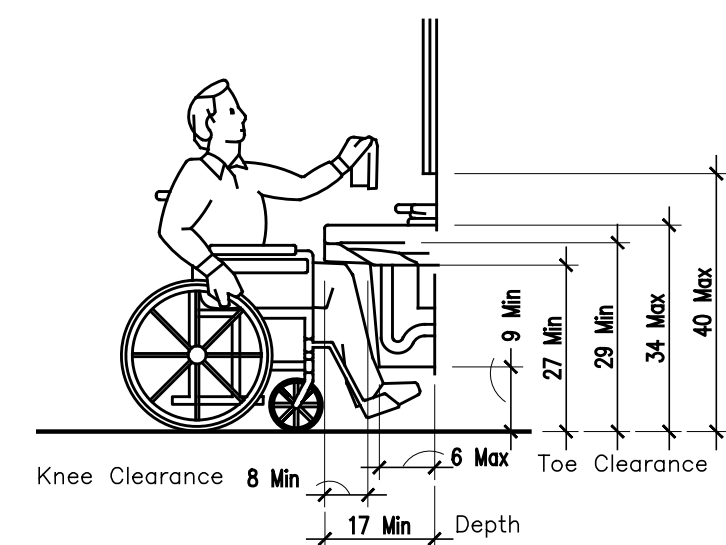


6 ADA CLEARANCES AT LAVS
N.T.S.

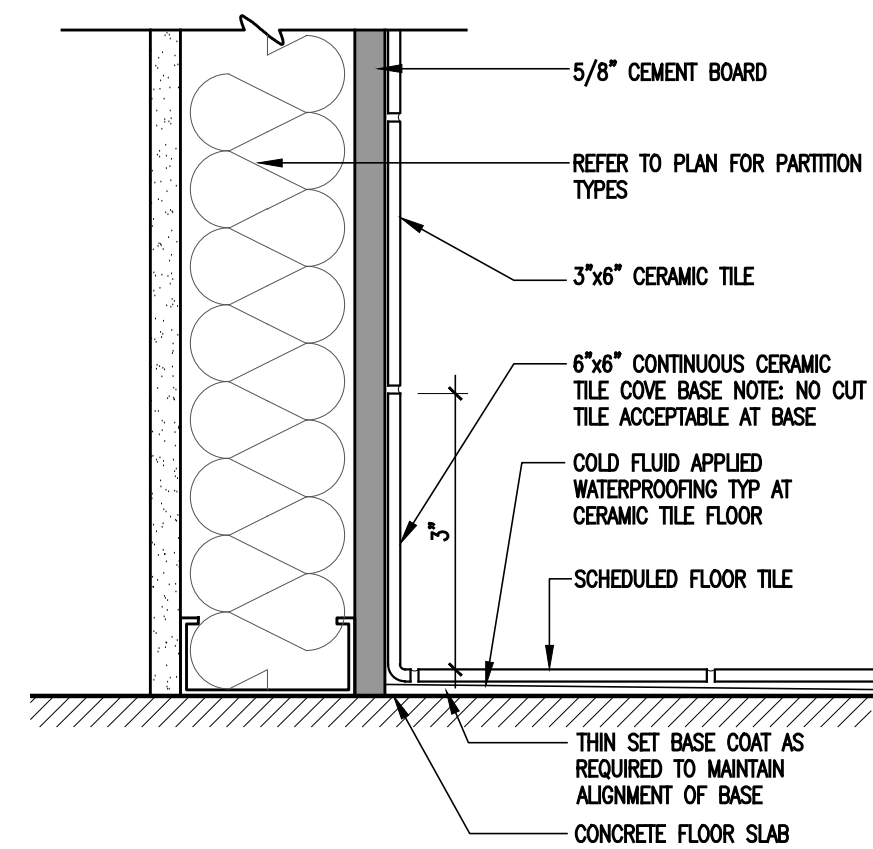


7 TYP. CERAMIC TILE DETAIL
3" = 1'-0"

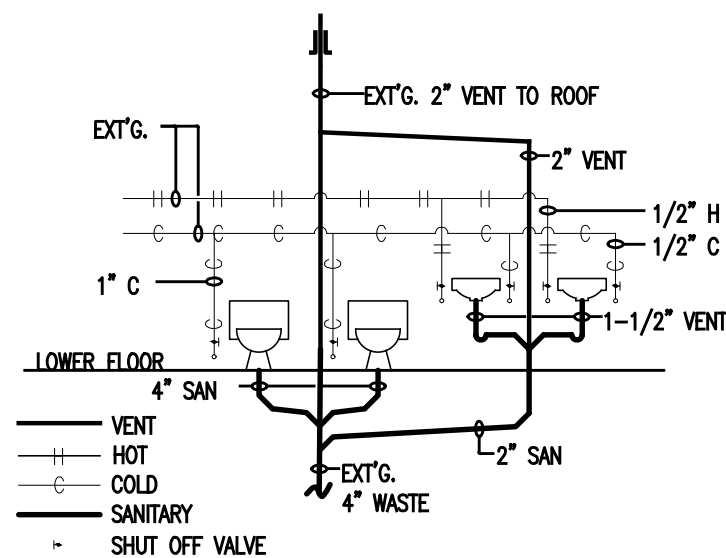


8 PLUMBING RISER DIAGRAM
N.T.S.

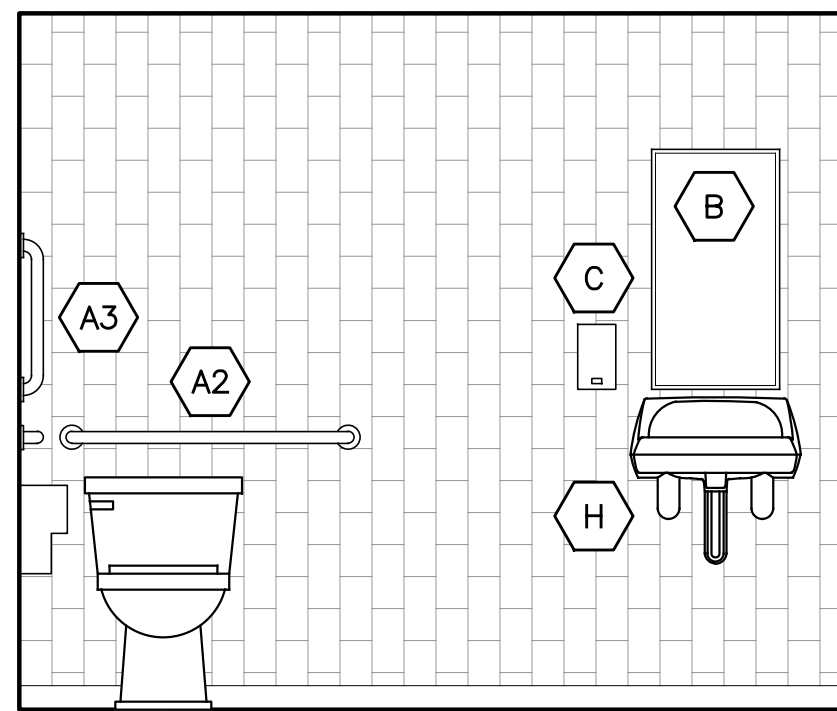

2A

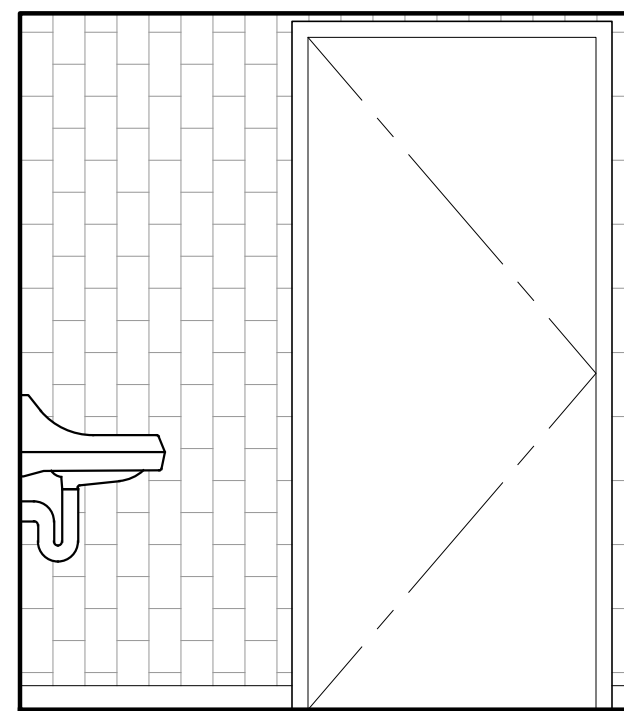


2B

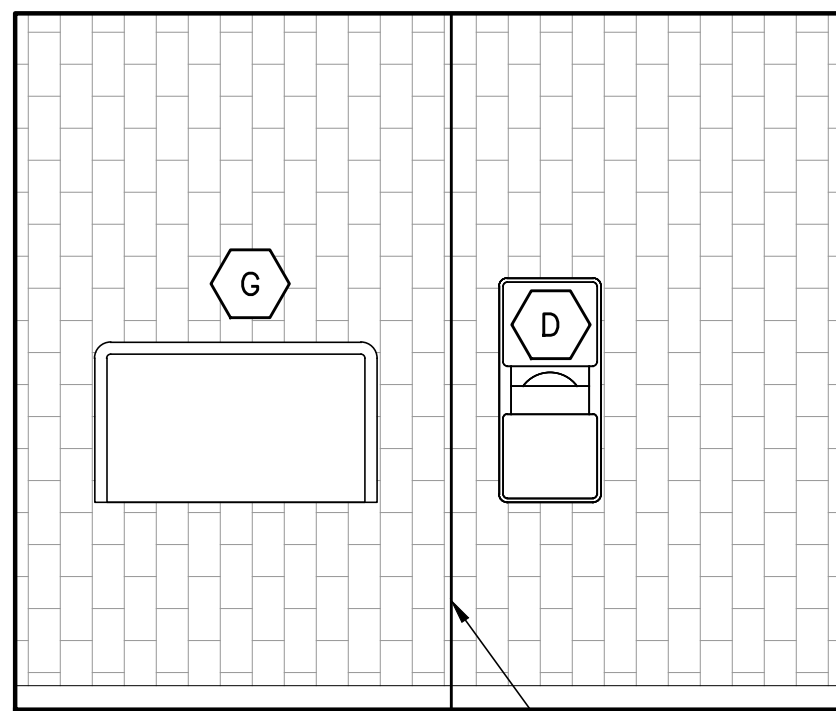


2C

PROVIDE SCHLUTER TRIM AT OUTSIDE CORNERS, TYP.

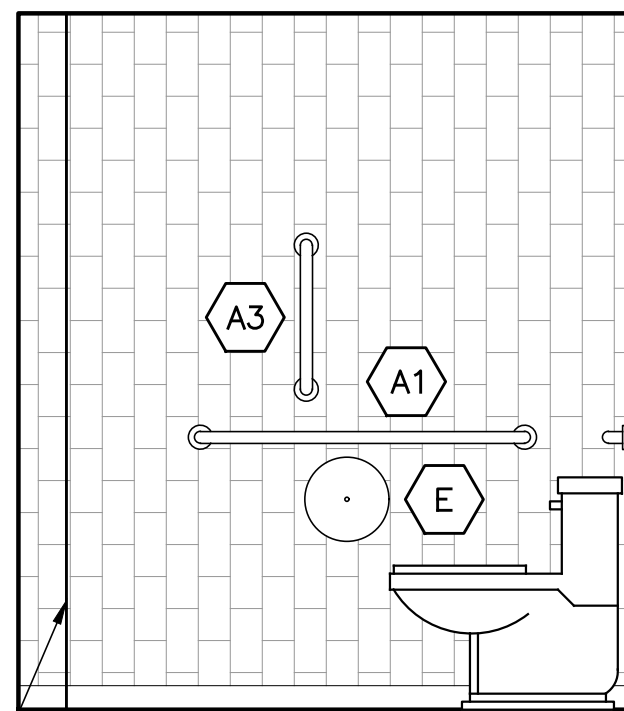


2D


2 INTERIOR ELEVATIONS - MEN'S TOILET
1/2" = 1'-0"

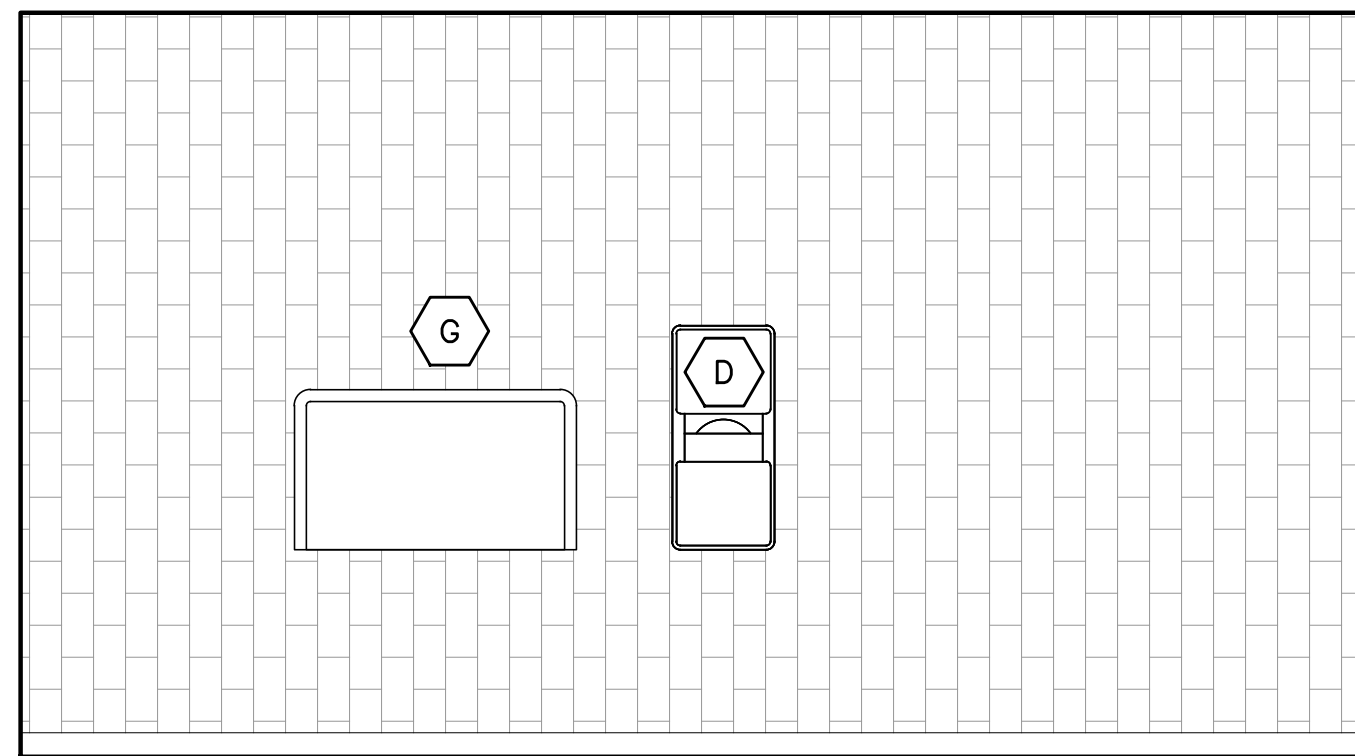

3A

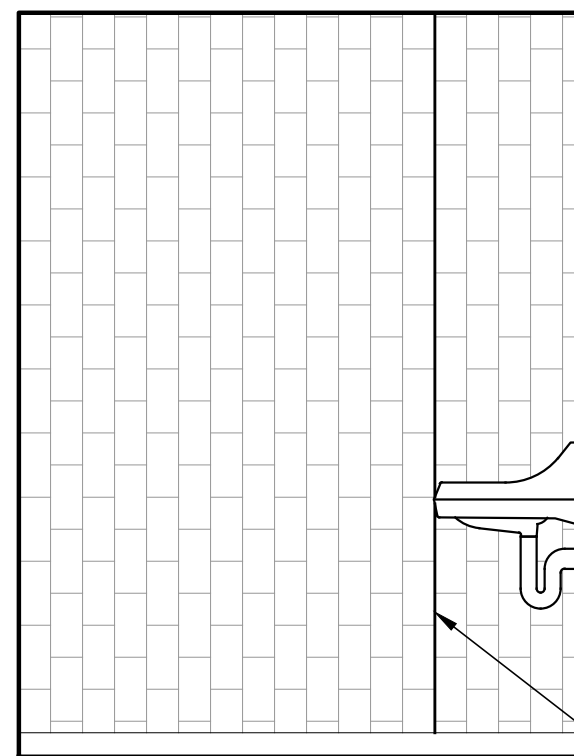


3B

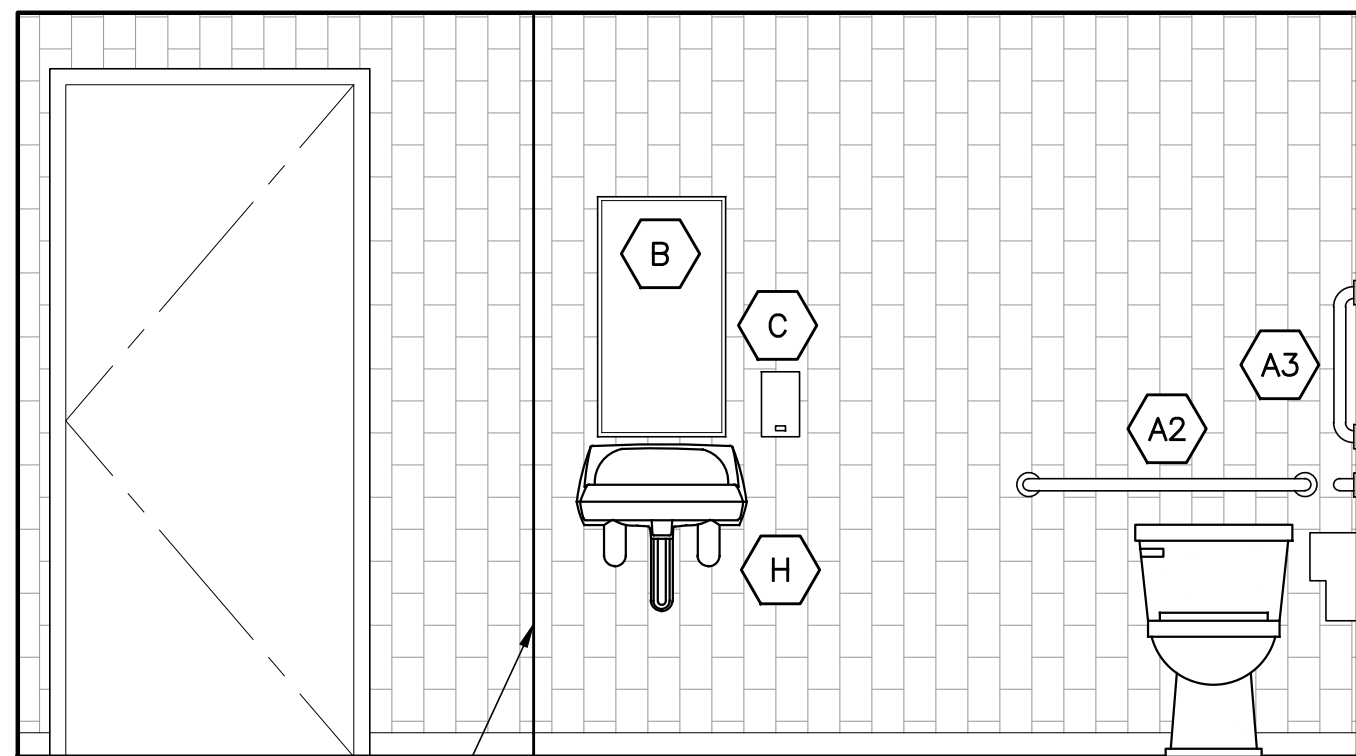

3C

PROVIDE SCHLUTER TRIM AT OUTSIDE CORNERS, TYP.

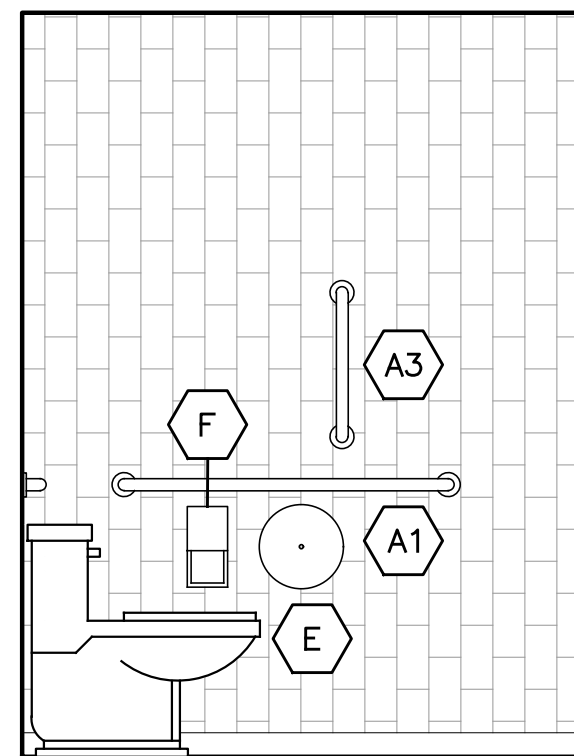

3D

3 INTERIOR ELEVATIONS - WOMEN'S TOILET
1/2" = 1'-0"

09.03.21 ISSUED FOR BID

NORTH CASTLE PUBLIC LIBRARY
RESTROOM ALTERATIONS

19 WHIPPOORWILL ROAD E. ARMONK, NY

arcari + iovino
ARCHITECTS PC

ONE KATHERINE STREET
LITTLE PERRY, NJ 07643
201 641 0600 FAX 201 641 0626
WWW.AIARCHS.COM

EDWARD ARCARI NY#020765 ANTHONY IOVINO NY#023349

ENLARGED RESTROOM PLAN,
INTERIOR ELEVATIONS,
FIXTURE AND ACCESSORY SCHEDULES

SCALE: AS NOTED

DATE: 09.03.21

FILE: 20661

©2021 arcari + iovino ARCHITECTS PC

A.102