


Drawing Name: S:\Projects\Webutuck CSD\HS & MS Health Center\0 Design\06 CAD\AutoCAD\PLUM\PO\PO00.dwg Date last accessed: 9/17/2020 9:59 AM Date last plotted: 9/18/2020 11:31 AM Plotted By: Brendon Mazza

PLUMBING EQUIPMENT & FIXTURE SCHEDULE								
MARK	FIXTURE	CW	HW	SAN	V	GAS	DESCRIPTION	MANUFACTURER & MODEL NUMBER
SK-1	SINK, ACCESSIBLE	1/2"	1/2"	1-1/2"	1-1/2"	-	COUNTER MOUNT, SINGLE BOWL, STAINLESS STEEL SINK, OD 17x19", ID 14x14", 6-3/16" DEEP, GOOSENECK FAUCET WITH WRISTBLADES, 1.5 GPM	ELKAY D11719
REMARKS:	1. ALL ACCESSIBLE EQUIPMENT/FIXTURES TO BE INSTALLED PER ADA REQUIREMENTS.							1

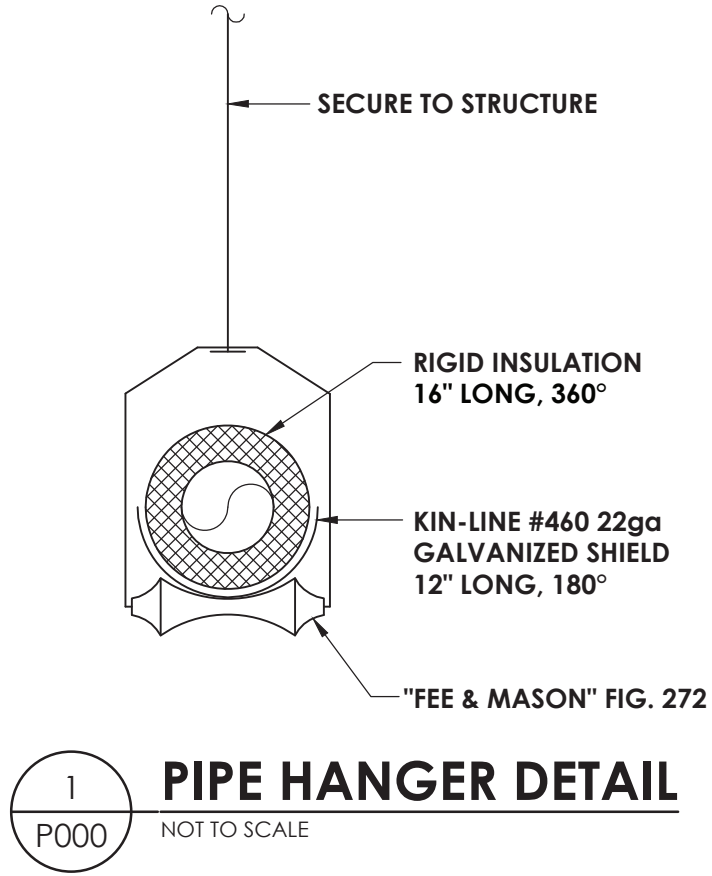

PIPING LEGEND

— XX —	PIPING
— XX —	PIPING BELOW GRADE
— XX —	EXISTING PIPING
CW	COLD WATER
HW	HOT WATER
HWR	HOT WATER RECIRCULATING
SAN	SANITARY SEWER
AW	ACID WASTE
IW	INDIRECT WASTE
ST	STORM SEWER
RL	RAIN LEADER
CA	COMPRESSED AIR
LA	LABORATORY COMPRESSED AIR
MA	MEDICAL COMPRESSED AIR
CL	CHLORINATED WATER
DE	DEIONIZED WATER
DI	DISTILLED WATER
SW	SOFT WATER
DWS	CHILLED DRINKING WATER SUPPLY
DWR	CHILLED DRINKING WATER RECIRCULATING
LS	LAWN SPRINKLER SUPPLY
DF	DIESEL FUEL
FILL	FILL LINE
FOF	FUEL OIL FILL
FOG	FUEL OIL GAUGE
FOS	FUEL OIL SUPPLY
FOR	FUEL OIL RETURN
LO	LUBRICATING OIL
WO	WASTE OIL
G	GAS - LOW PRESSURE
MG	GAS - MEDIUM PRESSURE
HG	GAS - HIGH PRESSURE
LPG	LIQUEFIED PROPANE GAS
NLG	NON-LEADED GASOLINE
PG	PREMIUM GASOLINE
RG	REGULAR GASOLINE
H	HUMIDIFICATION LINE
O2	OXYGEN
LO2	LIQUID OXYGEN
N2	NITROGEN
N2O	NITROUS OXIDE
CO2	CARBON DIOXIDE
VA	VACUUM
VPD	VACUUM PUMP DISCHARGE
MV	MEDICAL VACUUM
LV	LABORATORY VACUUM
WVC	WET VACUUM CLEANING
DVC	DRY VACUUM CLEANING
SP	FIRE PROTECTION/SPRINKLER
V	VENT
AV	ACID WASTE VENT
GV	GAS VENT
FOV	FUEL OIL VENT
WOV	WASTE OIL VENT
////	PLUMBING TO BE REMOVED
(ETR)	EXISTING TO REMAIN
(E)	EXISTING


FIXTURES & FITTINGS LEGEND

— O —	TEE OUTLET - UP
— O —	TEE OUTLET - DOWN
— O —	CONNECTION - BOTTOM
— O —	CONNECTION - TOP
— O —	ELBOW - TURNED UP
— O —	ELBOW - TURNED DOWN
— E —	PIPE CAP
— I —	UNION
— I —	FLANGE
— O —	BALL VALVE
— O —	BALL VALVE WITH MEMORY STOP
— O —	BALANCING VALVE
— O —	CHECK VALVE
— O —	BUTTERFLY VALVE
— O —	CONTROL VALVE, PNEUMATIC 2-WAY
— O —	GATE VALVE
— O —	GLOBE VALVE
— O —	PLUG VALVE
— O —	PRESSURE RELIEF VALVE
— O —	TEMPERATURE-PRESSURE RELIEF VALVE
— O —	PRESSURE REDUCING VALVE
— O —	COMBINATION VALVE (ISOLATION, CHECK, BALANCING)
— O —	MOTOR OPERATED VALVE
— O —	SOLENOID OPERATED VALVE
— O —	GAS PRESSURE REGULATOR
— O —	REDUCER, CONCENTRIC
— O —	REDUCER, ECCENTRIC
CO	CLEAN OUT
FCO	FLOOR CLEAN OUT
WCO	WALL CLEAN OUT
HB	HOSE BIBB
NFHB	NON FREEZE HOSE BIBB
NFWH	NON FREEZE WALL HYDRANT
YH	YARD HYDRANT
FD	FLOOR DRAIN
FFD	FUNNEL FLOOR DRAIN
FS	FLOOR SINK
RD	ROOF DRAIN
— — —	PIPE GUIDE
— X —	PIPE ANCHOR
— — —	FLEXIBLE PIPE CONNECTOR
— FS —	EXPANSION JOINT
— PS —	FLOW SWITCH
— AQ —	PRESSURE SWITCH
— — —	AQUASTAT
— — —	PRESSURE GAUGE
— — —	PRESSURE GAUGE WITH SYPHON (STEAM)
— — —	THERMOMETER
— — —	STRAINER
— — —	STRAINER WITH BLOWOFF
— V —	VACUUM BREAKER
— A —	INLINE PUMP
— A —	WATER HAMMER ARRESTER
— RPZ —	REDUCED PRESSURE ZONE BACK FLOW PREVENTER
— DC —	DOUBLE CHECK VALVE ASSEMBLY
— T —	STEAM TRAP
— — —	SHOWER HEAD
— O — V — M —	GAS OUTLET (O2, VACUUM, MEDICAL AIR)
— — —	SPRINKLER HEAD
— P —	POINT OF CONNECTION
— R —	POINT OF REMOVAL



CPLteam.com
ARCHITECTURE • ENGINEERING • PLANNING

50 FRONT STREET, SUITE 202
NEWBURGH, NEW YORK 12550
TEL (800) 274-9000
FAX (845) 567-9614

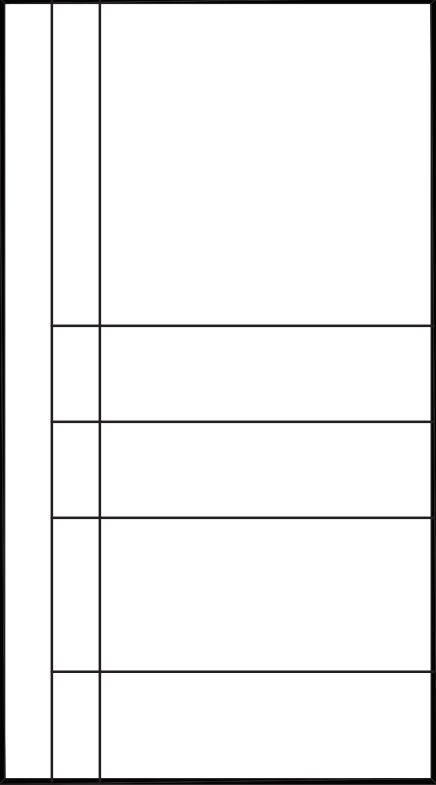


WEBUTUCK
CENTRAL SCHOOL DISTRICT
OPEN DOOR SBHC /
SCHOOL HEALTH OFFICE
WEBUTUCK MIDDLE/HIGH SCHOOL
SED # 13-11-01-04-0-002-020

DATE	DRAWN	CHECKED
09/18/2020	BKM	JJM
SCALE	NTS	
SHEET TITLE	PLUMBING LEGEND	

PROJECT NUMBER
15650.00

MSHS
P000
DRAWING NUMBER

Drawing Name: S:\Projects\Webutuck CSD\HS & MS Health Center\Design\06 CAD\AutoCAD\PLUM\P2\P201.dwg
Date last accessed: 9/18/2020 3:41 PM
Date last plotted: 9/18/2020 4:02 PM
Plotted By: Brendon Mazza

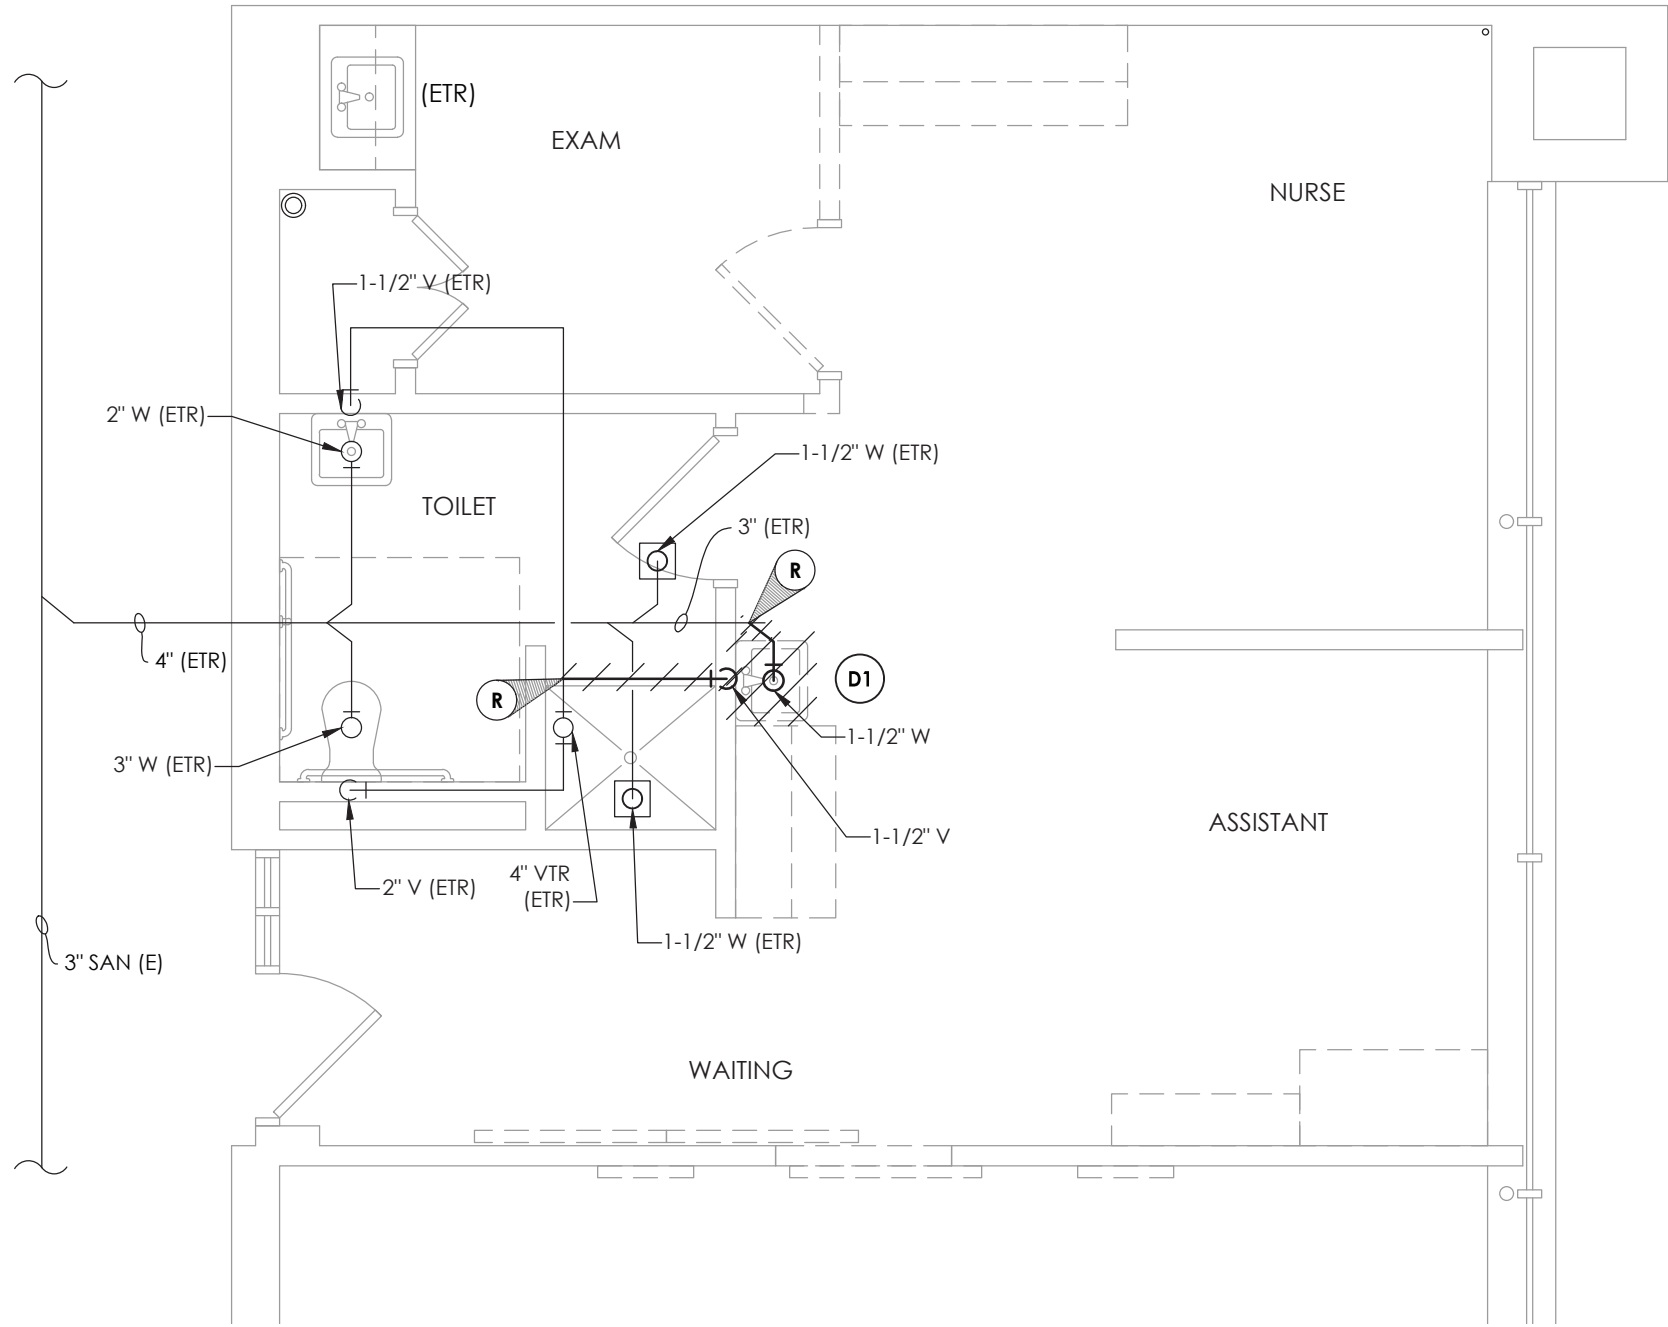

1
P201
SANITARY AND VENT PIPING DEMOLITION PLAN
SCALE: 1/4" = 1'-0"

GENERAL NOTES:


1. VERIFY ALL PIPES SIZES AND LOCATIONS PRIOR TO DEMOLITION.

DEMOLITION NOTES:


- (D1) REMOVE EXISTING SINK IN ITS ENTIRETY AND ALL ASSOCIATED SANITARY, VENT AND DOMESTIC PIPING BACK TO POINTS INDICATED. PREPARE FOR NEW WORK.

KEY NOTES:


1. INSTALL NEW SINK AND PROVIDE NEW DOMESTIC, SANITARY AND VENT PIPING. CONNECT TO EXISTING MAINS AS SHOWN. PROVIDE ALL SLAB CUTTING, REMOVAL, TRENCHING, BACKFILLING, NEW CONCRETE SLAB, AND FINISHES AS REQUIRED TO ACCOMMODATE NEW YORK.
2. RELOCATE EXISTING ISOLATION VALVE PIPE DROP TO ABOVE CEILING TO PROVIDE ACCESS TO VALVE FOR NEW PIPE CHASE. MODIFY PIPING AS NECESSARY. COORDINATE SHUTTING OFF WATER WITH DISTRICT.

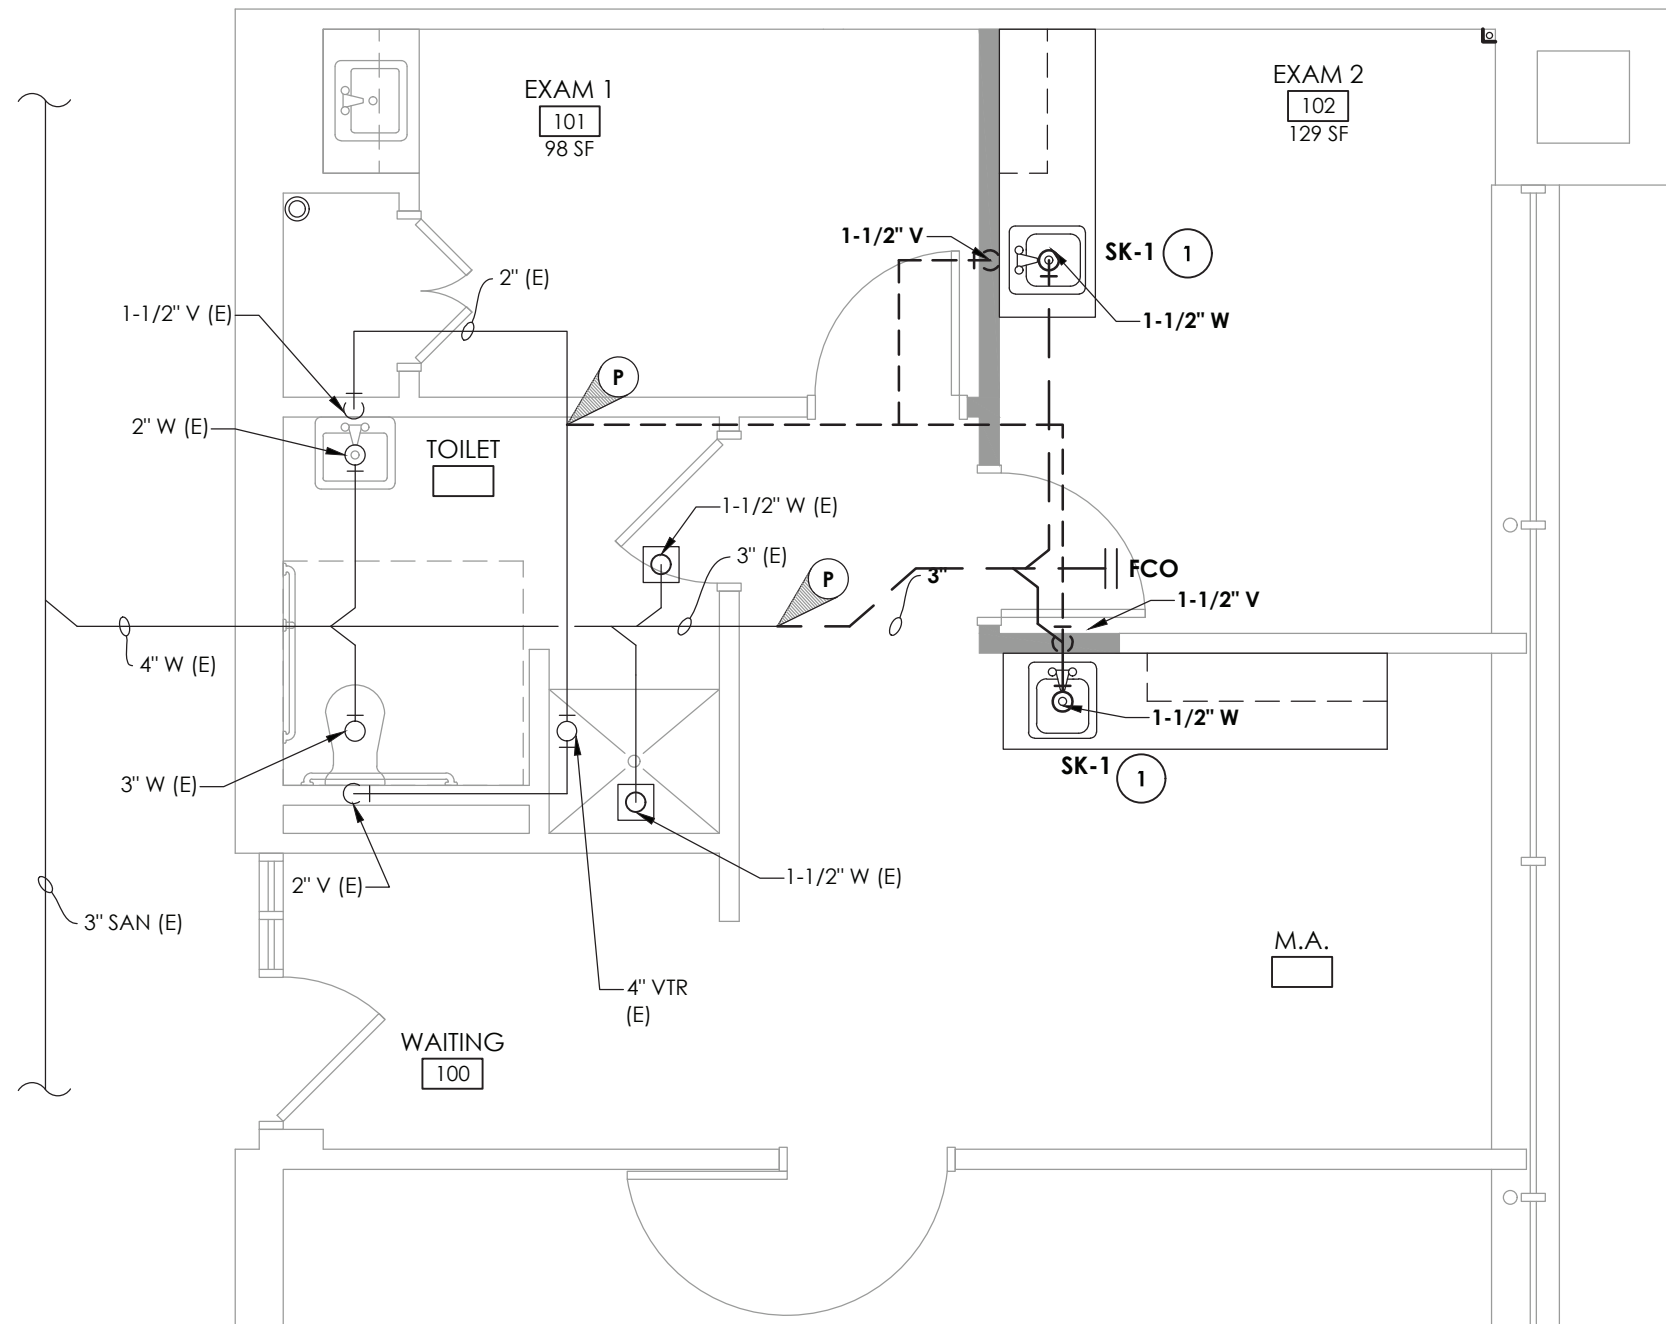


2
P201
SANITARY AND VENT NEW WORK PLAN
SCALE: 1/4" = 1'-0"

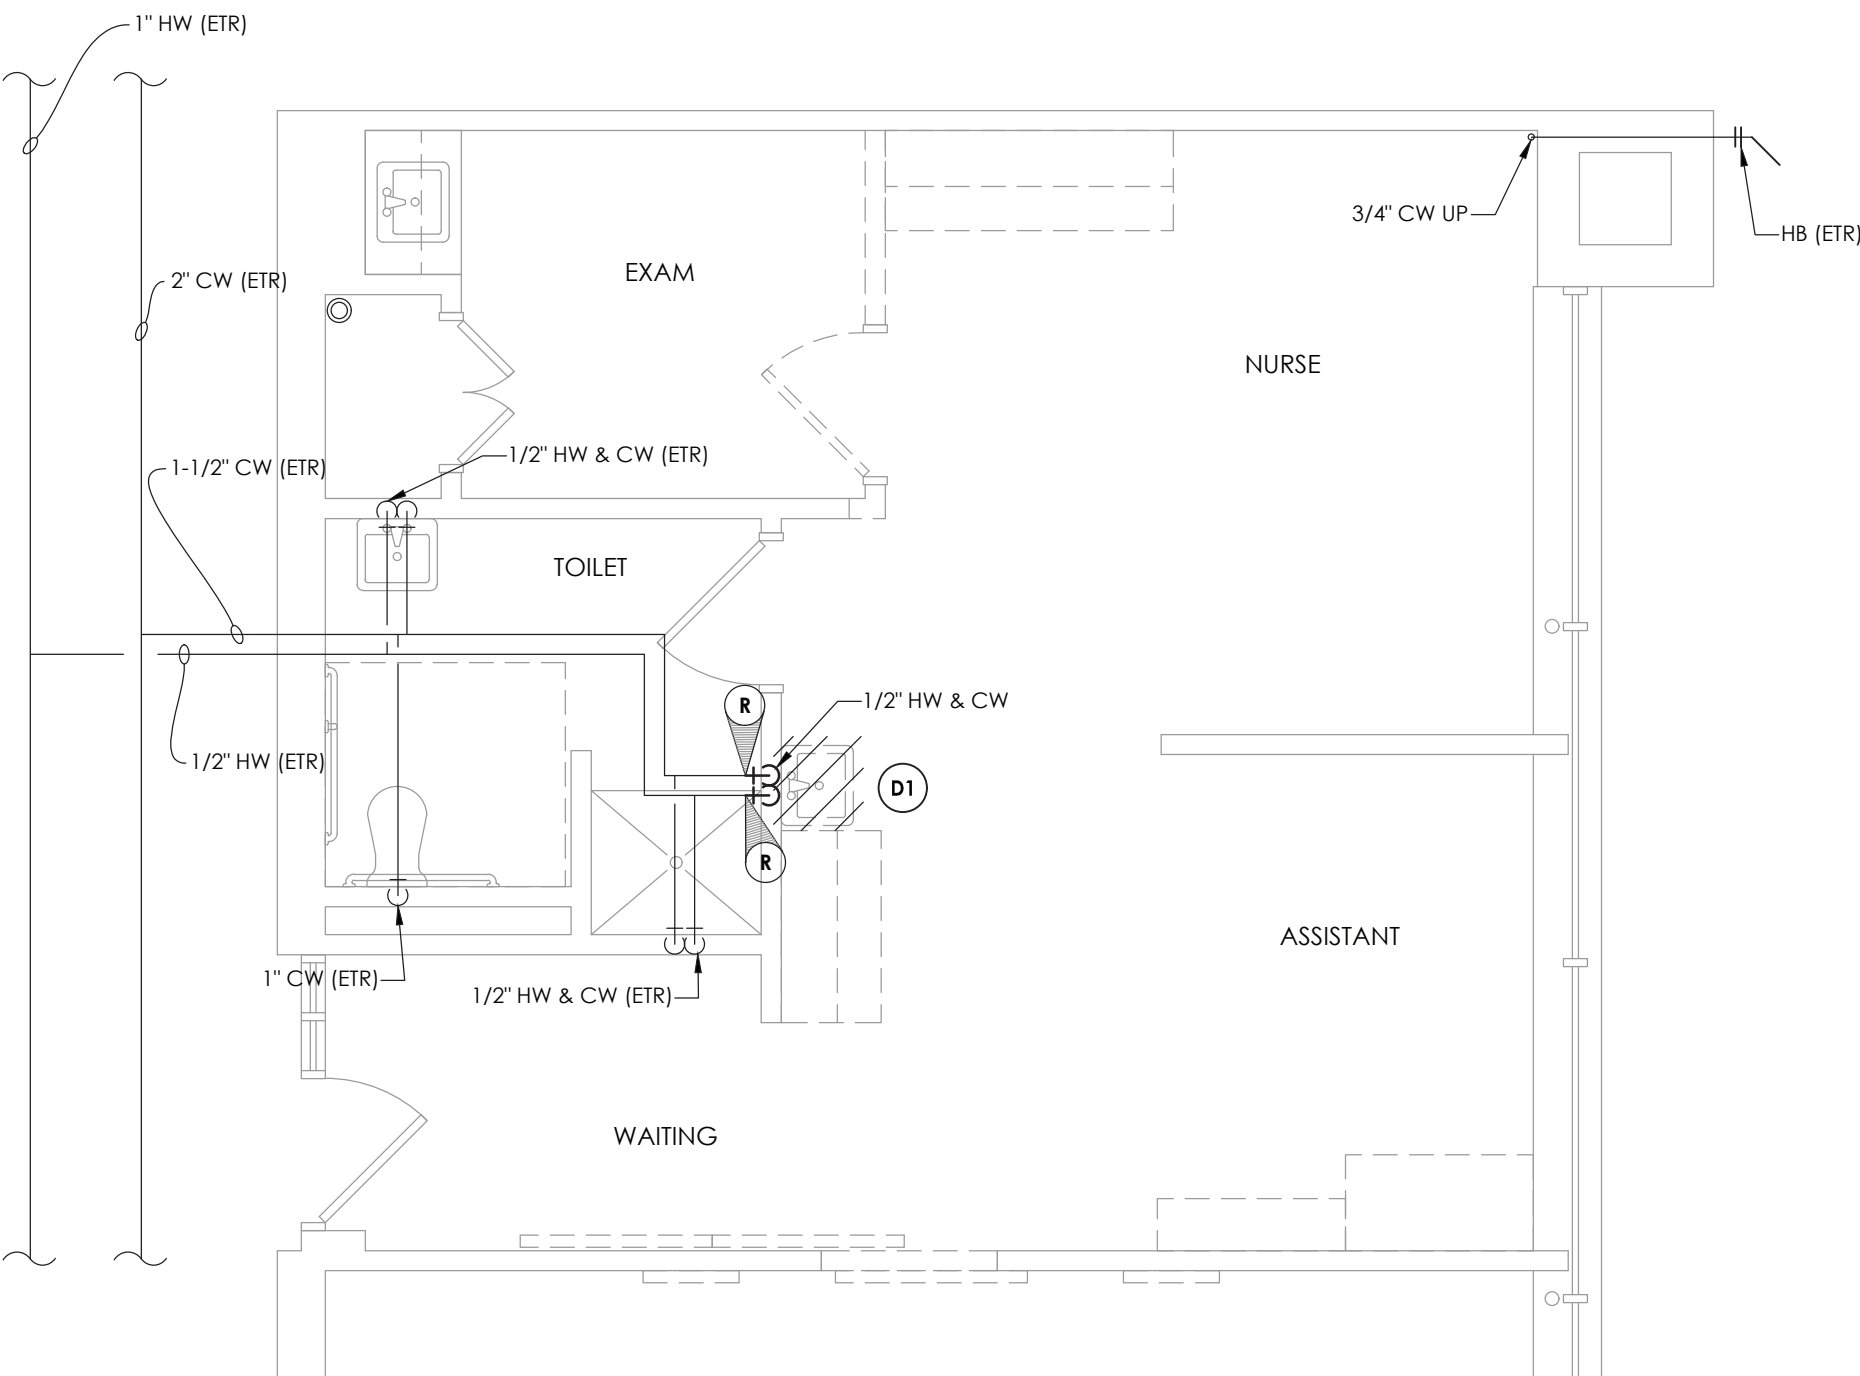

3
P201
DOMESTIC PIPING DEMOLITION PLAN
SCALE: 1/4" = 1'-0"

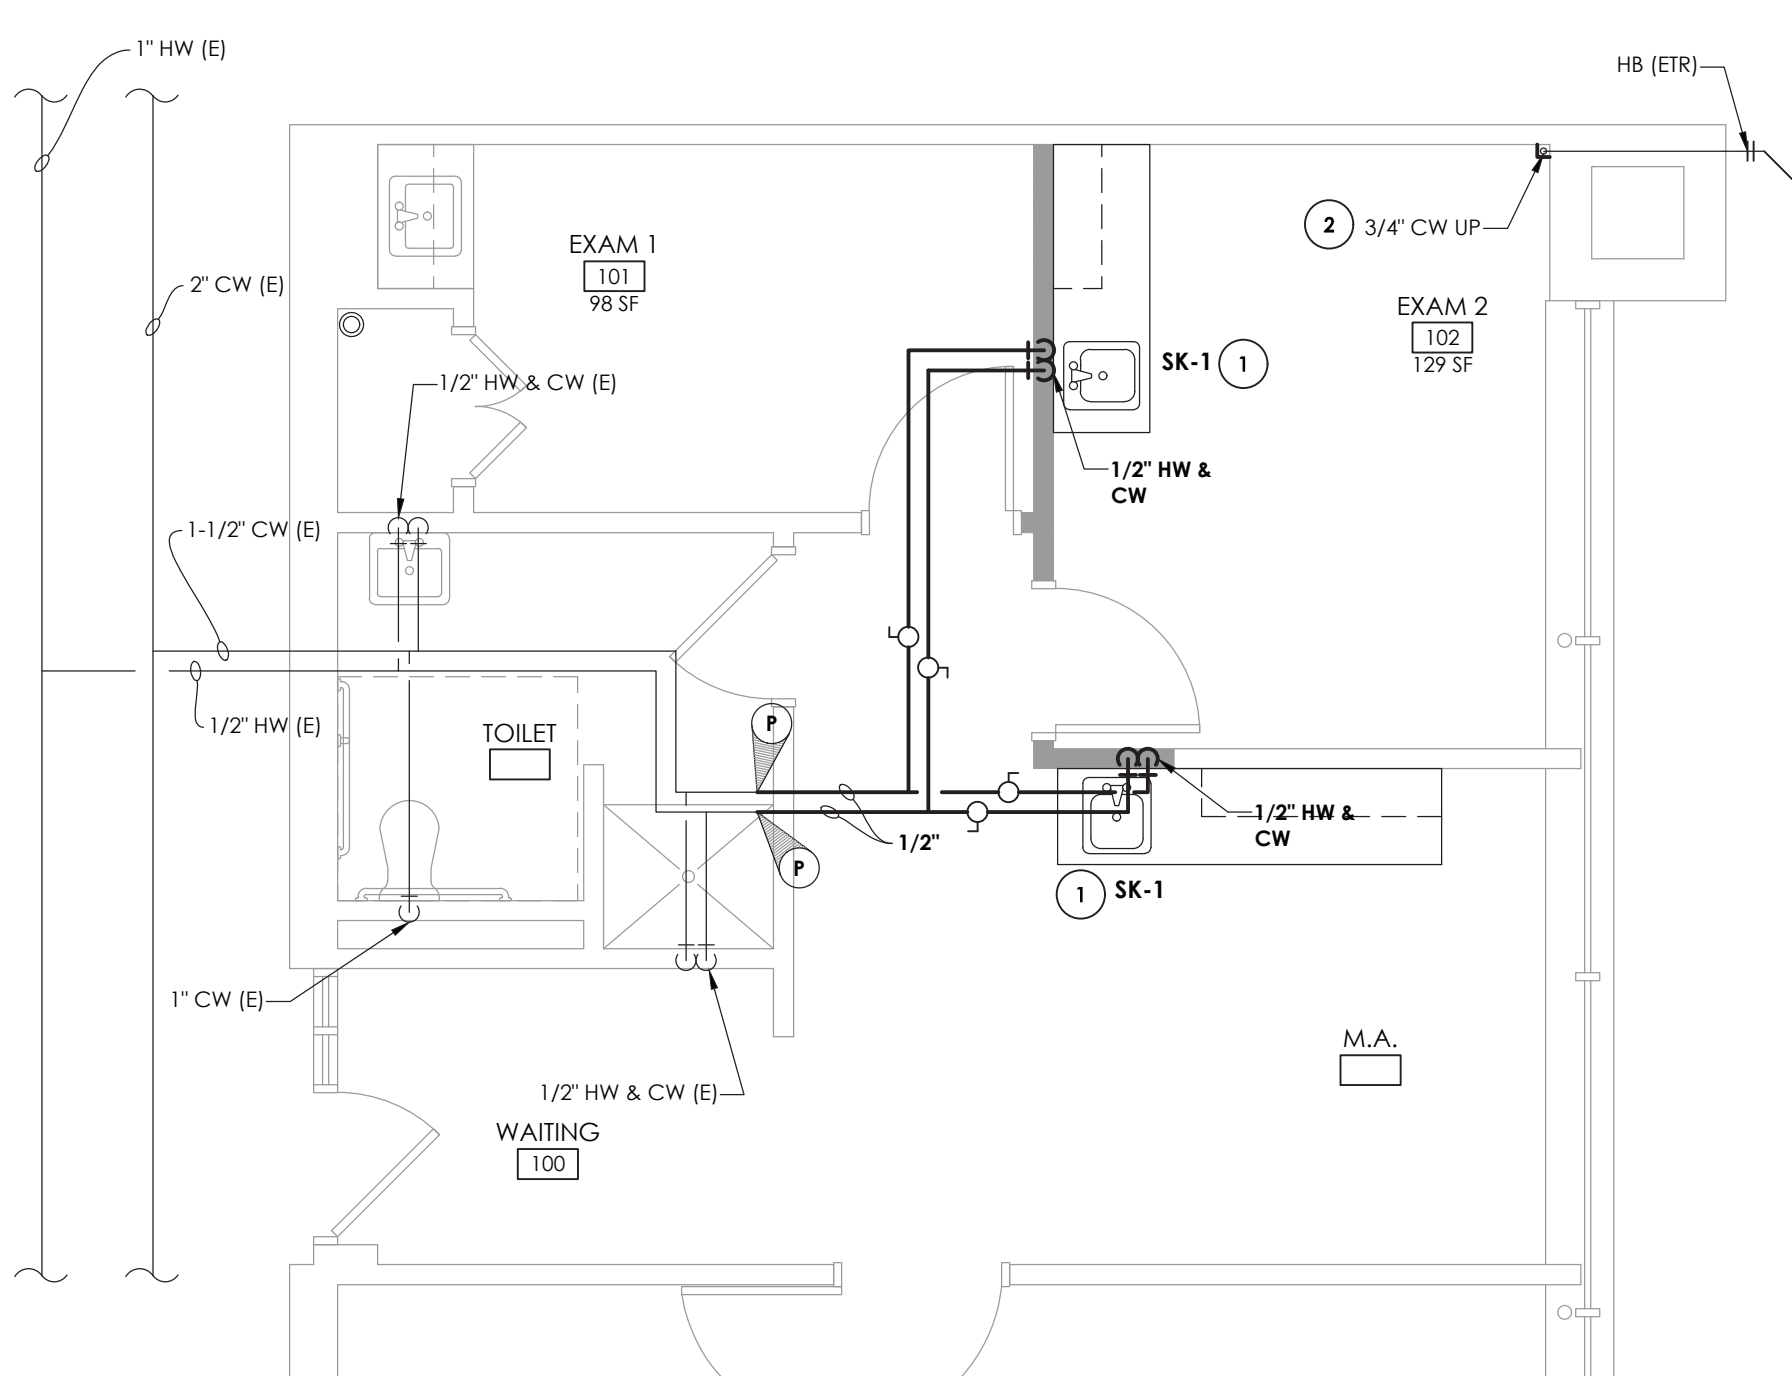

4
P201
DOMESTIC PIPING NEW WORK PLAN
SCALE: 1/4" = 1'-0"

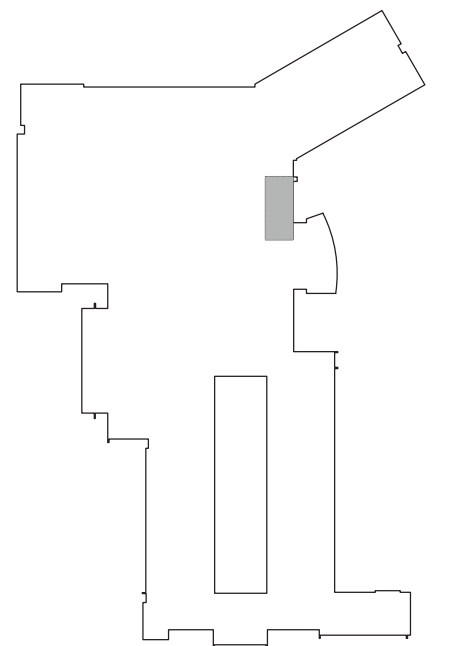


KEY PLAN
SCALE: N.T.S.



CPLteam.com
ARCHITECTURE • ENGINEERING • PLANNING

50 FRONT STREET, SUITE 202
NEWBURGH, NEW YORK 12550
TEL (800) 274-9000
FAX (845) 567-9614

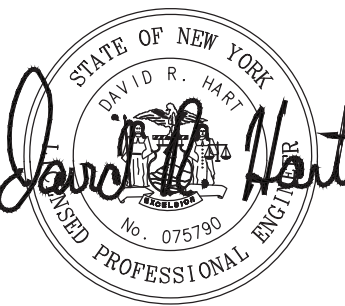

**WEBUTUCK
CENTRAL SCHOOL DISTRICT
OPEN DOOR SBHC /
SCHOOL HEALTH OFFICE
WEBUTUCK MIDDLE/HIGH SCHOOL**
SED # 13-11-01-04-0-002-020

DATE	DRAWN	CHECKED
1/18/2020	BKM	JJM
SCALE	NTS	
SHEET TITLE		
PLUMBING DEMOLITION AND NEW WORK PLAN		

PROJECT NUMBER
15650.00
MSHS P201
DRAWING NUMBER