

**A NEW 108-ROOM
COURTYARD BY
MARRIOTT
HOTEL & SUITES**
Turner Road
Woodbury, New York
location #12121

for
**RAINBOW
ENTERPRISES**
4758 Highway 28
Cooperstown, NY

REVISION DATES

UNAUTHORIZED ALTERATIONS OR
ADDITIONS TO THIS DRAWING ARE
A VIOLATION OF STATE
EDUCATION LAW ARTICLES 145
AND 147.


THIS DRAWING IS AN INSTRUMENT
OF SERVICE FOR RAINBOW
ENTERPRISES, AND MAY NOT BE
REPRODUCED WITHOUT THE
EXPRESS CONSENT OF THE
OWNER AND THE ARCHITECT

DRAWING TITLE
**SECOND FLOOR STORM &
SANITARY WASTE PLAN**

DATE
MARCH 1, 2021

PROJECT NUMBER
17971

SHEET NUMBER
P102

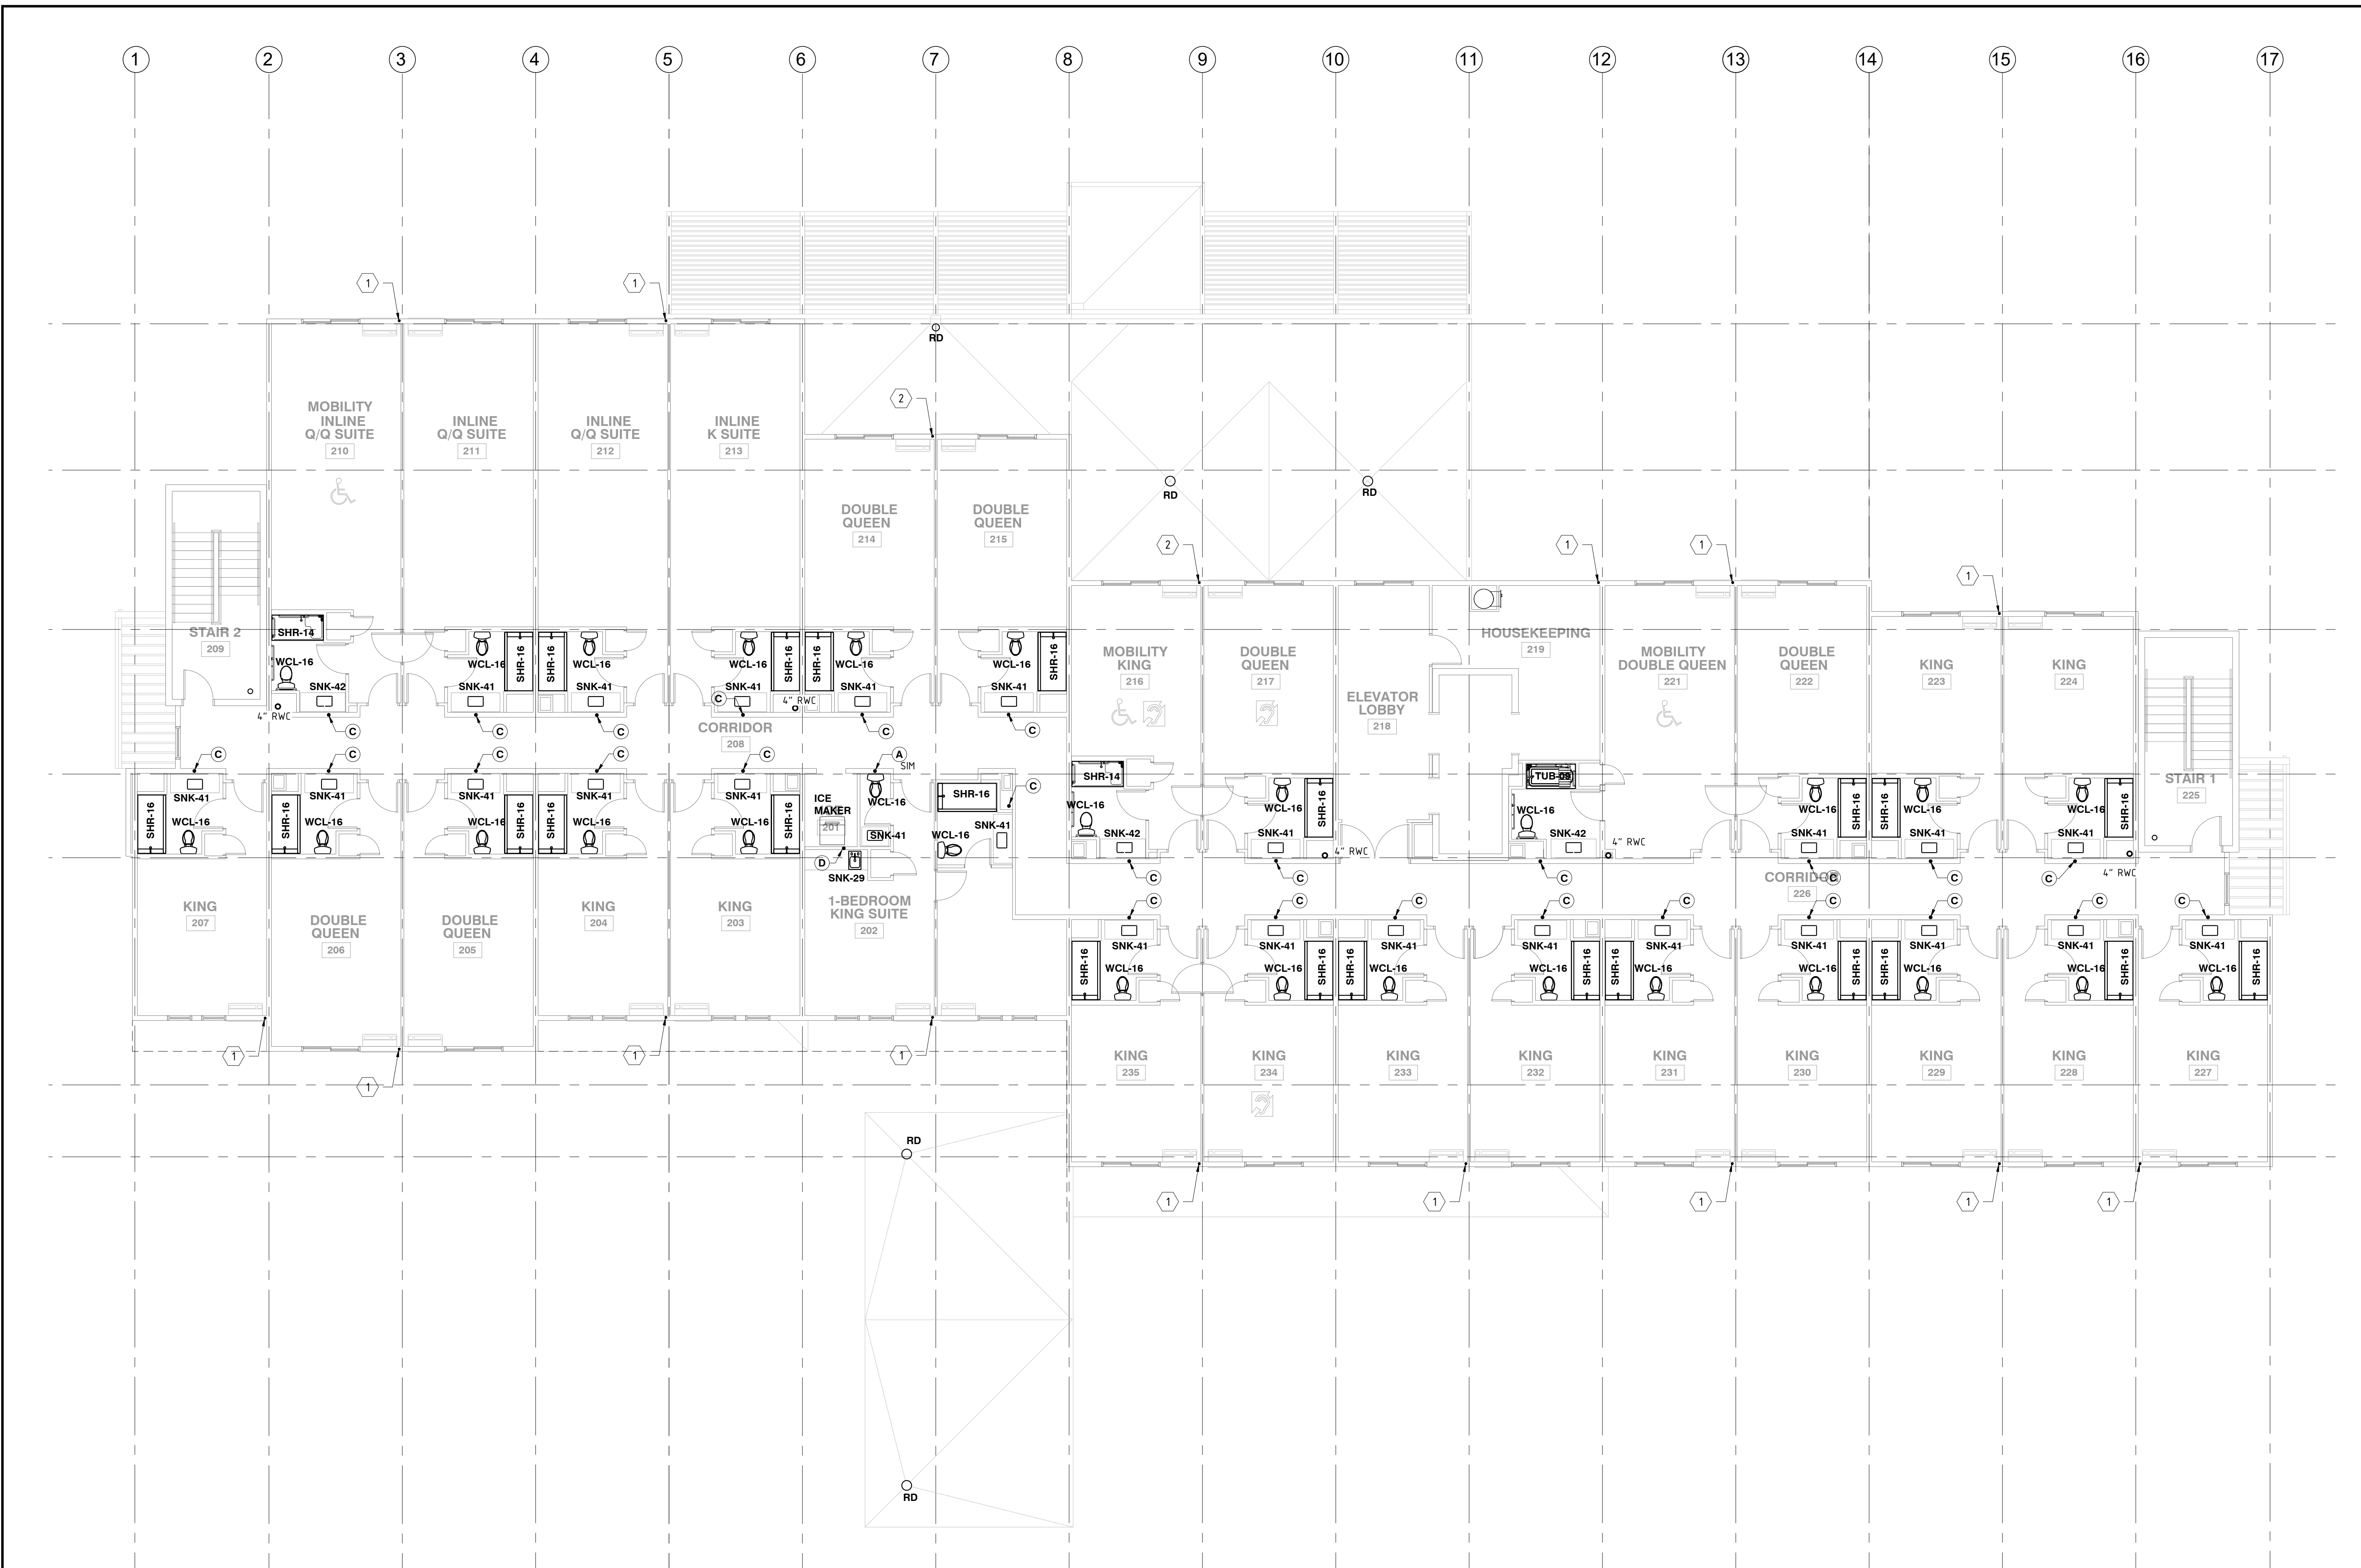

REFER TO SHEET P301 FOR ENLARGED GUESTROOM SANITARY PLUMBING PLANS
REFER TO SHEET P101 FOR KEYNOTE LEGEND