

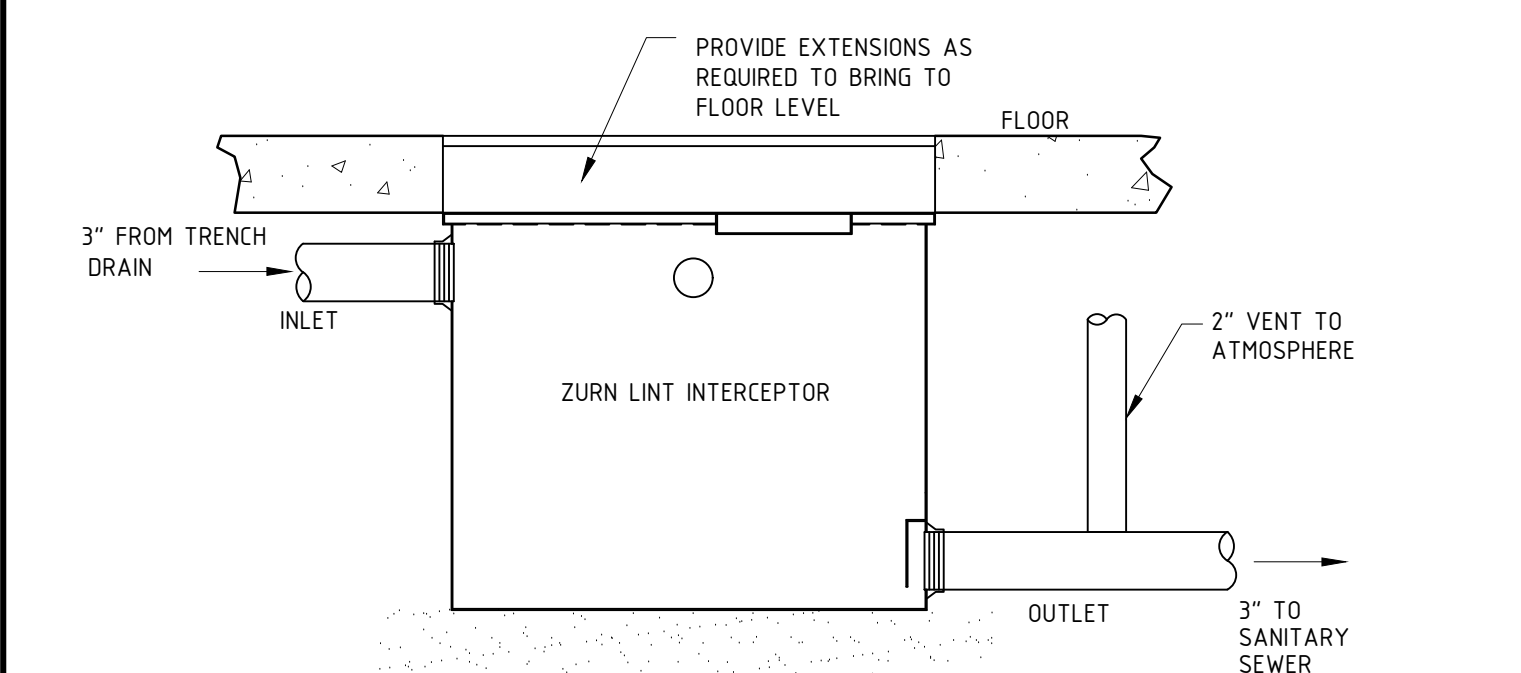
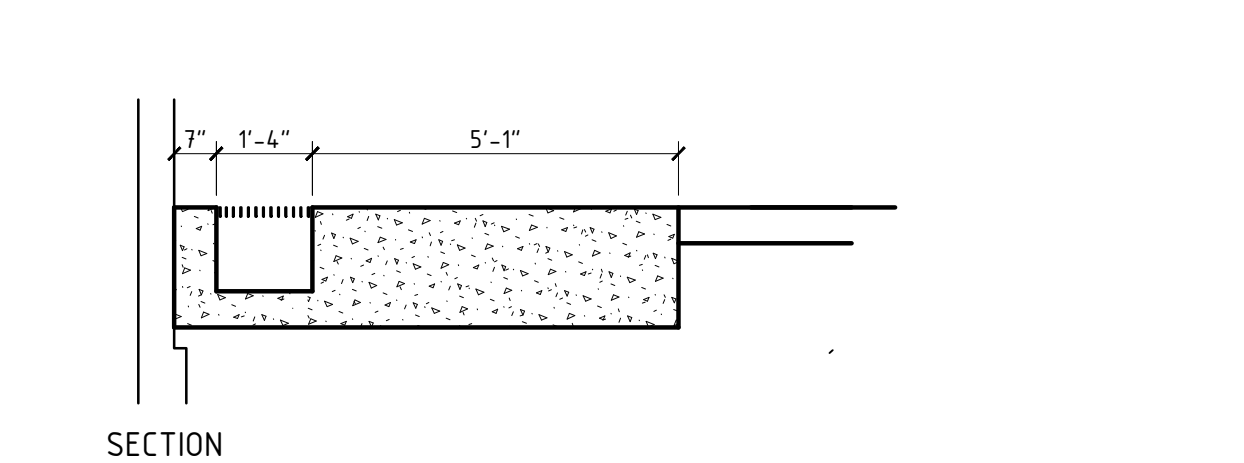
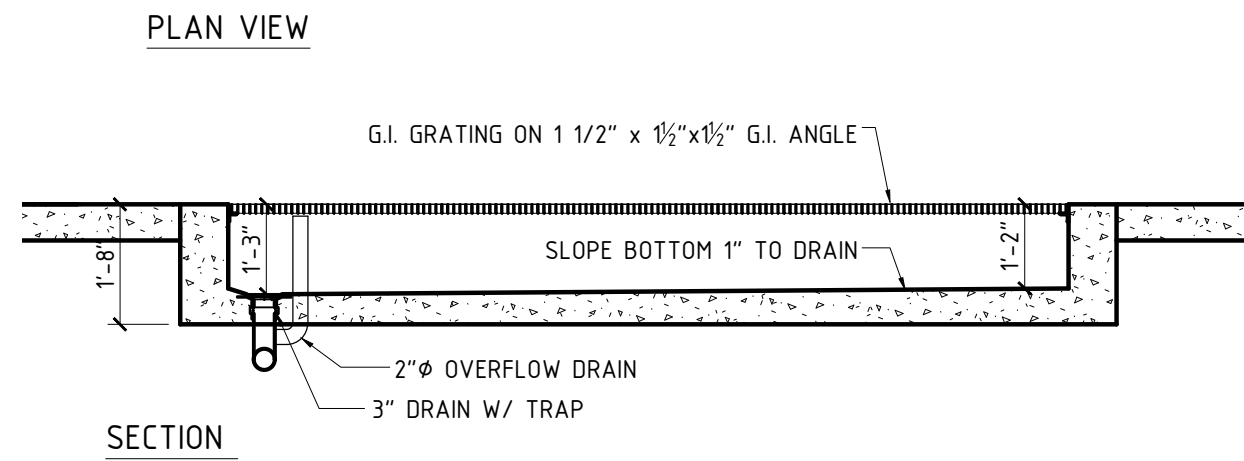


SYMBOL	ABBREVIATION	DESCRIPTION
---	CW	COLD WATER LINE
---	HW	HOT WATER LINE
---	HWR	HW RECIRCULATION LINE
---	CW	COLD WATER LINE
---	HW	HOT WATER LINE
---	HWR	HW RECIRCULATION LINE
---	SAN	SANITARY WASTE LINE
---	V	VENT LINE
---	UP	PIPE RISER UP
---	DN	PIPE RISER DOWN
---	SOV / GV	SHUT-OFF VALVE / GATE VALVE
---	SOV / BV	SHUT-OFF VALVE / BALL VALVE
---	SOV / GV (NC)	SOV / GV (NORMALLY CLOSED)
---	SOV / BV (NC)	SOV / BV (NORMALLY CLOSED)
---	SOV / GC	SHUT-OFF VALVE / GAS COCK
---	CK V	CHECK VALVE
---	UN	UNION
---	UN	PRESSURE REGULATING VALVE
---	P&T	PRESS. & TEMP. RELIEF VALVE
---	STR	"Y" STRAINER
---	PR GA	PRESSURE GAUGE
---	WTR MTR	WATER METER
---	GAS MTR	GAS METER
---	RW	RAIN WATER LINE
---	NG	NATURAL GAS (FUEL GAS) LINE
---	F	FIRE SPRINKLER LINE
---	FDC	FIRE DEPT. CONNECTION

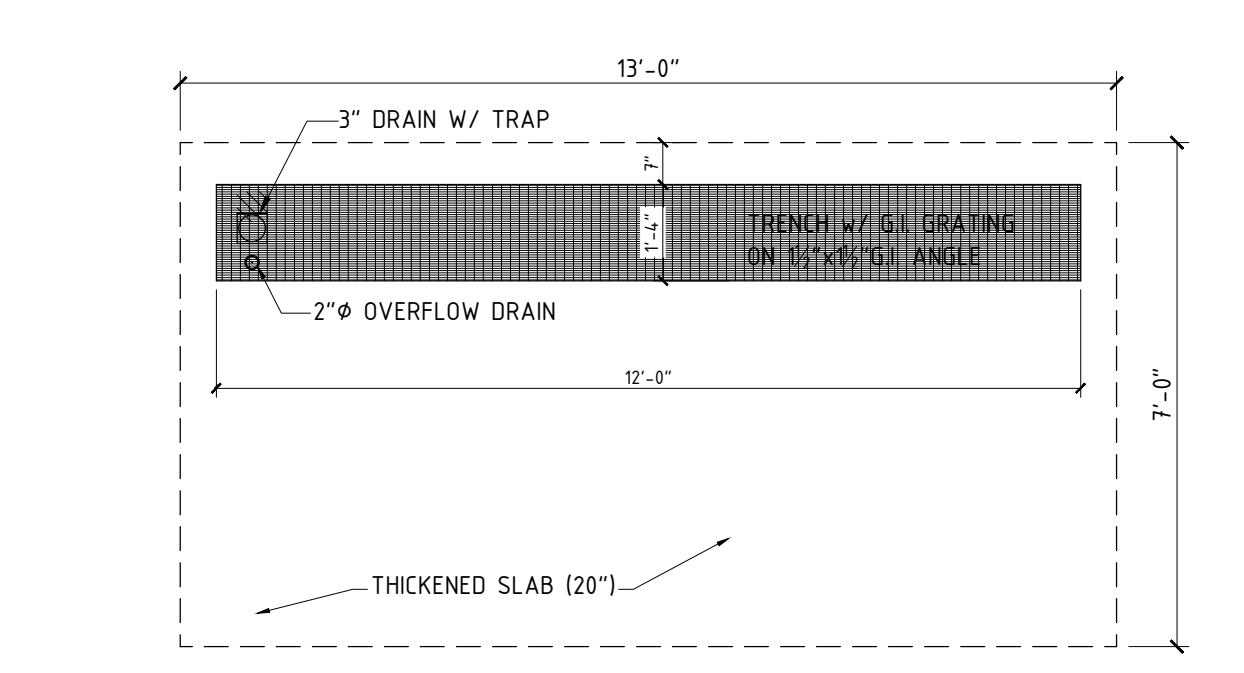

31 LINT INTERCEPTOR DETAIL

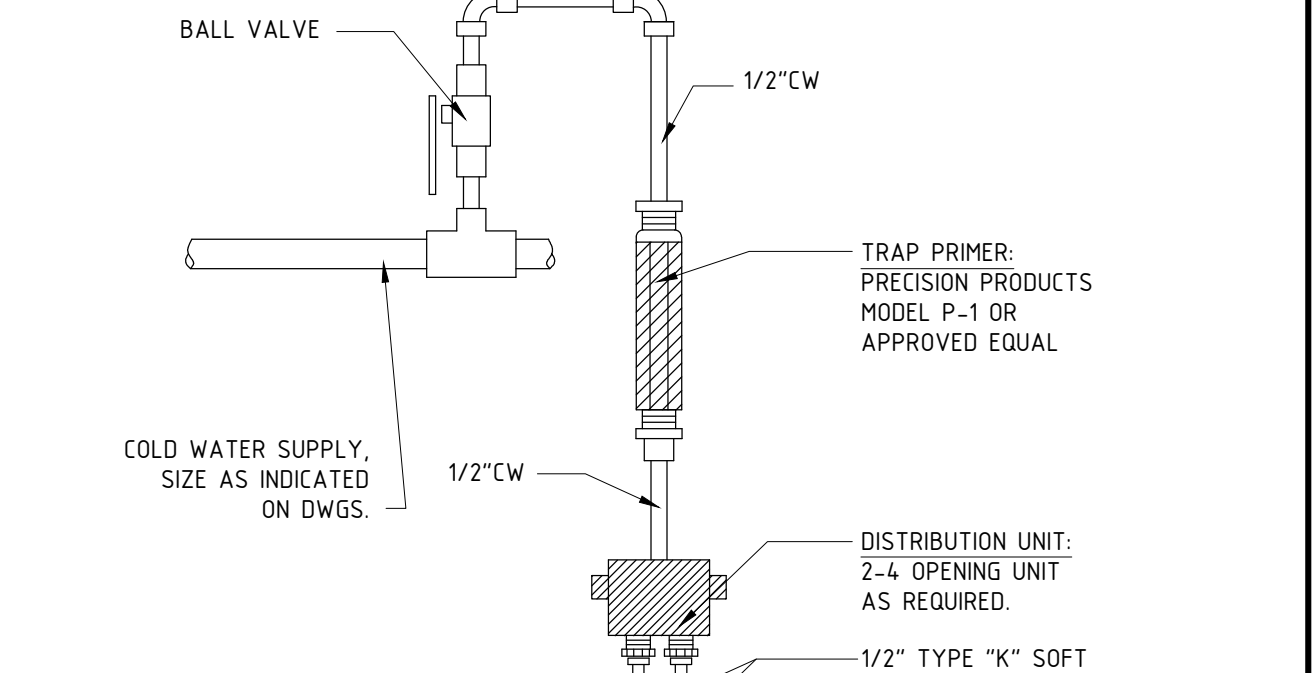


41 TRAP PRIMER

12 PLUMBING ABBREVIATIONS & SYMBOLS


22 LAUNDRY TRENCH DRAIN DETAILS

32 RPZ DIAGRAM


42 FLOOR SINK DETAIL

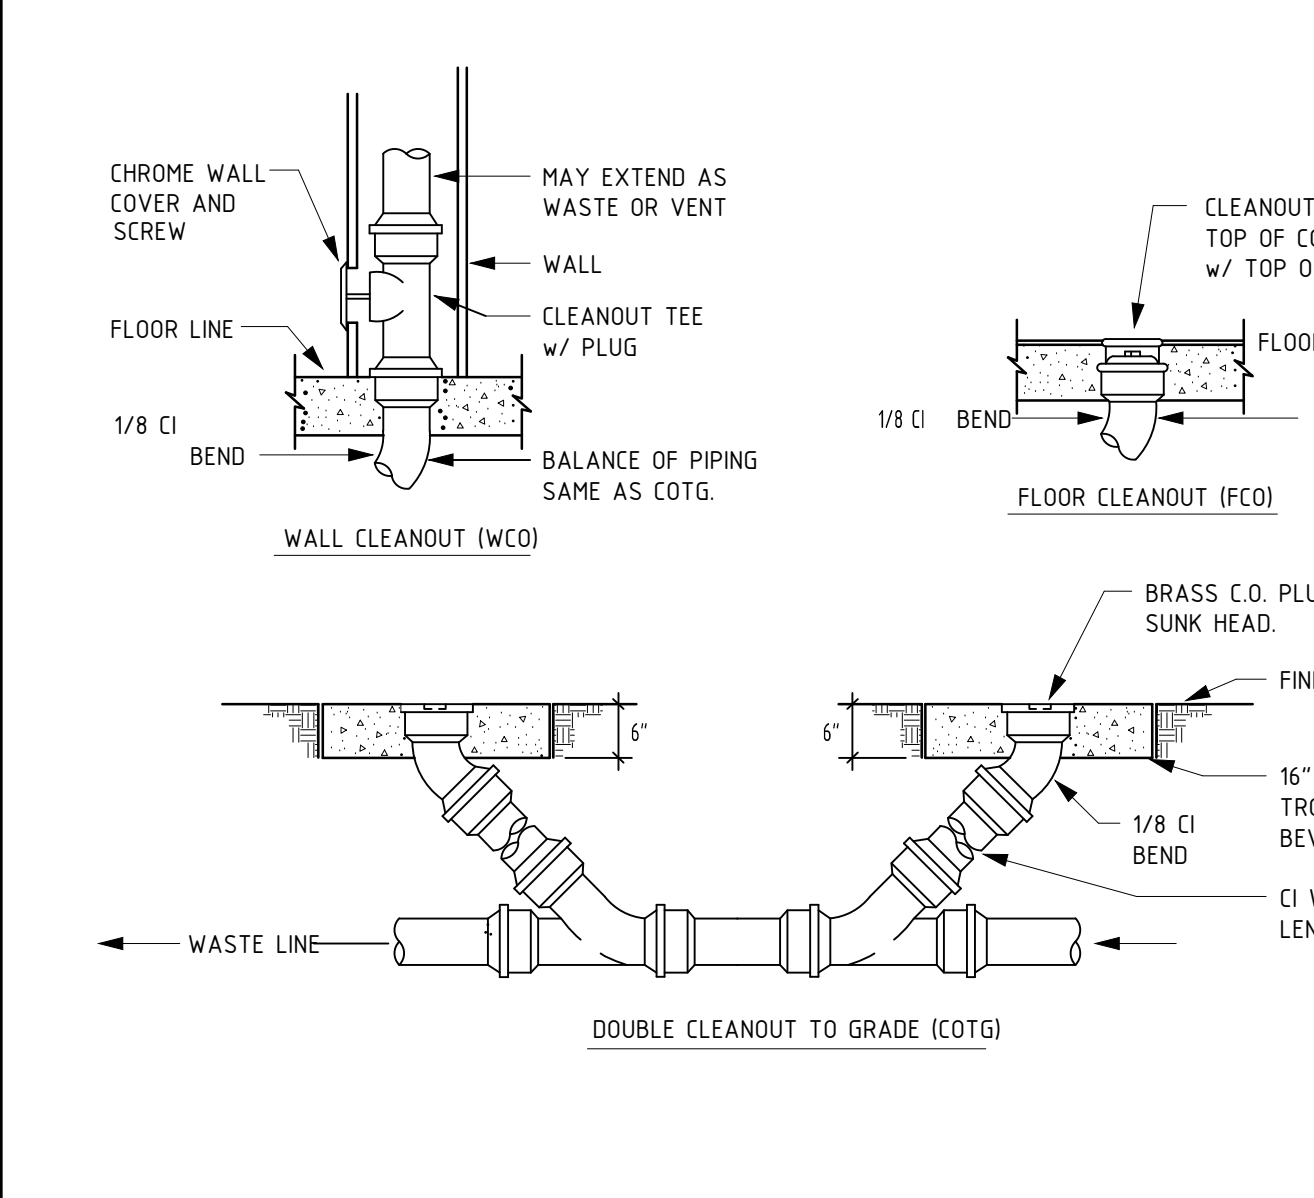


12 CLEANOUT DETAILS

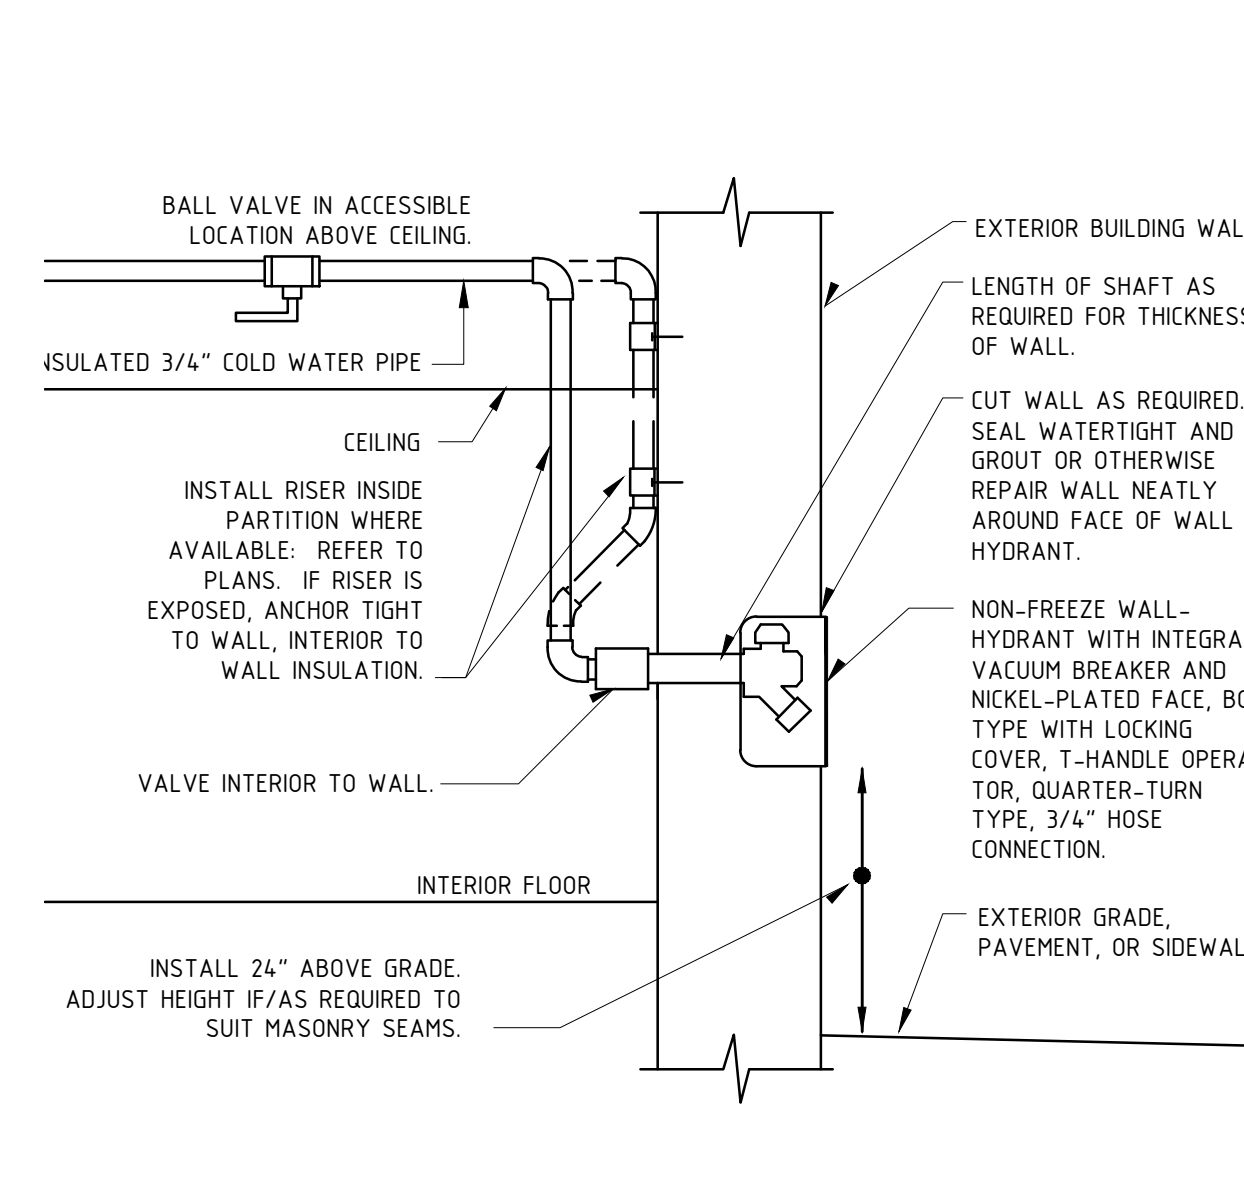


34 EXTERIOR WALL HOSE BIBB

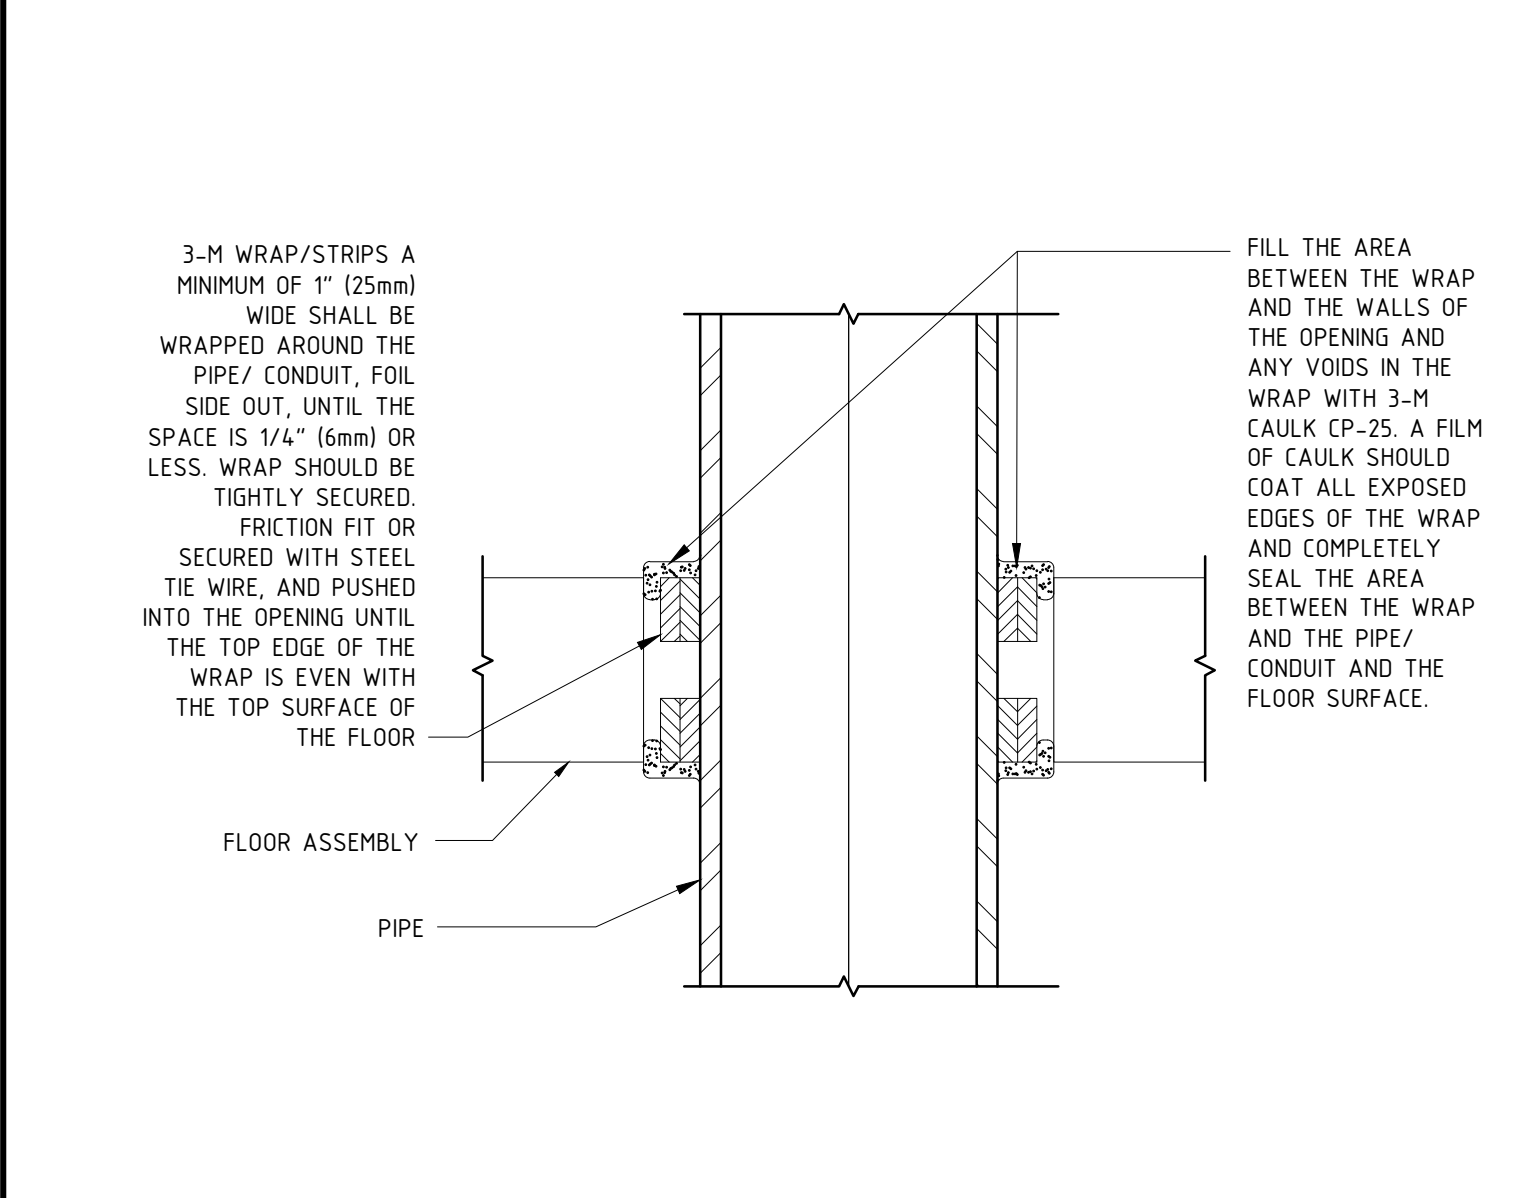


34 RPZ DIAGRAM

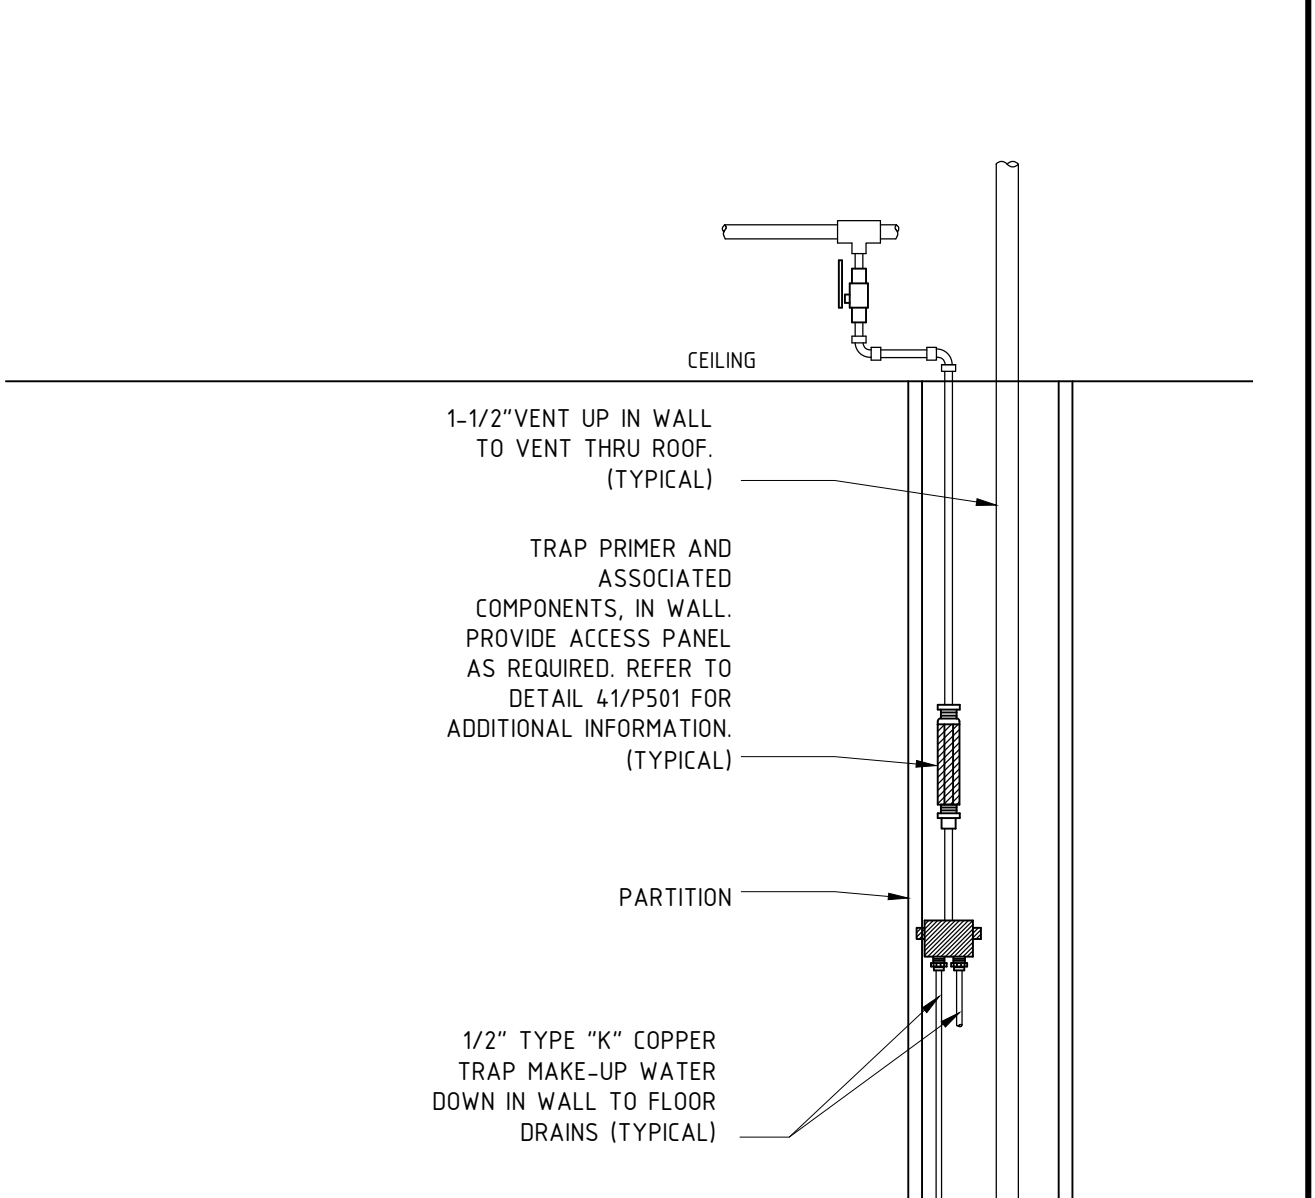


42 FLOOR SINK DETAIL

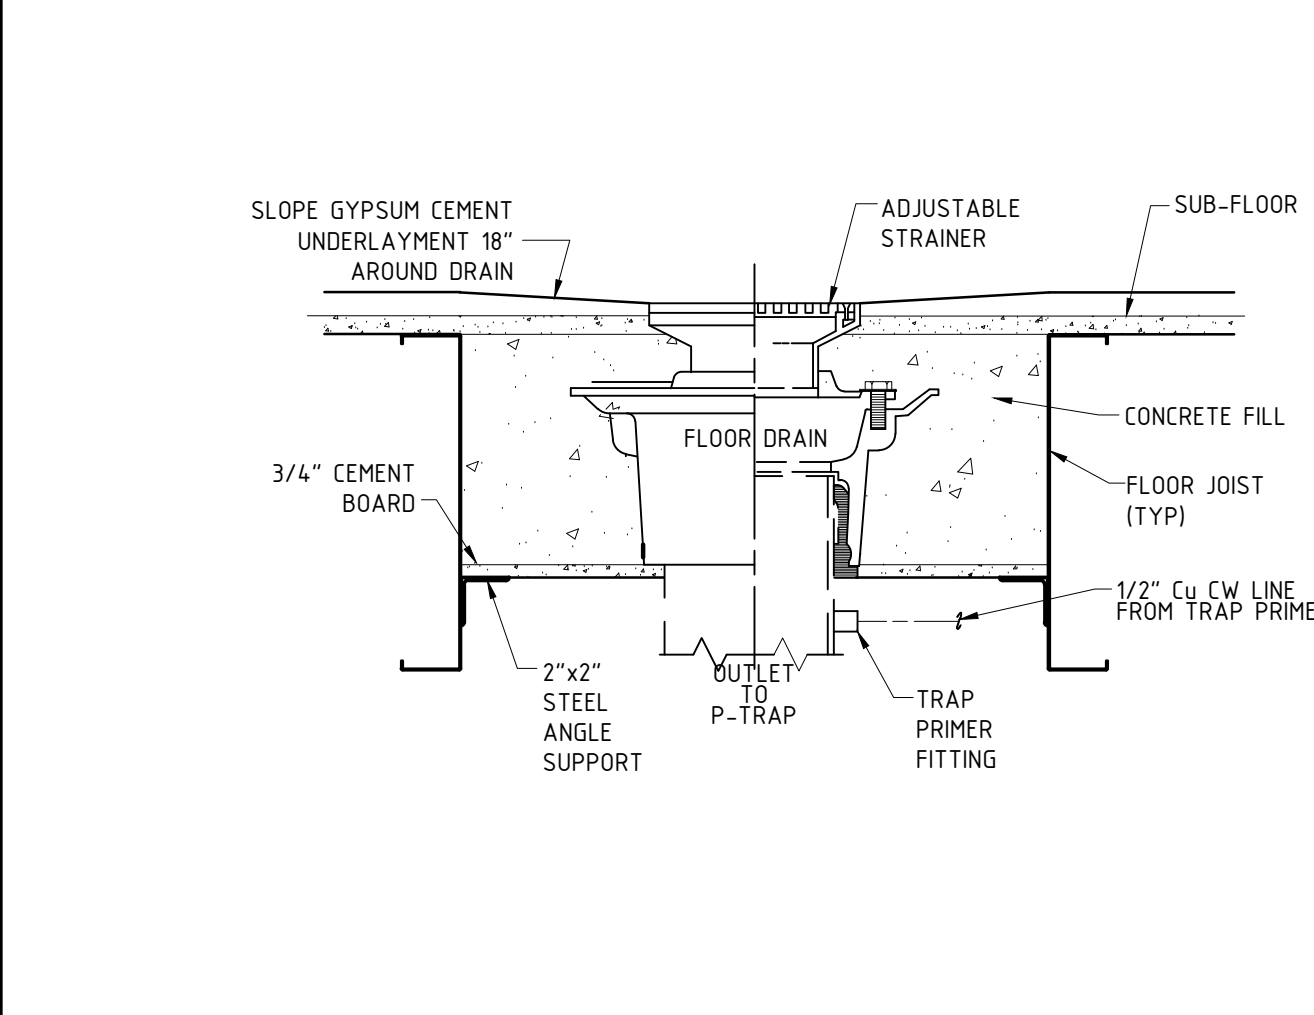


14 FLOOR DRAIN DETAIL

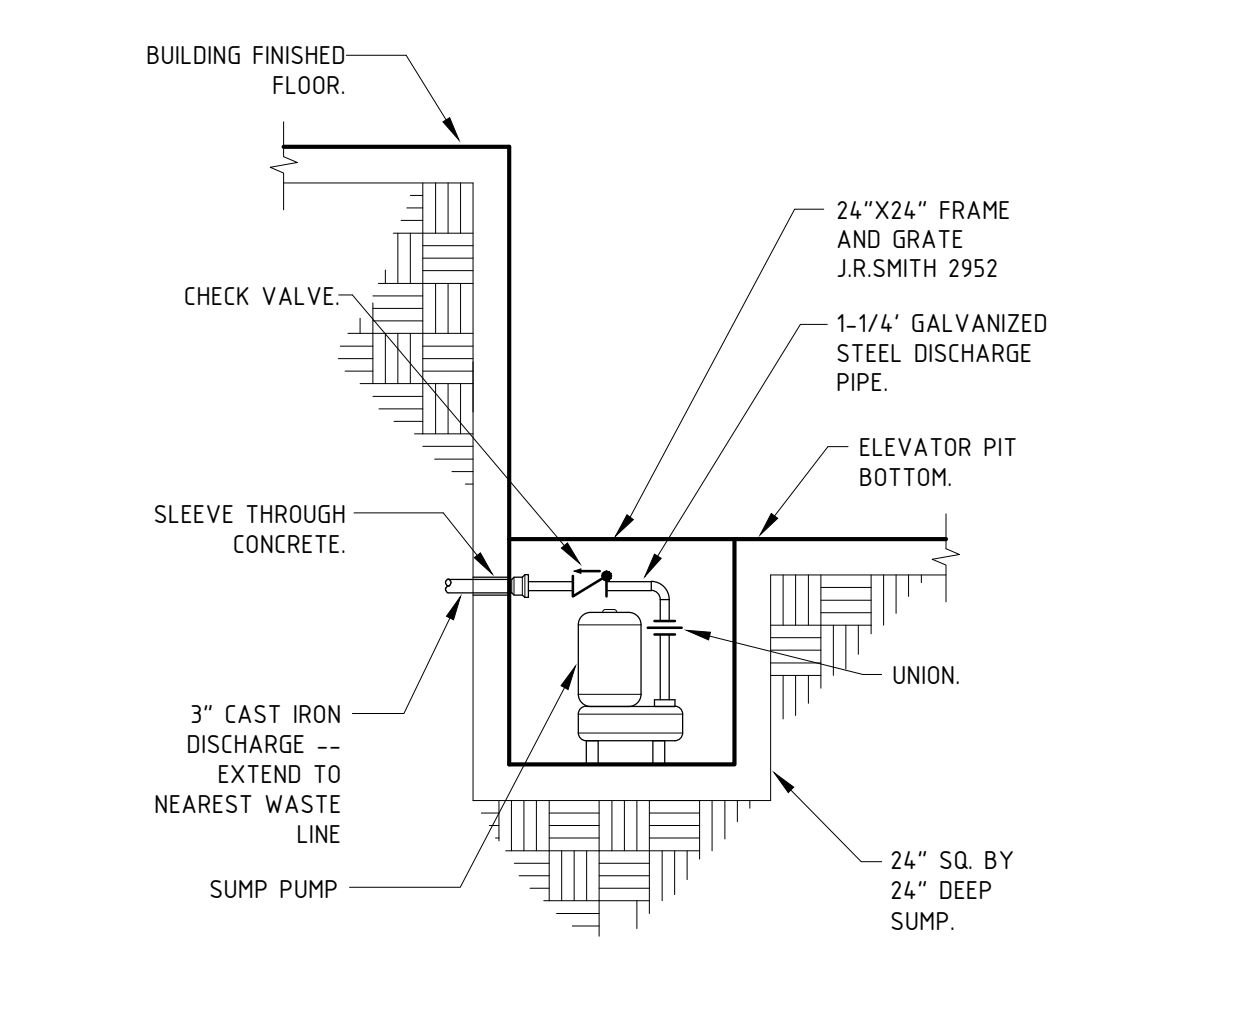

24 ELEVATOR SUMP PUMP

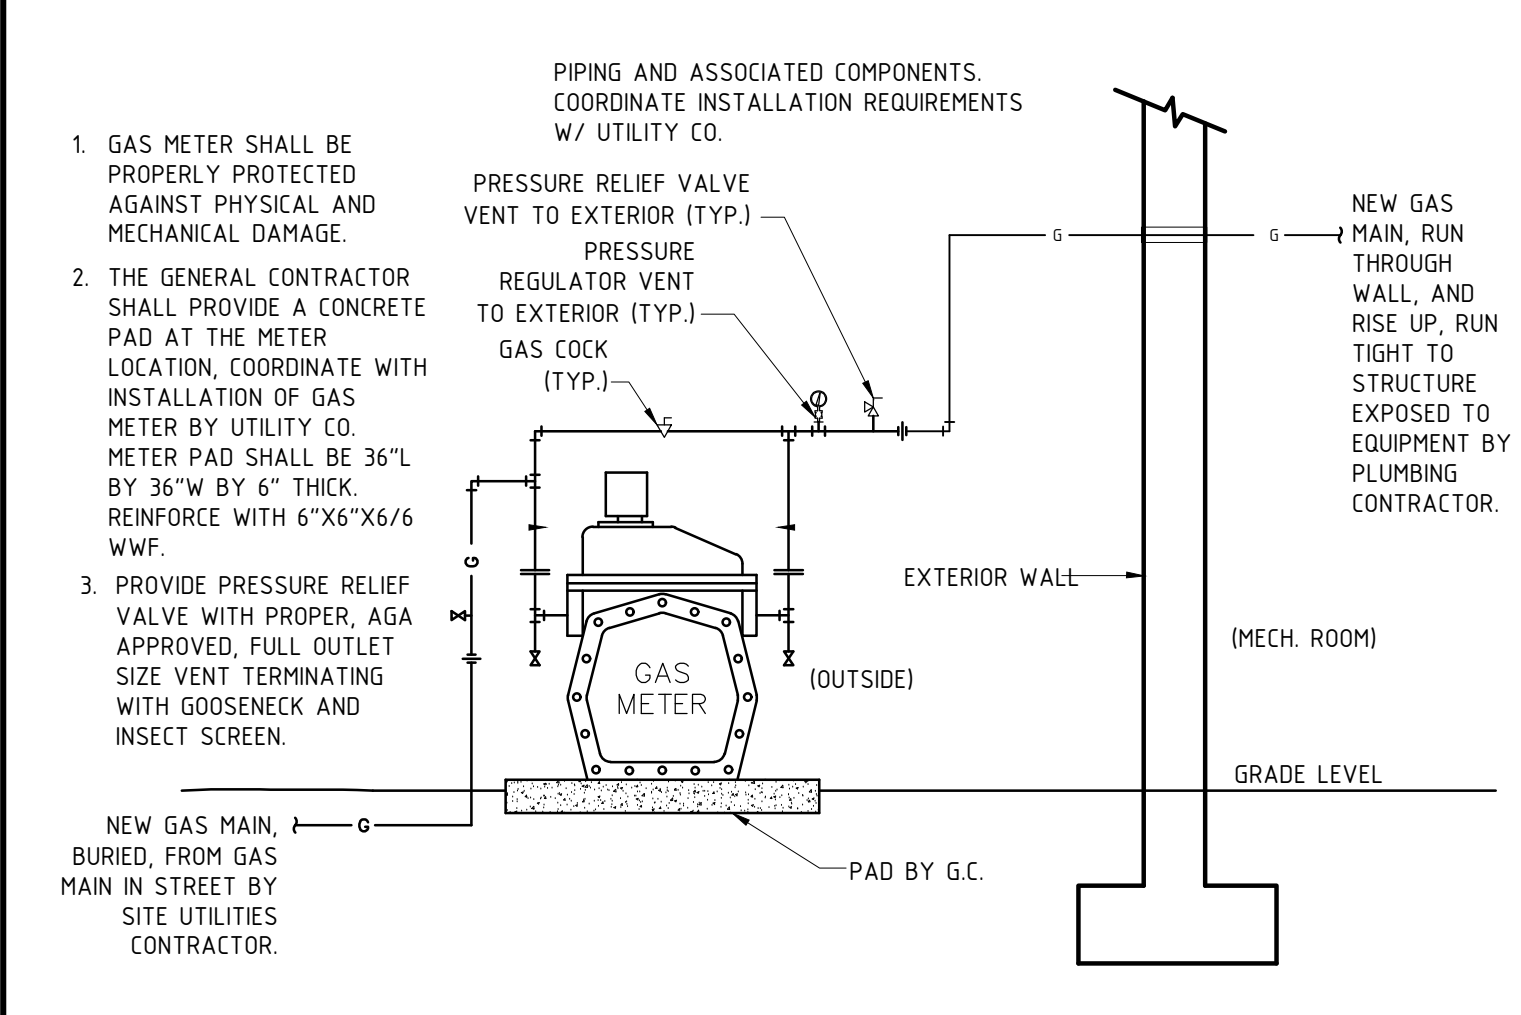

34 FUEL GAS METER INSTALLATION --- VERIFY WITH AHJ

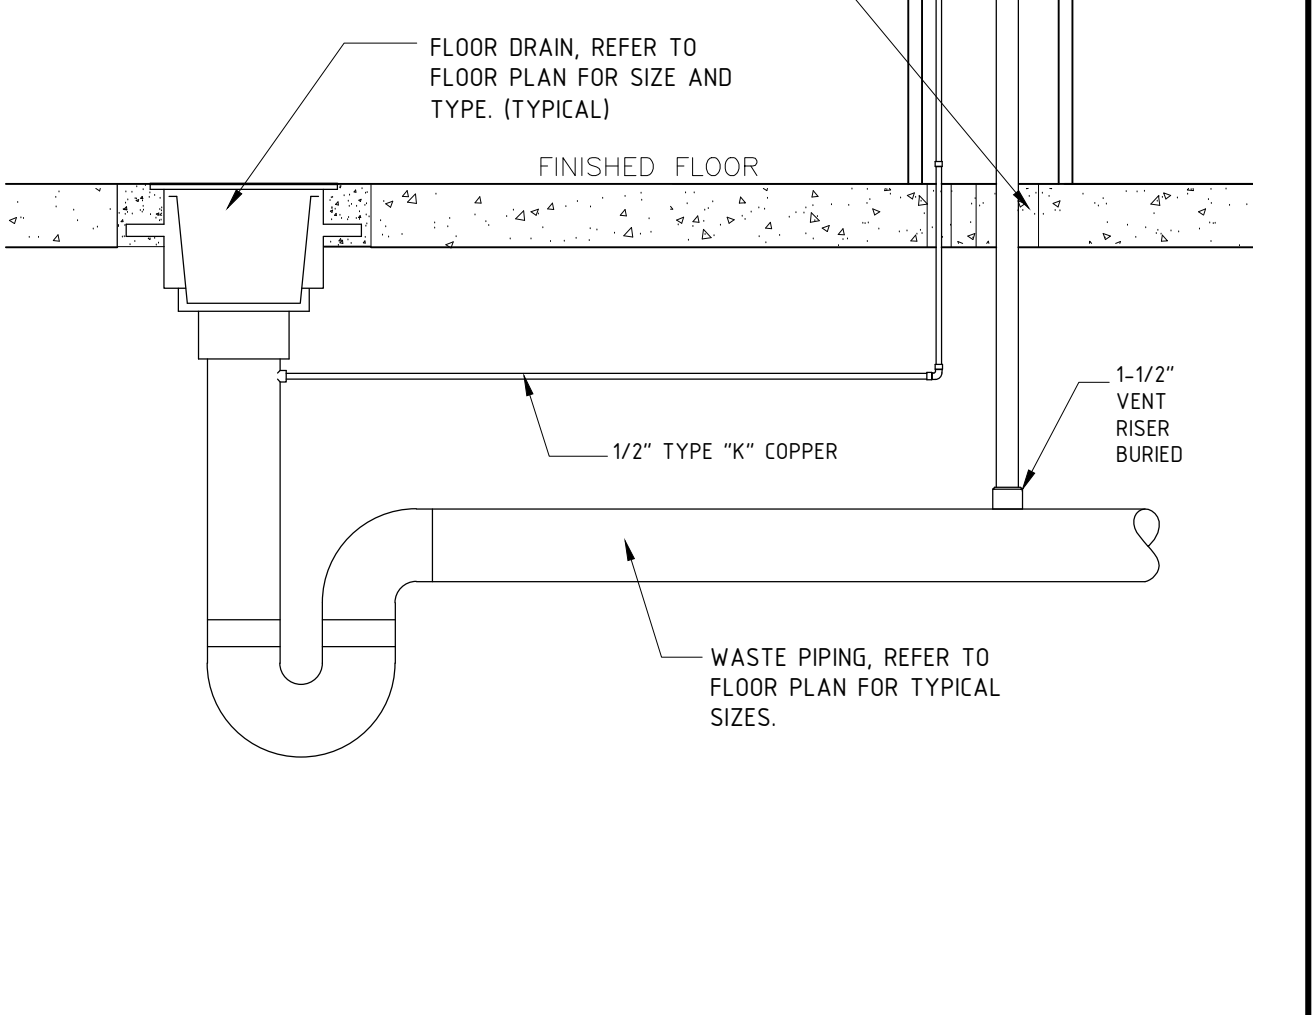

34 TRAP PRIMER SECTION



A NEW 108-ROOM COURTYARD BY MARRIOTT HOTEL & SUITES
Turner Road
Woodbury, New York
location #12121

for
RAINBOW ENTERPRISES
4758 Highway 28
Cooperstown, NY

REVISION DATES

UNAUTHORIZED ALTERATIONS OR ADDITIONS TO THIS DRAWING ARE A VIOLATION OF STATE EDUCATION LAW ARTICLES 145 AND 147.
THIS DRAWING IS AN INSTRUMENT OF SERVICE FOR RAINBOW ENTERPRISES, AND MAY NOT BE REPRODUCED WITHOUT THE EXPRESS CONSENT OF THE OWNER AND THE ARCHITECT

DRAWING TITLE
PLUMBING DETAILS
DATE
MARCH 1, 2021
PROJECT NUMBER
17971
SHEET NUMBER
P501