




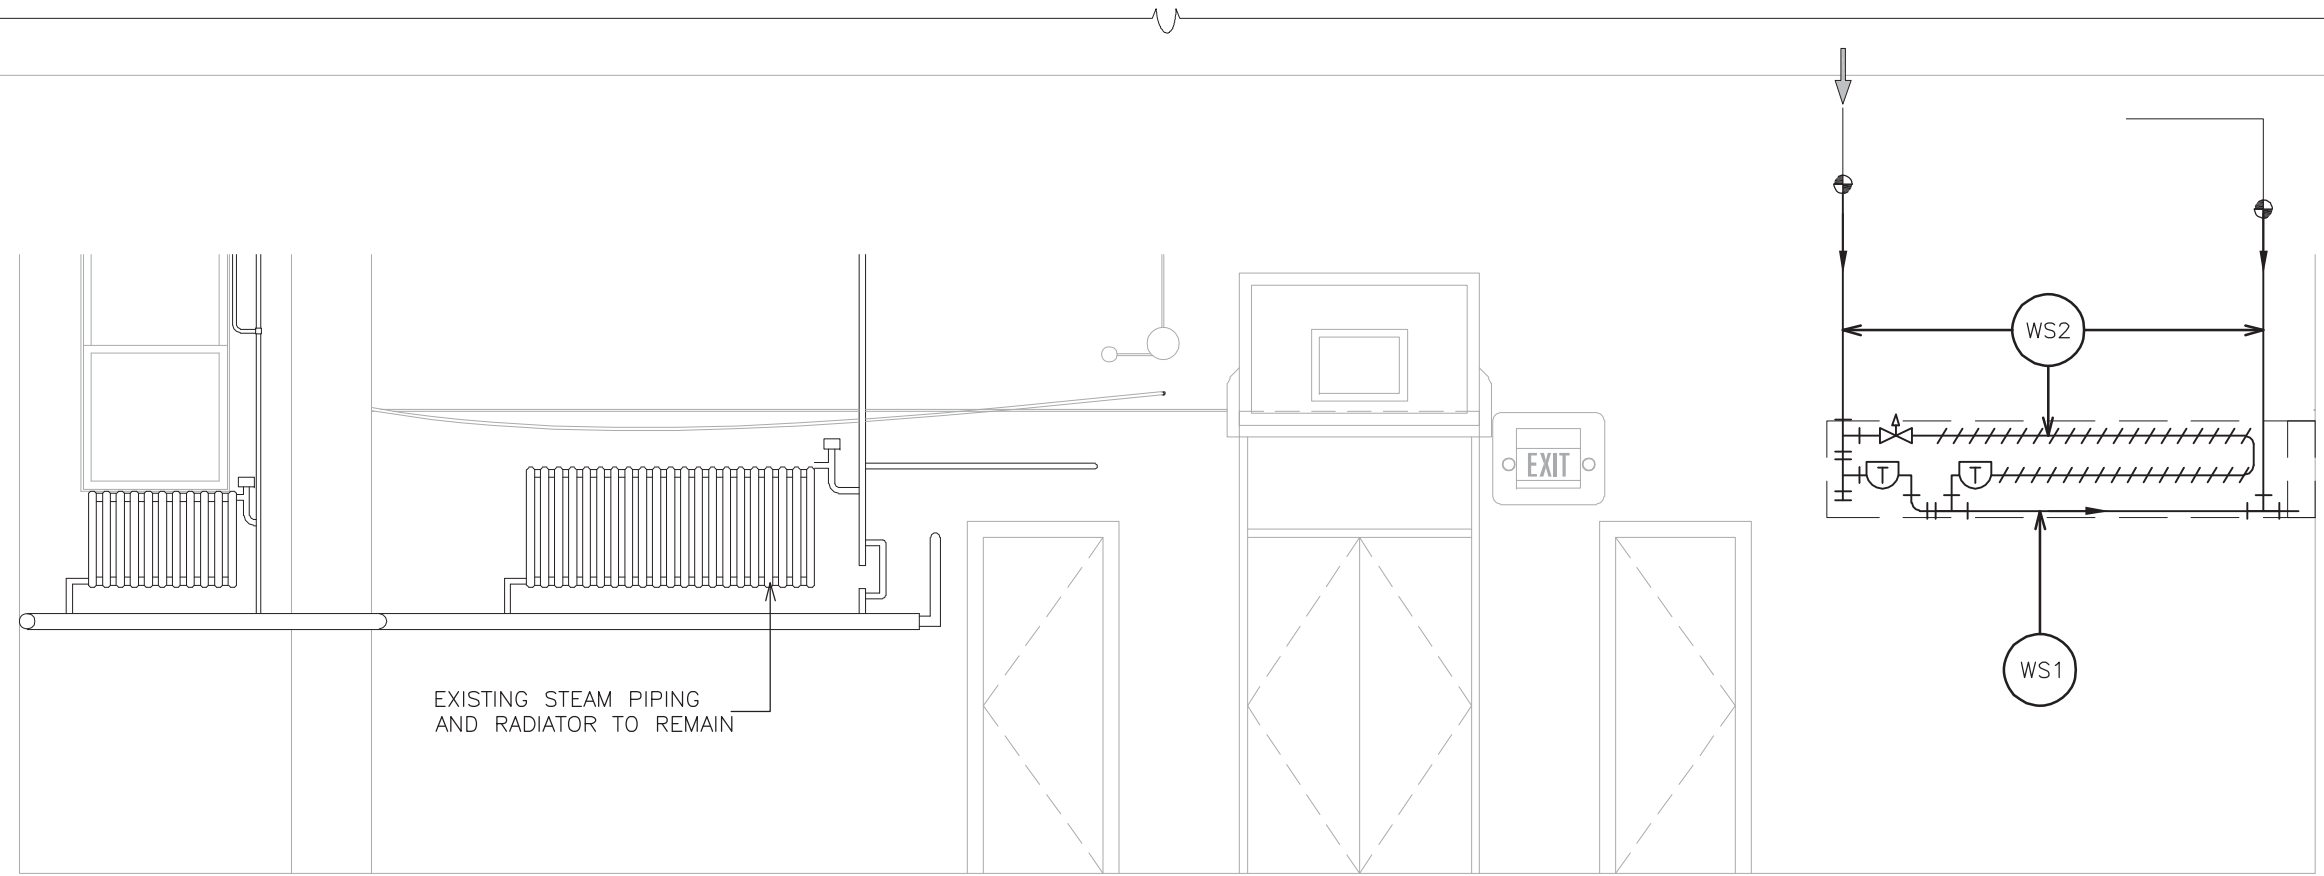


NEW INTERIOR ELEVATION
WEST - GYM/CAFETERIA
5 SCALE: 1/4" = 1'-0"

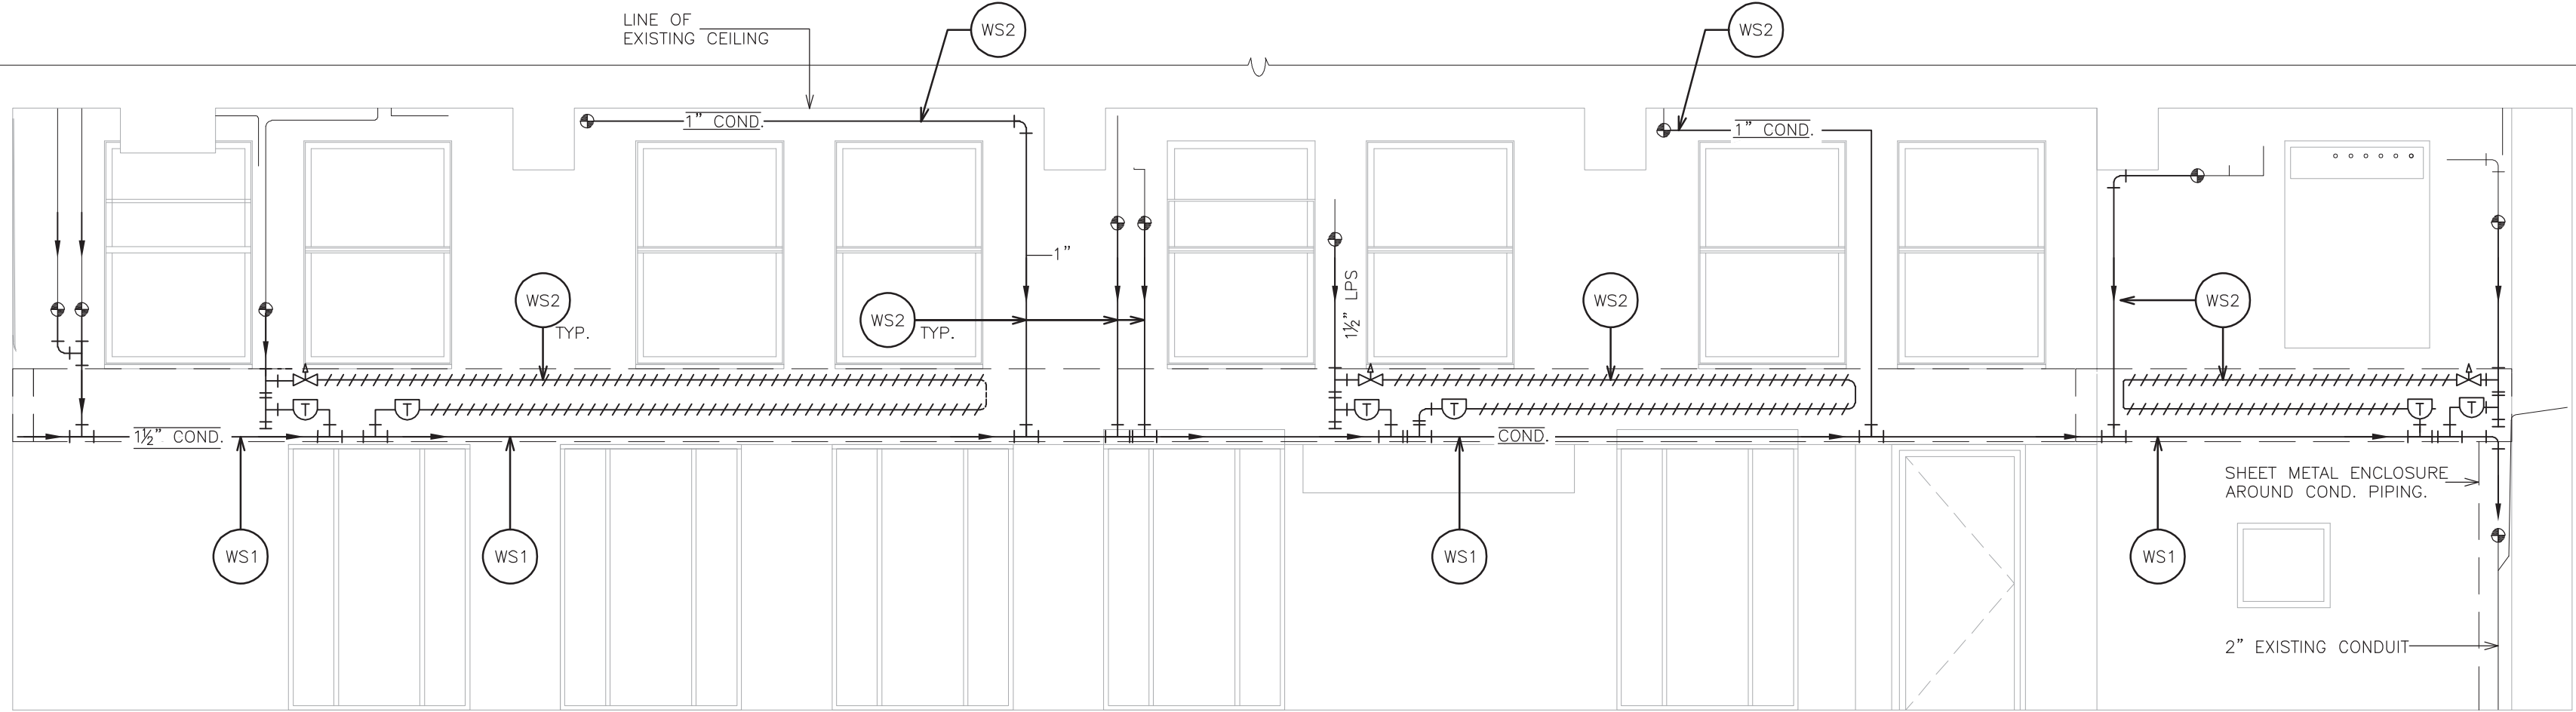


NEW INTERIOR ELEVATION
NORTH - GYM/CAFETERIA
3 SCALE: 1/4" = 1'-0"

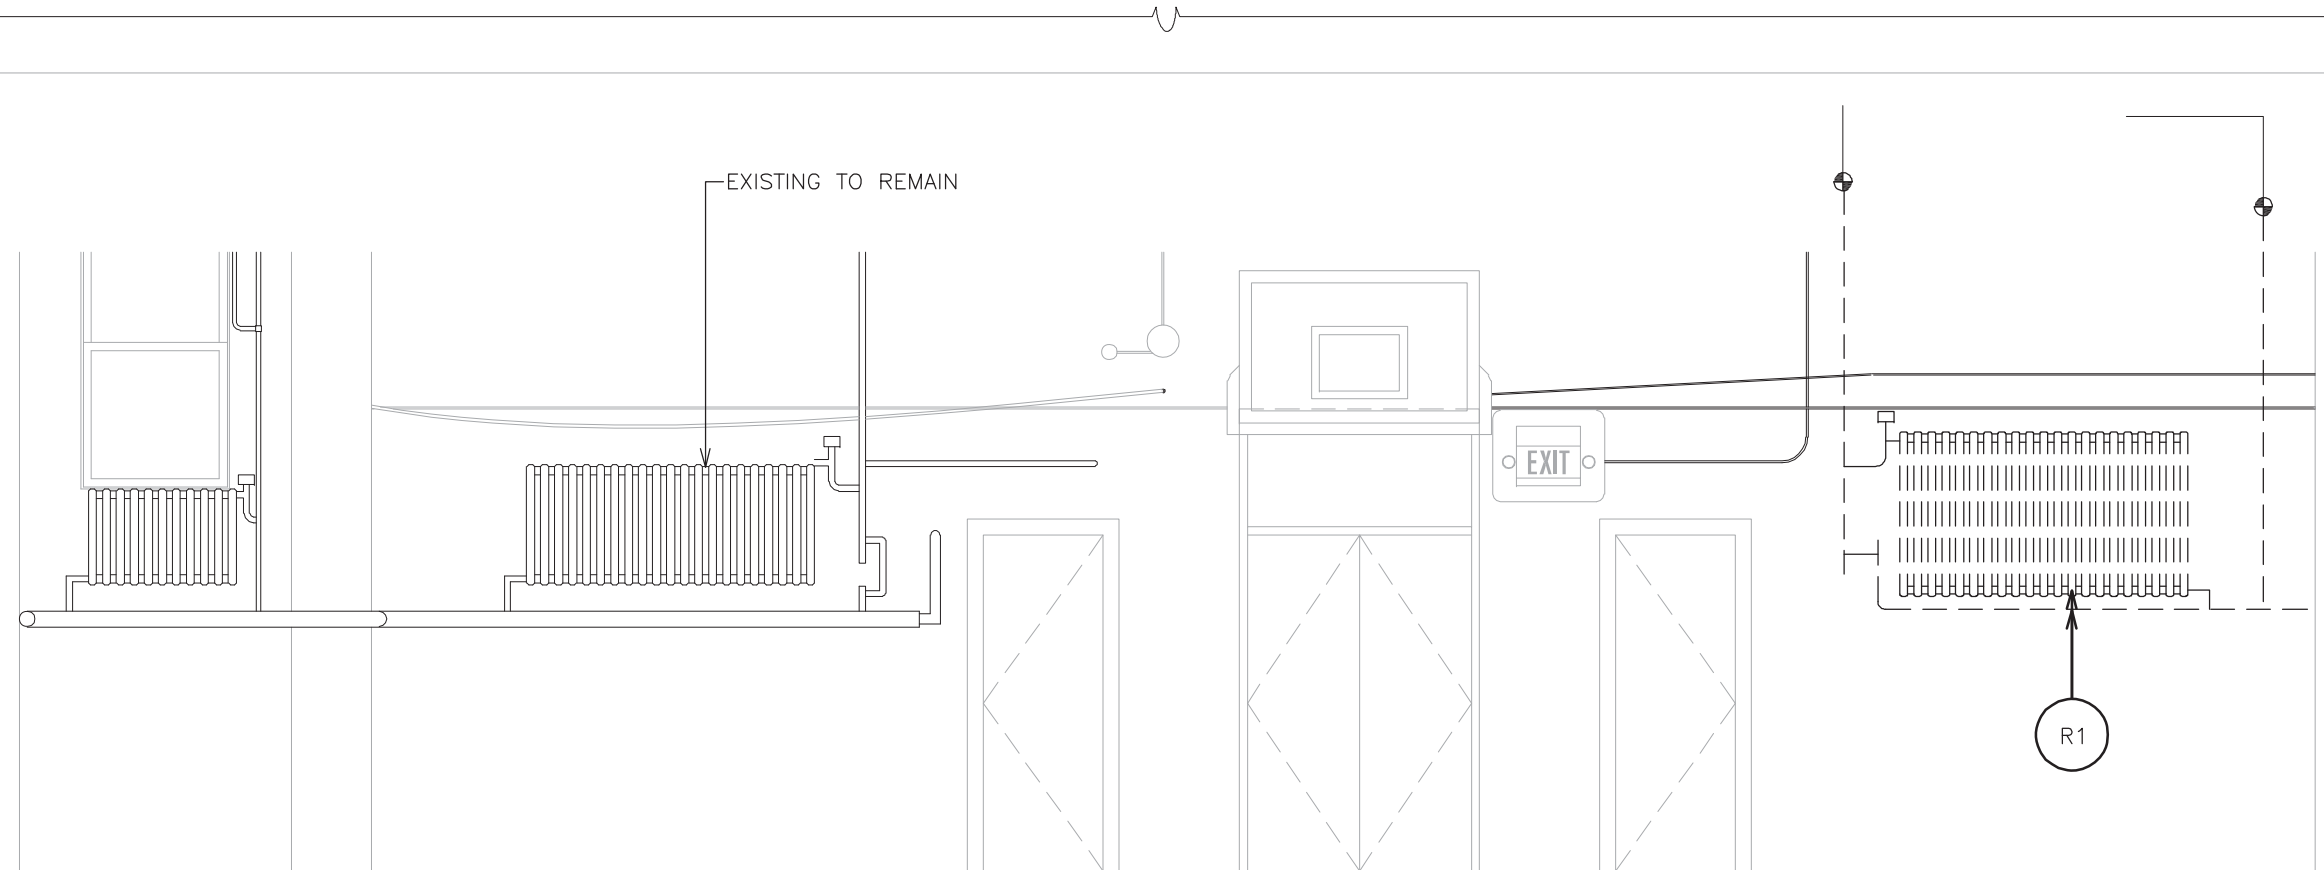


EXISTING INTERIOR ELEVATION
WEST - GYM/CAFETERIA
4 SCALE: 1/4" = 1'-0"

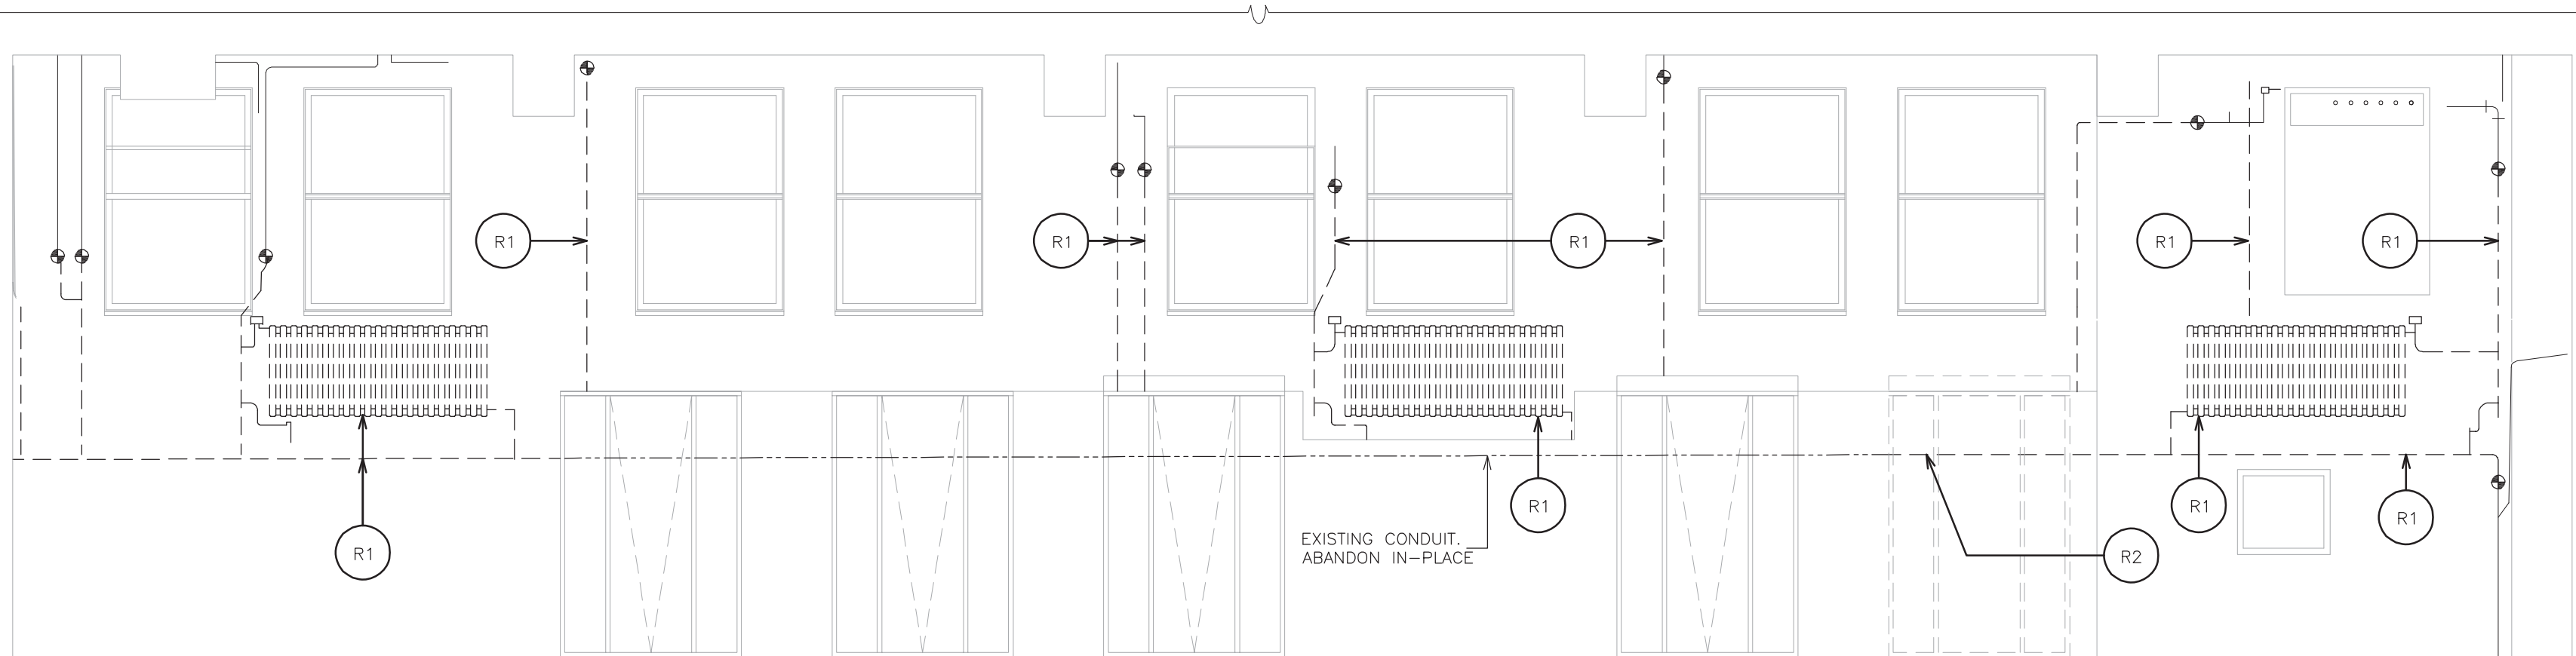


REMOVALS - INTERIOR ELEVATION
NORTH - GYM/CAFETERIA
2 SCALE: 1/4" = 1'-0"

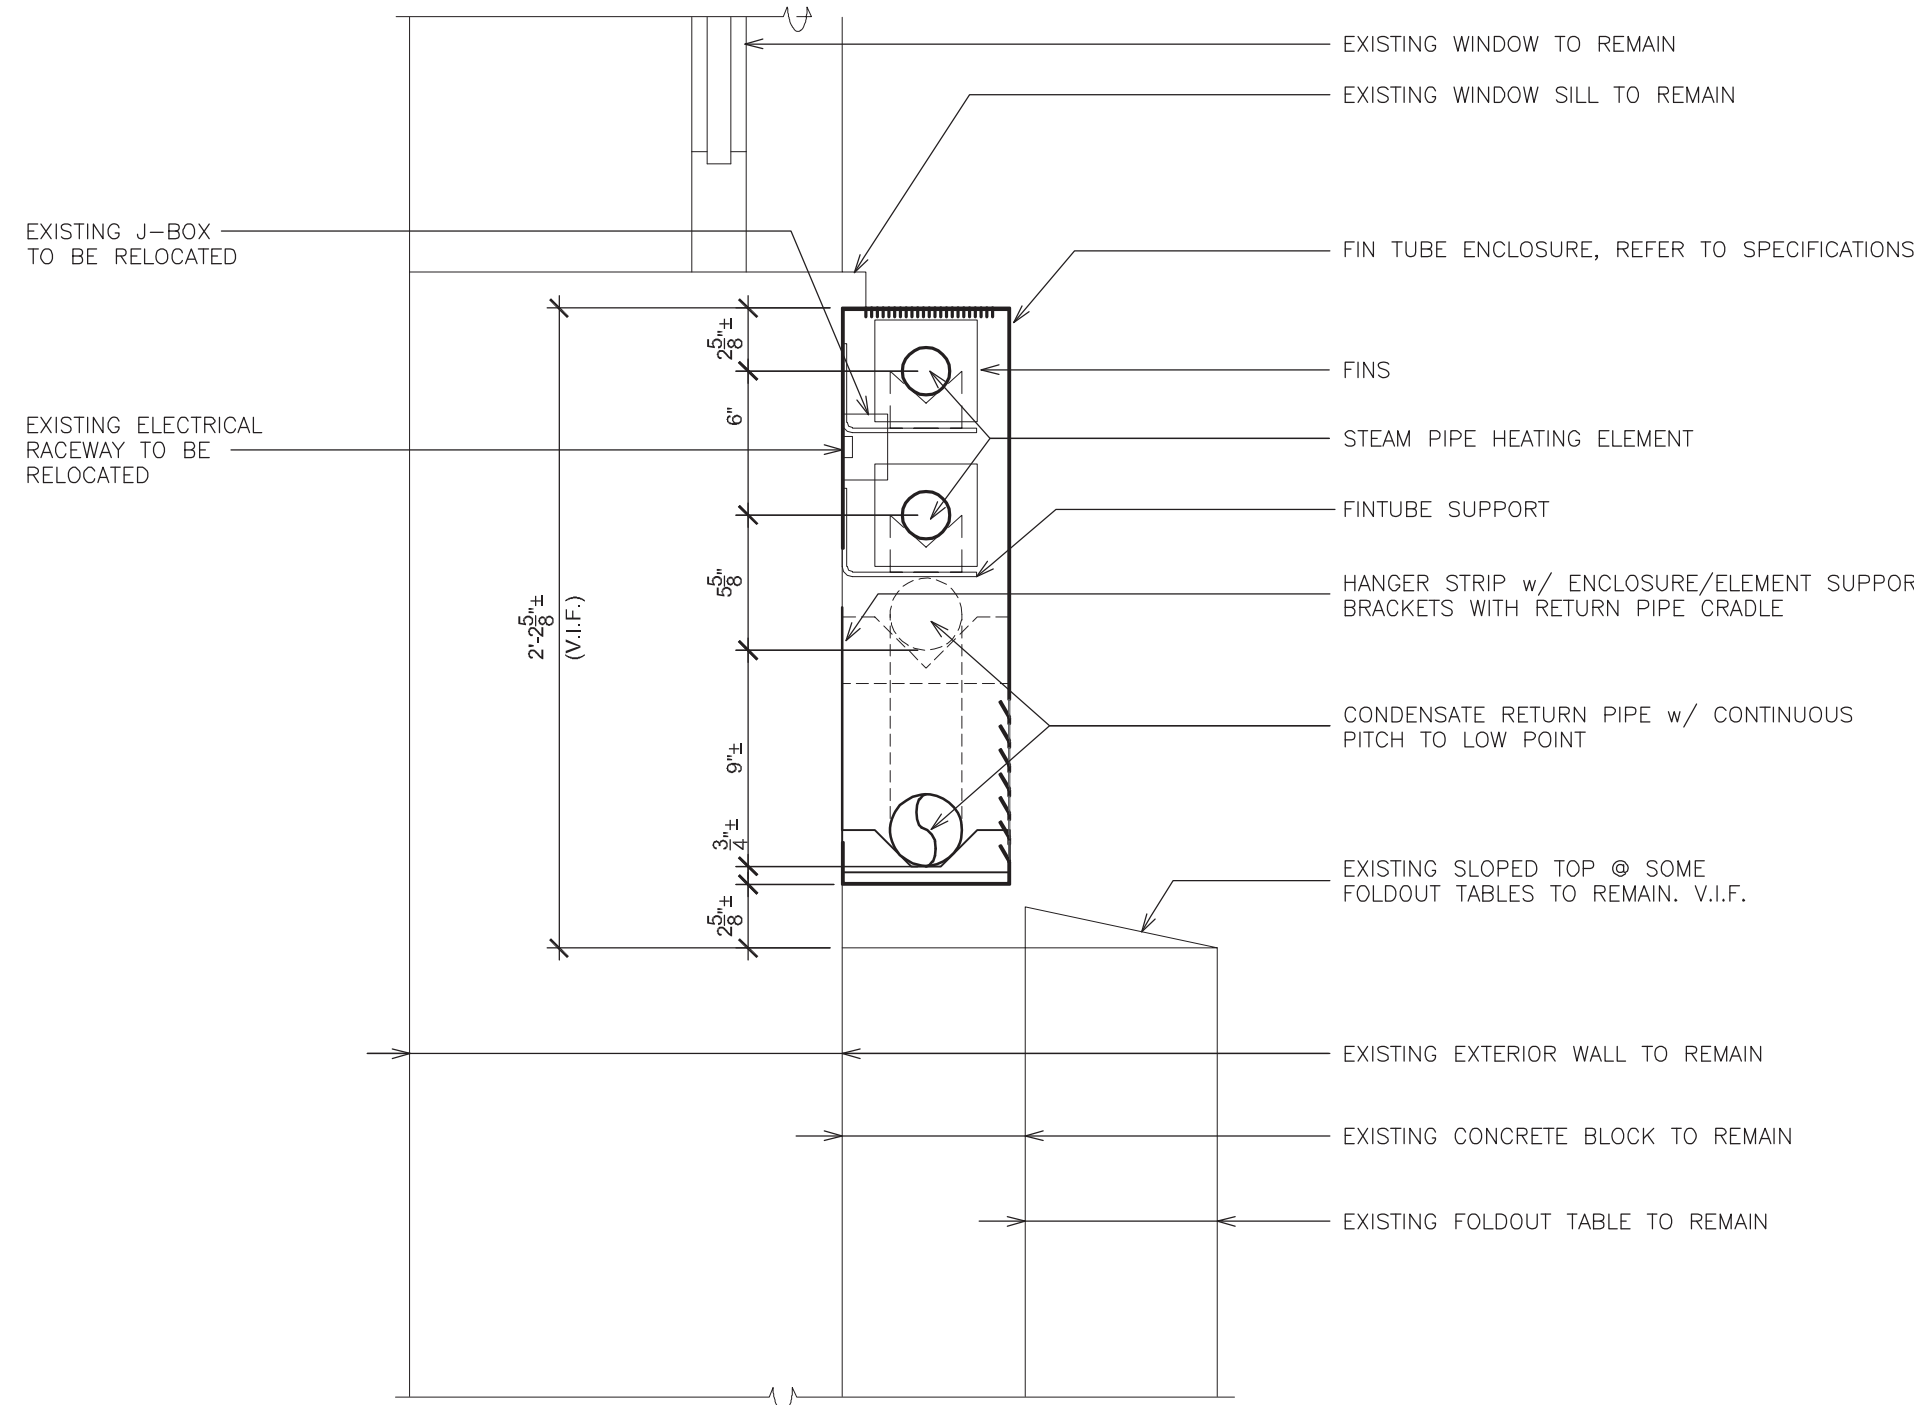


DETAIL -
FIN TUBE ENCLOSURE
6 SCALE: 1 1/2" = 1'-0"

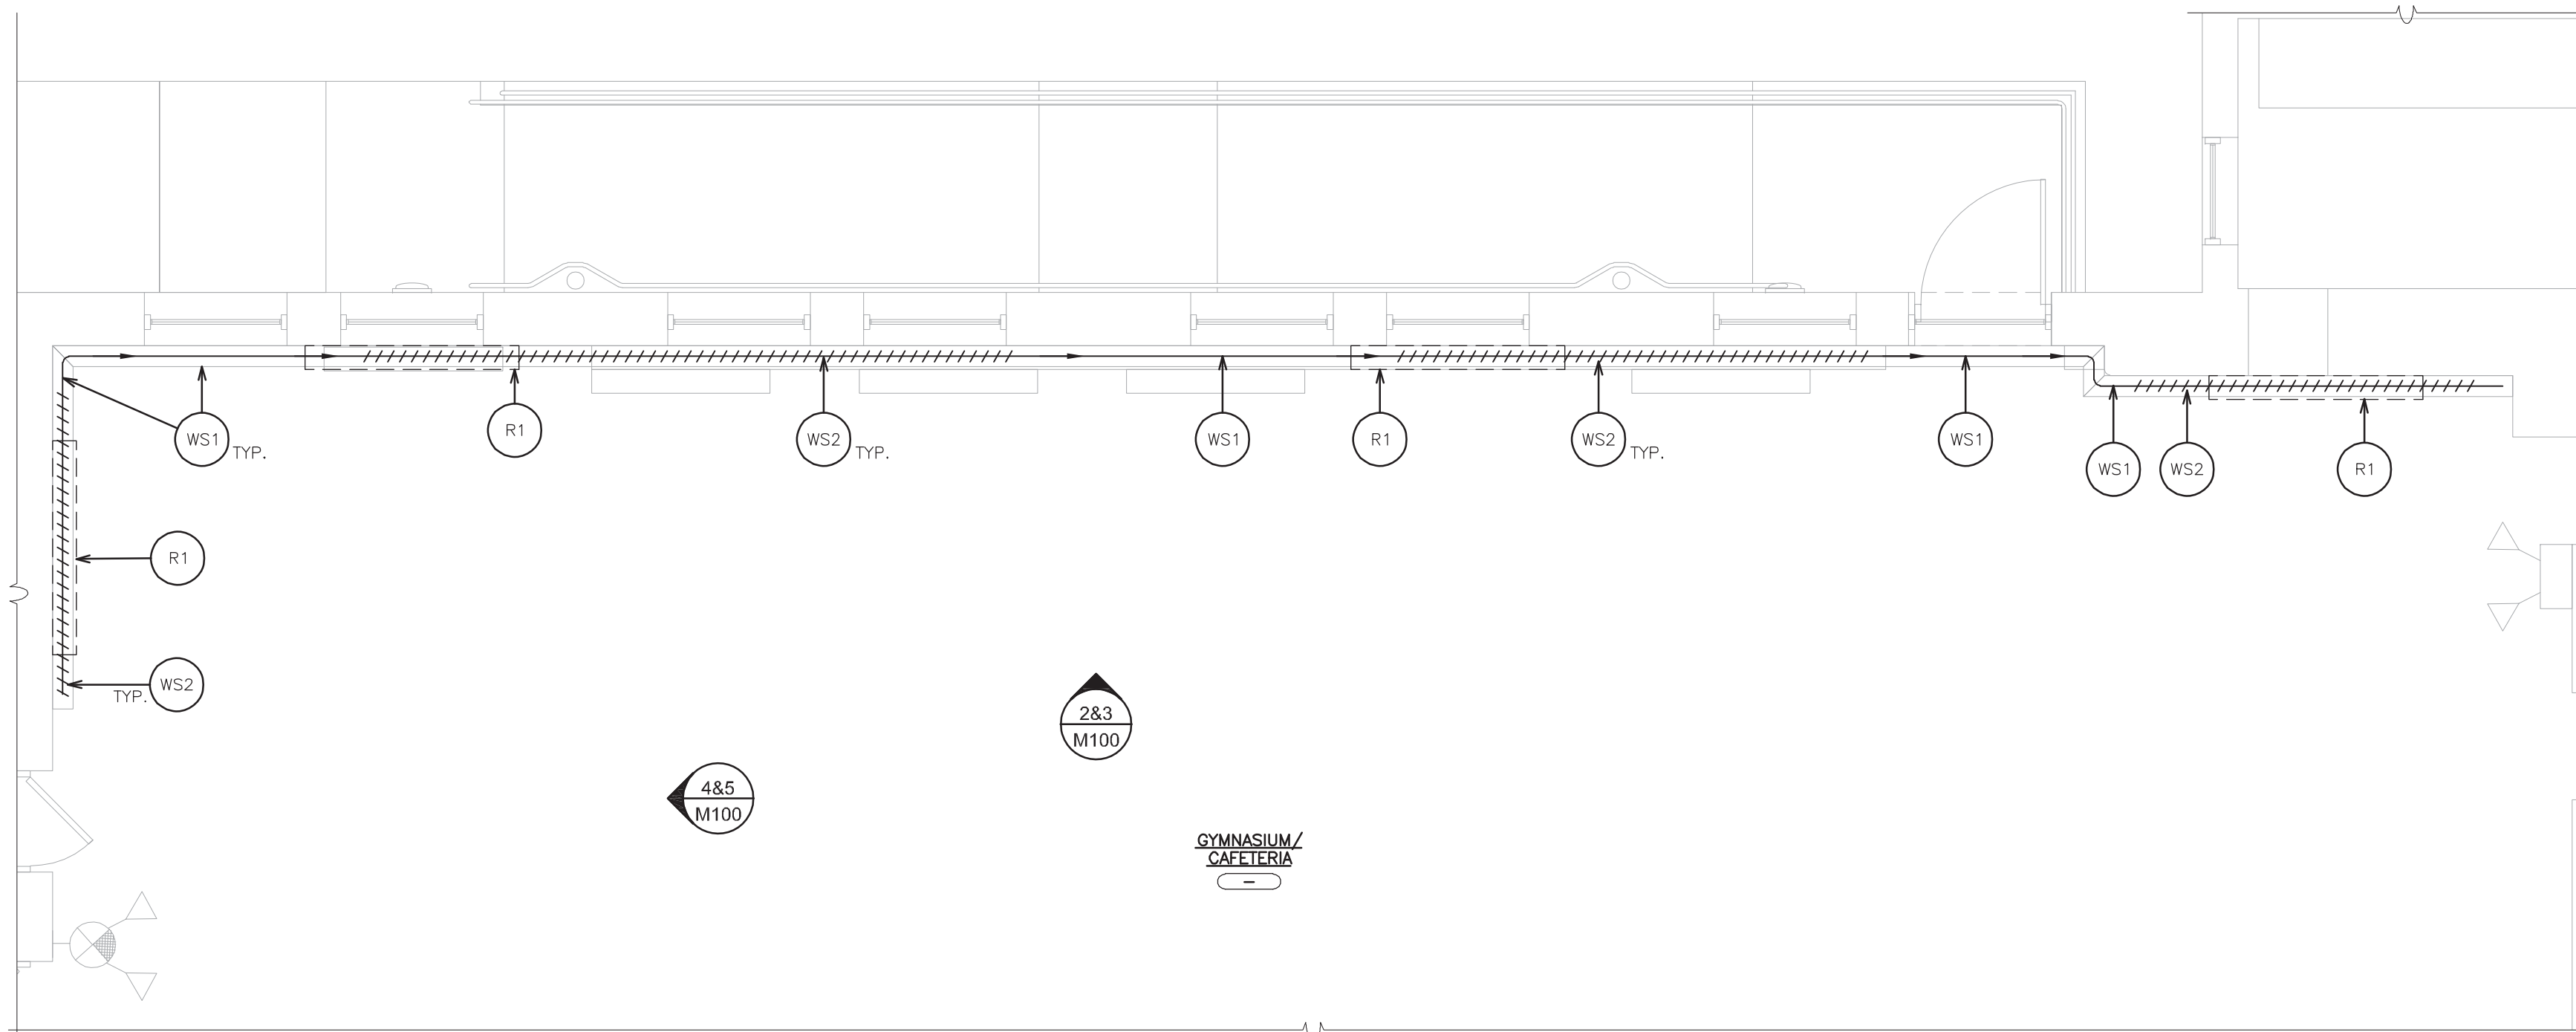

PARTIAL PLAN
GYM/CAFETERIA
1 SCALE: 1/4" = 1'-0"

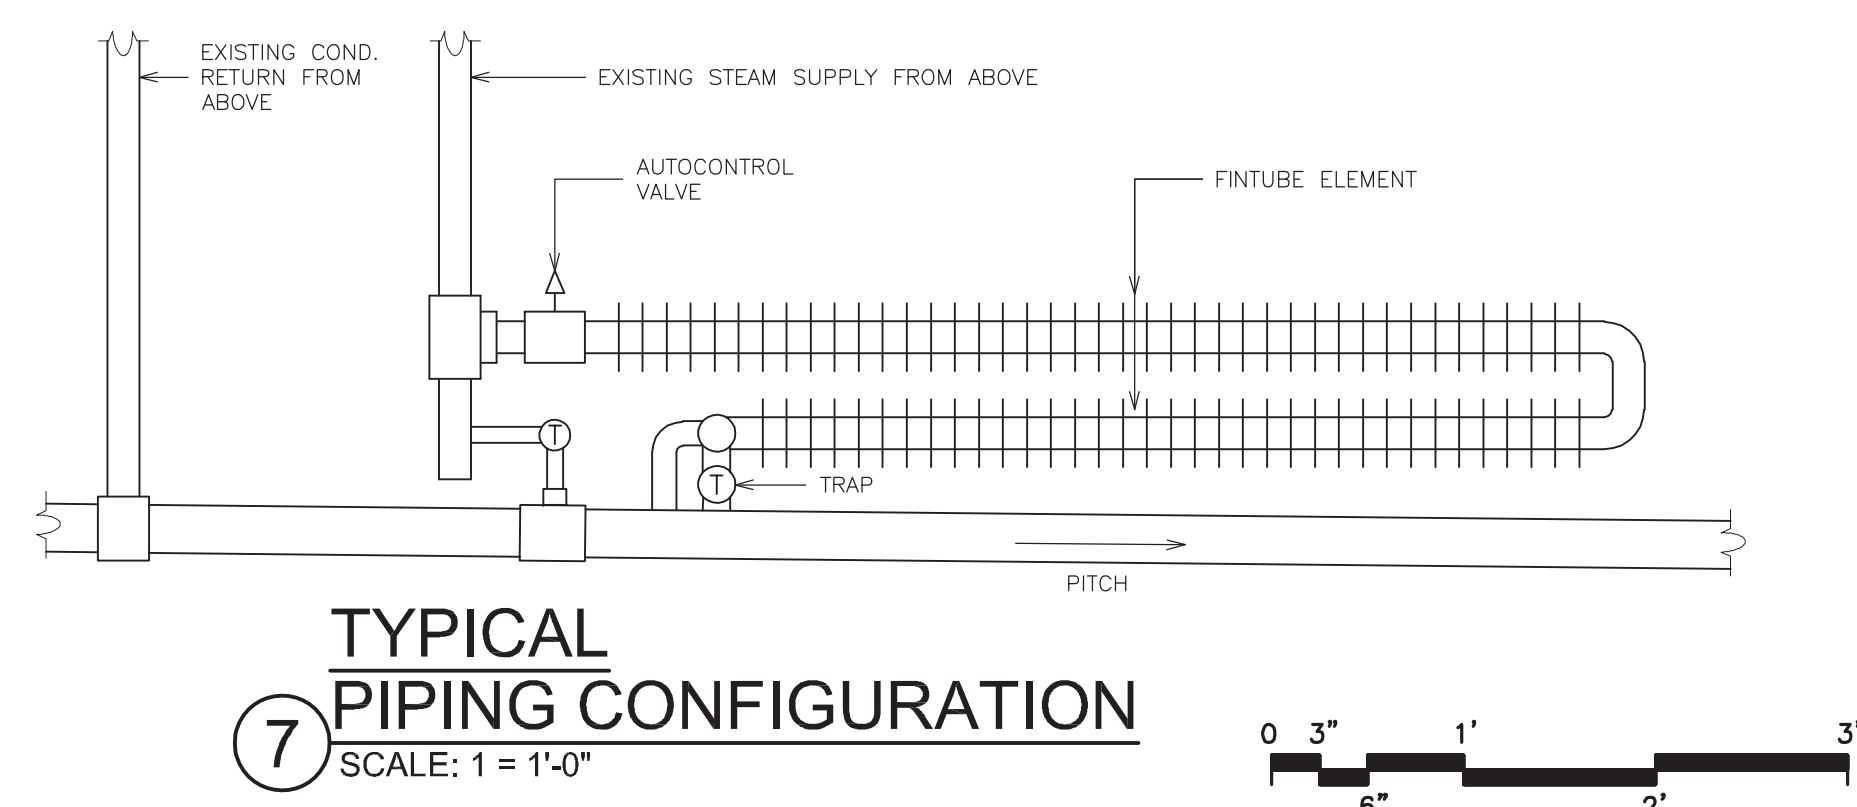

TYPICAL
PIPING CONFIGURATION
7 SCALE: 1 = 1'-0"

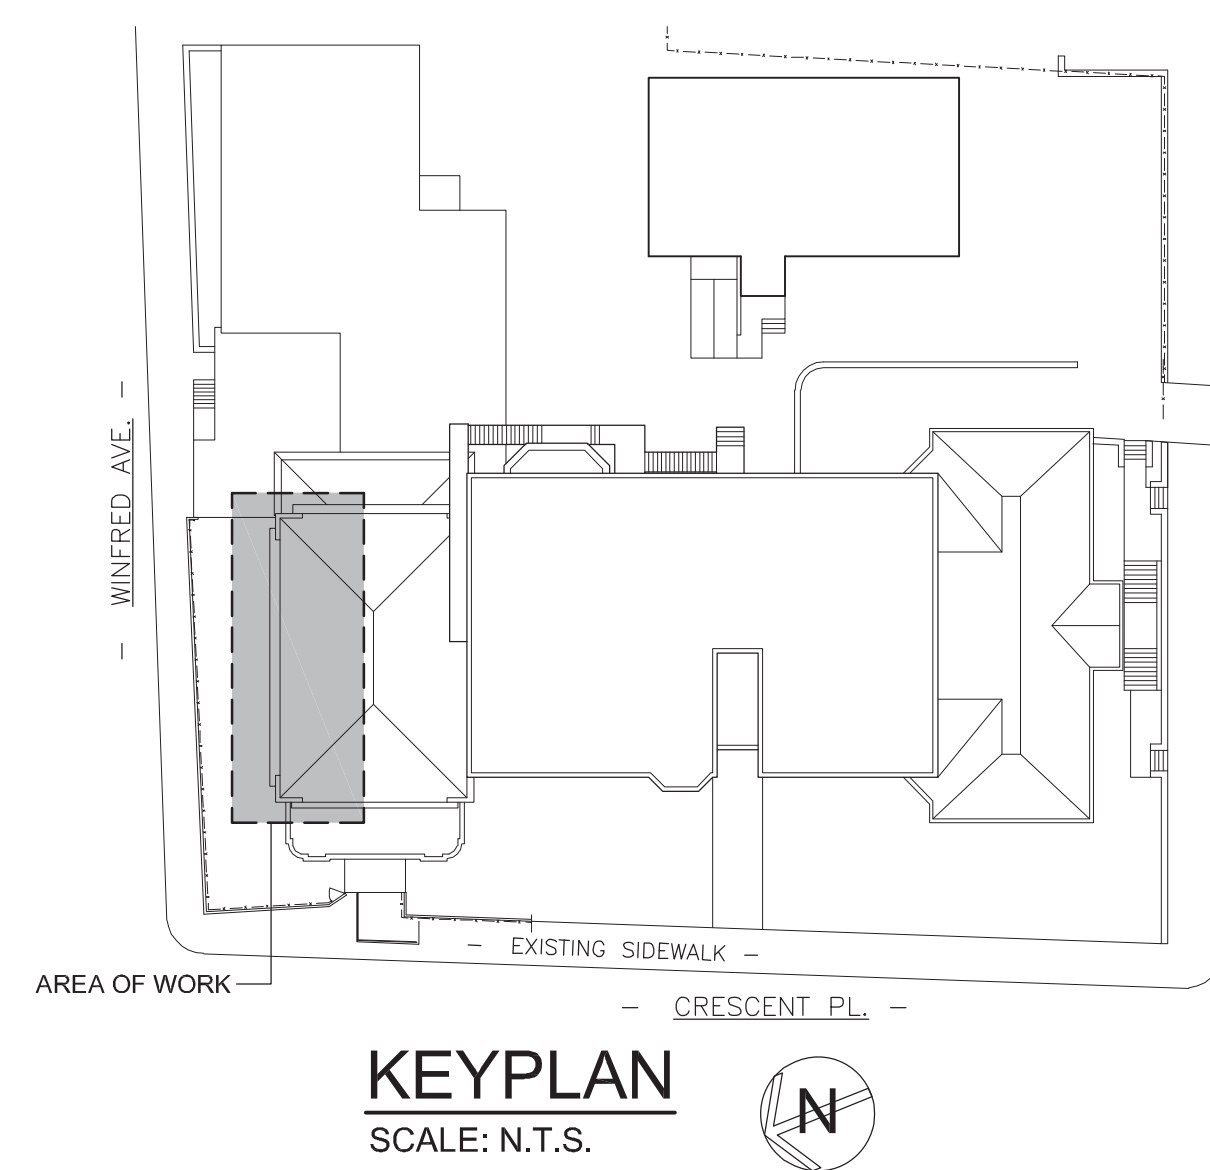

WORKSCOPE NOTES - KEYED

GYM INTERIOR

WS1 PROVIDE NEW CONDENSATE RETURN LINE, PITCHED 1/8" PER FOOT. MODIFY EXISTING CONDENSATE DROPS AS INDICATED & CONNECT TO RETURN LINE. REFER TO ELEVATIONS AND SPECIFICATIONS.

WS2 PROVIDE NEW FIN TUBE RADIATION AS INDICATED. PROVIDE NEW SUPPLY LINE, CONNECTED TO MAIN AT CEILING. REFER TO ELEVATIONS AND SPECIFICATIONS.

LEGEND

— POINT OF CONNECTION EXISTING TO NEW

— COND. — CONDUIT RETURN PIPING

— LPS — LOW PRESSURE STEAM SUPPLY

— GATE VALVE

— AUTO CONTROL VALVE

— THERMOSTATIC TRAP

———— FIN-TUBE ELEMENT

REMOVAL NOTE - KEYED

GYM INTERIOR

R1 REMOVE EXISTING CAST IRON RADIATION UNIT, ALL ASSOCIATED PIPING, BRACKETS, SUPPORTS AND ASSOCIATED PNEUMATIC CONTROL LINE. CUT, DRAIN AND TEMPORARILY CAP EXISTING CONDENSATE DRAINS TO REMAIN.

REMOVE EXPOSED PIPING - REMOVE BRANCH SUPPLY LINE BACK TO MAIN LOCATED AT CEILING, CAP & SEAL CLOSED. REMOVE CONDENSATE /RETURN TO CMU, CAP & SEAL END OF CONDENSATE LINE THAT IS TO BE ABANDONED IN PLACE, CONCEALED BEHIND CMU. REMOVE PNEUMATIC CONTROL LINES BACK TO NEAREST JUNCTION /CONTROL, CAP AND SEAL. PATCH & SEAL ALL HOLES IN AREAS OF WORK AND FINISH TO MATCH EXISTING ADJACENT SURFACES.

R2 REMOVE SECTION OF CONDENSATE PIPE EXPOSED WHEN CMU IS REMOVED TO INSTALL NEW DOOR. CAP & SEAL END OF PIPE ABANDONED IN PLACE BEHIND CMU.

AS PER USA CONGRESS ARCHITECTURAL WORKS COPYRIGHT PROTECTION ACT OF 1990 ALL IDEAS AND DESIGNS INCLUDING DERIVATIVES THEREOF, ALL DRAWINGS AND SPECIFICATIONS CONSTITUTE THE ORIGINAL COPYRIGHT WORK BY FULLER AND DANIELO, P.C. (F&D). THE DRAWINGS AND SPECIFICATIONS AS INSTRUMENTS OF SERVICE BY F&D ARE CREATED BY F&D FOR THIS PROJECT ONLY AND REMAIN THE PROPERTY OF F&D. ANY REPRODUCTION WITHOUT THE PRIOR CONSENT OF F&D IS PROHIBITED.

48 KNOLLWOOD ROAD ELMSFORD NEW YORK 10523
TEL 914.899.4444 FAX 914.899.1717
Copyright 2021 All Rights Reserved by FULLER & DANIELO P.C.

FULLER
DANIELO
P.C.
ARCHITECTS
PLANNERS

S.E.D. CONTROL NUMBER:
66-23-05-01-0-014-011

YPS JOB #: 10882

PROJECT TITLE
YONKERS SCHOOL DISTRICT
PS 14 ROSEMARY ANN BRAGUSA
IMPROVEMENTS
60 CRESCENT PLACE, YONKERS, NY 10704

DRAWING TITLE
MECHANICAL PLANS AND
ELEVATIONS

01-29-2021	BID SET
10-26-2020	S.E.D.
05-29-2020	REVIEW SET
01-03-2020	REVIEW
DATE	ISSUED TO

SHEET SIZE 30"x42"	DRAWING NO.
SCALE AS NOTED	M100
DRAWN BY F & D	FILE NO. 19366.00