


1 THIRD FLOOR PLAN - NEW WORK
SCALE: 1/8"=1'-0"

MECHANICAL CONTRACTOR TO ADJUST AAD-1 TO OUTSIDE AIR 200-2560 CFM. AAD AND AAD2 WILL BE ADJUSTED FOR 5000 CFM

NOTES:
1 - EXISTING EXHAUST FAN EF-5 TO REMAIN IN SAME LOCATION AND REUSE AAD-2 AND CONTROLS AS REQUIRED

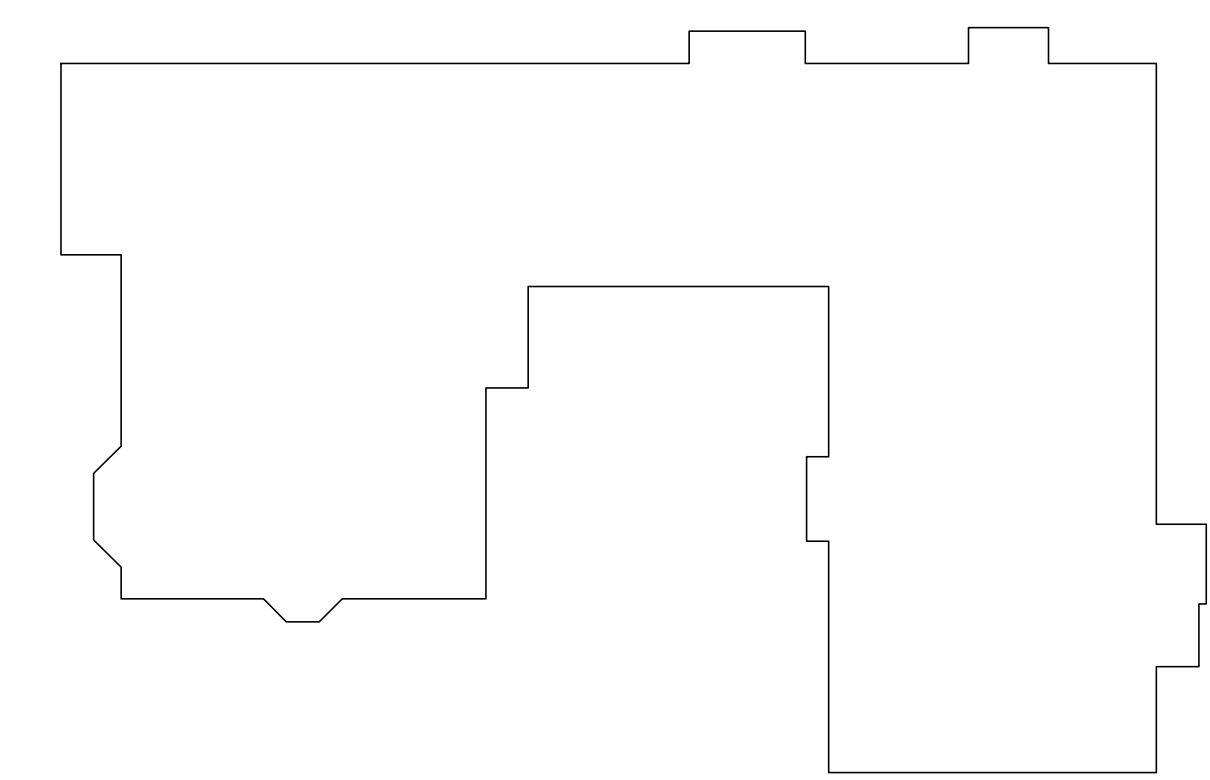


KEY-PLAN
SCALE: NONE

IT IS A VIOLATION OF THE LAW FOR ANY PERSON UNLESS HE IS ACTUALLY UNDER THE SUPERVISION OF A LICENSED PROFESSIONAL ARCHITECT/ENGINEER TO ALTER THIS DRAWING IN ANY WAY. A PERSON MUST HAVE THE SEAL ATTACHED ALONG WITH A DESCRIPTION OF THE ALTERATION, THE SIGNATURE AND DATE. COPYRIGHT © 2017

ENGINEER:

 Eisenbach & Ruhke Engineering, P.C.
 291 Corporate Street - Union, NY 13501
 (518) 532-2000 FAX: (518) 532-2002
 www.ereeng.com

CONSULTANT(S):

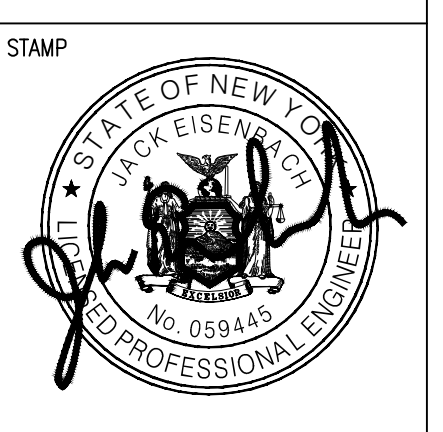

**YONKERS PUBLIC SCHOOLS
BUILDING RENOVATIONS AND
SITEWORK AT
SCHOOL 9**
53 FAIRVIEW STREET, YONKERS N.Y. 10703
S.E.D.# 69-25-00-01-0-009-009

E&R PROJECT NO.	Y170901
YPS NO.	10816

ADDENDUM	NO.	DATE	BY
REVISION	1	1.4.2021	JMJ
ISSUED FOR BID		10.20.2020	
DRWN BY		JMJ	
CHECKED BY		JJE	
SHEET SIZE	ARCH E1 30" x 42"		
SCALE	AS NOTED		

SHEET TITLE
THIRD FLOOR PLAN - NEW WORK

SHEET NO.

M-101

FILE PATH -- N:\1 - PROJECT DIRECTORIES\Yonkers Public Schools\School 9\Y170901 - Boiler System Replacement YPS 10816 (Additional)_Work\Y170901.m01.dwg