



BALCONY LIGHTING PLAN (NEW WORK) **E201**

AUDITORIUM DIMMING SCHEDULE
LIGHT DIMMER PANEL: LP

ZONE #	CIRCUIT #	AMP	LOCATION	LUMINAIRE TYPE	LOAD (VA)
1	PP-AUD-4	20	AUD-HOUSE-MAIN	LED	168
2	PP-AUD-4	20	AUD-HOUSE-MAIN	LED-EMERGENCY-RELAY UL924	100
3	PP-AUD-6	20	AUD-HOUSE-MAIN	LED	110
4	PP-AUD-6	20	AUD-HOUSE-MAIN	LED-EMERGENCY-RELAY UL924	400
5	PP-AUD-6	20	AUD-HOUSE-MAIN	LED	360
6	PP-AUD-4	20	AUD-HOUSE-MAIN	LED	364
7	PP-AUD-6	20	AUD-HOUSE-MAIN	LED-EMERGENCY-RELAY UL924	180
8	PP-AUD-10	20	AUD-HOUSE-BALC.	LED	48
9	PP-AUD-10	20	AUD-HOUSE-BALC.	LED	96
10	PP-AUD-10	20	AUD-HOUSE-BALC.	LED	756
11	PP-AUD-10	20	AUD-HOUSE-BALC.	LED-EMERGENCY-RELAY UL924	468
12	PP-AUD-16	20	SPARE	SPARE	3,050
TOTAL					3,050

AUDITORIUM DIMMING SCHEDULE (NO SCALE) **E201**

- WORK NOTES:**
- ① CIRCUIT NUMBERS FOR CONTRACTOR GUIDANCE ONLY. PROVIDE 2#12+1#12G IN 3/4" CONDUIT TO CIRCUIT MADE SPARE BY DEMO WORK.
 - ② EMERGENCY CIRCUIT NUMBER FOR CONTRACTOR GUIDANCE ONLY. PROVIDE 2#12+1#12G IN 3/4" CONDUIT TO NEARBY EMERGENCY LIGHTING CIRCUIT.
 - ③ WIRE NEW LIGHTING IN STAIRS TO EXISTING STAIR LIGHTING AND CONTROLS.

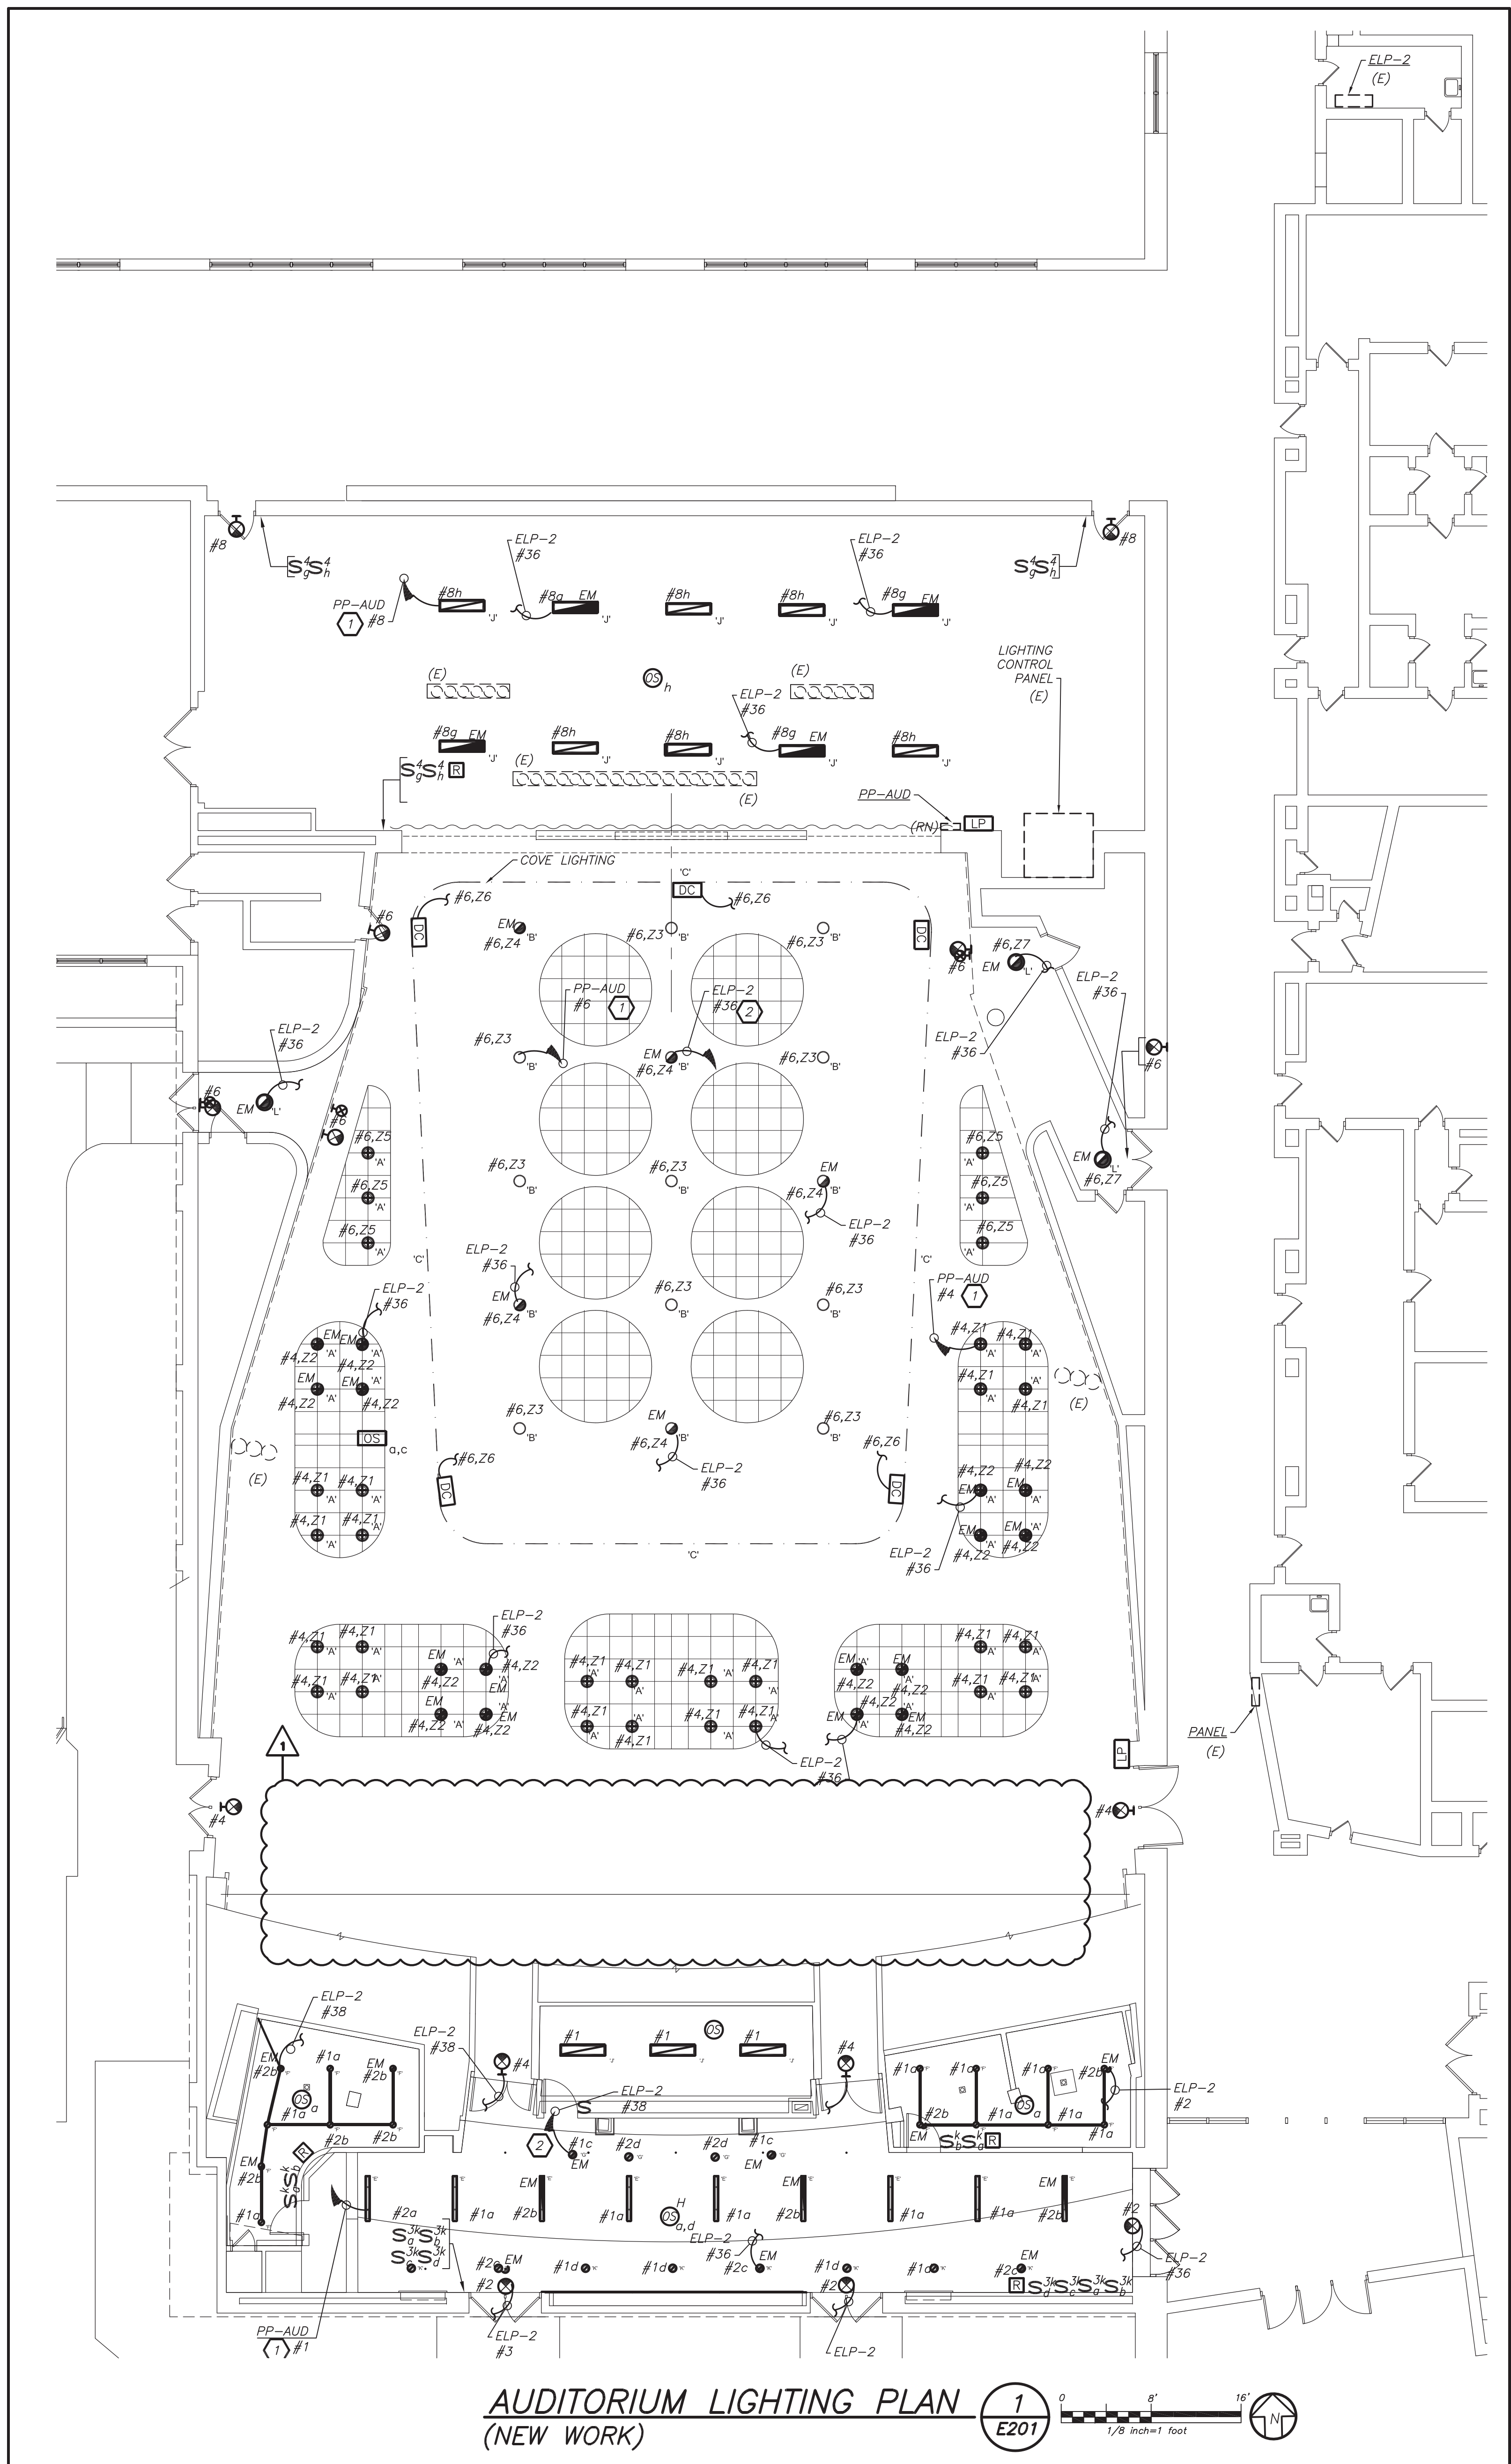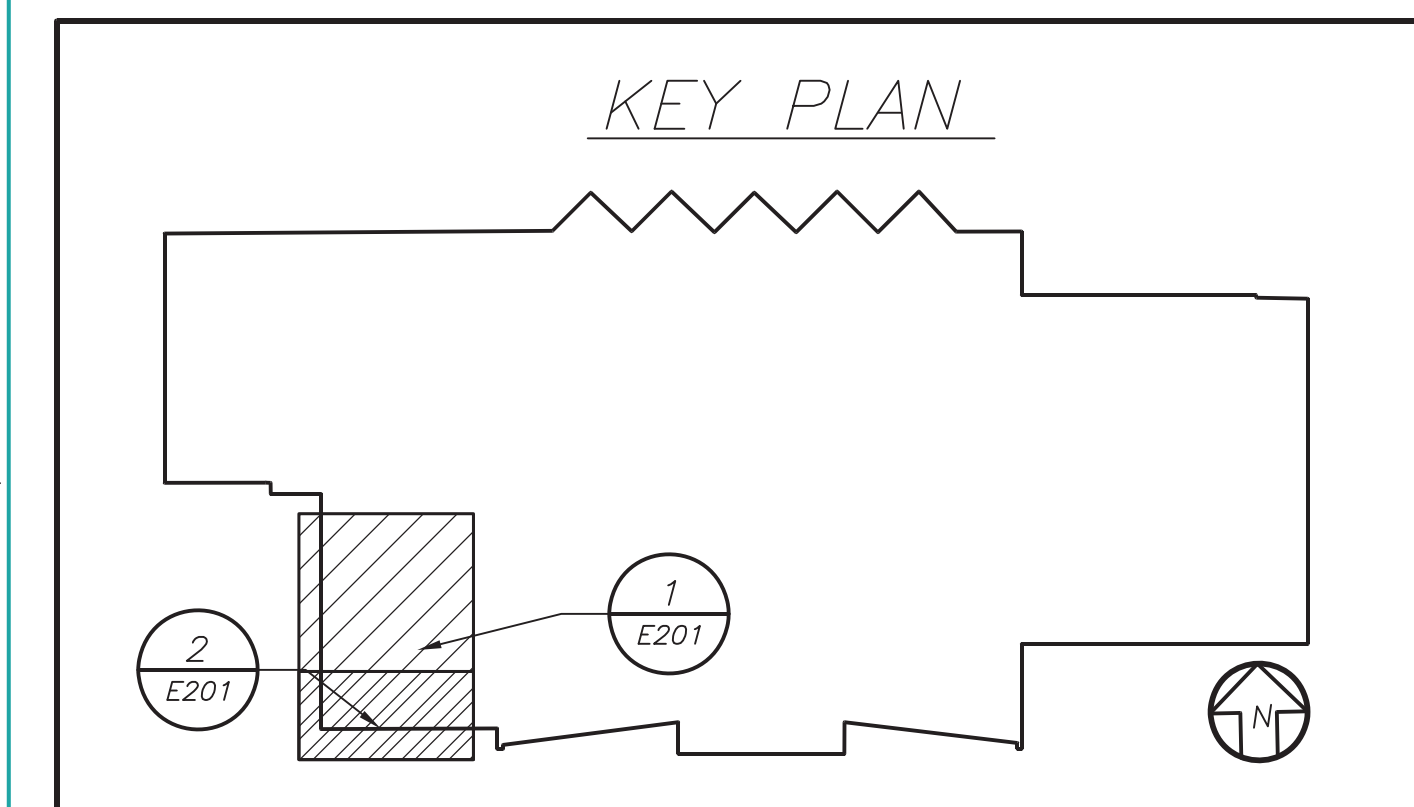

AUDITORIUM LIGHTING PLAN (NEW WORK) **E201**

AS PER USA CONGRESS ARCHITECTURAL WORKS COPYRIGHT PROTECTION ACT OF 1990 ALL IDEAS AND DESIGNS INCLUDING DERIVATIVES THEREOF, ALL DRAWINGS AND SPECIFICATIONS CONSTITUTE THE ORIGINAL COPYRIGHT WORK BY FULLER AND DANKELO, P.C. (F&D). THE DRAWINGS AND SPECIFICATIONS AS INSTRUMENTS OF SERVICE BY F&D ARE CREATED BY F&D FOR THIS PROJECT ONLY AND REMAIN THE PRODUCT AND PROPERTY OF F&D. ANY REPRODUCTION WITHOUT THE PRIOR CONSENT OF F&D IS PROHIBITED.

BARILE GALLAGHER & ASSOCIATES
CONSULTING ENGINEERS
30 MARBLE AVE. PLEASANTVILLE, NY 10570
914.326.6000 GENERAL@BGA-ENG.COM www.BGA-ENG.COM


FULLER DANKELO ARCHITECTS PLANNERS
48 KILLWOOD ROAD ELMSFORD NEW YORK 10523
TEL: 914.899.4444 FAX: 914.899.1917
Copyright © All Rights Reserved by FULLER & DANKELO

S.E.D. CONTROL NUMBER:
66-23-00-01-0-202-015

YPS JOB # 10873
YPS JOB # 10888


PROJECT TITLE:
YONKERS SCHOOL DISTRICT
LINCOLN HIGH SCHOOL & EXTERIOR
BLEACHER REPLACEMENT
375 NEELEND AVENUE, YONKERS, NY 10544
DRAWING TITLE:
SECOND FLOOR ELECTRICAL LIGHTING PLAN

03-19-2021	ADDENDUM #1
02-12-2021	BID
04-09-2020	PROGRESS DRAWINGS
01-24-2020	SCHEMATIC DESIGN
DATE	ISSUED TO
SHEET SIZE	DRAWING NO.
30"x42"	E201
SCALE	AS NOTED
DRAWN BY	FILE NO.
F & D	19356.00

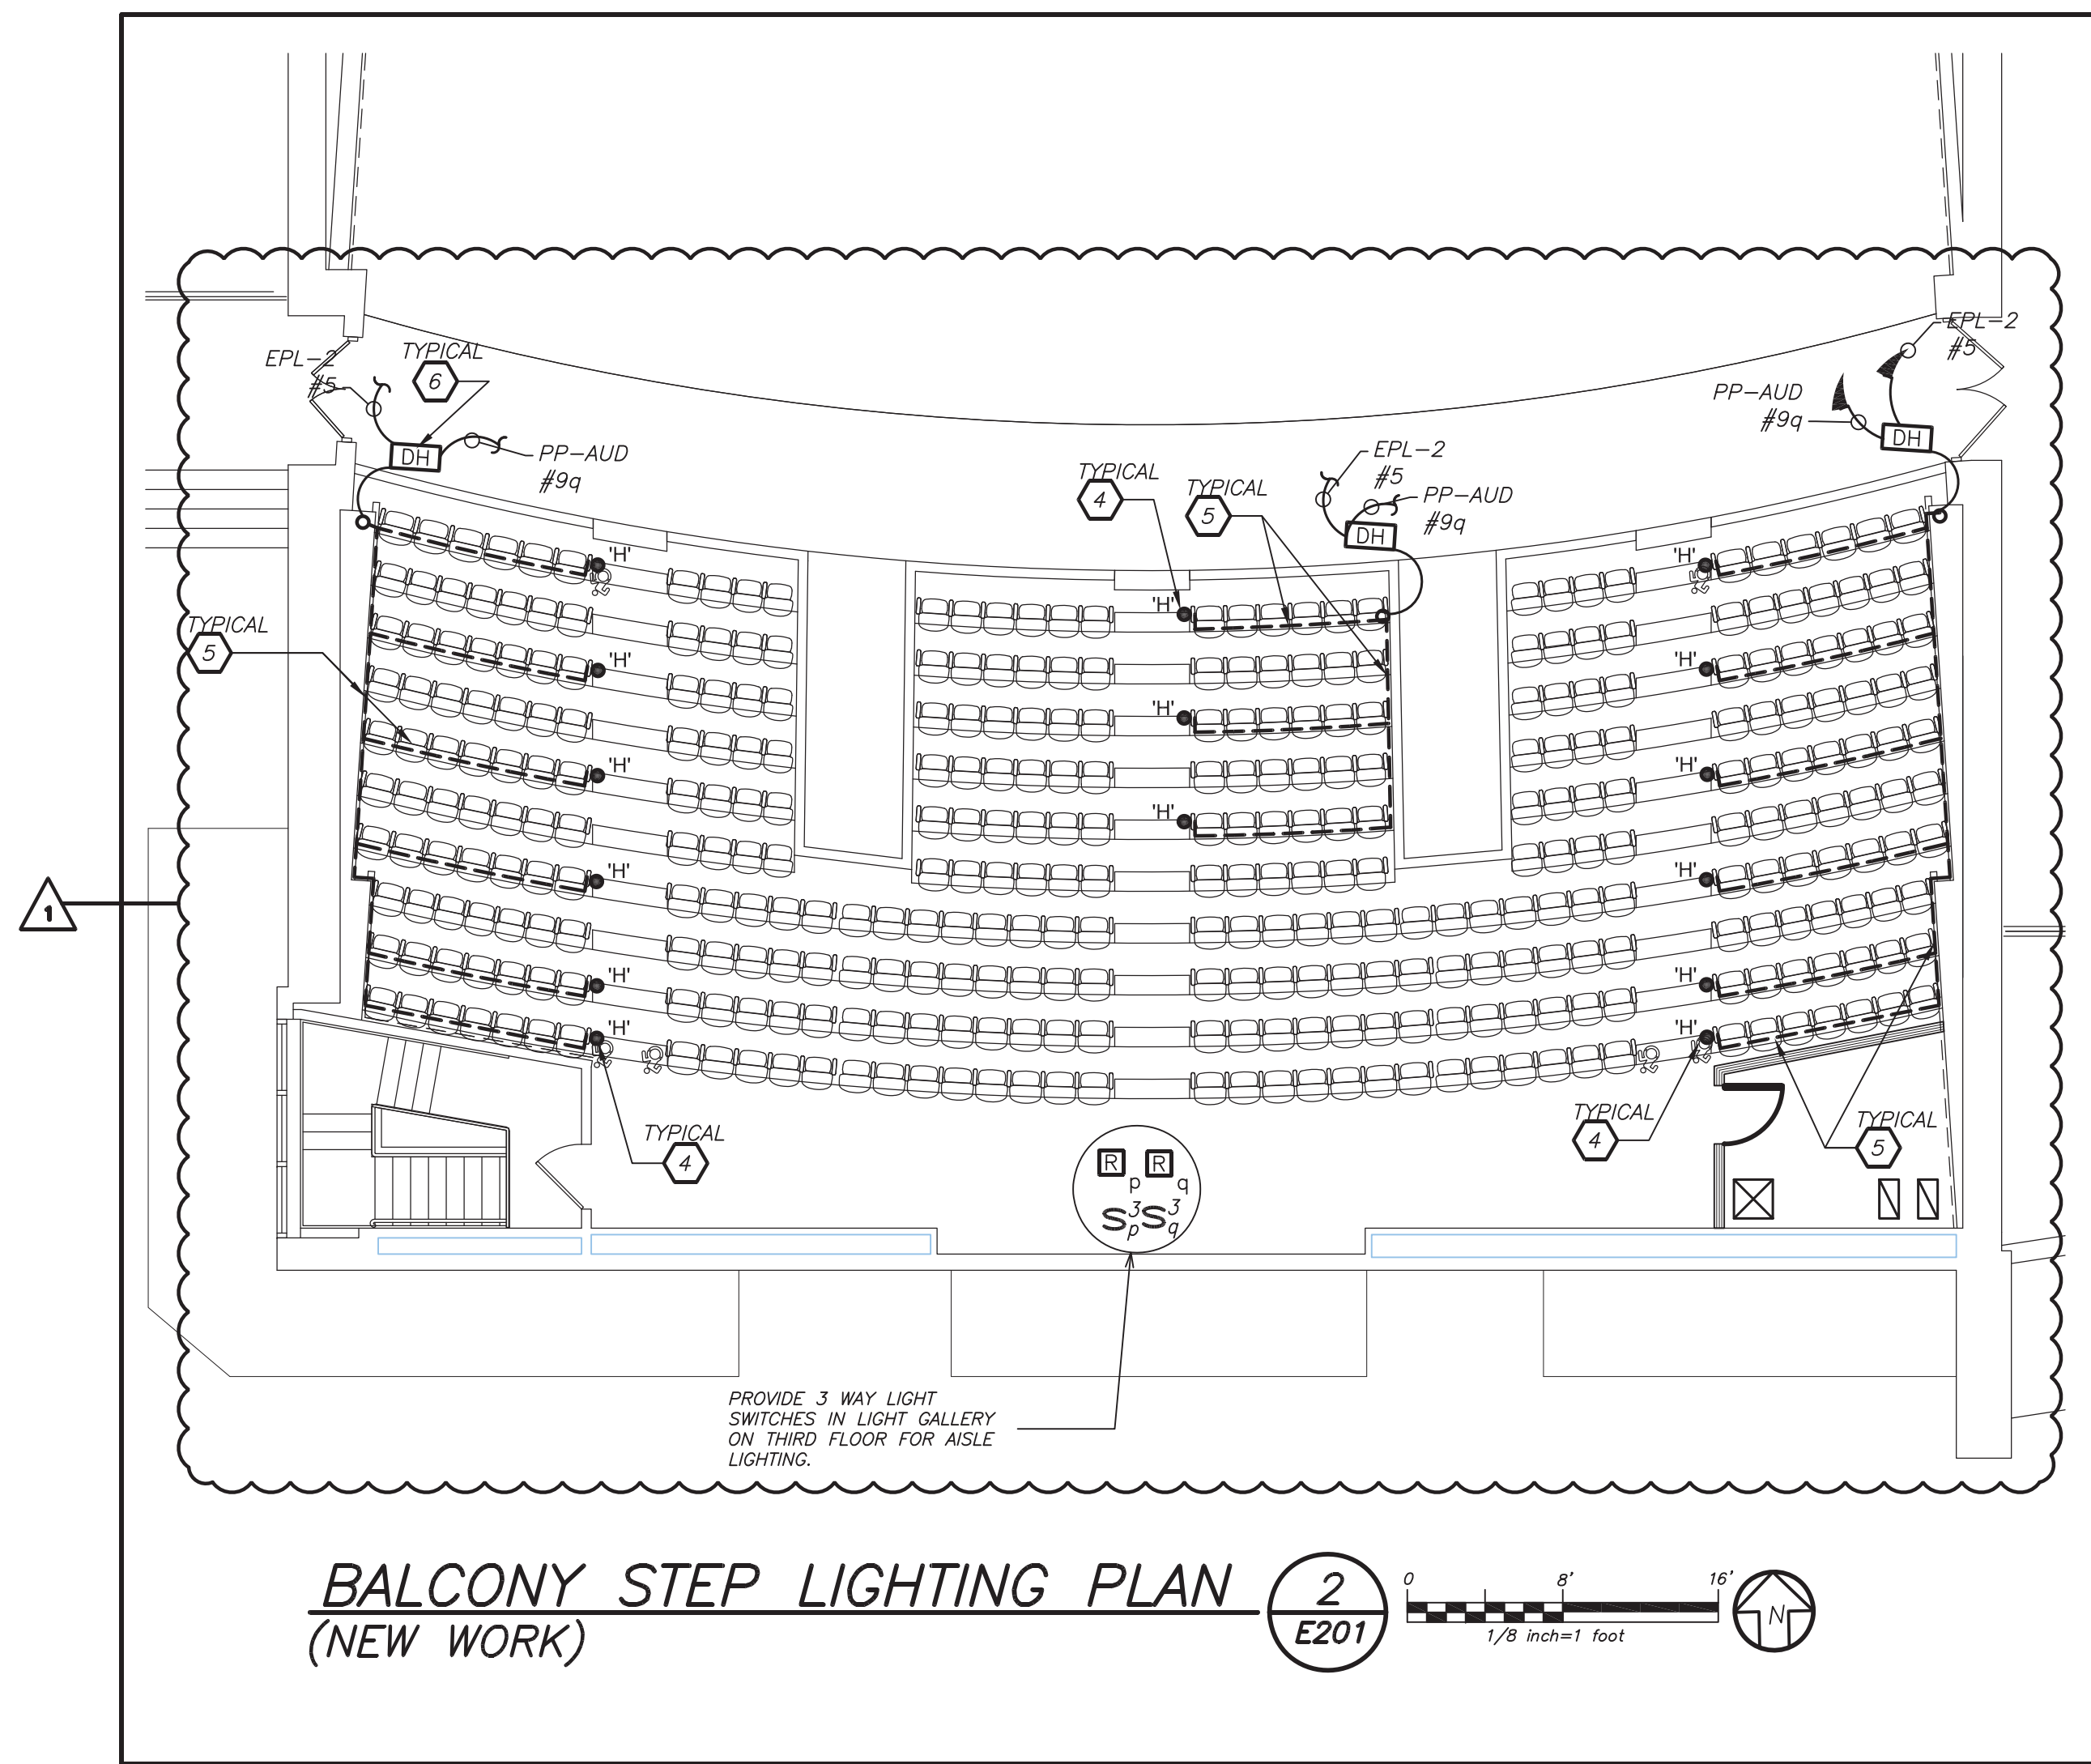



BALCONY STEP LIGHTING PLAN (NEW WORK) **2** E201

- WORK NOTES:**
- 1 CIRCUIT NUMBERS FOR CONTRACTOR GUIDANCE ONLY. PROVIDE 2#12+1#12G IN 3/4" CONDUIT TO CIRCUIT MADE SPARE BY DEMO WORK.
 - 2 NOT USED.
 - 3 NOT USED.
 - 4 AISLE LIGHTING AND 24" WHIP IS INTEGRAL PART OF AUDITORIUM SEAT BY OTHERS. FINAL CONNECTION, JUNCTION BOX, WIRING AND TRANSFORMER BY E-CONTRACTOR. COORDINATE WITH SEATING INSTALLER.
 - 5 PROVIDE WIREMOLD 1500 (BRANCHES) & 2600 (MAINS) PANCAKE OVER FLOOR RACEWAY. PROVIDE ALL TRANSITION, CONNECTORS, ELBOWS, ACCESSORIES, ETC. FOR COMPLETE AND MINIMAL WALKING SURFACE INTERFERENCE INSTALLATION.
 - 6 PROVIDE DRIVER AS SPECIFIED. REFER TO LEGEND AND LIGHTING FIXTURE SCHEDULE FOR MORE DETAIL. DRIVER SHALL BE LOCATED BELOW FLOOR SLAB IN CRAWL SPACE.
 - 7 PROVIDE POKE THRU FROM CRAWL SPACE BELOW. COORDINATE LOCATION WITH SEAT INSTALLER.

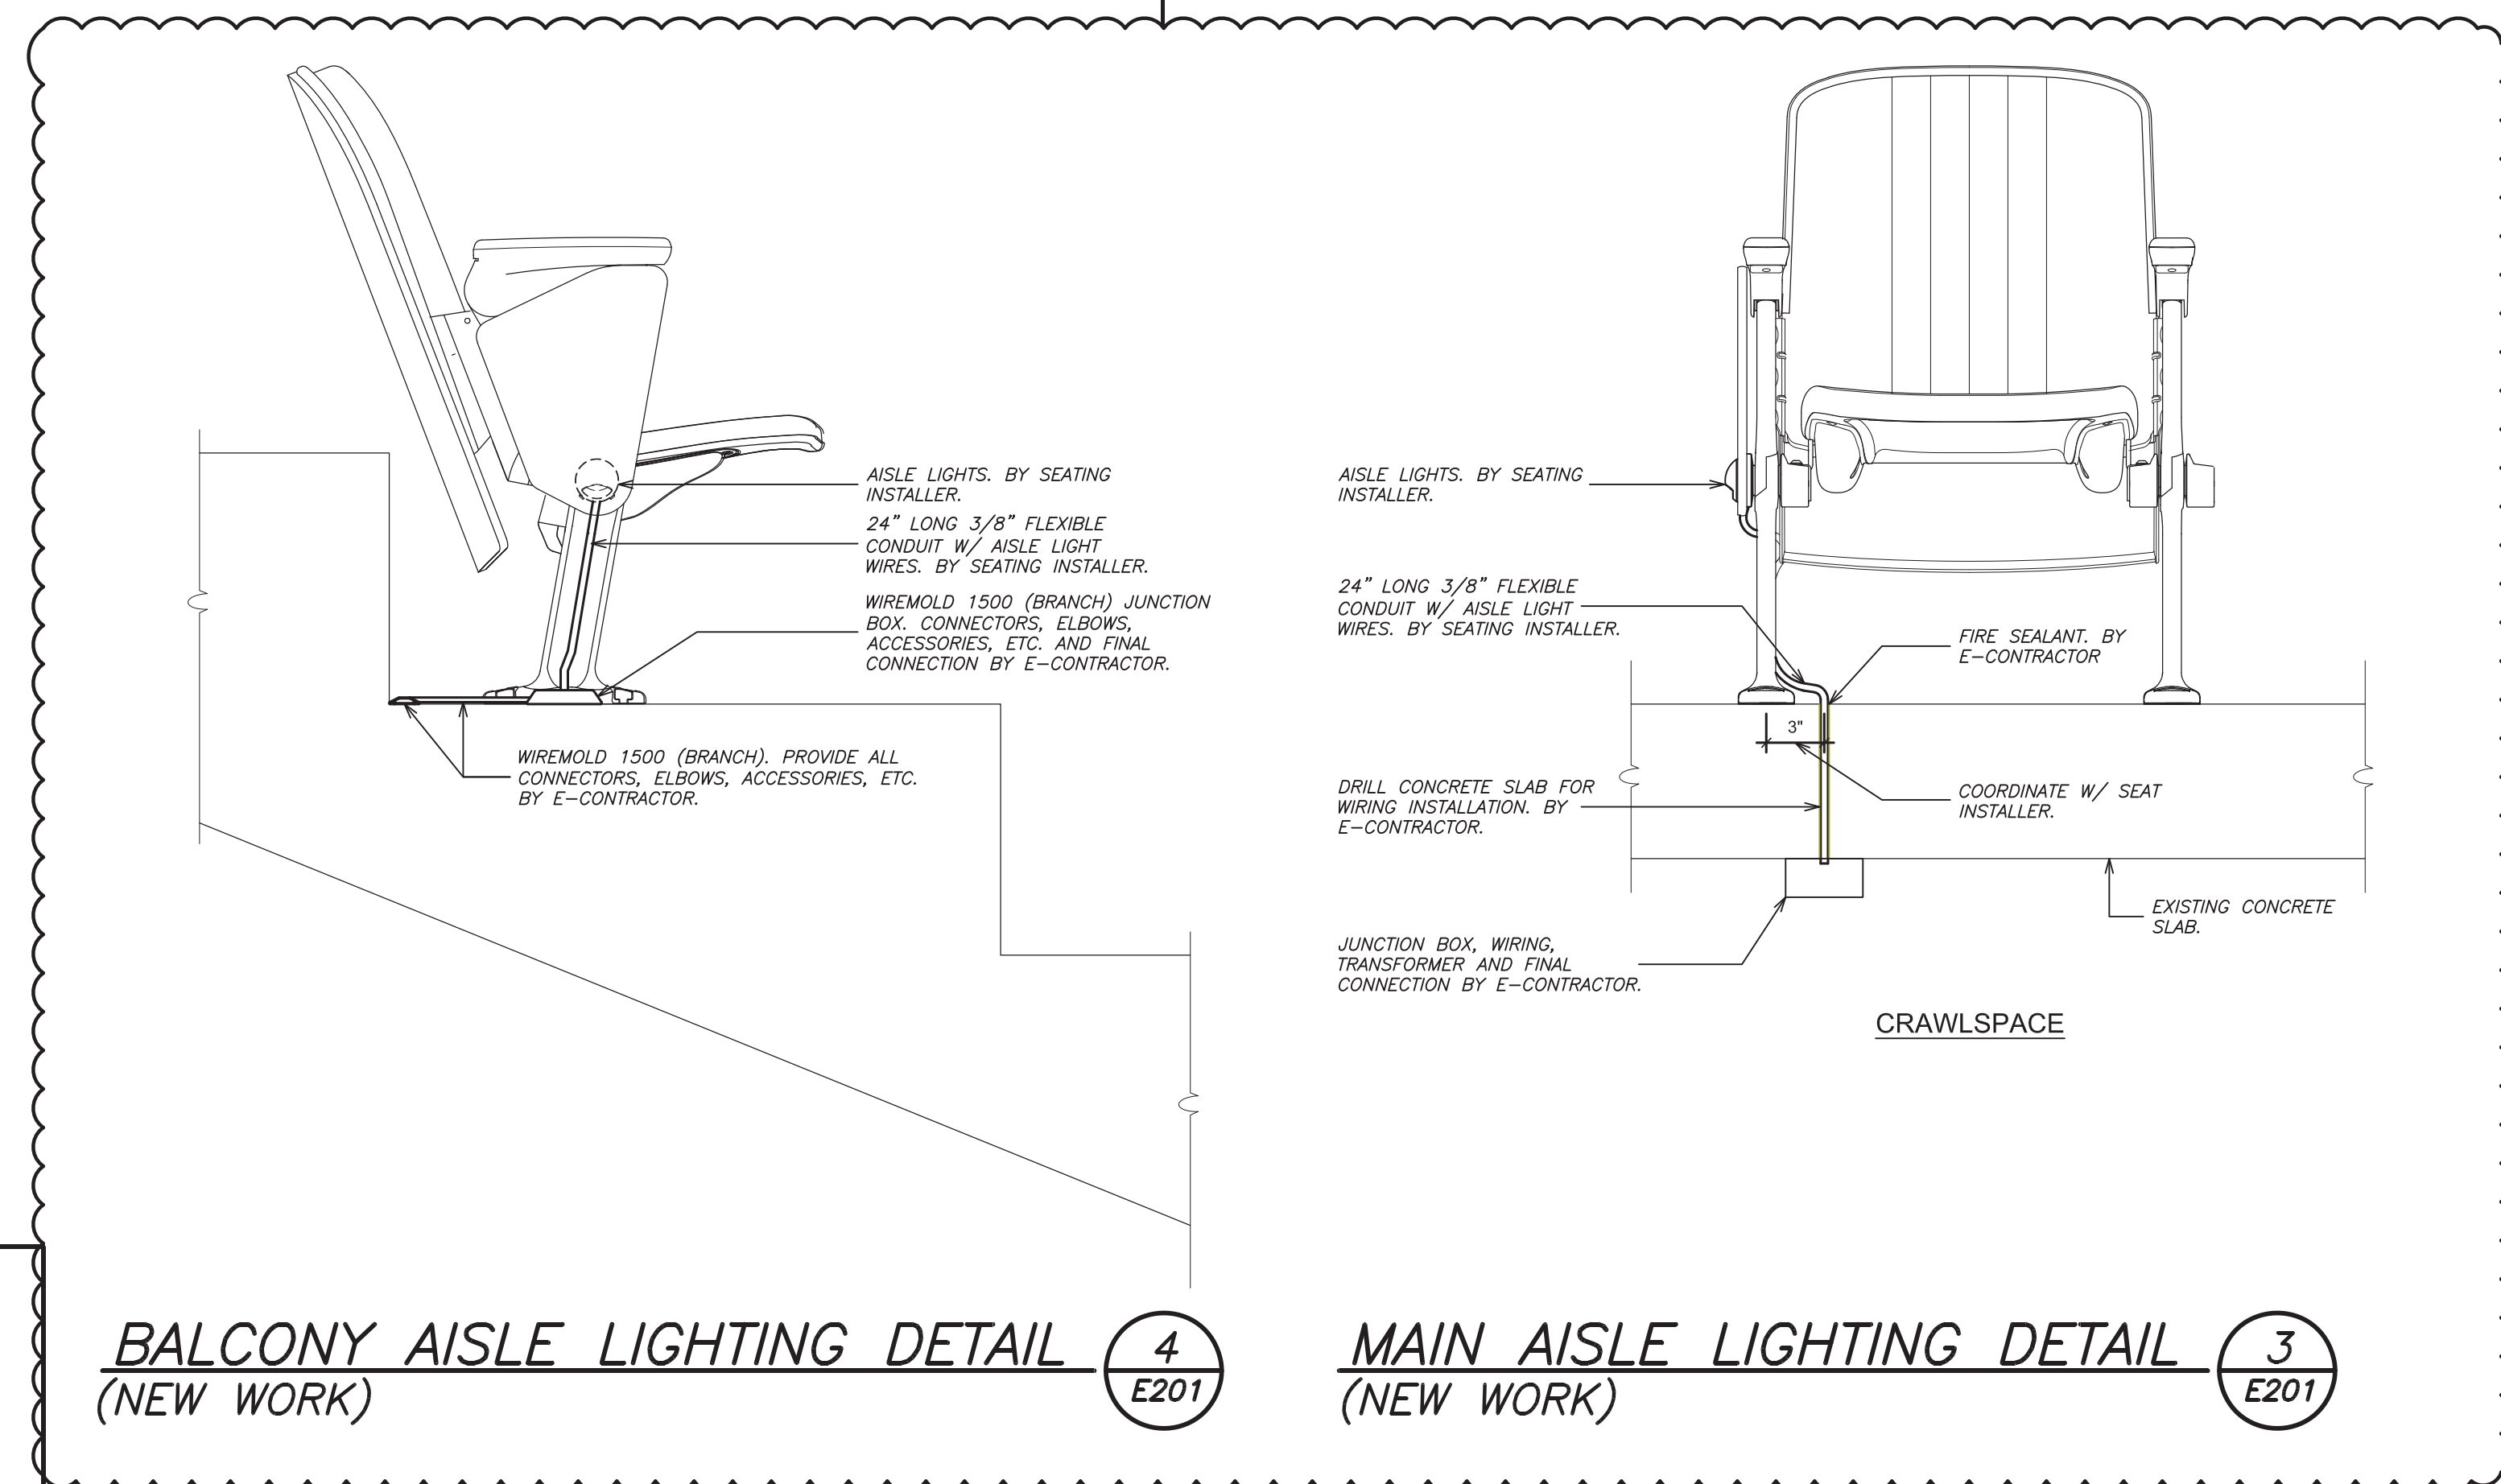

BALCONY AISLE LIGHTING DETAIL (NEW WORK) **4** E201

MAIN AISLE LIGHTING DETAIL (NEW WORK) **3** E201

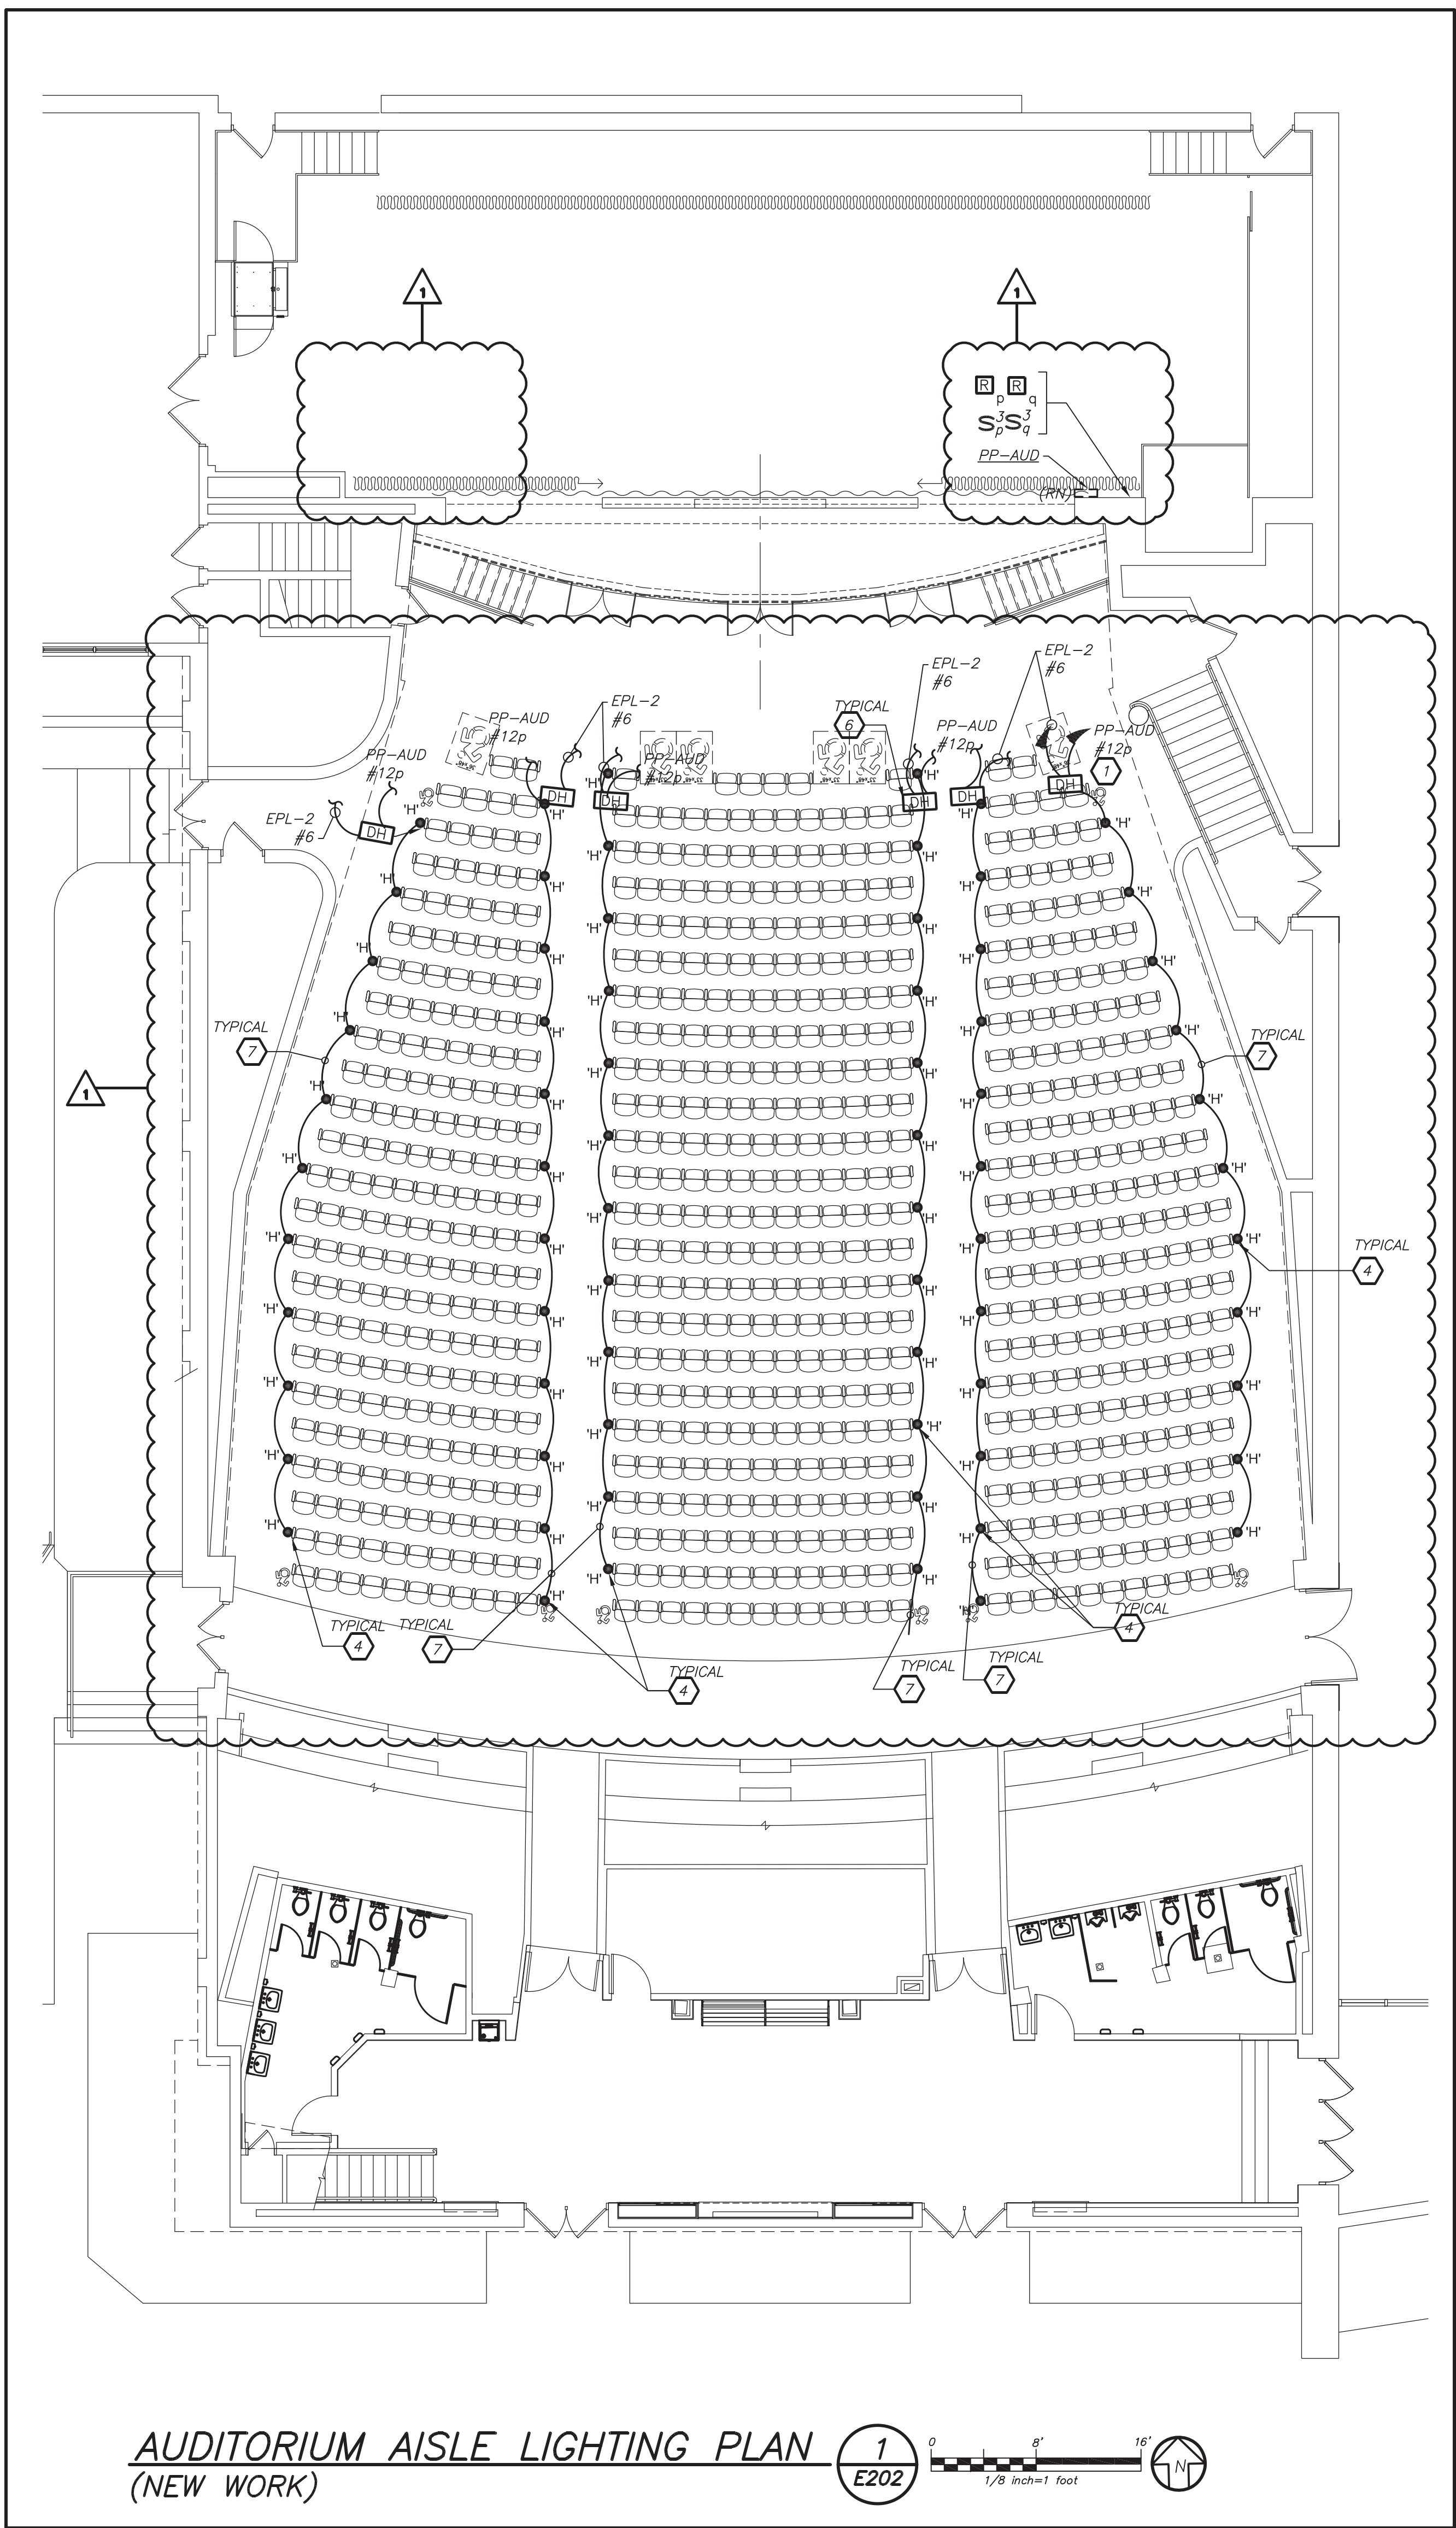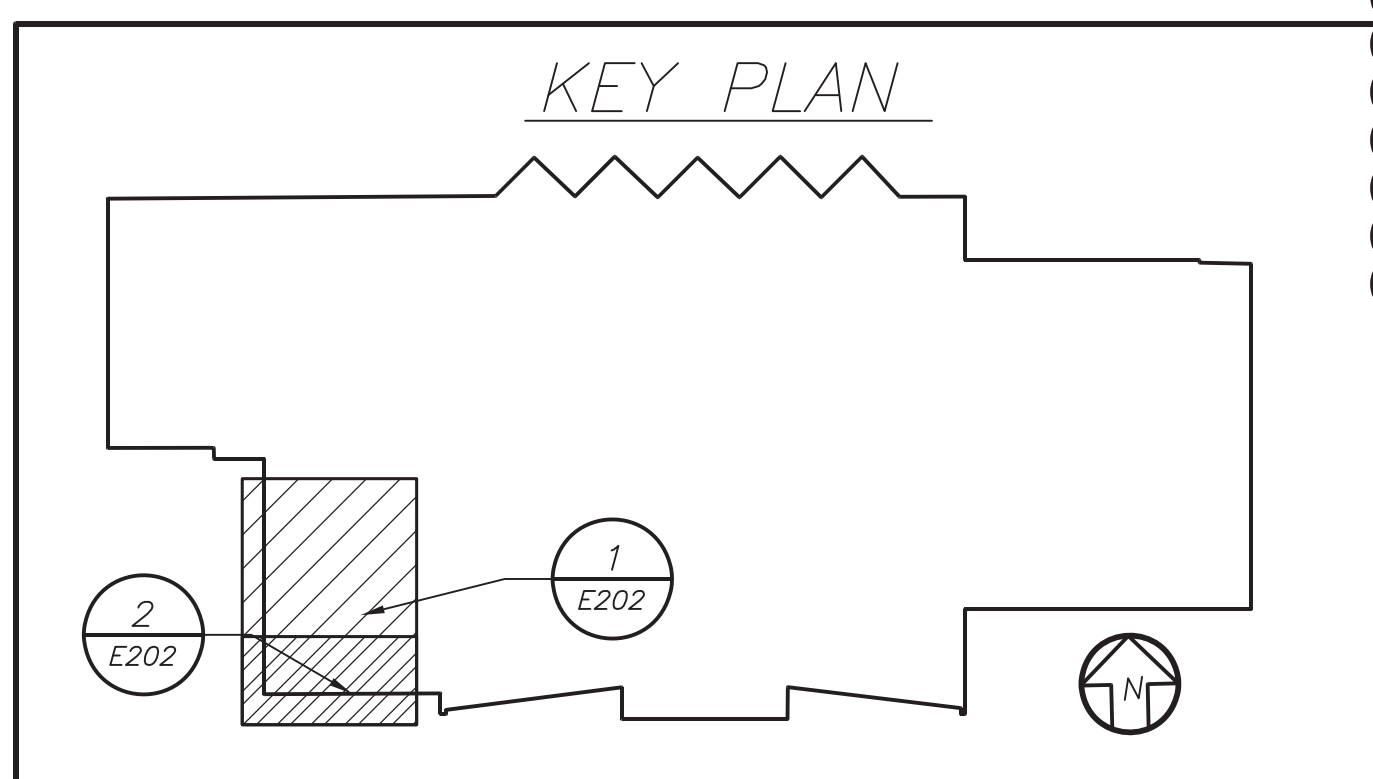

AUDITORIUM AISLE LIGHTING PLAN (NEW WORK) **1** E202

AS PER USA CONGRESS ARCHITECTURAL WORKS COPYRIGHT PROTECTION ACT OF 1990 ALL IDEAS AND DESIGNS INCLUDING DERIVATIVES THEREOF, ALL DRAWINGS AND SPECIFICATIONS CONSTITUTE THE ORIGINAL COPYRIGHT WORK BY FULLER AND DANSELO, P.C. (F&D). THE DRAWINGS AND SPECIFICATIONS AS INSTRUMENTS OF SERVICE BY F&D ARE CREATED BY F&D FOR THIS PROJECT ONLY AND REMAIN THE PRODUCT AND PROPERTY OF F&D. ANY REPRODUCTION WITHOUT THE PRIOR CONSENT OF F&D IS PROHIBITED.

BARILE GALLAGHER & ASSOCIATES
CONSULTING ENGINEERS
30 MARBLE AVE. PLEASANTVILLE, NY 10570
914.326.0000 GENERAL@BGA-ENG.COM www.BGA-ENG.COM

FULLER DANSELO P.C.
ARCHITECTS PLANNERS
48 KENILWOOD ROAD ELIZABETH NEW YORK 10888
TEL 914.888.4444 FAX 914.888.1919
Copyright © All Rights Reserved by FULLER & DANSELO

S.E.D. CONTROL NUMBER:
66-23-00-01-0-202-015


YPS JOB # 10873
YPS JOB # 10888

PROJECT TITLE:
YONKERS SCHOOL DISTRICT
LINCOLN HIGH SCHOOL & EXTERIOR
BLEACHER REPLACEMENT
375 INEELAND AVENUE, YONKERS, NY 10704

DRAWING TITLE:
AUDITORIUM AISLE LIGHTING ELECTRICAL
PLAN

03-19-2021	ADDENDUM #1
02-12-2021	BID
04-09-2020	PROGRESS DRAWINGS
01-24-2020	SCHEMATIC DESIGN
DATE	ISSUED TO

SHEET SIZE: 30"x42"
SCALE: AS NOTED
DRAWN BY: F & D
FILE NO.: 19356.00

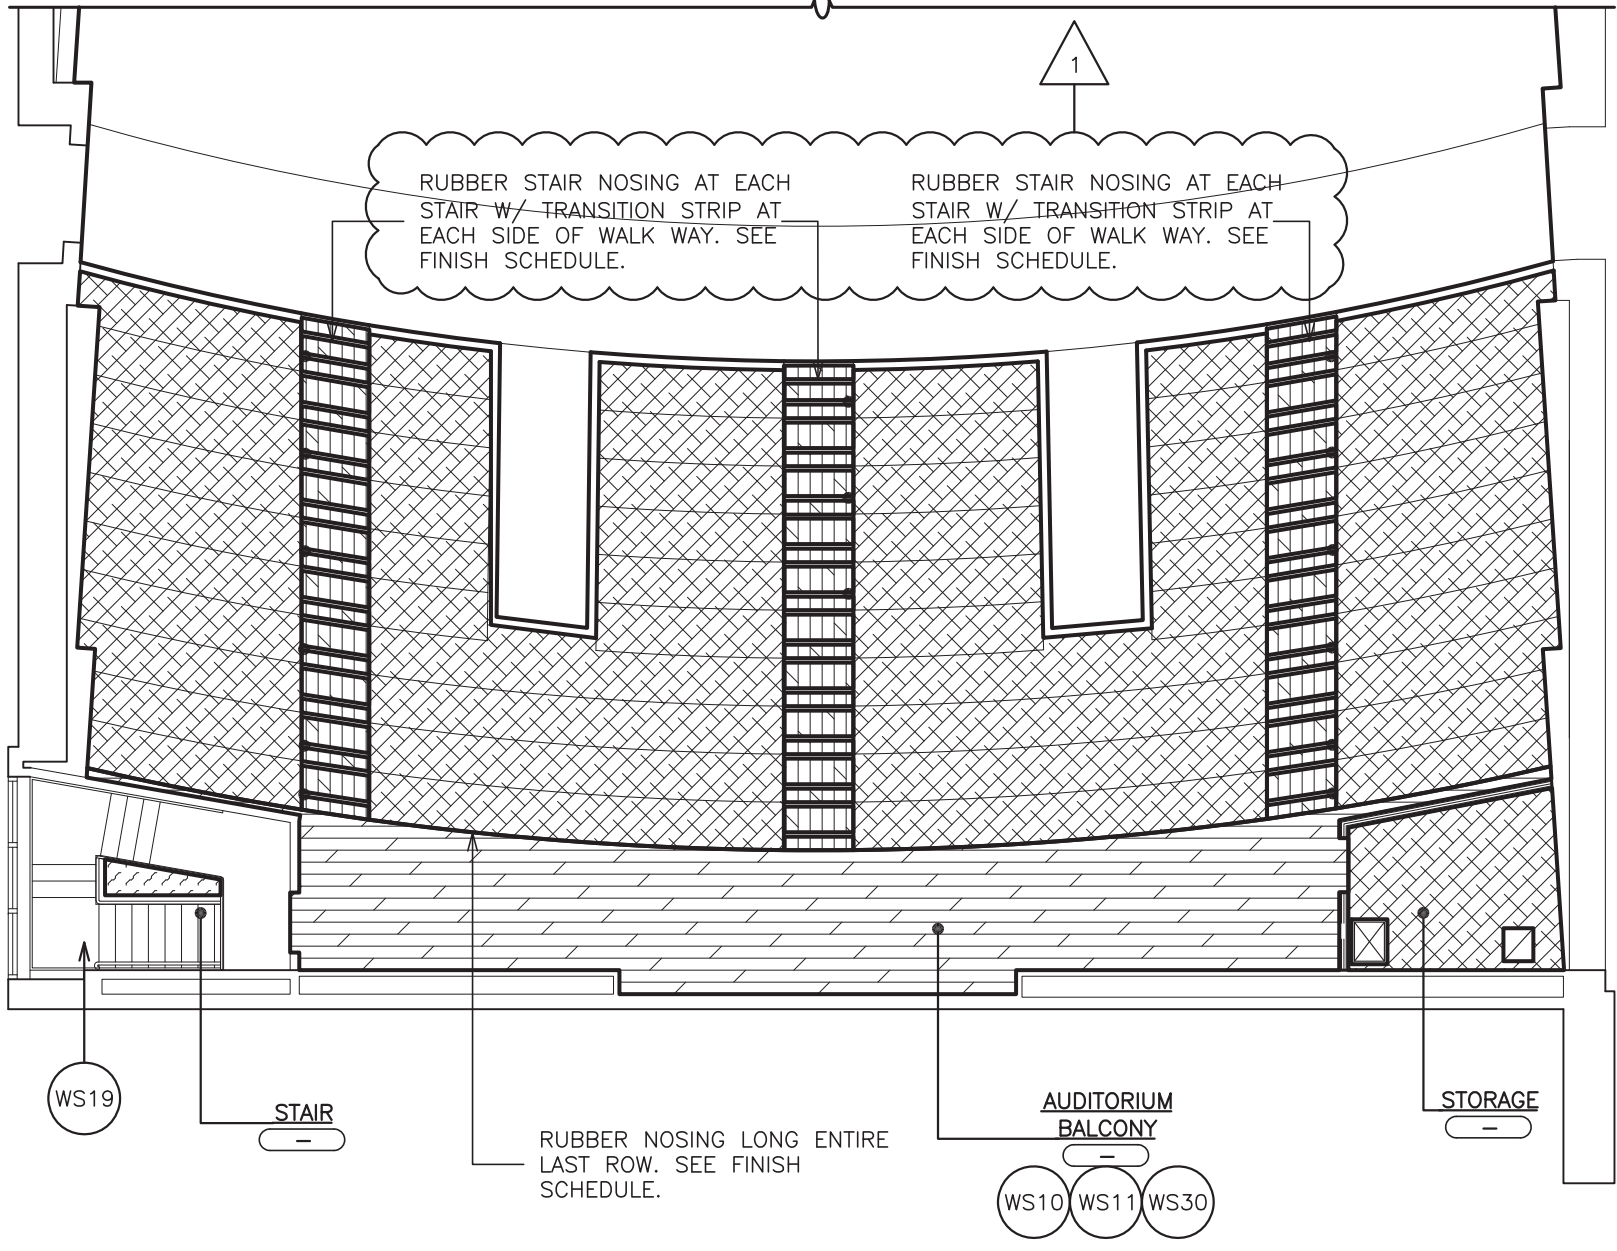

S.E.D. CONTROL NUMBER: 66-23-00-01-0-202-015


JOB NAME:
 YONKERS SCHOOL DISTRICT
 LINCOLN HIGH SCHOOL
 AUDITORIUM UPGRADES & EXTERIOR BLEACHER
 REPLACEMENT
 375 KNEELAND AVENUE, YONKERS, NY 10704

YPS JOB # 10873
 YPS JOB # 10888

**FULLER
 D'ANGELO
 P.C.**
**ARCHITECTS
 PLANNERS**

48 KNOWLEDGE ROAD ELMSFORD NEW YORK 10823
 TEL 914.892.4444 FAX 914.892.1717
 WWW.FULLERDANGELO.COM
 Copyright 2021 All Rights Reserved by FULLER & D'ANGELO P.C.

ADDENDUM #1	ISSUED TO
03-19-2021	AS NOTED
DATE	FILE NO.
SCALE:	19356.00
	DRAWING NO.
	SK-A1.0

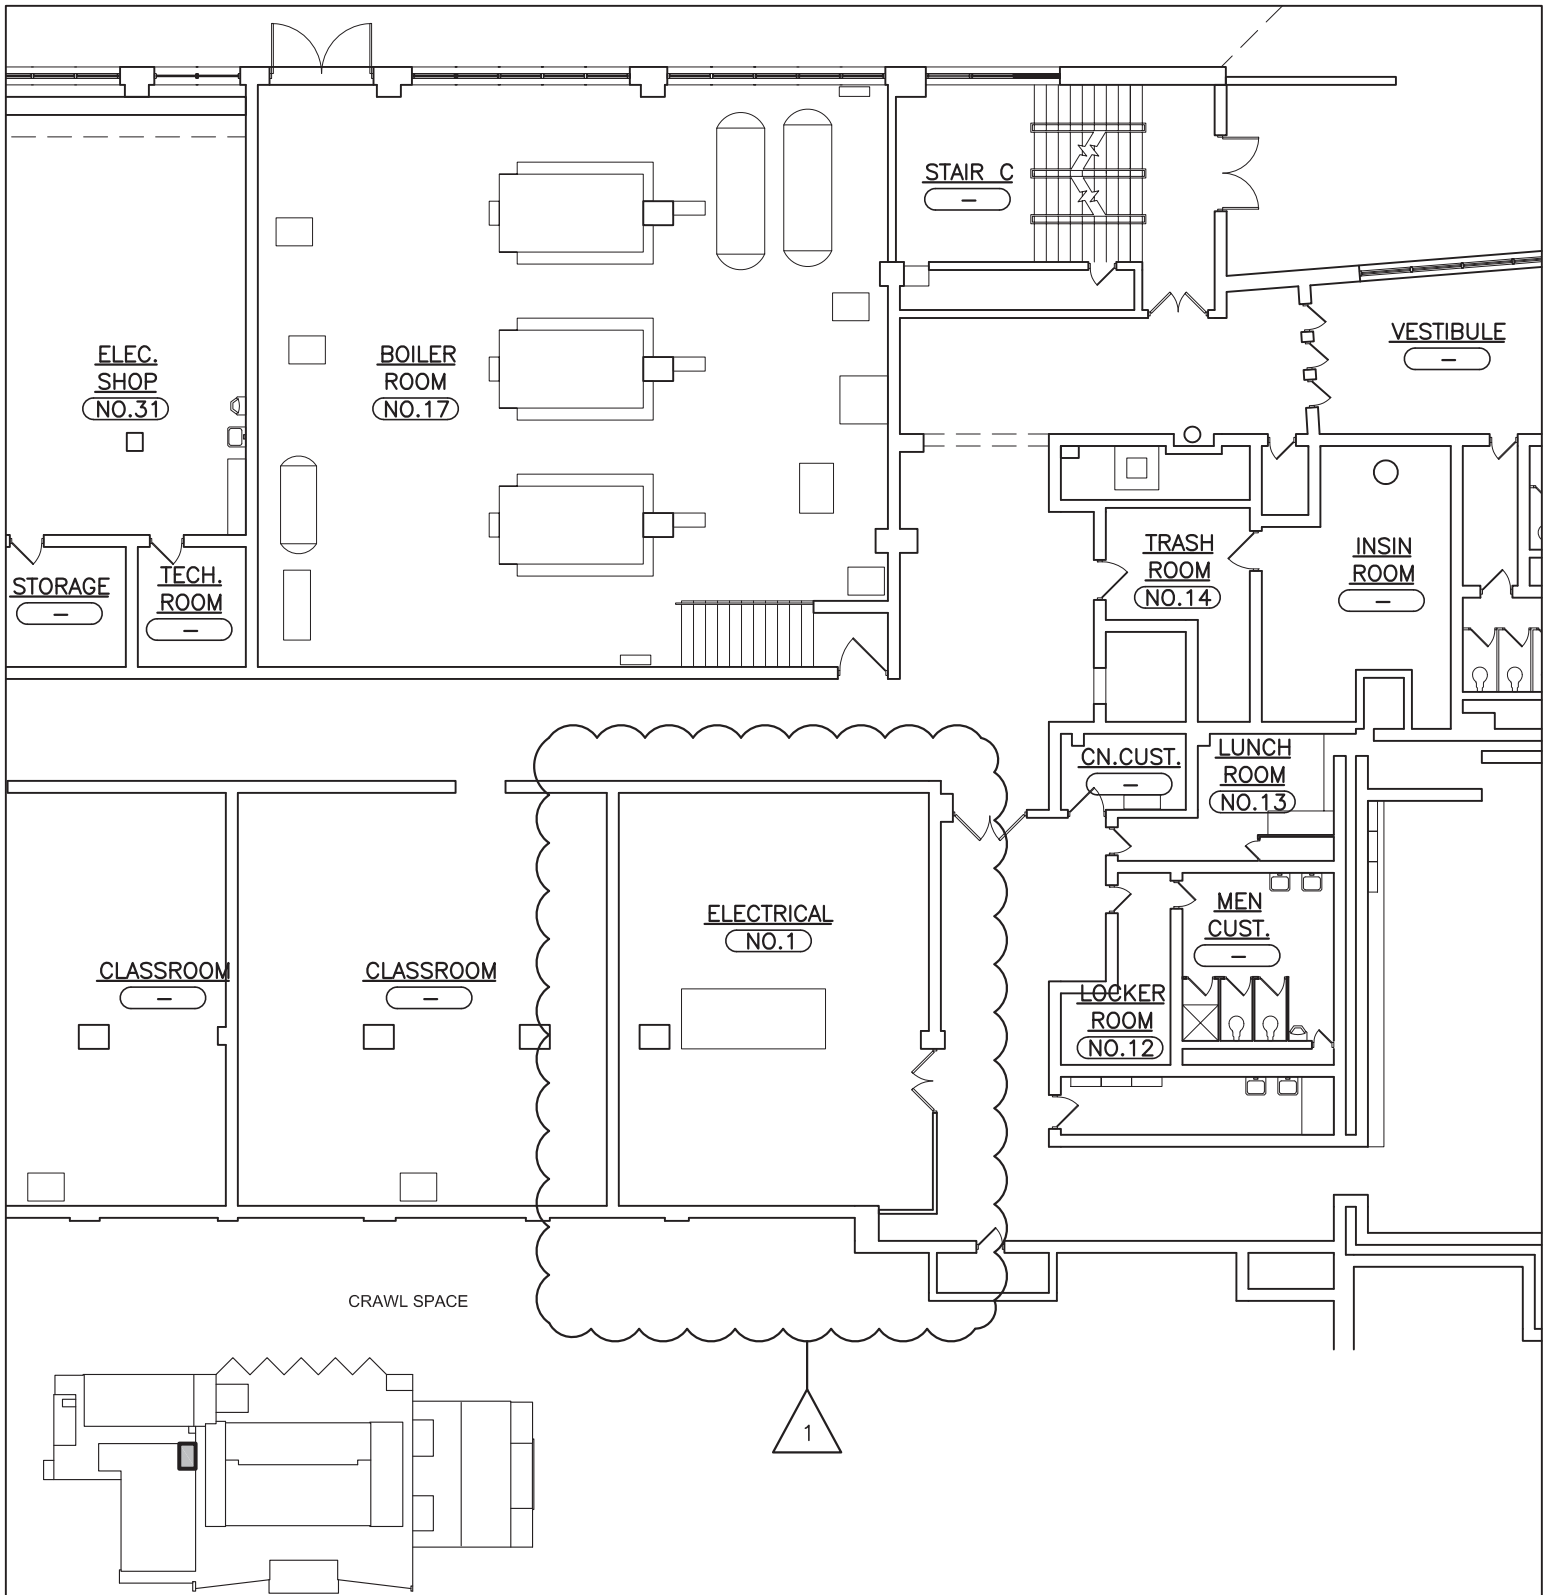

KEY PLAN 
SCALE N.T.S.

S.E.D. CONTROL NUMBER: 66-23-00-01-0-202-015

FULLER D'ANGELO P.C. ARCHITECTS PLANNERS	YPS JOB # 10873 YPS JOB # 10888	JOB NAME: YONKERS SCHOOL DISTRICT LINCOLN HIGH SCHOOL AUDITORIUM UPGRADES & EXTERIOR BLEACHER REPLACEMENT 375 KNEELAND AVENUE, YONKERS, NY 10704	
		03-19-2021	ADDENDUM #1
		DATE	ISSUED TO
		SCALE:	AS NOTED
45 KNOLLWOOD ROAD ELMSFORD NEW YORK 10523 TEL 914.892.4444 FAX 914.892.1717 WWW.FULLERDANSELO.COM <small>Copyright 2021 All Rights Reserved by FULLER & D'ANGELO P.C.</small>		DRAWING TITLE: PARTIAL BASEMENT FLOOR ELECTRICAL ROOM LOCATION	
		FILE NO. 19356.00	DRAWING NO. SK-E1.0