




PIPING SHOWN HERE JUST FOR REFERENCE ONLY.
REFER TO MECH DRAWING FOR
PIPING AND COMPONENTS.

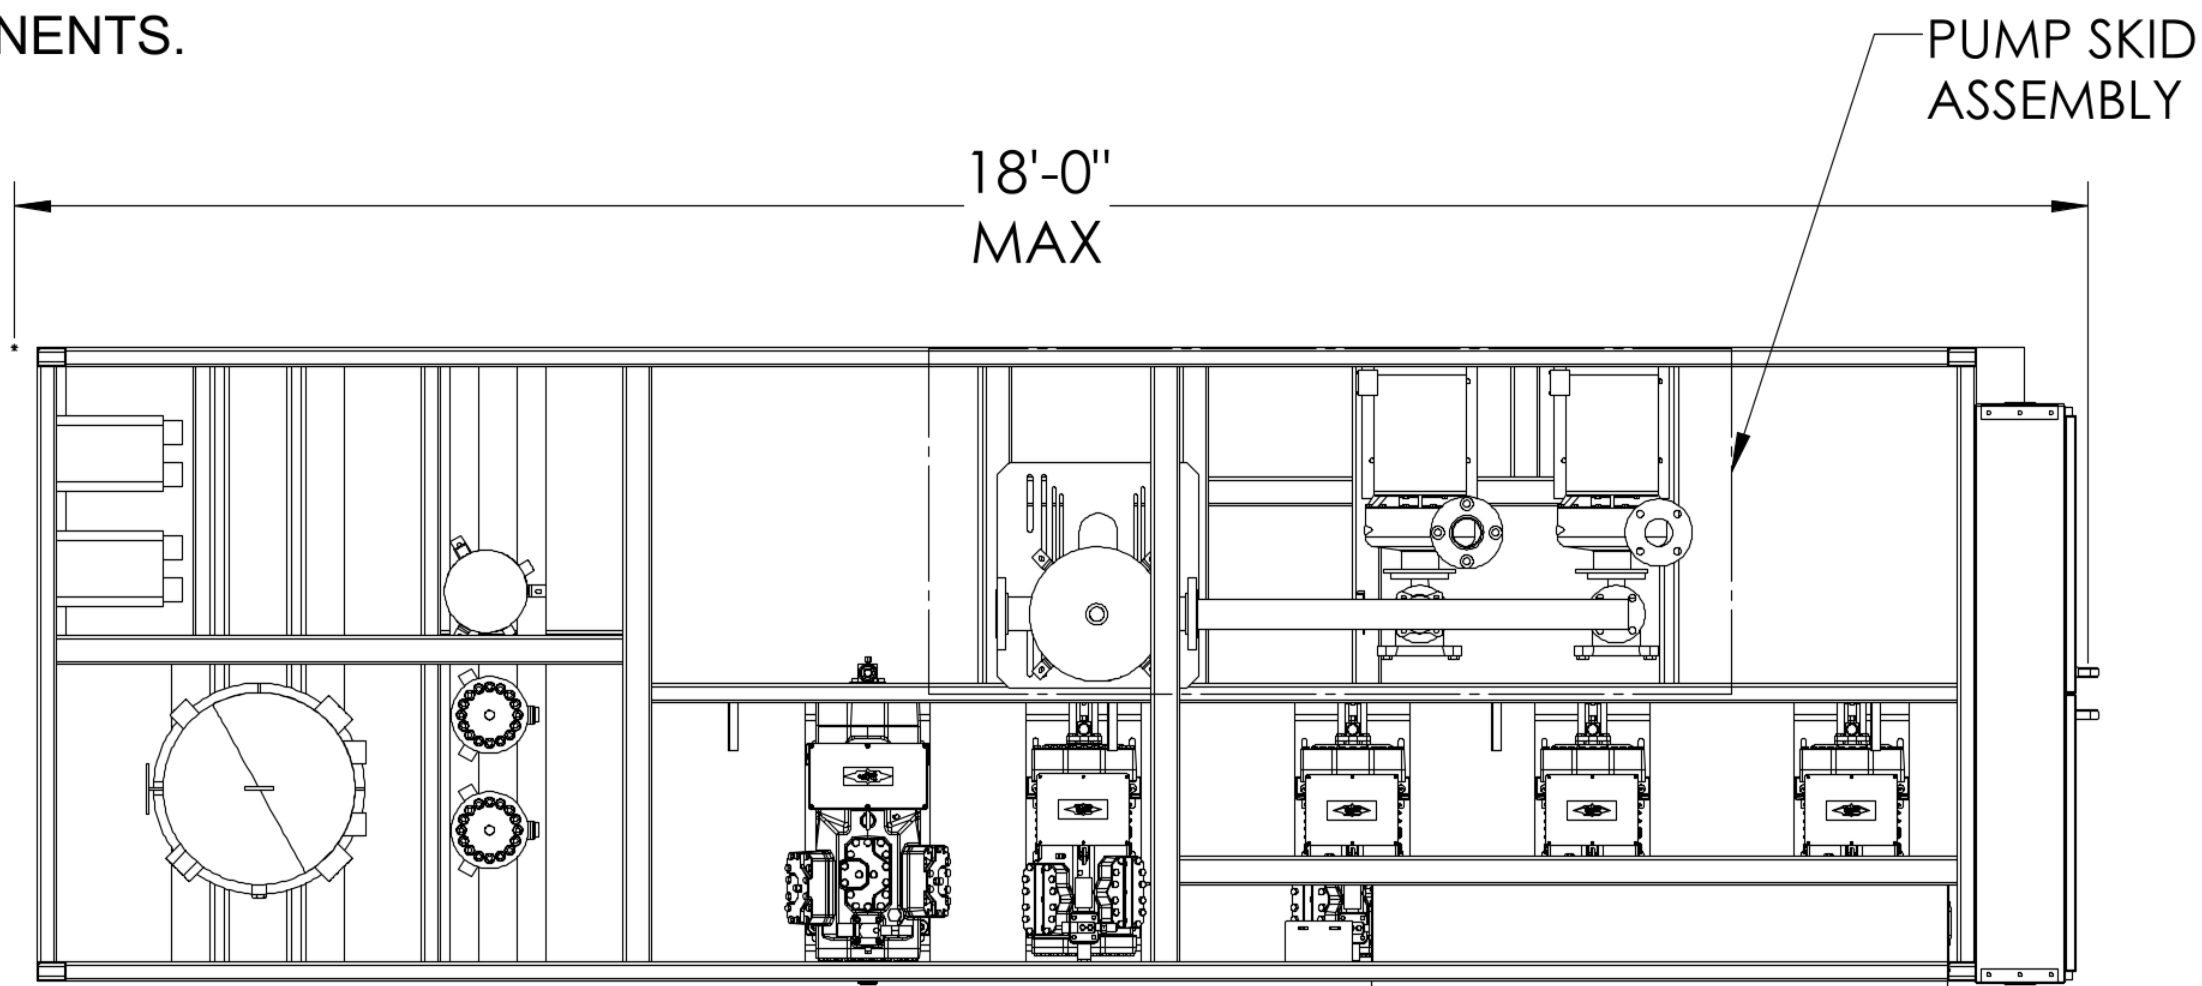


TOP VIEW

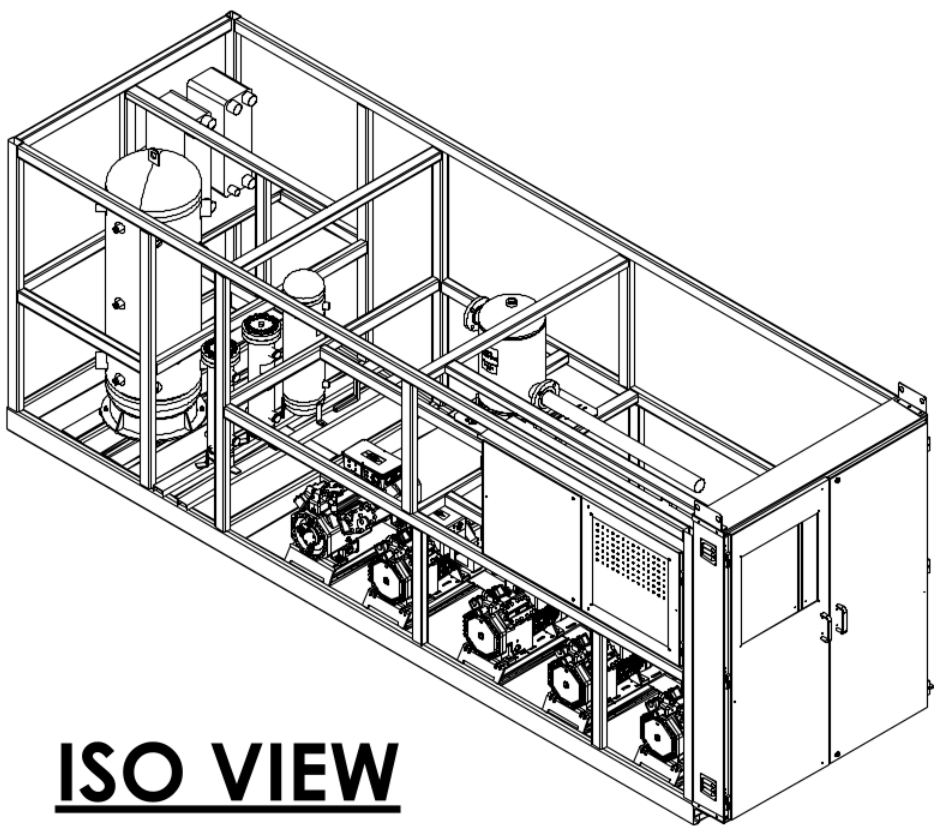

ISO VIEW

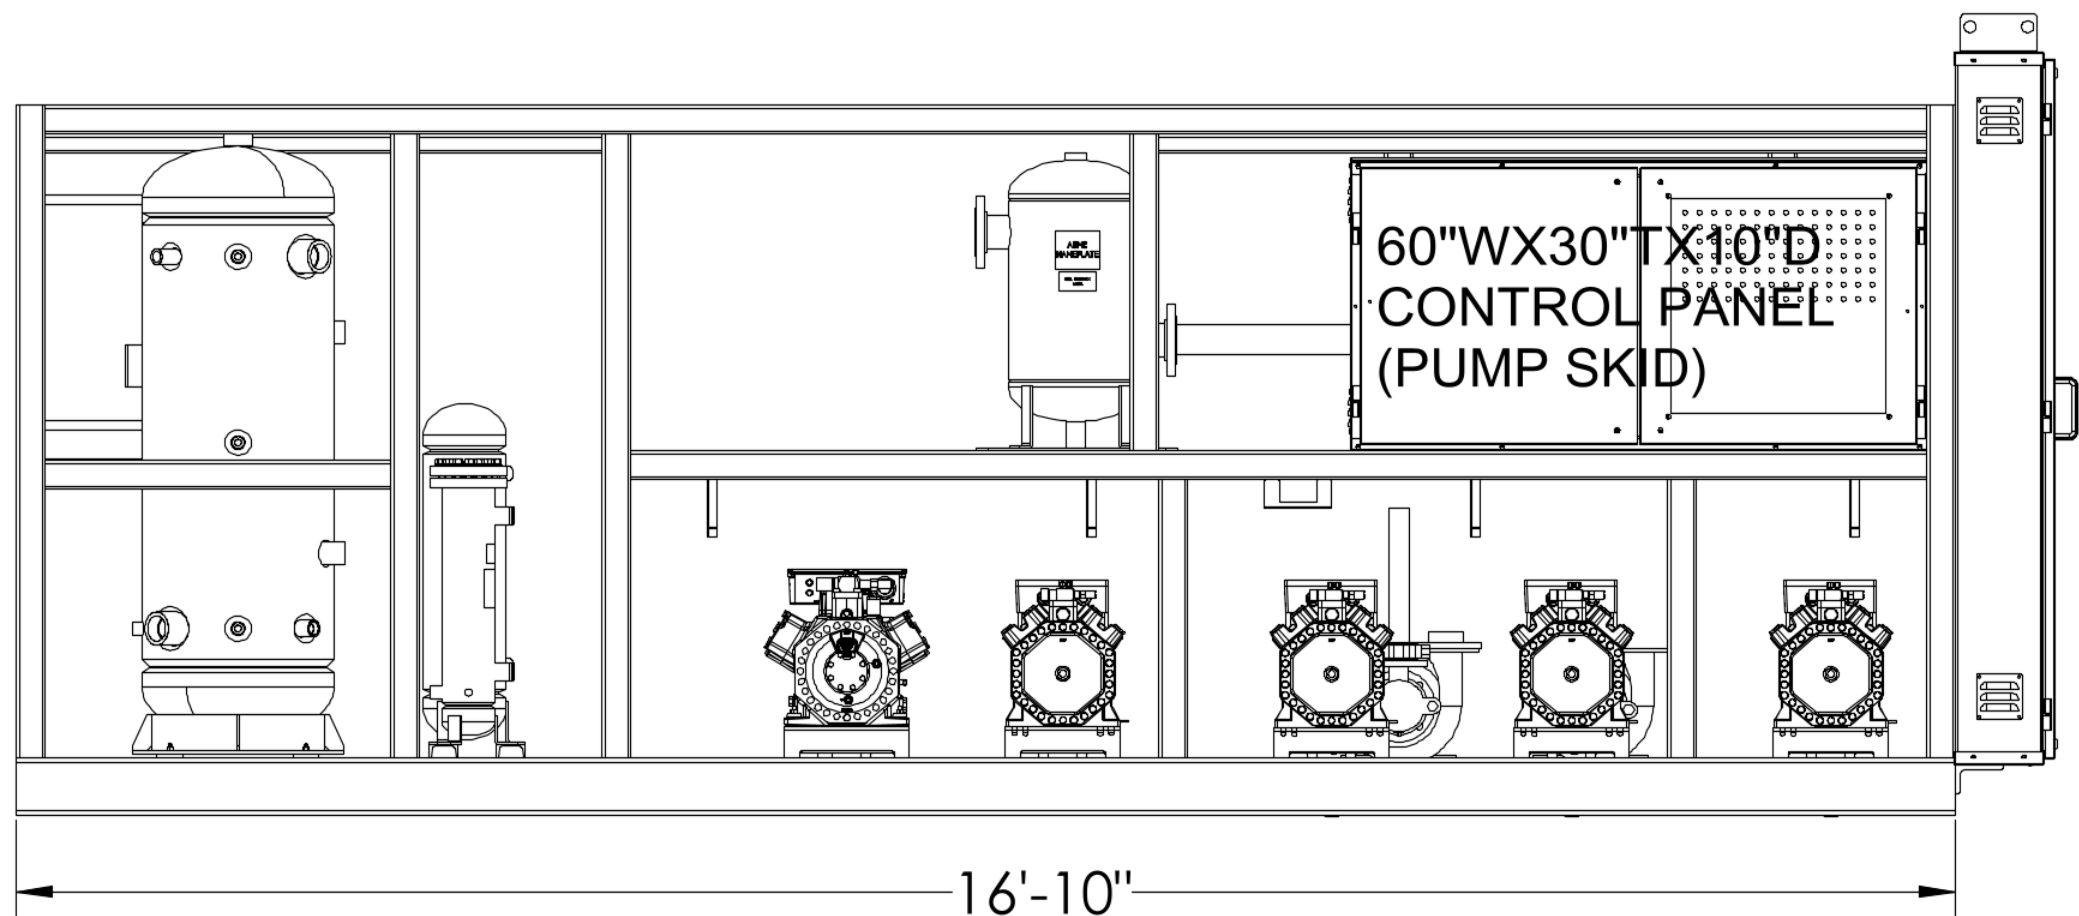

FRONT ELEVATION

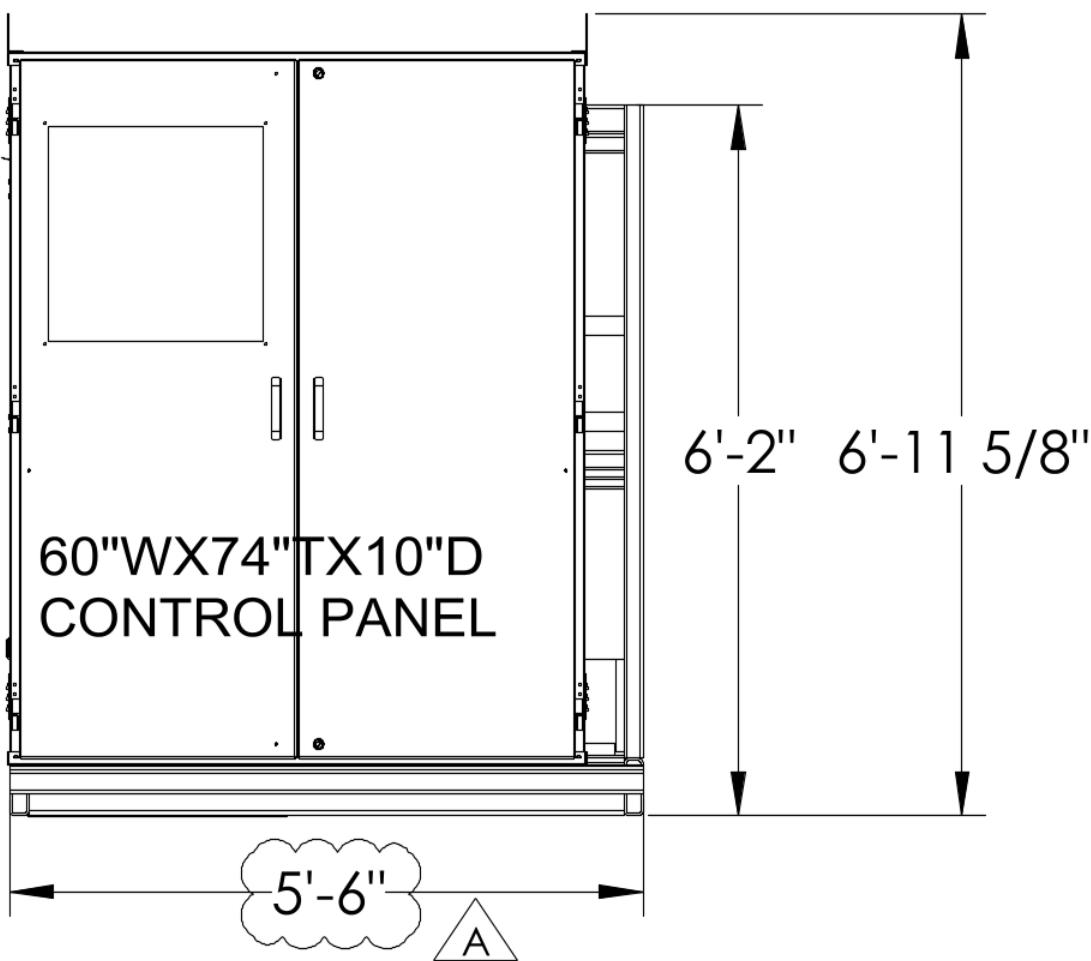

SIDE ELEVATION

SUBMITTAL APPROVAL			
	Y	N	WITH COMMENTS
OVERALL DIMENSIONS	☐	☐	☐
WEIGHT	☐	☐	☐
CIRCUIT LOCATION	☐	☐	☐
CIRCUIT LAYOUT	☐	☐	☐
CUSTOMER NAME	_____		
CUSTOMER SIGNATURE	_____		
DATE	_____		

FOR CUSTOMER USE ONLY
DO NOT USE FOR CONSTRUCTION

NOTE:
1. ESTIMATED SHIPPING(DRY) WEIGHT: 12,000 LBS

127258 BOA P S100

CUSTOMER		ADAM'S FIARACRE FARMS INC			
JOB NAME		ADAMS FIARACRE FARMS MIDDLETOWN, NEW YORK USA,			
JOB NUMBER		127258	STORE NUMBER		
REVISION RECORD			P/C:	P/N: 127258_BOA_P_S100	
REV	DATE	BY	DESCRIPTION	CAD FILE NAME: 127258_BOA_P_S100	ASSY,WELDED,BOOSTER,216"X66"X84"
△A	25 NOV 2021	NKL	RACK WIDTH REDUCED BY 9"		
△	-	-	-		
△	-	-	-		
△	-	-	-		
			Hillphoenix		DRAWN BY: NKL
			SYSTEMS - REFRIGERATION		ENG. APPROVAL: -
			709 SIGMAN ROAD • CONYERS, GA 30013		DATE: 18 NOV 2021
			PHONE: (770) 285-3100 • FAX: (770) 285-3076		SCALE: (EXCEPT AS NOTED) 1:32
					SIZE: C
					SHEET: 1 of 1

THIS DOCUMENT CONTAINS INFORMATION WHICH HILL PHOENIX CONSIDERS TO BE CONFIDENTIAL OR PROPRIETARY. ALL RIGHTS ARE RESERVED UNLESS OTHERWISE STATED HEREIN.