




PIPING SHOWN HERE JUST FOR REFERENCE ONLY.  
REFER TO MECH DRAWING FOR  
PIPING AND COMPONENTS.

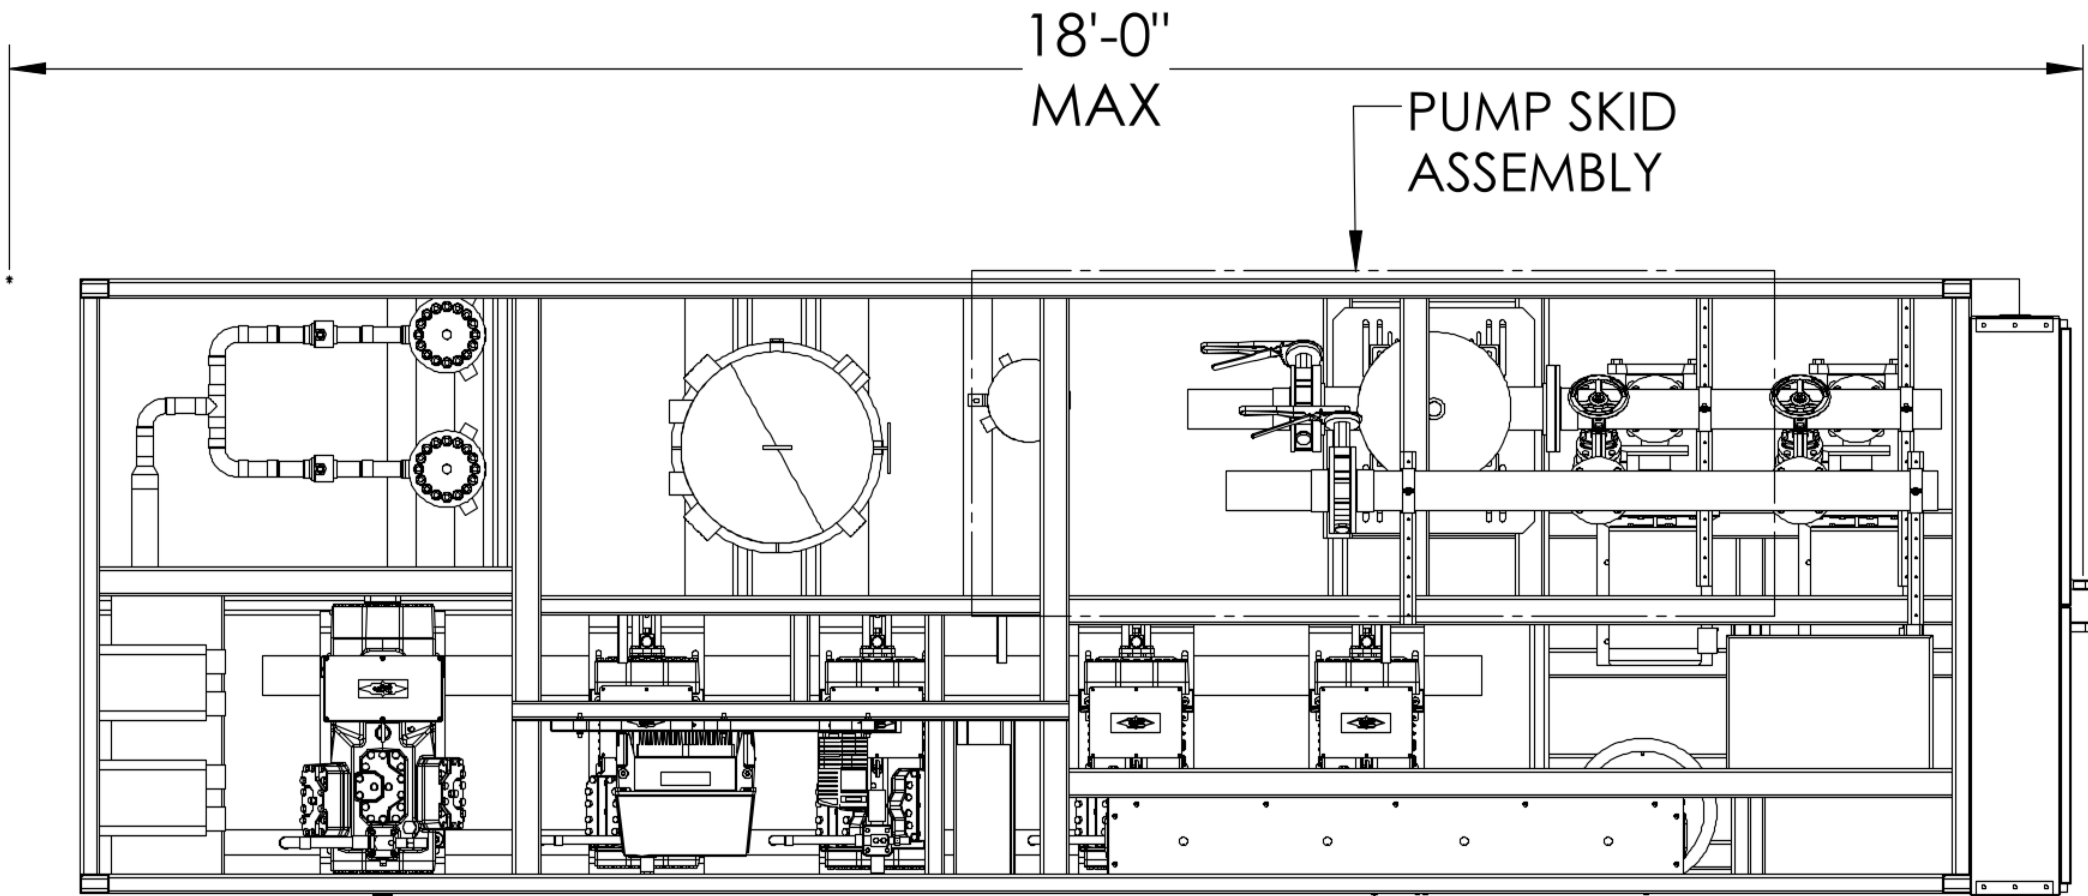


TOP VIEW

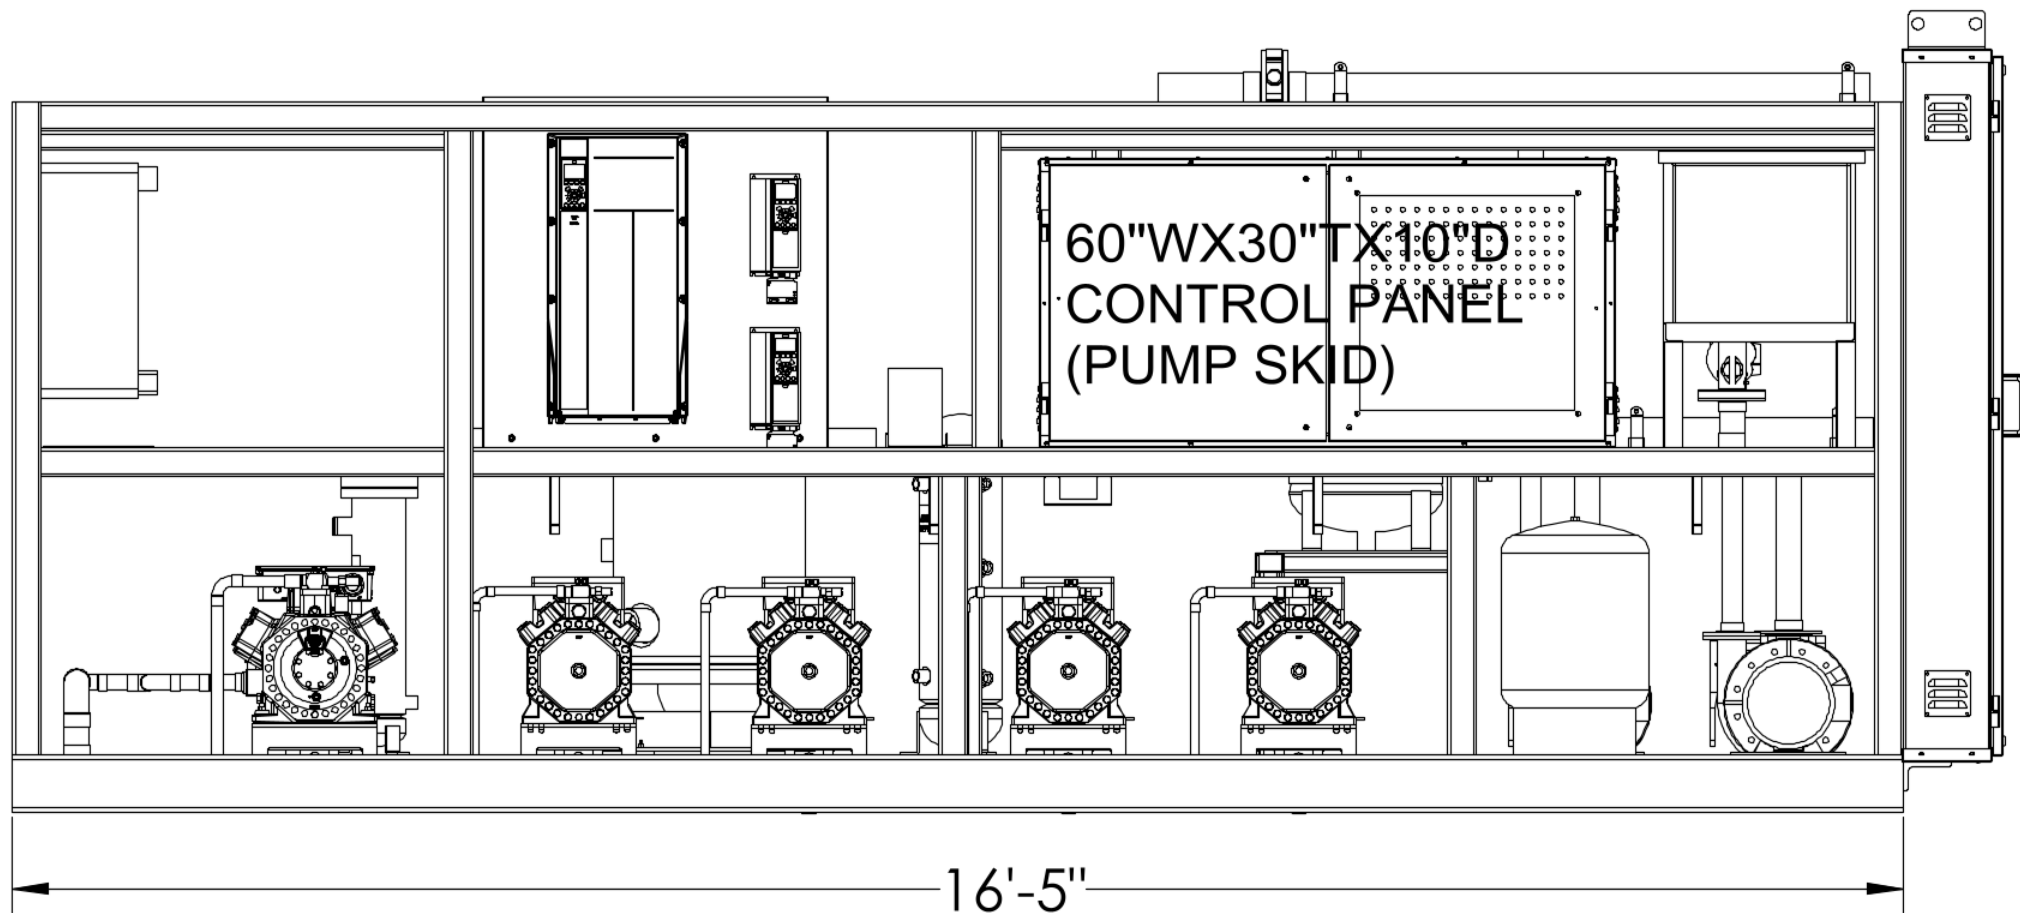

FRONT ELEVATION

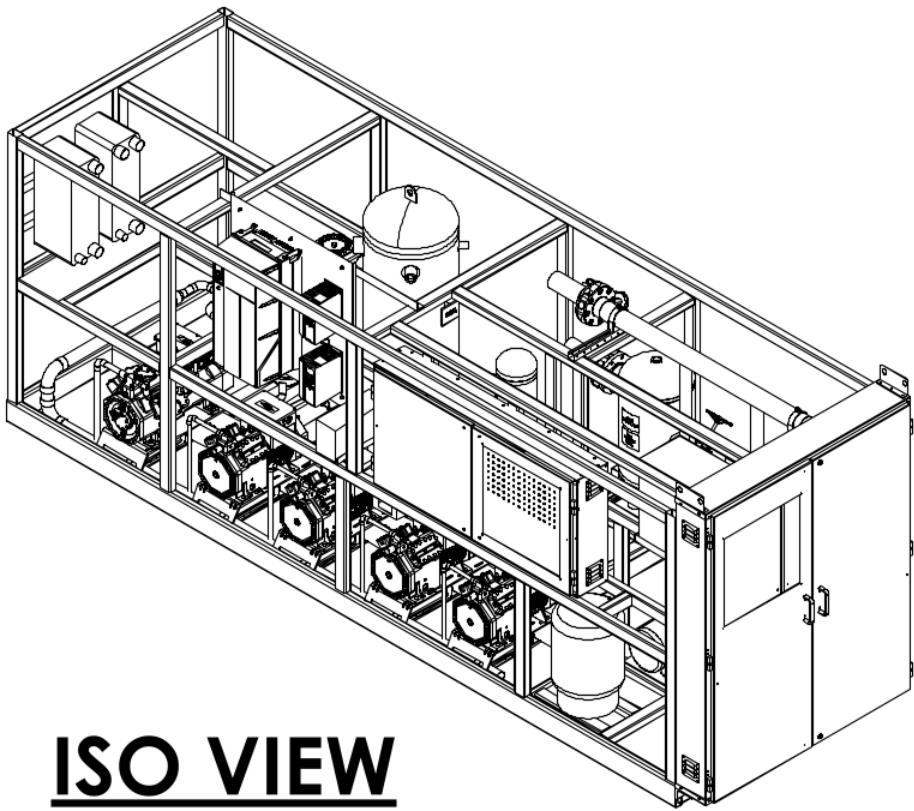

ISO VIEW

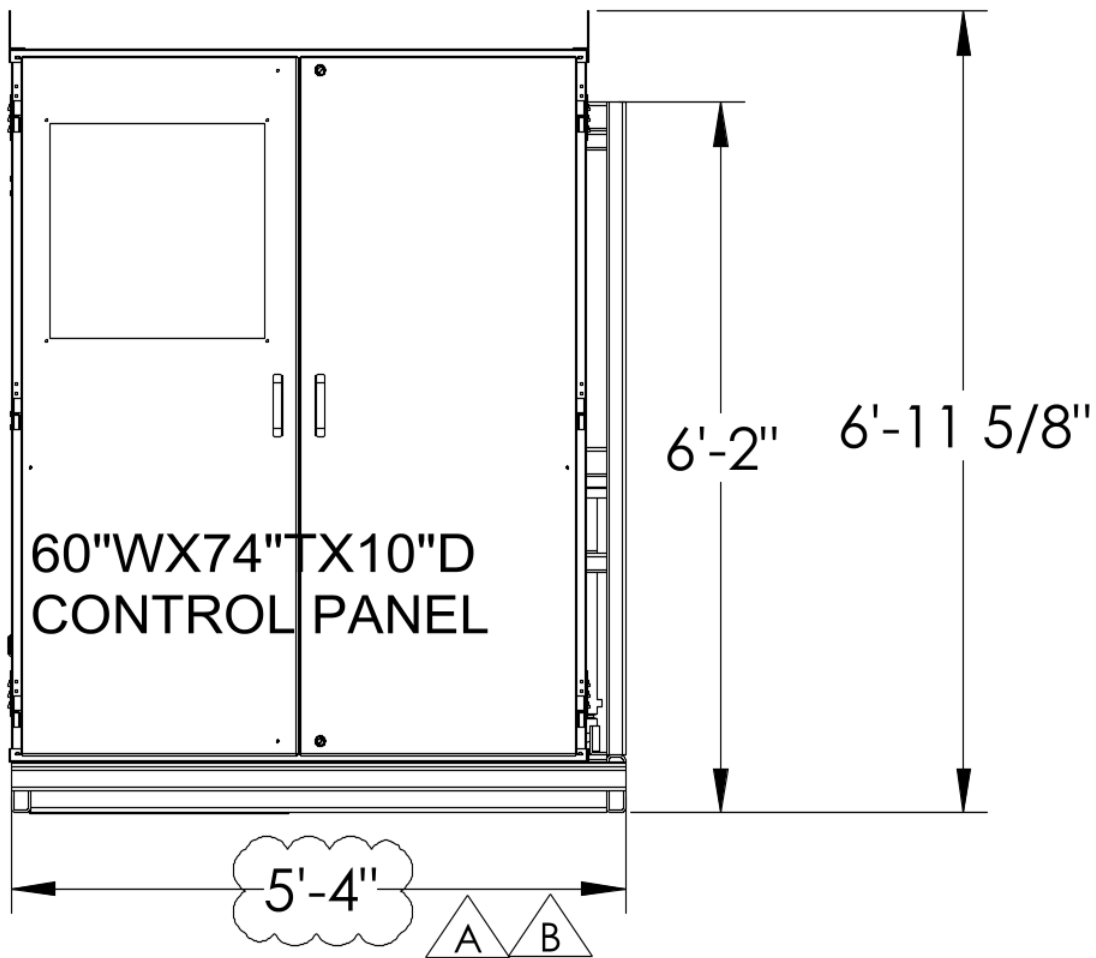

SIDE ELEVATION

SUBMITTAL APPROVAL

	Y	N	WITH COMMENTS
OVERALL DIMENSIONS	<input type="checkbox"/>	<input type="checkbox"/>	<input type="checkbox"/>
WEIGHT	<input type="checkbox"/>	<input type="checkbox"/>	<input type="checkbox"/>
CIRCUIT LOCATION	<input type="checkbox"/>	<input type="checkbox"/>	<input type="checkbox"/>
CIRCUIT LAYOUT	<input type="checkbox"/>	<input type="checkbox"/>	<input type="checkbox"/>

CUSTOMER NAME \_\_\_\_\_

CUSTOMER SIGNATURE \_\_\_\_\_

DATE \_\_\_\_\_

FOR CUSTOMER USE ONLY  
DO NOT USE FOR CONSTRUCTION

NOTE:  
1. ESTIMATED SHIPPING(DRY) WEIGHT: 12,000 LBS

127258 BOA P S100

CUSTOMER		ADAM'S FIARACRE FARMS INC			
JOB NAME		ADAMS FIARACRE FARMS MIDDLETOWN, NEW YORK USA,			
JOB NUMBER		127258	STORE NUMBER		
REVISION RECORD			P/C:	P/N: 127258_BOA_P_S100	
REV	DATE	BY	DESCRIPTION	CAD FILE NAME: 127258_BOA_P_S100	
A	25 NOV 2021	NKL	RACK WIDTH REDUCED BY 9"	ASSY,WELDED,BOOSTER,216"X66"X84"	
B	30 NOV 2021	NKL	OVERALL WIDTH REDUCED BY 2"		
				<div>Hillphoenix</div> <div>SYSTEMS - REFRIGERATION</div> <div>709 SIGMAN ROAD • CONYERS, GA 30013</div> <div>PHONE: (770) 285-3100 • FAX: (770) 285-3076</div>	
THIS DOCUMENT CONTAINS INFORMATION WHICH HILL PHOENIX CONSIDERS TO BE CONFIDENTIAL OR PROPRIETARY. ALL RIGHTS ARE RESERVED UNLESS OTHERWISE STATED HEREIN.				<div>DRAWN BY: NKL</div> <div>ENG. APPROVAL:</div> <div>DATE: 18 NOV 2021</div> <div>SCALE: (EXCEPT AS NOTED) 1:32</div> <div>SIZE: C</div> <div>SHEET: 1 of 1</div>	