

ARCHITECTURAL SYMBOL LEGEND

- PROPOSED EXTERIOR WALL. SEE WALL SECTIONS
- INTERIOR STUD FRAMED WALL. SEE WALL TYPES
- AREA OF NO WORK. FACILITY TO REMAIN OPERATIONAL
- 1 HR FIRE RATED PARTITION
- 2 HR FIRE RATED PARTITION
- SMOKE RATED PARTITION / SMOKE BARRIER / COMPARTMENT
- 1 HR FIRE SHAFT PARTITION
- 1 HR FIRE AND SMOKE BARRIER
- 2 HR FIRE AND SMOKE BARRIER
- VAVA ITEM - VA SUPPLIED & INSTALLED
- VA/CC OR VC ITEM - VA SUPPLIED & CONTRACTOR INSTALLED
- CC/CC ITEM - CONTRACTOR SUPPLIED & INSTALLED
- FIRE EXTINGUISHER CABINETS
FEC RECESSED - SEE (C1A-722)
FEC-3 SURFACE MNT. SEE: (C8A-731)
- FURNITURE, FIXTURE, & EQUIPMENT INDICATOR
DS RS
MATCHLINE
- EXPANSION JOINT
- DEDUCTIVE ALTERNATE


GENERAL SHEET NOTES

- A. REFER TO A-001 FOR TYPICAL ARCHITECTURAL SYMBOLS, ABBREVIATIONS, DIMENSIONING PROTOCOLS, AND OTHER NOTES RELATED TO INTERPRETING THE DOCUMENTS.
- B. CONTRACTOR TO VALIDATE AND VERIFY ALL FIRE RATED AND/OR SMOKE RATED WALLS AND ASSEMBLIES INDICATED ON PLANS IN WORK AREA. PROVIDE ALL PIPING PENETRATIONS OF FIRE, SMOKE AND FULL HEIGHT WALLS SHALL BE CAULKED AIRTIGHT TO THE ADJACENT STRUCTURE BY MEANS OF U.L. APPROVED FIRE PROOF CAULKING MATERIAL. SEE MECHANICAL AND PLUMBING DRAWINGS FOR ADDITIONAL INFORMATION. CONTRACTOR SHALL COORDINATE ALL PIPING, PLUMBING, AND CONDUIT PIPING WITH STRUCTURAL, MECHANICAL, AND ELECTRICAL SYSTEMS AND SHALL PROVIDE NECESSARY OFFSETS TO AVOID CONFLICTS AND TO MAINTAIN REQUIRED EQUIPMENT ACCESS AND SERVICEABILITY. EXISTING CONDITIONS ARE BASED ON EXISTING PLANS AND FIELD VERIFICATION WHERE FEASIBLE. ACTUAL CONDITIONS MAY DIFFER FROM THOSE INDICATED. CONTRACTOR TO FIELD VERIFY IN ADVANCE THE LOCATION AND CONDITION OF THOSE EXISTING SYSTEMS SHOWN TO BE MODIFIED OR REMOVED. CONTRACTOR TO NOTIFY ARCHITECT SHOULD CONDITIONS BE FOUND TO DIFFER SIGNIFICANTLY FROM CONSTRUCTION DOCUMENTS.
- C. CONTRACTOR TO COORDINATE ALL NEW EQUIPMENT LOCATIONS WITH ALL TRADES PRIOR TO INSTALLATION.
- D. CONTRACTOR TO PROVIDE GALVANIC PROTECTION AS REQUIRED AT CONNECTIONS BETWEEN ALL DISSIMILAR METALS.
- E. ANY FLOOR, WALL, OR CEILING CUTTING OR FILLING THAT IS REQUIRED TO COMPLETE THIS PROJECT, THE CONTRACTOR SHALL PATCH AND PAINT AND RETURN TO MATCH EXISTING CONDITIONS AND FINISHES.
- F. CONTRACTOR TO PROVIDE ESCUTCHEONS ON ALL NEW EXPOSED EXTERIOR PIPE PENETRATIONS AND SEAL COMPLETELY.
- G. CONTRACTOR TO PROVIDE TEMPORARY FLOORING WHILE MODIFYING SUBFLOORING.
- H. ANY LANDSCAPE, HARDSCAPE, FIXTURE, SIGNAGE AND SYSTEMS OR PEDESTRIAN CONTROL DEVICES WITHIN THE TEMPORARY ACCESSIBLE PATHWAY SHALL BE PROTECTED IN PLACE OR TEMPORARILY RELOCATED AS NECESSARY FOR CONTINUED UNINTERRUPTED OPERATION, ACCESS, MAINTENANCE AND / OR VISIBILITY.
- I. REFER TO A-101, A-101A, AND A-101B FOR ARCHITECTURAL NOTES, COORDINATION AND LOCATION OF ENLARGED DRAWINGS, DETAILS, AND SECTIONS.
- J. REFER TO A-111A AND A-111B FOR DETAILED ARCHITECTURAL DIMENSIONS OF INTERIOR AND EXTERIOR ELEMENTS.
- K. FINISHES, FURNITURE AND FURNISHINGS ARE NOT SHOWN ON ARCHITECTURAL PLANS FOR CLARITY. REFER TO INTERIOR PLANS FOR FINISH AND FURNISHING INFORMATION.

KEYNOTES

- 1. FURNITURE IS HIDDEN FOR CLARITY. REFER TO FURNITURE PLANS FOR ADDITIONAL INFORMATION.
- 2. ALIGN FACE OF WALL FINISHES. COORDINATE WITH PARTITION TYPES AND STUD FRAMING.
- 3. RECESSED DISPLAY CASE. TYP ALL SITTING ALCOVE AREAS; REFER TO INTERIOR SHEETS FOR MORE INFORMATION.
- 4. I.T. RACKS REFER TO ELECTRICAL PLANS FOR MORE INFORMATION.
- 5. EXPANSION JOINT
- 6. PEDESTAL FOR DOOR PUSH PLATE AND CARD READER. SEE ELECTRICAL FOR MORE INFORMATION.
- 7. DEDUCTIVE ALTERNATE 14; REFER TO RCP SHEETS FOR PATIENT LIFT BOUNDARY INFORMATION.
- 8. STEEL SUPPORTS FOR SHOWER SEAT SUPPORT SEE A1 & A3/A-554
- 9. STEEL SUPPORTS FOR UP-SWING GRAB BAR SEE E1/A-554
- 10. RAIN CHAIN AND ANCHOR
- 11. SOFFIT ABOVE

KEY PLAN

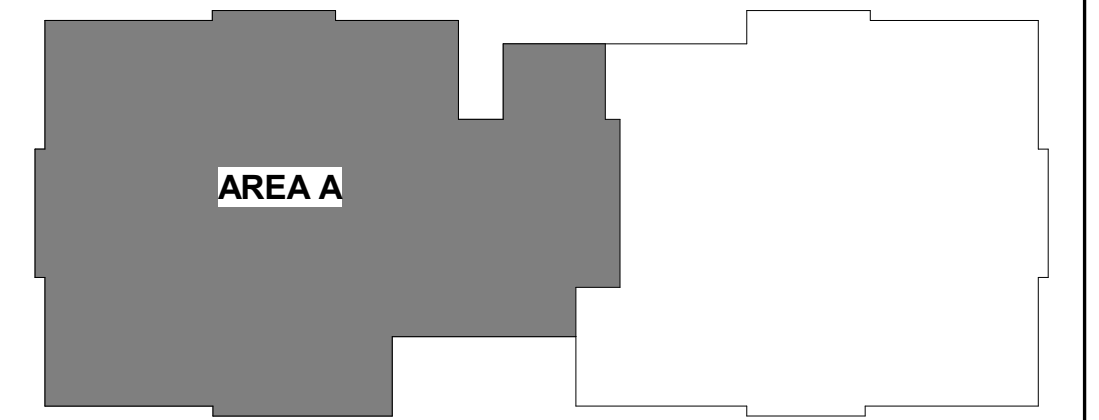

KEY PLAN

DEDUCTIVE ALTERNATES:

- (DEDUCTIVE ALTERNATES ARE CASCADING AND MUST BE EXERCISED IN THE ORDER PRESENTED) FOR A DETAILED DESCRIPTION OF EACH DEDUCTIVE ALTERNATE REFER TO COVER SHEET G000
- DEDUCTIVE ALTERNATE #1: REDUCE WATER AND ICE SHIELD COVERAGE
- DEDUCTIVE ALTERNATE #2: ELIMINATE TUNNEL (EAST EGG)
- DEDUCTIVE ALTERNATE #3: ELIMINATE FAUX WINDOWS AT CLEARSTORY
- DEDUCTIVE ALTERNATE #4: ELIMINATE WORK AT B6 CORRIDOR
- DEDUCTIVE ALTERNATE #5: ELIMINATE CONCRETE
- DEDUCTIVE ALTERNATE #6: ELIMINATE LANDSCAPE
- DEDUCTIVE ALTERNATE #7: REDUCE PLATFORM AT CHILLER
- DEDUCTIVE ALTERNATE #8: ELIMINATE VVR SECURITY
- DEDUCTIVE ALTERNATE #9: ELIMINATE LARGE PORCH
- DEDUCTIVE ALTERNATE #10: ELIMINATE SMALL PORCH A
- DEDUCTIVE ALTERNATE #11: ELIMINATE SMALL PORCH B
- DEDUCTIVE ALTERNATE #12: ELIMINATE ENTRANCE CANOPY
- DEDUCTIVE ALTERNATE #13: ELIMINATE FENCE/FAUX ROOFS AT RESIDENT ROOMS
- DEDUCTIVE ALTERNATE #14: ELIMINATE PATIENT LIFT TRACK EXTENSIONS INTO RESIDENT RESTROOMS
- DEDUCTIVE ALTERNATE #15: REDUCE THE POROUS ASPHALT / PARKING / PORTION OF DRIVE ENTRANCE
- DEDUCTIVE ALTERNATE #16: ELIMINATE EXTERIOR SIGNAGE

F1 ARCHITECTURAL PLAN - ENLARGED COVERED WALKWAY
1/8" = 1'-0"

F3 ARCHITECTURAL FLOOR PLAN - LEVEL 1 - AREA A
1/8" = 1'-0"

CONSULTANT NORRIS DESIGN Landscape Architect 416 North Toole Avenue Tucson, AZ 85701 (520) 622-9565 Josh Orth, PLA		HINMAN Protective Design Specialist 240 West 35th St, Suite 1004 New York, NY 10001 (212) 967-4890 Corinne Tate, SE		C.S. Davidson, Inc. Structural 315 West James Street, Suite 102 Lancaster, PA 17603 (717) 481-2991 Jason Vannoy, SE, PE		MES GROUP MEP 550 North Roe Street, Suite 203 Tampa, FL 33609 (813) 289-4700 Nicholas Stephenson, PE		ARCHITECT/ENGINEER OF RECORD A/E: TRIPLE C - The A/E Group 201 E. Jefferson Street, Suite 200 Syracuse, NY 13202 (315) 484-5958 Mat Perkins		STAMP OFFICE OF CONSTRUCTION AND FACILITIES MANAGEMENT U.S. Department of Veterans Affairs		Drawing Title ARCHITECTURAL FLOOR PLAN - LEVEL 1 - AREA A		Phase ISSUED FOR CONSTRUCTION FULLY SPRINKLERED		Project Title NEW COMMUNITY LIVING CENTER		Location 2094 Albany Post Road, Montrose, NY 10548		Issue Date 05/09/2022		Checked M. PERKINS		Drawn N. BLANCHARD		Project Number 620-334		Building Number CLC		Drawing Number A-101A	
---	--	---	--	---	--	--	--	--	--	---	--	---	--	--	--	---	--	--	--	---------------------------------	--	------------------------------	--	------------------------------	--	----------------------------------	--	-------------------------------	--	---------------------------------	--