
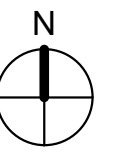
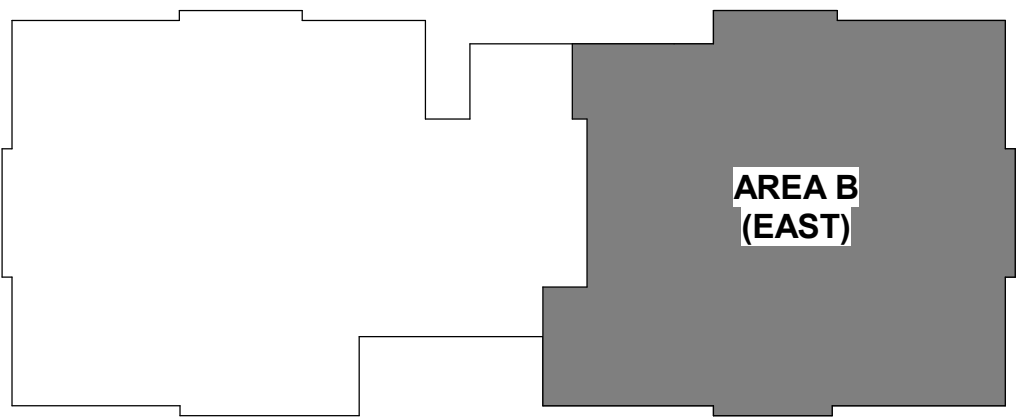
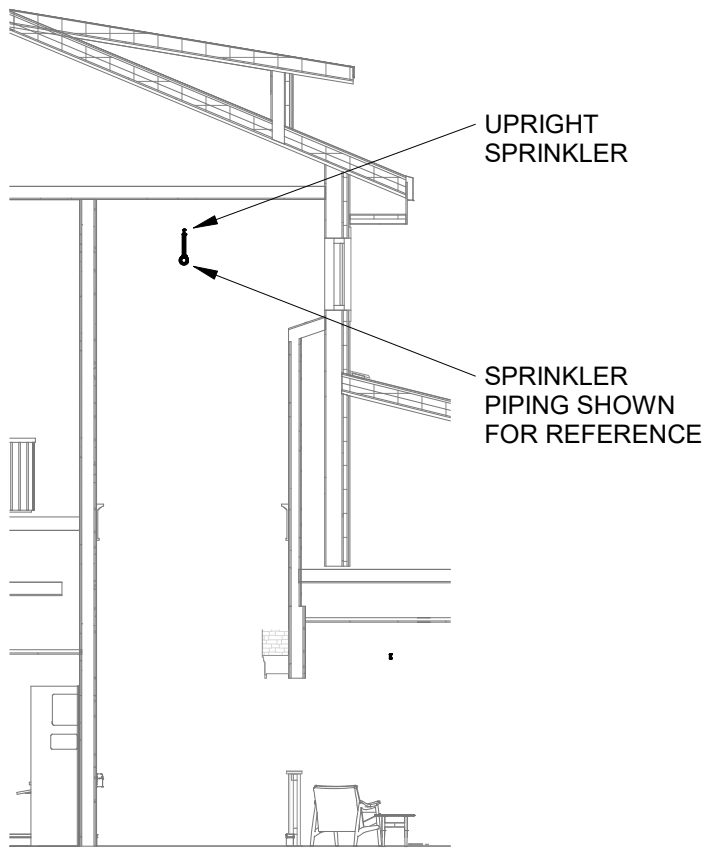
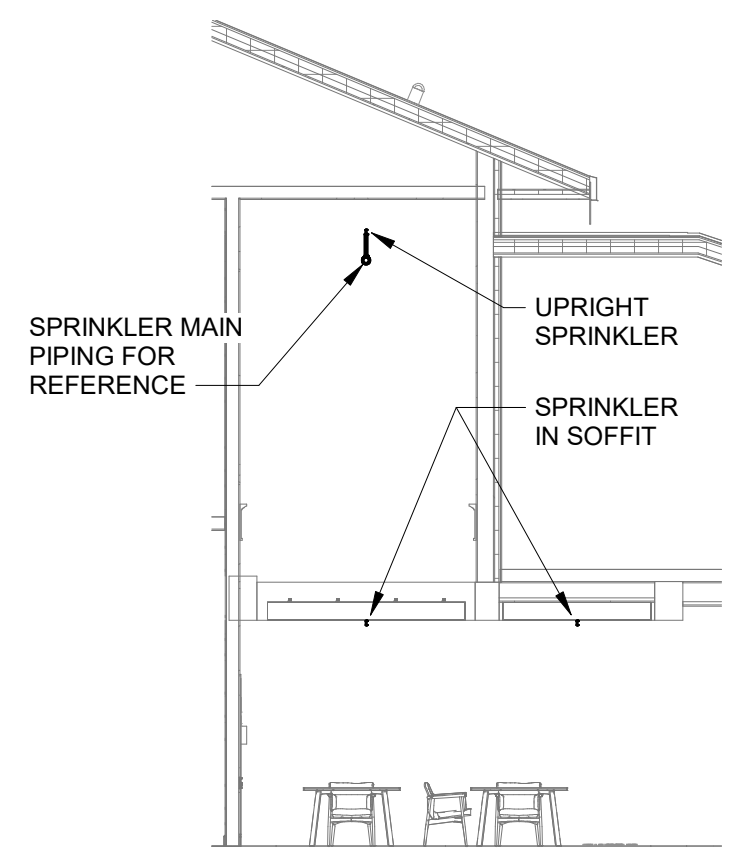


FIRE SPRINKLER LEGEND	
●	PENDENT SPRINKLER
×	UPRIGHT SPRINKLER
⊗	UPRIGHT SPRINKLER WITH CAGE
◁	SIDEWALL SPRINKLER

KEYNOTES	
1	SPRINKLER SHALL BE MOUNTED TO THE SOFFIT, ASSOCIATED SPRINKLER PIPING SHALL BE ROUTED IN THE SOFFIT.
2	SPRINKLER ZONE VALVE ASSEMBLY, REFER TO DETAIL FOR MORE INFORMATION.
3	INSPECTOR TEST DRAIN, REFER TO DETAIL FOR MORE INFORMATION.
4	PAINT EXPOSED SPRINKLER PIPING IN THIS ROOM RED.

PARTITION RATING GRAPHICS:	
PARTITIONS REQUIRED TO BE SMOKE RESISTANT, FIRE RESISTANT, OR BOTH FIRE AND SMOKE RESISTANT ARE SHOWN GRAPHICALLY ON PLANS WITH HATCH PATTERNS.	
PARTITION RATING GRAPHIC DESIGNATION:	PRIORITY
1 HIGHEST	4 HR FIRE BARRIER
2	3 HR FIRE BARRIER
3	2 HR FIRE BARRIER
4	2 HR FIRE BARRIER/SHAFT
5 LOWEST	1 HR FIRE & SMOKE BARRIER
	1 HR FIRE BARRIER
	1 HR FIRE BARRIER/SHAFT
	SMOKE PARTITION (NON RATED)
	NON RATED

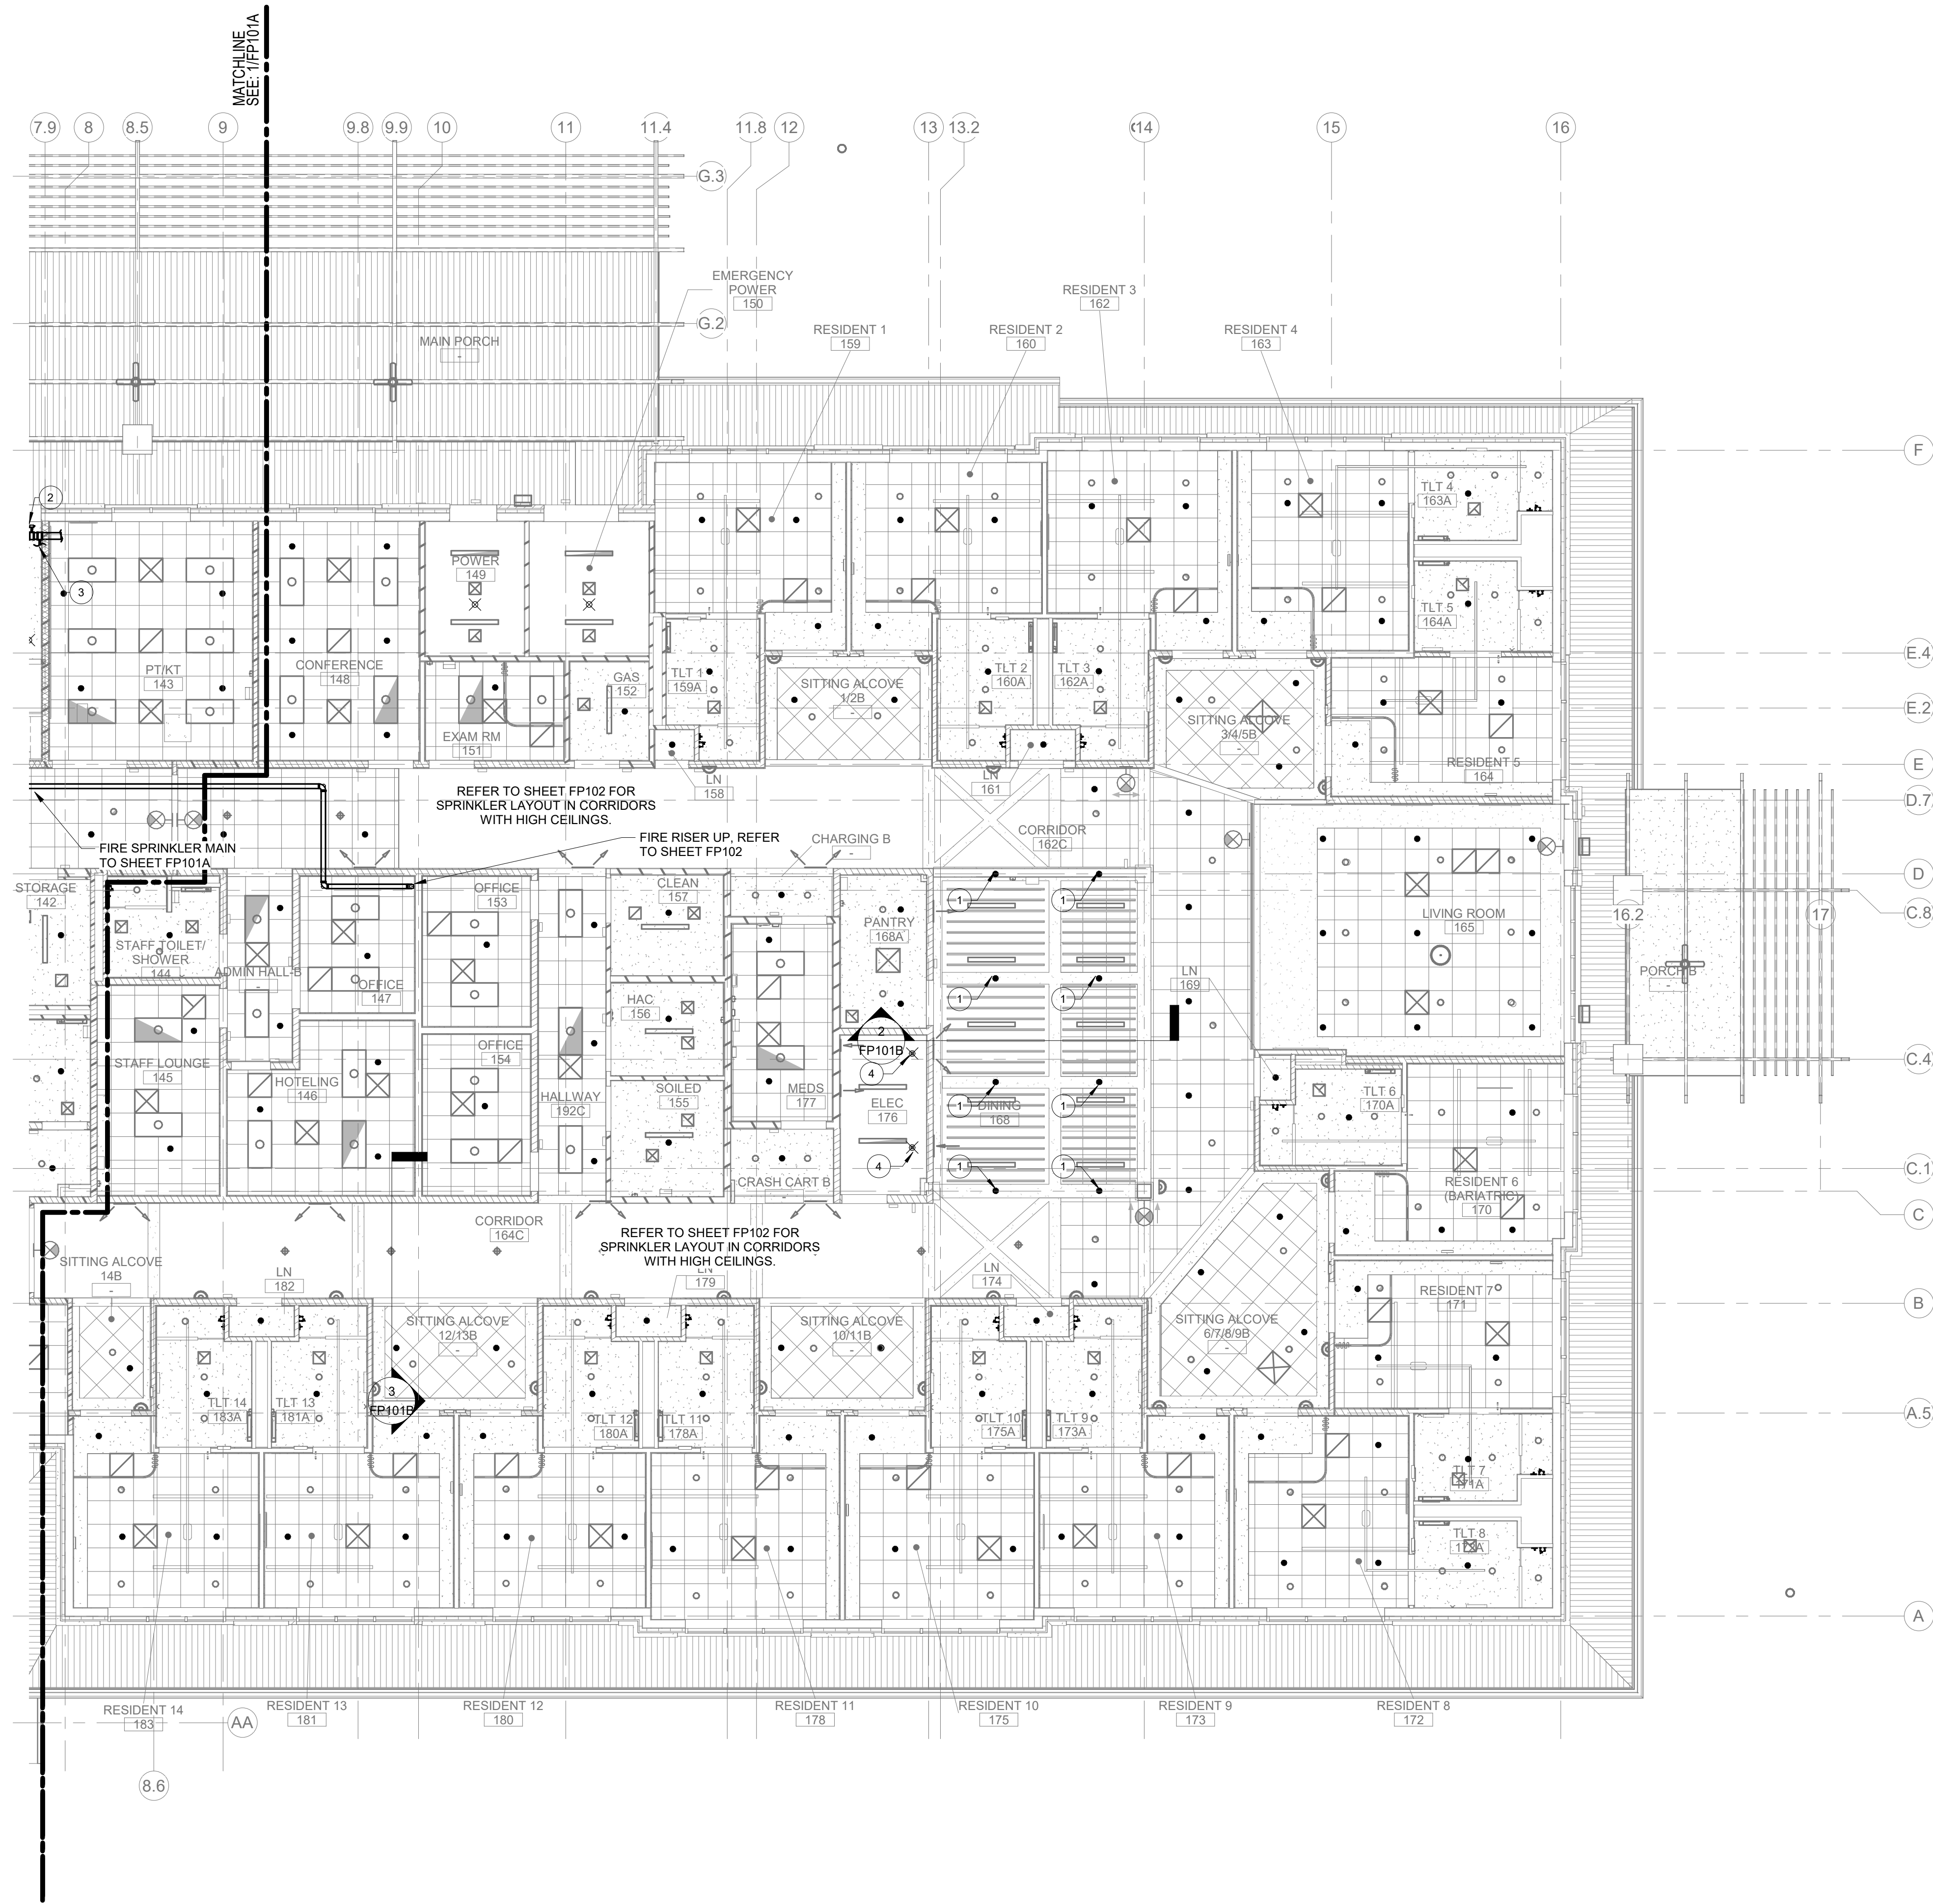

1 FIRE SPRINKLER FLOOR PLAN - LEVEL 1 - AREA B
1/8" = 1'-0"

2 DINING 168 SECTION
1/8" = 1'-0"

3 CORRIDOR 164C SECTION
1/8" = 1'-0"

KEY PLAN

Revisions:	Date:

CONSULTANT

NORRIS DESIGN
Landscape Architect
416 North Toole Avenue
Tucson, AZ 85701
(520) 622-9565
Josh Orth, PLA

HINMAN
Protective Design Specialist
240 West 35th St. Suite 1004
New York, NY 10001
(212) 967-4890
Corrine Tan, SE

C.S. Davidson, Inc.
Structural
515 West James Street, Suite 102
Lancaster, PA 17603
(717) 481-2991
Jason Vannoy, SE, PE

MES GROUP
MEP
550 North Roo Street, Suite 203
Tampa, FL 33609
(813) 289-4700
Nicholas Stephenson, PE

ARCHITECT/ENGINEER OF RECORD
A/E:
TRIPLE C - The A/E Group
201 E. Jefferson Street, Suite 200
Syracuse, NY 13202
(315) 484-5958
Mat Perkins

TRIPLE C - THE A/E GROUP
A MULTI-DISCIPLINARY COMPANY

STAMP

Office of Construction and Facilities Management
U.S. Department of Veterans Affairs

Drawing Title
FIRE SPRINKLER FLOOR PLAN - LEVEL 1 - AREA B

Approved:

Phase
ISSUED FOR CONSTRUCTION

FULLY SPRINKLERED

Project Title
NEW COMMUNITY LIVING CENTER

Location
2094 Albany Post Road, Montrose, NY 10548

Issue Date
05/09/2022

Checked
CJF/NPS

Drawn
TMR

Project Number
620-334

Building Number
CLC

Drawing Number
FP101B

B:\620-334 New Community Living Center\15871_MEP-VA Montrose CLC_PSD.rvt 7/21/2021 1:32:30 PM