


<u>PARTITION RATING GRAPHIC DESIGNATION:</u>	<u>PRIORITY</u>
4 HR FIRE BARRIER	1 HIGHEST
3 HR FIRE BARRIER	2
2 HR FIRE & SMOKE BARRIER	3
2 HR FIRE BARRIER/SHAFT	
1 HR FIRE & SMOKE BARRIER	4
1 HR FIRE BARRIER	
1 HR FIRE BARRIER/SHAFT	5 LOWEST
SMOKE PARTITION (NON RATED)	
NON RATED	

DEDUCT ALTNERATIVE #9 : ELIMINATE LARGE PORCH
DEDUCT ALTNERATIVE #11 : ELIMINATE SMALL PORCH-B

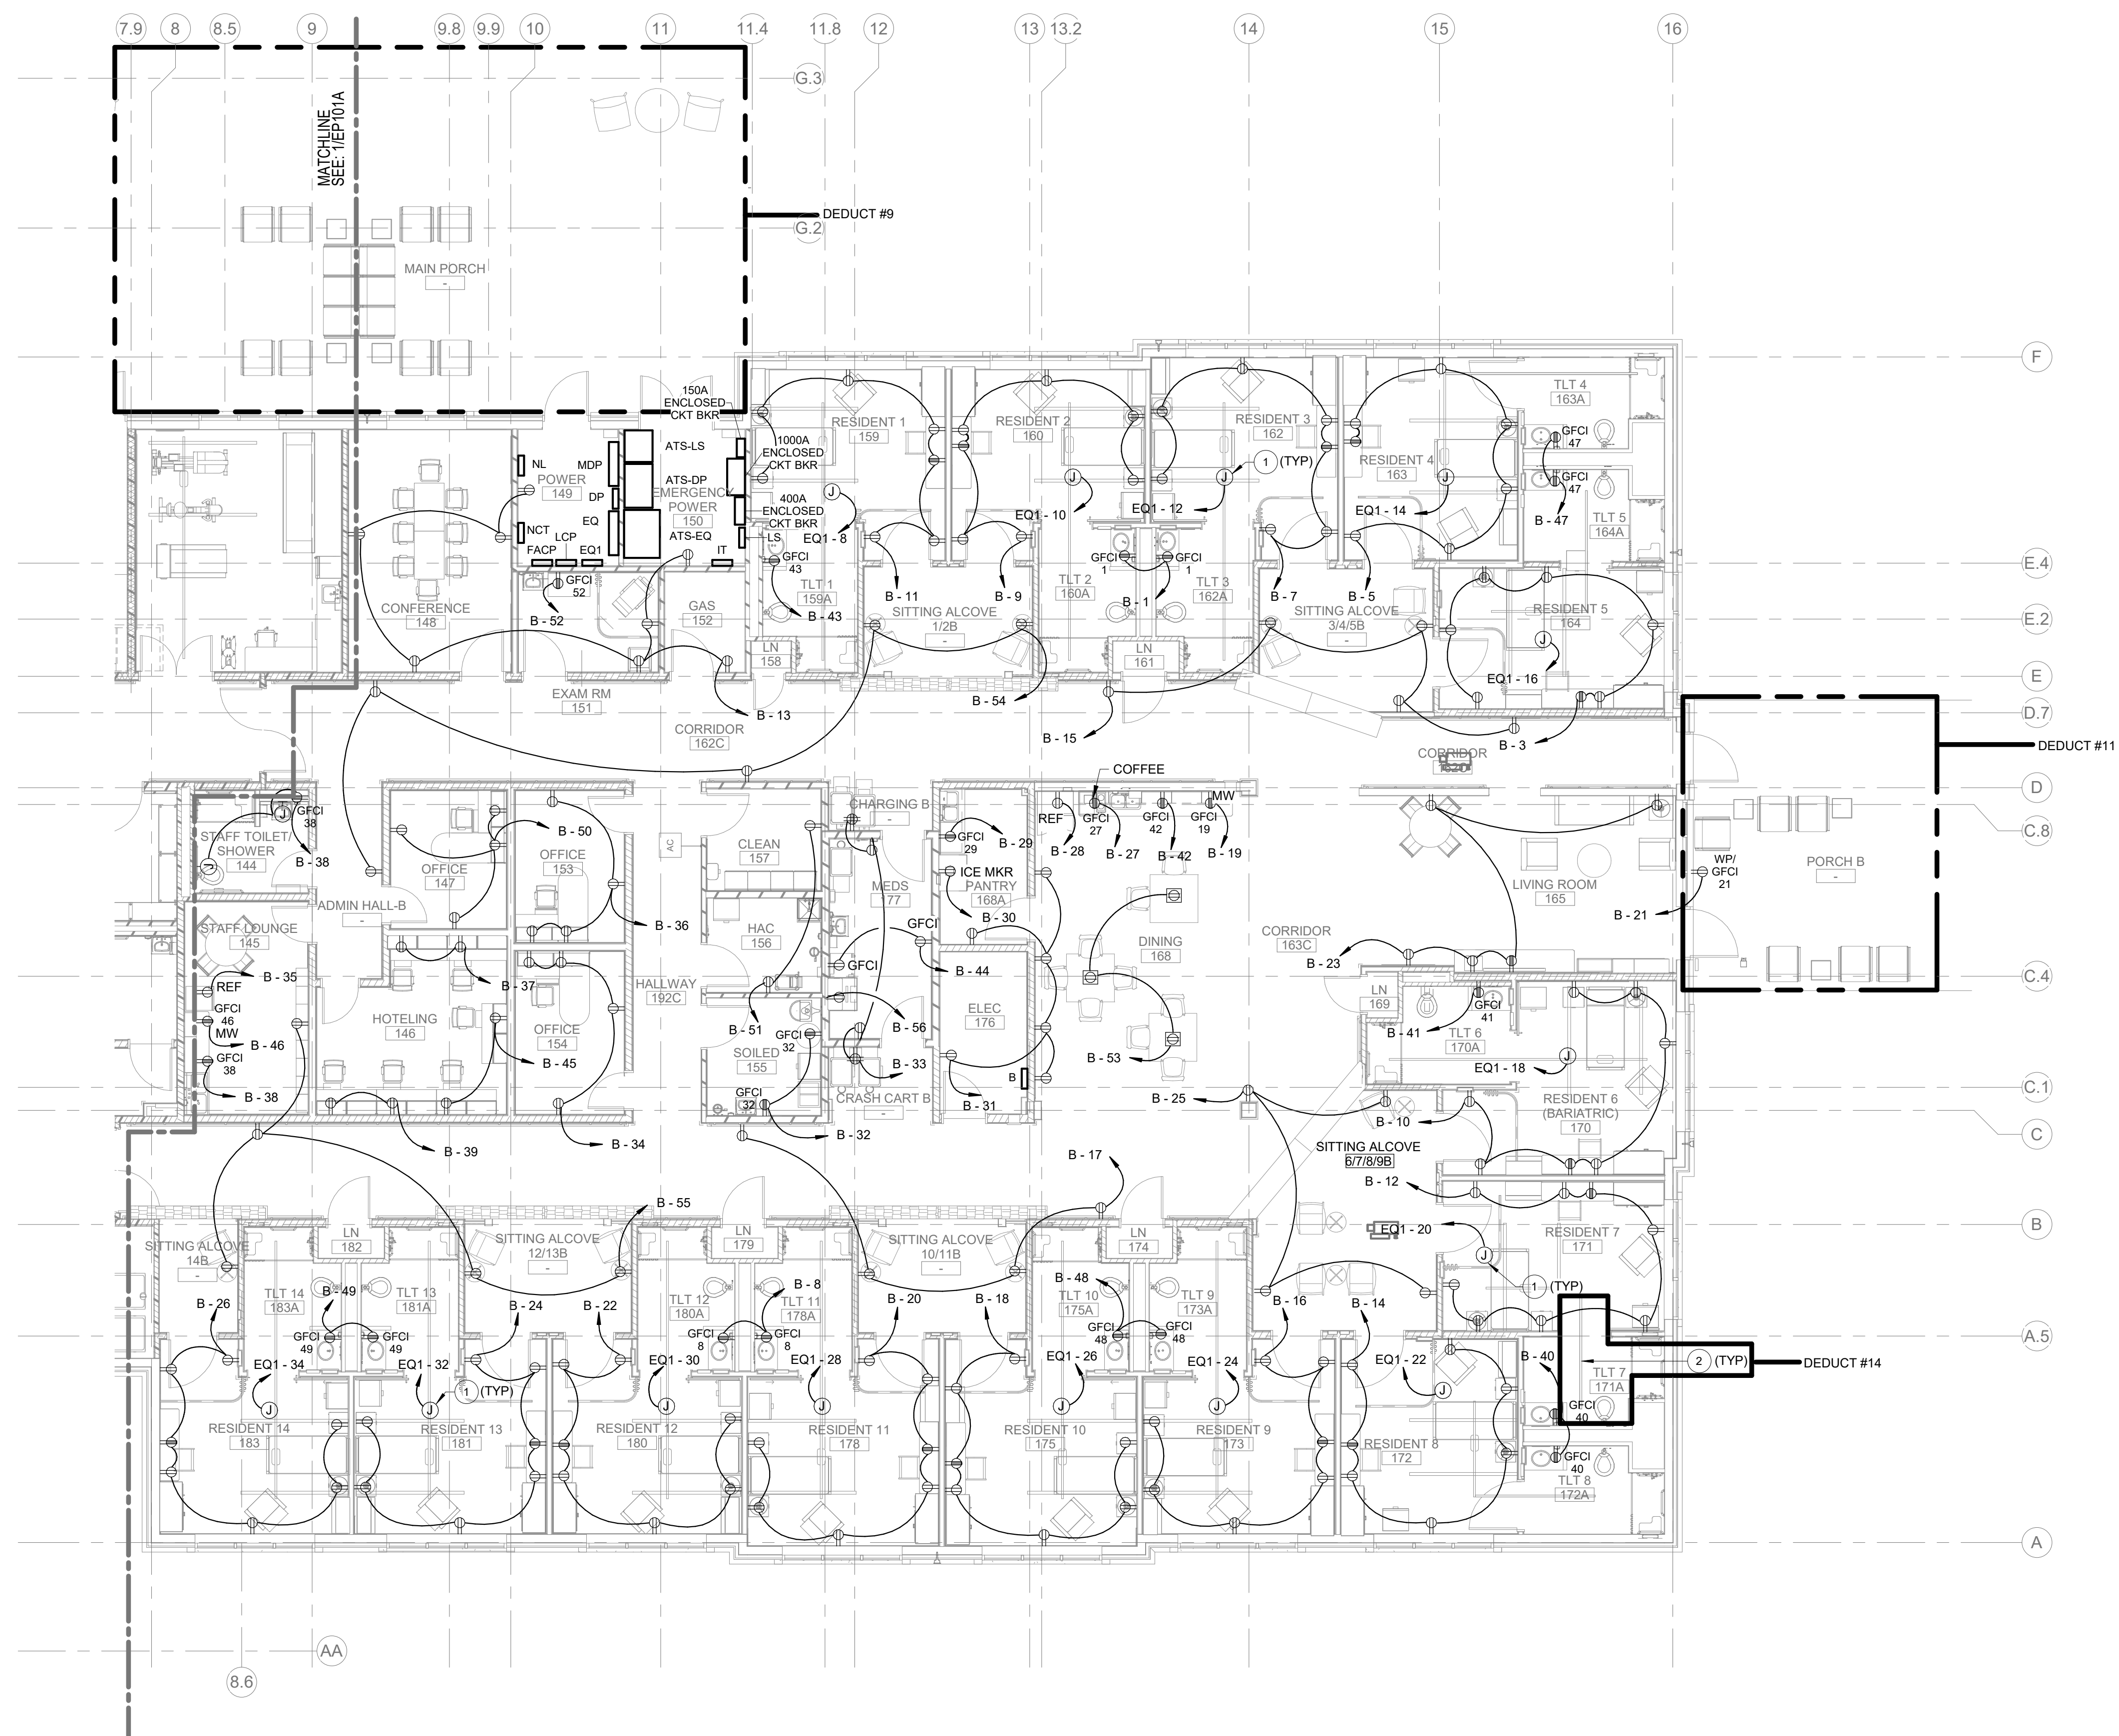


1 POWER FLOOR PLAN - LEVEL 1 - AREA B
1/8" = 1'-0"

	TRANSFORMER
	MOTOR CONNECTION - NUMERAL INDICATES HP
	DISCONNECT SWITCH - FUSED - AMPS/FUSE/POLE/NEMA
	DISCONNECT SWITCH - NON-FUSED - AMPS/IN/POLES/NEMA
	DISCONNECT SWITCH - MOTOR/STARTER COMBINATION
	VARIABLE FREQUENCY DRIVE
	CONTROL PANEL
	JUNCTION BOX OR PULL BOX
	WALL MOUNTED JUNCTION BOX OR PULL BOX
	TIMECLOCK (REFER TO PLANS)
	DUPLEX RECEPTACLE (18" AFF)
	DOUBLE DUPLEX RECEPTACLE (18" AFF)
	DUPLEX RECEPTACLE - FLOOR BOX
	SIMPLEX RECEPTACLE (18" AFF)
	DUPLEX RECEPTACLE MOUNTED 6" ABOVE COUNTER OR BACKSPLASH
	GFCI DUPLEX RECEPTACLE
	GFCI DUPLEX RECEPTACLE WITH WHILE-IN-USE WEATHERPROOF COVER
	SPECIAL RECEPTACLE (18" AFF) 30A, 2P, 3W, 208V, NEMA 6-30R
	PUSH BUTTON

- A. CONTRACTOR SHALL BE RESPONSIBLE FOR IDENTIFICATION OF ALL RATED WALLS, CEILINGS AND SLABS AND THEIR SPECIFIED RATING ON THE ARCHITECTURAL DRAWINGS. ALL DEVICES AND MATERIALS SHALL MEET THE UL RATING OF THE RATED WALLS, CEILINGS AND SLABS ASSEMBLY. CONTRACTOR SHALL PROVIDE AN ASSEMBLY INSTALLED IN ACCORDANCE WITH THE RATED APPLICATION.
- B. ELECTRICAL CONTRACTOR SHALL COORDINATE ELECTRICAL CHARACTERISTICS AND REQUIREMENTS OF ALL MECHANICAL EQUIPMENT WITH MECHANICAL CONTRACTOR PRIOR TO ORDERING/INSTALLATION.
- C. ALL CONTROL WIRING SHALL BE INCLUDED AS PART OF THE MECHANICAL WORK. MECHANICAL CONTRACTOR SHALL ENSURE THAT ELECTRICAL INTERFACE DEVICES THAT ARE NECESSARY IN THE ELECTRICAL COMPONENT ARE COORDINATED WITH THE ELECTRICAL CONTRACTOR.
- D. ALL TELEVISION POWER OUTLETS SHALL BE MOUNTED 60" AFF UNLESS OTHERWISE SPECIFIED. SEE ARCHITECTURAL ELEVATION PLANS FOR ADDITIONAL INFORMATION.
- E. REFER TO ONE-LINE AND PANEL SCHEDULES FOR ADDITIONAL INFORMATION.

2 PATIENT LIFTS TRACK EXTENSION INTO RESIDENT BATHROOMS. REMOVE AS REQUIRED UNDER DEDUCT #14.

DEDUCT #14

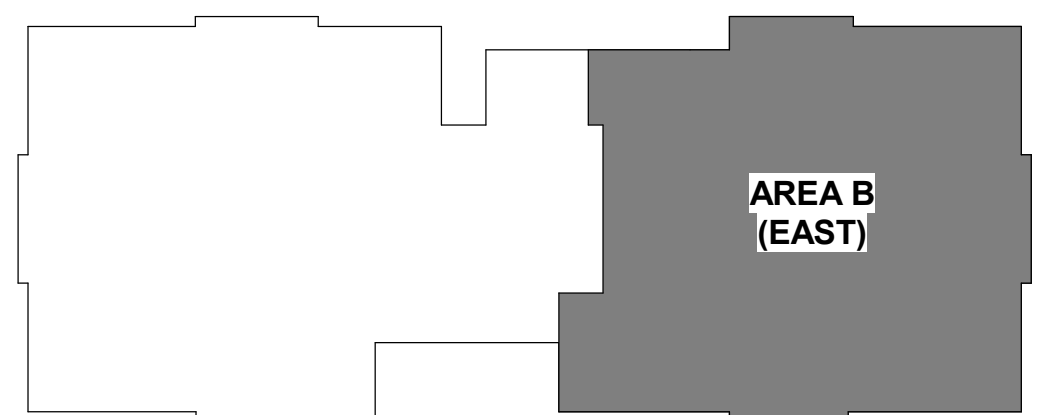

KEY PLAN

[illegible]

Landscape Architect
418 North Toole Avenue
Tucson, AZ 85701
(520) 622-9565
Josh Orth., PLA

Protective Design Specialist
240 West 35th St. Suite 1004
New York, NY 10001
(212) 967-4890
Corrine Tan, SE

Structural
315 West James Street, Suite 102
Lancaster, PA 17603
(717) 481-2991
Jason Vannoy, SE, PE

MEP
550 North Reo Street, Suite
Tampa, FL 33609
(813) 289-4700
Nicholas Stephenson, PE

A/E:
TRIPLE C - The A/E Group
 101 E. Jefferson Street, Suite 200
 Syracuse, NY 13202
 (315) 484-5958
 Pat Perkins



VA | U.S. Department
of Veterans Affairs

Drawing Title
POWER FLOOR PLAN - LEVEL 1 - AREA B

Approved:

Phase	ISSUED FOR CONSTRUCTION
-------	----------------------------

FULLY SPRINKLERED

Project Title
NEW COMMUNITY LIVING
CENTER

Location
2094 Albany Post Road, Montrose, NY 10548

Issue Date	05/09/2022
------------	------------

Checked
DK

Drawn	SC
-------	----

Project Number
620-334

Building Number	CLC
-----------------	-----

Drawing Number

EP101B