


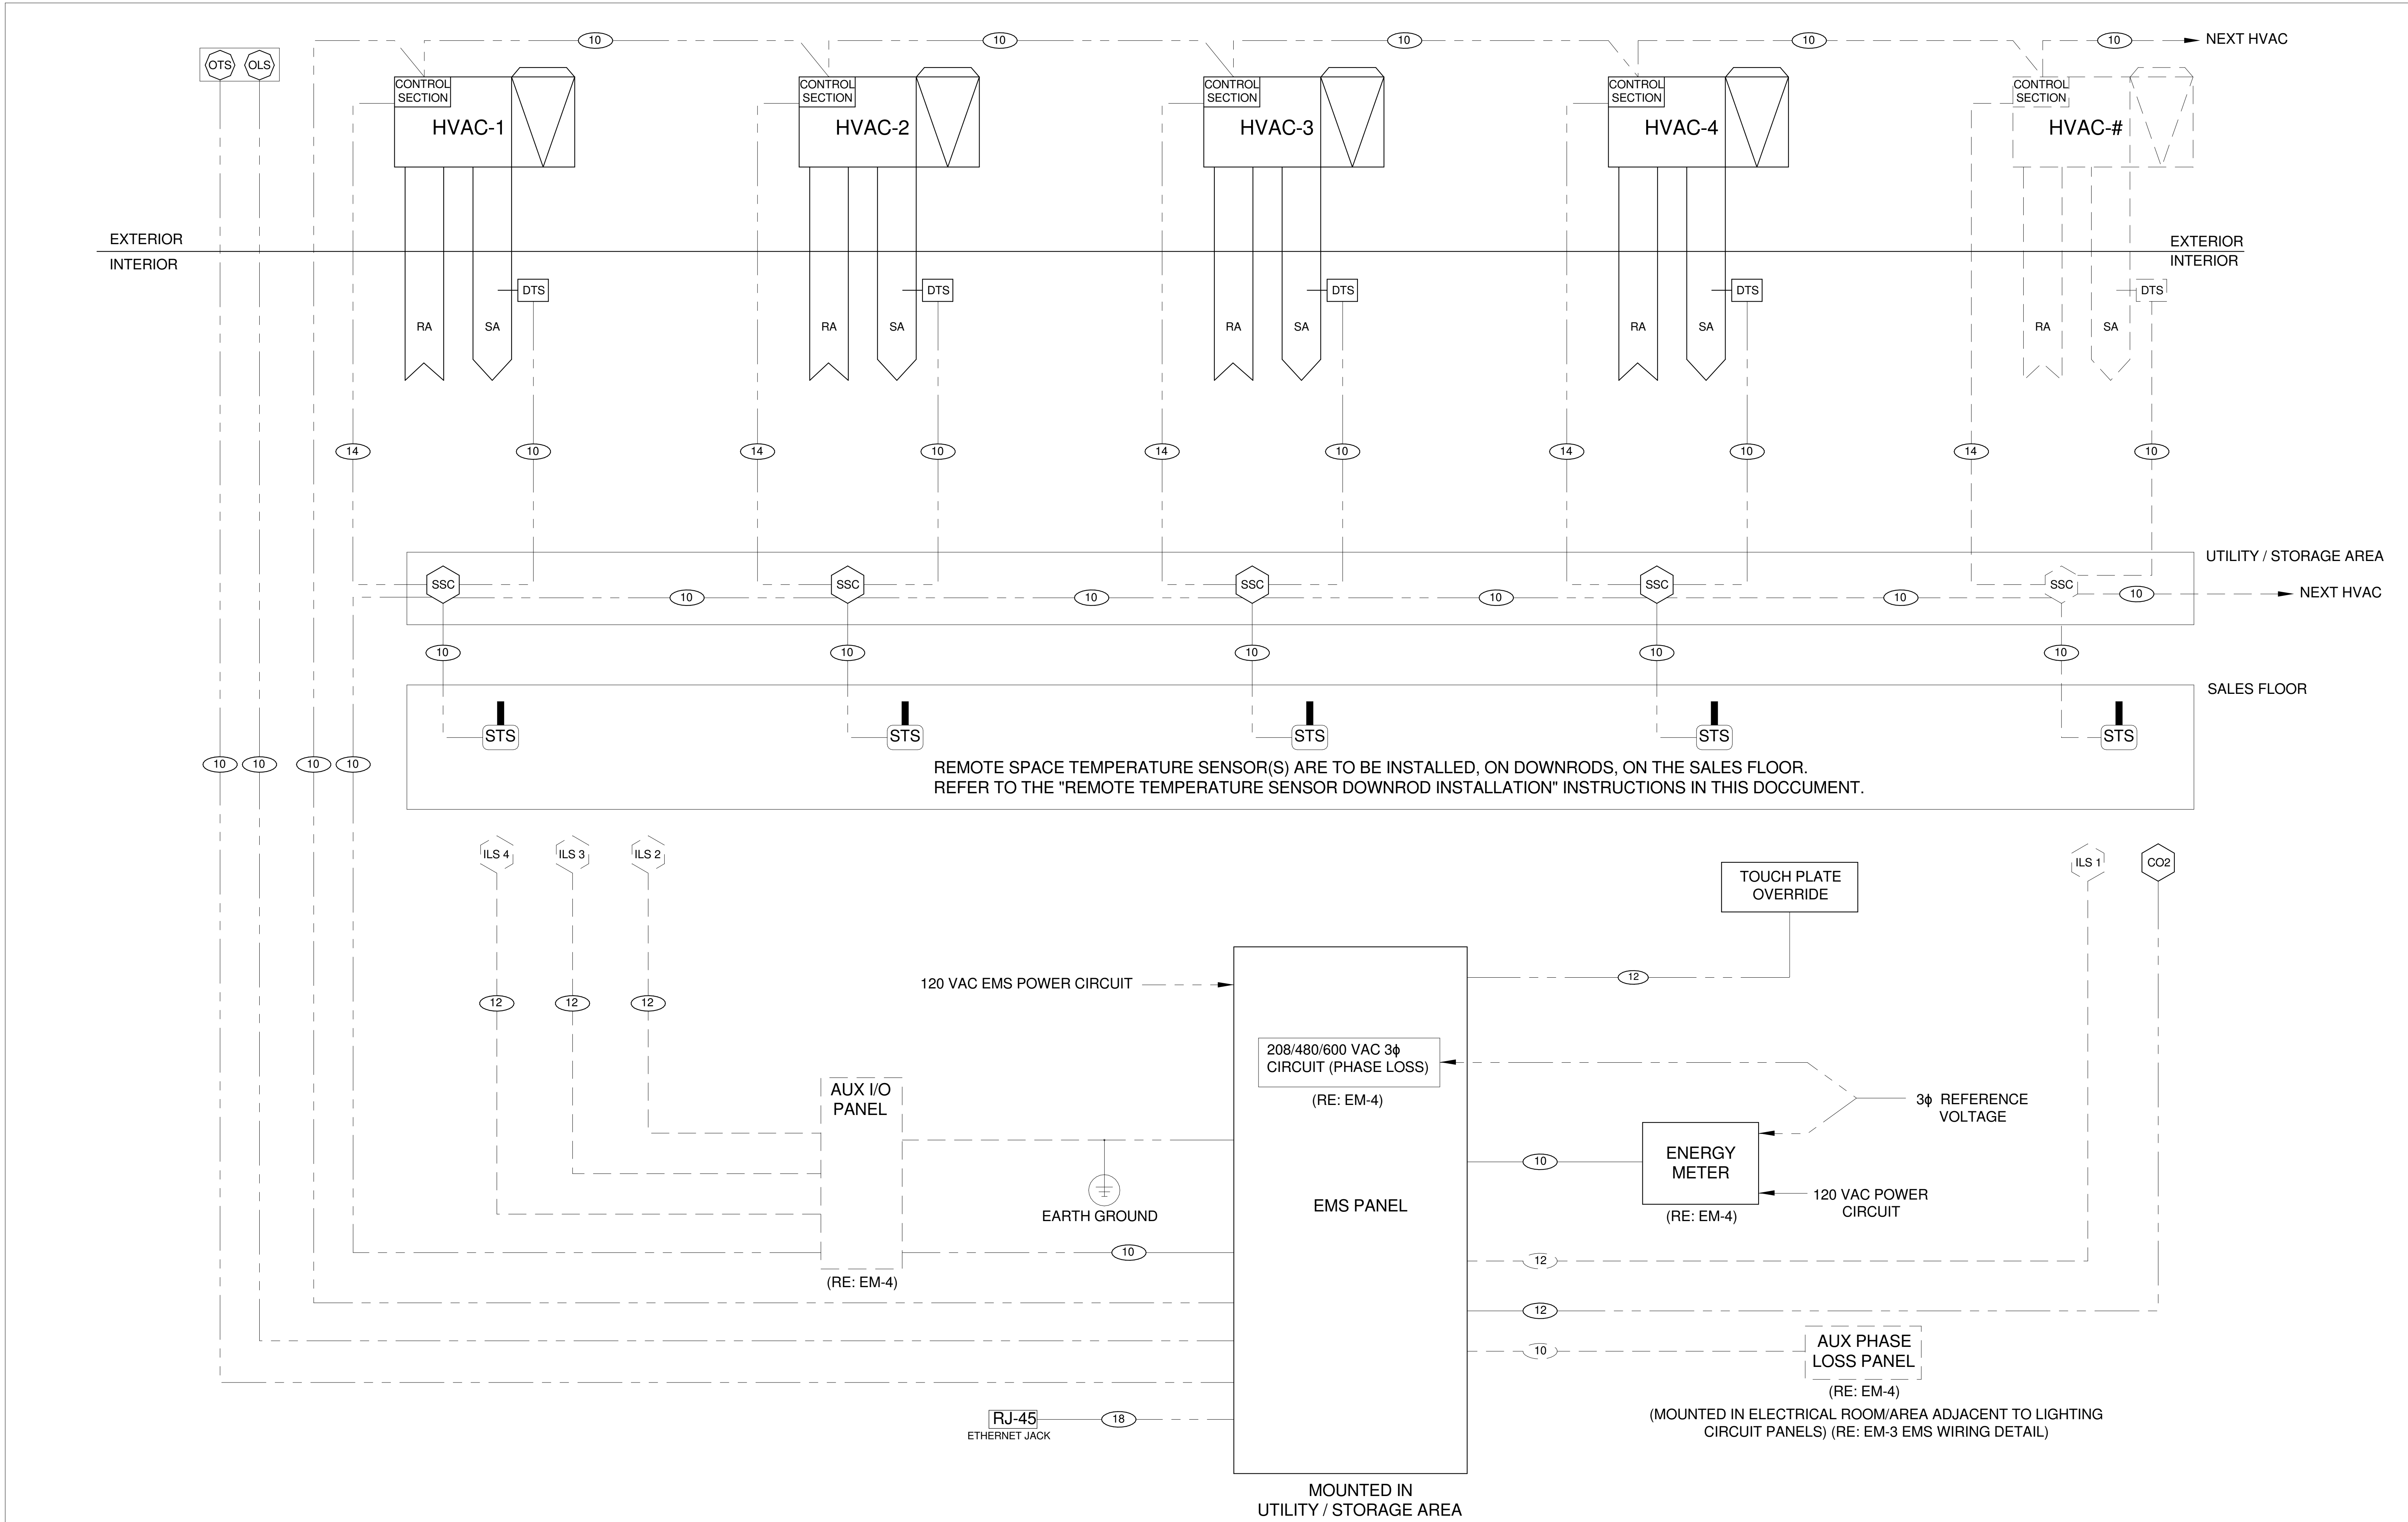

ENERGY MANAGEMENT SYSTEM SINGLE LINE DIAGRAM
SCALE: None

WIRING LEGEND

---	FIELD WIRING
---	POSITIVE
---	NEGATIVE
---	OPTIONAL COMPONENT



25 Sundial Ave - Suite 310 W
Manchester, NH 03103

DOLLAR TREE
LINE DIAGRAM
(FOR REFERENCE ONLY NOT TO SCALE)

REVISION: 1	DATE: 06/05/20	ECN#: 2390
LOOSE DT OPTION		
REVISION: ----	DATE: ----	ECN#: ----
REVISION: ----	DATE: ----	ECN#: ----
REVISION: ----	DATE: ----	ECN#: ----
DRAWN: WPC	CHECKED: CGP	
PART #: 94-402	OPTION: P	

ENERGY
MANAGEMENT
PLAN

EM-2 of 4



description
by
mark
revisions

06/15/2022	06/15/2022	KLH	RNK	LG
date	project	designed	drawn	checked



DOLLAR TREE
166 S. LIBERTY DRIVE - DEAL #13216 / STORE #2573
STONY POINT, NY 10980
EMS DETAILS

project
drawing

sheet
EM-102