



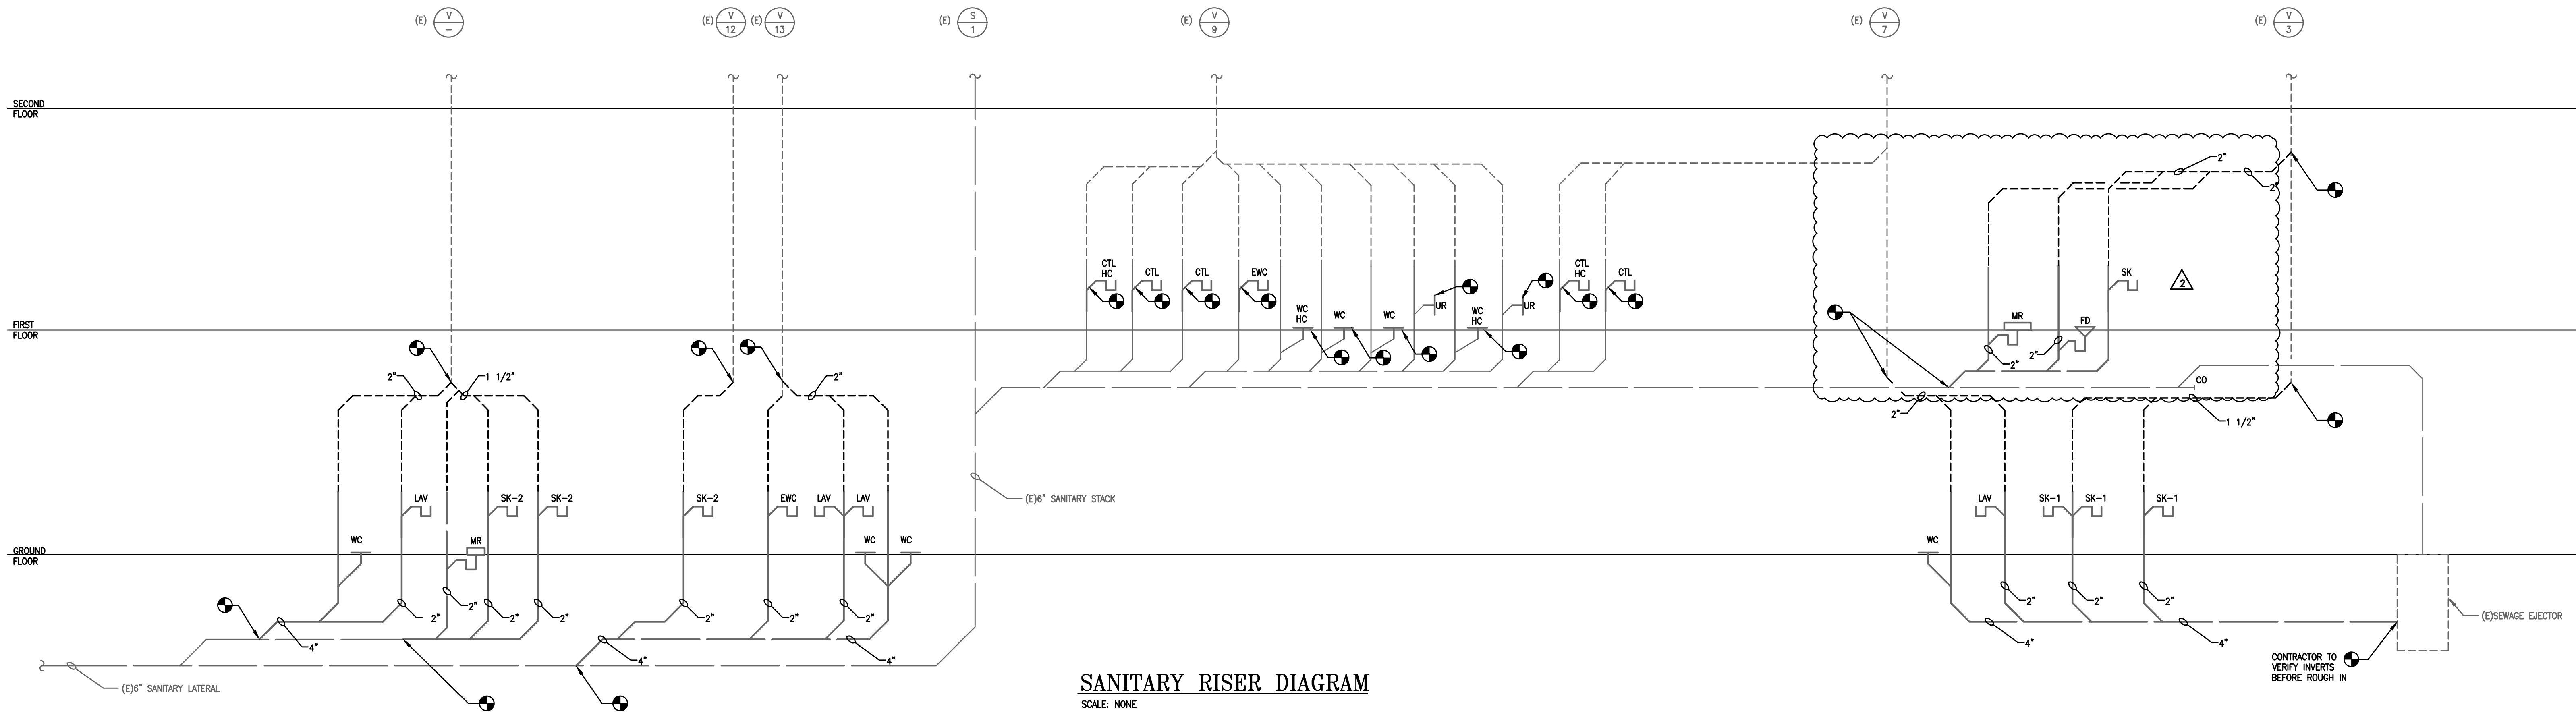

SANITARY RISER DIAGRAM

- SCALE: NONE
- SANITARY RISER DIAGRAM NOTES
1. PROVIDE A TRAP PRIMER AT EVERY FLOOR DRAIN.
 2. PIPING SHALL BE SLOPED AT AN 1/8" PER UNIT FOR 3" PIPE AND ABOVE.
 3. PIPING SHALL BE SLOPED AT A 1/4" PER UNIT FOR 2-1/2" PIPE OR SMALLER UNLESS OTHERWISE NOTED.
 4. PROVIDE A CLEAN OUT AT THE BASE OF EVERY STACK, AT THE END OF THE RUN, AT EVERY CHANGE IN DIRECTION AND 50'-0" ON CENTER FOR STRAIGHT LENGTHS.
 5. REFER TO PLUMBING FIXTURE SCHEDULE FOR FIXTURE BRANCH PIPE SIZING.
 6. ALL UNDERGROUND SANITARY PIPING SHALL BE 2" MINIMUM PIPE SIZE.

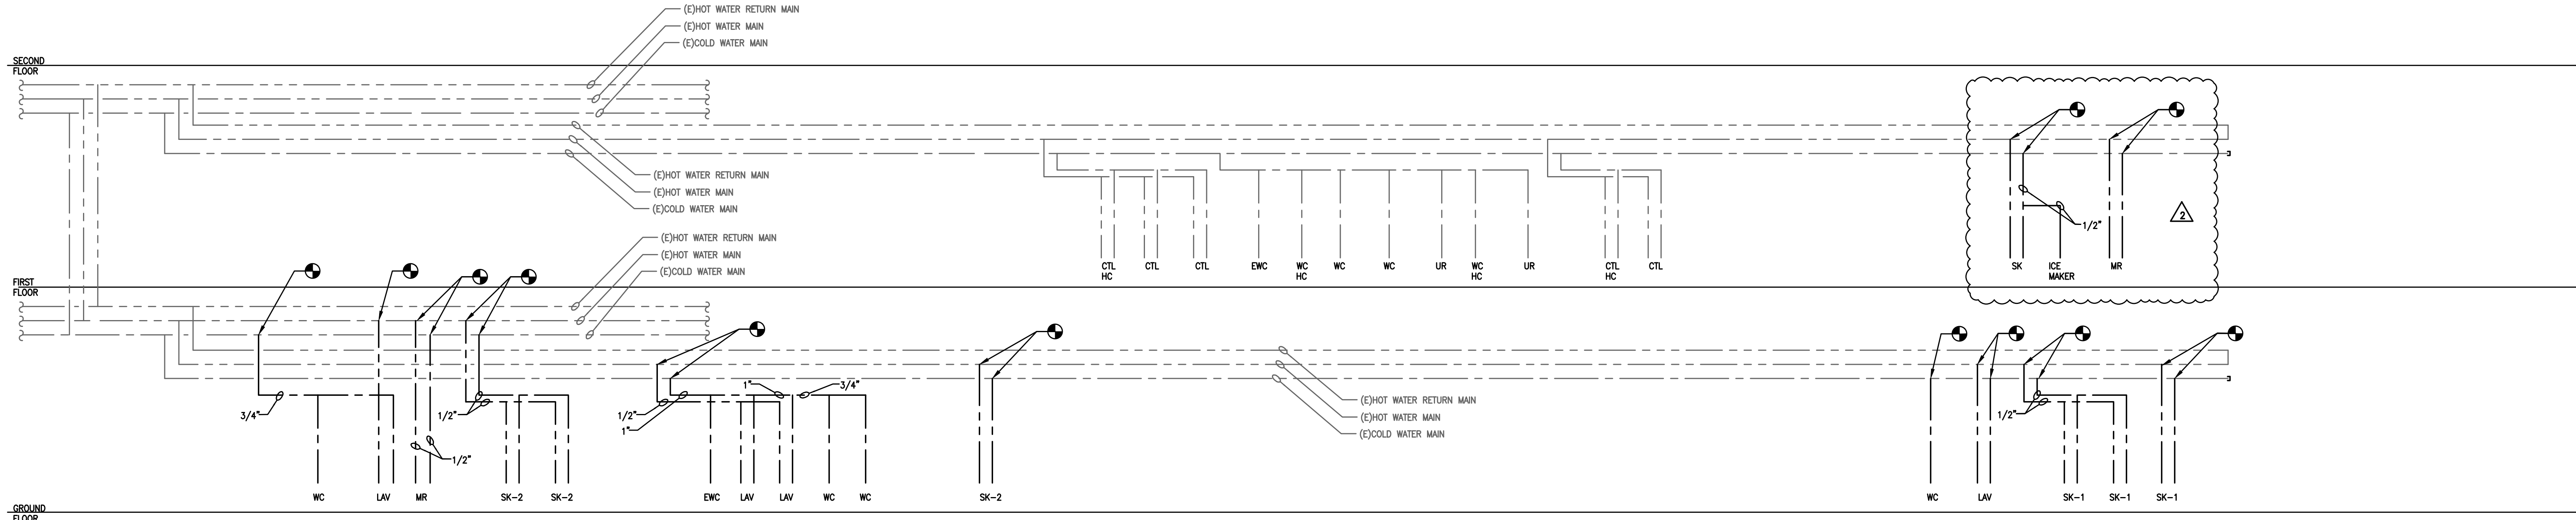


DOMESTIC WATER RISER DIAGRAM

- SCALE: NONE
- DOMESTIC WATER RISER DIAGRAM NOTES
1. PROVIDE A TRAP PRIMER AT EVERY FLOOR DRAIN.
 2. PROVIDE A SHUT OFF VALVE AT EACH PIECE OF EQUIPMENT.
 3. PROVIDE A CHECK VALVE AND BALANCING VALVE AT EVERY DOMESTIC HOT WATER RETURN BRANCH / LOOP. THE CONTRACTOR IS RESPONSIBLE TO PROVIDE A CERTIFIED BALANCING REPORT ON EACH HOT WATER RETURN SYSTEM.
 4. REFER TO PLUMBING FIXTURE SCHEDULE FOR FIXTURE BRANCH PIPE SIZING.

THE DELIVERY OF THIS DRAWING SHOULD NOT BE CONSTRUED TO PROVIDE AN EXPRESS WARRANTY OR GUARANTEE TO ANYONE THAT ALL THE DIMENSIONS AND DETAILS ARE EXACT OR TO INDICATE THAT THE USE OF THIS DRAWING IMPLIES THE REVIEW AND APPROVAL BY THE DESIGN PROFESSIONAL OF ANY FUTURE USE. ANY USE OF THIS INFORMATION WITHOUT THE WRITTEN APPROVAL BY THE DESIGN PROFESSIONAL IS AT THE SOLE RISK AND LIABILITY OF THE USER. THE DESIGN PROFESSIONAL RESERVES THE RIGHT TO REMOVE OUR PROFESSIONAL SEAL AND/OR TITLE BLOCK.

NOTICE
THE SCHEDULES AND DRAWINGS REPRESENT ONLY CERTAIN REQUIREMENTS OF THE PROJECT. THERE ARE ADDITIONAL REQUIREMENTS IN THE SPECIFICATIONS BOOKLET WHICH THE CONTRACTOR IS BOUND TO PROVIDE. A SUPPLIER OR CONTRACTOR'S PRICING, WHICH IS BASED ONLY ON DRAWINGS OR SCHEDULES, MAY LEAVE IMPORTANT COSTS UNACCOUNTED FOR WHICH WILL ULTIMATELY BE THE CONTRACTOR OR SUPPLIER'S RESPONSIBILITY TO PROVIDE.

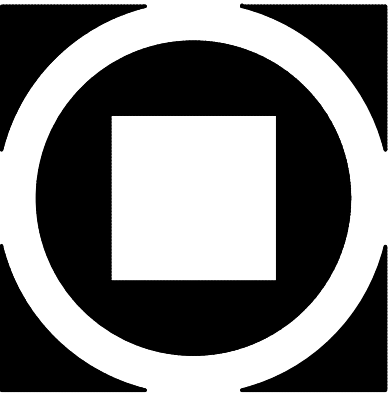

KIMMEL BOGRETTE
Architecture + Site
482 Norrisown Road, Suite 200
Blue Bell, PA 19422
Phone: 610.834.7805
Facsimile: 610.834.7815
© COPYRIGHT 2021 KIMMEL BOGRETTE ARCHITECTURE + SITE, INC. ALL RIGHTS RESERVED



MOUNT SAINT MARY COLLEGE, GUZMAN HALL
COMMUNITY WELLNESS CENTER
330 POWELL AVE.
NEWBURGH, NY 12550

Construction Issue Date:
Drawn By: AFMZ/PR
Checked By:
Scale: AS NOTED

Sheet Name: DETAILS & SCHEDULES - PLUMBING	Revisions:	
	Progress Prints:	
	Bid Set (08/09/21)	