

NEW REFRIGERANT LINE SETS
(4 TOTAL) UP THE EXTERIOR WALL
AND ONTO ROOF. COORDINATE
ROUTING WITH EXISTING SECURITY
CAMERA AND JUNCTION BOX
LOCATED AT 2ND FLOOR LEVEL.
SEE HE-101 FOR CONTINUATION

EXISTING TREE
TO REMAIN

STEP WALL FROM
4' HIGH TO
1' HIGH
AS REQUIRED

NEW CONDENSING UNIT CU-1

2" THICK, ½" CRUSHED
STONE OVER FILTER
FABRIC THROUGHOUT
EQUIPMENT AREA

4' HIGH
RETAINING WALL

PERFORATED RETAINING
WALL DRAIN PIPE WITH
OUTLET TO DAYLIGHT

M1-25,27,29

PROVIDE NEW 6"
HOUSEKEEPING PAD FOR
CU-1. SEE DETAIL 7/HE-701

EXISTING CARRIER UNIT TO REMAIN

EXISTING HOUSEKEEPING PAD TO REMAIN

EXISTING GAS PIPING TO REMAIN

PROVIDE NEW RETAINING WALL.
SEE DETAIL 5/HE-701

PROVIDE NEW 6'-0" HIGH CHAIN
LINK FENCE WITH 4'-0" WIDE
GATE. SEE DETAIL 6/HE-701

EXCAVATE AREA FOR NEW RETAINING WALL.
REMOVE ALL MATERIALS OFFSITE AND
RESTORE EXISTING AREAS.

1

MECHANICAL/ELECTRICAL CONSTRUCTION SITE PLAN

SCALE: 10' = 1'-0"

FELLENZER III
ENGINEERING LLP

www.fellp.com

22 Mulberry St., Suite 2A,
Middletown, NY 10940
t 845-343-1481 fx 855-320-8735

181 Church St., Suite 100,
Poughkeepsie, NY 12601
t 845-454-9704; fx 855-320-8735

PROJECT TITLE: **OSCC ORANGE HALL THEATER
HVAC UNIT REPLACEMENT**
COUNTY JOB NO.: OSCC-2023-20

FE PROJECT No:
22-230

SCALE:
AS SHOWN

DESIGNED BY:
JDD

DRAWN BY:
JCL

CHECKED BY:
EDF


REF. DWG.:
HE-100

SKETCH TITLE:
RETAINING WALL CLARIFICATION

REF. DWG. TITLE:
**MECHANICAL/ELECTRICAL
DETAIL & SCHEDULES**

SKETCH No:
SKHE-100.1

ISSUE DATE:
11/03/22

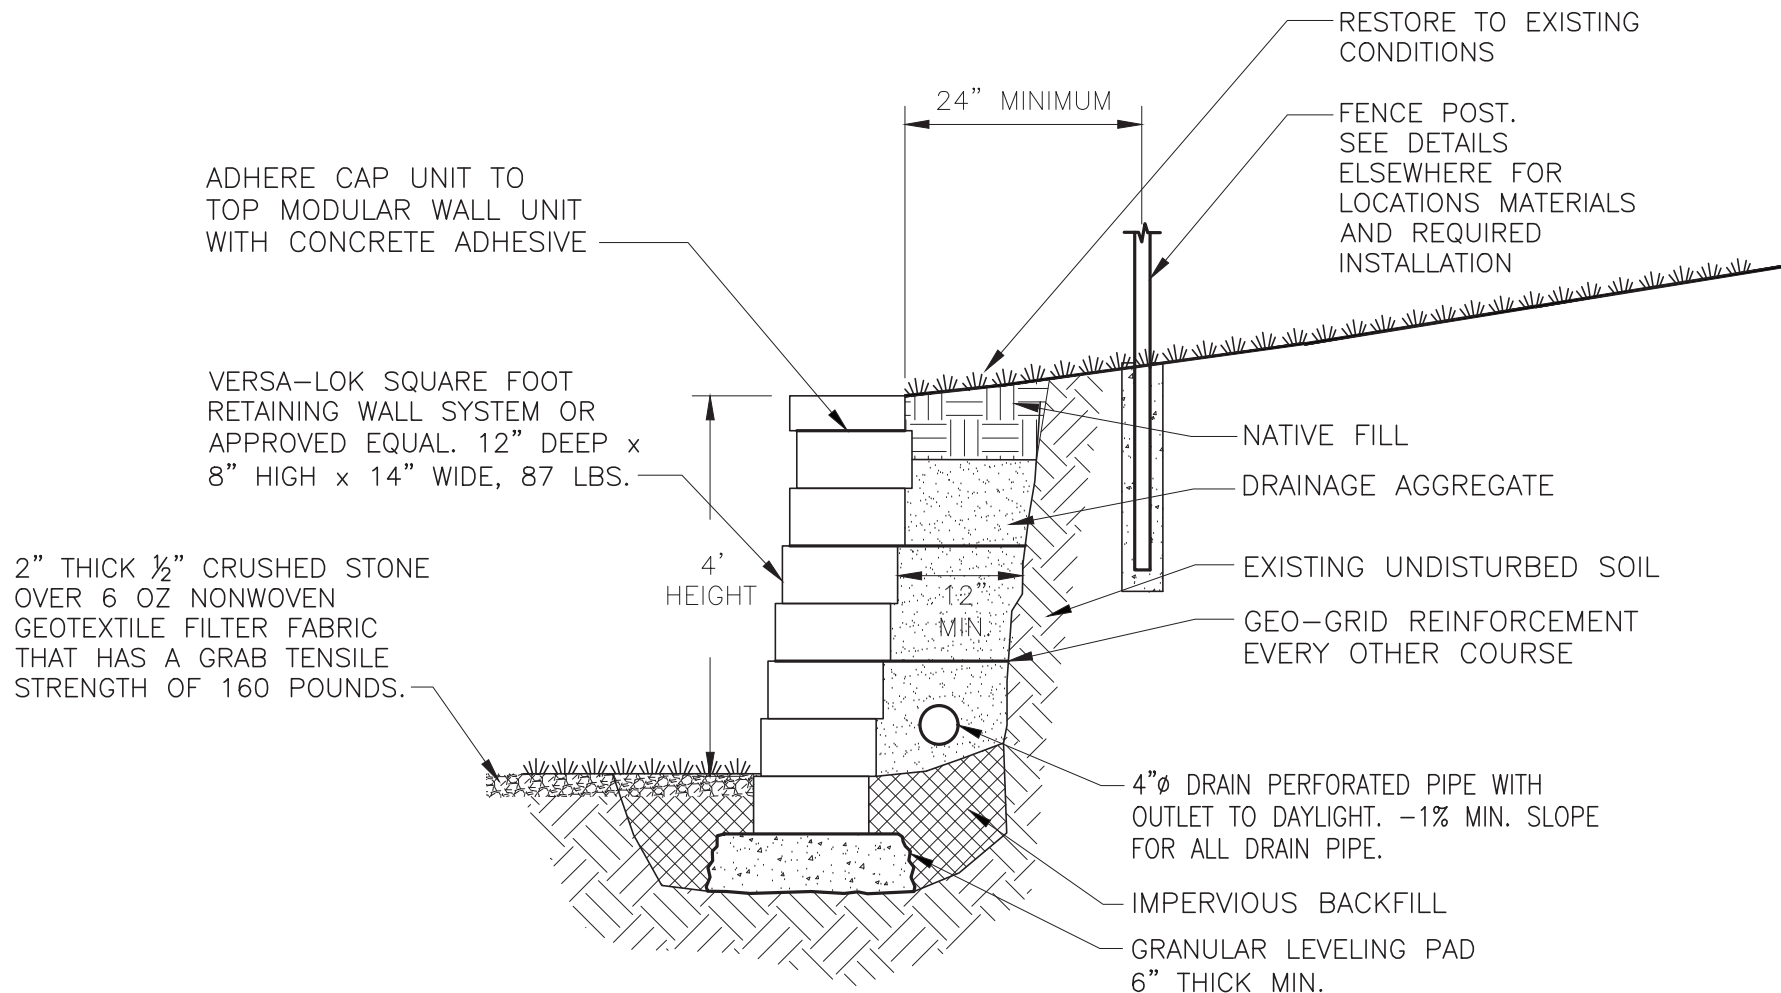

TYPICAL SECTION VIEW

5 MODULAR CONCRETE BLOCK RETAINING WALL
N.T.S.

FELLENZER III
ENGINEERING LLP

www.fellp.com

22 Mulberry St., Suite 2A,
Middletown, NY 10940
t 845-343-1481 fx 855-320-8735

181 Church St., Suite 100,
Poughkeepsie, NY 12601
t 845-454-9704; fx 855-320-8735

PROJECT TITLE: **OCCC ORANGE HALL THEATER
HVAC UNIT REPLACEMENT**
COUNTY JOB NO.: OCCC-2023-20

FE PROJECT No:
22-230

SCALE:
NTS

DESIGNED BY:
JDD

DRAWN BY:
JCL

CHECKED BY:
EDF


REF. DWG.:
HE-701

SKETCH TITLE:
RETAINING WALL CLARIFICATION

REF. DWG. TITLE:
**MECHANICAL/ELECTICAL
DETAIL & SCHEDULES**

SKETCH No:
SKHE-701.1

ISSUE DATE:
11/03/22

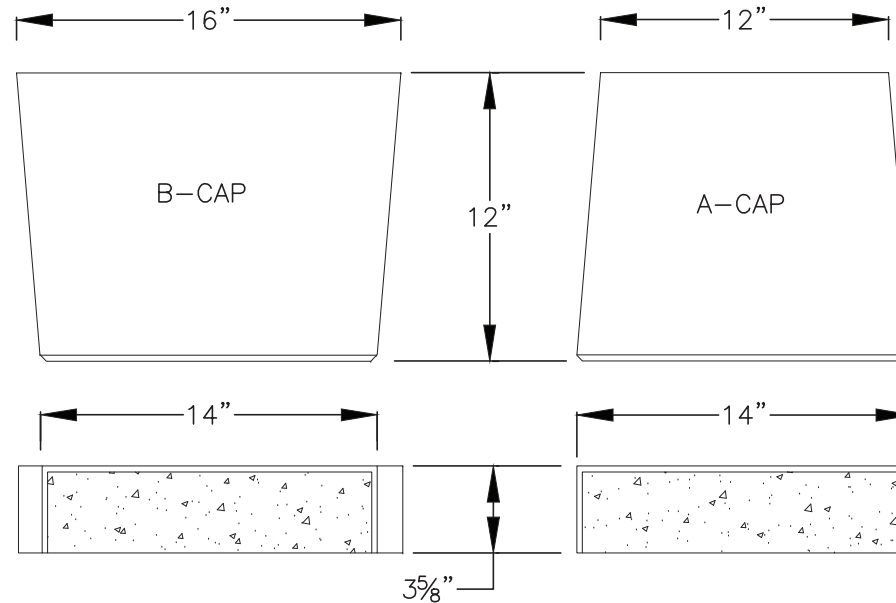

8 VERSA-LOK CAP UNITS

1 1/2" = 1'-0"

FELLENZER III
ENGINEERING LLP

www.fellp.com

22 Mulberry St., Suite 2A,
Middletown, NY 10940
t 845-343-1481 fx 855-320-8735

181 Church St., Suite 100,
Poughkeepsie, NY 12601
t 845-454-9704; fx 855-320-8735

PROJECT TITLE: **OCCC ORANGE HALL THEATER
HVAC UNIT REPLACEMENT**
COUNTY JOB NO.: OCCC-2023-20

FE PROJECT No:
22-230

SCALE:
AS SHOWN

DESIGNED BY:
JDD

DRAWN BY:
JCL

CHECKED BY:
EDF

REF. DWG.:
HE-701


SKETCH TITLE:
RETAINING WALL CLARIFICATION

REF. DWG. TITLE:
**MECHANICAL/ELECTICAL
DETAIL & SCHEDULES**

SKETCH No:
SKHE-701.2

ISSUE DATE:
11/03/22

FOR STRAIGHT WALLS, ALTERNATE A-CAP AND B-CAP

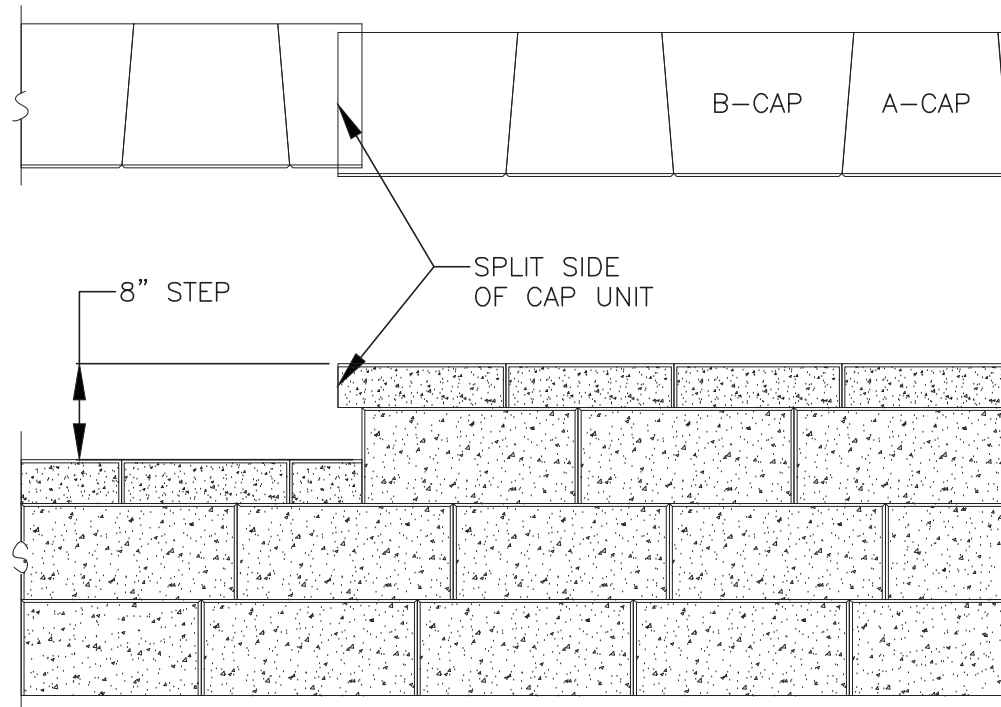

9 VERSA-LOK CAPPING DETAIL-PROFILE

$\frac{3}{4}'' = 1'-0''$

FELLENZER III
ENGINEERING LLP

www.fellp.com

22 Mulberry St., Suite 2A,
Middletown, NY 10940
t 845-343-1481 fx 855-320-8735

181 Church St., Suite 100,
Poughkeepsie, NY 12601
t 845-454-9704; fx 855-320-8735

PROJECT TITLE: **OSCC ORANGE HALL THEATER
HVAC UNIT REPLACEMENT**
COUNTY JOB NO.: OSCC-2023-20

FE PROJECT No:
22-230

SCALE:
AS SHOWN

DESIGNED BY:
JDD

DRAWN BY:
JCL

CHECKED BY:
EDF

REF. DWG.:


HE-701

SKETCH TITLE:
RETAINING WALL CLARIFICATION


REF. DWG. TITLE:
**MECHANICAL/ELECTICAL
DETAIL & SCHEDULES**

SKETCH No:
SKHE-701.3

ISSUE DATE:
11/03/22

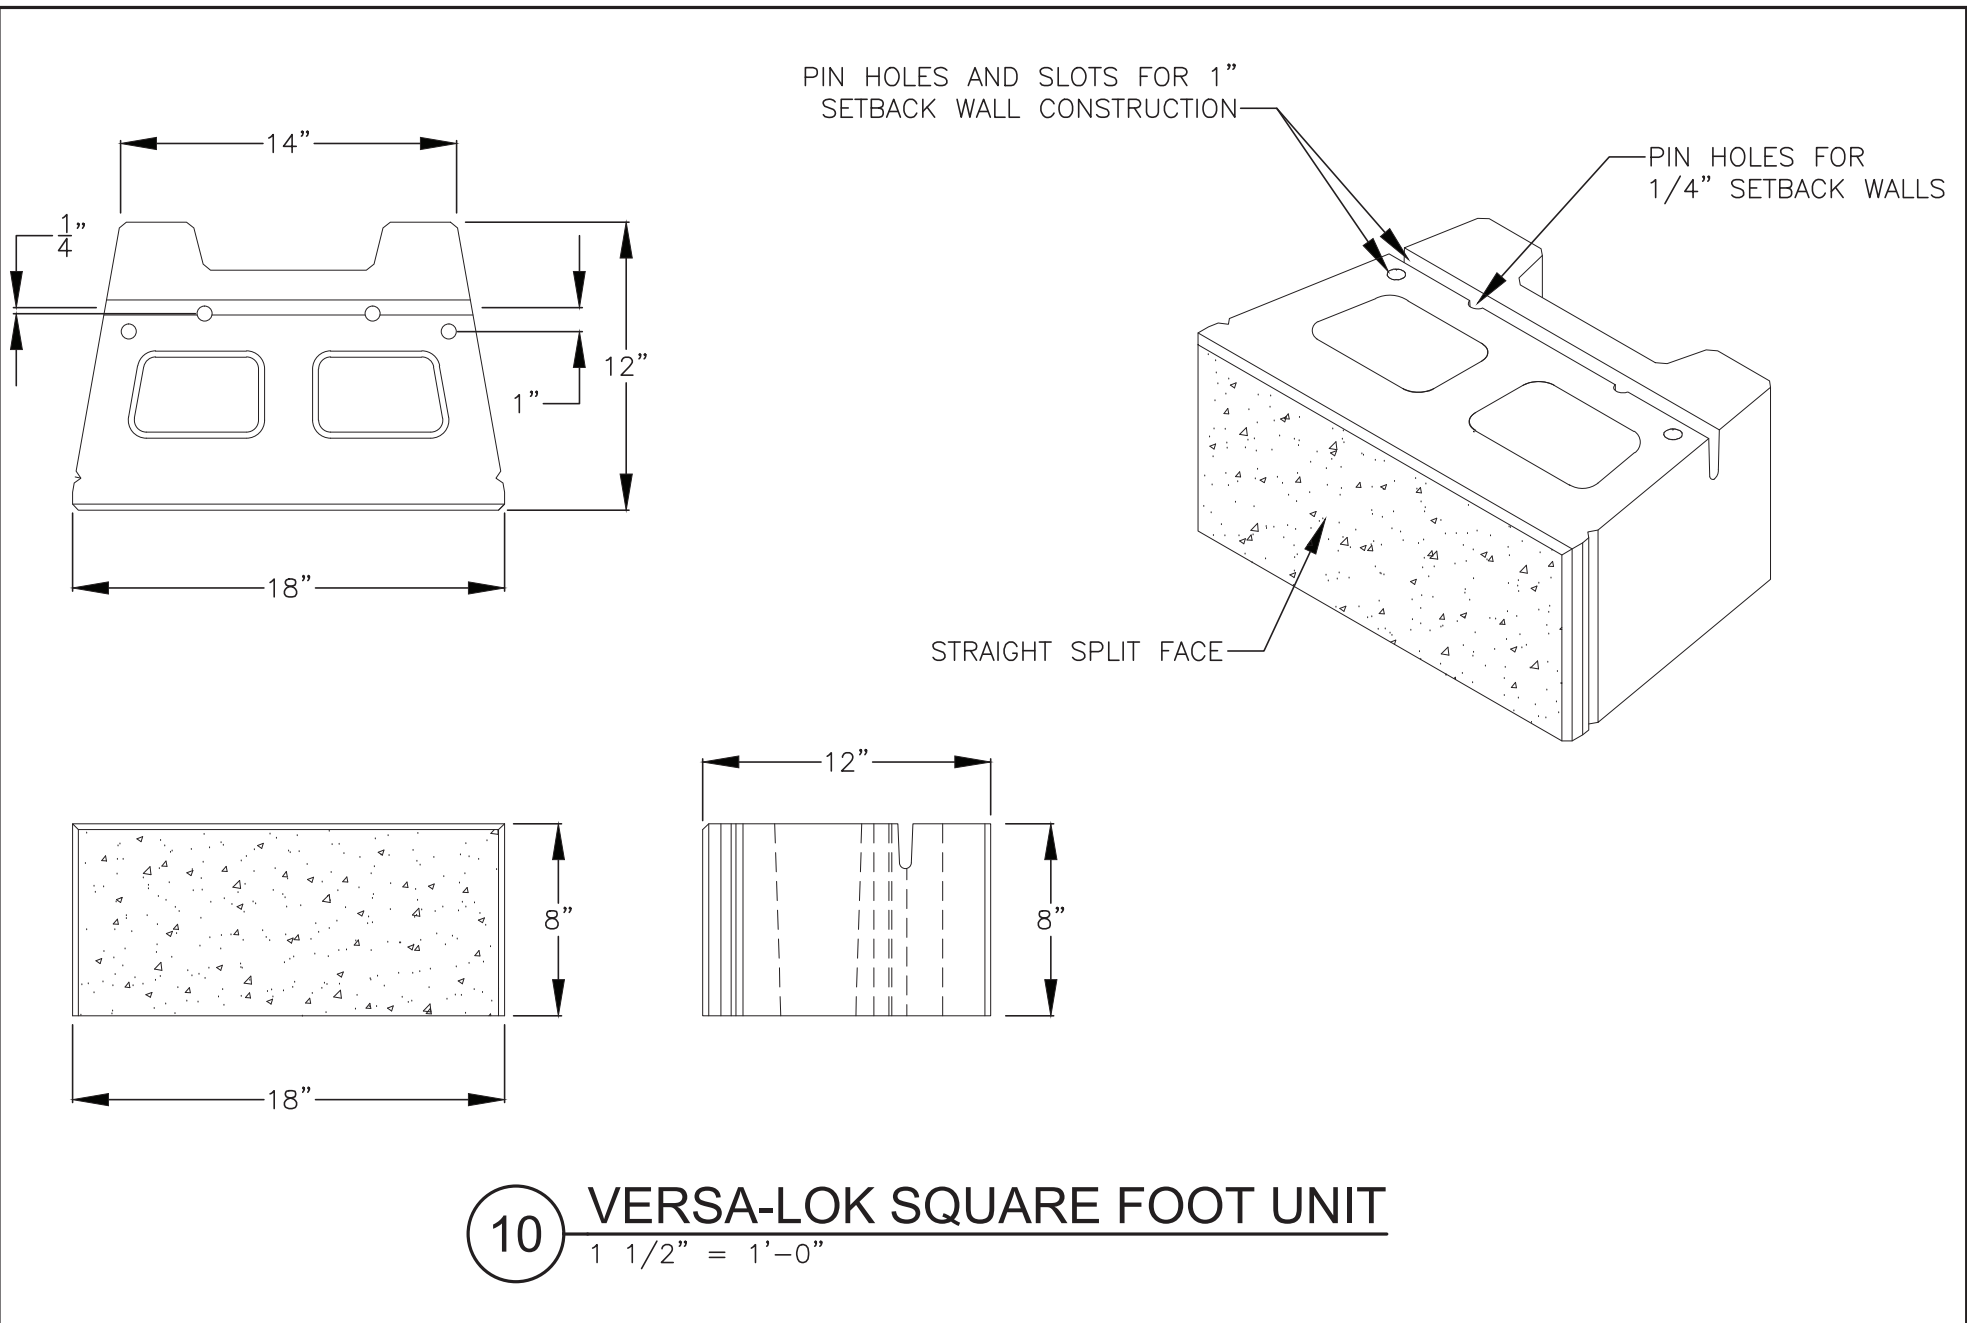

FELLENZER III ENGINEERING LLP www.fellp.com 22 Mulberry St., Suite 2A, Middletown, NY 10940 t 845-343-1481 fx 855-320-8735 181 Church St., Suite 100, Poughkeepsie, NY 12601 t 845-454-9704; fx 855-320-8735	PROJECT TITLE: OCCC ORANGE HALL THEATER HVAC UNIT REPLACEMENT		SKETCH TITLE: RETAINING WALL CLARIFICATION	SKETCH No: SKHE-701.4
	COUNTY JOB NO.: OCCC-2023-20		REF. DWG. TITLE: MECHANICAL/ELECTICAL DETAIL & SCHEDULES	ISSUE DATE: 11/03/22
	FE PROJECT No: 22-230	SCALE: AS SHOWN		
	DESIGNED BY: JDD	DRAWN BY: JCL	CHECKED BY: EDF	
			HE-701	

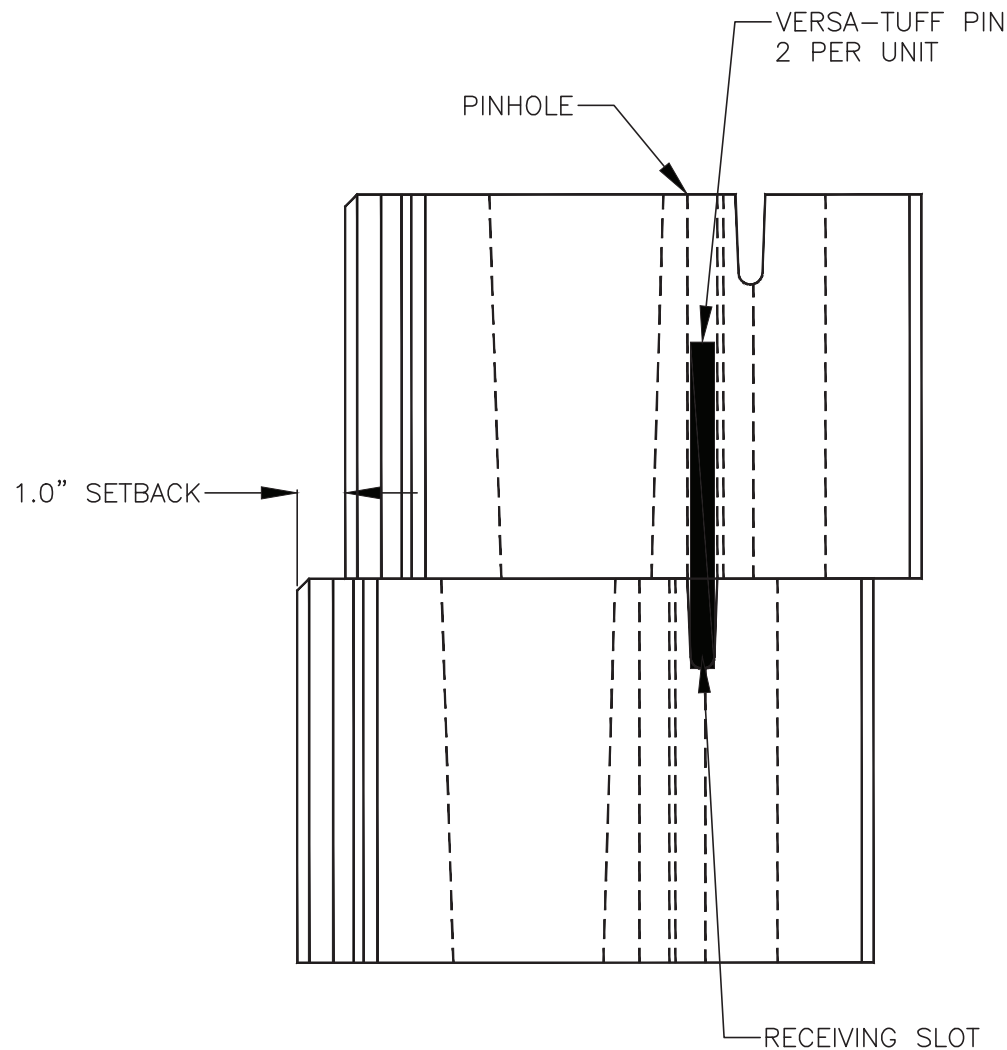

11 VERSA-LOK PINNING DETAIL

3" = 1'-0"

FELLENZER III
ENGINEERING LLP

www.fellp.com

22 Mulberry St., Suite 2A,
Middletown, NY 10940
t 845-343-1481 fx 855-320-8735

181 Church St., Suite 100,
Poughkeepsie, NY 12601
t 845-454-9704; fx 855-320-8735

PROJECT TITLE: **OCCC ORANGE HALL THEATER
HVAC UNIT REPLACEMENT**
COUNTY JOB NO.: OCCC-2023-20

FE PROJECT No:
22-230

SCALE:
AS SHOWN

DESIGNED BY:
JDD

DRAWN BY:
JCL

CHECKED BY:
EDF

REF. DWG.:
HE-701

SKETCH TITLE:
RETAINING WALL CLARIFICATION

REF. DWG. TITLE:
**MECHANICAL/ELECTICAL
DETAIL & SCHEDULES**

SKETCH No:
SKHE-701.5

ISSUE DATE:
11/03/22