

[illegible]

ORANGETOWN
TOWN HALL

ADDITION AND ALTERATIONS


26 ORANGEBURG RD
ORANGEBURG, NEW YORK 10962

LEVEL 03
CONSTRUCTION PLAN
AND NOTES

PROJECT NO.: 2219-05

DRAWING NO.:

P-204

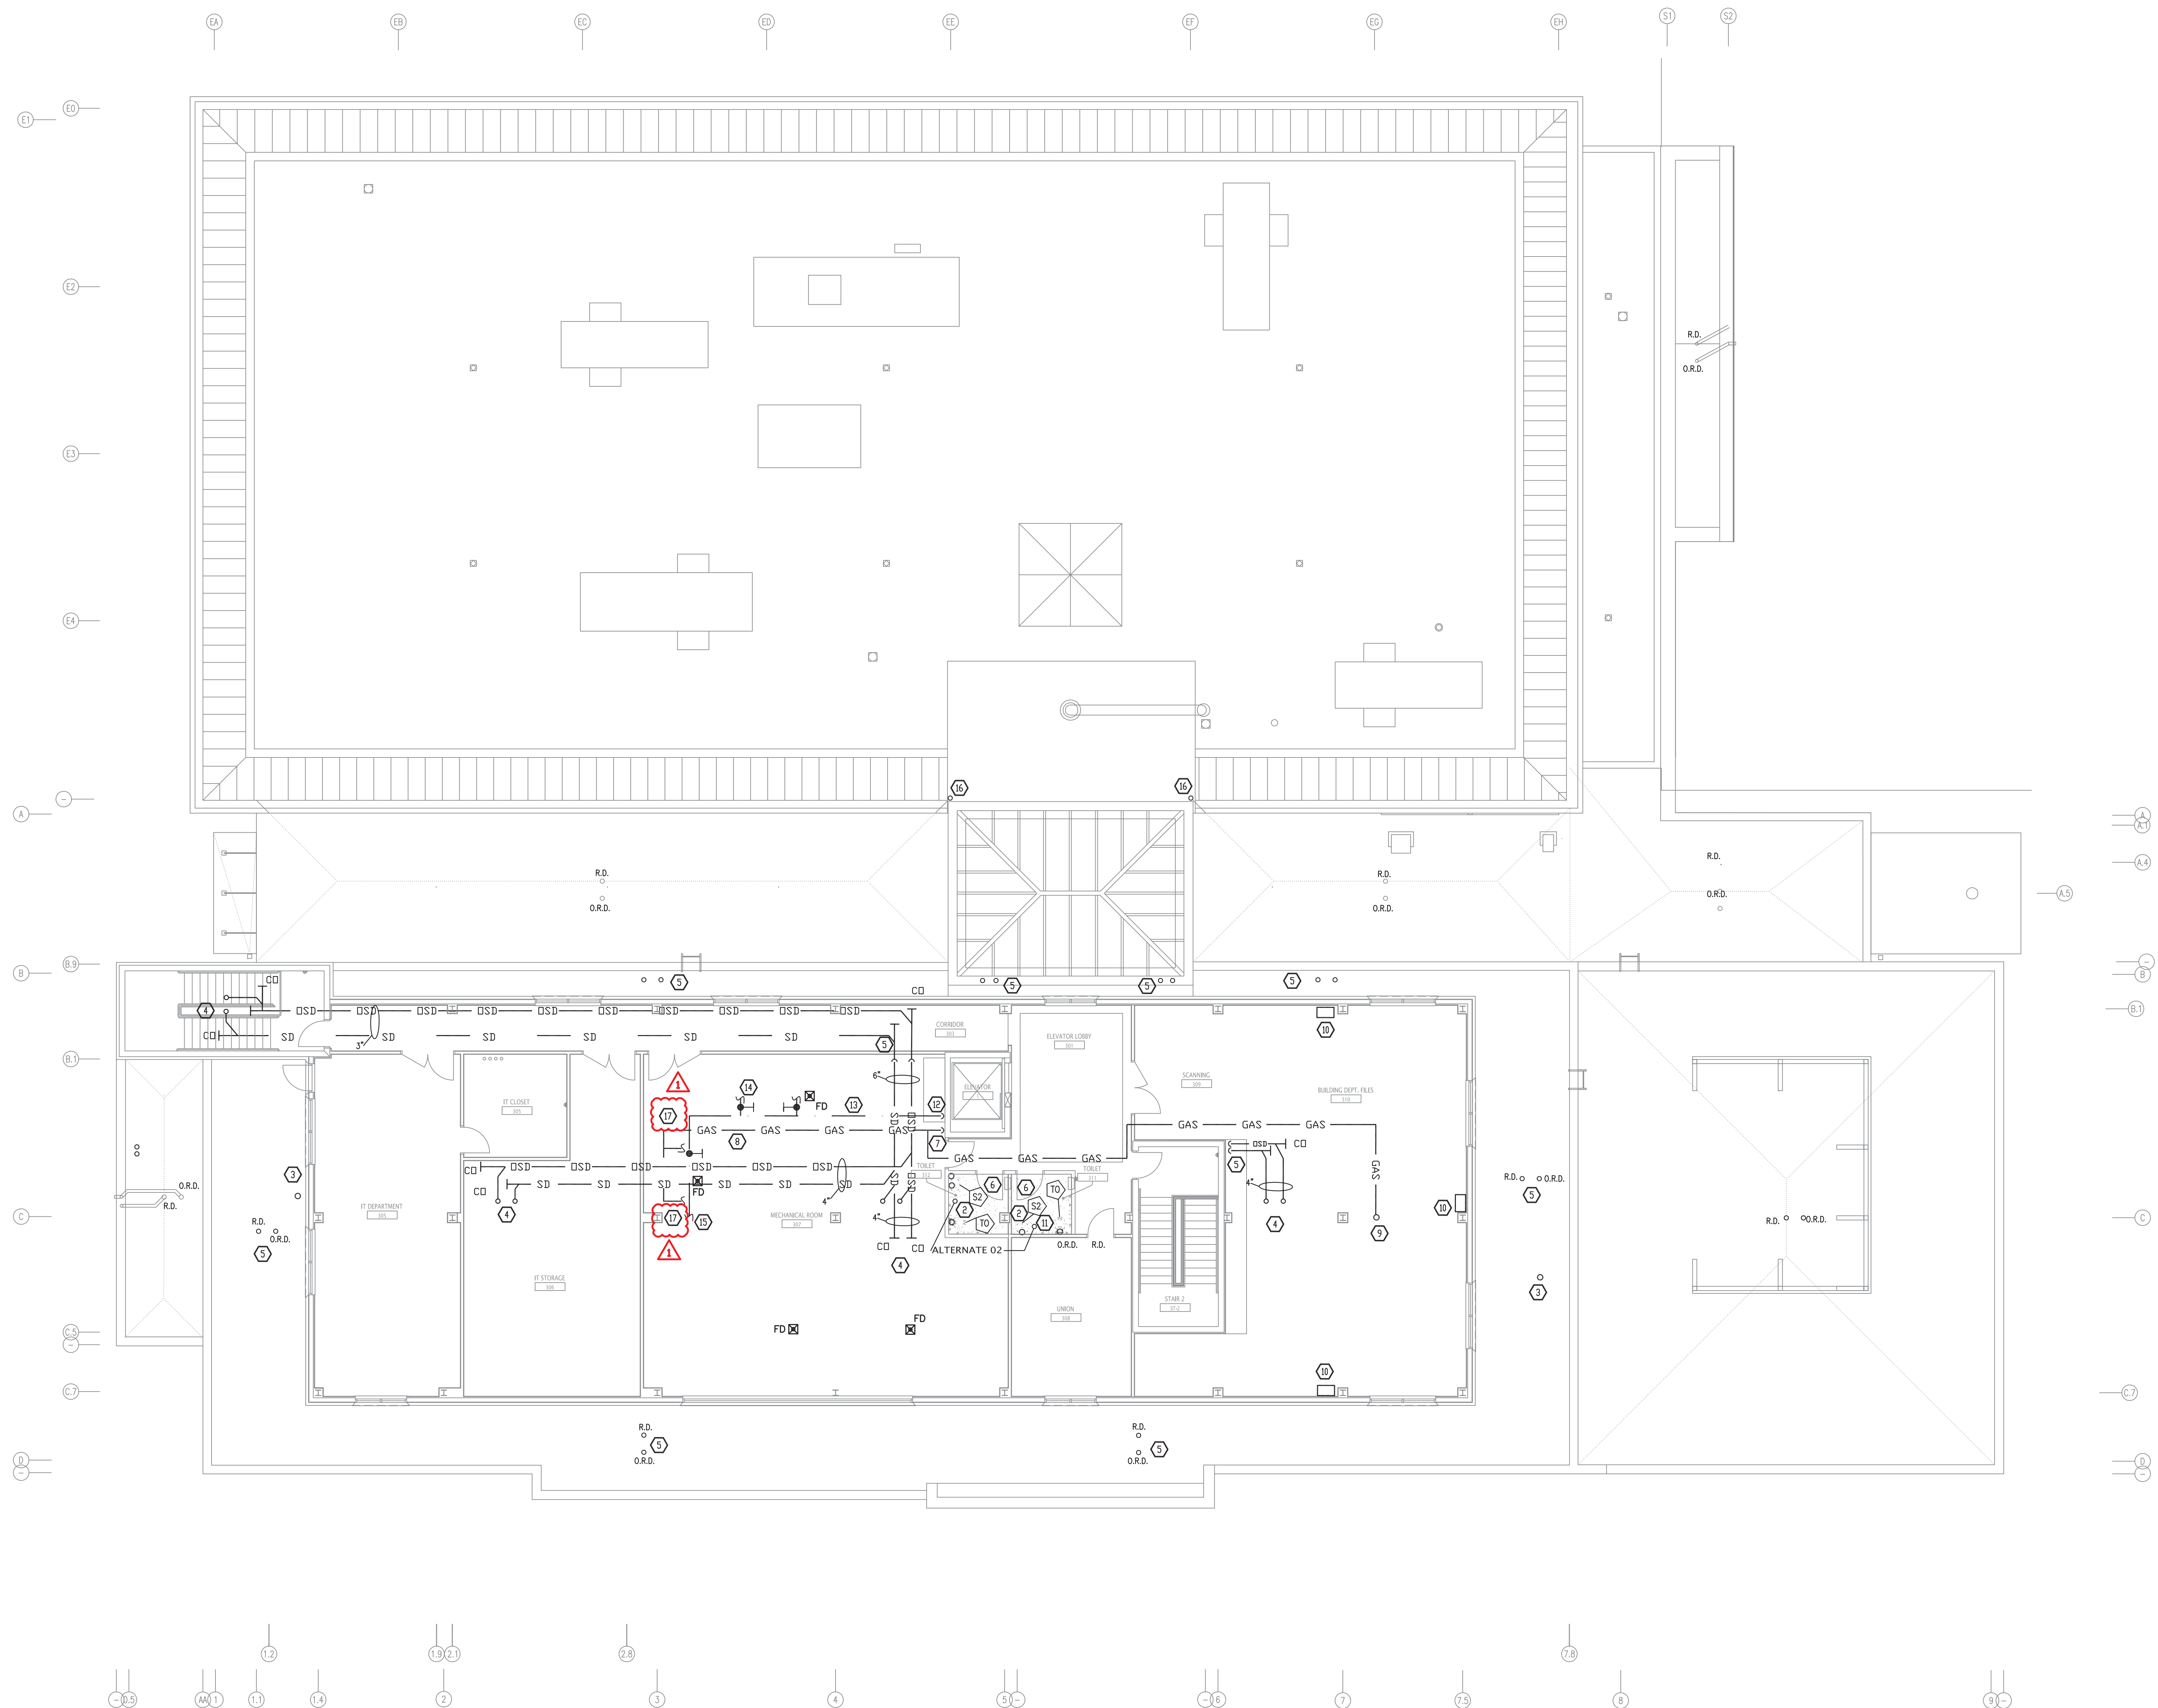


CONSTRUCTION NOTES

- | | |
|----|---|
| 1 | 3" VENT TO ROOF. DSD AND SD DOWN TO BASEMENT. |
| 2 | COLD WATER AND WASTE PIPING FED TO FIXTURES FROM BELOW. |
| 3 | 4" VENT FROM BELOW. |
| 4 | UP TO RD AND OVER FLOW DRAIN. |
| 5 | 6" RD AND OVER FLOW DRAIN DOWN TO LEVEL 02. |
| 6 | PLUMBING FIXTURES AND INSTALLATION IN THIRD FLOOR TOILETS |
| 7 | SHALL BE BID AS ALTERNATE 2. |
| 8 | GAS PIPING DOWN TO LEVEL 02 |
| 9 | GAS PIPING TO BOILERS |
| 10 | GAS PIPING UP TO RTU-1 |


- | | | |
|----|--|---|
| 10 | WALL MOUNTED HUMIDIFIER. SEE M DRAWINGS. | |
| 11 | PROVIDE ELECTRIC WATER HEATER 1.5 KW BOSCHTRONIC 3000 ESB FOR LAVATORIES MOUNTED IN CEILING. | |
| 12 | COLD WATER DOWN TO LEVEL 02 | |
| 13 | 2" MAKEUP WATER FOR CONDENSER WATER SYSTEM. | |
| 14 | 2" MAKEUP TO CHILLED WATER SYSTEM. | |
| 15 | 1 1/2" MAKEUP TO HOT WATER SYSTEM. | |
| 16 | ROOF DRAIN LEADERS TO SPLASH BLOCKS. | |
| 17 | GAS PIPING TO B-1 AND B-2 | 1 |

1 LEVEL 03 CONSTRUCTION PLAN
SCALE: 1/8"=1'-0"

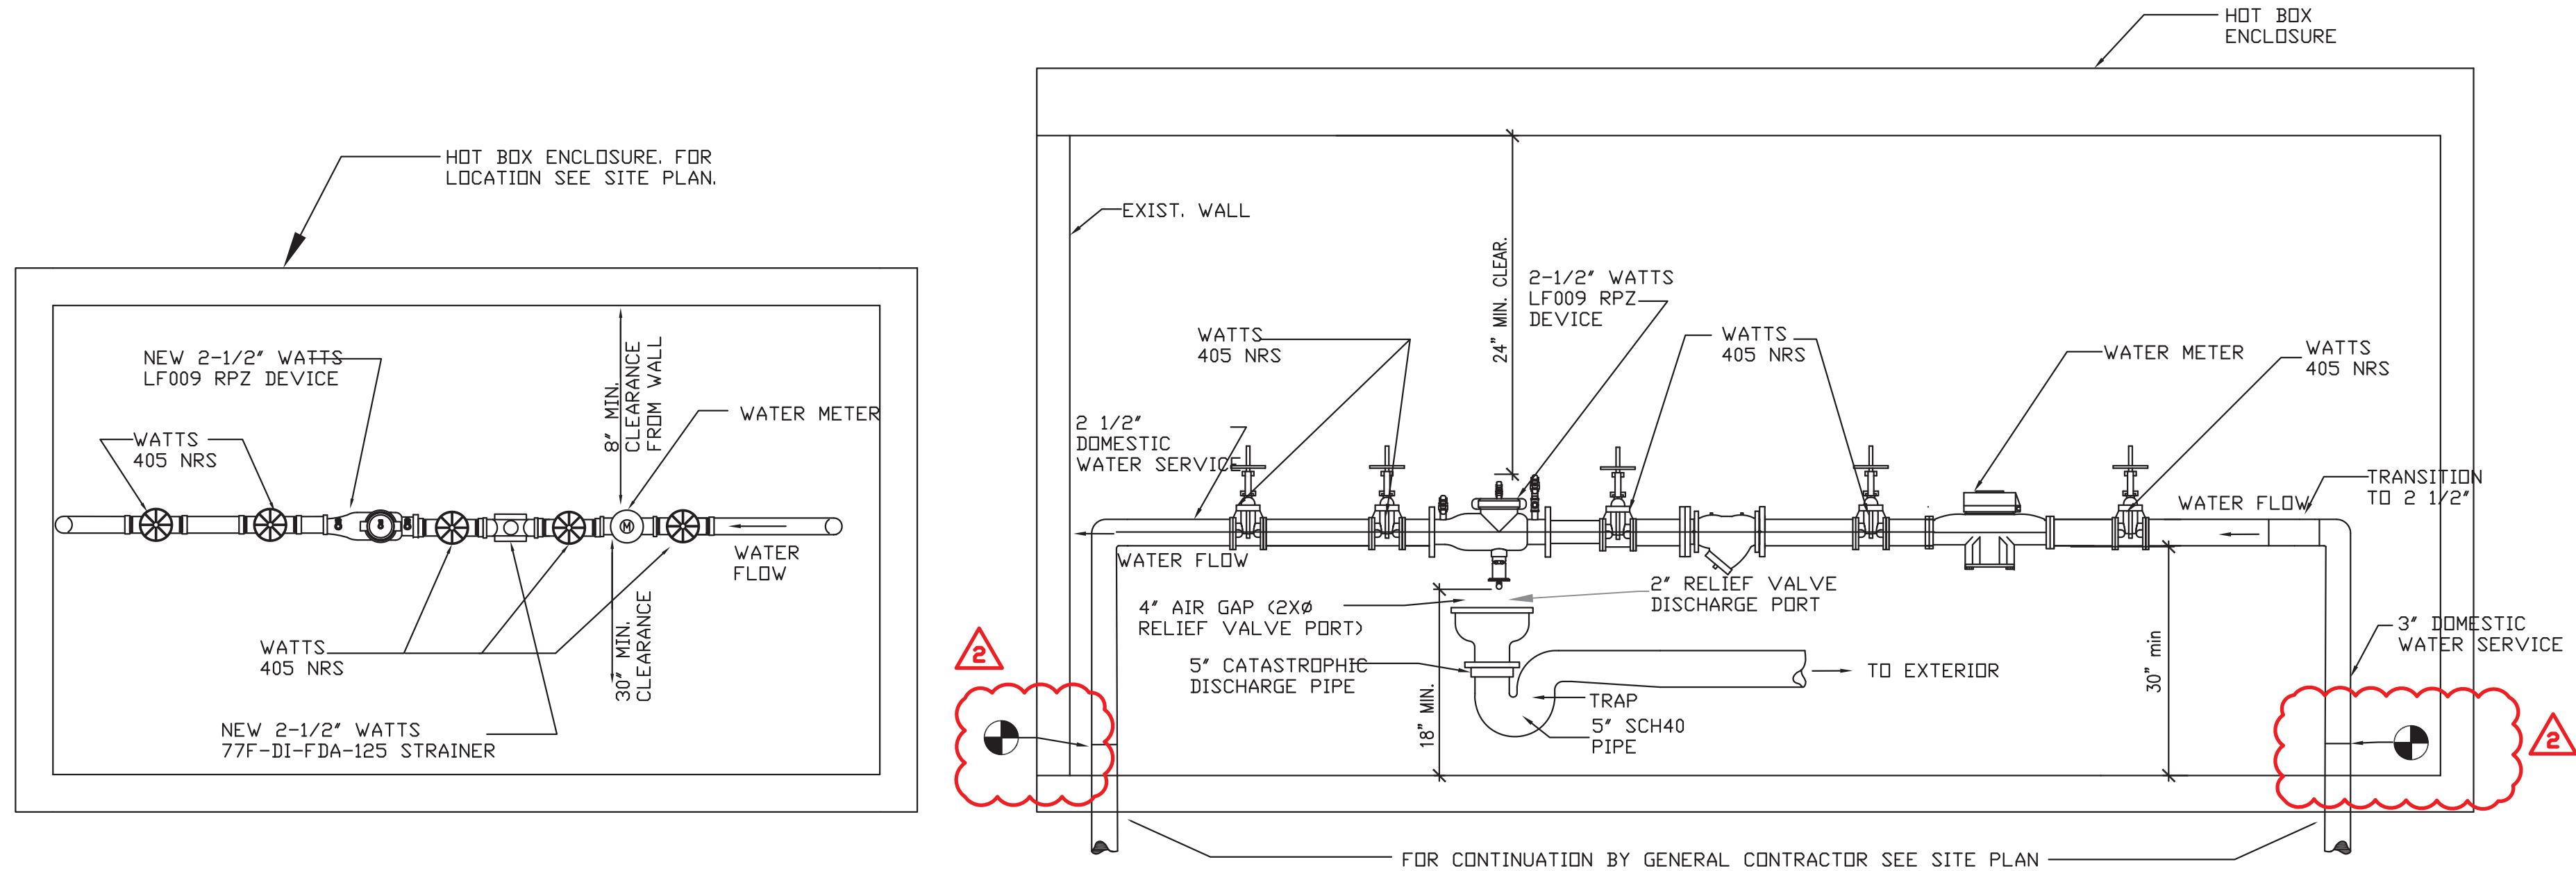


1 RPZ PLAN
SCALE: NOT TO SCALE


2 RPZ ELEVATION
SCALE: NOT TO SCALE

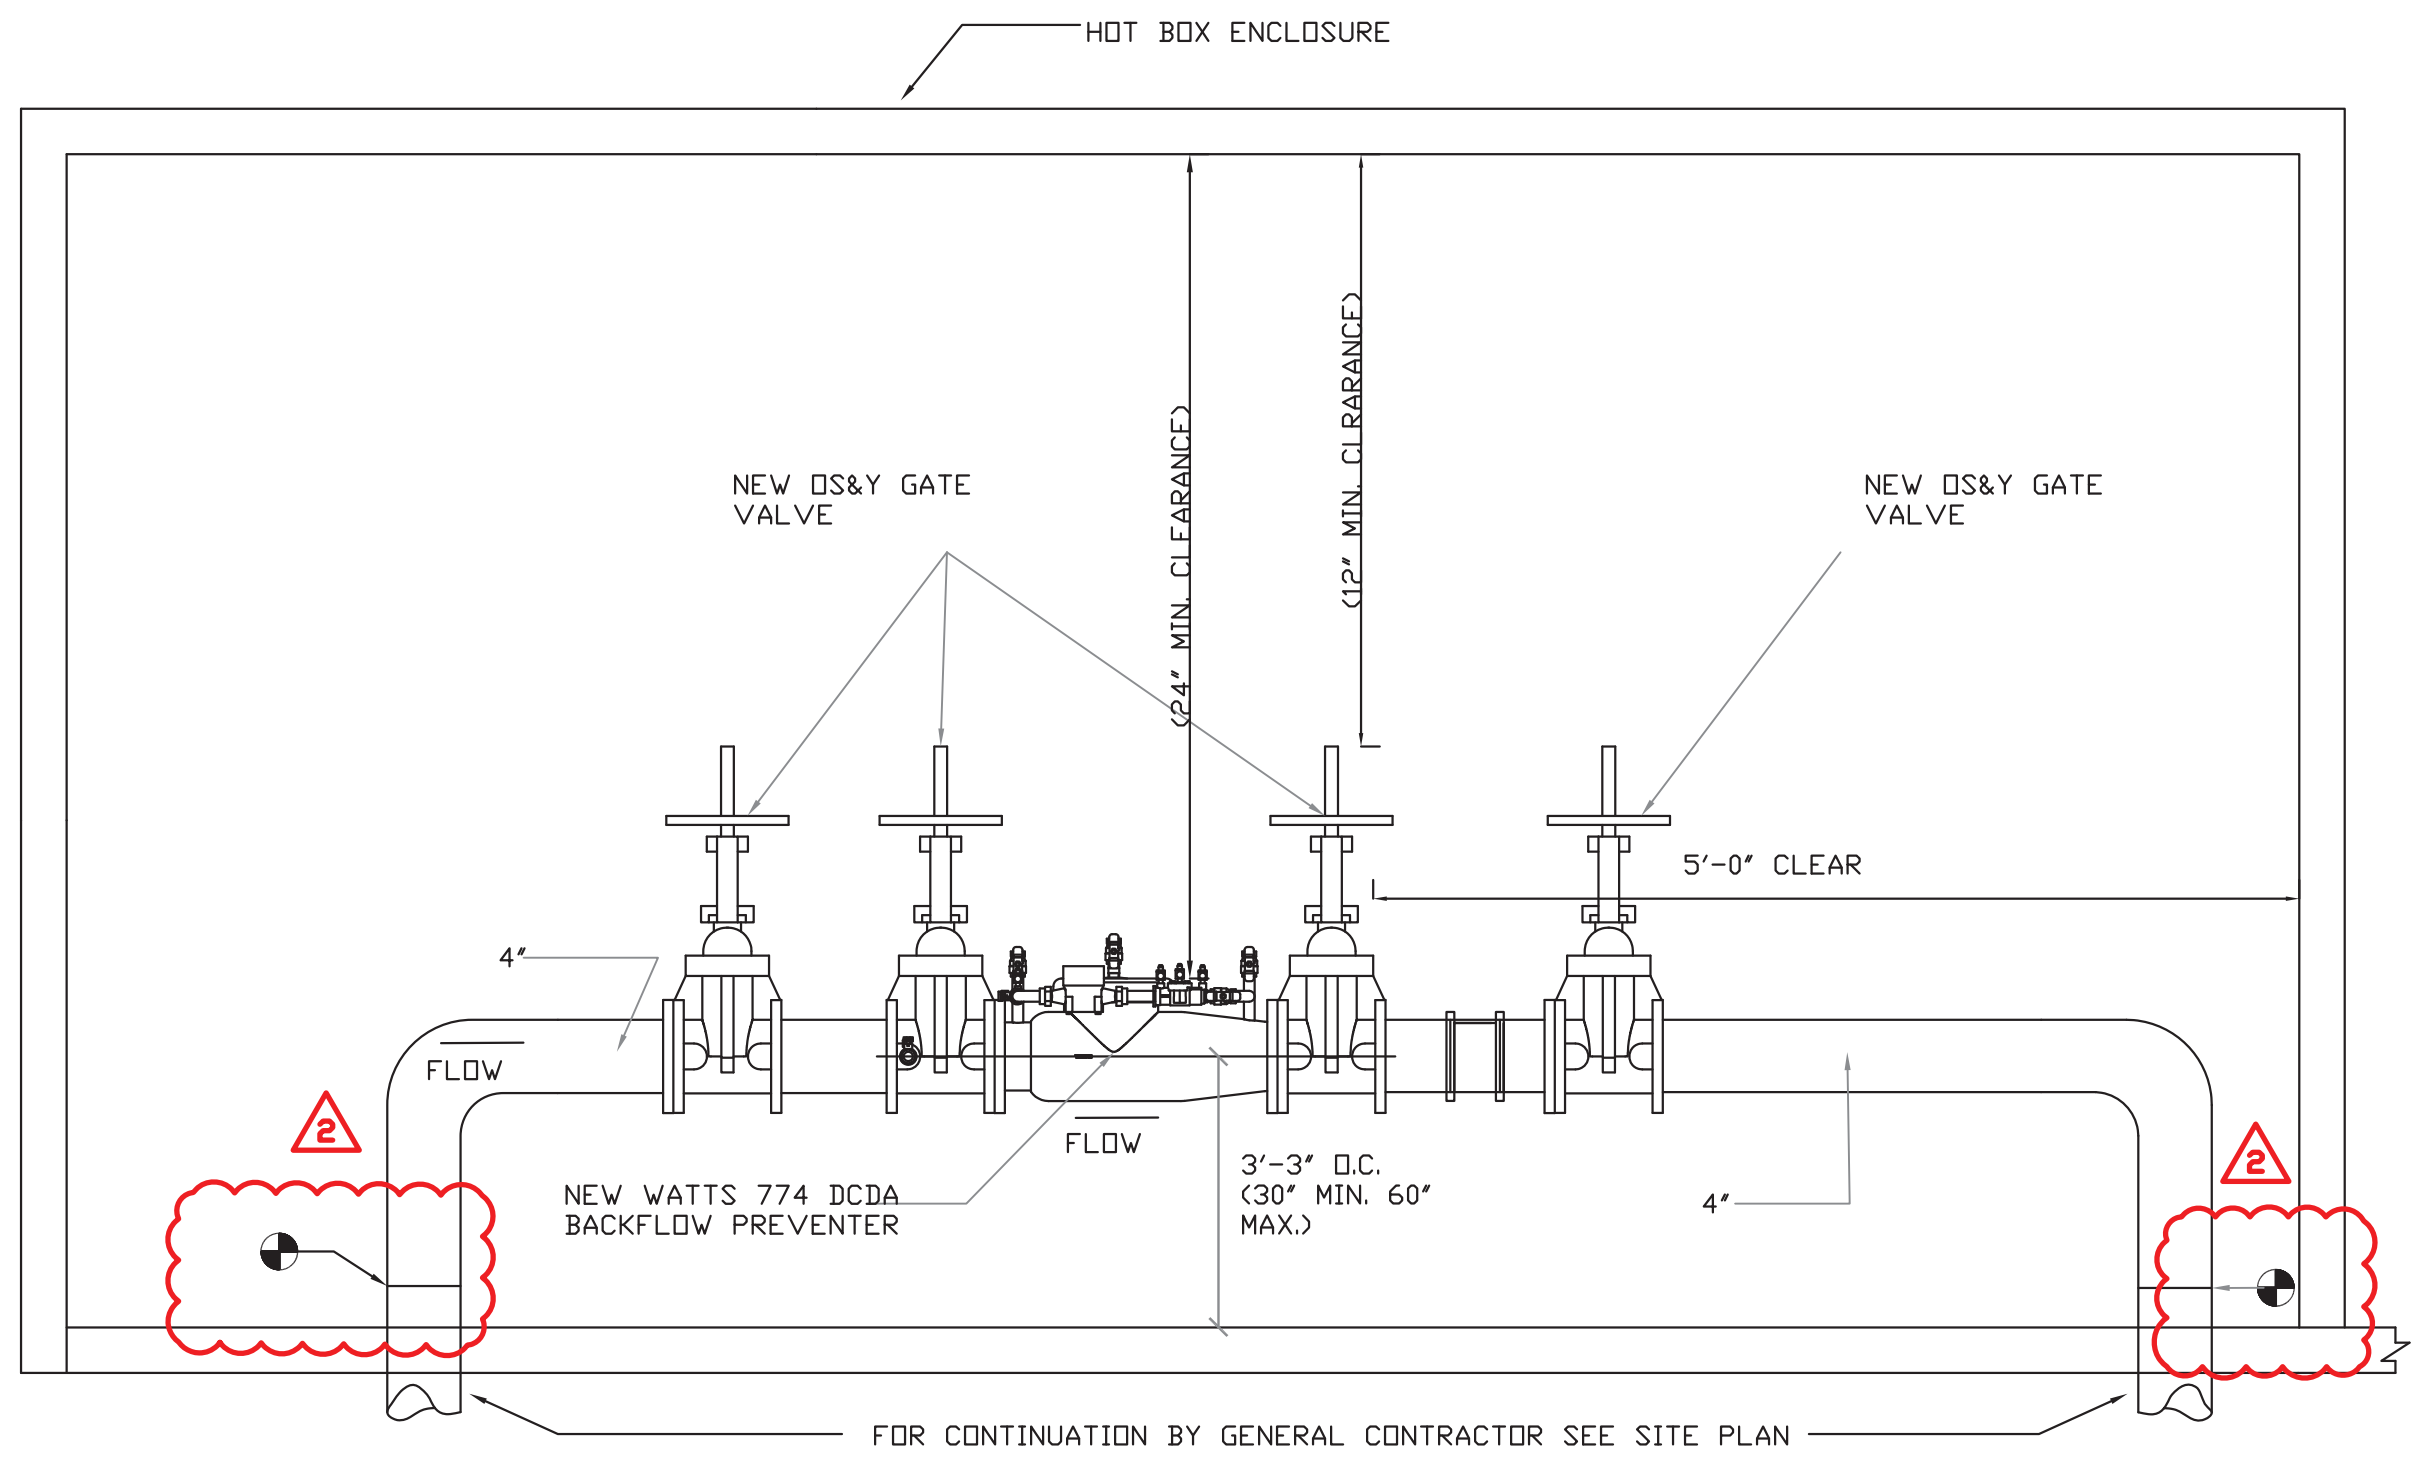

3 DOUBLE CHECK VALVE ELEVATION
SCALE: NOT TO SCALE

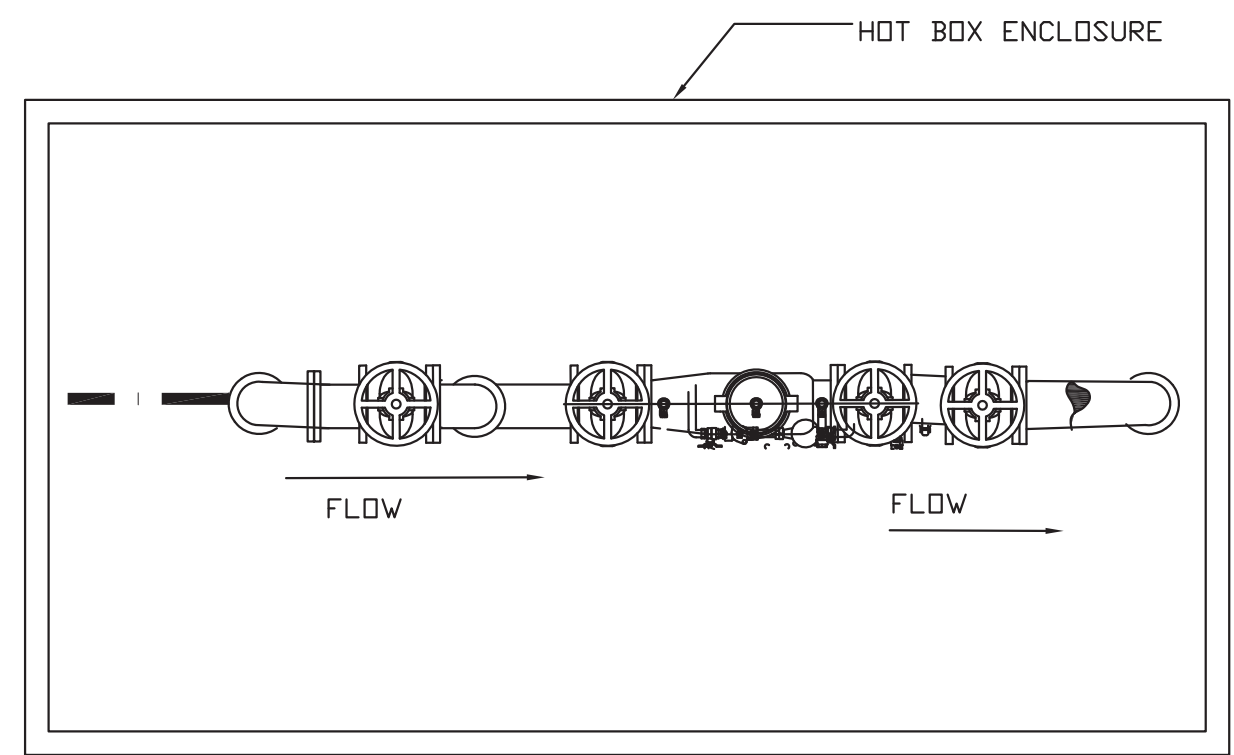

4 DOUBLE CHECK VALVE PART PLAN
SCALE: NOT TO SCALE

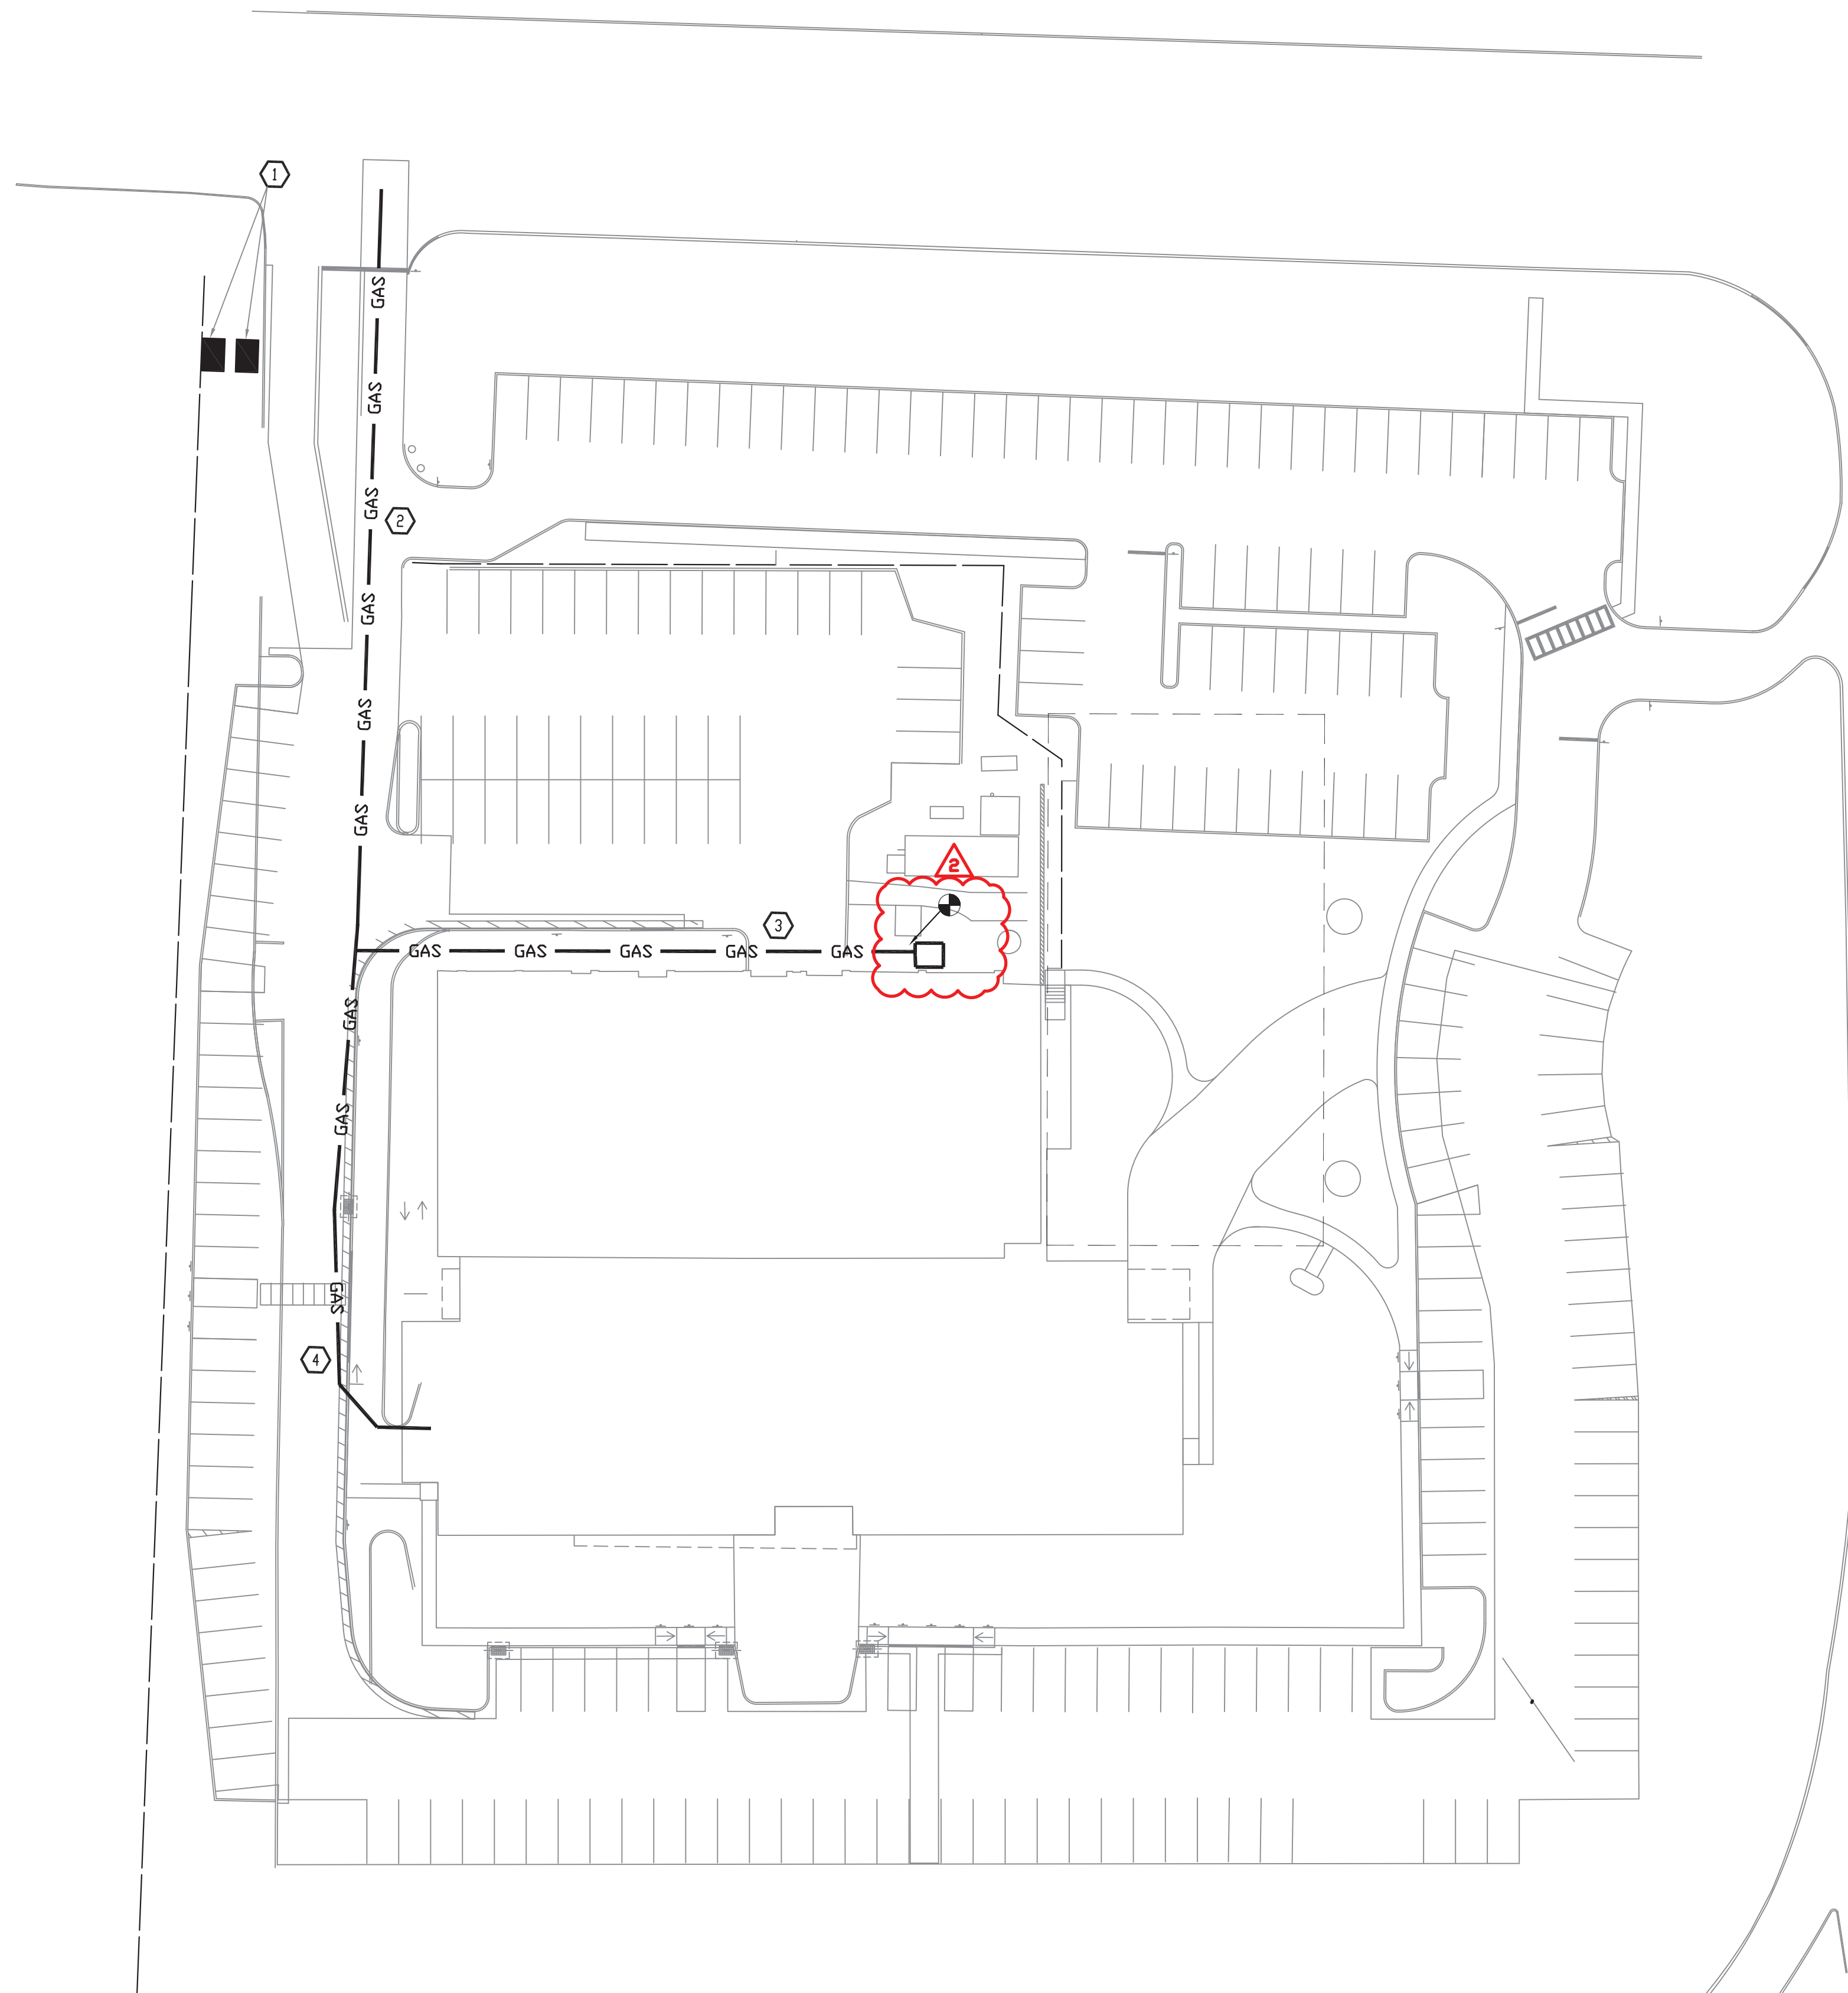

5 SITE PLAN
SCALE: 1/32"=1'-0"

NOTES

- APPROXIMATE LOCATION OF DOUBLE CHECK VALVE AND RPZ ON SITE. FOR ACTUAL LOCATION SEE SITE PLAN.
- NEW 2" GAS PIPING IN TRENCH PROVIDED UNDER THE GENERAL CONSTRUCTION WORK. COORDINATE CONNECTION TO NEW GAS SERVICE WITH UTILITY COMPANY.
- CONNECT NEW GAS PIPING TO EXISTING METER STATIONS FOR AT&T AND VERIZON GENERATORS.
- NEW GAS SERVICE INTO BUILDING.

SITE PLAN, BACKFLOW PIPING AND NOTES

PROJECT NO.: 2219-05


DRAWING NO.:

P-206




ORANGETOWN
TOWN HALL
ADDITION AND ALTERATIONS

26 ORANGEBURG RD
ORANGEBURG, NEW YORK 10962

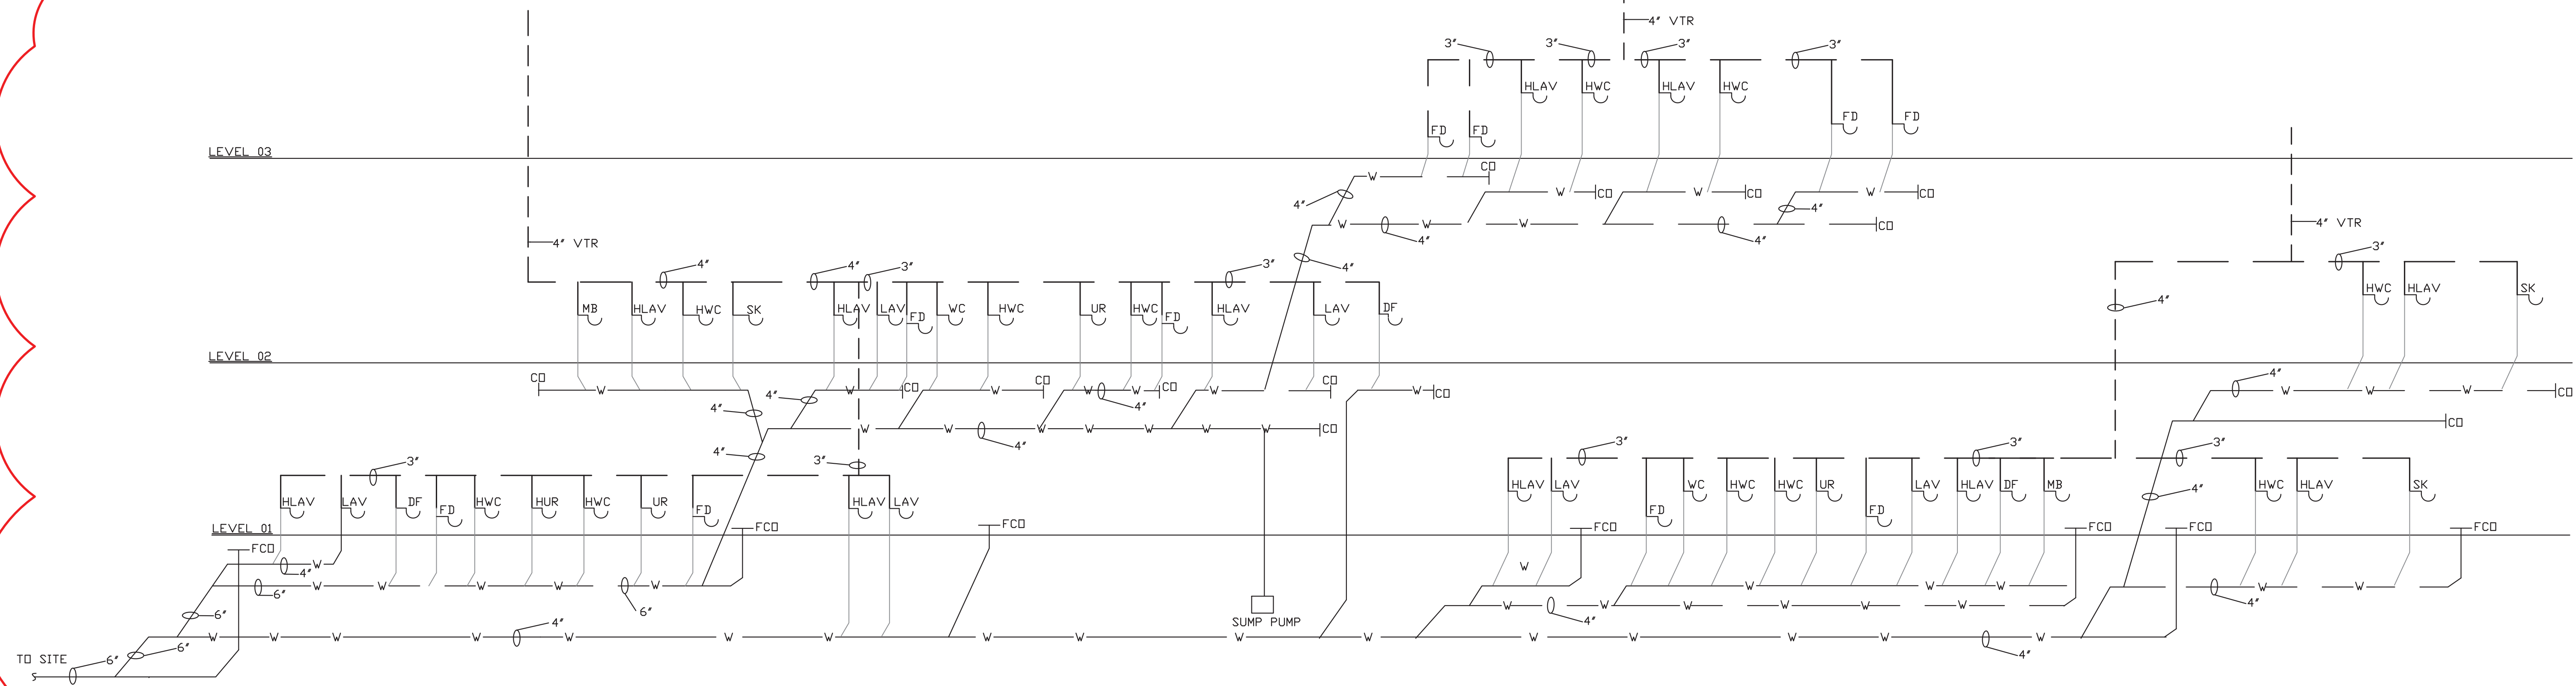

1 WASTE AND VENT RISER DIAGRAM
SCALE: NOT TO SCALE

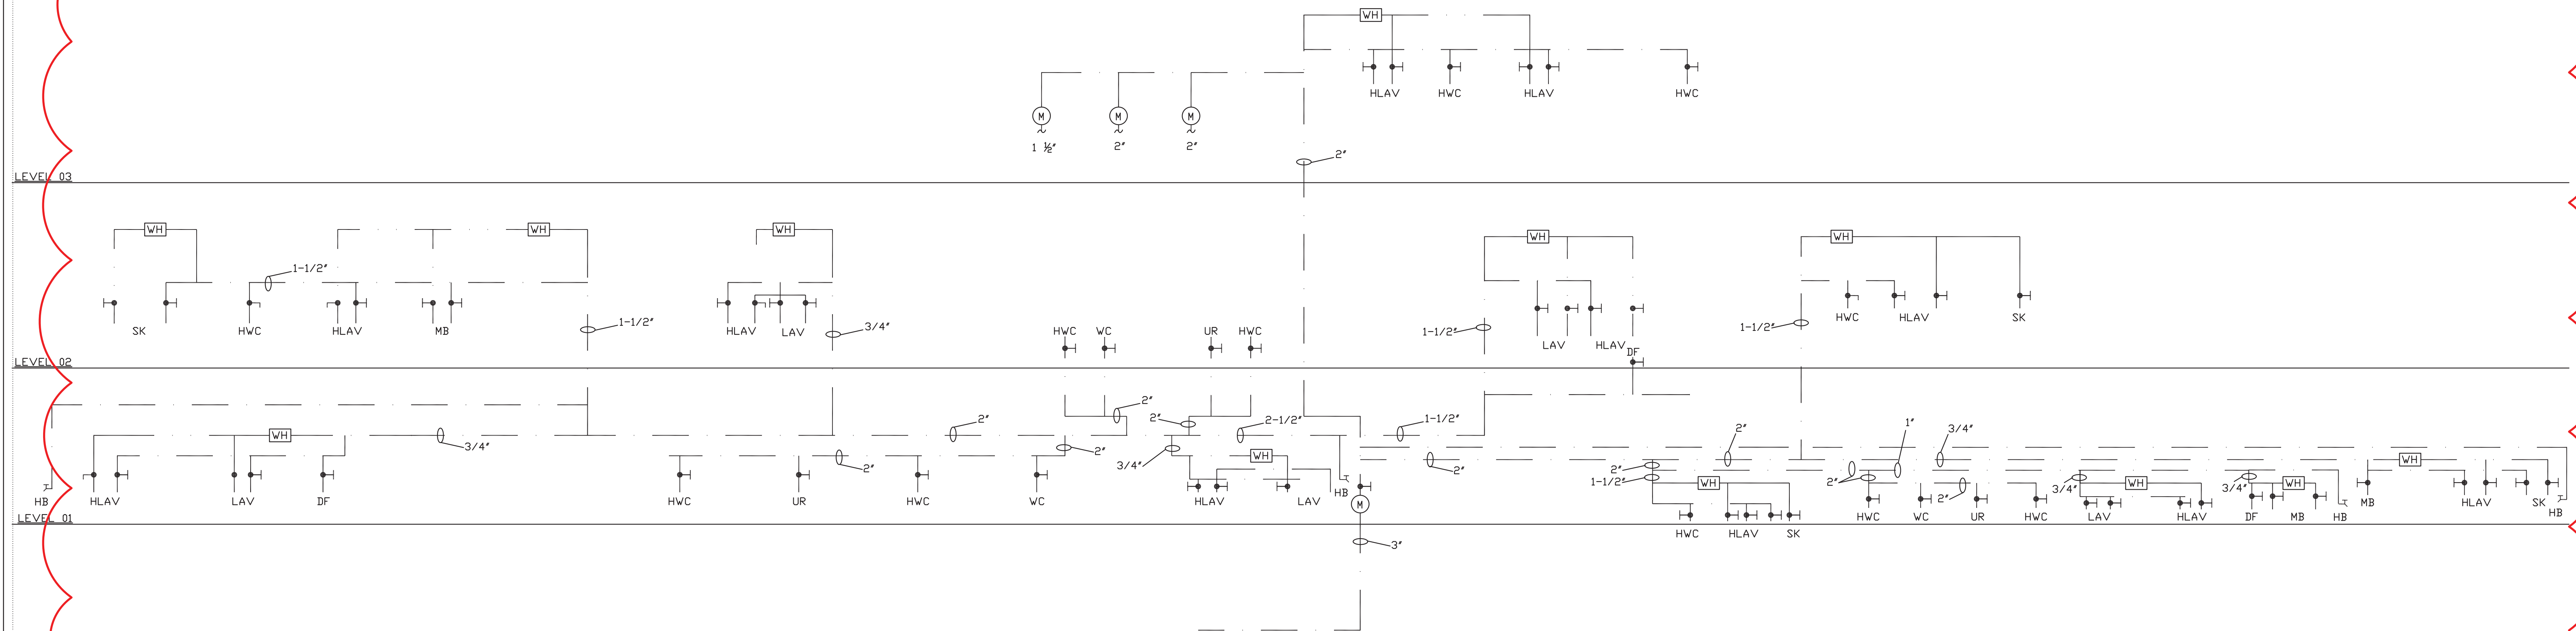

1 DOMESTIC WATER RISER DIAGRAM
SCALE: NOT TO SCALE

2	1/21/2022	ADDENDUM NO 7 
1	11/9/2021	RELEASE FOR BID
ISSUE NO.	ISSUE DATE	DESCRIPTION



ORANGETOWN TOWN HALL

ADDITION AND ALTERATIONS

26 ORANGEBURG RD
ORANGEBURG, NEW YORK 10962

RISER DIAGRAMS


PROJECT NO.: 2219-05

DRAWING NO.:


P-301

PLUMBING FIXTURE SCHEDULE	
TAG NUMBER	DESCRIPTION
TO	WALL MOUNTED TOILET : SLOAN – WHITE VITREOUS CHINA / WALL MOUNTED ST-2459 / CODE 2102459
TO2	FLOOR MOUNTED TOILET : SLOAN – WHITE VITREOUS CHINA / FLOOR MOUNTED / ST-2009 / CODE 2102009
FL	FLUSHOMETER : SLOAN – SENSORED WITH COURTESY FLUSH OVERRIDE BUTTON / G2 8111 / CODE 3250289
UR	URINAL : KOHLER – STEWARD – HYBRID HIGH EFFICIENCY URINAL (HEU) – K-5244-ER – WHITE FINISH
UF	URINAL FLUSHOMETER : SLOAN – ROYAL SENSOR FLUSHOMETER – ROYAL 186 SMO
S1	SINK, LAVATORY : KOHLER – CAXTON RECTANGLE UNDER – MOUNT BATHROOM SINK – K-20000 – WHITE FINISH
S2	SINK : KOHLER – GREENWICH 20-3/4" X 18-1/4" WALL MOUNTED SINK –K-2032-L-0
FA	FAUCET : DELTA – COMPEL COLLECTION – SINGLE HANDLE DECK MOUNT TOUCH 2.0 TECHNOLOGY – CHROME FINISH – MODEL #561T-DST
DF	DRINKING FOUNTAIN – EZH2O BOTTLE FILLING STATION & VERSATILE BI-LEVEL ADA COOLER, FILTERED NON-REFRIGERATED BY ELKAY MODEL- #LZSTLBWSSP STAINLESS
SS	AMERICAN STANDARD – COLONY PRO 25X22 ADA STAINLESS STEEL KITCHEN SINK #22SB6252284S.075
SS4	AMERICAN STANDARD – COLONY PRO 15X15 ADA STAINLESS STEEL KITCHEN SINK #22SB.6151511S.075
FI	AMERICAN STANDARD – AVERY PULL DOWN KITCHEN FAUCET WITH SELECTRONIC HANDS FREE TECHNOLOGY – MODEL #4901.380
SP	HYDRO SYSTEMS – UNIVERSAL SHOWER PAN
ST	DELTA – MONITOR 17 SERIES SHOWER TRIM – STAINLESS/ #T17233-SS-I
MB	MOP BASIN – FIAT MSB3624 WITH 830AA FAUCET, 832AA HOSE AND BRACKET AND 889CC MOP HANGER BRACKET.
WH	FREEZE PROTECTED HYDRANT MANUFACTURED BY WATTS MODEL NO. FHB FROST PRODF AUTOMATIC DRAINING WALL HYDRANT WITH BACK FLOW PREVENTIION.
FD	FLOOR DRAIN AS MANUFACTURED BY JR SMITH MODEL NUMBER 2130 MEDIUM DUTY WITH 12" ROUND TOP
ASP	ACCESSIBLE SHOWER PAN- GRIFform INNOVATIONS SOLID SURFACE CUSTOMIZABLE PAN WITH LOW EGRESS THRESHOLD. COLOR SHALL BE CONCRETE. PROVIDE SLIP RESISTANT FINISH.
ASB	ACCESSIBLE SHOWER BODY – AMERICAN STANDARD FLASH ROUGH SHOWER VALVE BODY WITH TU662213 COMMERCIAL SHOWER SYSTEM TRIM KIT
RD	ROOF DRAIN AS MANUFACTURED BY JAY R. SMITH MODEL NO. 1010 WITH EPOXY COATING, CAST IRON DOME AND SUMP RECEIVER.
ORD	OVERFLOW ROOF DRAIN AS MANUFACTURED BY JAY R. SMITH MODEL NO. 1010 WITH EPOXY COATING, CAST IRON DOME AND SUMP RECEIVER. MOUNT OVERFLDOW DRAIN INLET APPROXIMATELY 2" HIGHER THAN PRIMARY DRAIN.


FIXTURE CONNECTION SCHEDULE					
MARK	DESCRIPTION	HW	CW	W	V
HLAV/LAV/S1	HANDICAPPED LAVATORY	1/2"	1/2"	2"	1-1/2"
HVC/WC/TO/TD2	HANDICAPPED WATER CLOSET	-	1"	3"	2"
MS/MB	MOP BASIN	3/4"	3/4"	2"	1 1/2"
FD	FLOOR DRAIN	-	-	3"	1 1/2"
DF	DRINKING FOUNTAIN	-	1/2"	2"	1 1/2"
UR	URINAL	-	3/4"	3"	2"
SK/S2/S3/S4	SINK	1/2"	1/2"	2"	1 1/2"
WH	WALL HYDRANT	-	1/2"	-	-

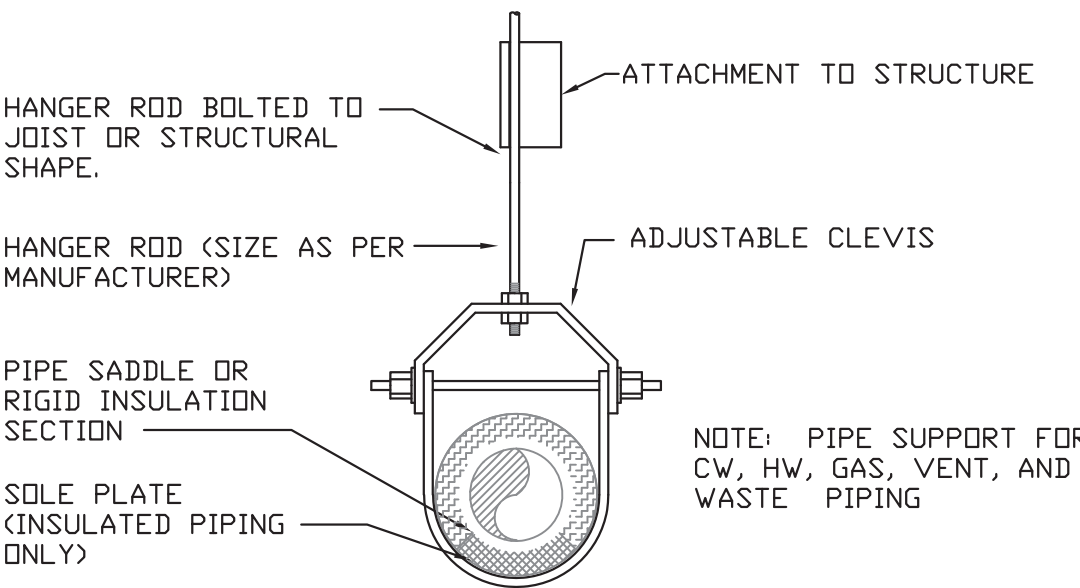

1 PIPE HANGER DETAIL
SCALE: NOT TO SCALE

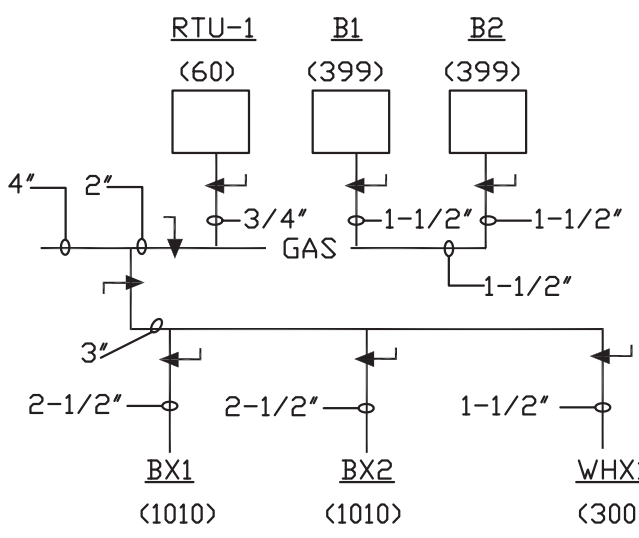

2 GAS RISER DIAGRAM
SCALE: NOT TO SCALE

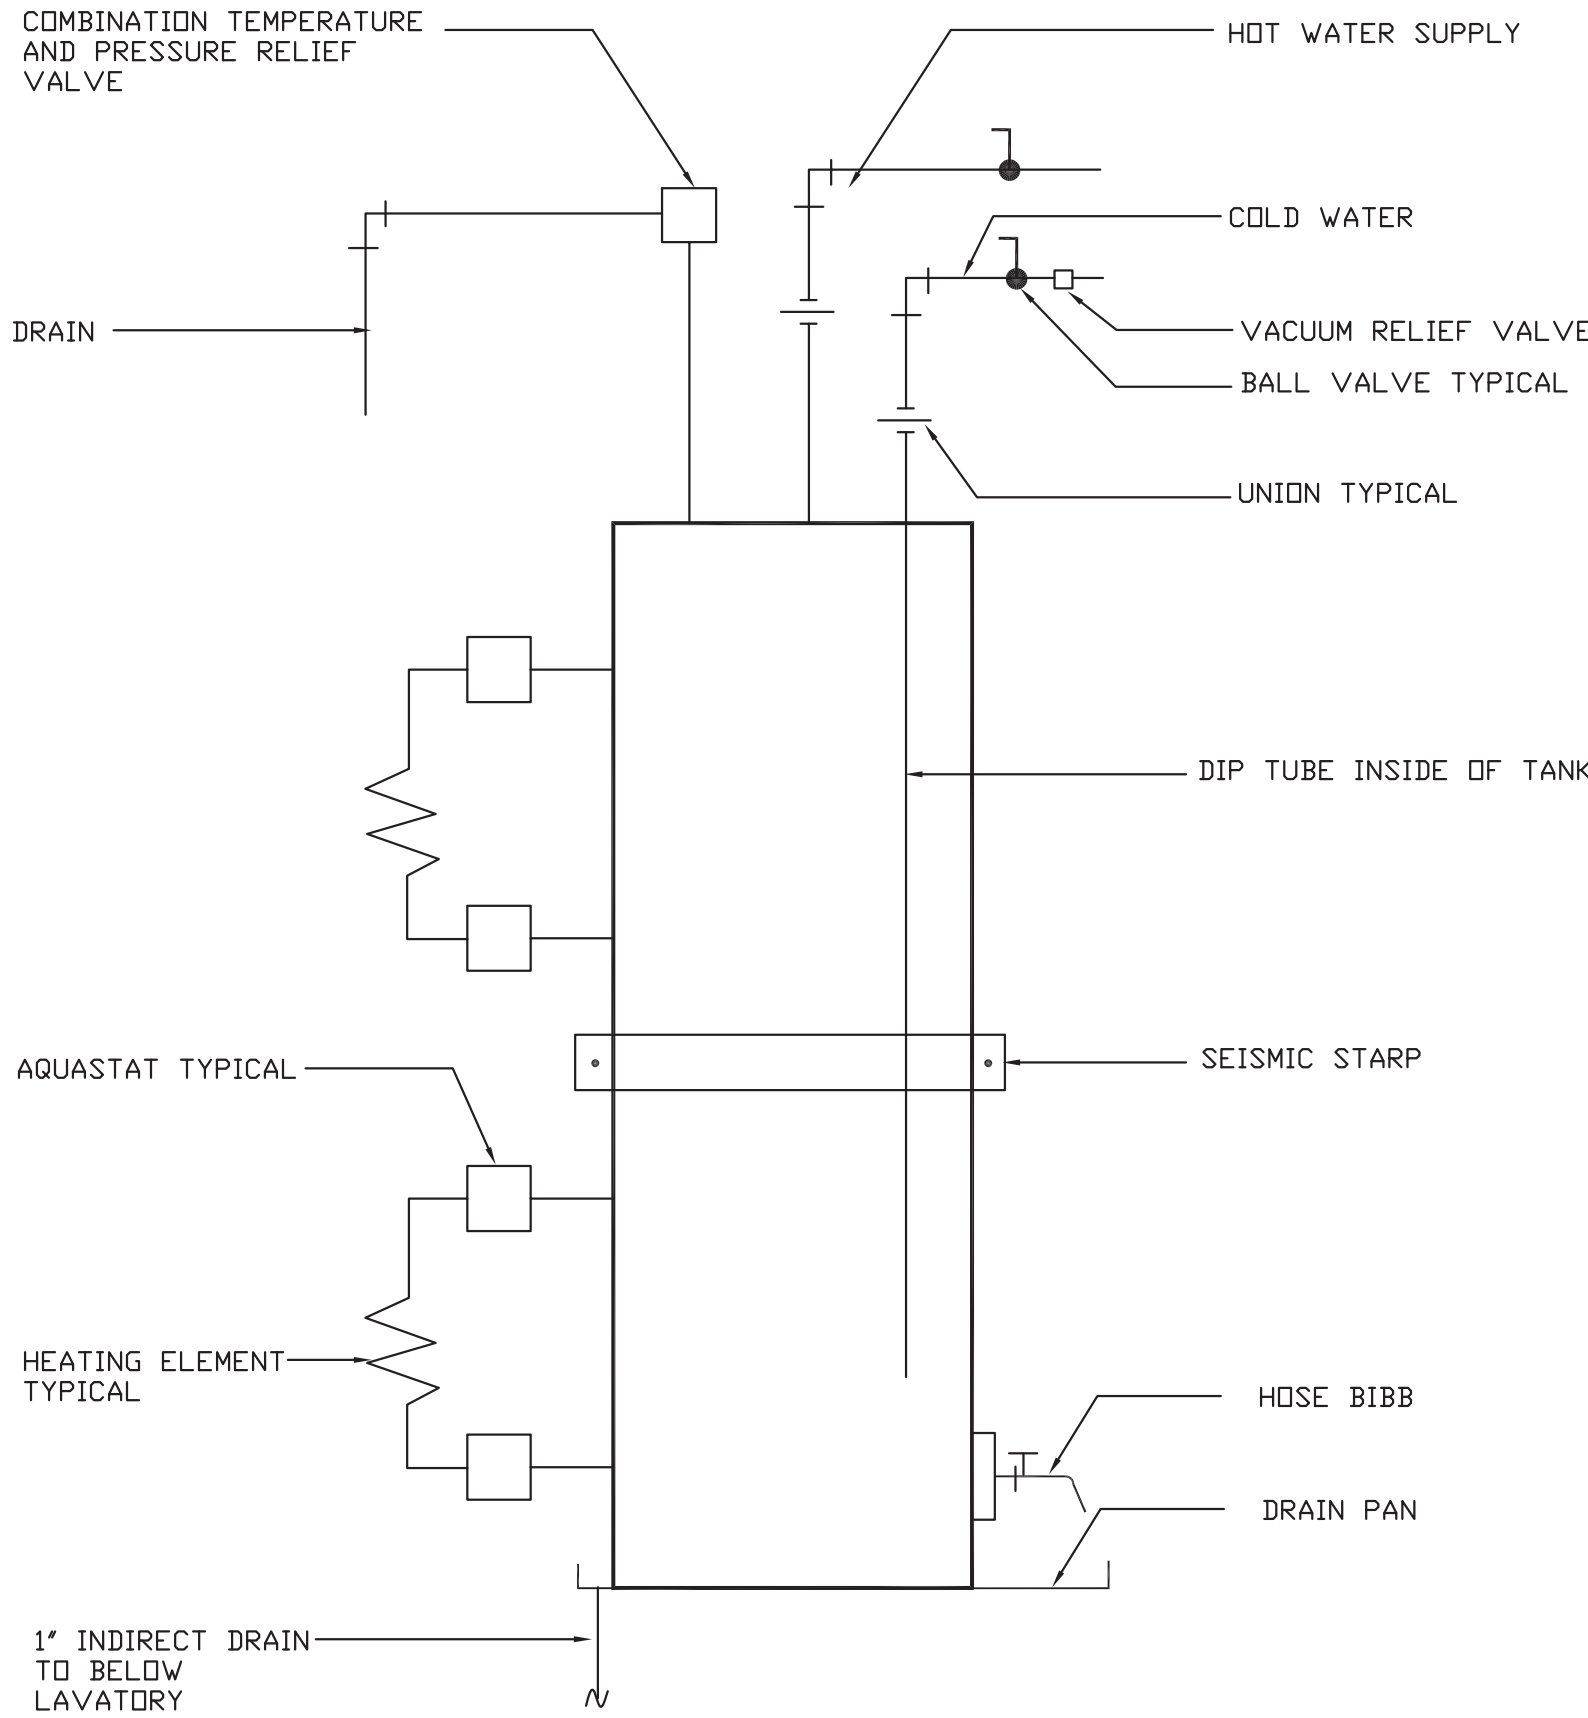

3 ELECTRIC WATER HEATER DETAIL
SCALE: NOT TO SCALE

2	1/21/2022	ADDENDUM NO 7
1	11/9/2021	RELEASE FOR BID
ISSUE NO.	ISSUE DATE	DESCRIPTION



ORANGETOWN
TOWN HALL
ADDITION AND ALTERATIONS

26 ORANGEBURG RD
ORANGEBURG, NEW YORK 10962

SCHEDULES AND
DETAILS

PROJECT NO.: 2219-05

DRAWING NO.:

P-302