


S:\2024\PROJECTS\2024\21030 Orangetown Town Hall Renovation\Drawings\PROJECT\15-302.dwg




PLUMBING FIXTURE SCHEDULE	
TAG NUMBER	DESCRIPTION
TO	WALL MOUNTED TOILET : SLOAN – WHITE VITREOUS CHINA / WALL MOUNTED ST-2459 / CODE 2102459
TO2	FLOOR MOUNTED TOILET : SLOAN – WHITE VITREOUS CHINA / FLOOR MOUNTED / ST-2009 / CODE 2102009
FL	FLUSHOMETER : SLOAN – SENSORED WITH COURTESY FLUSH OVERRIDE BUTTON / G2 8111 / CODE 3250289
UR	URINAL : KOHLER – STEWARD – HYBRID HIGH EFFICIENCY URINAL (HEU) – K-5244-ER – WHITE FINISH
UF	URINAL FLUSHOMETER : SLOAN – ROYAL SENSOR FLUSHOMETER – ROYAL 186 SMO
S1	SINK, LAVATORY : KOHLER – CAXTON RECTANGLE UNDER – MOUNT BATHROOM SINK – K-20000 – WHITE FINISH
S2	SINK : KOHLER – GREENWICH 20-3/4" X 18-1/4" WALL MOUNTED SINK –K-2032-L-0
FA	FAUCET : DELTA – COMPEL COLLECTION – SINGLE HANDLE DECK MOUNT TOUCH 2.0 TECHNOLOGY – CHROME FINISH – MODEL #561T-DST
DF	DRINKING FOUNTAIN – EZH2O BOTTLE FILLING STATION & VERSATILE BI-LEVEL ADA COOLER, FILTERED NON-REFRIGERATED BY ELKAY MODEL: #LZSTL6WSSP STAINLESS
SS	AMERICAN STANDARD – COLONY PRO 25X22 ADA STAINLESS STEEL KITCHEN SINK #22SB6252284S.075
SS4	AMERICAN STANDARD – COLONY PRO 15X15 ADA STAINLESS STEEL KITCHEN SINK #22SB.6151511S.075
FI	AMERICAN STANDARD – AVERY PULL DOWN KITCHEN FAUCET WITH SELECTRONIC HANDS FREE TECHNOLOGY – MODEL #4901.380
SP	HYDRO SYSTEMS – UNIVERSAL SHOWER PAN
ST	DELTA – MONITOR 17 SERIES SHOWER TRIM – STAINLESS/ #T17233-SS-I
MB	MOP BASIN – FIAT MSB3624 WITH 830AA FAUCET, 832AA HOSE AND BRACKET AND 889CC MOP HANGER BRACKET.
WH	FREEZE PROTECTED HYDRANT MANUFACTURED BY WATTS MODEL NO. FHB FROST PRODF AUTOMATIC DRAINING WALL HYDRANT WITH BACK FLOW PREVENTION.
FD	FLOOR DRAIN AS MANUFACTURED BY JR SMITH MODEL NUMBER 2130 MEDIUM DUTY WITH 12" ROUND TOP
ASP	ACCESSIBLE SHOWER PAN- GRIFform INNOVATIONS SOLID SURFACE CUSTOMIZABLE PAN WITH LOW EGRESS THRESHOLD. COLOR SHALL BE CONCRETE. PROVIDE SLIP RESISTANT FINISH.
ASB	ACCESSIBLE SHOWER BODY – AMERICAN STANDARD FLASH ROUGH SHOWER VALVE BODY WITH TU662.213 COMMERCIAL SHOWER SYSTEM TRIM KIT.


FIXTURE CONNECTION SCHEDULE					
MARK	DESCRIPTION	HW	CW	W	V
HLAV/LAV/S1	HANDICAPPED LAVATORY	1/2"	1/2"	2"	1-1/2"
HVC/WC/TO/TO2	HANDICAPPED WATER CLOSET	-	1"	3"	2"
MS/MB	MOP BASIN	3/4"	3/4"	2"	1 1/2"
FD	FLOOR DRAIN	-	-	3"	1 1/2"
DF	DRINKING FOUNTAIN	-	1/2"	2"	1 1/2"
UR	URINAL	-	3/4"	3"	2"
SK/S2/S3/S4	SINK	1/2"	1/2"	2"	1 1/2"
WH	WALL HYDRANT	-	1/2"	-	-

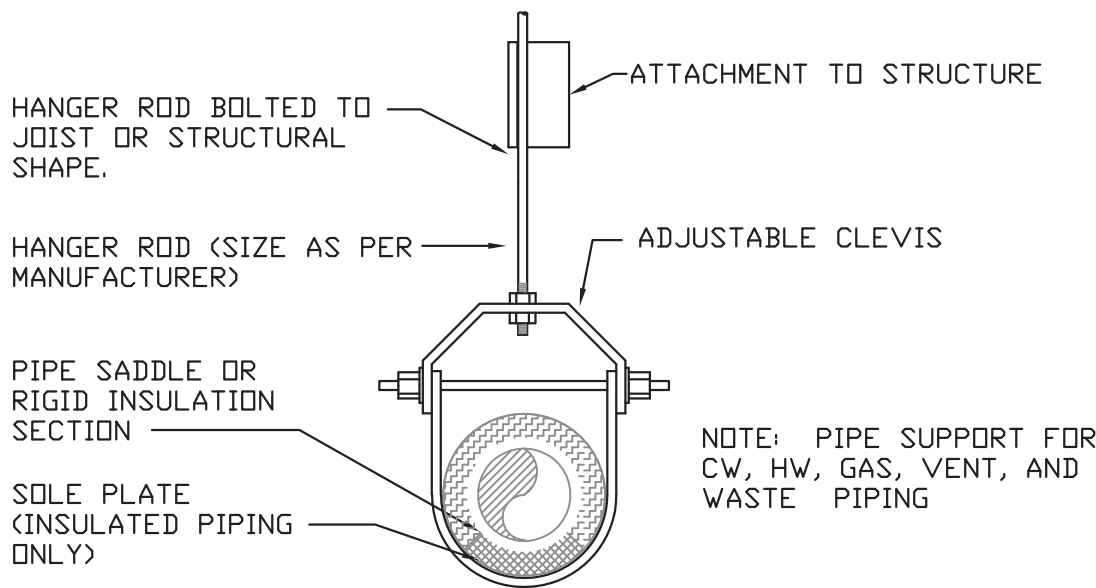

① PIPE HANGER DETAIL
SCALE: NOT TO SCALE

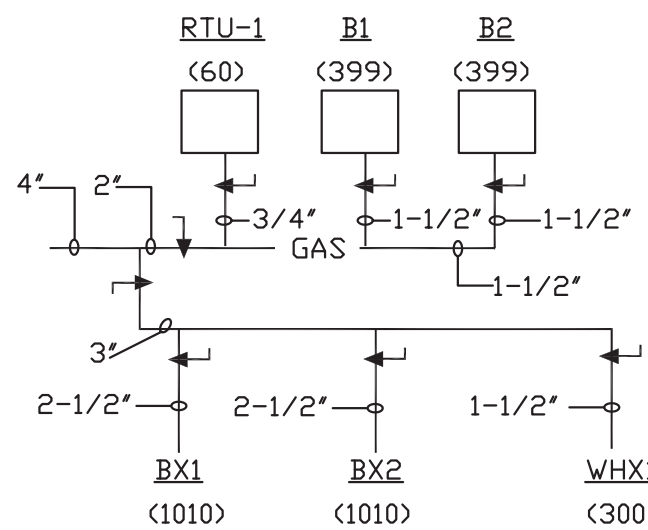

② GAS RISER DIAGRAM
SCALE: NOT TO SCALE

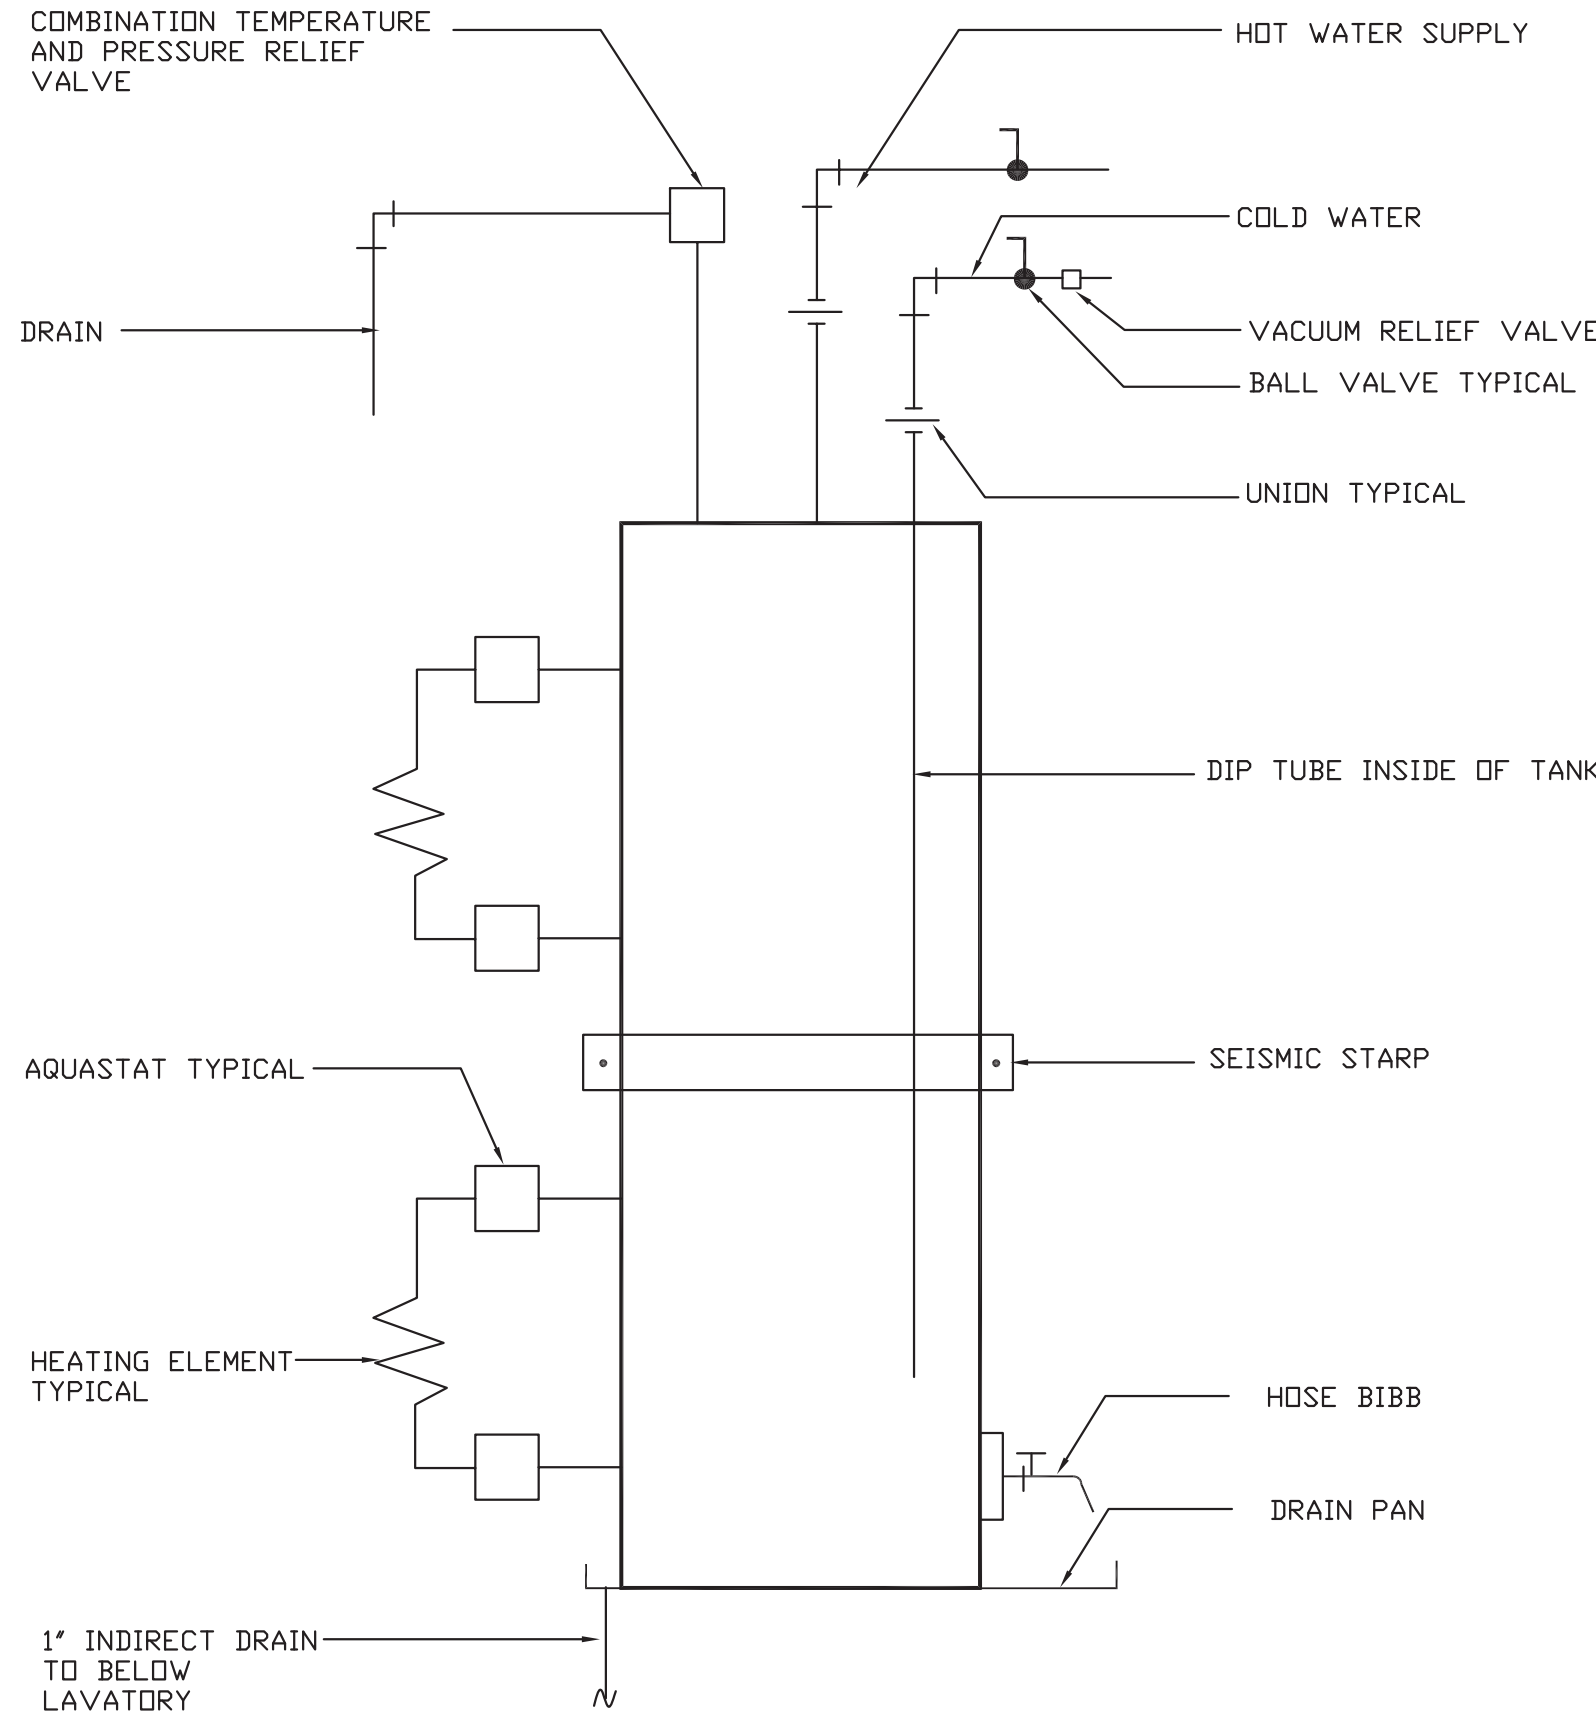

③ ELECTRIC WATER HEATER DETAIL
SCALE: NOT TO SCALE

Lothrop

Lothrop Associates LLP Architects
333 Westchester Avenue
White Plains, New York 10604
914-741-1115

White Plains Rochester Red Bank Hartford

CBK Engineering PC

44-46 Foster Road Suite 7
Hopewell Junction , N.Y. 12533
T (914) 509-6557 F (914) 509-8162

CBK PROJECT NO. 21030

1	11/9/2021	RELEASE FOR BID
ISSUE NO.	ISSUE DATE	DESCRIPTION



ORANGETOWN TOWN HALL

ADDITION AND ALTERATIONS

26 ORANGEBURG RD
ORANGEBURG, NEW YORK 10962

SCHEDULES AND DETAILS

PROJECT NO.: 2219-05

DRAWING NO.:

P-302