 


KEYED NOTES	
1	PROVIDE PAD MOUNTED UTILITY COMPANY TRANSFORMER, COORDINATE PAD LOCATION AND REQUIREMENTS WITH UTILITY COMPANY.
2	CONCRETE ENCASED DUCTBANK FOR SECONDARY CONDUCTORS, REFER TO RISER DIAGRAM ON SHEET E-501 FOR ADDITIONAL INFORMATION.
3	PROVIDE 2-WAY DUCTBANK WITH PULL STRINGS FOR ROUTING OF UTILITY COMPANY PRIMARY CABLING, COORDINATE ROUTING AND REQUIREMENTS WITH UTILITY COMPANY.

[illegible]

KCI
TECHNOLOGIES

ENGINEERS
PLANNERS
SCIENTISTS

CONSTRUCTION MANAGERS

5001 LOUISE DRIVE, SUITE 201
MECHANICSBURG, PA 17055
PHONE: 717-691-1340
www.kci.com

SAA architects
Client centered • Smart solutions
100 North Hartley Street, Suite 150
York, PA 17404
717.333.7777
www.saaarchitects.com

ELECTRICAL SITE PLAN

POUGHKEEPSIE NY STORAGE

998 SOUTH ROAD POUGHKEEPSIE, NEW YORK 12601

DRAWING TITLE:



FILE No.: 22-222


DATE:

SCALE:

DRAWN BY:

DRAWING No.:

E-101

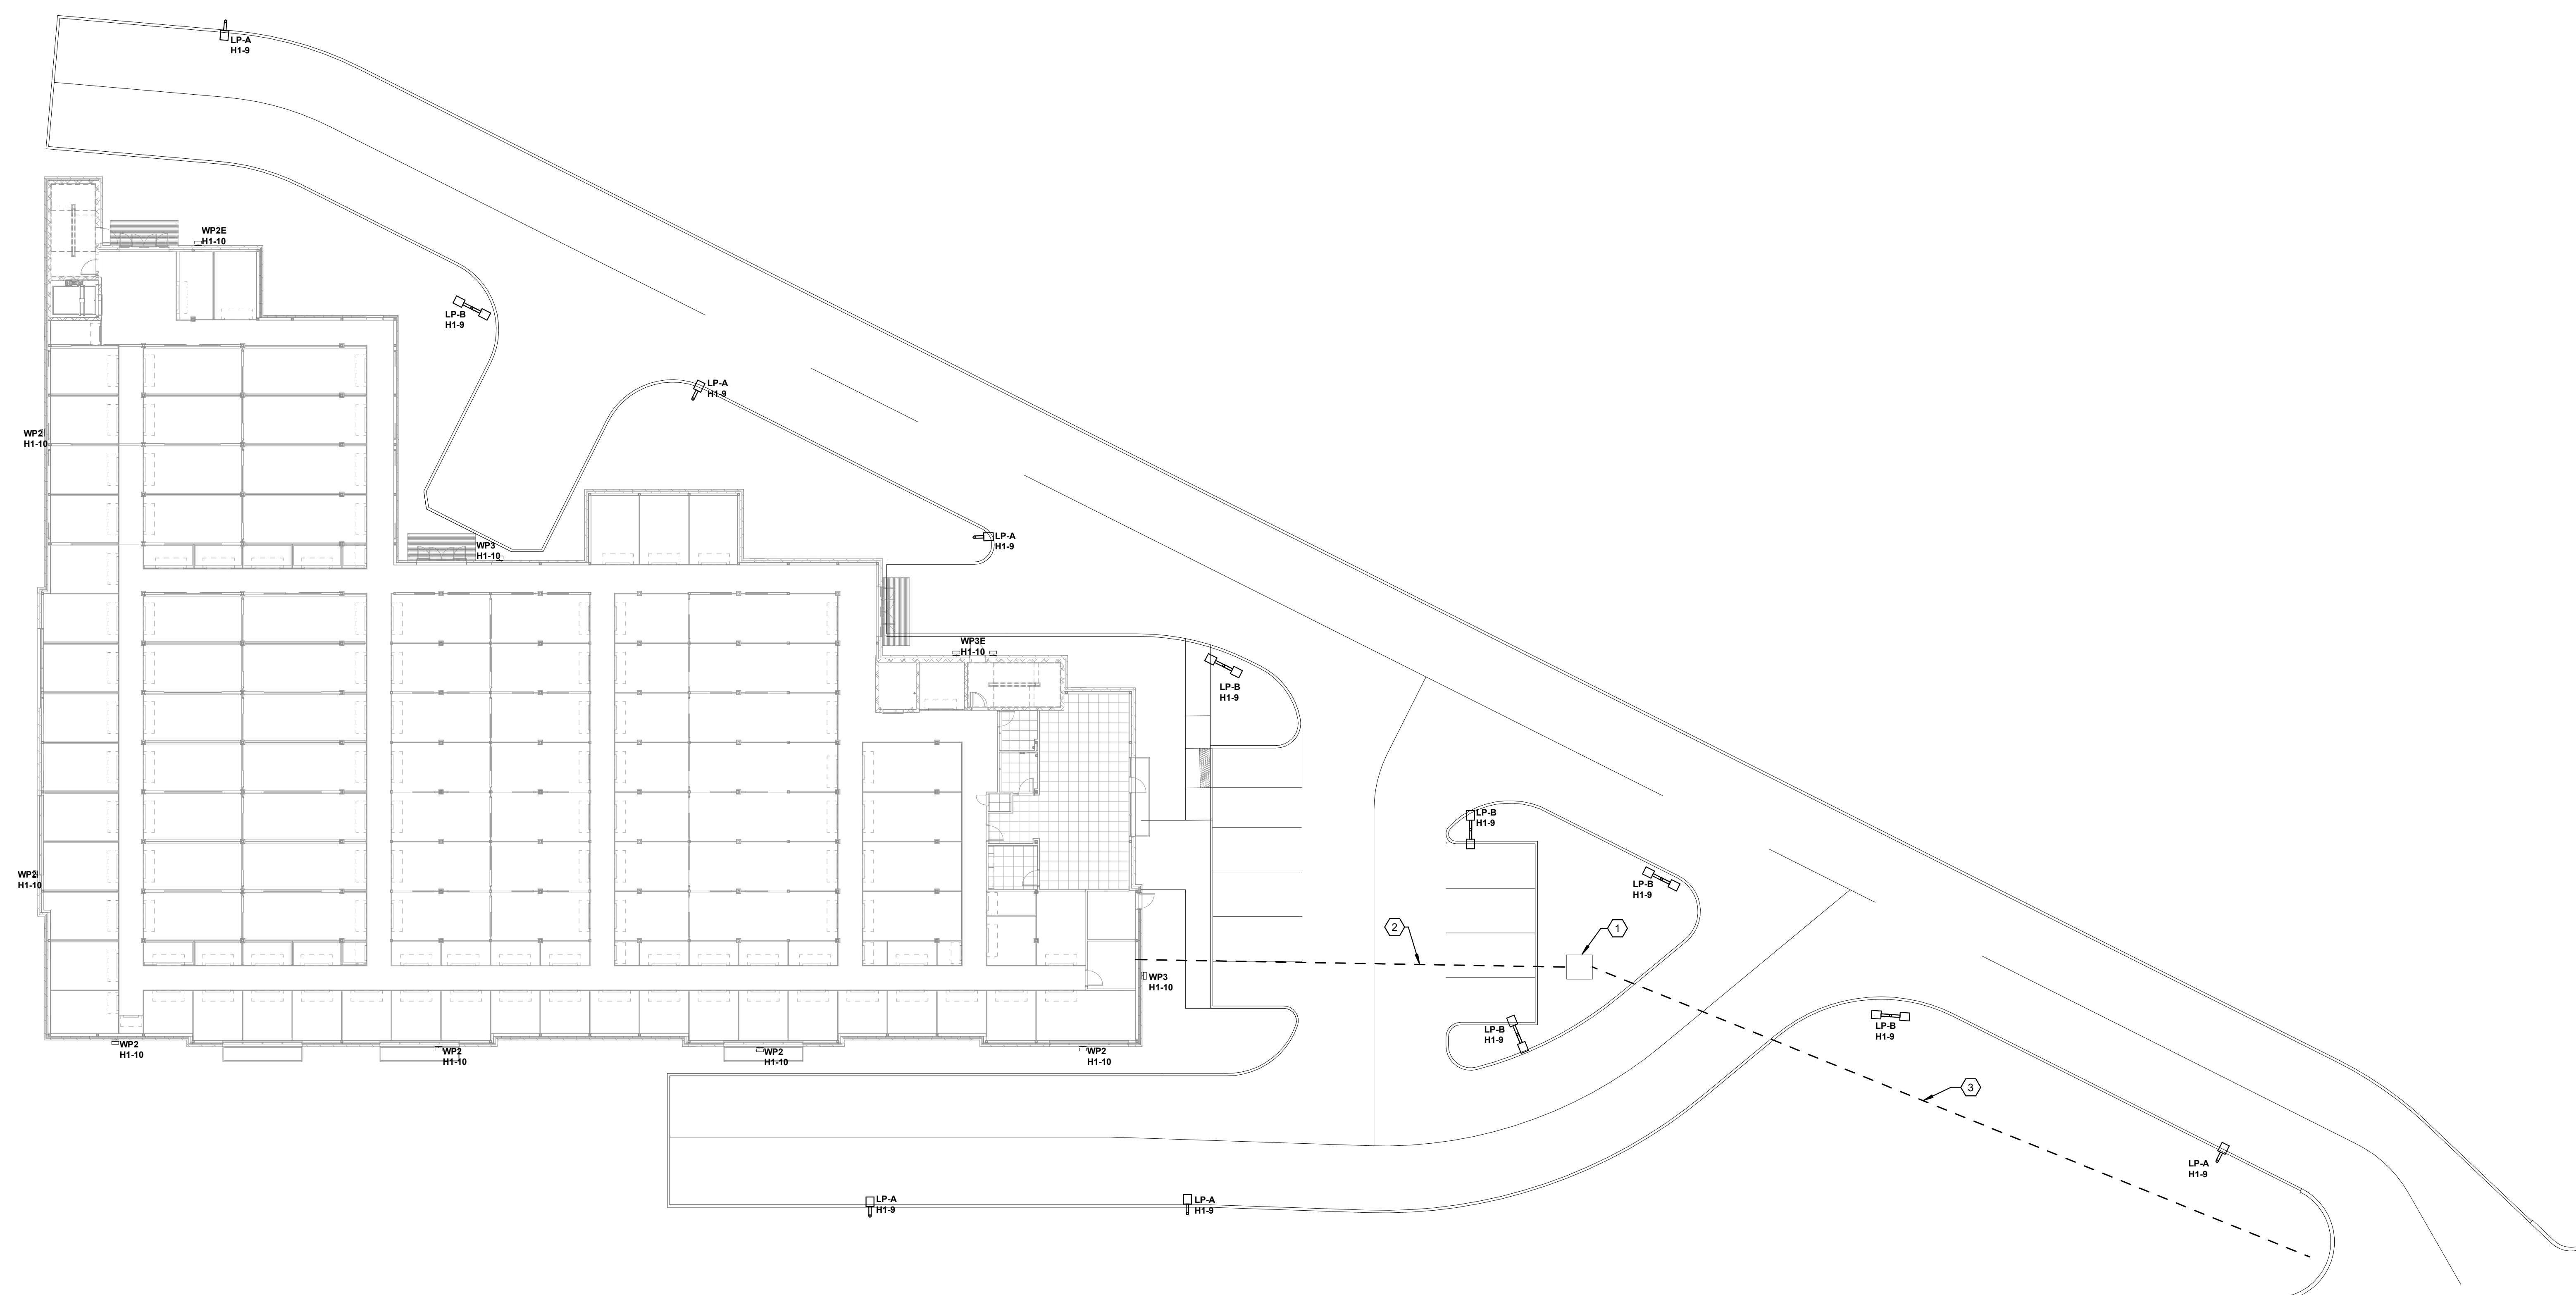

WARNING: it is a violation of the NYS Education Law Article 145 for any person to alter this document in anyway, unless they are acting under the direction of a Professional Engineer

ISSUED FOR PERMIT