



KEYED NOTES	
1	PHOTOELECTRIC SMOKE DETECTOR FOR ELEVATOR RECALL.
2	PROVIDE JUNCTION BOX WITH 120V POWER FOR BUILDING SIGN. PROVIDE 3/4" FOR POWER. COORDINATE EXACT ELECTRICAL REQUIREMENTS WITH SIGN VENDOR PRIOR TO INSTALLATION. COORDINATE SIGN LOCATION WITH ARCHITECT PRIOR TO ROUGH-IN.
3	MOUNT DEVICE 4'-0" AFF. TYPICAL FOR ALL STORAGE UNIT CORRIDOR RECEPTACLES.
4	PROVIDE RECEPTACLE WITH VERTICAL SELF-CLOSING COVERS WITH LOCK HASPS. ALL KEYS ALIKE. TYPICAL FOR ALL STORAGE UNIT CORRIDOR RECEPTACLES.
5	PROVIDE 240V, 2P, 60A NON-FUSED DISCONNECT SWITCH.
6	PROVIDE MANUAL MOTOR STARTER WITH PROPER THERMAL ELEMENT INSTALLED.

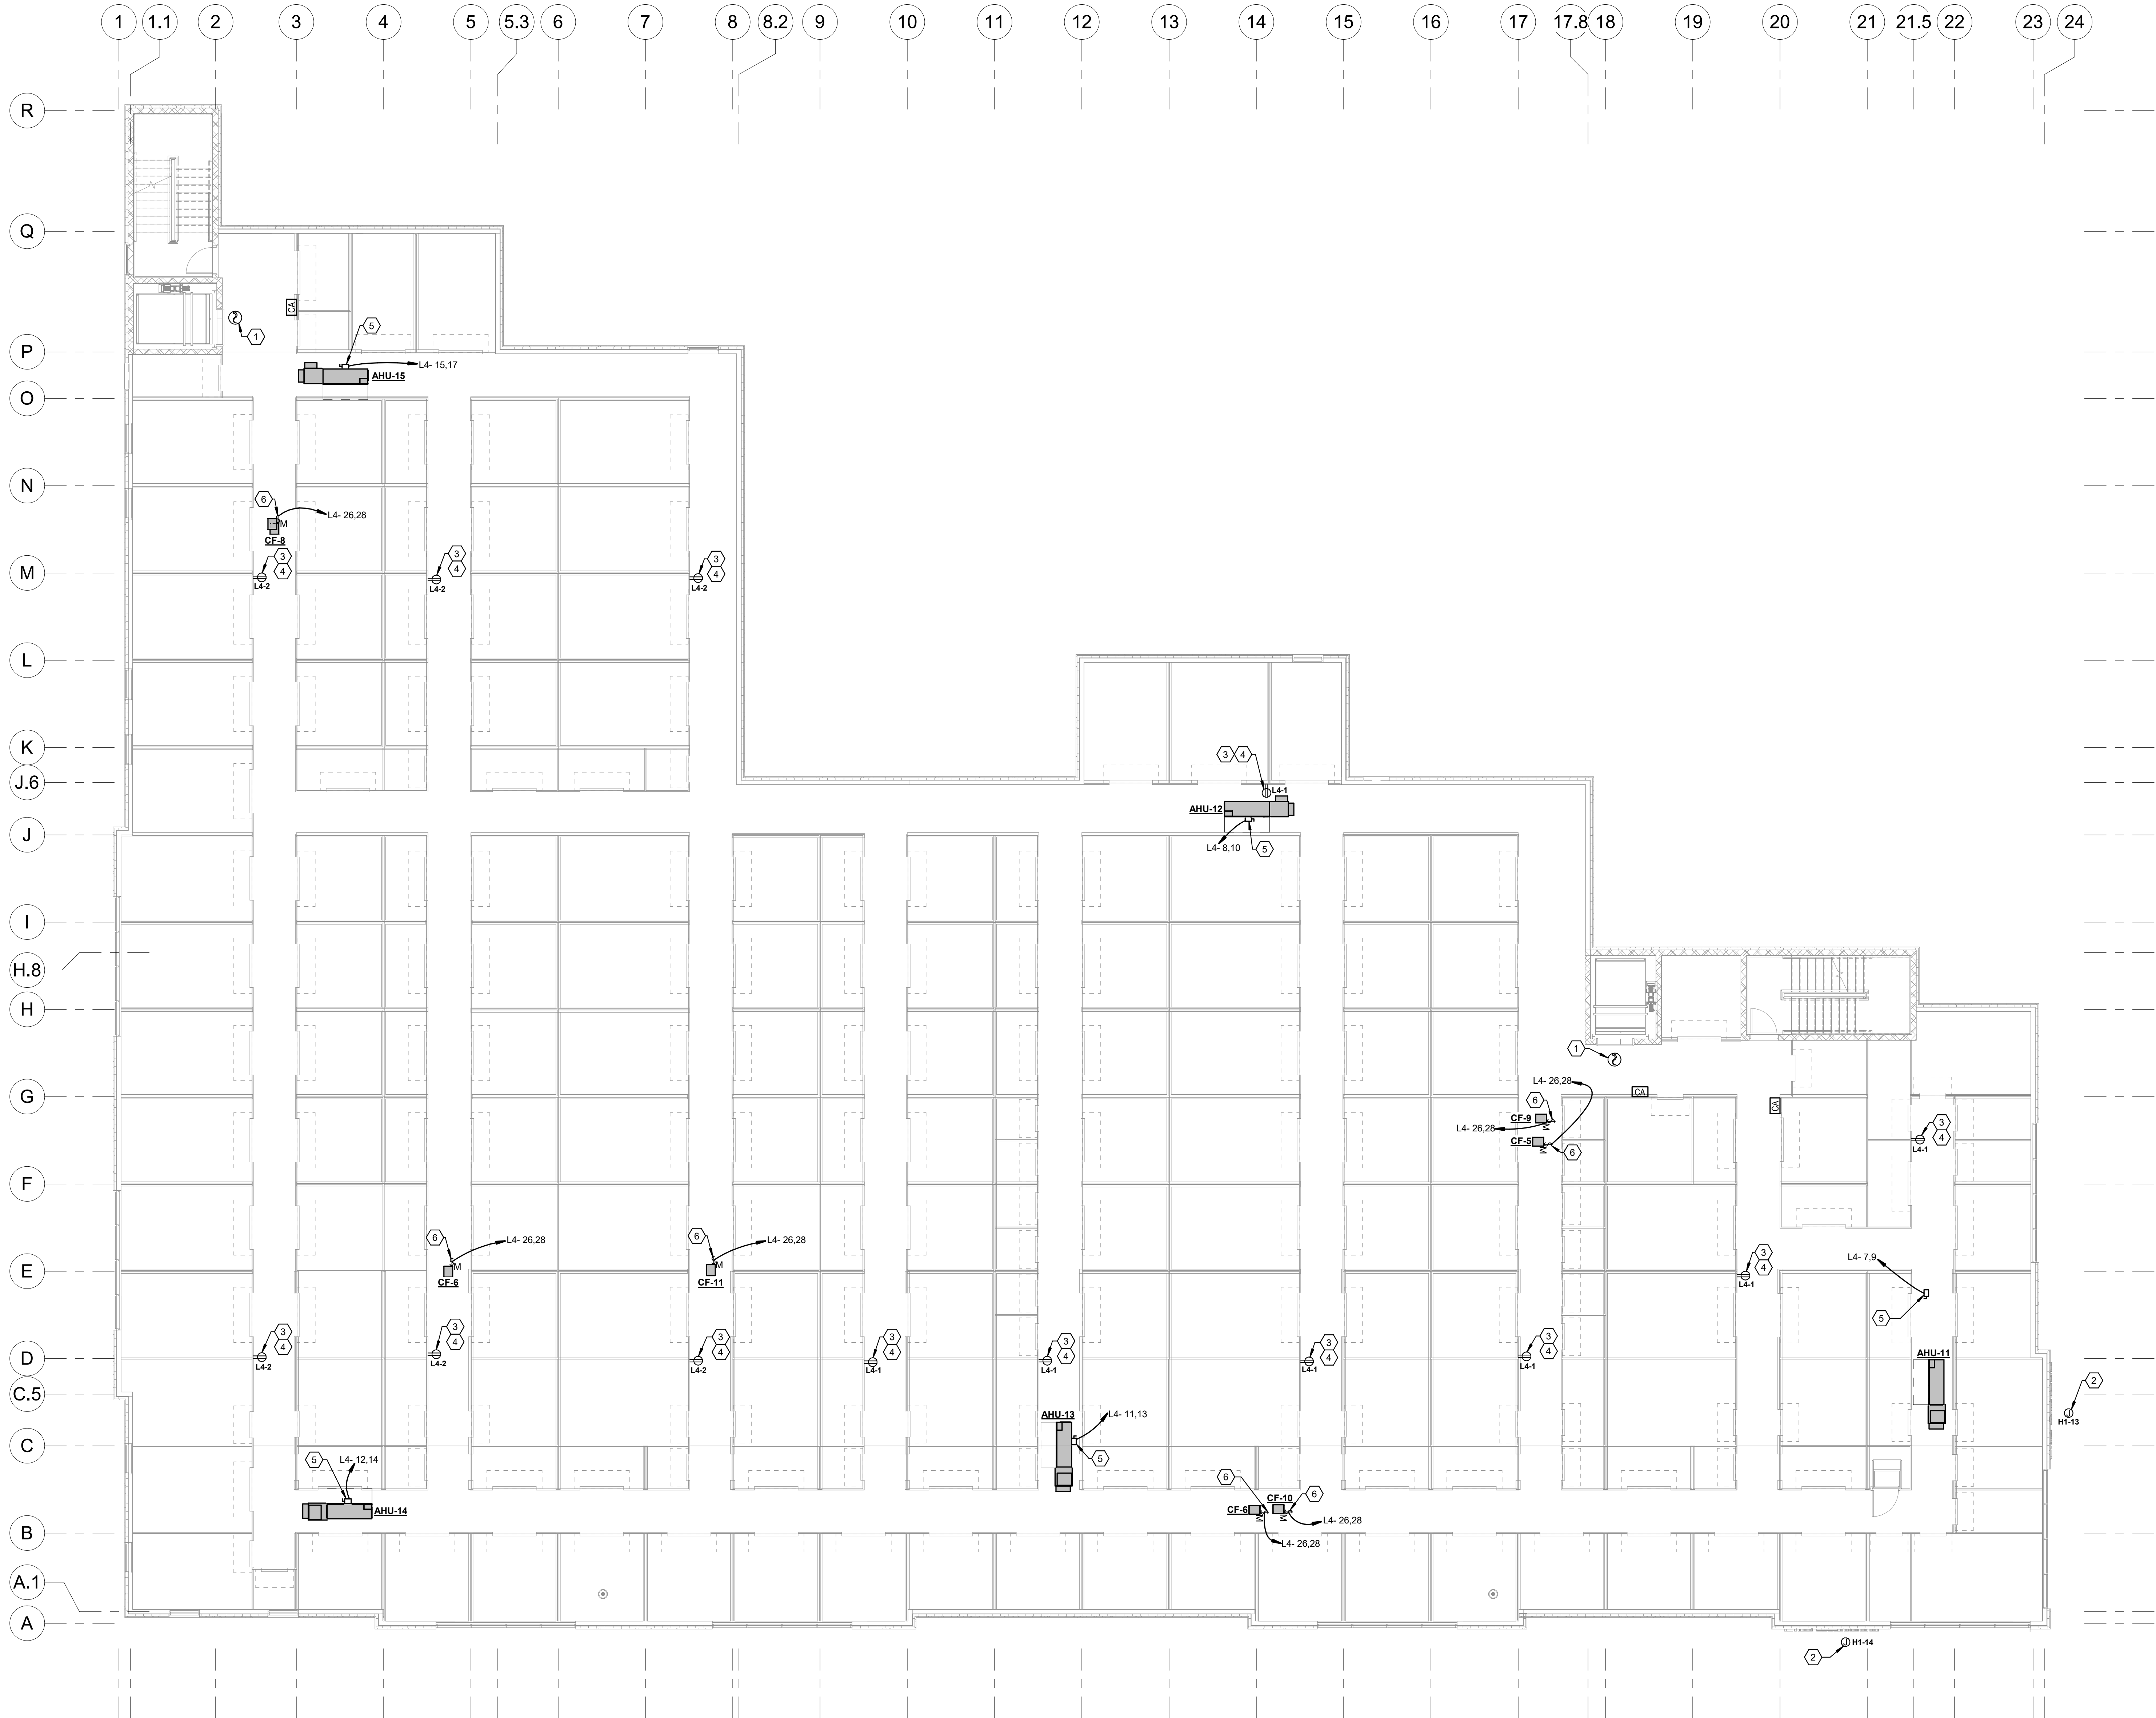

1 ELECTRICAL POWER PLAN - THIRD FLOOR
1/8" = 1'-0"

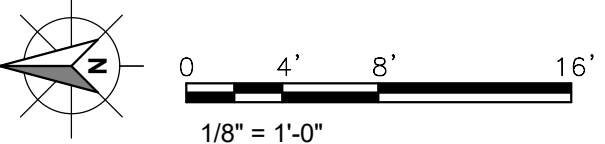

WARNING: It is a violation of the NYS Education Law Article 145 for any person to alter this document in anyway, unless they are acting under the direction of a Professional Engineer

ISSUED FOR PERMIT

REVISIONS	
No.	Description

ENGINEERS
PLANNERS
SCIENTISTS
CONSTRUCTION MANAGERS
KCI
TECHNOLOGIES
500 LOUISE DRIVE, SUITE 300
ROCKVILLE, MD 20850
PHONE: 717-691-1340
WWW.KCI.COM

SAA architects
Client centered • Smart solutions
600 North Hanley Street, Suite 150
York, PA 17404
T - 717.843.3200 F - 717.698.0205
www.SAAarchitects.com

DRAWING TITLE
ELECTRICAL POWER PLAN - THIRD FLOOR
POUGHKEEPSIE NY STORAGE
DIAMOND POINT DEVELOPMENT
1999 SOUTH ROAD POUGHKEEPSIE, NEW YORK 12601
DUTCHESS COUNTY



FILE NO:	22-082
DATE:	7/1/2022
SCALE:	AS NOTED
DRAWN BY:	AMB
DRAWING NO.:	E-203