


KEYED NOTES	
1	PROVIDE JUNCTION BOX WITH 120V POWER FOR BUILDING SIGN. PROVIDE 34°C FOR POWER. COORDINATE EXACT ELECTRICAL REQUIREMENTS WITH SIGN VENDOR PRIOR TO INSTALLATION. COORDINATE SIGN LOCATION WITH ARCHITECT PRIOR TO ROUGH-IN.
2	PROVIDE 240V, 2P, 30A, NON-FUSED DISCONNECT IN NEMA 3R ENCLOSURE
3	PROVIDE 600V, 3P, 30A, NON-FUSED DISCONNECT IN NEMA 3R ENCLOSURE

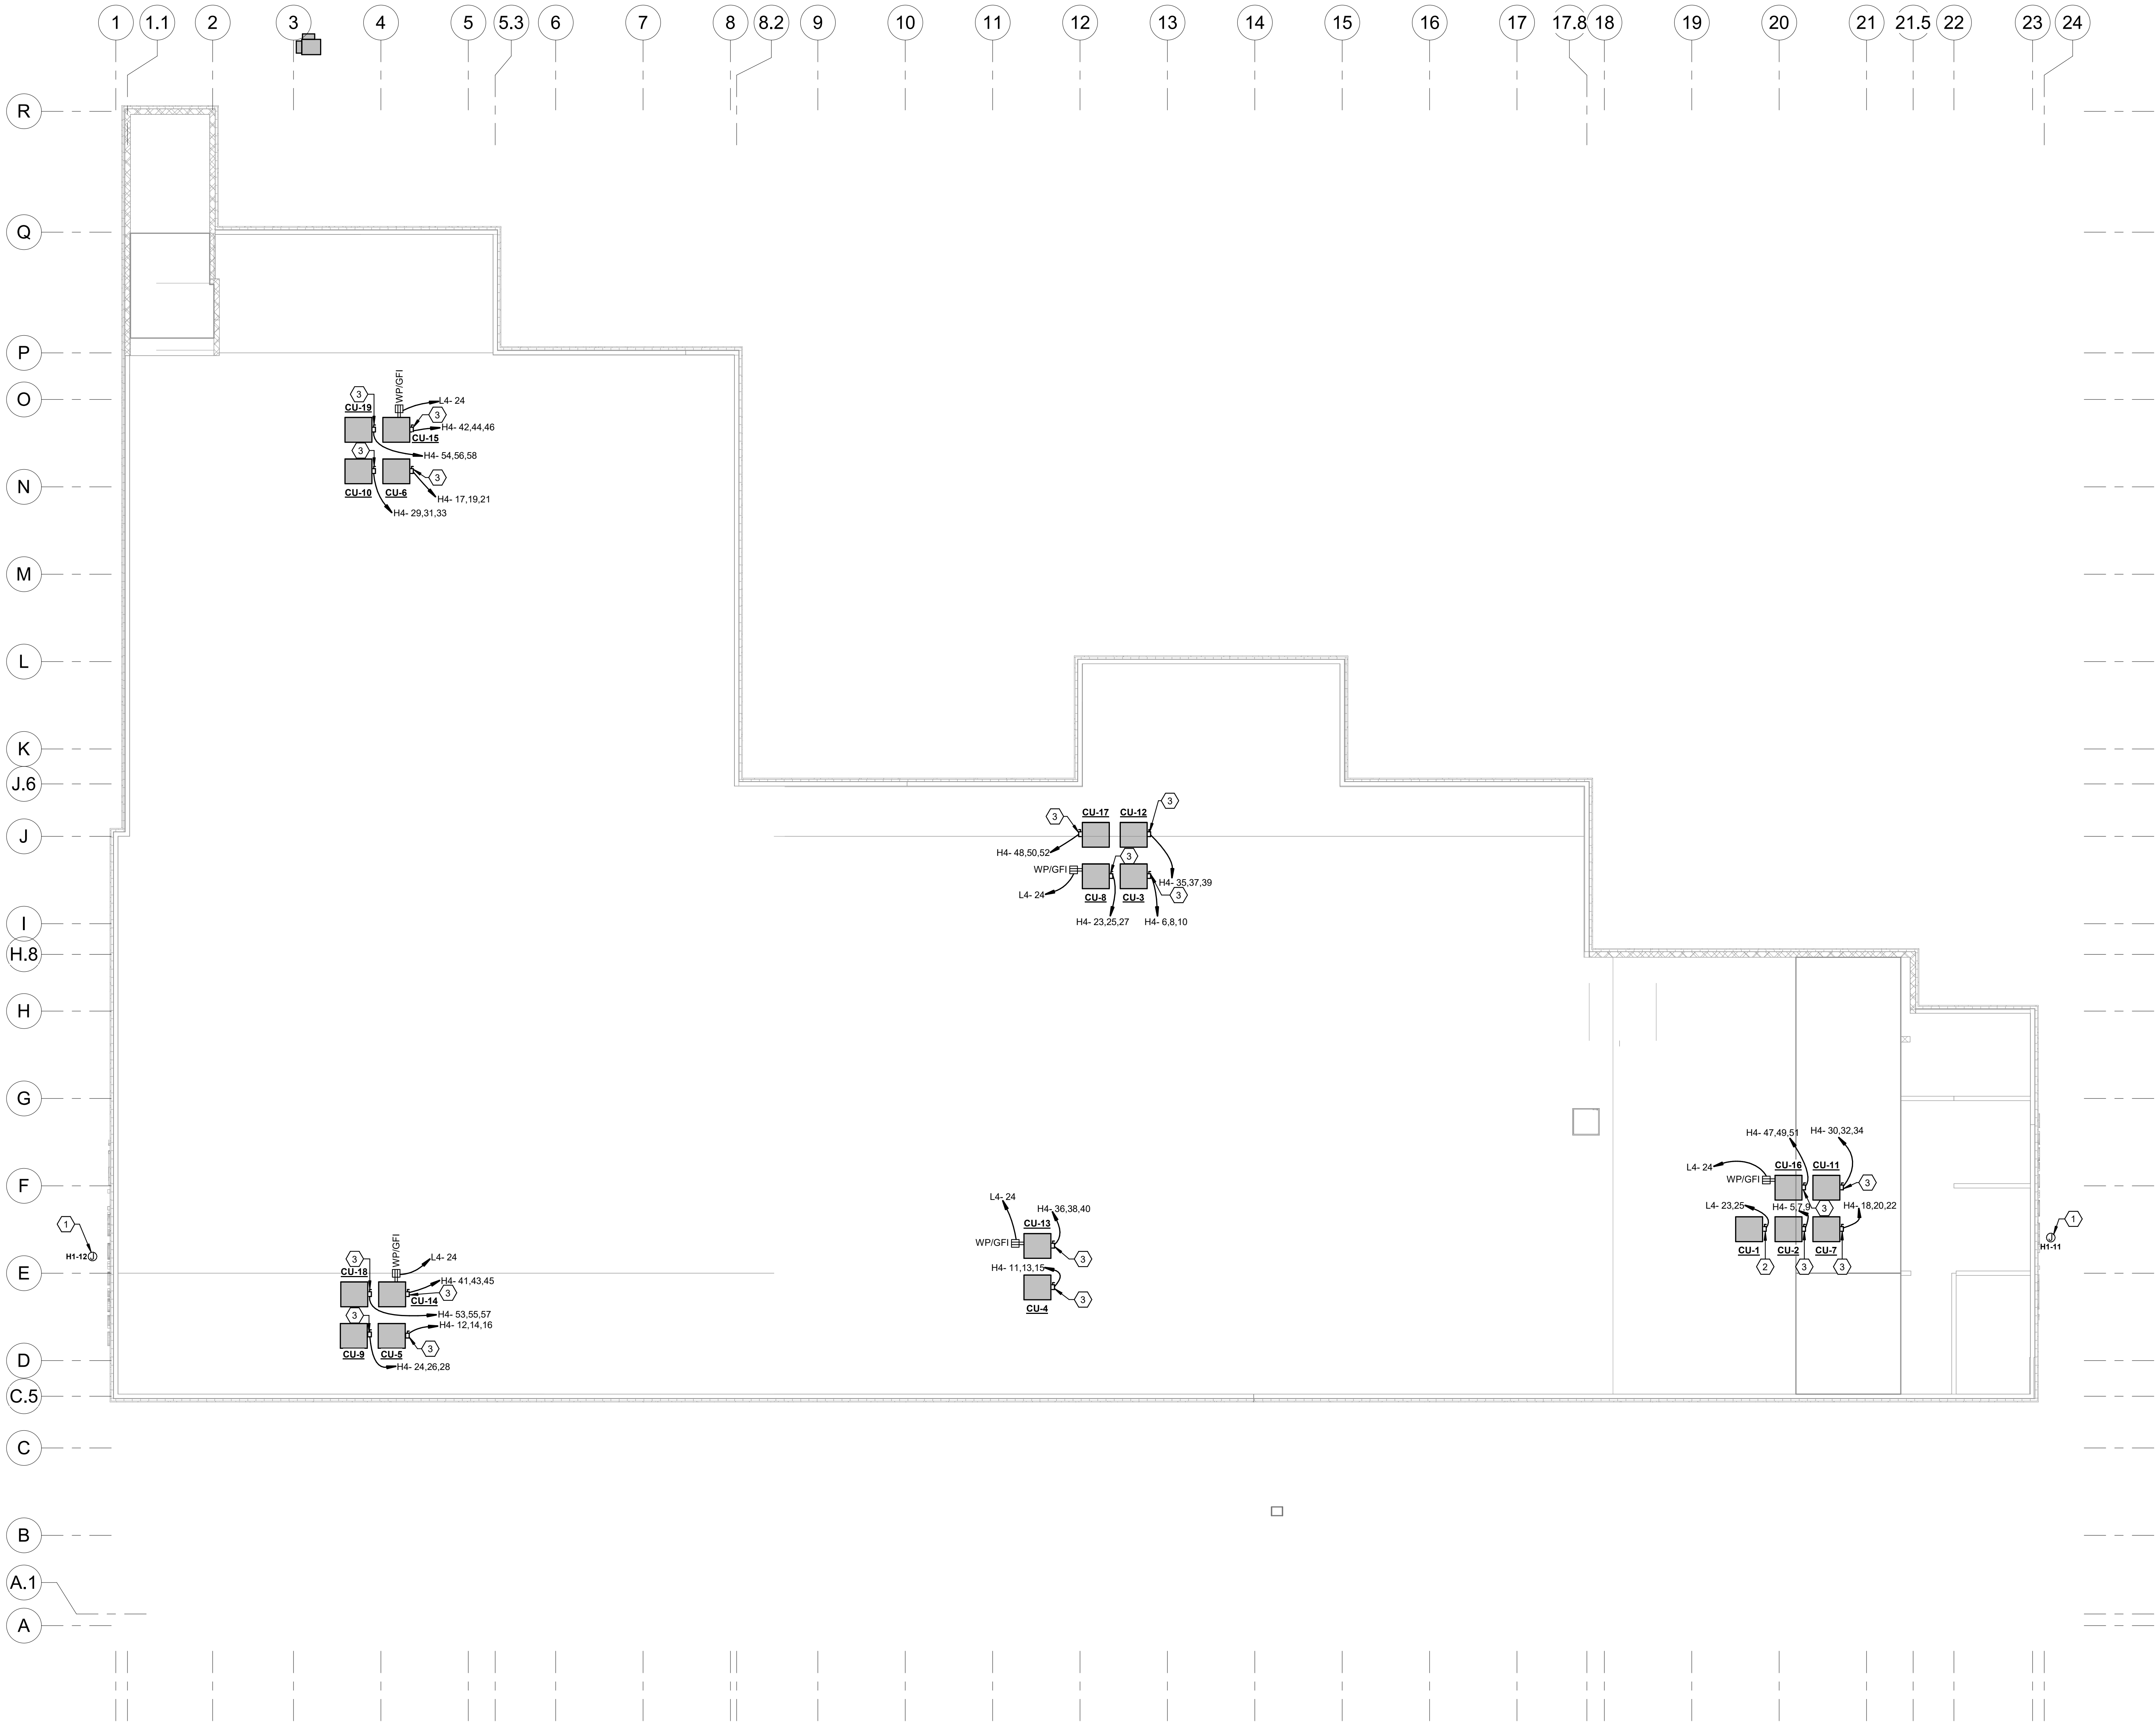

REVISIONS	
No.	Description

ENGINEERS
PLANNERS
SCIENTISTS
CONSTRUCTION MANAGERS
KCI
TECHNOLOGIES
5000 LOUISE DRIVE SUITE 300
BIRMINGHAM, AL 35205
PHONE: 205-991-1340
WWW.KCI.COM

SAAarchitects
Client centered • Smart solutions
600 North Hanley Street, Suite 150
Yonk, PA 17404
T - 717 843.3200 F - 717 698.0205
www.SAAarchitects.com

DRAWING TITLE
© 2020 SAAarchitects, Inc.
ELECTRICAL POWER PLAN - ROOF
POUGHKEEPSIE NY STORAGE
DIAMOND POINT DEVELOPMENT
1999 SOUTH ROAD POUGHKEEPSIE, NEW YORK 12601
DUTCHESS COUNTY



FILE No:	22-082
DATE:	7/1/2022
SCALE:	AS NOTED
DRAWN BY:	AMB
DRAWING No.:	E-205

WARNING: It is a violation of the NYS Education Law Article 145 for any person to alter this document in anyway, unless they are acting under the direction of a Professional Engineer

ISSUED FOR PERMIT