



- ELECTRICAL GENERAL NOTES**
- SEE SHEET E-001 FOR SYMBOL, ABBREVIATIONS, GENERAL NOTES AND NEMA RATING OF ENCLOSURES FOR EACH RESPECTIVE AREA.
 - CONTRACTOR SHALL FIELD COORDINATE ALL ELECTRICAL INSTALLATIONS WITH ALL DISCIPLINES.
 - SEE LIGHT FIXTURE AND PANEL SCHEDULES ON SHEET E-602 FOR BRANCH CIRCUIT CONDUIT AND WIRING SIZES.
 - CONNECT EXIT SIGNS AND EMERGENCY BATTERY PACKS AT LIGHT FIXTURES TO LIGHT CIRCUIT SERVING AREA, AHEAD OF ANY LIGHTING CONTROL.
 - IN ACCORDANCE WITH NEC 358.26, THERE SHALL BE NO MORE THAN A TOTAL OF 360° OF BENDS IN A CONDUIT ROUTING BETWEEN PULL POINTS (BOXES AND ENCLOSURES).
 - HOMERUN FOR EXTERIOR WALL PACKS TO RUN THROUGH EXTERIOR LIGHTING CONTROL CONTACTOR. REFER TO DETAIL 7 ON SHEET E-502 FOR ADDITIONAL INFORMATION.

KEYED NOTES

- COORDINATE THE LOCATION OF ALL ELEVATOR PIT AND SHAFT LIGHTING, RECEPTACLES, EQUIPMENT, ETC. WITH ARCHITECT, ELEVATOR MANUFACTURER AND EQUIPMENT PROVIDED.

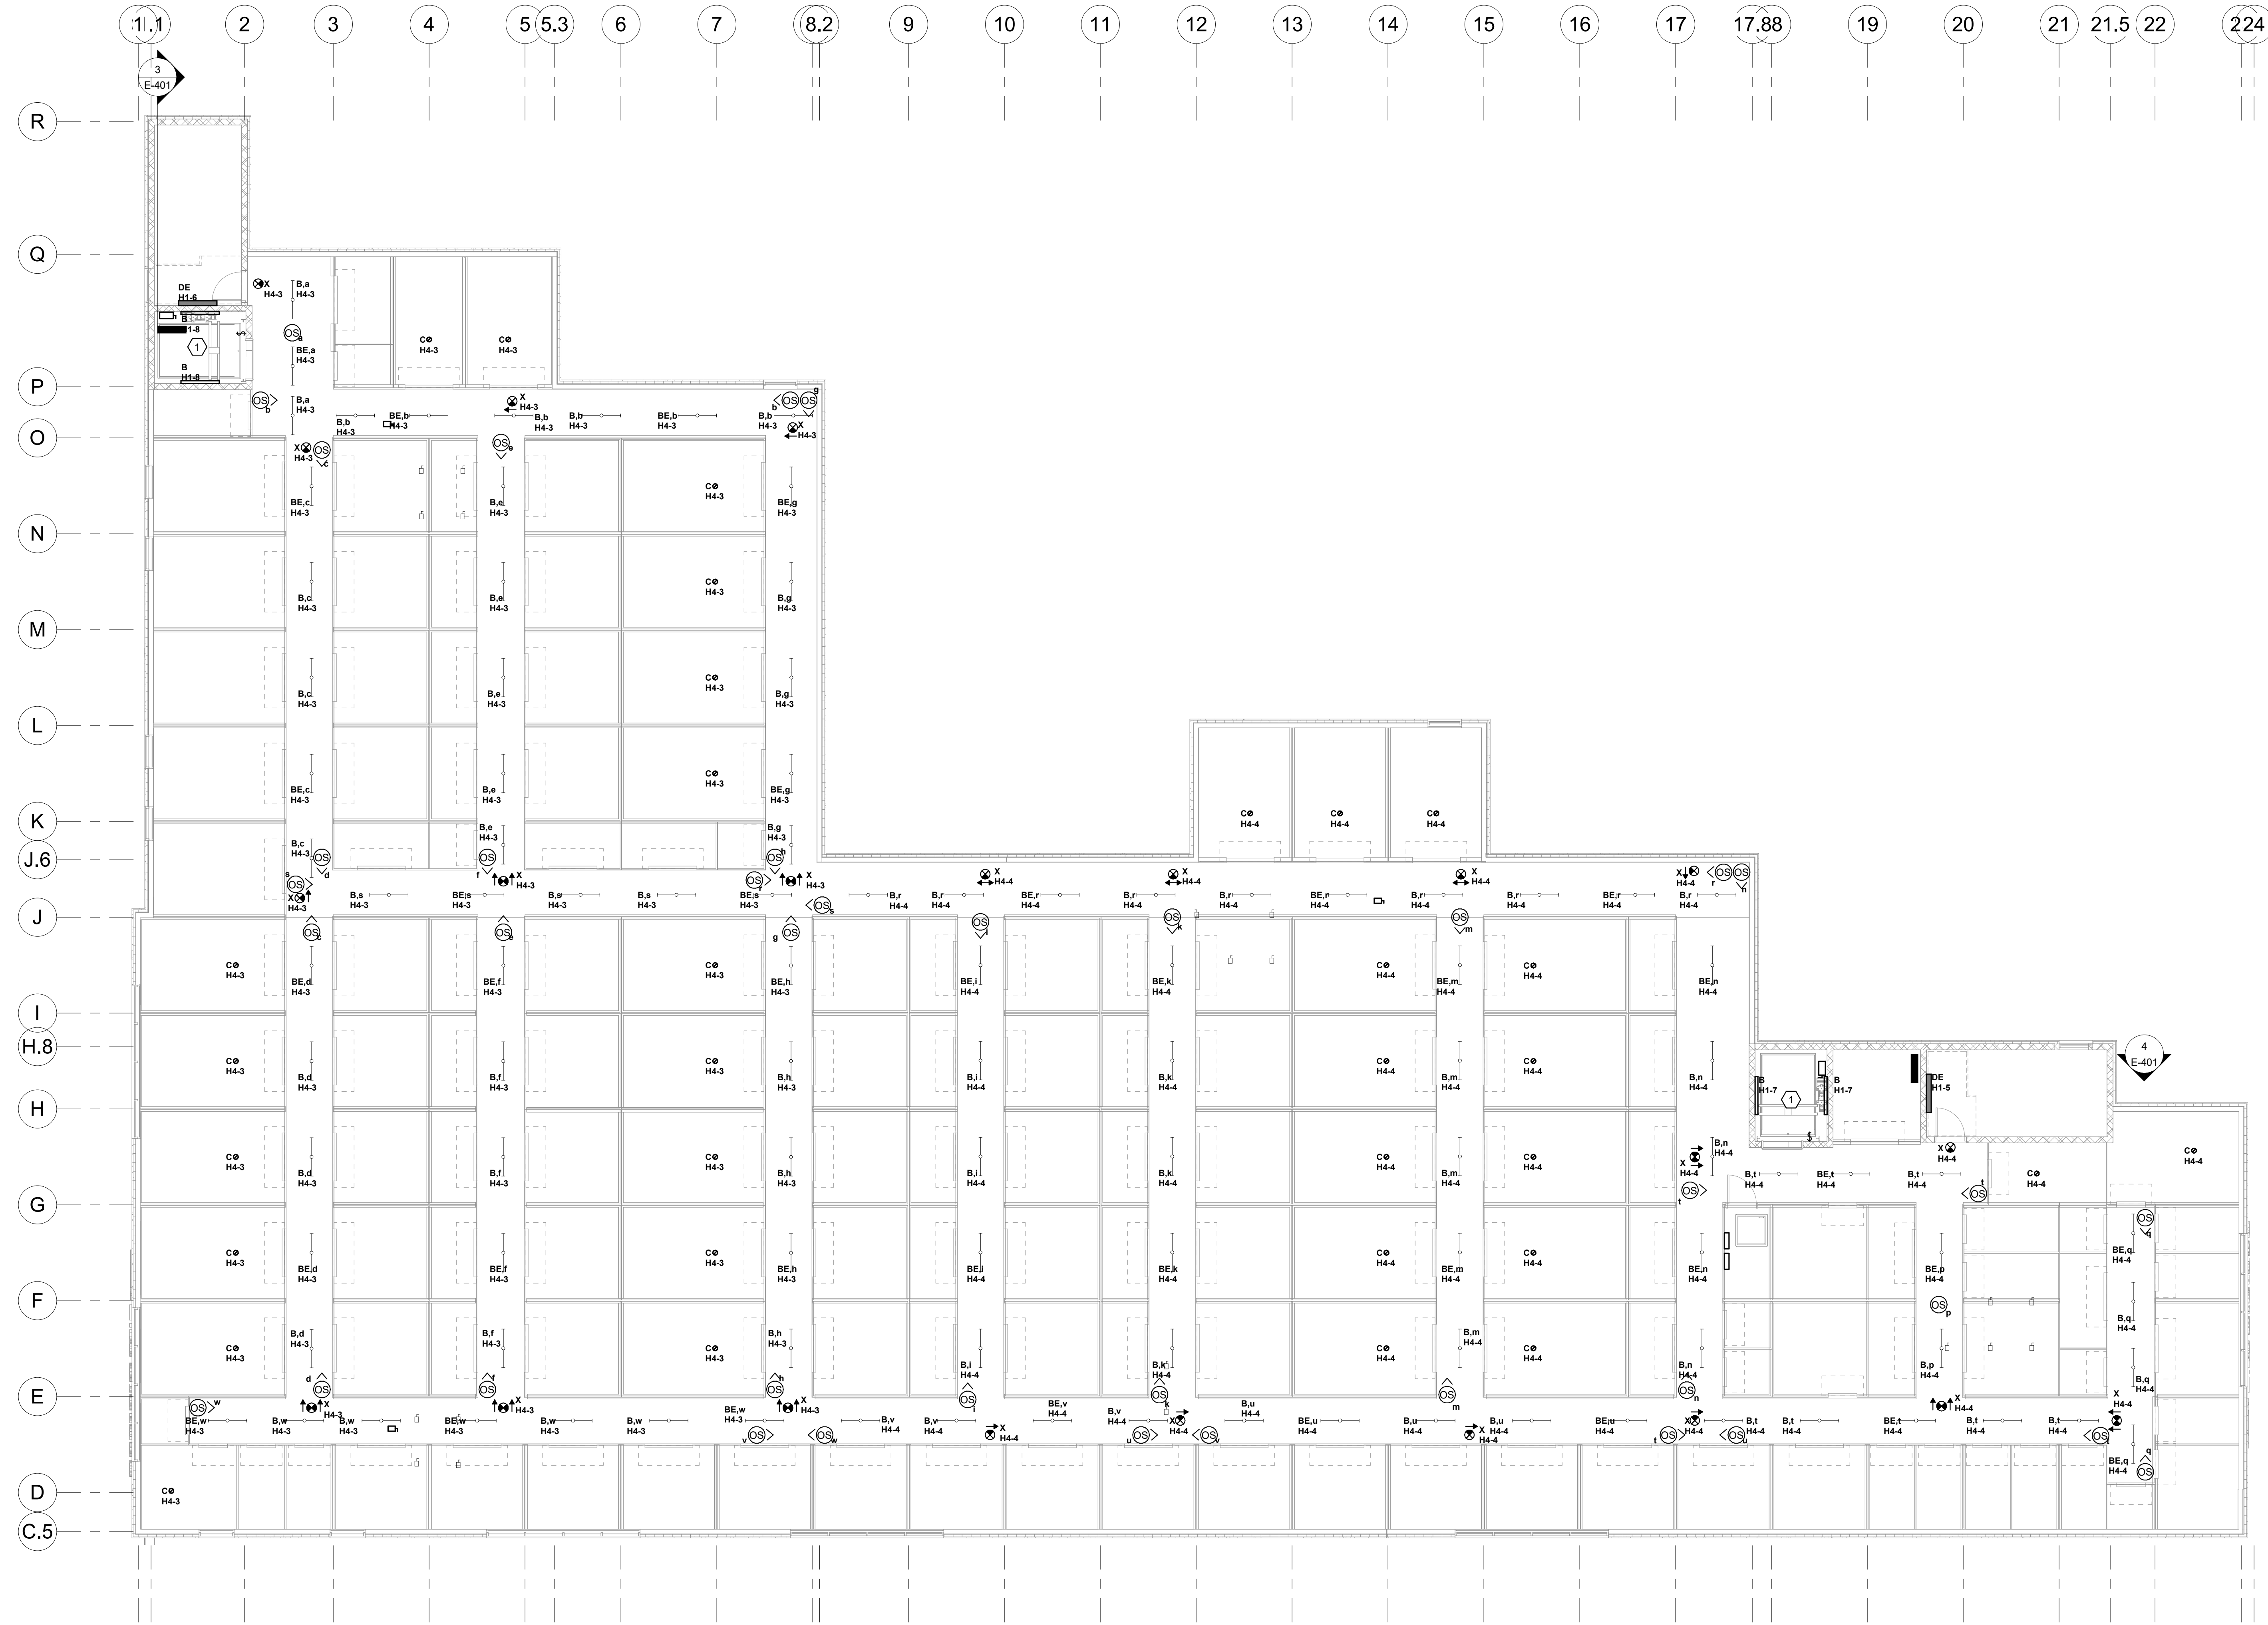

1 ELECTRICAL LIGHTING PLAN - FOURTH FLOOR
1/8" = 1'-0"

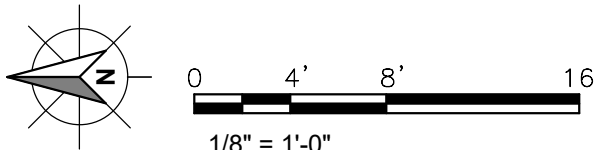

WARNING: It is a violation of the NYS Education Law Article 145 for any person to alter this document in anyway, unless they are acting under the direction of a Professional Engineer

DRAWING TITLE
ELECTRICAL LIGHTING PLAN - FOURTH FLOOR

POUGHKEEPSIE NY STORAGE

DIAMOND POINT DEVELOPMENT

1898 SOUTH ROAD POUGHKEEPSIE, NEW YORK 12601
DUTCHESS COUNTY



FILE NO: 22-082
DATE: 7/1/2022
SCALE: AS NOTED
DRAWN BY: AMB
DRAWING NO: E-304

ISSUED FOR PERMIT



SAA architects
Client centered • Smart solutions
600 North Hanley Street, Suite 150
York, PA 17404
T - 717.843.3200 F - 717.698.0205
www.SAAarchitects.com