



KEYED NOTES	
1	EXTEND REFRIGERANT PIPING TO AHU. INSTALL PER MANUFACTURER RECOMMENDATIONS.
2	LOCATION OF REFRIGERANT PIPING UP TO CONDENSING UNITS ON ROOF.
3	14x10 OPEN END DUCT WITH BIRDSCREEN. BALANCE TO 700 CFM.
4	24x10 OPEN END DUCT WITH BIRDSCREEN. BALANCE TO 700 CFM.
5	16x16 OUTSIDE AIR DUCT UP TO GOOSENECK DUCT ON ROOF.

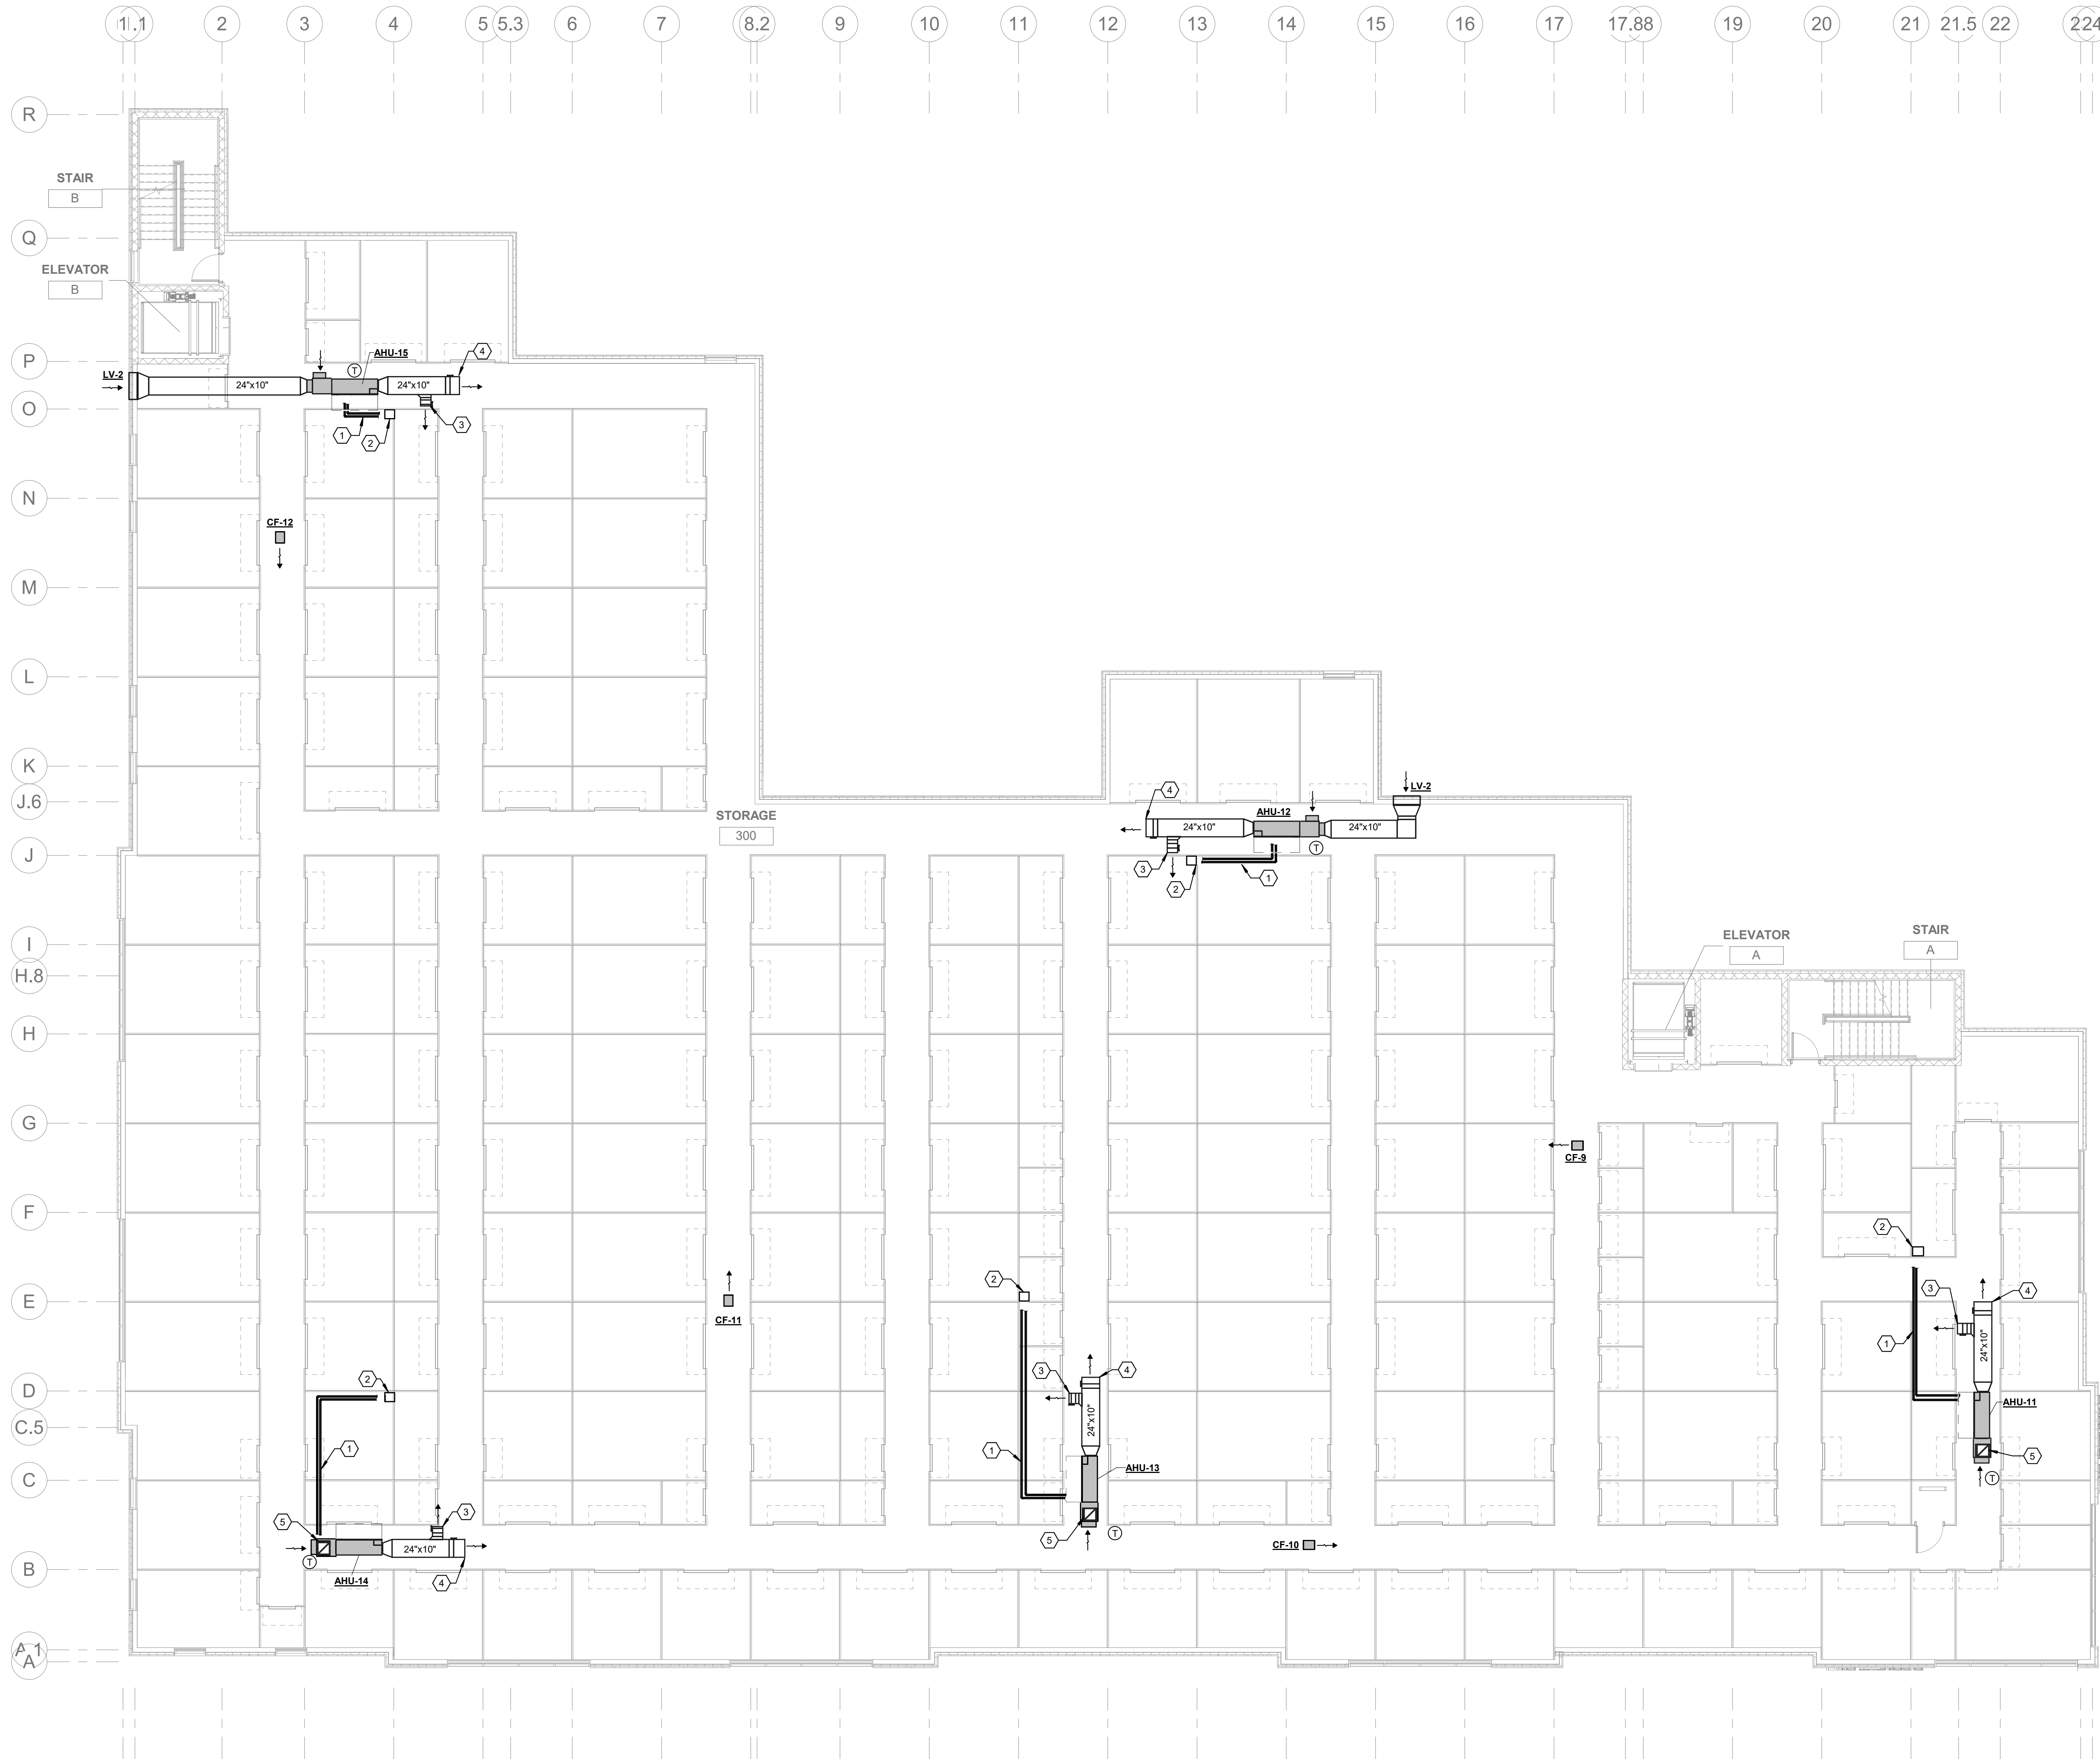

1 THIRD FLOOR MECHANICAL PLAN
1/8" = 1'-0"

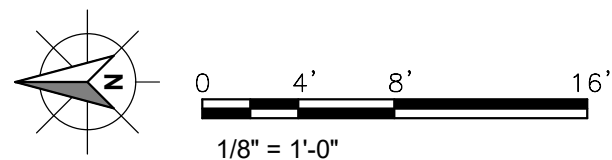

WARNING: It is a violation of the NYS Education Law Article 145 for any person to alter this document in anyway, unless they are acting under the direction of a Professional Engineer

ISSUED FOR PERMIT

REVISIONS	
No.	Description

ENGINEERS
PLANNERS
SCIENTISTS
CONSTRUCTION MANAGERS
500 LOUISE DRIVE SUITE 300
MILWAUKEE, WI 53212
PHONE: 717-691-1340
www.kci.com

KCI
TECHNOLOGIES

SAA architects
Client centered • Smart solutions
600 North Hanley Street, Suite 150
York, PA 17404
T - 717-843-3200 F - 717-698-0205
www.SAAarchitects.com

THIRD FLOOR MECHANICAL PLAN
POUGHKEEPSIE NY STORAGE
DIAMOND POINT DEVELOPMENT
1899 SOUTH ROAD POUGHKEEPSIE, NEW YORK 12601
DUTCHESS COUNTY



FILE NO:	22-082
DATE:	7/1/2022
SCALE:	AS NOTED
DRAWN BY:	IRS
DRAWING NO.:	M-103