



7/1/2022 2:25:39 PM C:\Users\j_rapier\OneDrive\Documents\NY Storage\4857-2022-0416-Storage\4857.dwg

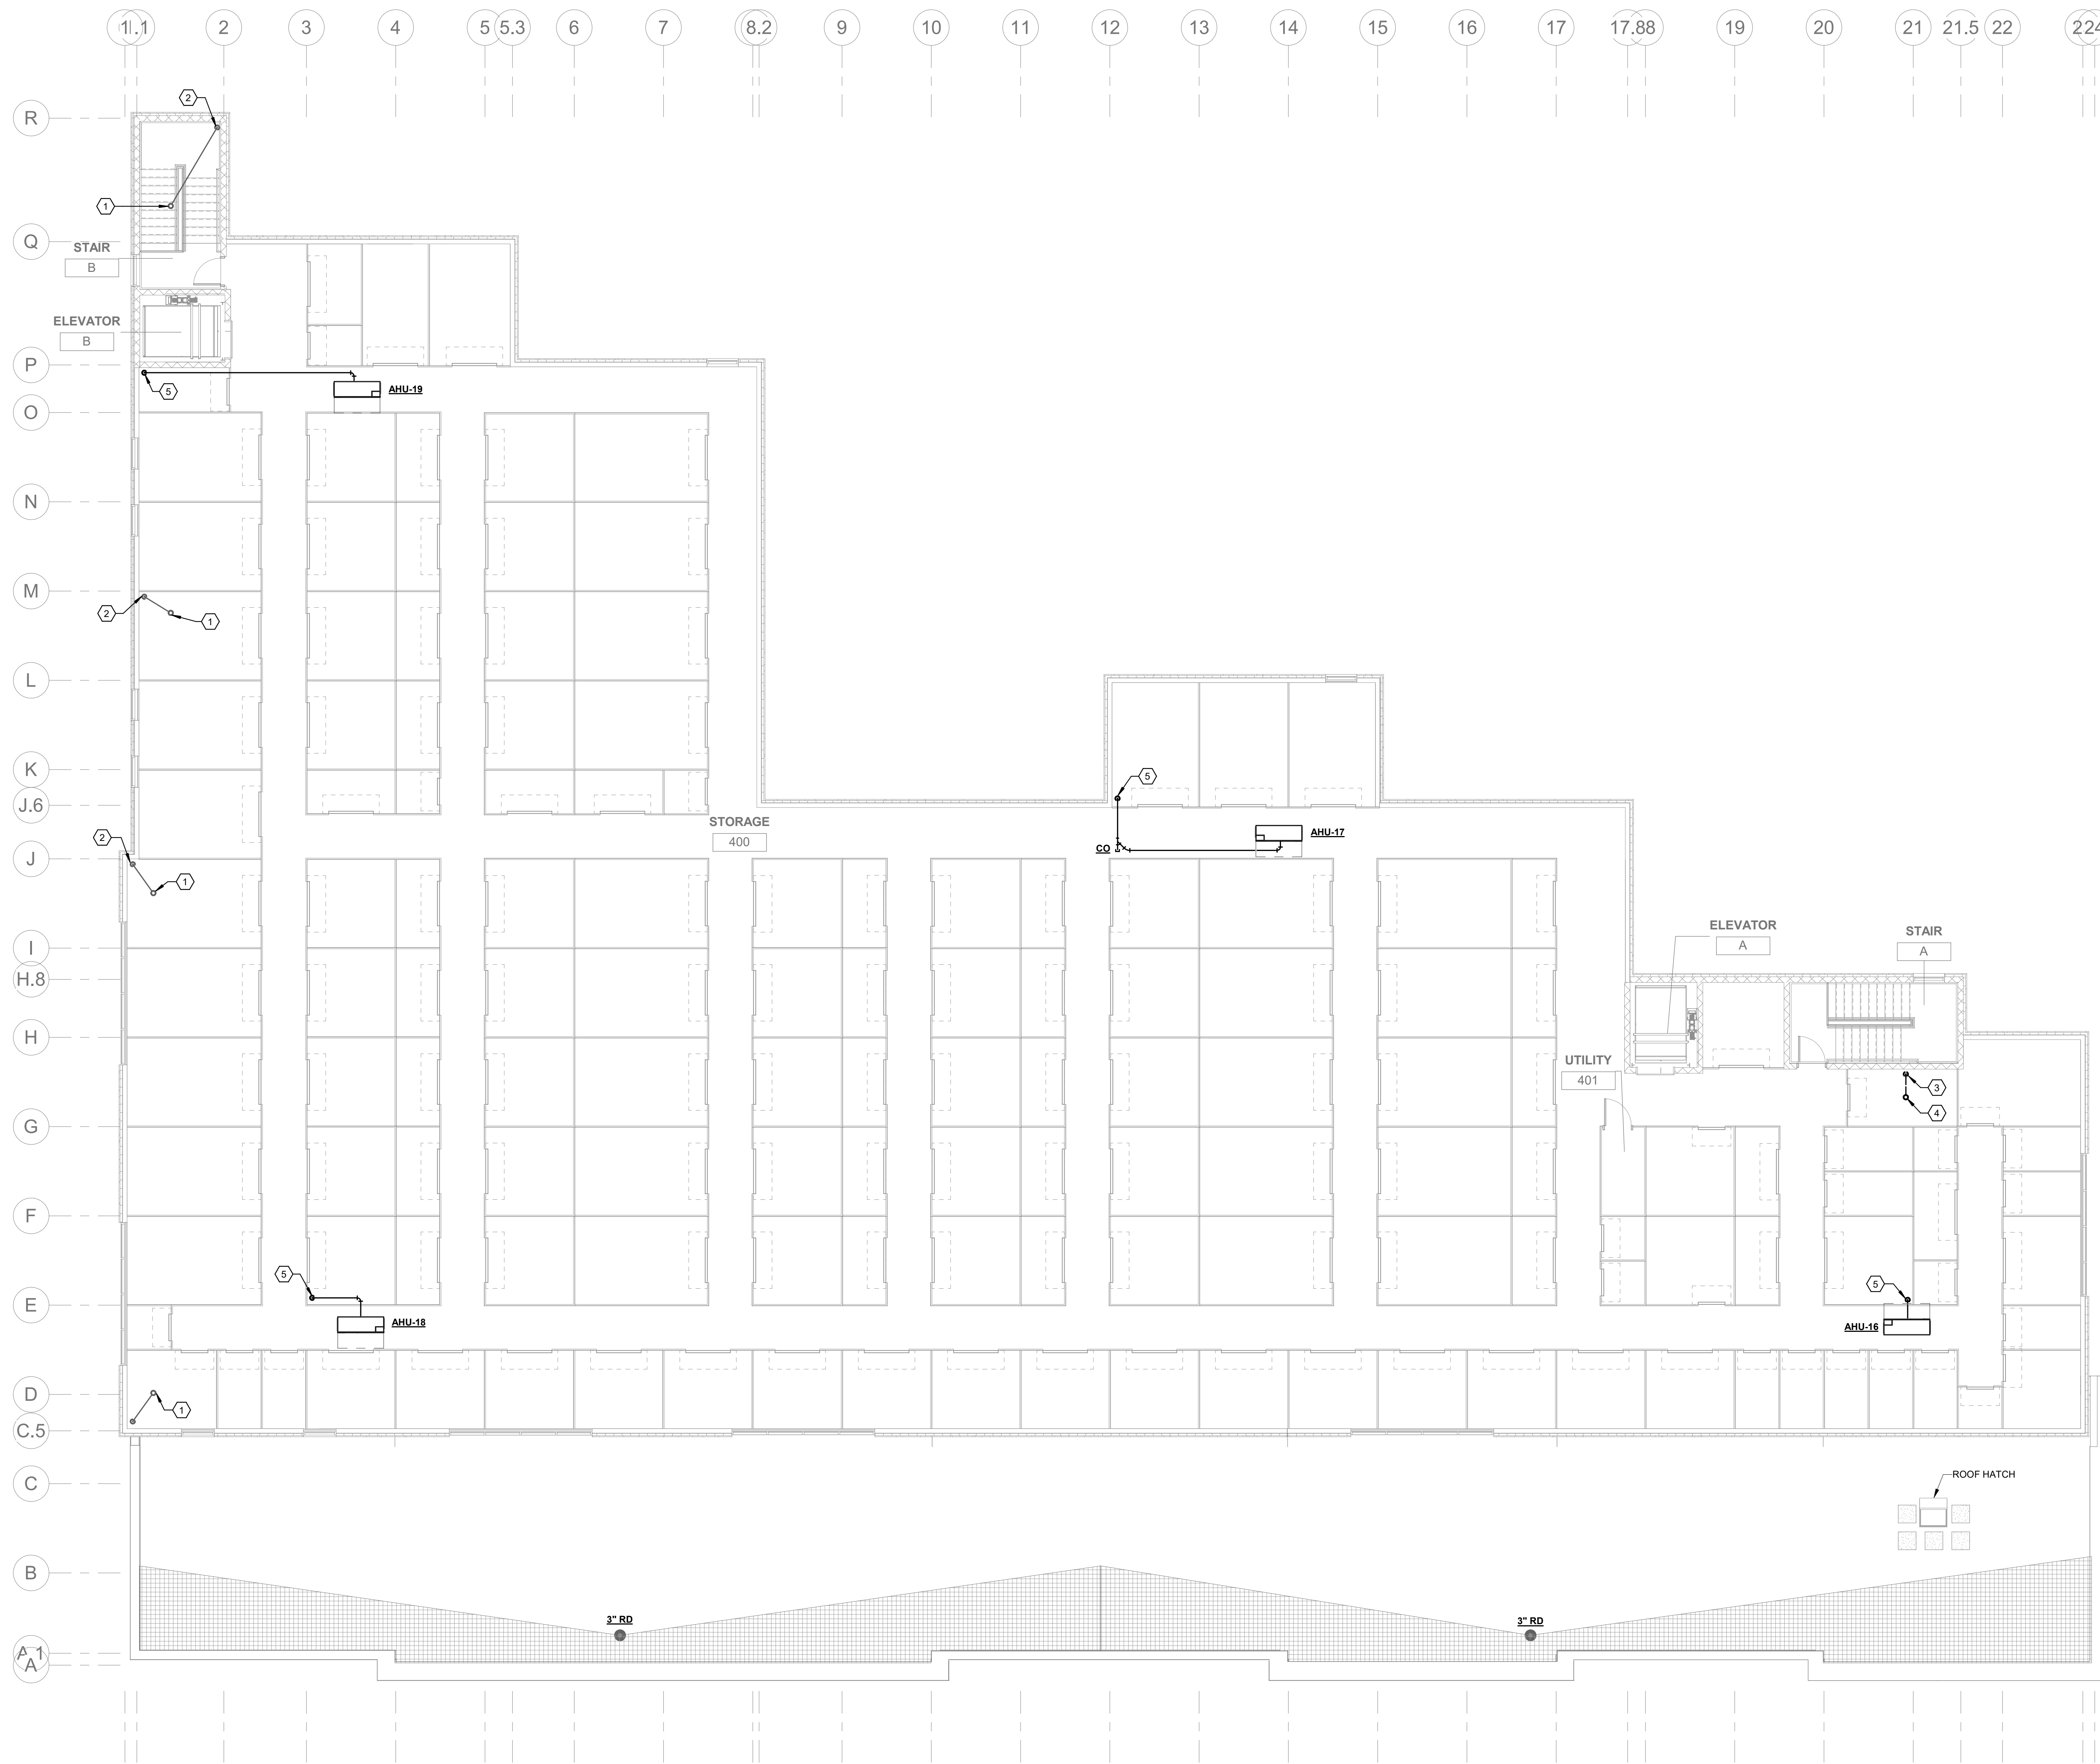

KEYED NOTES	
1	4" STORM WATER UP TO ROOF DRAIN.
2	4" STORM WATER DOWN THROUGH FLOOR.
3	3" VENT DOWN THROUGH FLOOR.
4	3" VENT THROUGH ROOF.
5	CONDENSATE DRAIN DOWN THROUGH ROOF.

1 FOURTH FLOOR PLUMBING PLAN
1/8" = 1'-0"

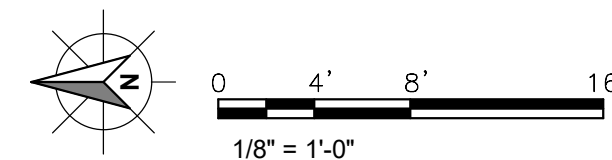

WARNING: It is a violation of the NYS Education Law Article 145 for any person to alter this document in anyway, unless they are acting under the direction of a Professional Engineer

ISSUED FOR PERMIT

REVISIONS	
No.	Description

CONSULTANT

ENGINEERS
PLANNERS
SCIENTISTS
CONSTRUCTION MANAGERS

KCI
TECHNOLOGIES

500 LOUISE DRIVE, SUITE 300
ROCKVILLE, MD 20850
PHONE: 717-691-1340
WWW.KCI.COM

SAA architects

Client centered • Smart solutions

600 North Hanley Street, Suite 150
York, PA 17404
T - 717-843-3200 F - 717-698-0205
www.SAAarchitects.com

FOURTH FLOOR PLUMBING PLAN

POUGHKEEPSIE NY STORAGE

DIAMOND POINT DEVELOPMENT

1898 SOUTH ROAD POUGHKEEPSIE, NEW YORK 12601
DUTCHESS COUNTY



FILE NO:	22-082
DATE:	7/1/2022
SCALE:	AS NOTED
DRAWN BY:	IRS
DRAWING NO.:	P-104