


1 ROOF PLUMBING PLAN
1/8" = 1'-0"

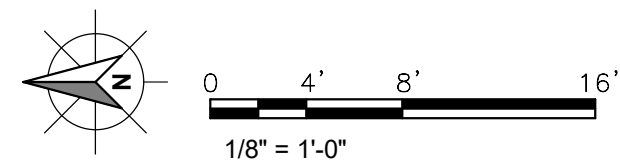

WARNING: It is a violation of the NYS Education Law Article 145 for any person to alter this document in anyway, unless they are acting under the direction of a Professional Engineer

REVISIONS	
No.	Description

CONSULTANT

ENGINEERS
PLANNERS
SCIENTISTS
CONSTRUCTION MANAGERS

KCI TECHNOLOGIES

500 LOUISE DRIVE SUITE 300
ROCKFORD, IL 60087
PHONE: 717-691-1340
www.kci.com

SAA architects

Client centered • Smart solutions

600 North Hanley Street, Suite 150
York, PA 17404
T - 717.843.3200 F - 717.698.0205
www.SAAarchitects.com

DRAWING TITLE

© 2005 SAAarchitects, Inc.

ROOF PLUMBING PLAN

POUGHKEEPSIE NY STORAGE
DIAMOND POINT DEVELOPMENT

1899 SOUTH ROAD POUGHKEEPSIE, NEW YORK 12601
DUTCHESS COUNTY



FILE No.	22-082
DATE	7/1/2022
SCALE	AS NOTED
DRAWN BY	IRS
DRAWING No.	P-151

ISSUED FOR PERMIT