


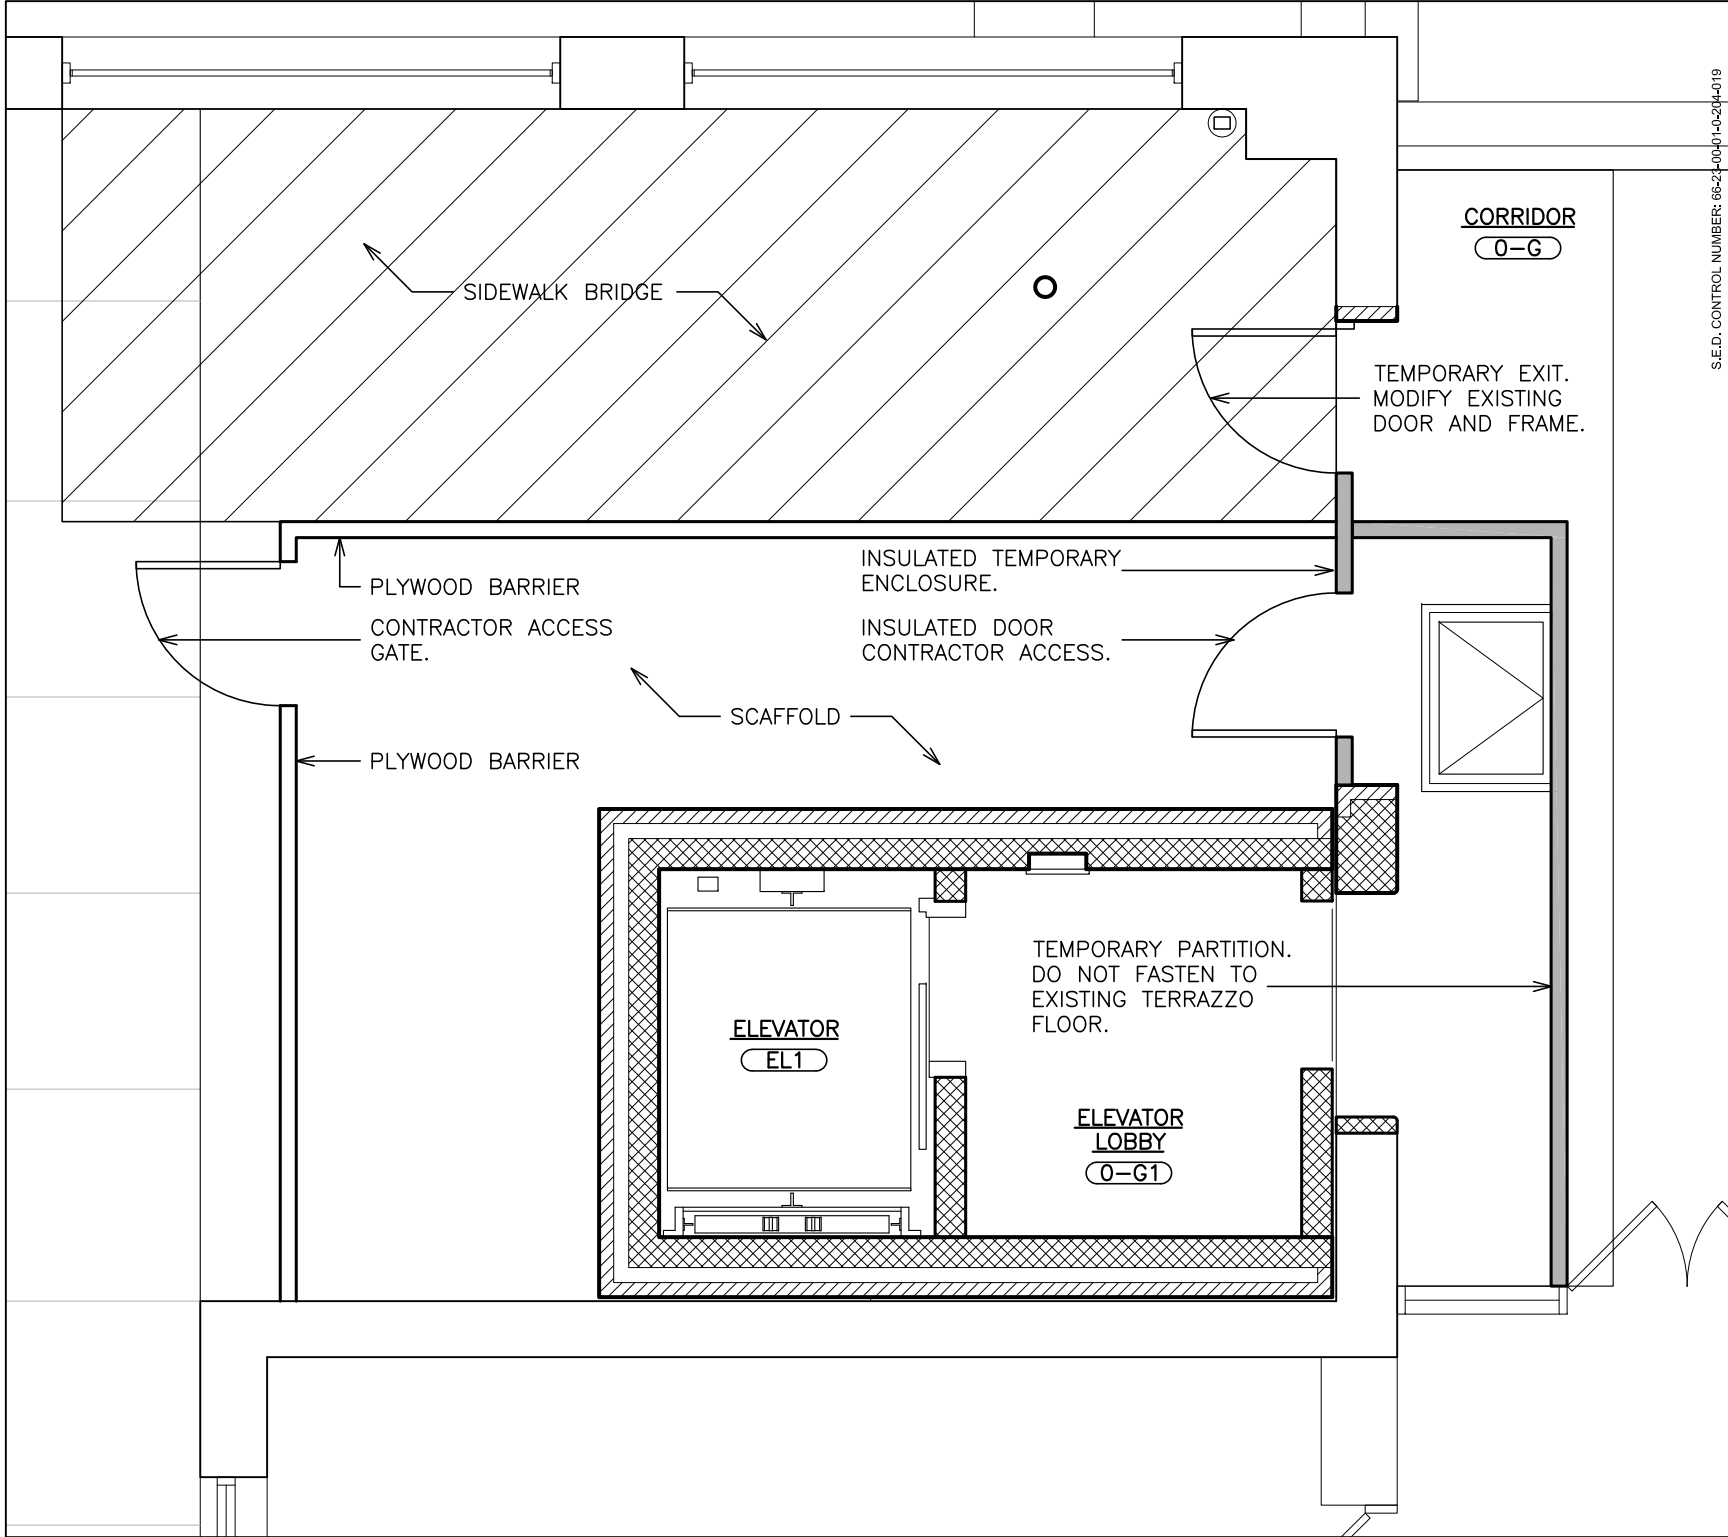

S.E.D. CONTROL NUMBER: 66-21400-01-0-204-019

JOB NAME:
YONKERS SCHOOL DISTRICT
GORTON HIGH SCHOOL
CAPITAL IMPROVEMENT PHASE 3
100 SHONNARD PLACE, YONKERS, N.Y. 10703

**FULLER
D'ANGELO
P.C.**
**ARCHITECTS
PLANNERS**

48 KNOWLEDGE ROAD ELMSFORD NEW YORK 10523
TEL 914.393.4444 FAX 914.393.1717
WWW.FULLERDANGELO.COM
Copyright 2021 All Rights Reserved by FULLER & D'ANGELO P.C.

DRAWING TITLE:
TEMPORARY FACILITIES PLAN
PARTIAL GROUND FLOOR PLAN

11-19-2021

DATE

SCALE:

AS NOTED

FILE NO.

20373.00

DRAWING NO.

SK-A1.0

ADDENDUM #1

ISSUED TO