


Luminaire Schedule						
Symbol	Qty	Model No.	Arrangement	Total Lamp Lumens	LLF	Description
● [SL1]	12	MRS-LED-09L-SIL-SW-30-70CRI-PLP	Single	N.A.	0.900	MRS-LED-09L-SIL-SW-30-70CRI-PLP
■ [SL4]	18	XWS-LED-06L-FW-30-80CRI-PLP	Single	N.A.	0.900	XWS-LED-06L-FW-30-80CRI-PLP

Calculation Summary						
Label	CalcType	Units	Avg	Max	Min	Avg/Min
Entire Area	Illuminance	Fc	0.70	13.1	0.0	N.A.

LEGEND	
	EXISTING UTILITY POLE
	EXISTING LIGHT POLE
	SITE LIGHTING STANDARD
	BUILDING MOUNTED LIGHTING STANDARD
	PROPOSED ILLUMINANCE IN FOOT-CANDLES

- NOTES:**
- ALL CABLES AND WIRING NEEDED FOR LIGHTS SHALL BE INSTALLED UNDERGROUND IN CONDUIT. CONDUIT AND WIRING SHALL BE DESIGNED BY THE PROJECT ELECTRICAL ENGINEER.
 - REFER TO DRAWINGS PREPARED BY THE PROJECT ELECTRICAL ENGINEER FOR CONDUIT AND CIRCUITRY INFORMATION.
 - AREA OF ANALYSIS SHOWN ON THIS PLAN IS LIMITED TO THE PROPOSED AREAS OF IMPROVEMENTS. ILLUMINANCE LEVELS SHOWN ARE MEASURED ON THE GROUND.

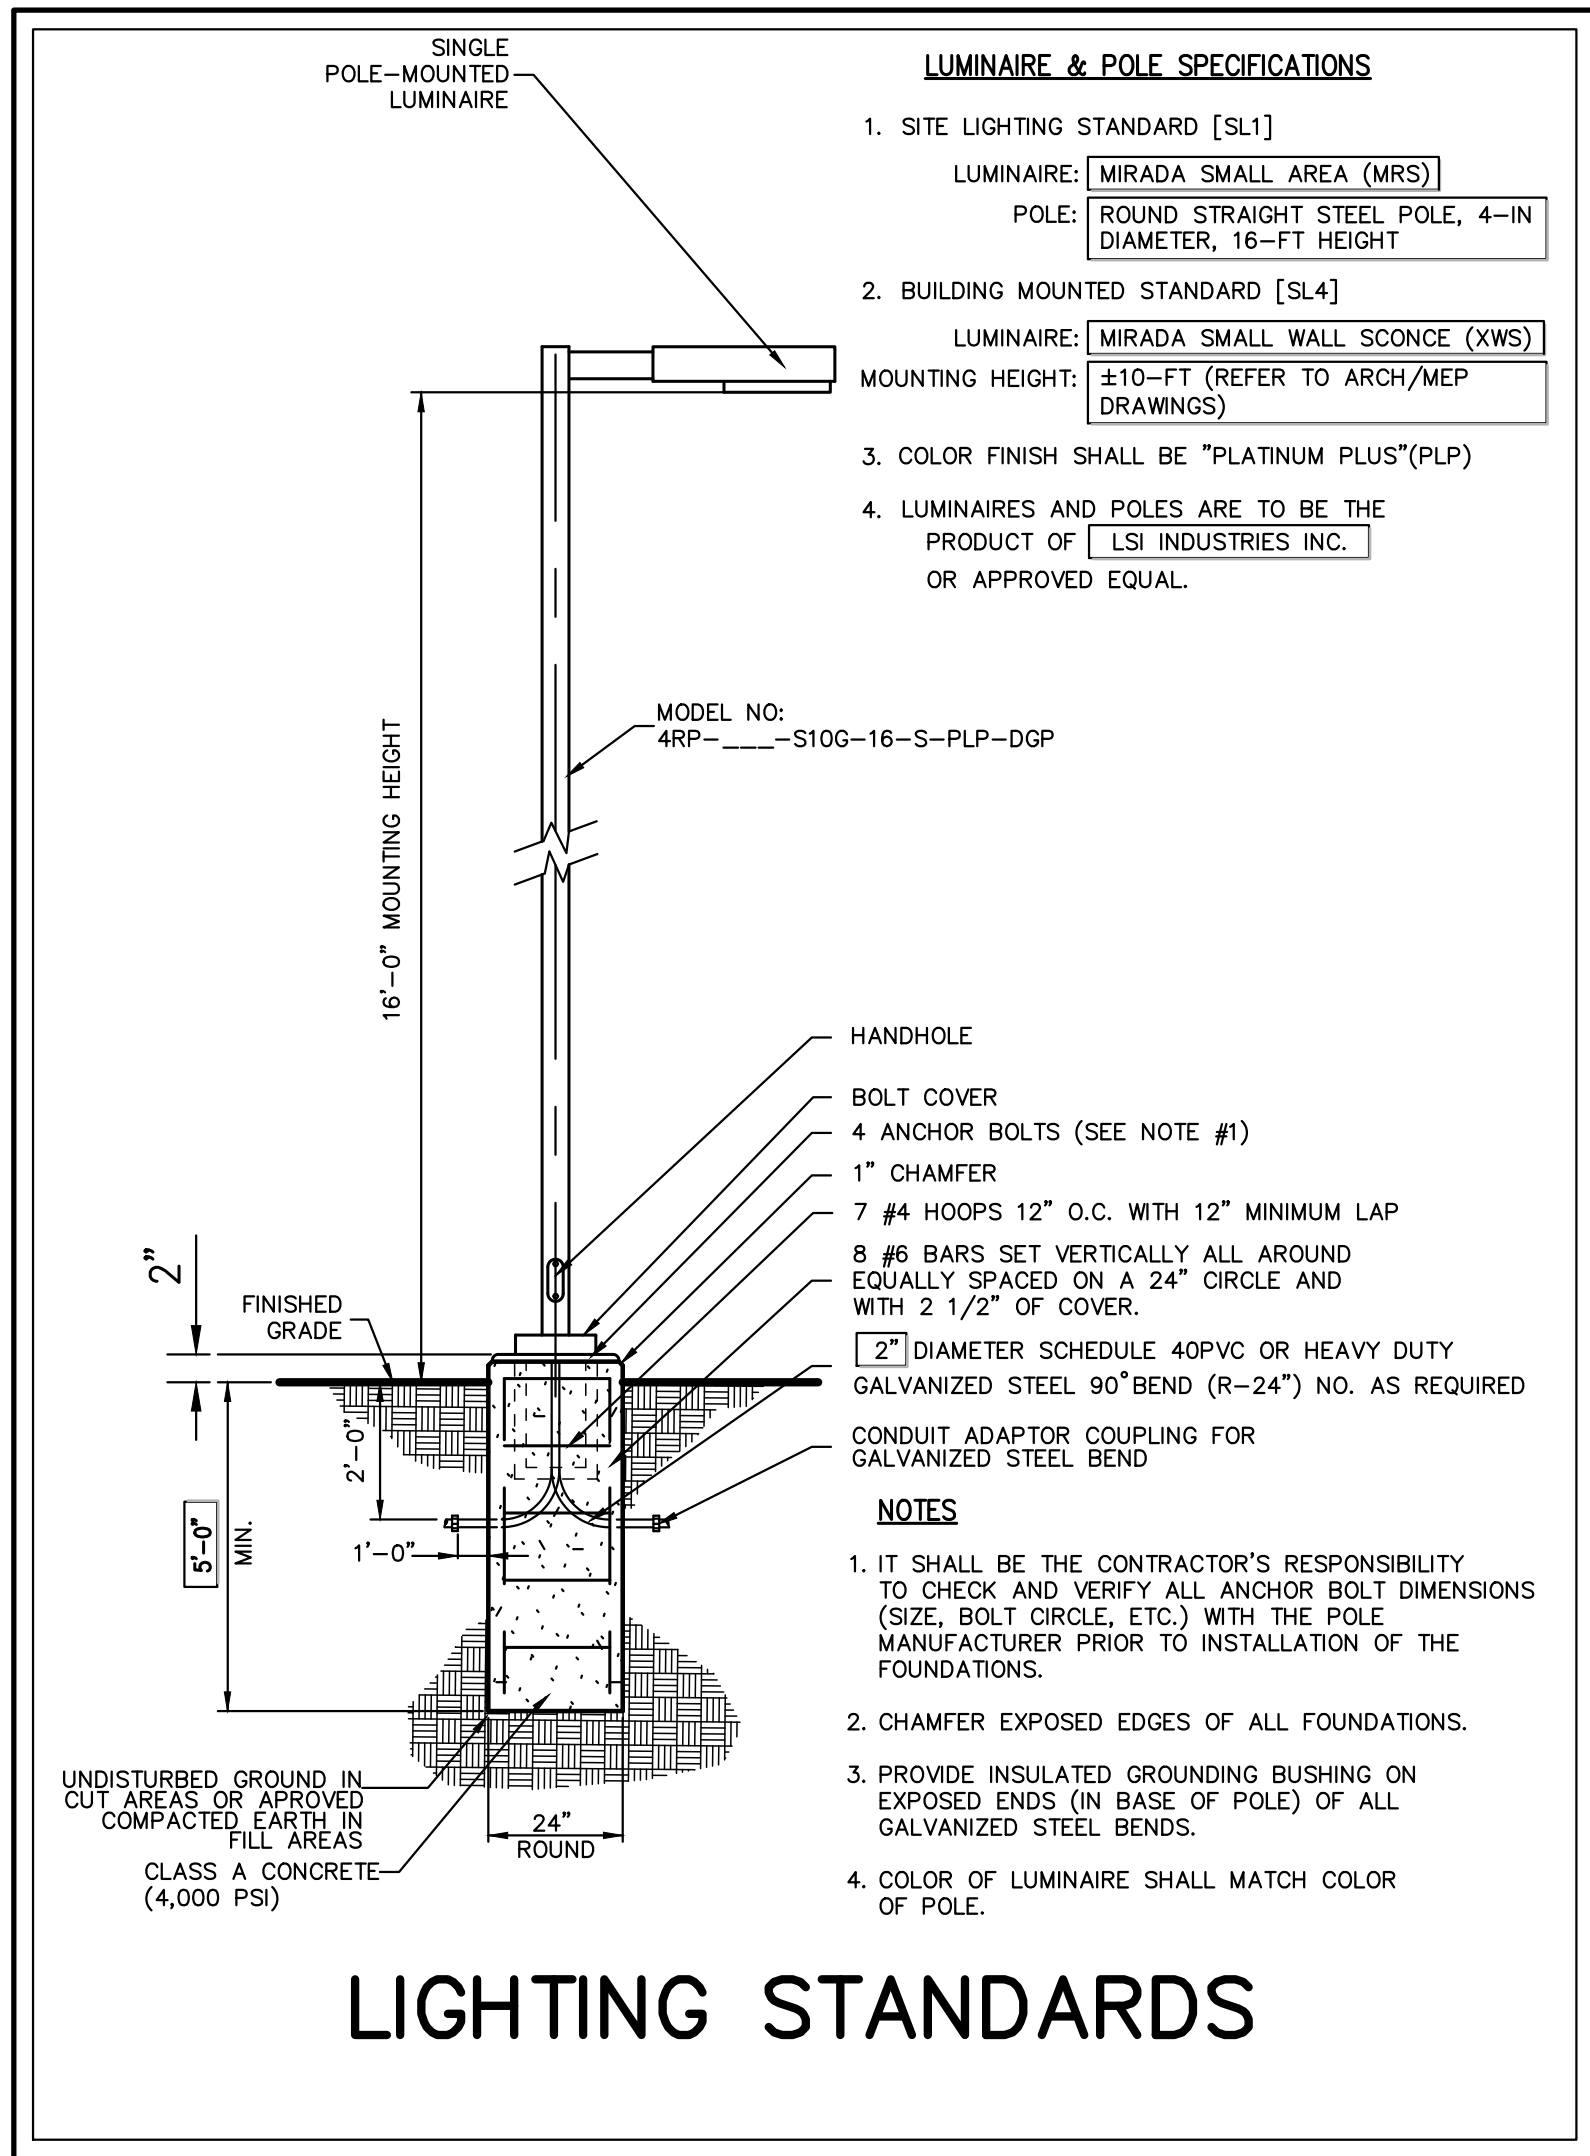

REGENERON

REAL ESTATE & FACILITIES MANAGEMENT

777 Old Saw Mill River Road
Tarrytown, NY 10591-6707
T: 914.847.7400
F: 914.847.7991
www.regeneron.com

BUILDING #17
CAMPUS EXPANSION CHILD
DAY-CARE CENTER

899 OLD SAW MILL RIVER ROAD
MOUNT PLEASANT, NY 10591

Civil Engineer:

Site Development Consultants
120 Bedford Road
Armonk, NY 10504
914-273-5225
www.jmcpllc.com

Attorney:

DelBello Donnellan Weingarten Wise & Wiederkehr, LLP
One North Lexington Avenue, 11th Floor
White Plains, New York 10601
Phone: (914) 681-0200

Geotechnical Engineer:

Carlin-Simpson & Associates
61 Main Street
Sayreville, NJ 08872
Phone: (732) 432-5757

Architect:

Gensler
1700 Broadway, Suite 400
New York, New York 10019
Phone: (212) 492-1400
Fax: (212) 492-1472


Landscape Architect (Playground):

Langan
21 Penn Plaza, 360 West 31st Street, 8th Floor
New York, New York 10001
Phone: (212) 479-5400
Fax: (212) 479-5444

MEP/IT/Security Engineer:

Cosentini Associates
498 Seventh Avenue
New York, New York 10018
Phone: (212) 615-3600
Fax: (212) 615-3700

No. Date Description

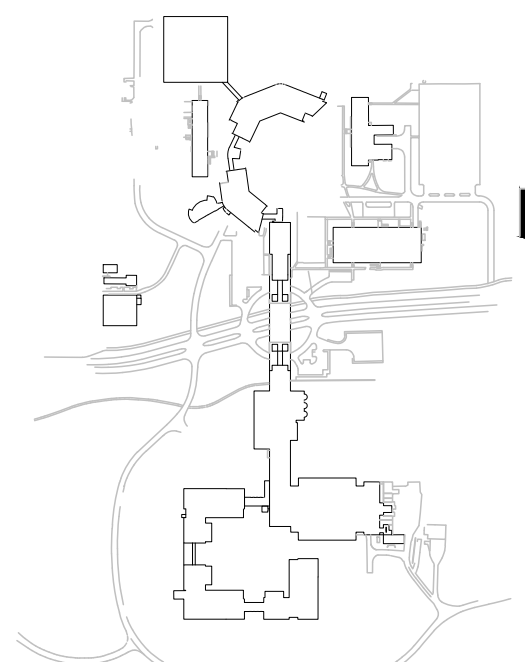

No. Date Description

0 05/20/2022 ISSUED FOR PERMIT
1 06/20/2022 100% CONSTRUCTION DOCUMENTS
2 07/01/2022 100% CONSTRUCTION DOCUMENTS - 1

ALL DRAWINGS AND WRITTEN MATERIALS REPRESENTED ON THIS SHEET CONSTITUTE THE COPYRIGHTED WORK AND ARE THE SOLE PROPERTY OF REGENERON PHARMACEUTICALS. THIS SHEET MAY NOT BE REPRODUCED OR COPIED IN WHOLE OR IN PART, NOR MAY ANY OF THE DRAWINGS OR WRITTEN MATERIALS APPEARING WITHIN, BE INCORPORATED INTO ANOTHER WORK FOR ANY REASON WITHOUT THE WRITTEN CONSENT OF REGENERON PHARMACEUTICALS. THIS SHEET MUST BE RETURNED UPON THE REQUEST OF REGENERON PHARMACEUTICALS.

Professional Seal and Signature

ANY ALTERATION OF PLANS, SPECIFICATIONS, PLATS AND REPORTS BEARING THE SEAL OF A LICENSED PROFESSIONAL ENGINEER OR LICENSED LAND SURVEYOR IS A VIOLATION OF SECTION 7209 OF THE NEW YORK STATE EDUCATION LAW, EXCEPT AS PROVIDED FOR BY SECTION 7209, SUBSECTION 2.

Vendor Name: JMC, PLLC
Vendor Project No.: 20090-3
Discipline: Civil Drawn By: TC
Drawing Title:

LIGHTING PLAN

Scale: 1" = 30'

C-600