

777 Old Saw Mill River Road
Tarrytown, NY 10591-6707
T: 914.847.7400
F: 914.847.7991
www.regeneron.com

Building #17
Campus Expansion Child
Day-care Center

777 Old Saw Mill River Road
Mount Pleasant, NY 10591

Project No. B17-DAYCARE

Architect

Gensler

1700 Broadway, Suite 400
New York, NY 10019
(212) 492-1400 Phone
(212) 492-1472 Fax

Structural Engineer

Thornton Tomasetti
120 Broadway, 15th Floor
New York, NY 10271
(917) 661-7800 Phone
(917) 661-7801 Fax

MEP / IT / Security Engineer

Cosentini Associates

498 Seventh Avenue
New York, NY 10018
(212) 615-3600 Phone
(212) 615-3700 Fax

Civil Engineer

JMC


120 Bedford Road
Armonk, NY 10504
(914) 273-5225 Phone
(914) 273-2102 Fax

Landscape Architect

Langan

21 Penn Plaza, 360 West 31st Street, 8th Floor
New York, NY 10001
(212) 479-5400 Phone
(212) 479-5444 Fax

Key Plan

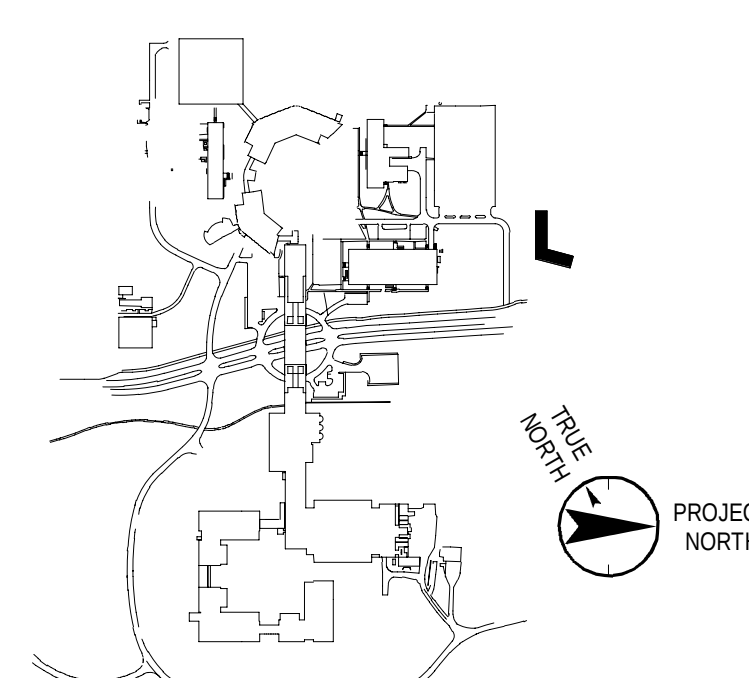

No. Date Description

0	06.20.2022	ISSUED FOR PERMIT
1	06.22.2022	100% CONSTRUCTION DOCUMENTS
2	07.01.2022	100% CONSTRUCTION DOCUMENTS-1

Plot Date: 07.01.2022

ALL DRAWINGS AND WRITTEN MATERIALS REPRESENTED ON THIS SHEET CONSTITUTE THE COPYRIGHTED WORK AND ARE THE SOLE PROPERTY OF REGENERON PHARMACEUTICALS. THIS SHEET MAY NOT BE REPRODUCED OR COPIED IN WHOLE OR IN PART, NOR MAY ANY OF THE DRAWINGS OR WRITTEN MATERIALS BE REPRODUCED OR COPIED IN WHOLE OR IN PART, NOR MAY ANY OTHER WORK FOR ANY REASON WITHOUT THE WRITTEN CONSENT OF REGENERON PHARMACEUTICALS. THIS SHEET MAY BE RETURNED UPON THE REQUEST OF REGENERON PHARMACEUTICALS. IF REGENERON NAMES OR AUTHORIZES REUSE OF ANY SUCH DOCUMENTS OR INFORMATION PROVIDED BY DESIGN PROFESSIONAL, REGENERON ASSIGNS FULL RESPONSIBILITY FOR ANY AND ALL RISKS INVOLVED IN SUCH REUSE.

Professional Seal and Signature

Vendor Name: COSENTINI

Vendor Project No.: 210104

Discipline: Electrical

Drawn By: AI
ELECTRICAL POWER PLAN - 1ST FLOOR


Scale: 1/8" = 1'-0"

Floor:

E-100

NOTES:

- FOR SYMBOL LIST REFER TO DRAWING E-001.
- FOR PANEL SCHEDULES REFER TO DRAWING E-600 AND E-601.
- FOR LEGEND OF EQUIPMENT SCHEDULE REFER TO DRAWING E-110.
- FOR ONE-LINE DIAGRAM REFER TO DRAWING E-700.
- COORDINATE FINAL LOCATIONS OF PLUMBING, SPRINKLER, MECHANICAL, AV/IT, SECURITY, ETC. DEVICES WITH RESPECTIVE TRADES.
- RECEPTACLES INSTALLED ON THE EXTERIOR OF THE BUILDING SHALL BE PROVIDED WITH WEATHER PROOF PROTECTIVE COVERING.
- ALL POWER AND CONTROL WIRING ARE TO BE INSTALLED IN CONDUIT.
- ALL OUTLETS SERVING BATHROOMS, TOILETS, PANTRY, AND OUTDOORS SHALL BE GFCI TYPE.
- WHERE FLOOR MOUNTED RECEPTACLES ARE NOTED, PROVIDE SHALLOW FLOOR BOX AND RUN CONDUIT IN FLOOR SLAB.
- ALL CONTROL RELAYS INSTALLED ON THE EXTERIOR OF THE BUILDING SHALL BE IN NEMA 4 ENCLOSURE.
- WHERE OUTLETS ARE INSTALLED BACK TO BACK, OFFSET OUTLETS AT LEAST 1" APART.
- ALL RECEPTACLES IN THE CLASSROOM, PUBLIC AND COMMON AREAS SHALL BE TAMPER RESISTANT TYPE.
- ALL RECEPTACLES, DISCONNECT SWITCHES, HARD WIRED EQUIPMENT SHALL BE PROVIDED WITH LABELS IDENTIFYING THE PANEL'S CIRCUIT NUMBERS.

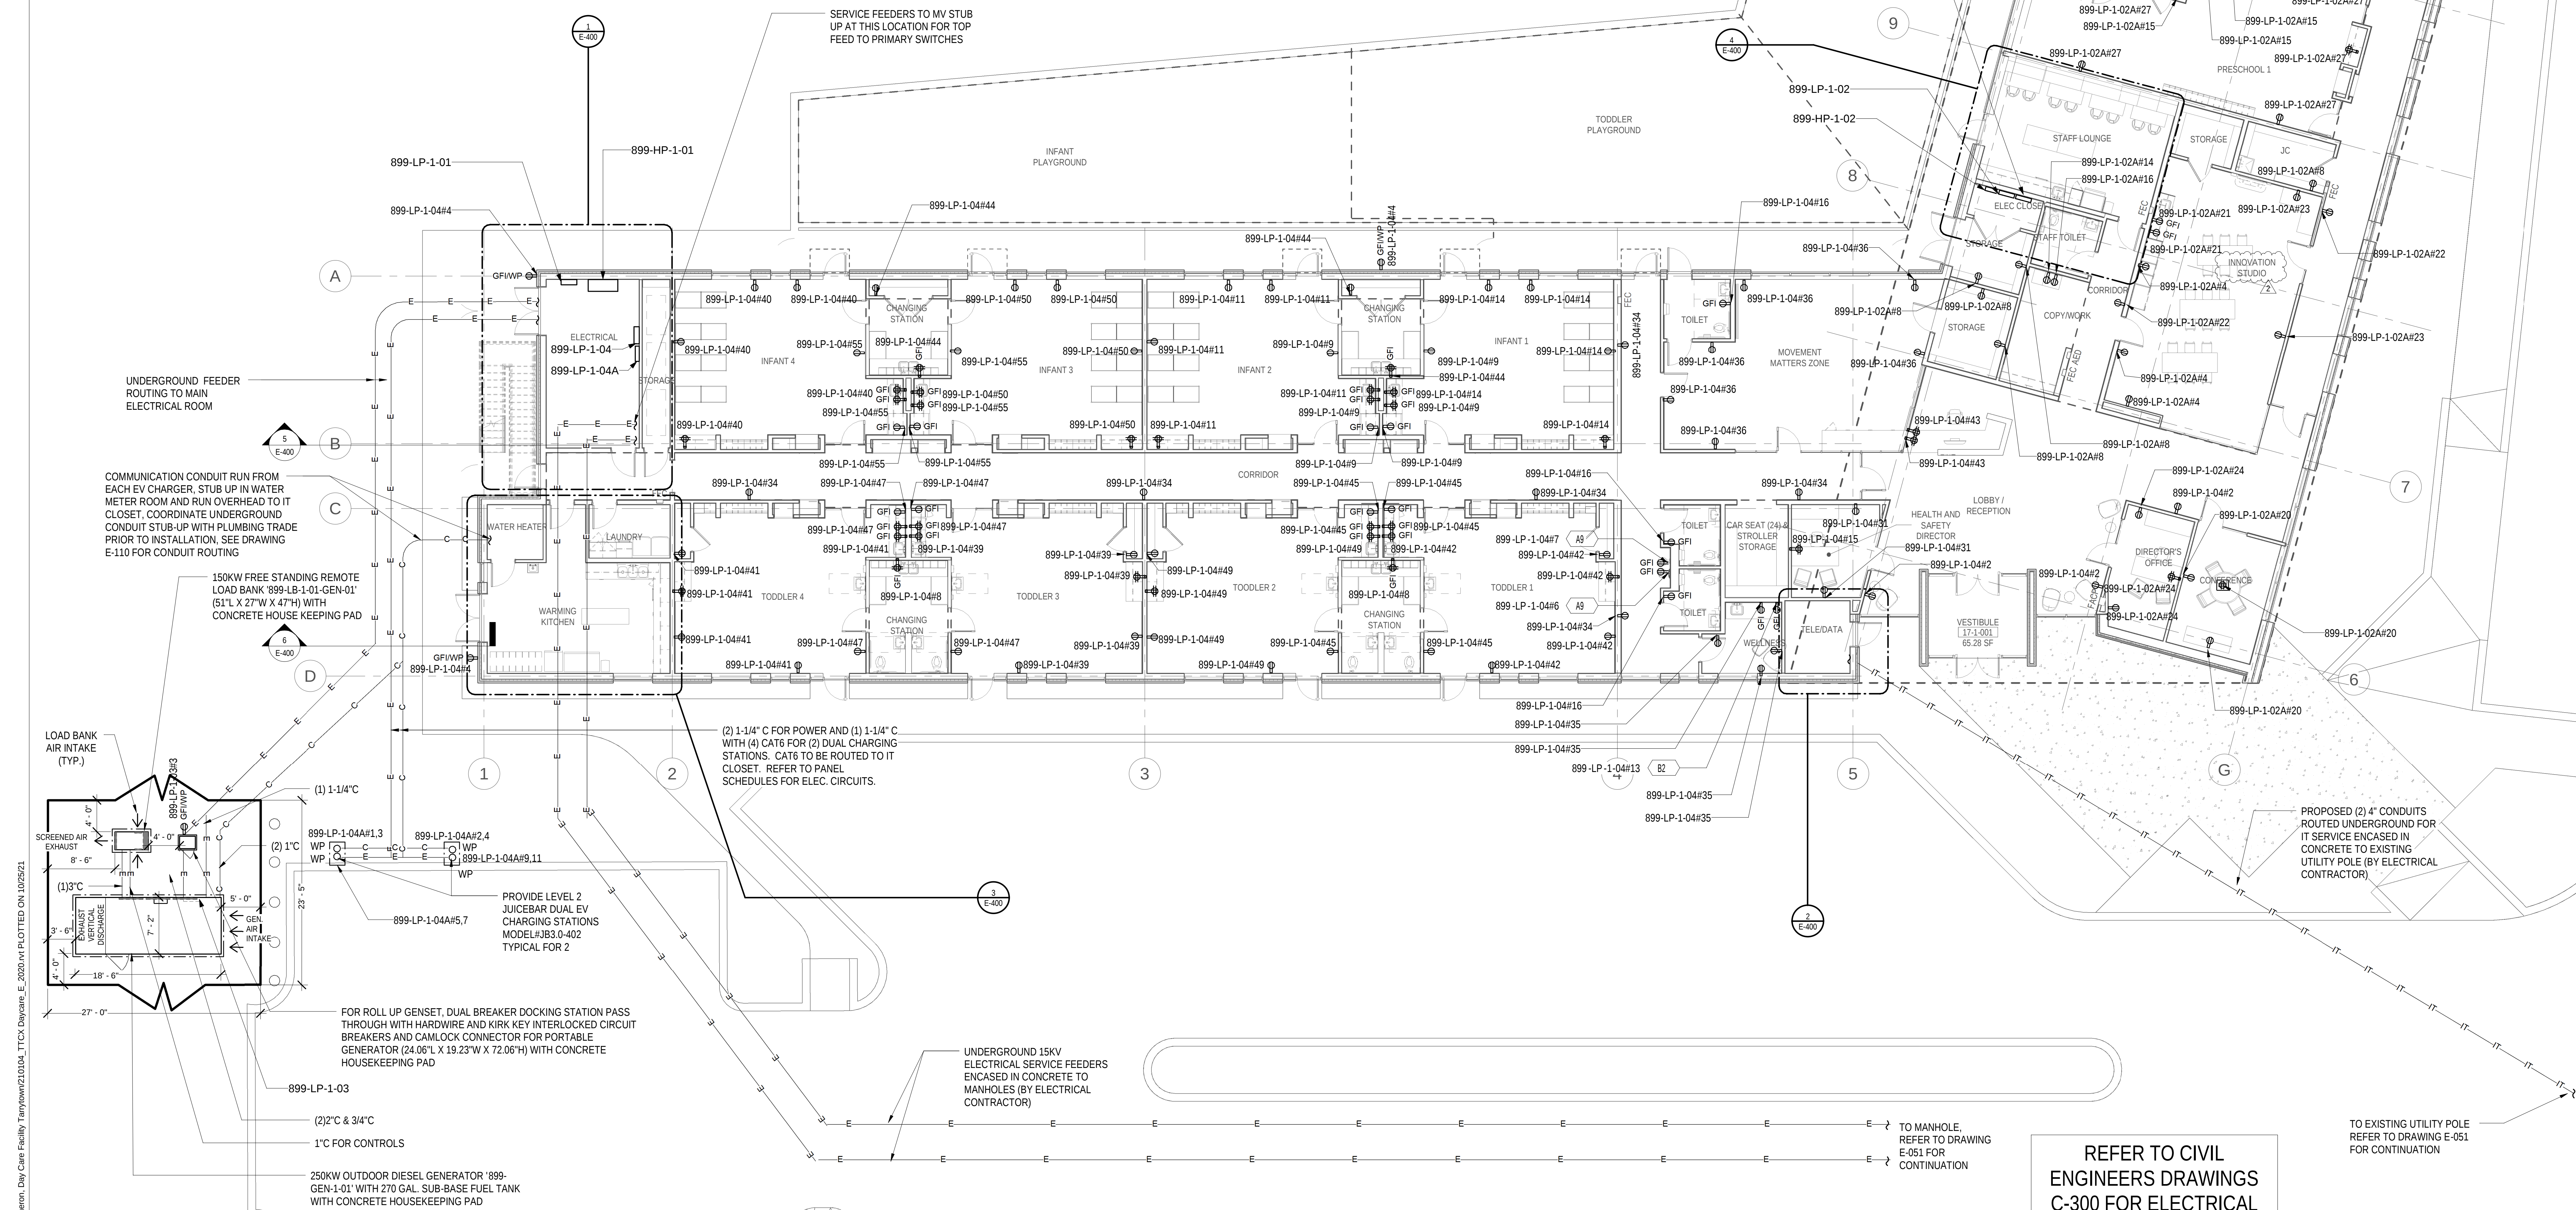

REFER TO CIVIL
ENGINEERS DRAWINGS
C-300 FOR ELECTRICAL
SERVICE ROUTING

TO THE BEST OF MY KNOWLEDGE, BELIEF AND PROFESSIONAL JUDGMENT, THESE PLANS AND SPECIFICATION ARE IN COMPLIANCE WITH THE 2020 ENERGY CONSERVATION CODE OF NYS

This plan is approved only for work indicated on the application specification sheet. All other matters shown are not to be relied upon, or to be considered as either being approved or in accordance with applicable codes.

Alterations or additions to this engineering document by an unlicensed person is a violation of Chapter 16, Title VIII, Article 145 § 7209.2 of the New York State Education Law.