




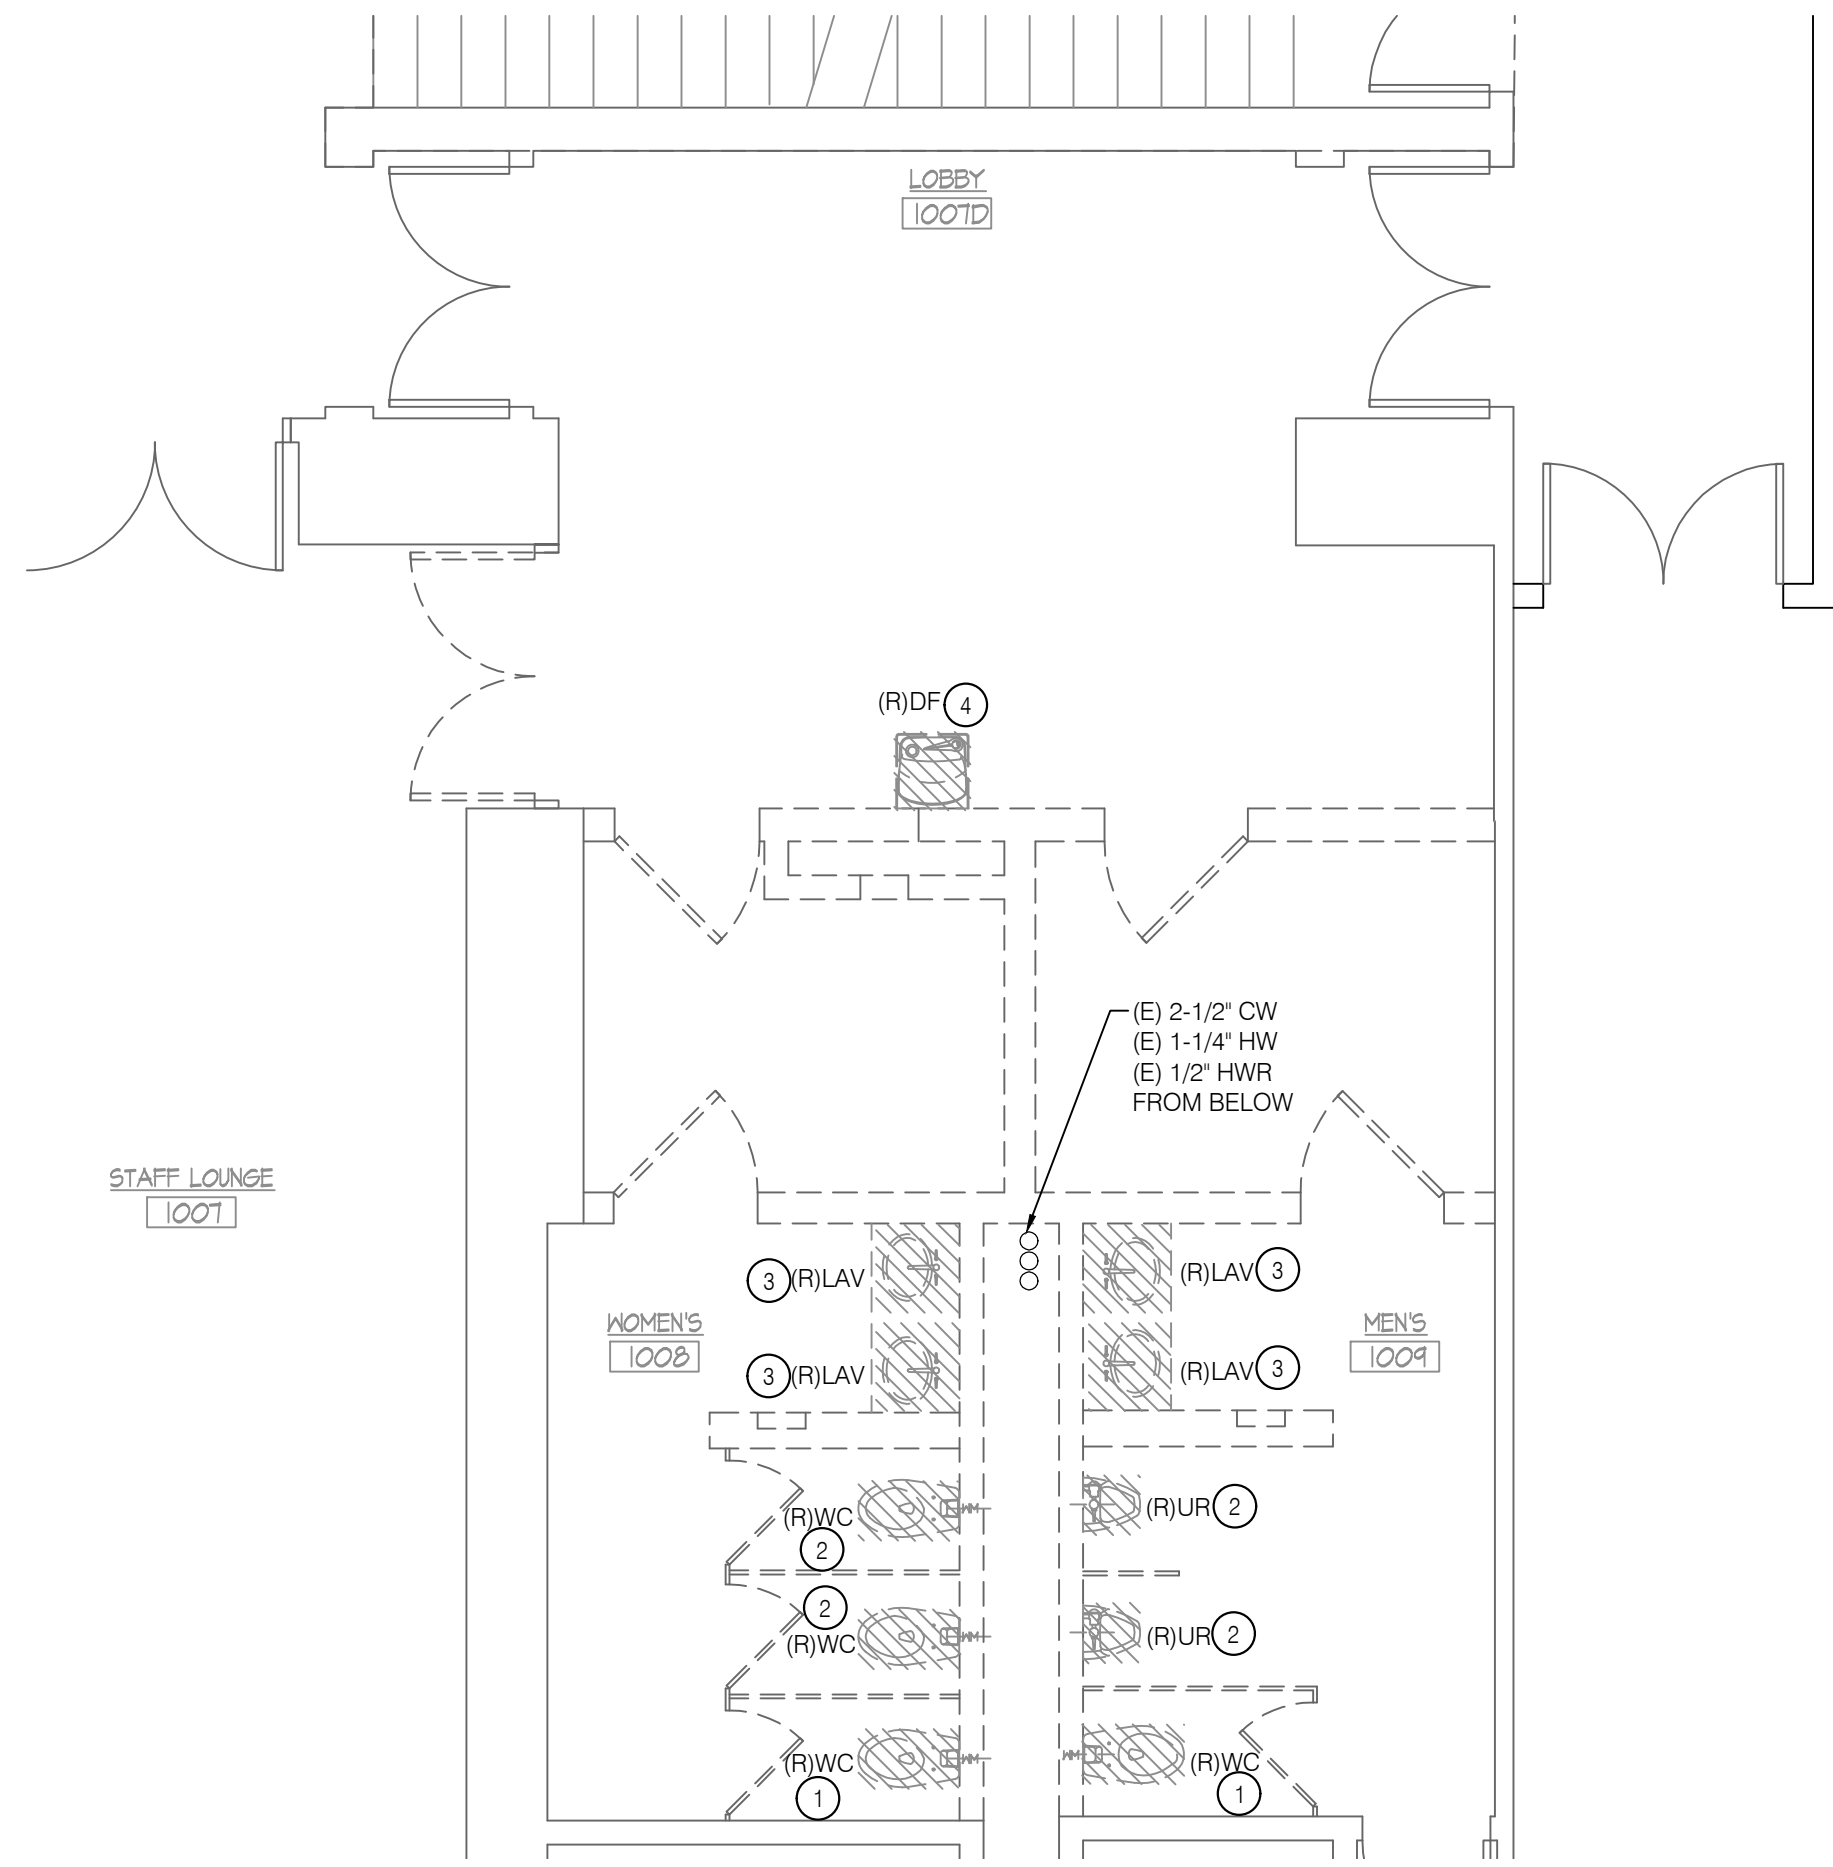


1 FIRST FLOOR PLAN - PLUMBING REMOVALS
P-104.00 SCALE: 1/4" = 1'-0"

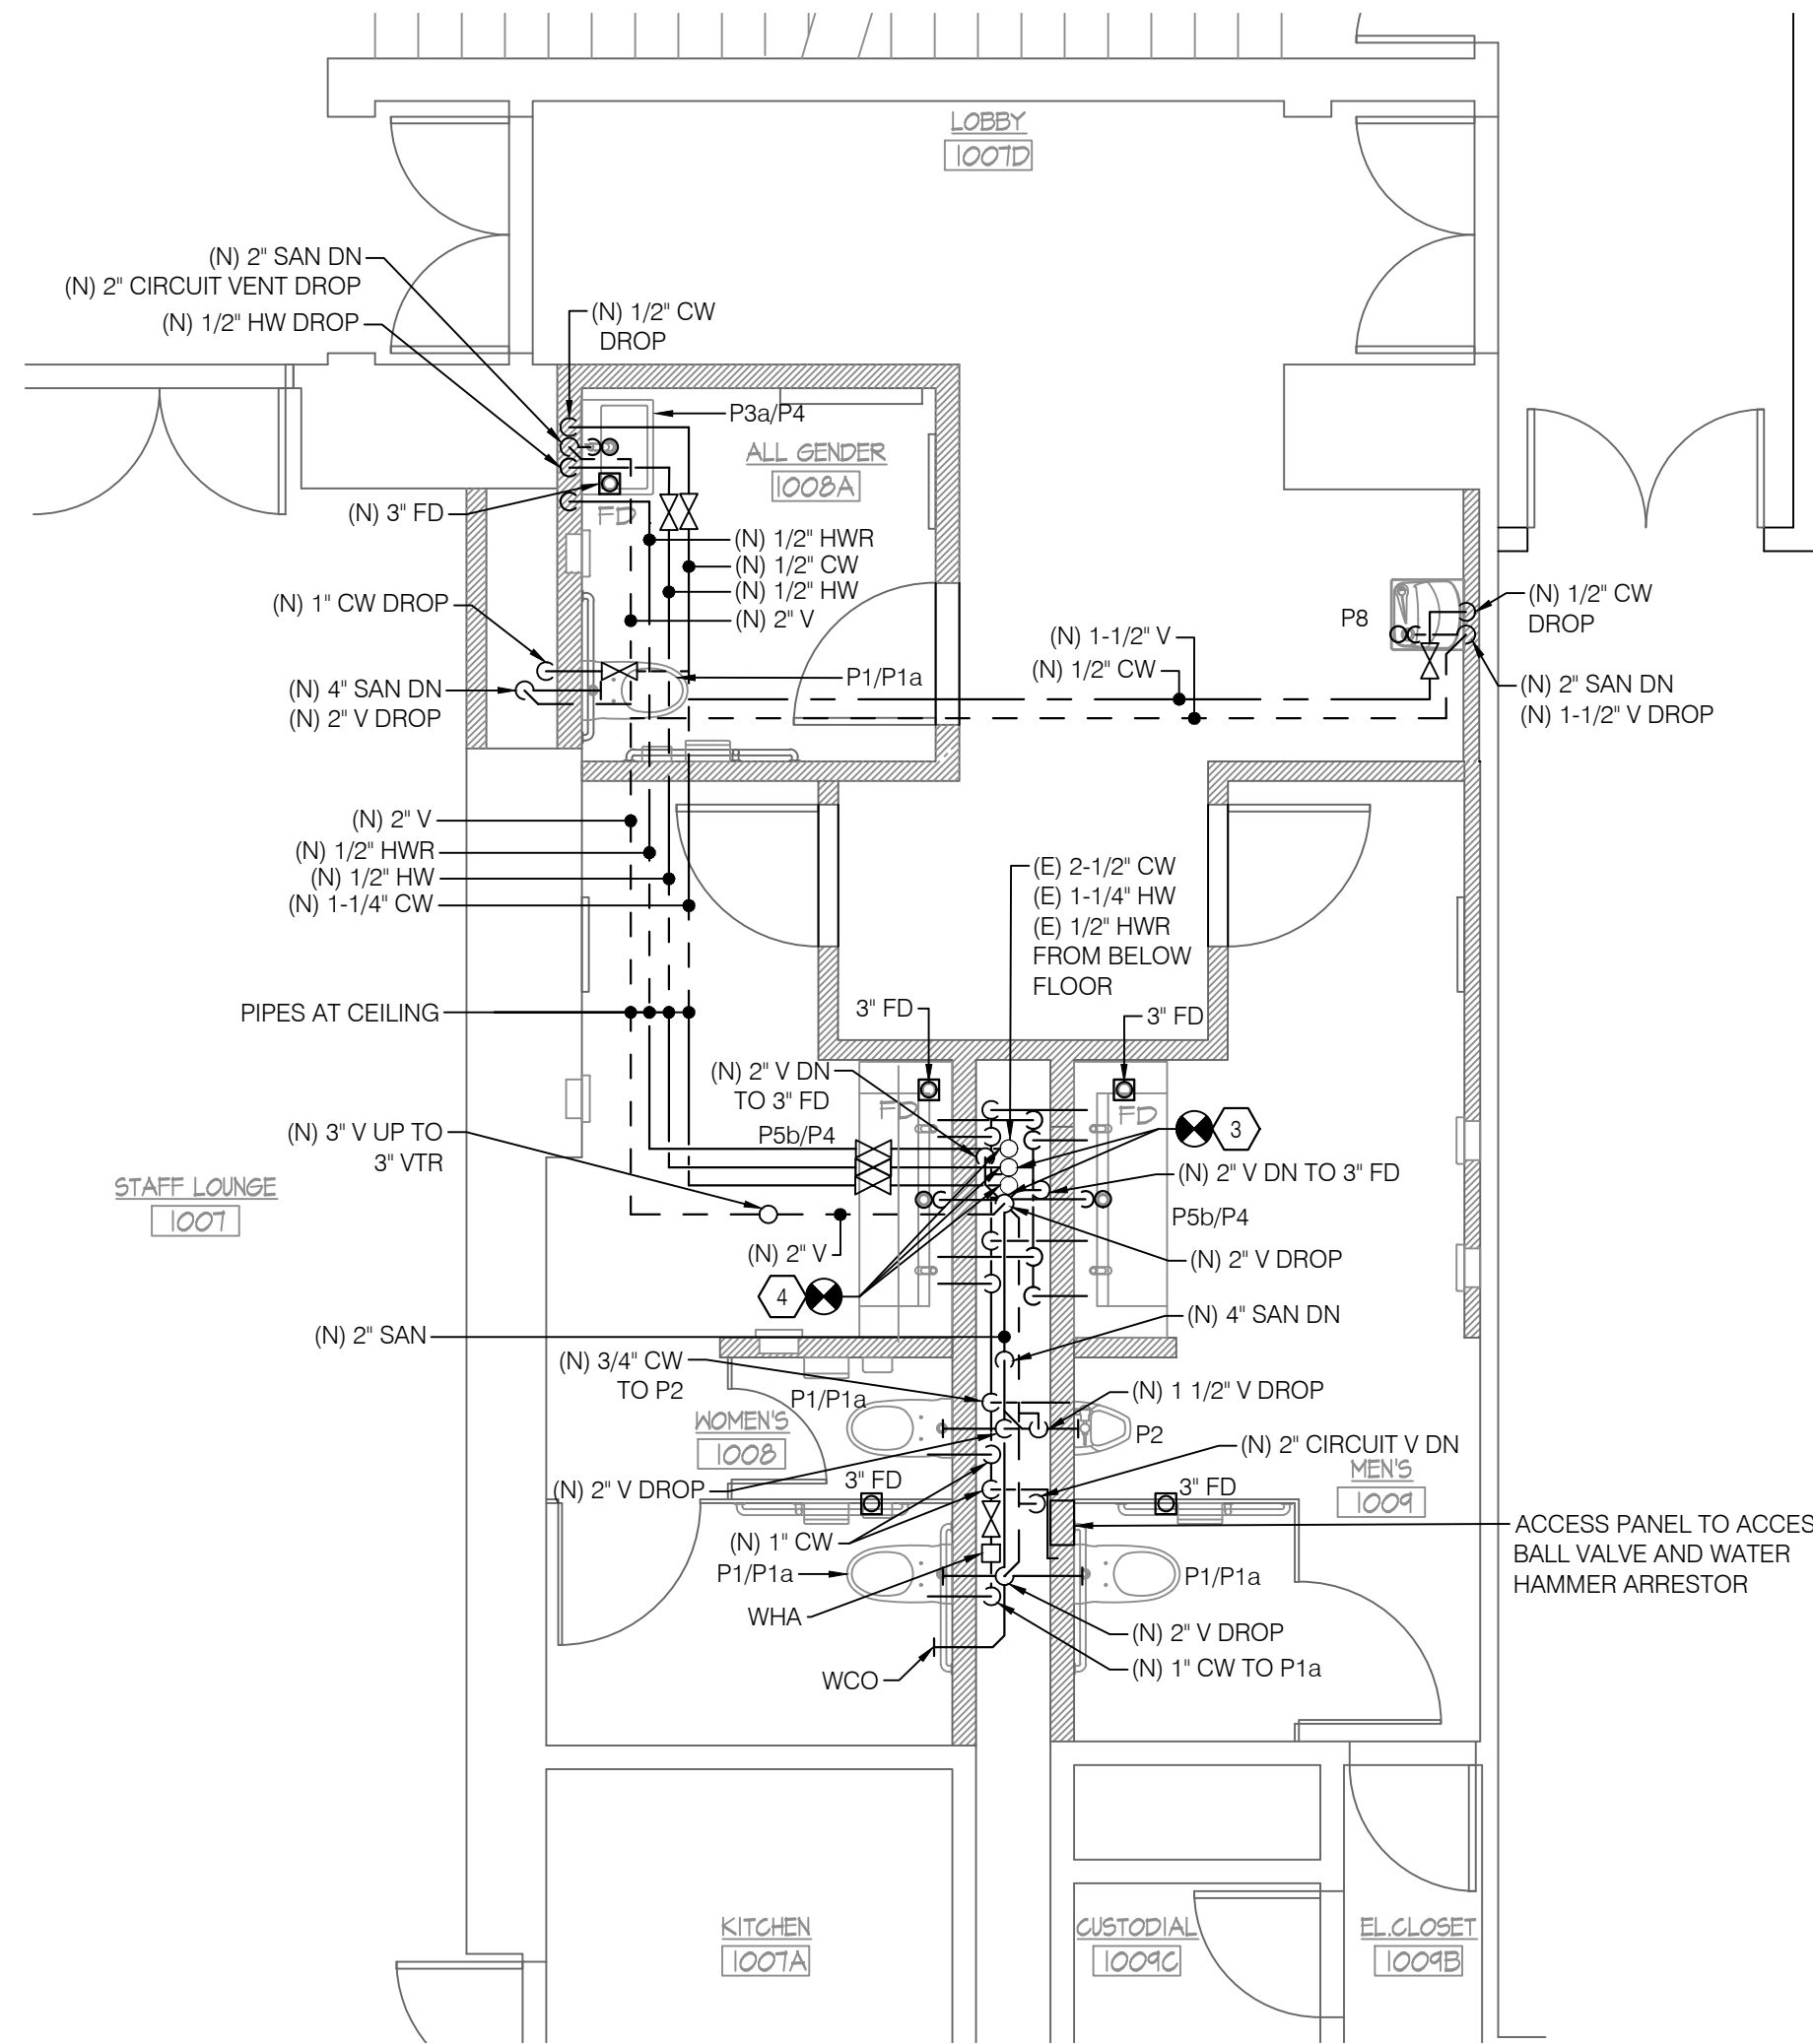

3 FIRST FLOOR PLAN PLAN - PLUMBING NEW WORK
P-104.00 SCALE: 1/4" = 1'-0"

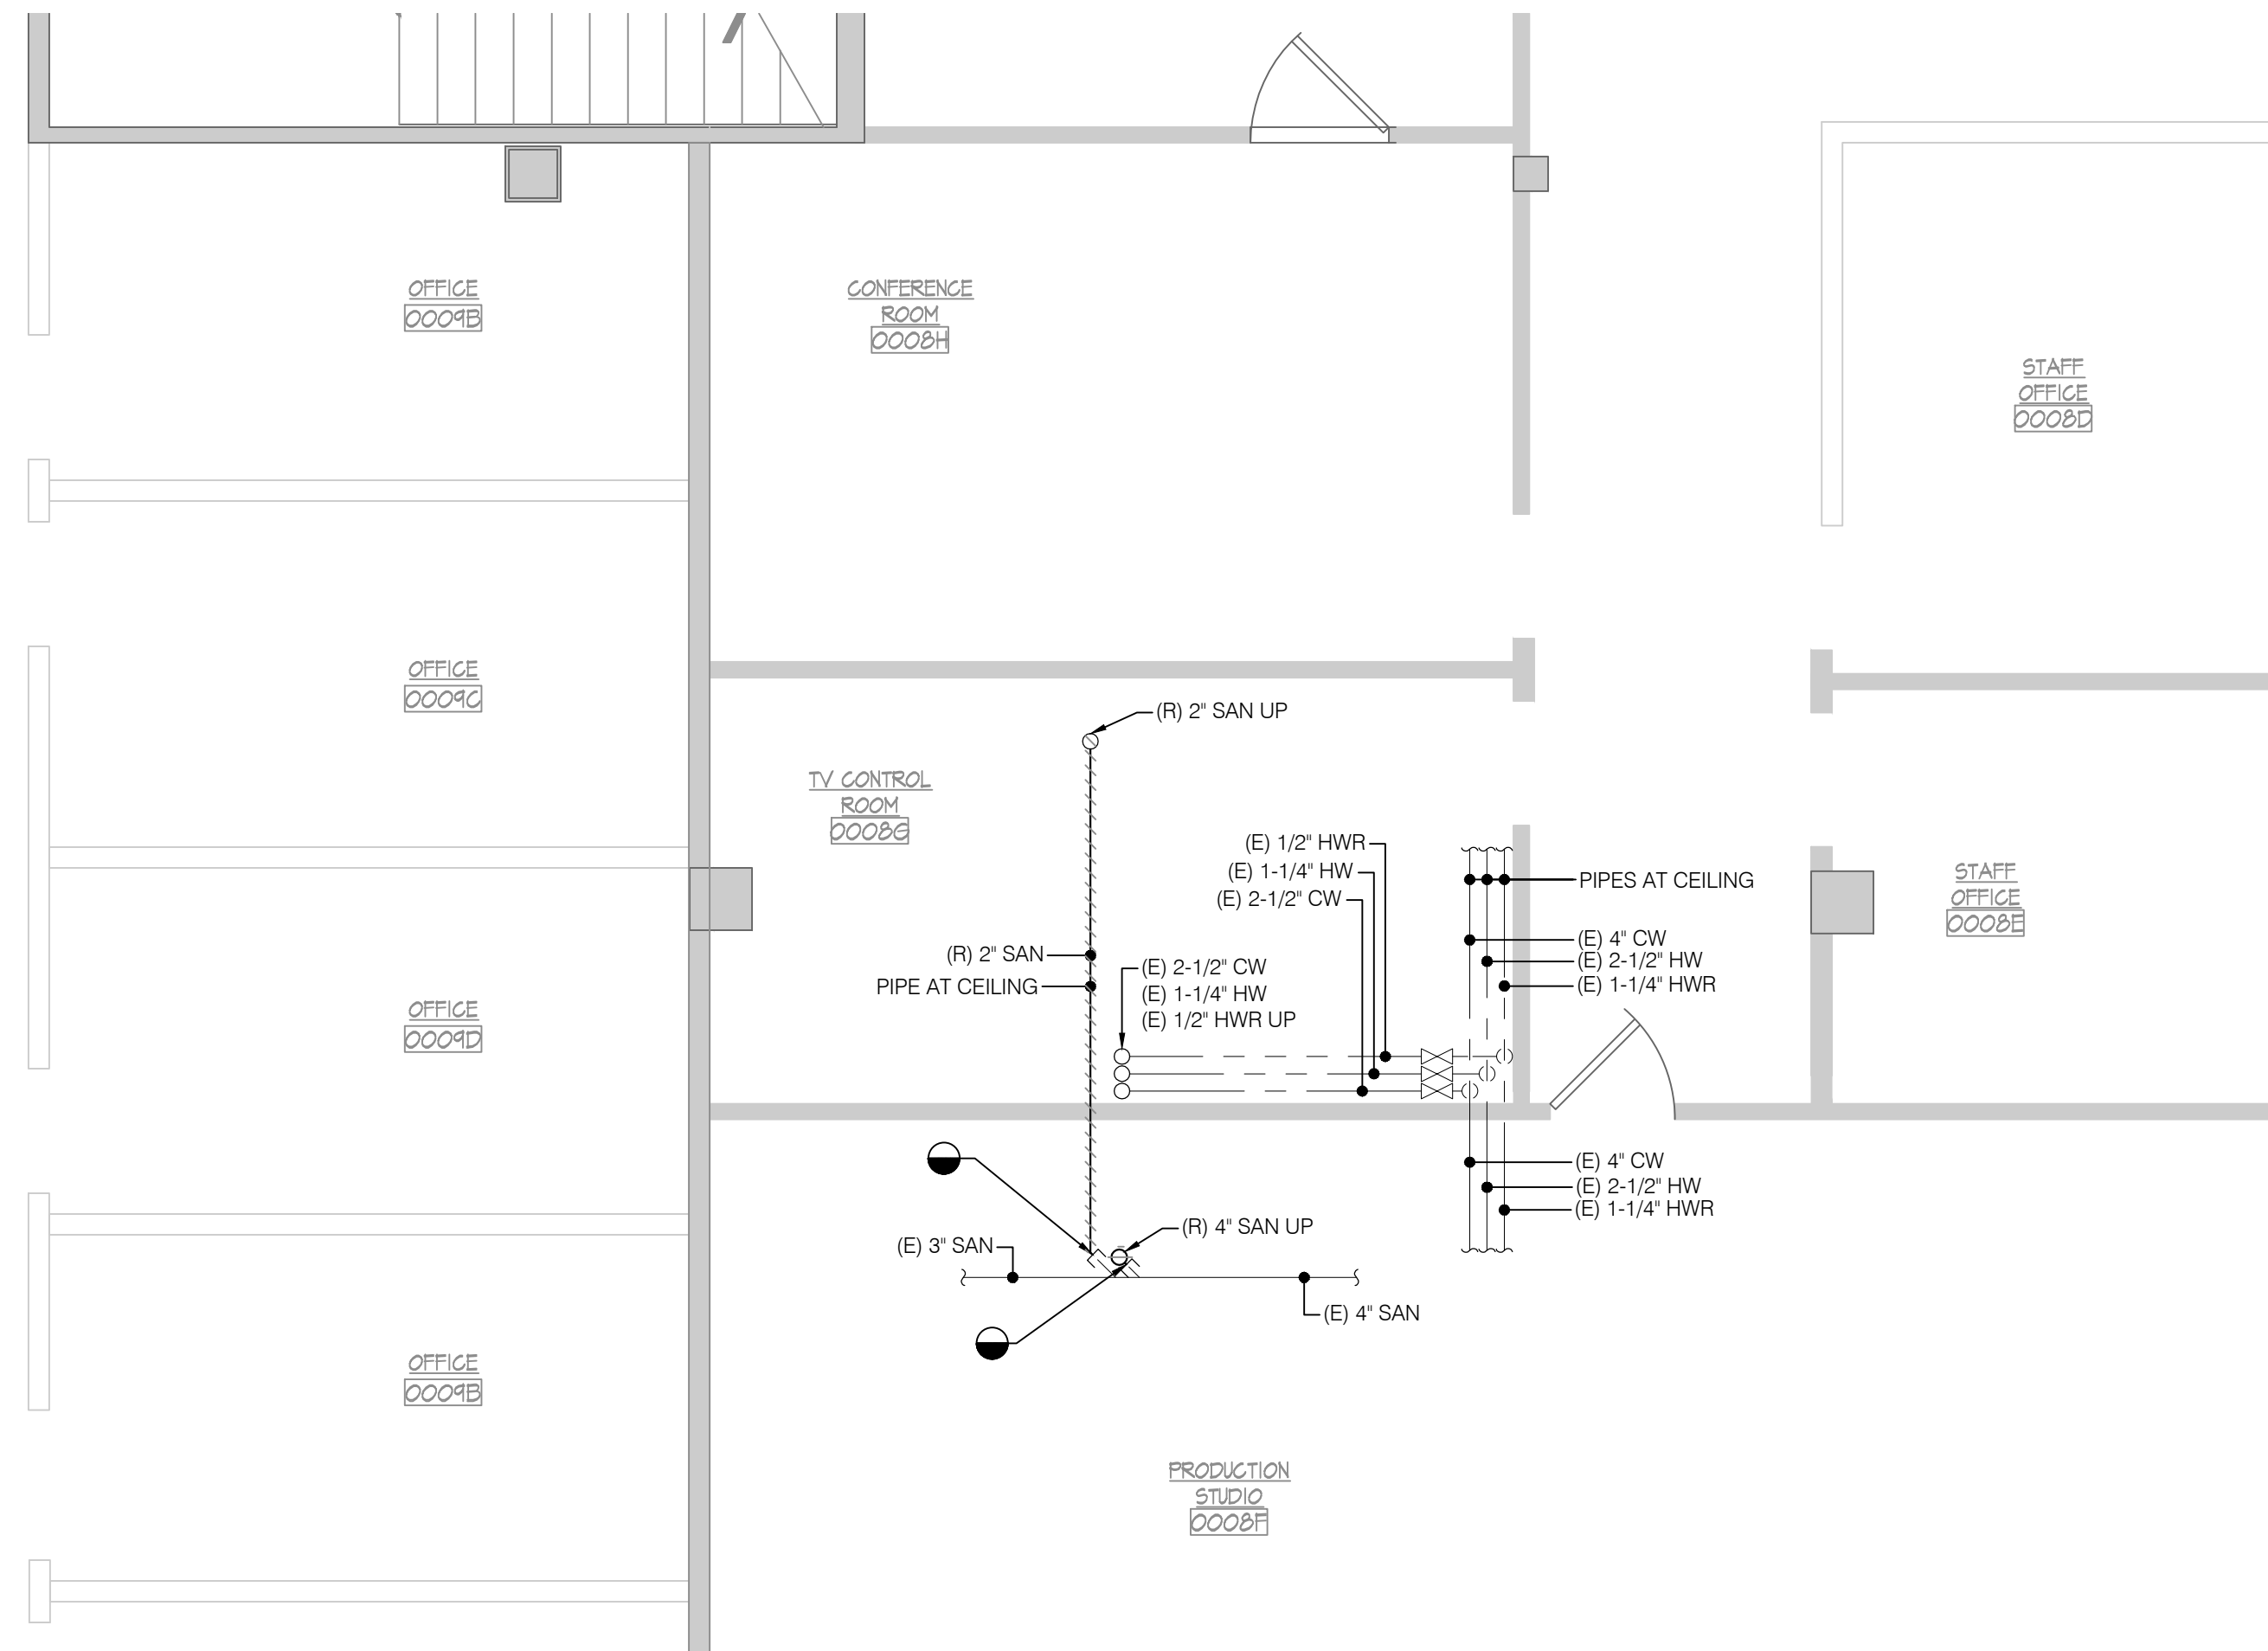

2 BASEMENT FLOOR PLAN - PLUMBING REMOVALS
P-104.00 SCALE: 1/4" = 1'-0"

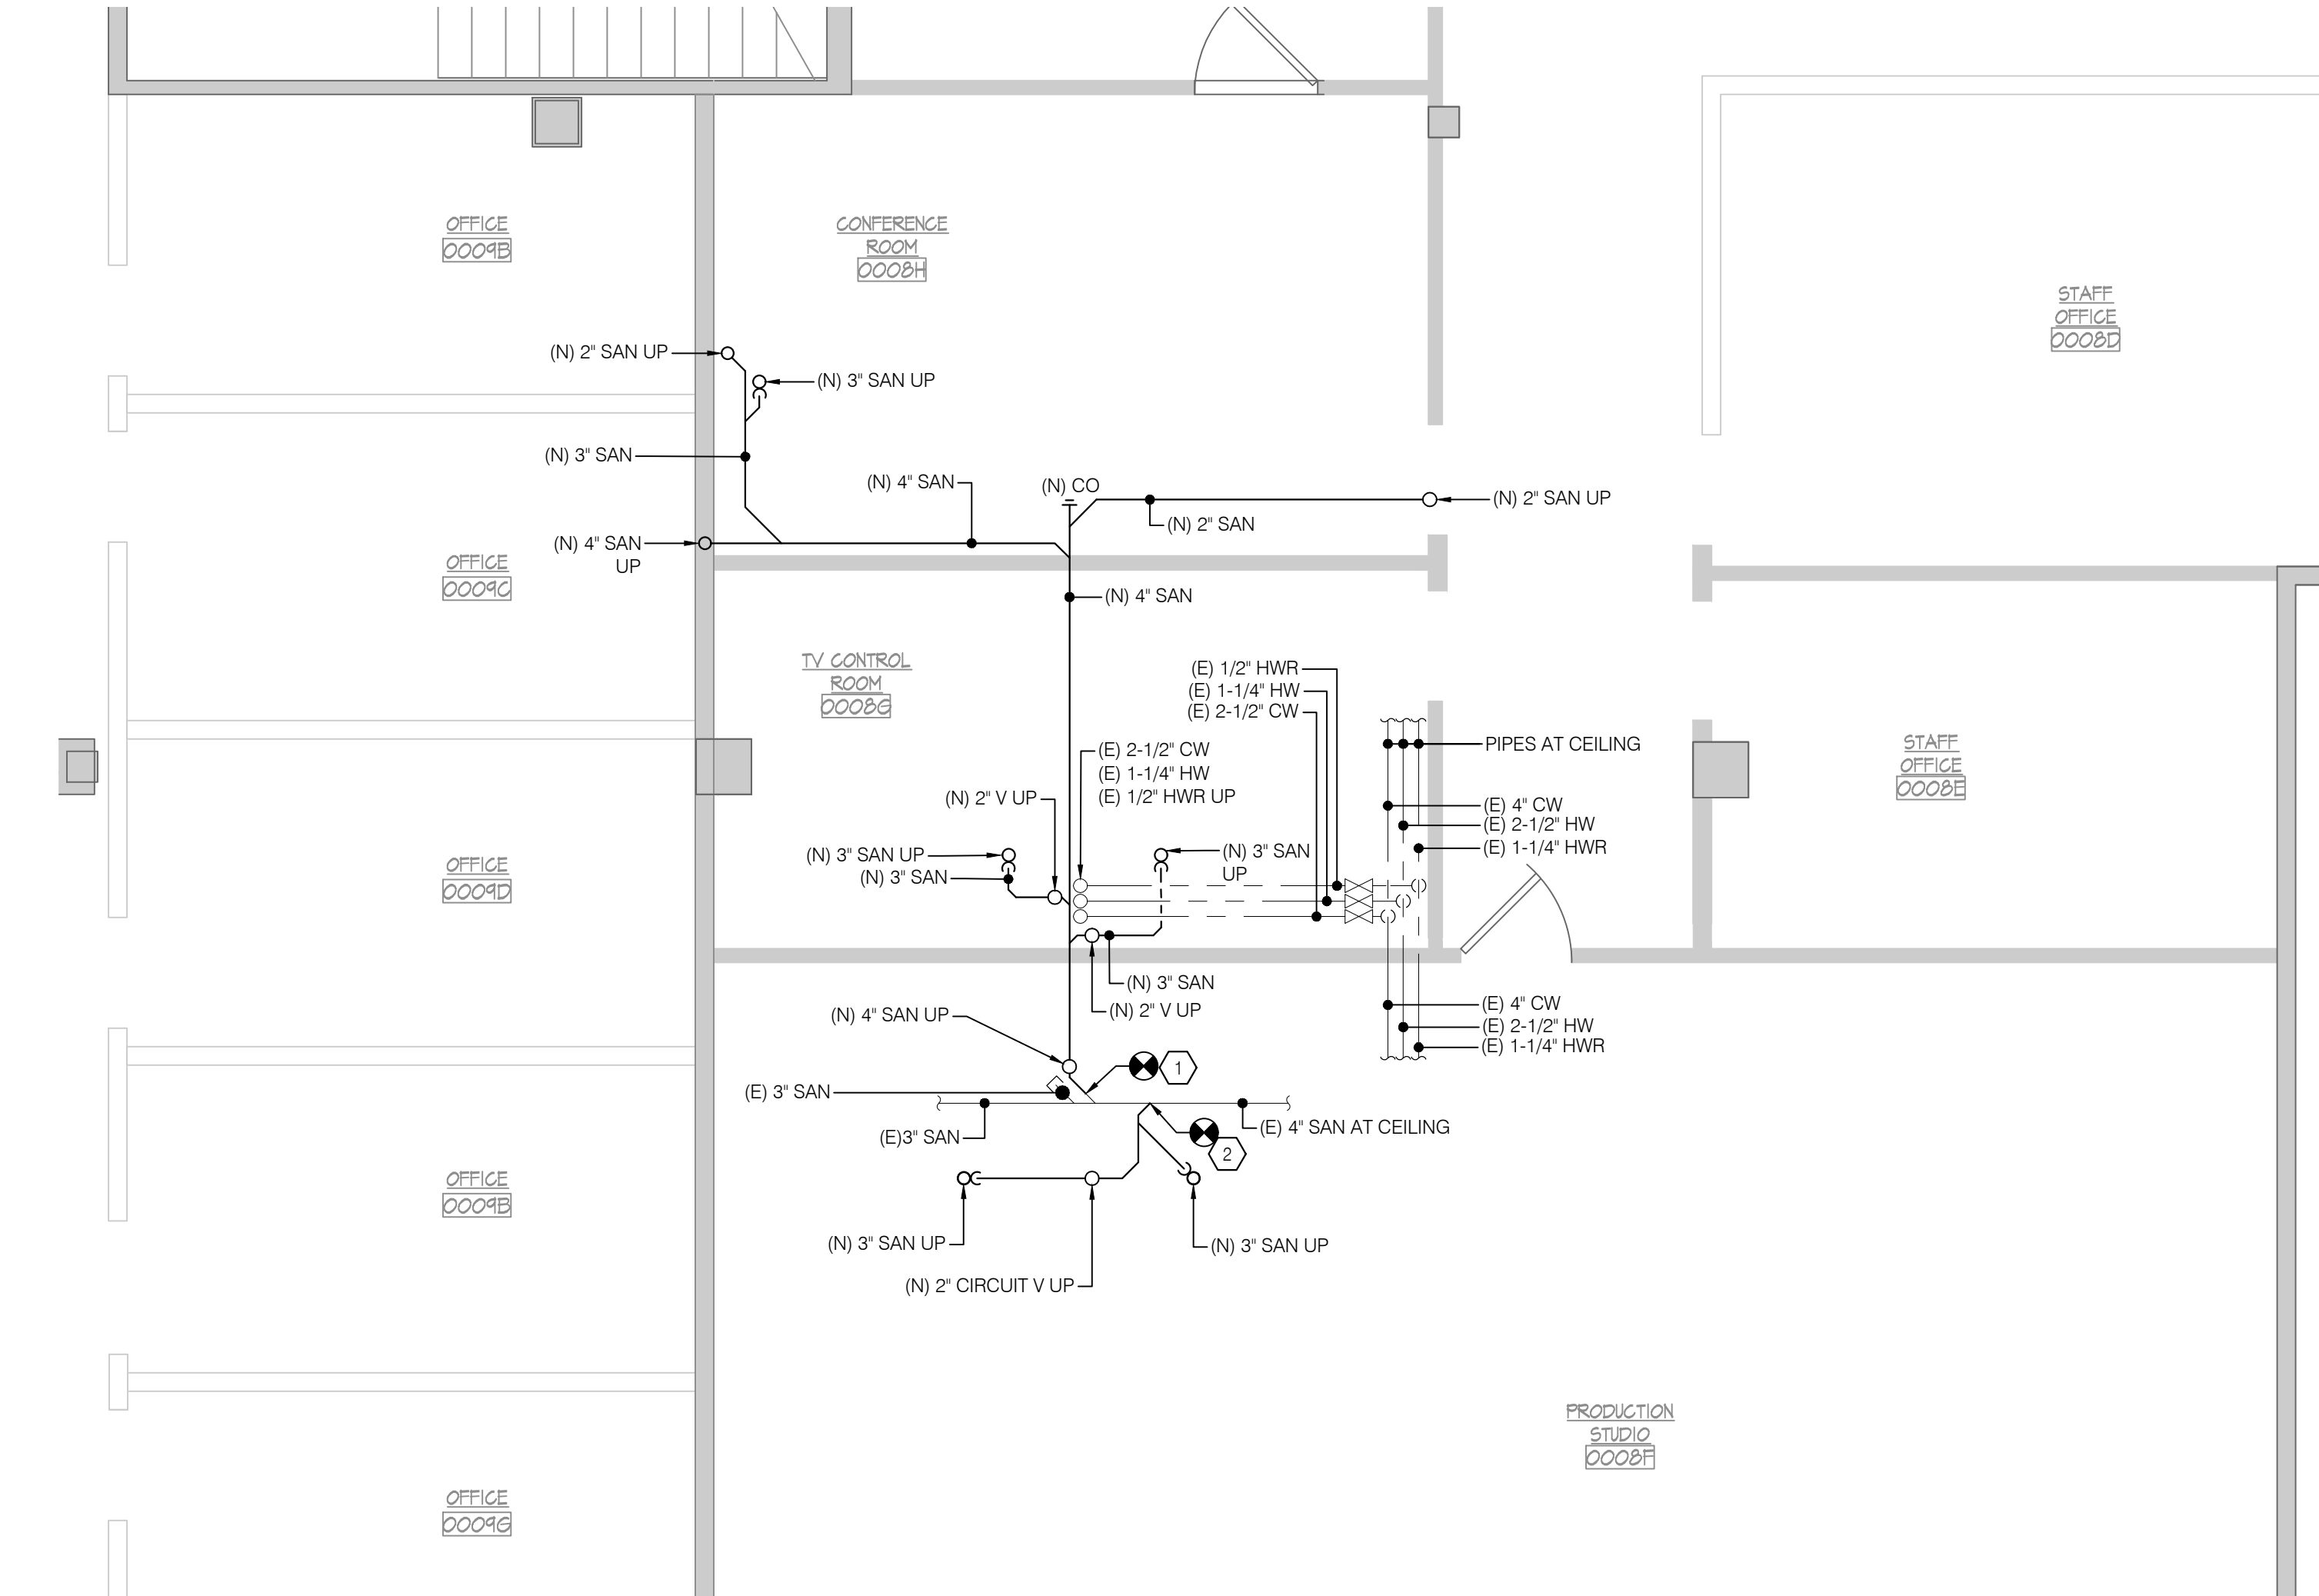

4 BASEMENT FLOOR PLAN - PLUMBING NEW WORK
P-104.00 SCALE: 1/4" = 1'-0"

DEMOLITION KEY NOTES

1. REMOVE EXISTING WATER CLOSET, FLUSH VALVE, CARRIER AND ASSOCIATED PIPES.
2. REMOVE EXISTING URINAL, FLUSH VALVE, CARRIER AND ASSOCIATED PIPES.
3. REMOVE EXISTING LAVATORY, FAUCET ALONG WITH P-TRAP CONNECTIONS AND ASSOCIATED PIPES.
4. REMOVE EXISTING DRINKING FOUNTAIN AND ALL ASSOCIATED PIPES.

NEW WORK KEY NOTES

1. CONNECT NEW 4\"/>

RESTROOM RENOVATION PURCHASE COLLEGE

STATE UNIVERSITY OF NEW YORK

735 Anderson Hill Rd.
Purchase, NY 10577

PHASE 2:

MUSIC BUILDING
DANCE BUILDING
PHYS. ED. BUILDING
LIBRARY

Conditions

ALL IDEAS, DESIGNS, ARRANGEMENTS AND PLANS INDICATED OR REPRESENTED BY THIS DRAWING ARE OWNED BY, AND THE PROPERTY OF RONNETTE RILEY ARCHITECT AND WERE CREATED, DEVELOPED AND DEVELOPED FOR THE USE OF, AND IN CONNECTION WITH THE NONE OF SUCH IDEAS, DESIGNS, ARRANGEMENTS OR PLANS SHALL BE USED BY OR DISCLOSED TO ANY PERSON, FIRM OR CORPORATION FOR ANY PURPOSE WHATSOEVER WITHOUT THE WRITTEN PERMISSION OF RONNETTE RILEY ARCHITECT.

© Copyright Ronnette Riley Architect 2020

Ronnette Riley Architect


494 Eighth Avenue, 15th Floor
New York, NY 10001
T 212 594 4015
F 212 594 2868
www.ronnetteriley.com

MEP Engineer

SETTY & Associates, Ltd
149 W 36th Street, 8th floor
New York, NY 10018
T 646 253 9000
F 646 224 8497

Rev	Date	Issue
	05 May 2022	Issue for Bid

KEY PLAN

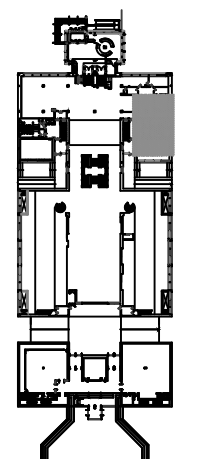

Title LIBRARY BUILDING - PLUMBING PLANS

Date	01-16-2020
Project No.	1944
Drawing By	CHS
CHK By	KB
Scale	AS NOTED

DOB Rev

P-104.00

