


1 BASEMENT LEVEL PLAN - PLUMBING REMOVALS
SCALE: 1/4" = 1'-0"

2 BASEMENT LEVEL PLAN - PLUMBING REMOVALS (BELOW FLOOR PIPING)
SCALE: 1/4" = 1'-0"

3 BASEMENT LEVEL PLAN - PLUMBING NEW WORK
SCALE: 1/4" = 1'-0"

4 BASEMENT LEVEL PLAN - PLUMBING NEW WORK (BELOW FLOOR PIPING)
SCALE: 1/4" = 1'-0"

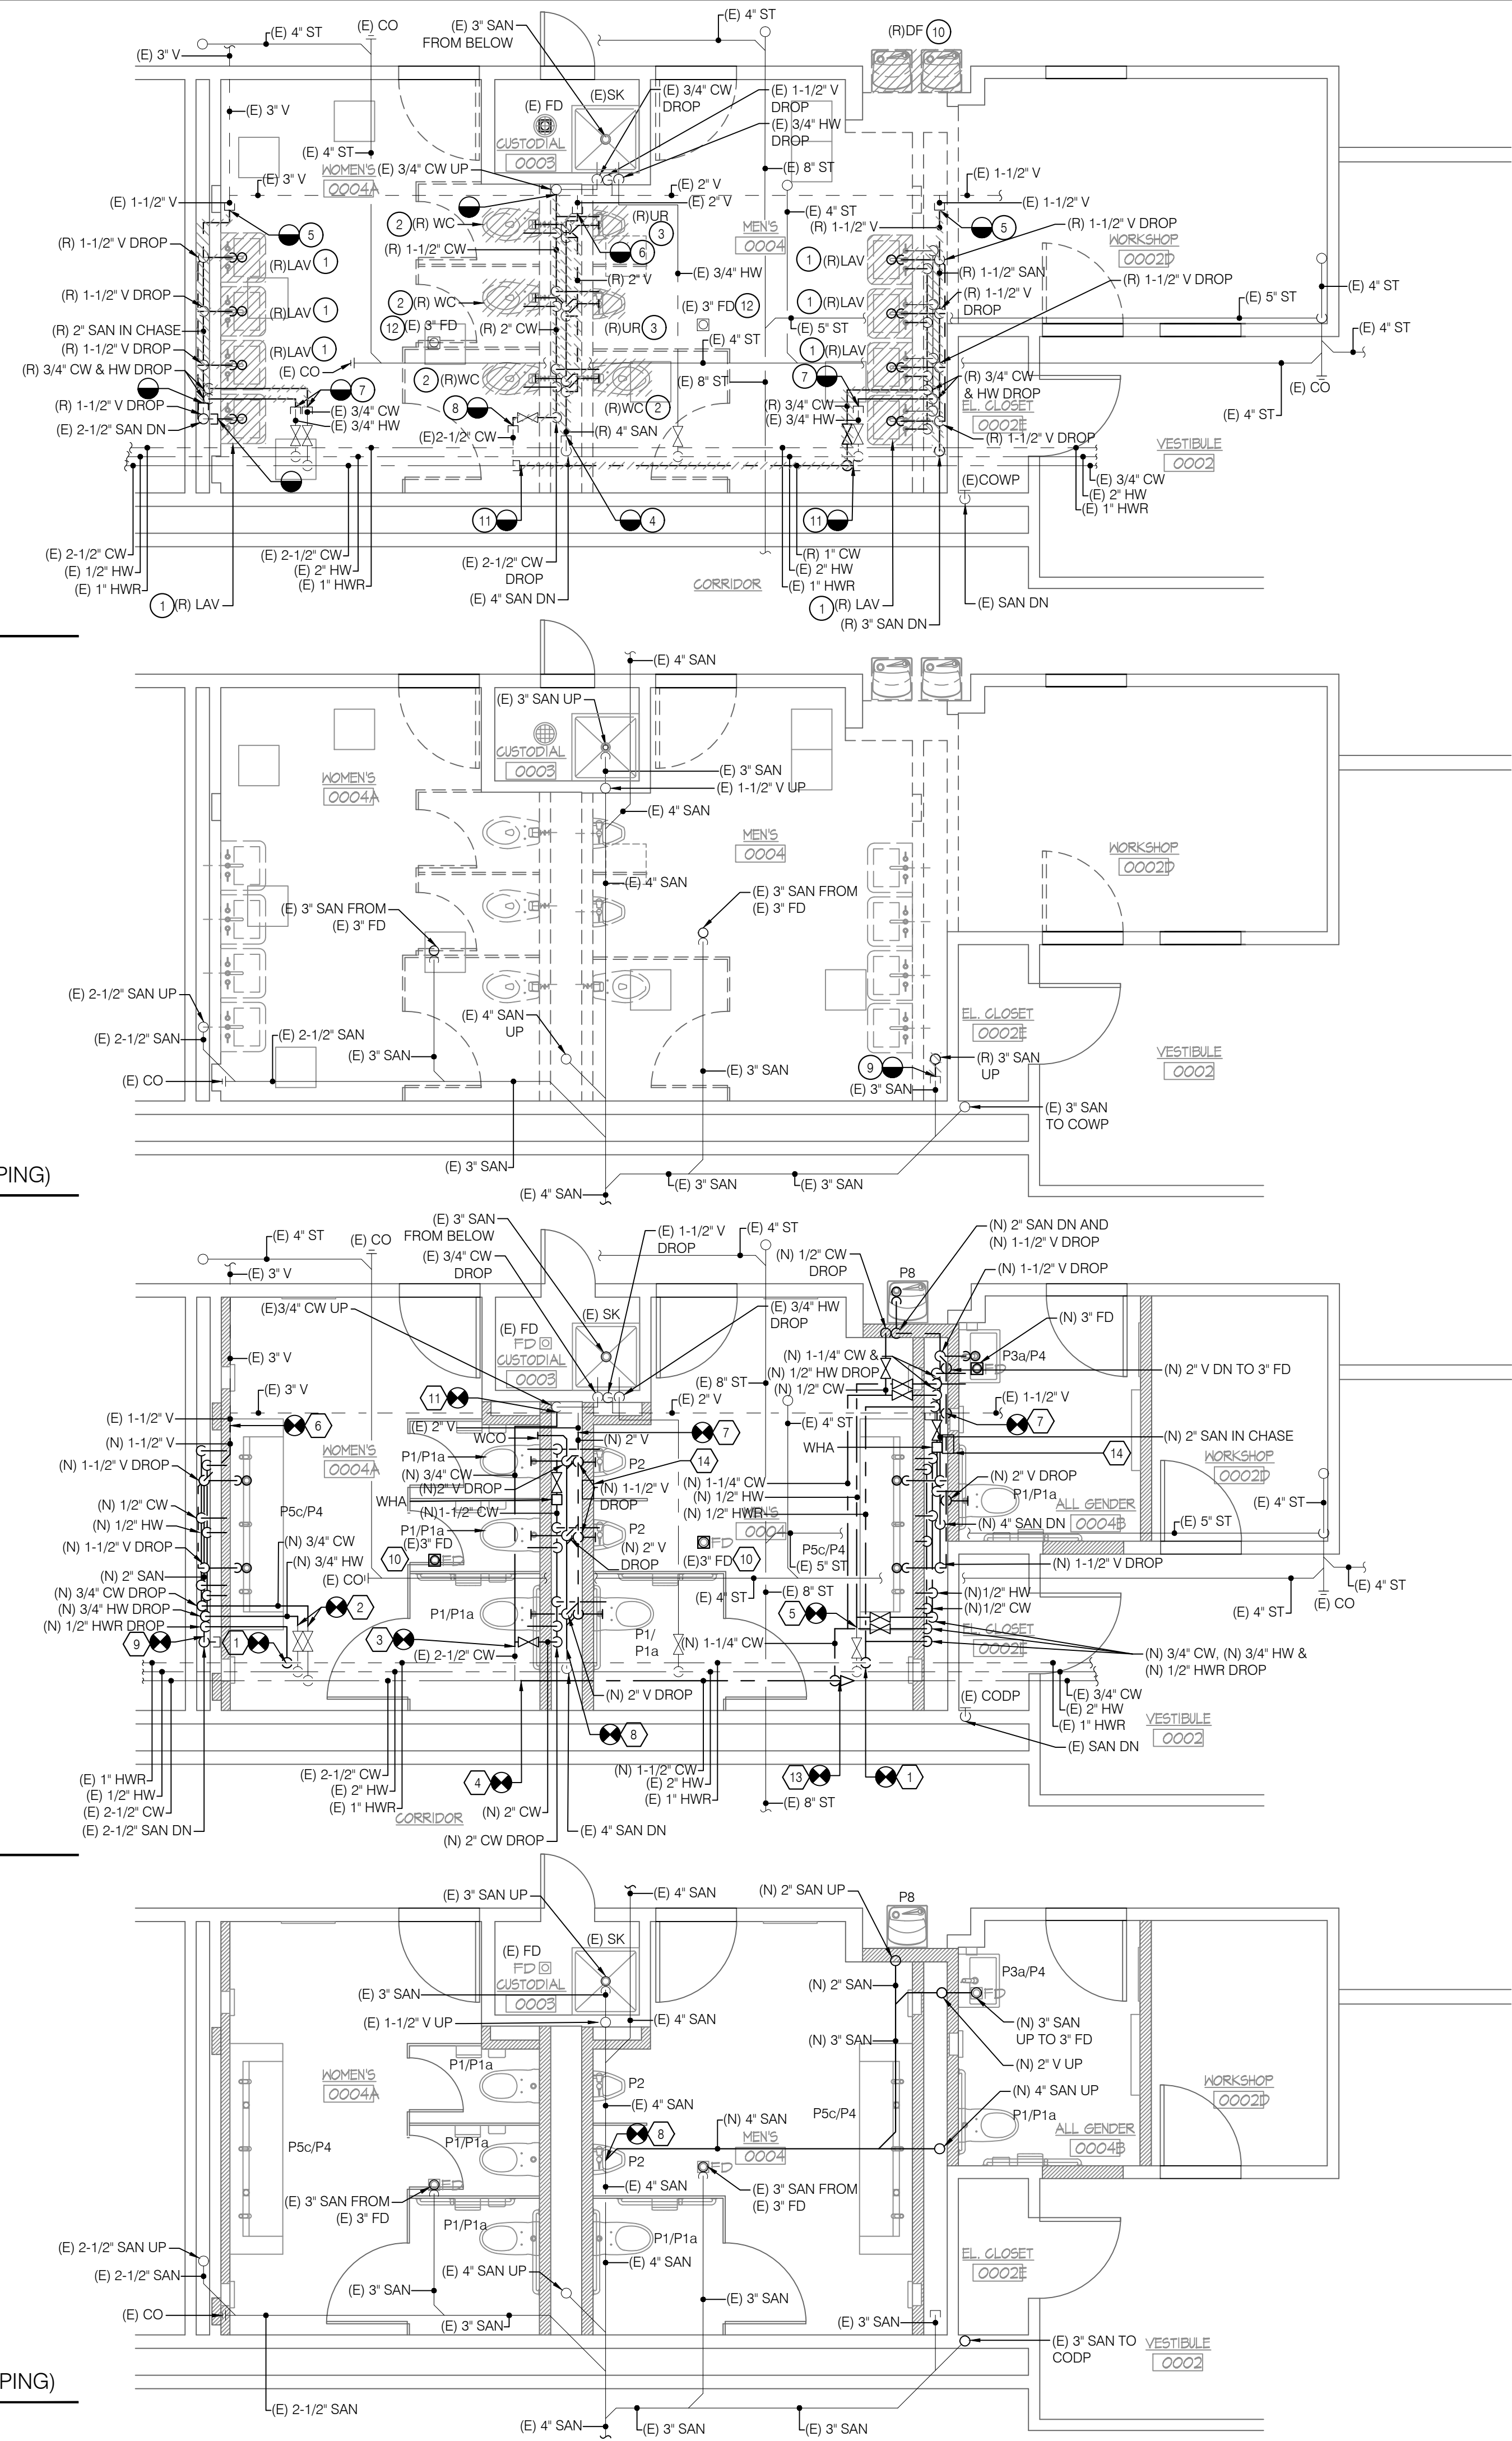

- ### # DEMOLITION KEY NOTES
1. REMOVE EXISTING LAVATORY, FAUCET ALONG WITH P-TRAP CONNECTIONS AND ASSOCIATED PIPES.
 2. REMOVE EXISTING WATER CLOSET, FLUSH VALVE, CARRIER AND ASSOCIATED PIPES.
 3. REMOVE EXISTING URINAL, FLUSH VALVE, CARRIER AND ASSOCIATED PIPES.
 4. CUT AND CAP EXISTING 4\"/>

- ### # SHEET KEY NOTES
1. CONNECT NEW 1/2\"/>

RESTROOM RENOVATION PURCHASE COLLEGE

STATE UNIVERSITY OF NEW YORK

735 Anderson Hill Rd.
Purchase, NY 10577

PHASE 2: MUSIC BUILDING DANCE BUILDING PHYS. ED. BUILDING LIBRARY

Conditions
ALL IDEAS, DESIGNS, ARRANGEMENTS AND PLANS INDICATED OR REPRESENTED BY THIS DRAWING ARE OWNED BY, AND THE PROPERTY OF RONNETTE RILEY ARCHITECT AND WERE CREATED, DEVELOPED AND DEVELOPED FOR THE USE OF, AND IN CONNECTION WITH THE NONE OF SUCH IDEAS, DESIGNS, ARRANGEMENTS OR PLANS SHALL BE USED BY OR DISCLOSED TO ANY PERSON, FIRM OR CORPORATION FOR ANY PURPOSE WHATSOEVER WITHOUT THE WRITTEN PERMISSION OF RONNETTE RILEY ARCHITECT.


© Copyright Ronnette Riley Architect 2020

Ronnette Riley Architect

494 Eighth Avenue, 15th Floor
New York, NY 10001
T 212 594 4015
F 212 594 2868
www.ronnetteriley.com

MEP Engineer
SETTY & Associates, Ltd
149 W 36th Street, 8th floor
New York, NY 10018
T 646 253 9000
F 646 224 8497

Rev	Date	Issue
	05 May 2022	Issue for Bid

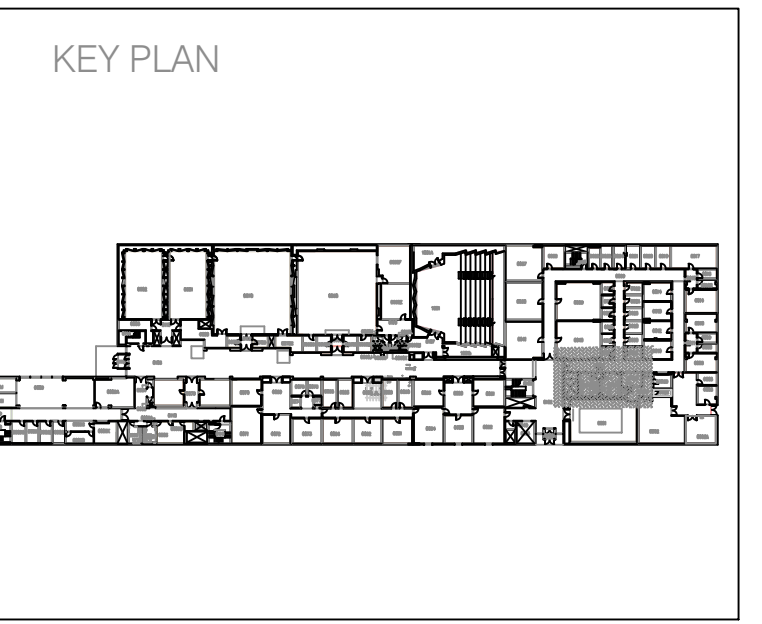

MUSICAL BUILDING - PLUMBING PLANS

Date	01-16-2020
Project No.	1944
Drawing By	CHS
CHK By	KB
Scale	AS NOTED
	DOB Rev
P-101.00	