



PRINTED ARCHITECT 30" x 42" 3/10/2022 9:40:40 AM

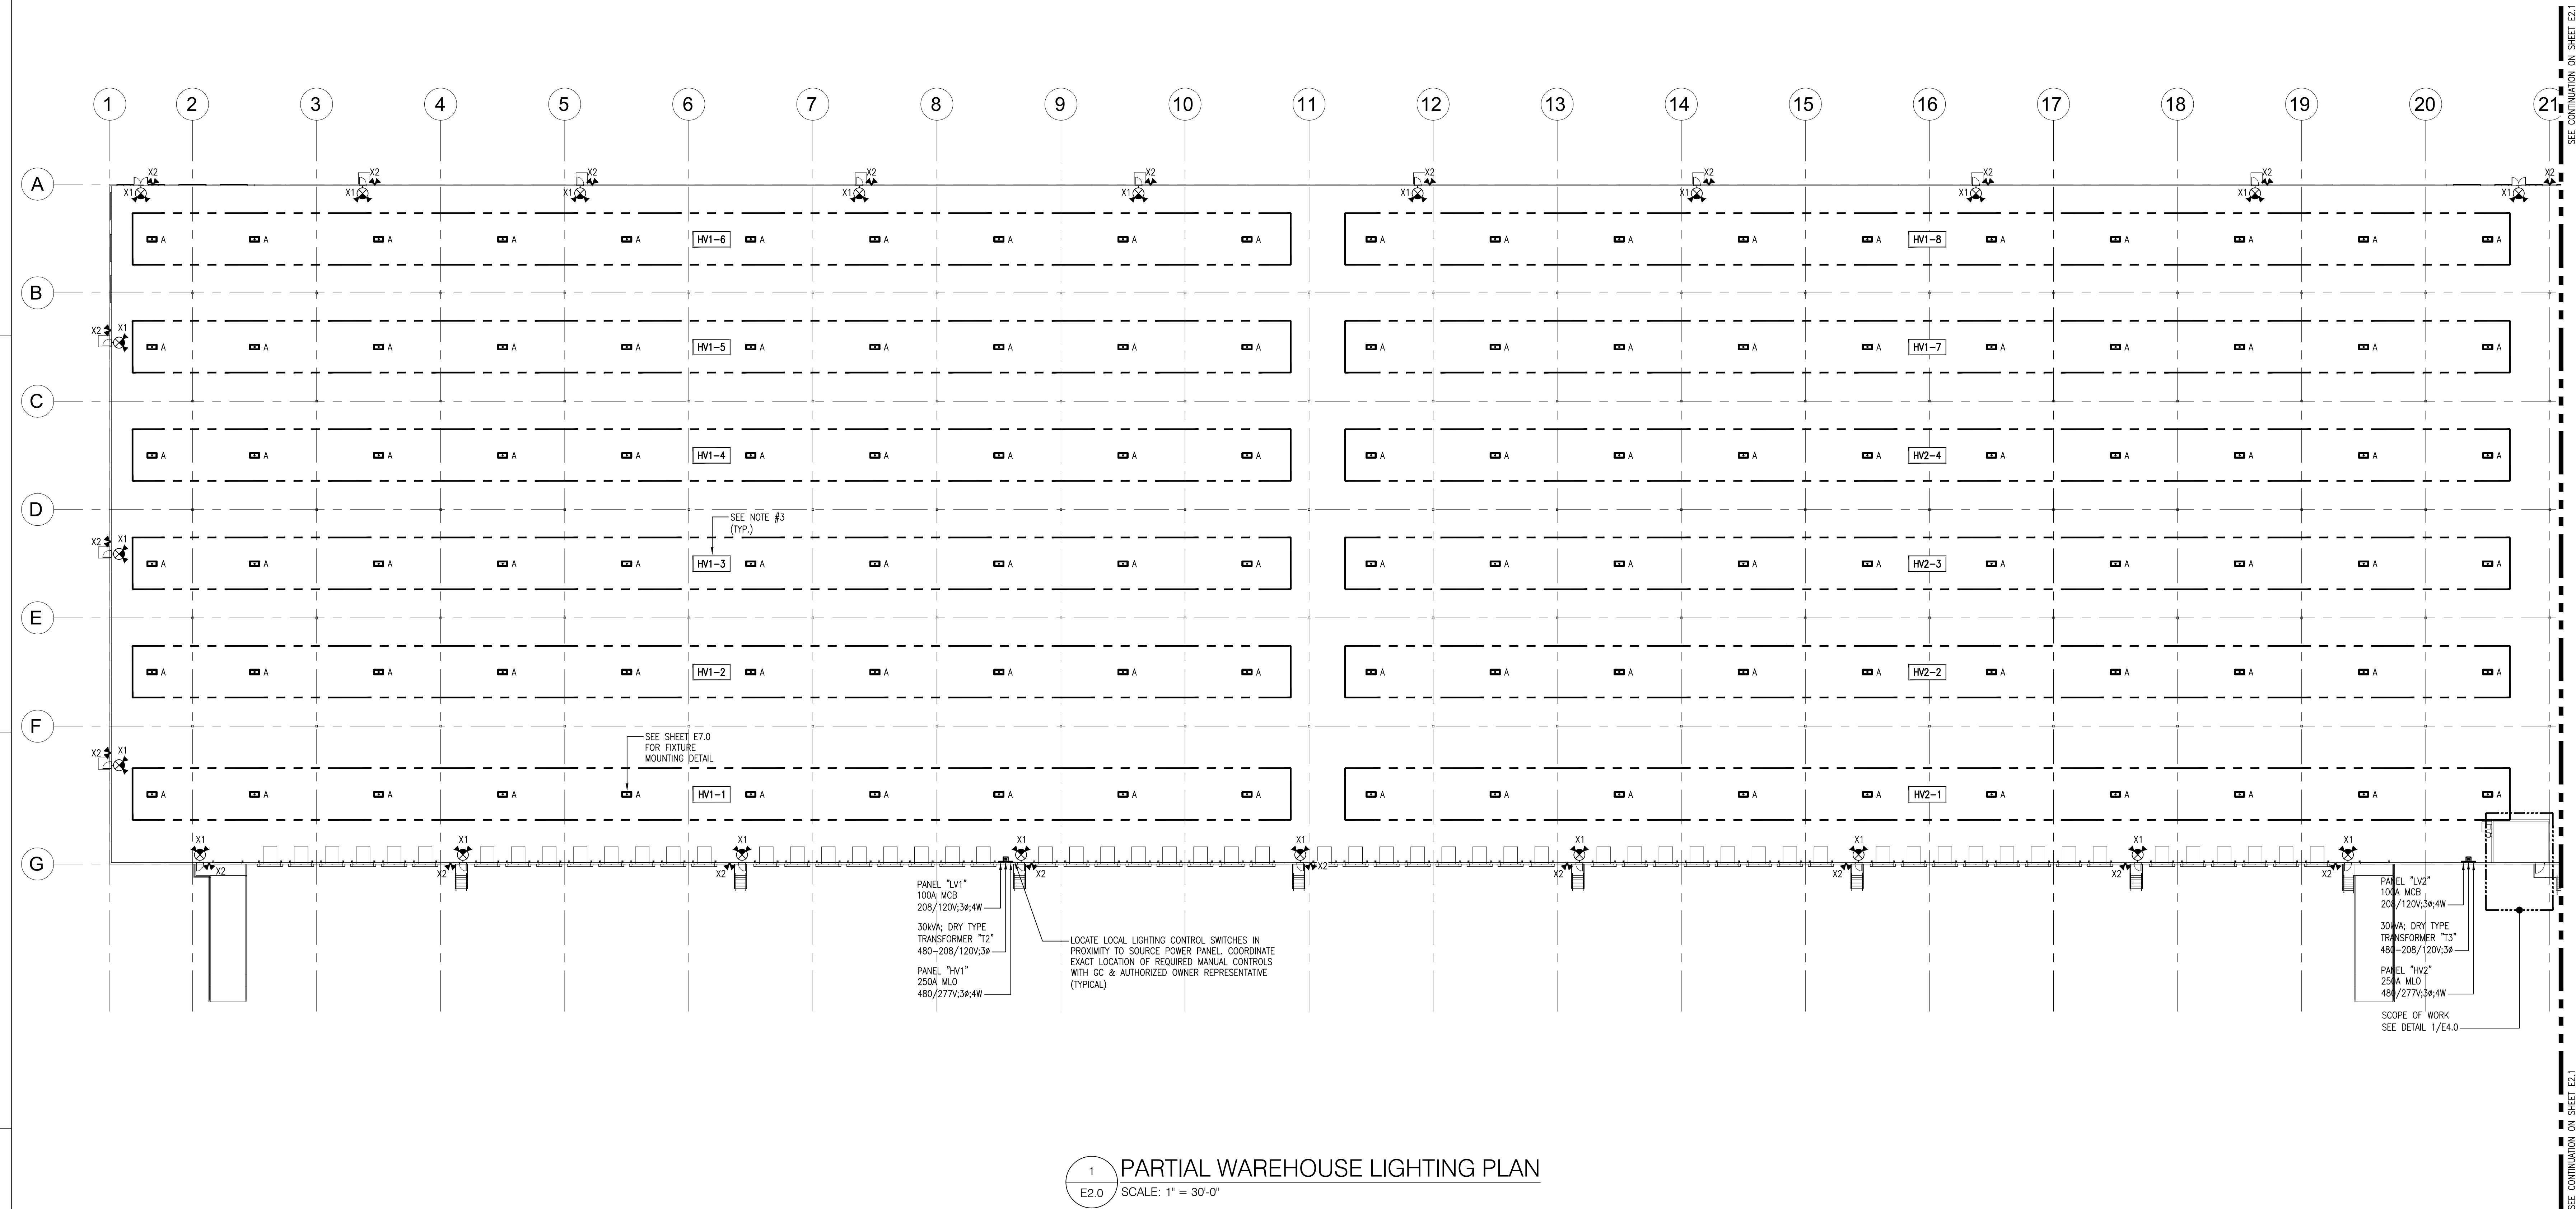

1
E2.0

PARTIAL WAREHOUSE LIGHTING PLAN
SCALE: 1" = 30'-0"

NOTES:
1. ALL SHOWN IS NEW & BY EC UNLESS SPECIFICALLY NOTED OTHERWISE
2. ALL EXIT SIGNAGE & EMERGENCY LIGHTING TO BE WIRED TO LOCAL LIGHTING CIRCUIT AND AHEAD OF ALL SWITCHING
3. ALL LIGHTING FIXTURES WITHIN THE SPECIFIED AREA SHALL BE CIRCUITED TO THE CIRCUIT NUMBER(S) INDICATED ON THIS PLAN, UNLESS NOTED OTHERWISE. SEE PANEL SCHEDULES ON DRAWING E6.0 FOR ADDITIONAL INFORMATION.

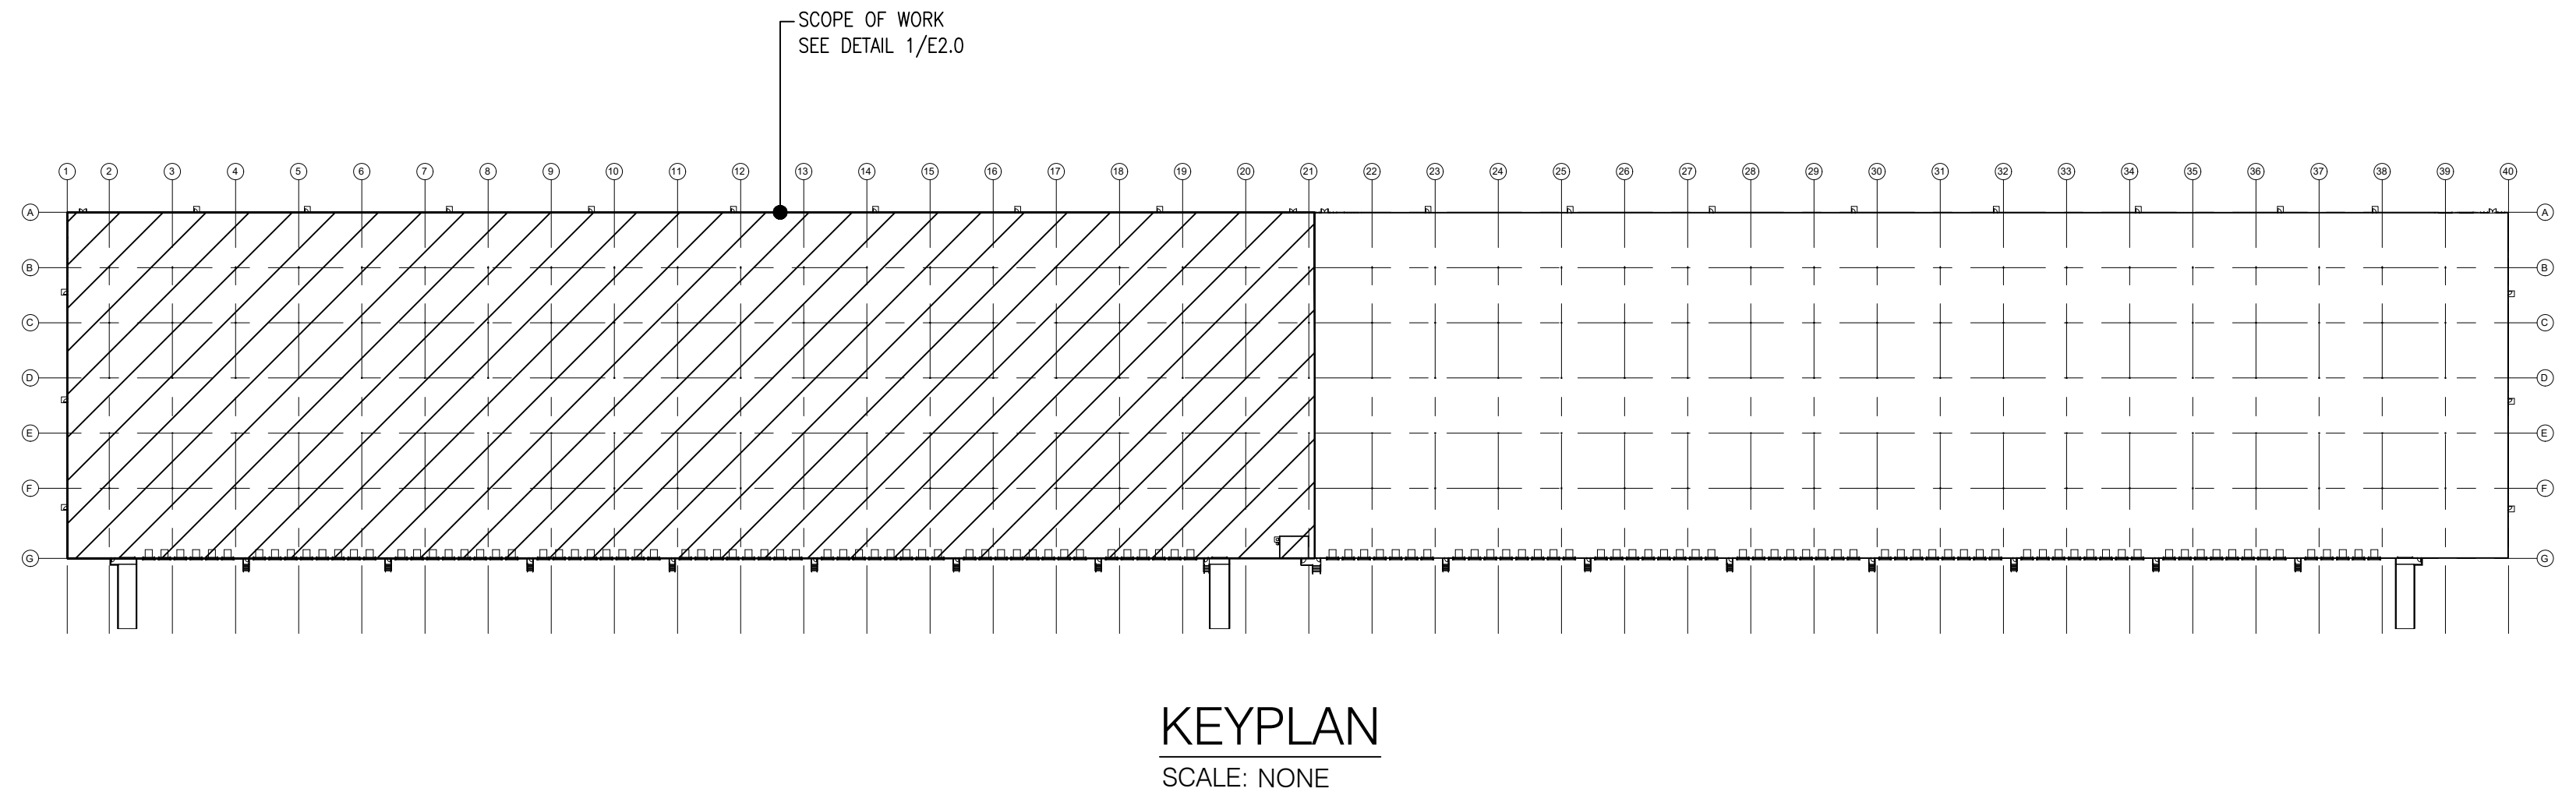

DESIGNER / BUILDER

ARCO

DESIGN/BUILD INDUSTRIAL

44 SOUTH BROADWAY, SUITE 1003
WHITE PLAINS, NY 10601
P: 914.821.5535 F: 914.306.6010

ADBI / *DESIGN SERVICES*

PROJECT TITLE

**LINCOLN
EQUITIES -
NY-312 - ALT.
BLDG B**

**NY-312 & PUGSLEY RD,
SOUTHEAST, NY 10509**

ARCHITECT

ADBI / DESIGN SERVICES LLC
44 SOUTH BROADWAY, SUITE 1003
WHITE PLAINS, NY 10601

CIVIL ENGINEER

LANGAN ENGINEERING
300 KIMBALL DRIVE
PARSIPPANY, NJ 07054

STRUCTURAL ENGINEER

SMITH/ROBERTS AND ASSOCIATES, INC.
6501 BLUFF RD.
INDIANAPOLIS, INDIANA 46217

MECHANICAL ENGINEER

NATIONAL DESIGN/ BUILD SERVICES
11840 BORMAN DRIVE
ST. LOUIS, MO 63146

ELECTRICAL ENGINEER

FBX ENGINEERING
5 CHRISTY DRIVE, SUITE 307
CHADDS FORD, PA 19317


PLUMBING ENGINEER

MCCARTHY ENGINEERING ASSOCIATES, INC.
315 EAST SECOND STREET
BOYERTOWN, PA 19512

FIRE PROTECTION ENGINEER

S A COMUNALE CO. INC.
2900 NEWPARK DRIVE
BARBERTON, OH 44203

SEAL

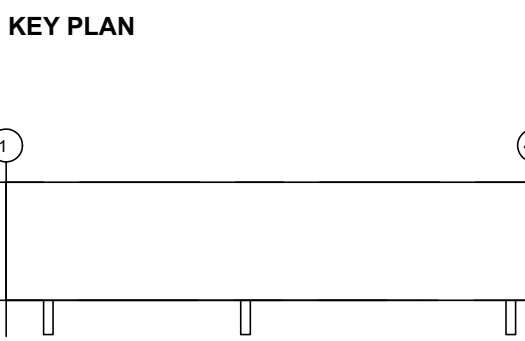

SUBMITTALS		
NO.	DATE	DESCRIPTION
A	05.27.22	ISSUE FOR REVIEW
0	06.10.22	ISSUE FOR PERMIT

PROJECT NO.
AS286-21/ NY131

DRAWN BY
FXB

SHEET TITLE
**PARTIAL WAREHOUSE
LIGHTING PLAN**

SHEET NO.

E2.0