


SEE CONTINUATION ON SHEET E2.0


SEE CONTINUATION ON SHEET E2.0

PRINTED ARCHITECT 30" x 42" 3/16/2022 9:40:40 AM

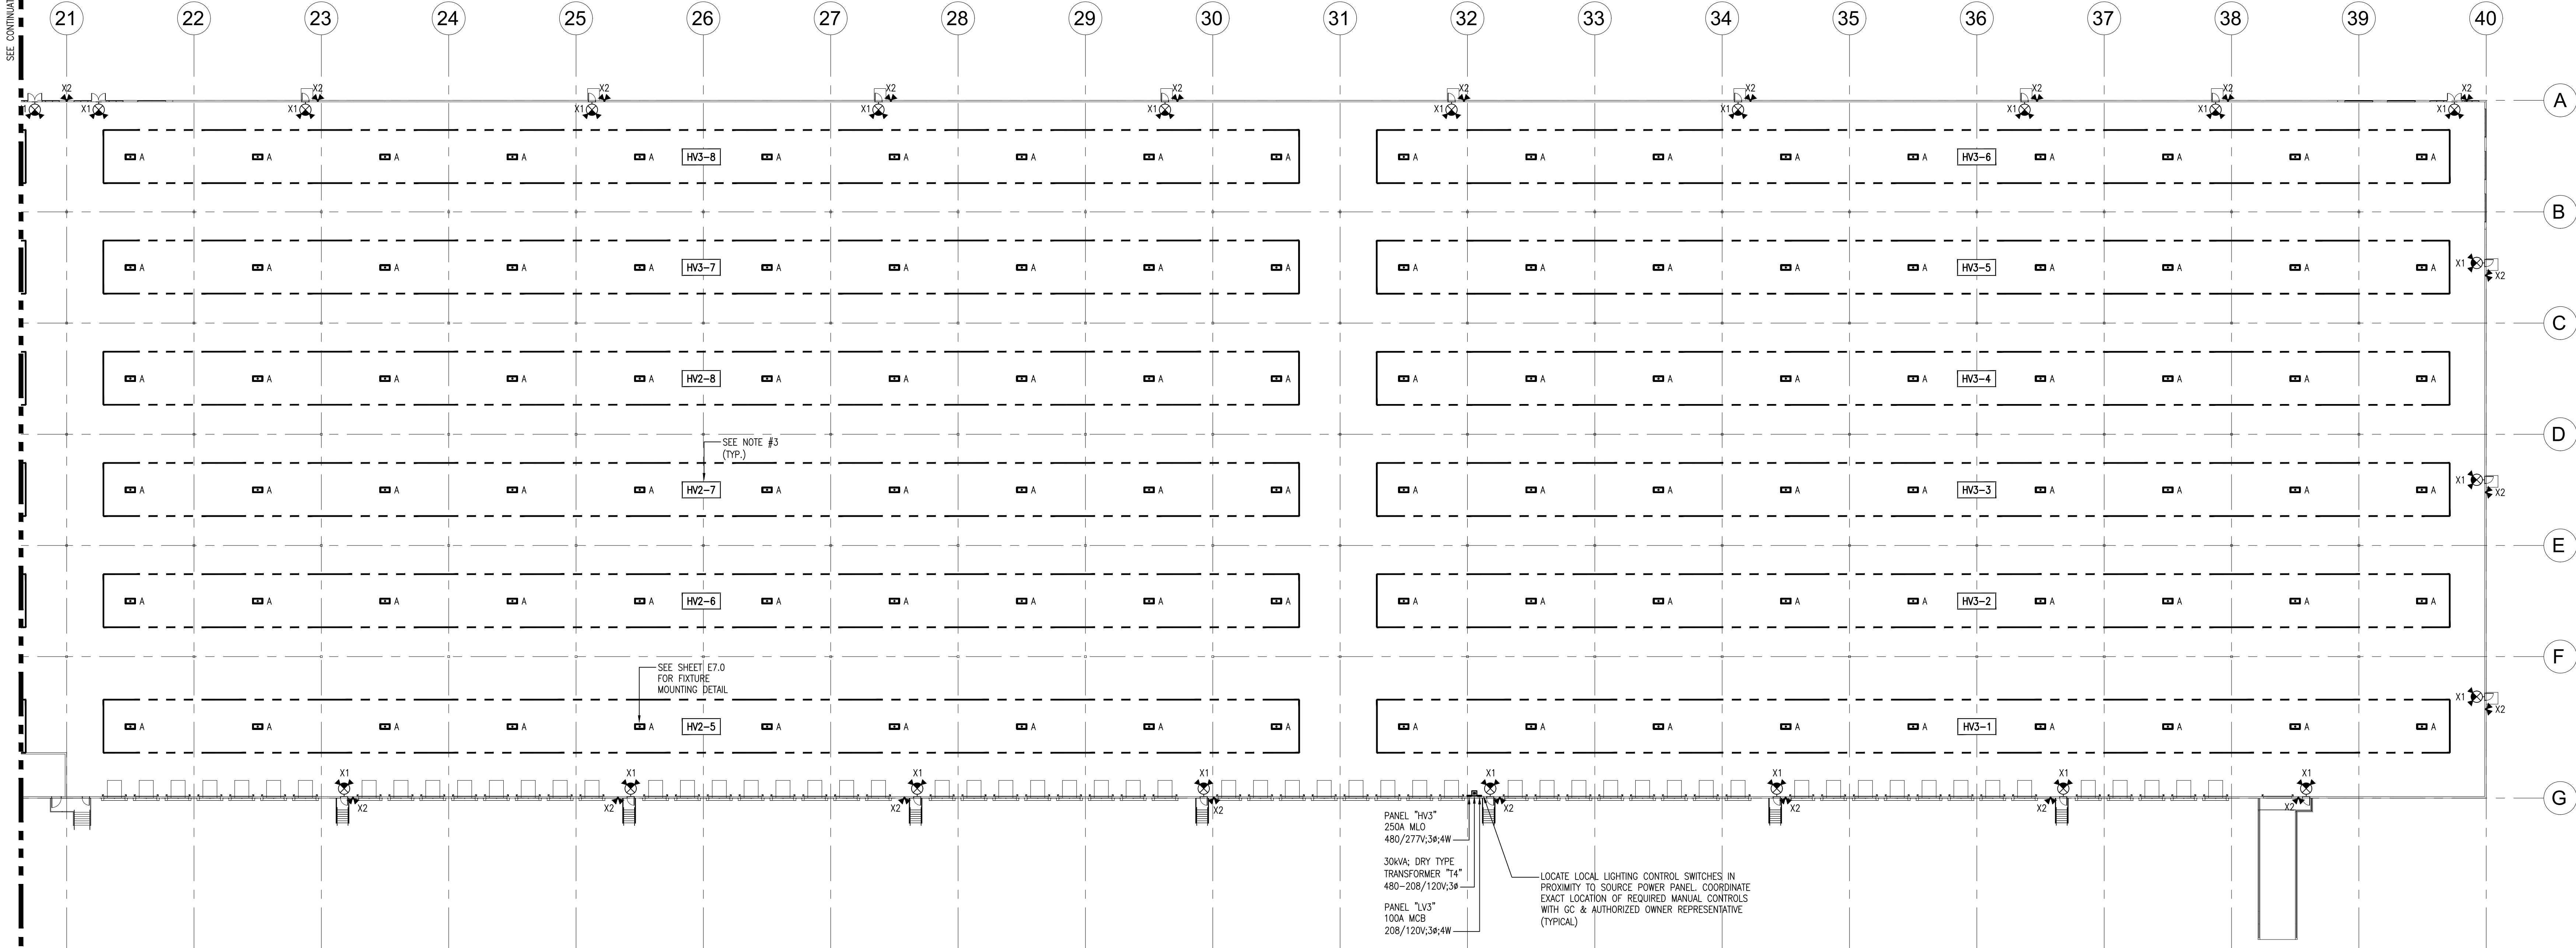

1 E2.1 PARTIAL WAREHOUSE LIGHTING PLAN SCALE: 1" = 30'-0"

- NOTES:
- ALL SHOWN IS NEW & BY EC UNLESS SPECIFICALLY NOTED OTHERWISE
 - ALL EXIT SIGNAGE & EMERGENCY LIGHTING TO BE WIRED TO LOCAL LIGHTING CIRCUIT AND AHEAD OF ALL SWITCHING
 - ALL LIGHTING FIXTURES WITHIN THE SPECIFIED AREA SHALL BE CIRCUITED TO THE CIRCUIT NUMBER(S) INDICATED ON THIS PLAN, UNLESS NOTED OTHERWISE. SEE PANEL SCHEDULES ON DRAWING E6.0 FOR ADDITIONAL INFORMATION.

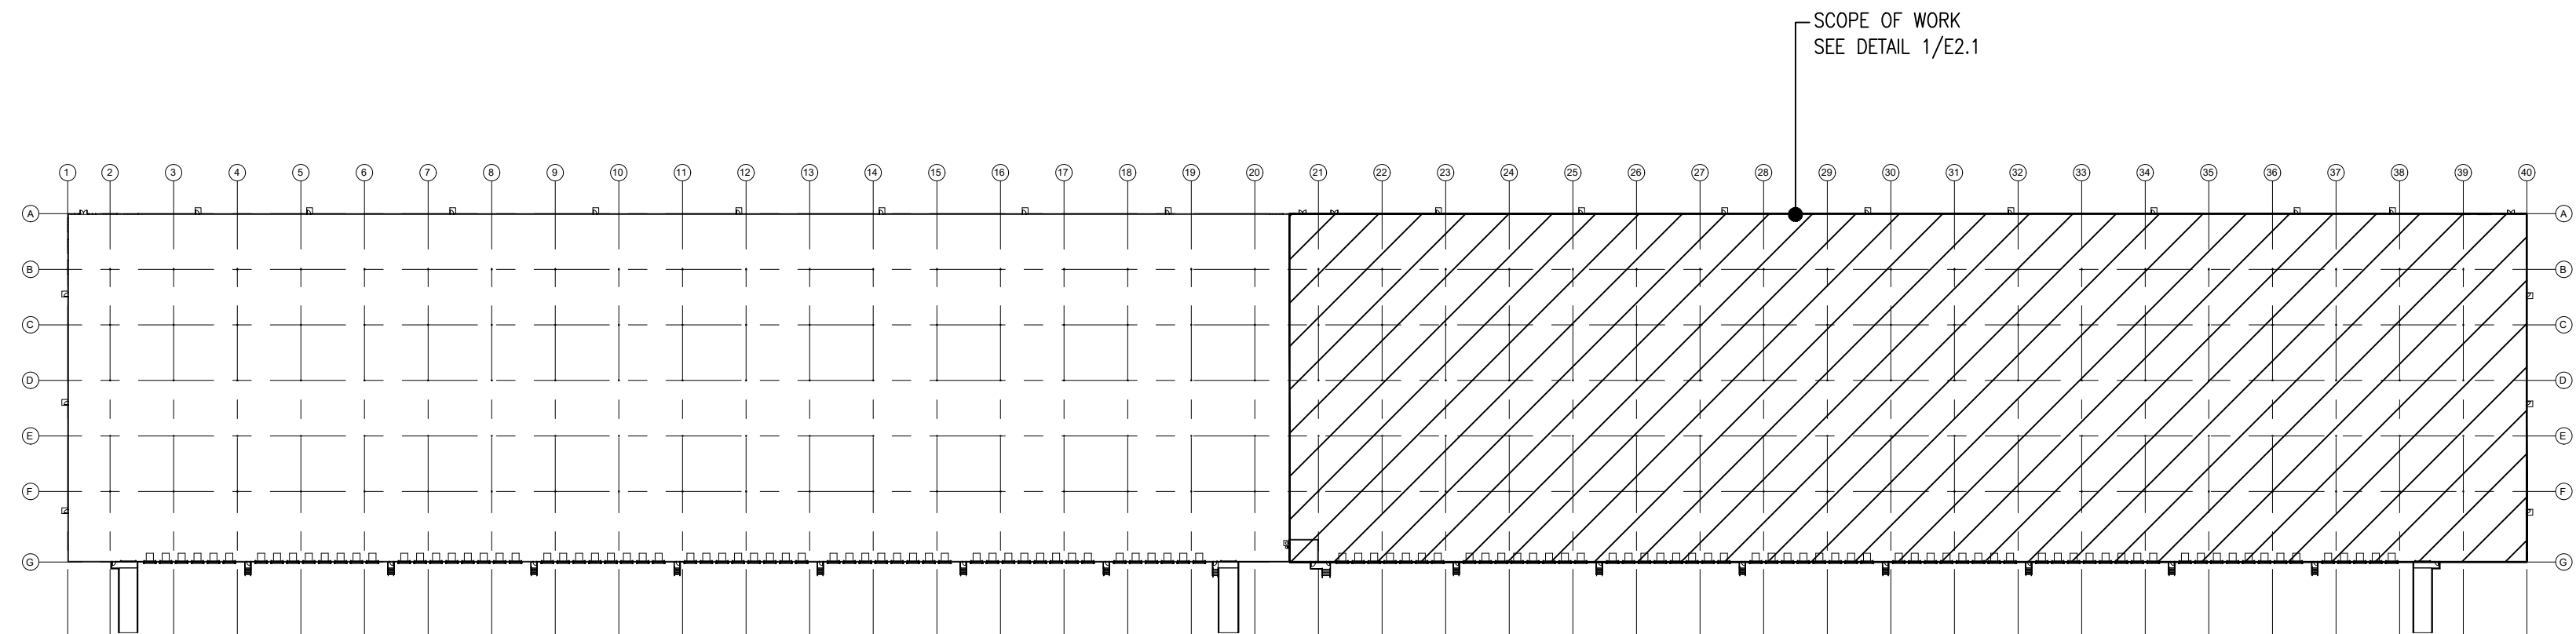

KEYPLAN
SCALE: NONE

DESIGNER / BUILDER

ARCO
DESIGN/BUILD
INDUSTRIAL

44 SOUTH BROADWAY, SUITE 1003
WHITE PLAINS, NY 10601
P: 914.821.5535 F: 914.306.6010

ADBI / DESIGN
SERVICES

PROJECT TITLE
**LINCOLN
EQUITIES -
NY-312 - ALT.
BLDG B**
NY-312 & PUGSLEY RD,
SOUTHEAST, NY 10509

ARCHITECT
ADBI / DESIGN SERVICES LLC
44 SOUTH BROADWAY, SUITE 1003
WHITE PLAINS, NY 10601

CIVIL ENGINEER
LANGAN ENGINEERING
300 KIMBALL DRIVE
PARSIPPANY, NJ 07054

STRUCTURAL ENGINEER
SMITH/ROBERTS AND ASSOCIATES, INC.
6501 BLUFF RD.
INDIANAPOLIS, INDIANA 46217

MECHANICAL ENGINEER
NATIONAL DESIGN/ BUILD SERVICES
11840 BORMAN DRIVE
ST. LOUIS, MO 63146


ELECTRICAL ENGINEER
FBX ENGINEERING
5 CHRISTY DRIVE, SUITE 307
CHADDS FORD, PA 19317

PLUMBING ENGINEER
MCCARTHY ENGINEERING ASSOCIATES,
INC.
315 EAST SECOND STREET
BOYERTOWN, PA 19512

FIRE PROTECTION ENGINEER
S A COMUNALE CO. INC.
2900 NEWPARK DRIVE
BARBERTON, OH 44203

SEAL

KEY PLAN

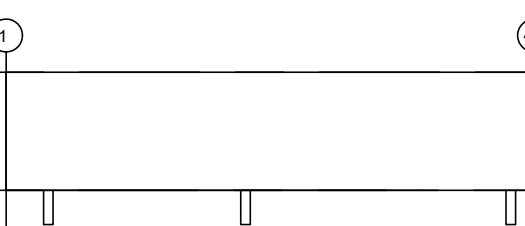

SUBMITTALS

NO.	DATE	DESCRIPTION
A	05.27.22	ISSUE FOR REVIEW
0	06.10.22	ISSUE FOR PERMIT

PROJECT NO.
AS286-21/ NY131

DRAWN BY
FBX

SHEET TITLE
**PARTIAL WAREHOUSE
LIGHTING PLAN**

SHEET NO.

E2.1