


| SUBMITTALS |          |                  |
|------------|----------|------------------|
| NO.        | DATE     | DESCRIPTION      |
| A          | 05.27.22 | ISSUE FOR REVIEW |
| 0          | 06.10.22 | ISSUE FOR PERMIT |


SEE CONTINUATION ON SHEET E3.0

SEE CONTINUATION ON SHEET E3.0

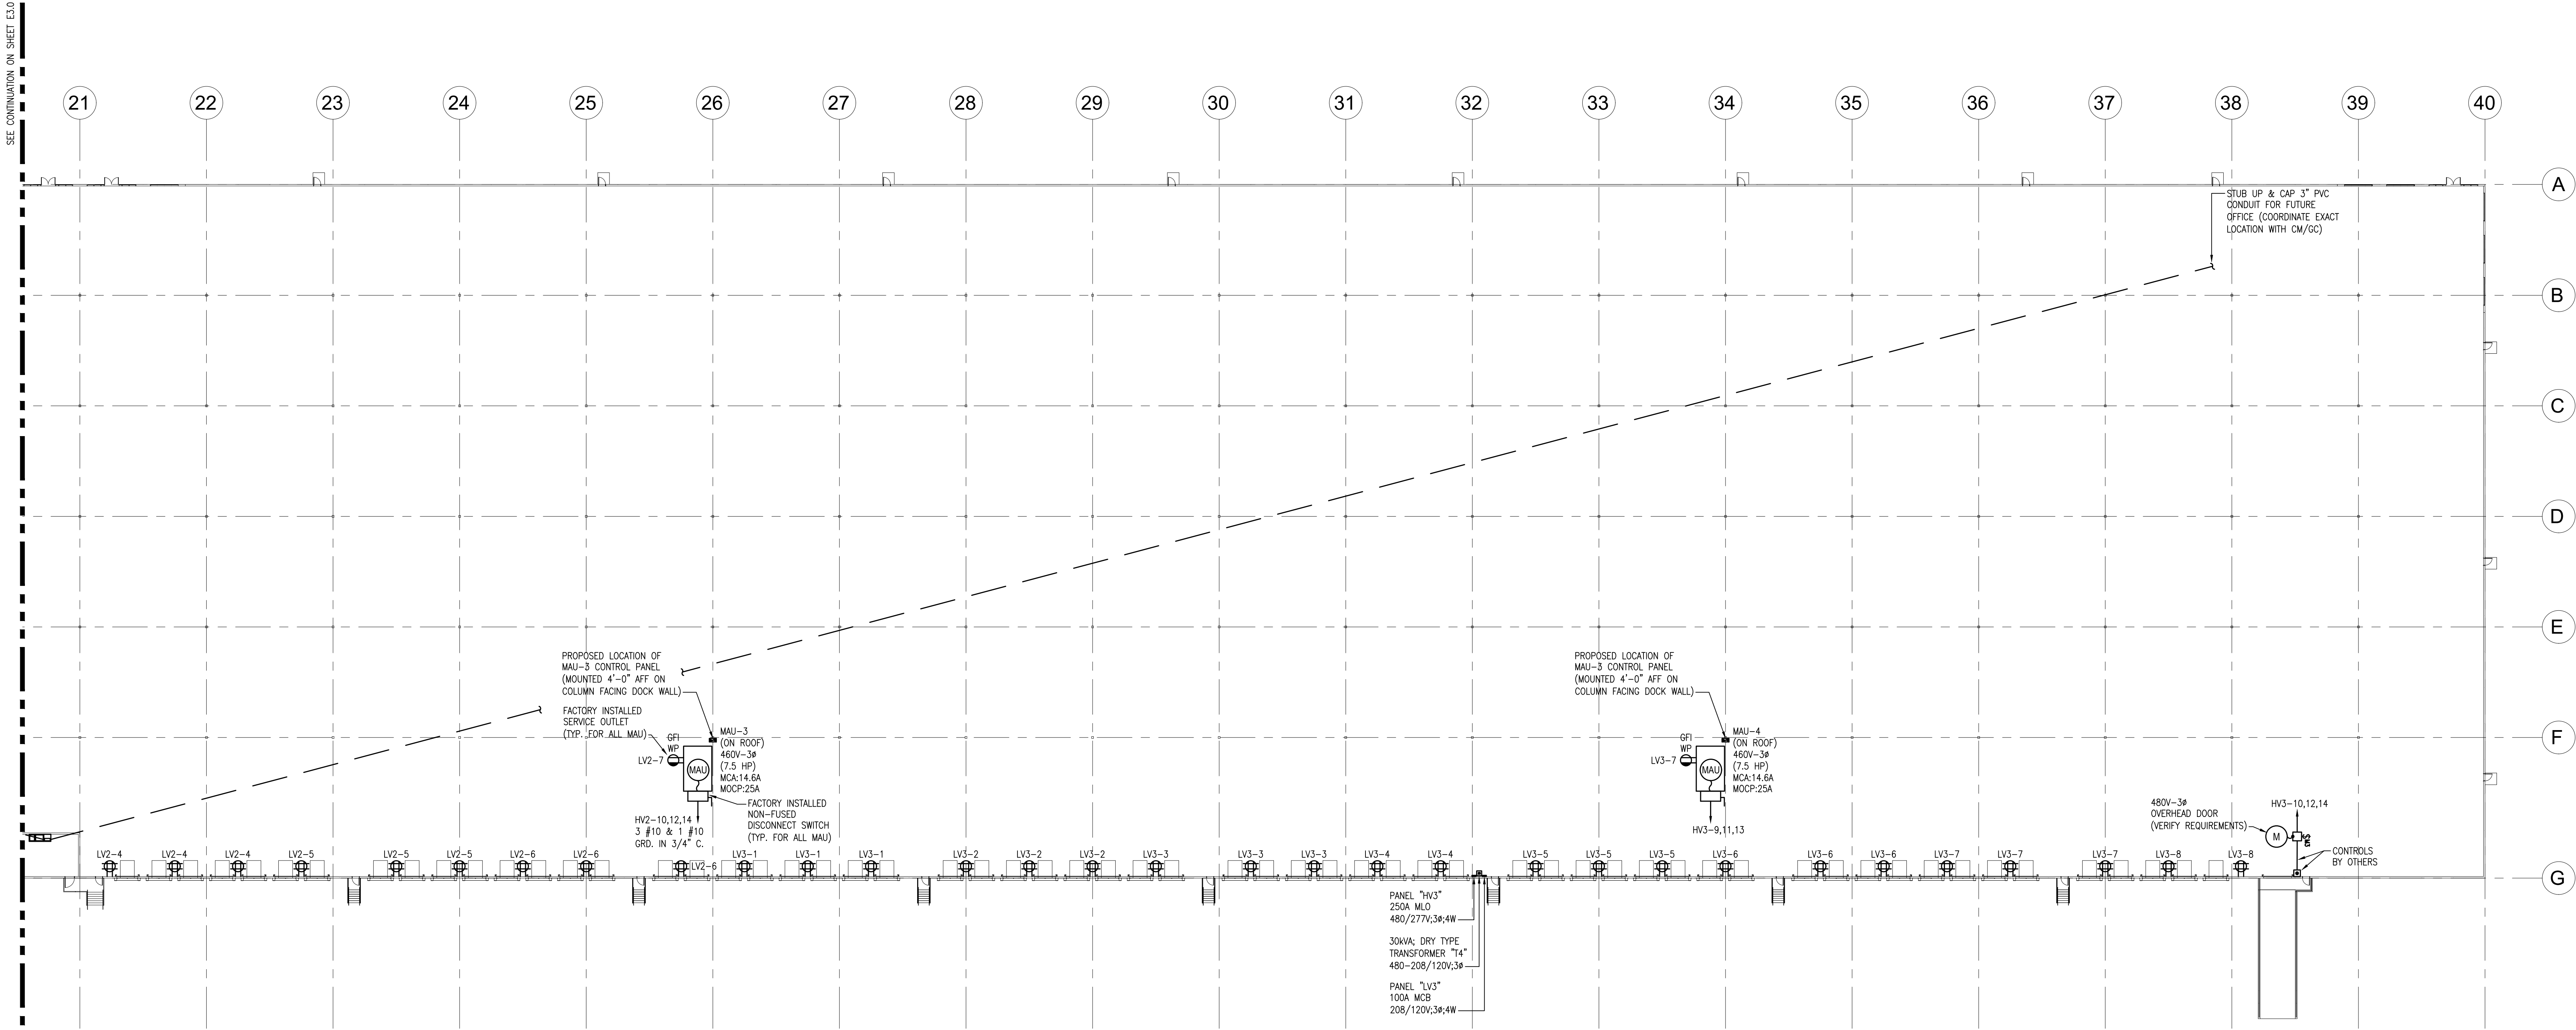

1  
E3.1 PARTIAL WAREHOUSE POWER PLAN  
SCALE: 1" = 30'-0"

- NOTES:
- ALL SHOWN IS NEW & BY EC UNLESS SPECIFICALLY NOTED OTHERWISE.
  - E.C. SHALL VERIFY ALL MECHANICAL EQUIPMENT LOCATIONS AND ELECTRICAL REQUIREMENTS WITH MECHANICAL DRAWINGS PRIOR TO INSTALLATION.

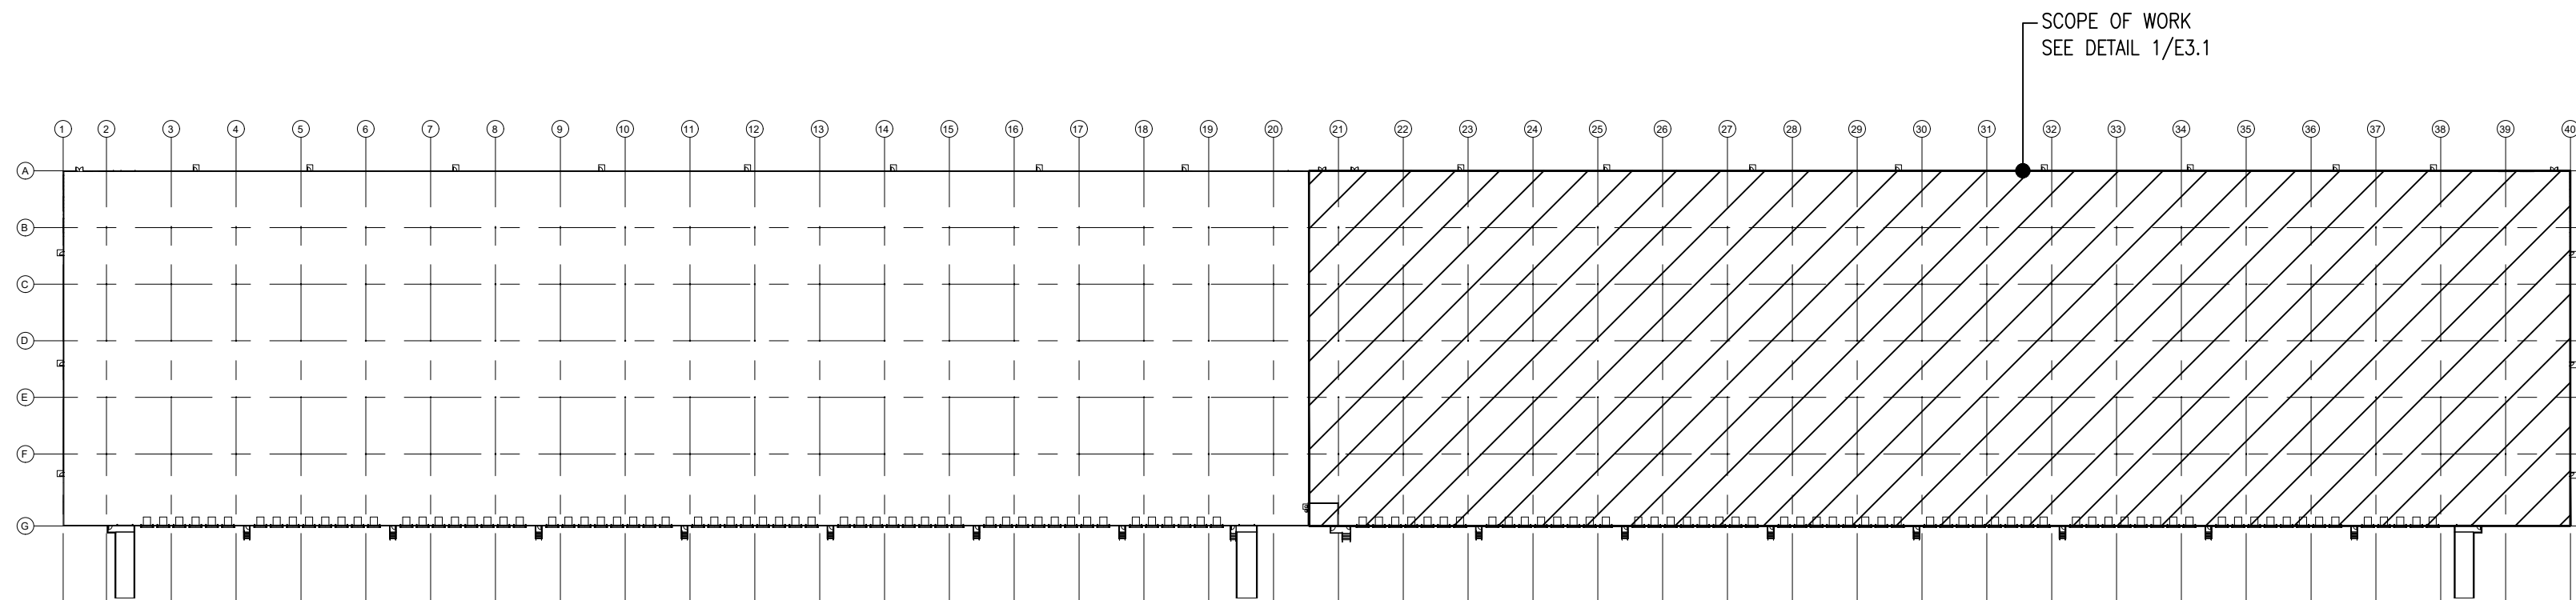

KEYPLAN  
SCALE: NONE