


PENNSYLVANIA STATE PLANE
COORDINATE SYSTEM OF 1983

LEGEND

- PROPOSED FENCE
- UTILITY POLE
- EXISTING 10 FOOT CONTOUR LINE
- EXISTING 2 FOOT CONTOUR LINE
- PROPOSED 10 FOOT CONTOUR LINE
- PROPOSED 2 FOOT CONTOUR LINE
- ELECTRIC LINE
- GAS LINE
- FFE FIRST FLOOR ELEVATION

GENERAL NOTES:

- THE DIESEL TANK(S) FOR THE EMERGENCY GENERATOR AND FIRE PUMP SHALL INCLUDE 110% CONTAINMENT OF THE TANK VOLUME(S).
- THE ENTIRE PERIMETER OF THE PUMP BUILDING SITE TO BE ILLUMINATED FOR SECURITY PURPOSES. PROVIDE SHIELDING AS APPLICABLE AND MEET ALL APPLICABLE ORDINANCES RELATED TO LIGHTING.
- PUMP BUILDING DOORS AND ACCESS GATE TO THE SITE SHALL BE LOCKED AT ALL TIMES UNLESS OPERATIONS PERSONNEL ARE ON-SITE. COMMERCIAL GRADE, ONE-SIDED LOCKS TO BE USED ON ALL DOORS. HINGES TO BE PLACED ON THE INTERIOR TO PROTECT THEM FROM VANDALISM.
- "AUTHORIZED PERSONNEL ONLY" SIGNS ARE TO BE LOCATED AT ALL ENTRANCES TO THE PUMP BUILDING, THE PUMP BUILDING SITE AND THE REMOTE WELL LOCATIONS.

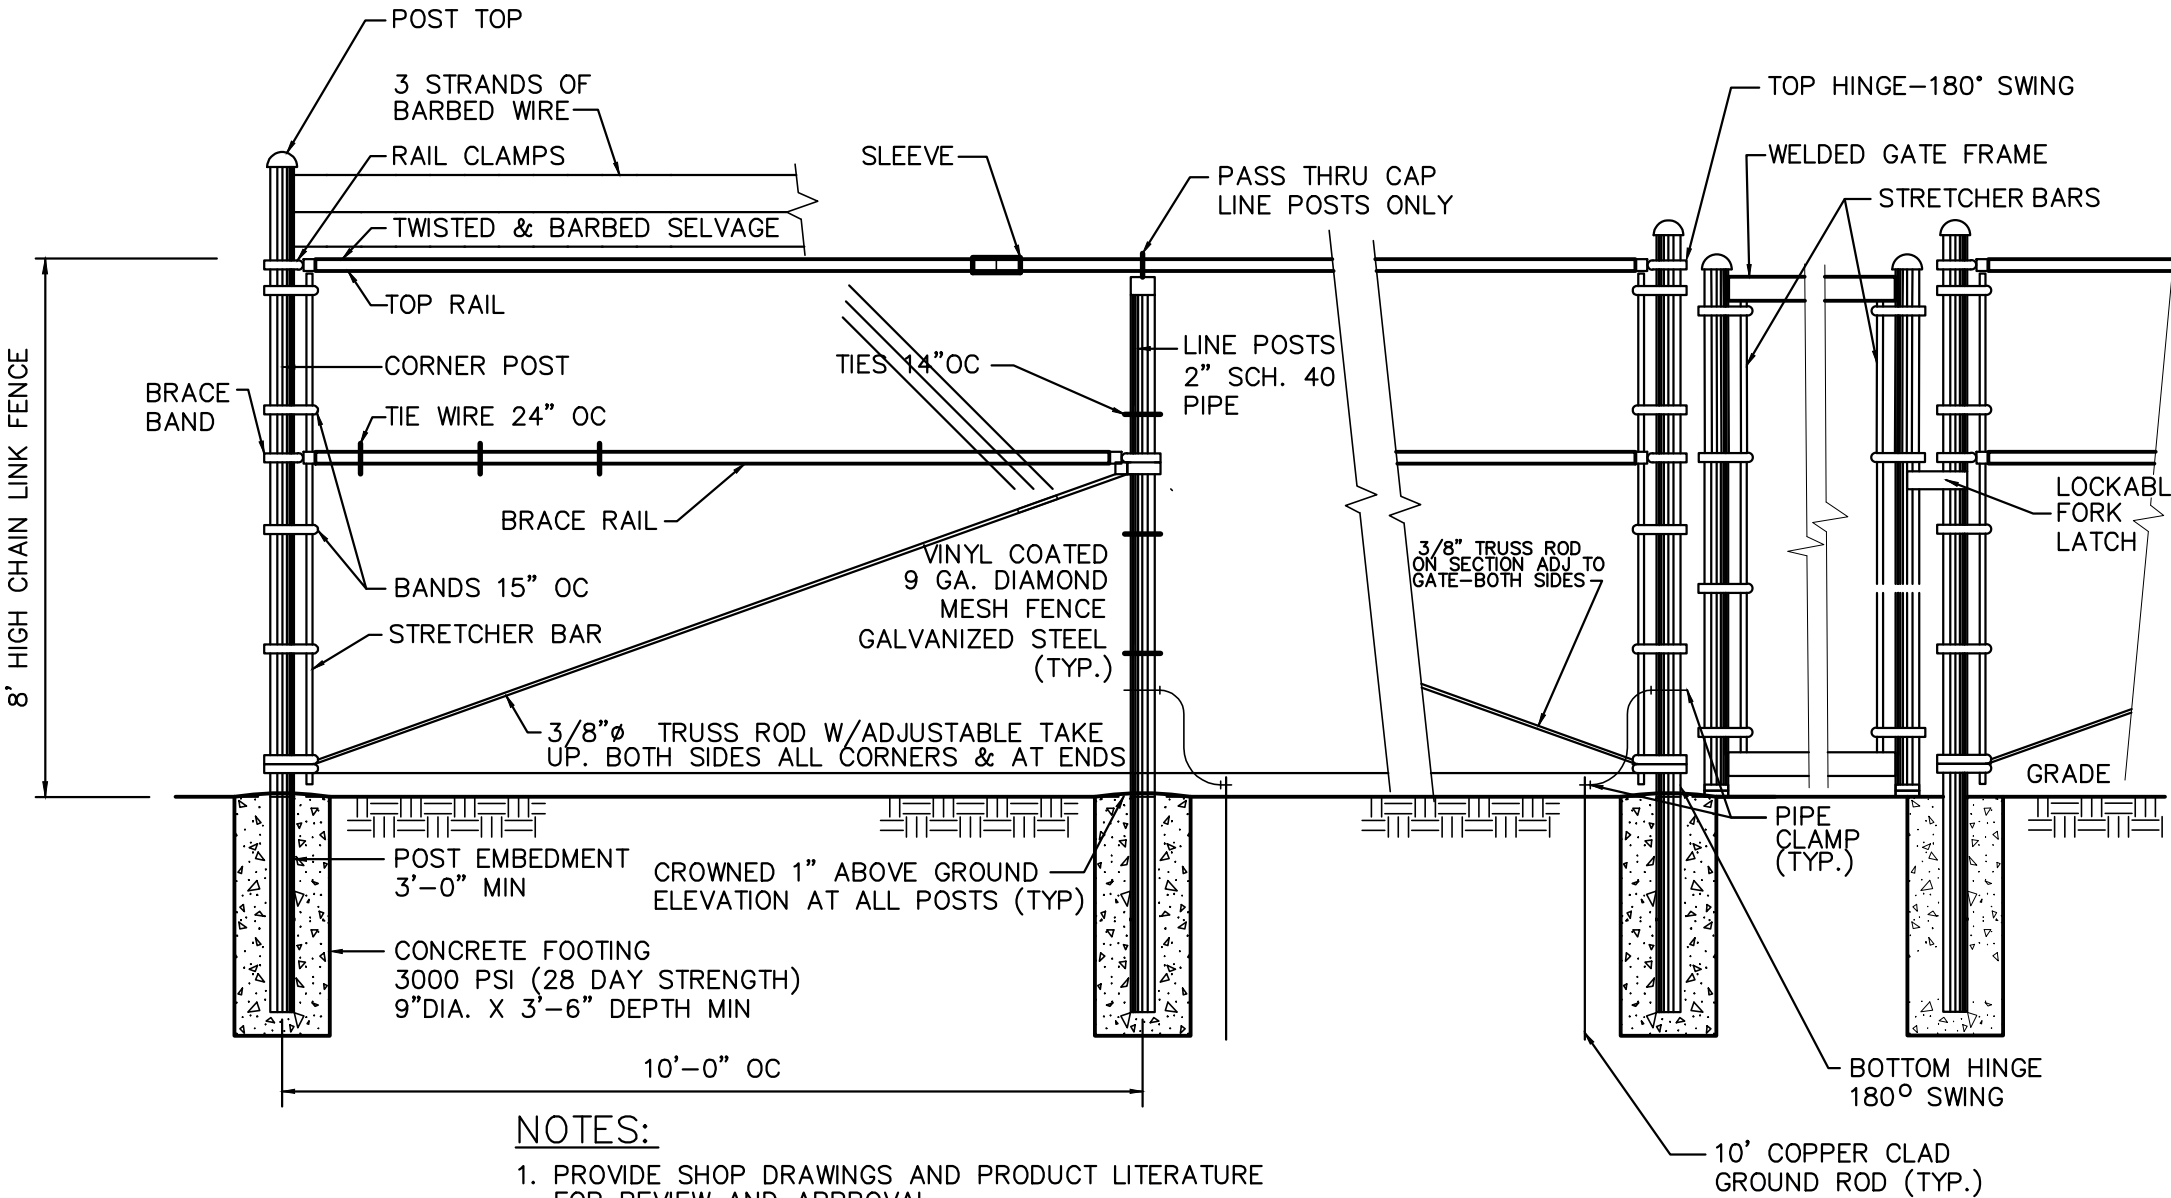

NOTES:

- PROVIDE SHOP DRAWINGS AND PRODUCT LITERATURE FOR REVIEW AND APPROVAL
- ALL FENCE MATERIALS TO HOT-DIPPED GALVANIZED
- CORNER POSTS, GATE POSTS, AND TERMINATION POSTS TO BE 2 1/2\" SCH. 40 PIPE
- GATE FRAMES TO BE 1 1/2\" SCH. 40 PIPE, WITH 1 1/4\" SCH. 40 HORIZONTAL MID-RAIL
- GATE TO HAVE CLASP WITH PROVISIONS FOR PADLOCK HORIZONTAL MID-RAIL
- ALL END, CORNER, ANGLE AND GATE POSTS SHALL BE BRACED
- LINE POSTS SHALL BE BRACED IN BOTH DIRECTIONS AT INTERVALS NOT TO EXCEED 800 FEET
- FENCING AND BARBED WIRE LINE TO BE LOCATED ON THE OUTSIDE OF THE POST TOWARD THE ADJACENT PROPERTY
- ALL POSTS, RAILS, FABRIC AND ACCESSORIES SHALL BE VINYL COATED. COLOR OF VINYL COATING SHALL BE BLACK.

CHAINLINK FENCE DETAIL

NOT TO SCALE

NOTE

PROVIDE SECURITY FENCE AT WELLS OW-3 AND NW-4. (10' X 10' ENCLOSURE W/GATE AT EACH WELL).

NOTES:

SITE INFORMATION AND RELATED INFRASTRUCTURE TAKEN FROM DRAWINGS PREPARED BY JMC. PLEASE REFER TO JMC DWG S-1 FOR MORE INFORMATION.

GENERAL SITE SECURITY IS IN ACCORDANCE WITH THE RECOMMENDATIONS STANDARDS FOR WATER POLICY STATEMENT ON INFRASTRUCTURE SECURITY FOR PUBLIC WATER SUPPLIES AND NYS BUREAU OF WATER SUPPLY PROTECTION.


EACH WELL SHALL HAVE SECURITY FENCE WITH LOCKABLE GATE AND EACH WELLHEAD SHALL BE LOCKED.

DRAWING NOTES:

THE DOCUMENTS CONTAINED HEREIN ARE BEING SUBMITTED FOR APPROVAL BY A PUBLIC AGENCY (OR AGENCIES). THESE DOCUMENTS ARE CONSIDERED PRELIMINARY AND NOT IN FINAL FORM UNTIL THE DOCUMENTS ARE REVIEWED AND APPROVED BY THE APPLICABLE PUBLIC AGENCY (OR AGENCIES). THESE DOCUMENTS MAY BE REVISED TO REFLECT RESOLUTION OF COMMENTS BY ANY AGENCY PRIOR TO FINAL ACTION BY THE AGENCY (OR AGENCIES). ADDITIONAL SUBMISSIONS OF THESE DOCUMENTS IS POSSIBLE.

WARNING: IT IS A VIOLATION OF THE STATE REGISTRATION LAW FOR ANY PERSON TO IN ANY WAY ALTER THIS DOCUMENT BEARING THE SEAL OF A PROFESSIONAL ENGINEER, UNLESS THAT PERSON IS ACTING UNDER THE SPECIFIC DIRECTION OF THE LICENSED PROFESSIONAL ENGINEER.

PRELIMINARY-
NOT FOR
CONSTRUCTION

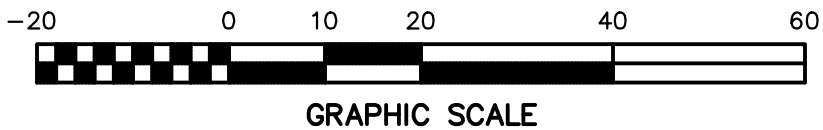

REV.	DESCRIPTION	BY	DATE	APP'D.	SEAL
2	PER PLANNING 1/28/22 COMMENTS	KPS	1/28/22		
2	PER NYSDOH 10/21/21 COMMENTS	MPG	11/15/21		
1	PER NYSDOH 7/14/21 COMMENTS	MPG	8/3/21		

MILNES
MILNES ENGINEERING INC.
PLANNING • DESIGNING • ENGINEERING
SURVEYING • CONSTRUCTION SERVICES
12 FREAR HILL ROAD
TUNKHANNOCK, PA 18657
(570) 836-2145

TITLE:			
WATER SUPPLY SITE PLAN AND DETAILS COMMERCIAL CAMPUS AT FIELDS CORNER PUBLIC WATER SUPPLY PERMIT TOWN OF SOUTHEAST, PUTNAM COUNTY, NY			
DRAWN: MPG	DATE: 4/2021	CHK'D:	DATE:
SCALE: AS SHOWN	APP'D:	DATE:	
AUTOCAD FILE	DRAWING NUMBER	REV.	
PROJECT NUMBER E-2121	S-2	3	