



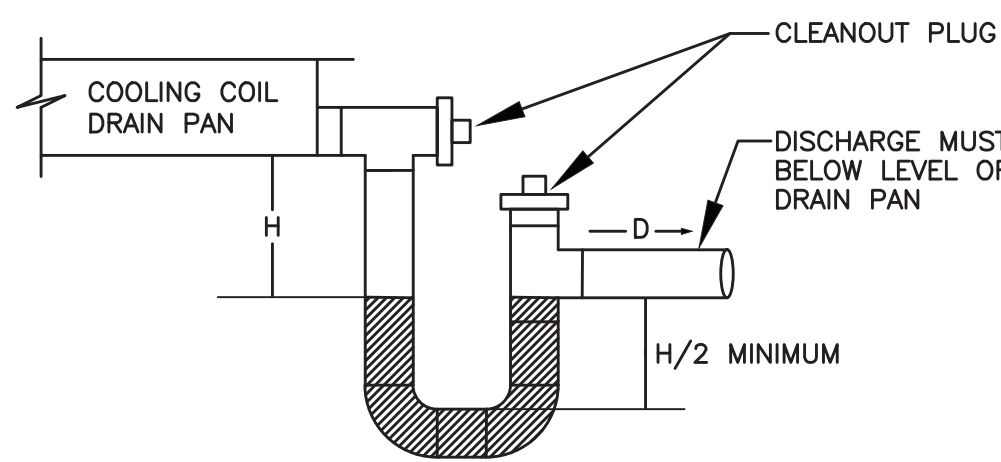


CONDENSATE TRAP DETAIL
DRAW-THRU UNIT
NO SCALE


- NOTES:
1. ALLOW SUFFICIENT SPACE BELOW DRAIN PAN FOR TRAP.
 2. PITCH DRAIN FOR PROPER RUN-OFF.
 3. MANUALLY PRIME FILL TRAP BEFORE START-UP TO FORM INITIAL DRAIN SEAL.
 4. SUPPORT LENGTHY DRAIN LINES TO PREVENT SAG AND CONDENSATE OVERFLOW.
 5. FOR PIPING ON ROOF, ROUTE CONDENSATE PIPING TO WITHIN 5FT OF ROOF DRAIN.

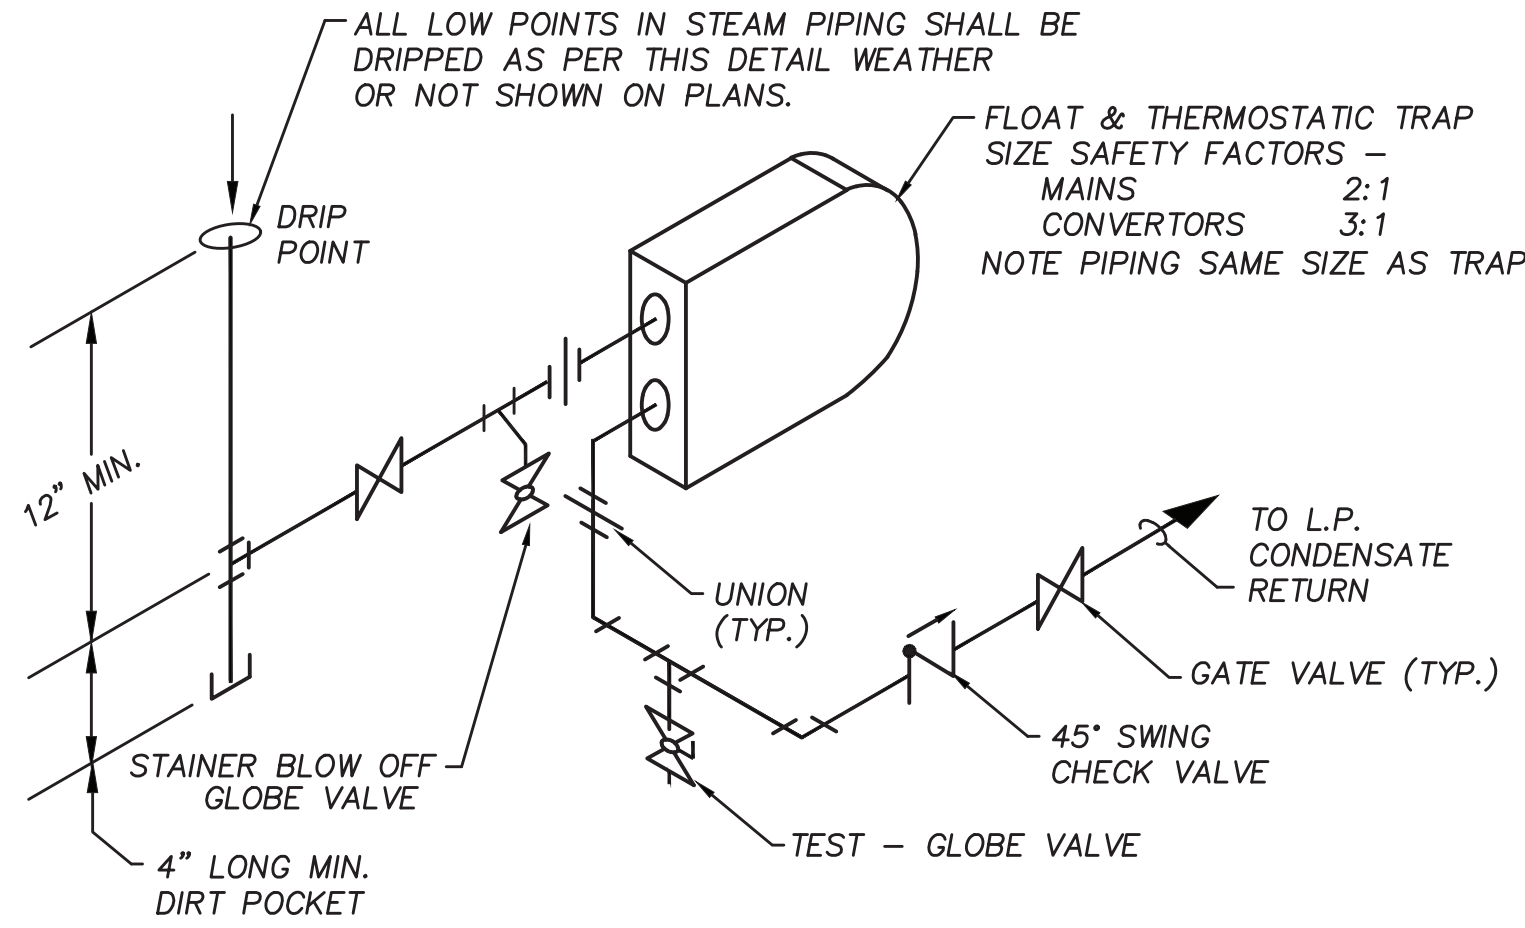


LOW PRESSURE STEAM MAIN DRIP DETAIL
N.T.S.

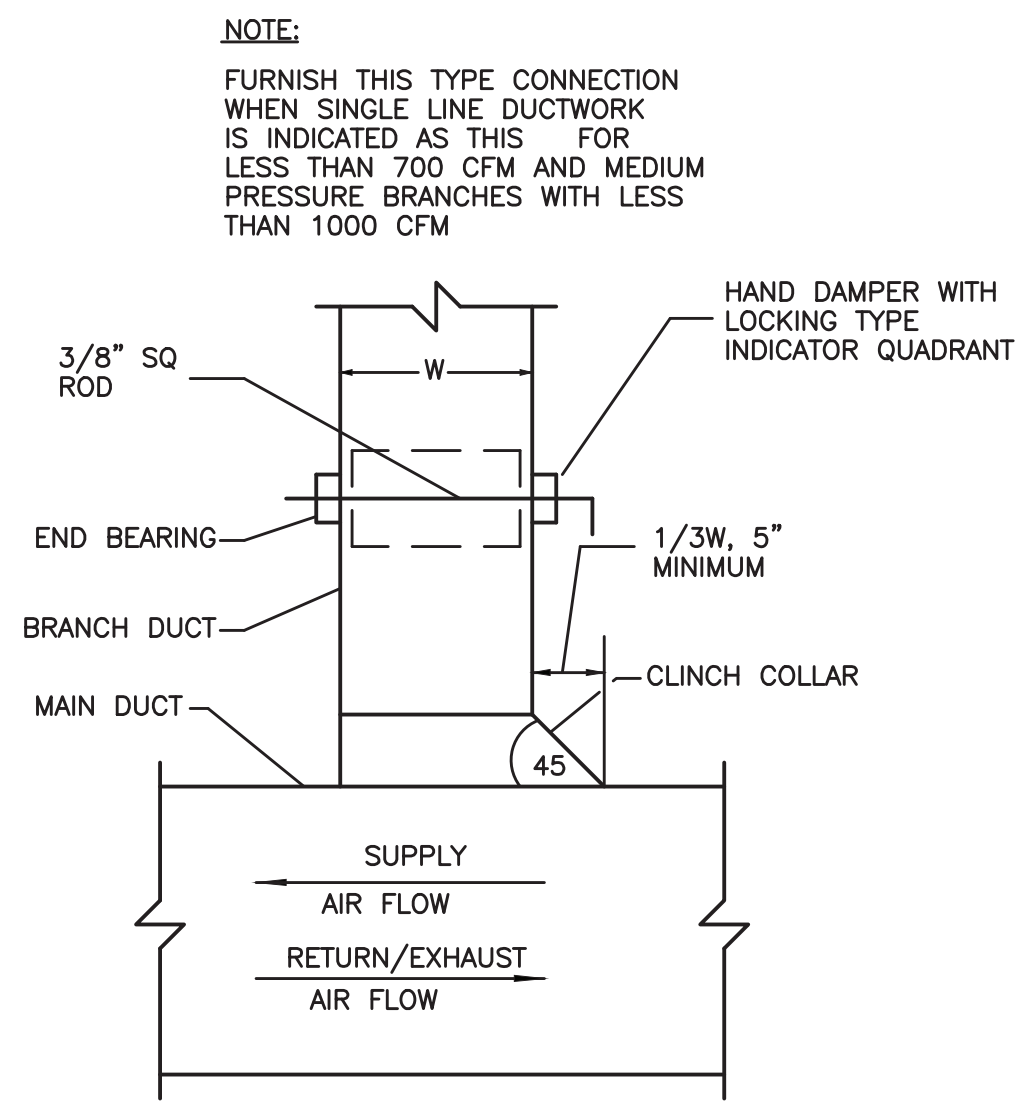


RECTANGULAR DUCT TAP
NO SCALE

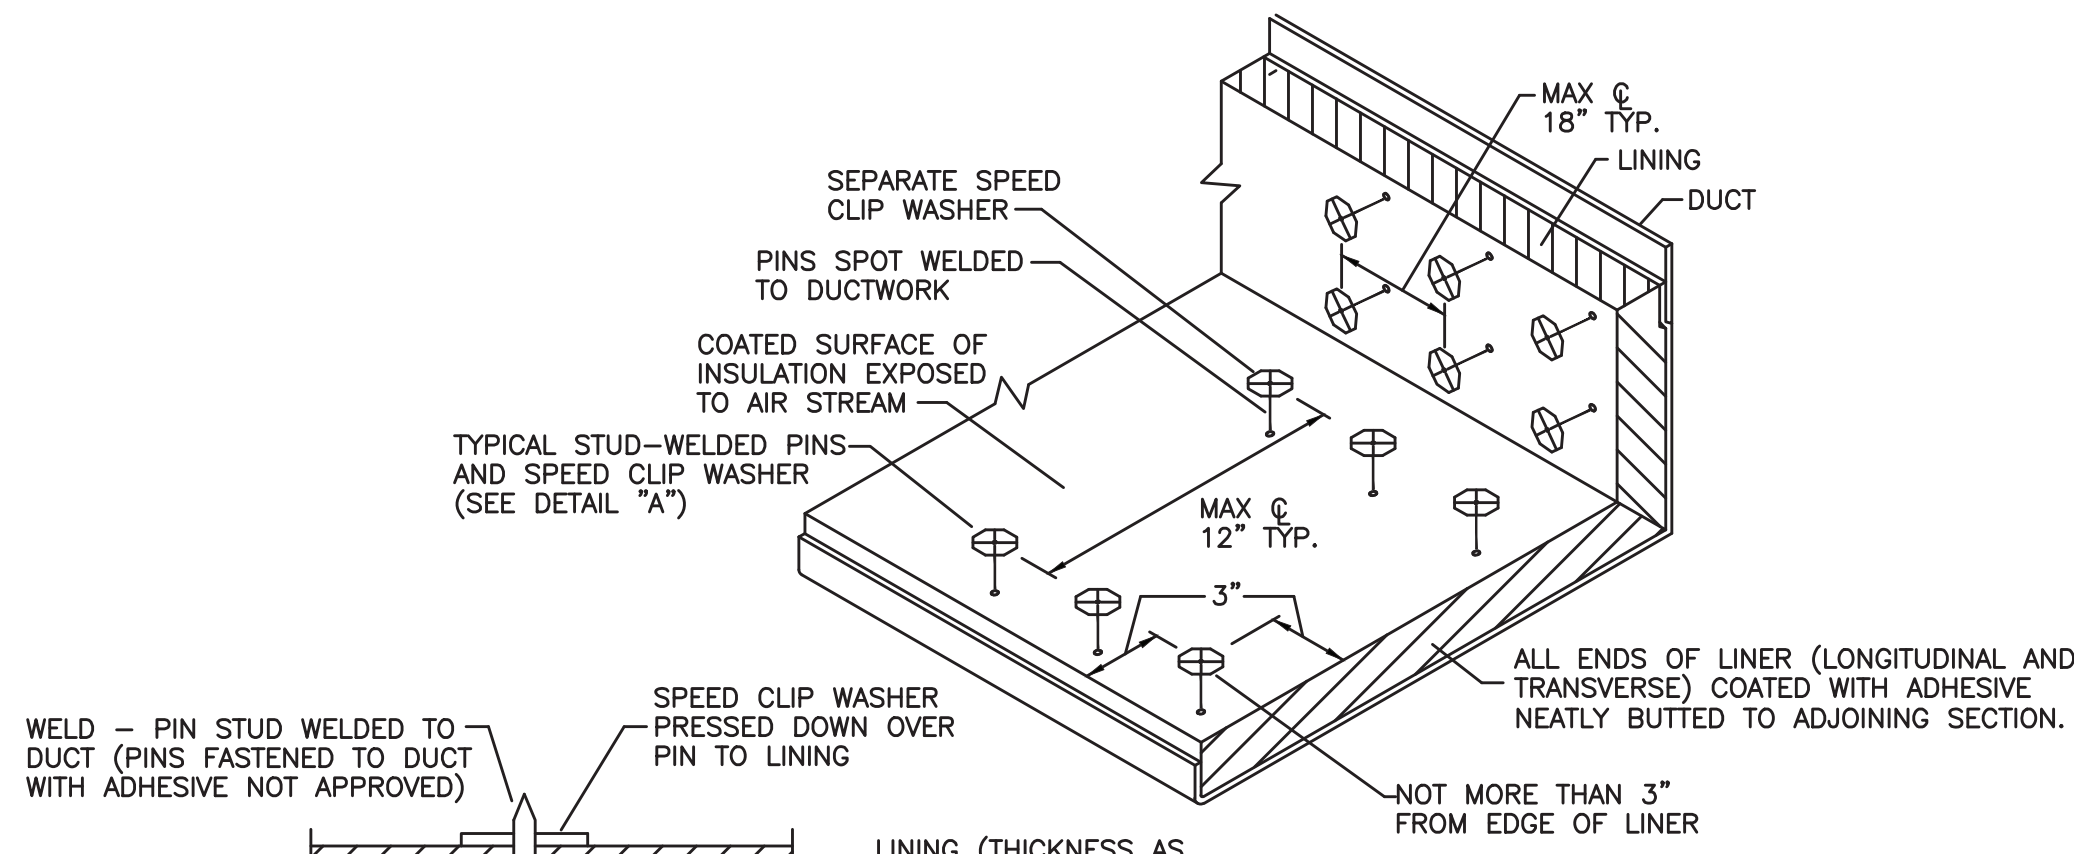

DETAIL 'A'
SOUND LINING INSTALLATION DETAIL
NO SCALE

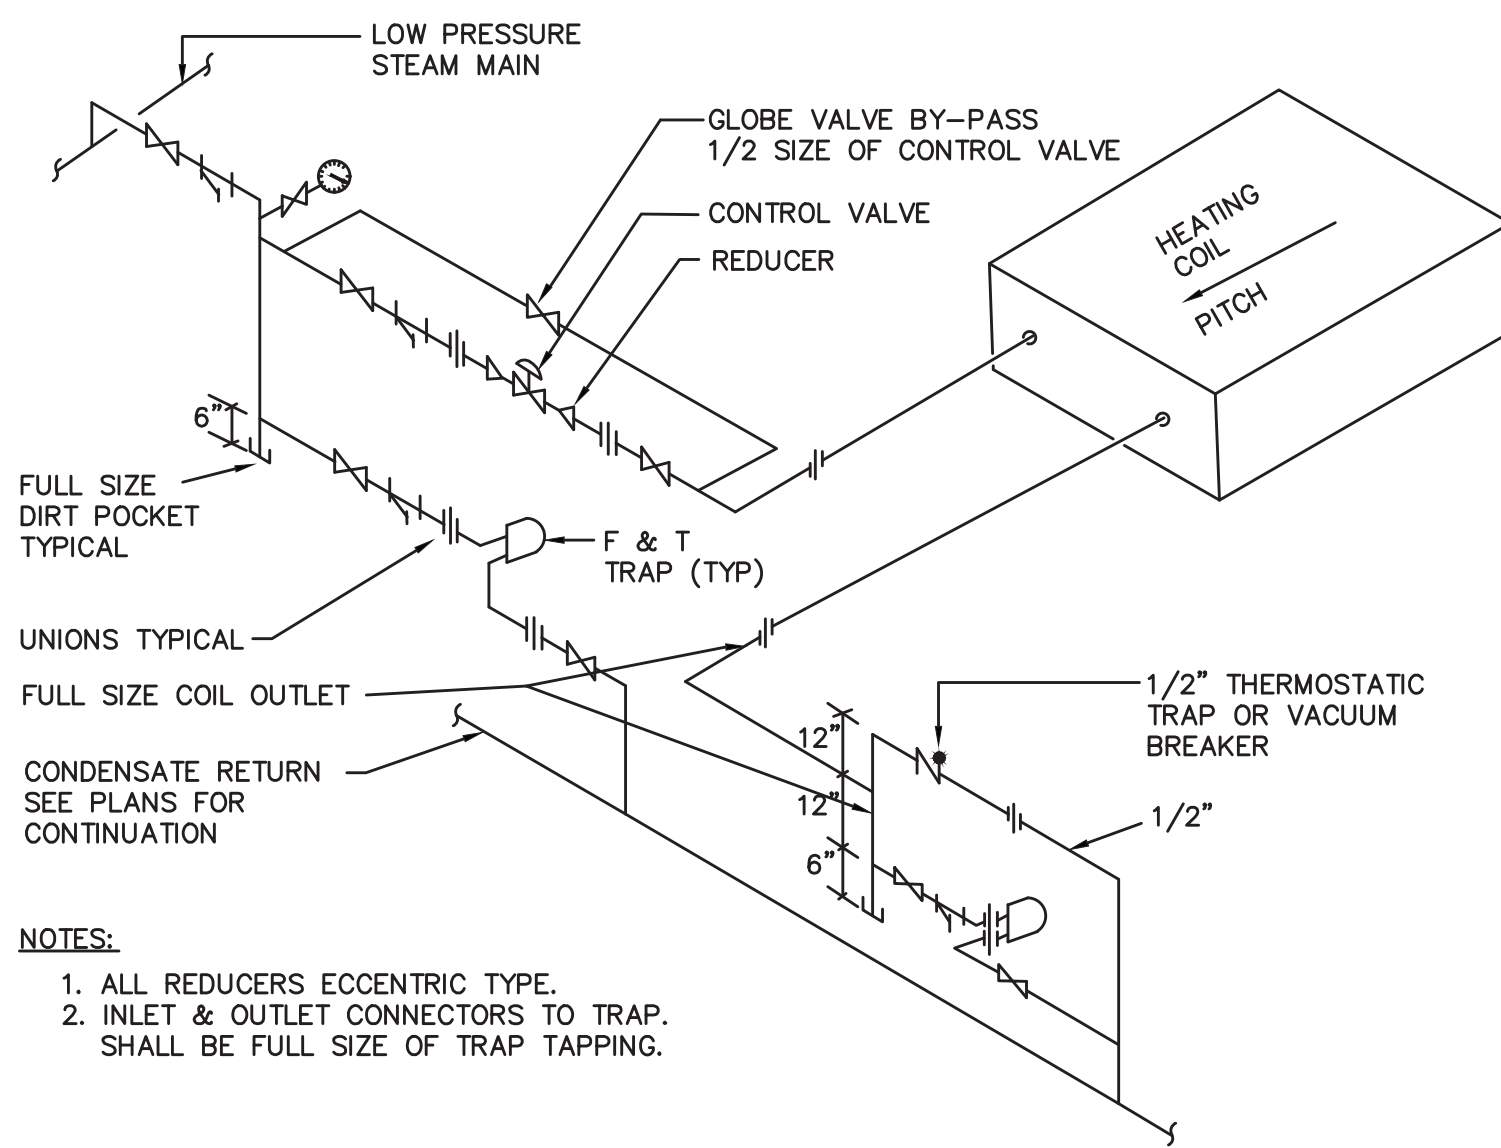


HORIZONTAL STEAM HEATING COIL PIPING
N.T.S.

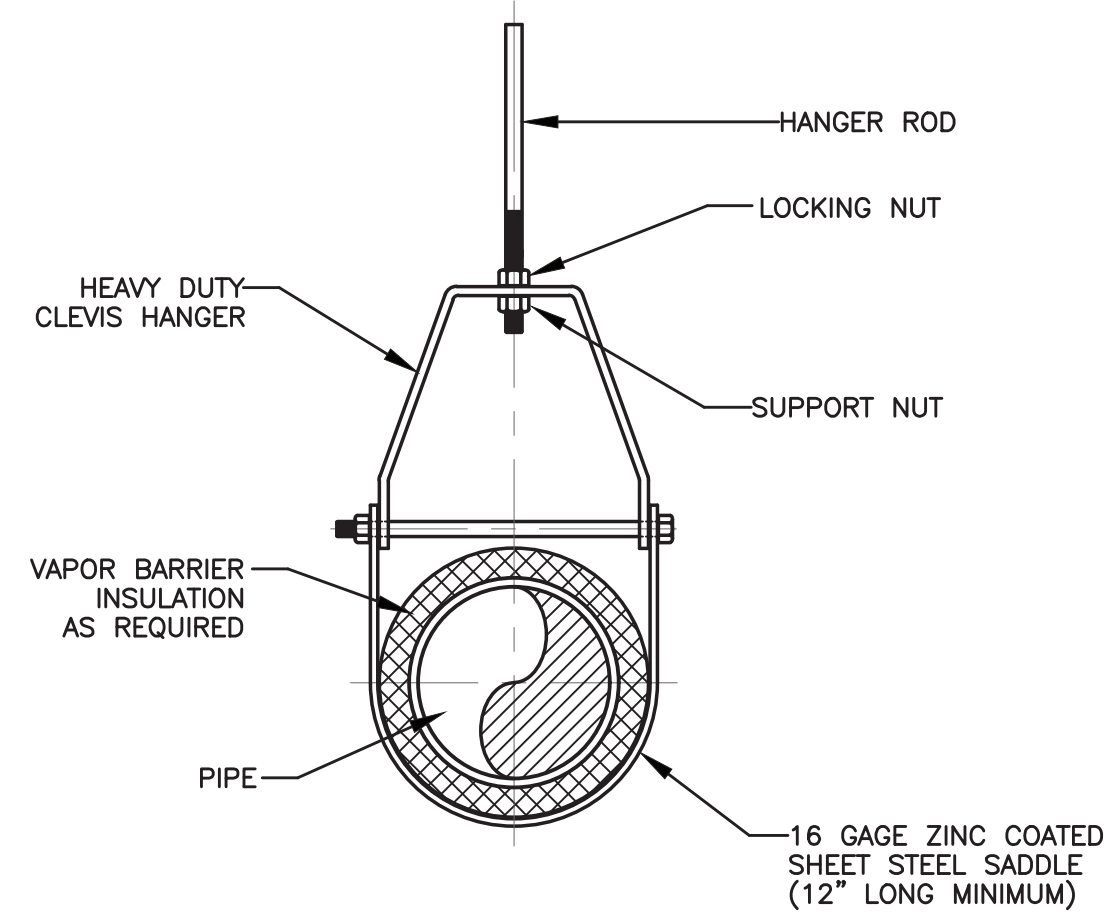


HANGER ROD SCHEDULE			
PIPE SIZE	ROD SIZE	PIPE SIZE	ROD SIZE
UP TO 2"	3/8" DIA.	4" THRU 5"	5/8" DIA.
2 1/2" THRU 3"	1/2" DIA.	6" THRU 12"	7/8" DIA.

CLEVIS HANGER
HORIZONTAL RUNS

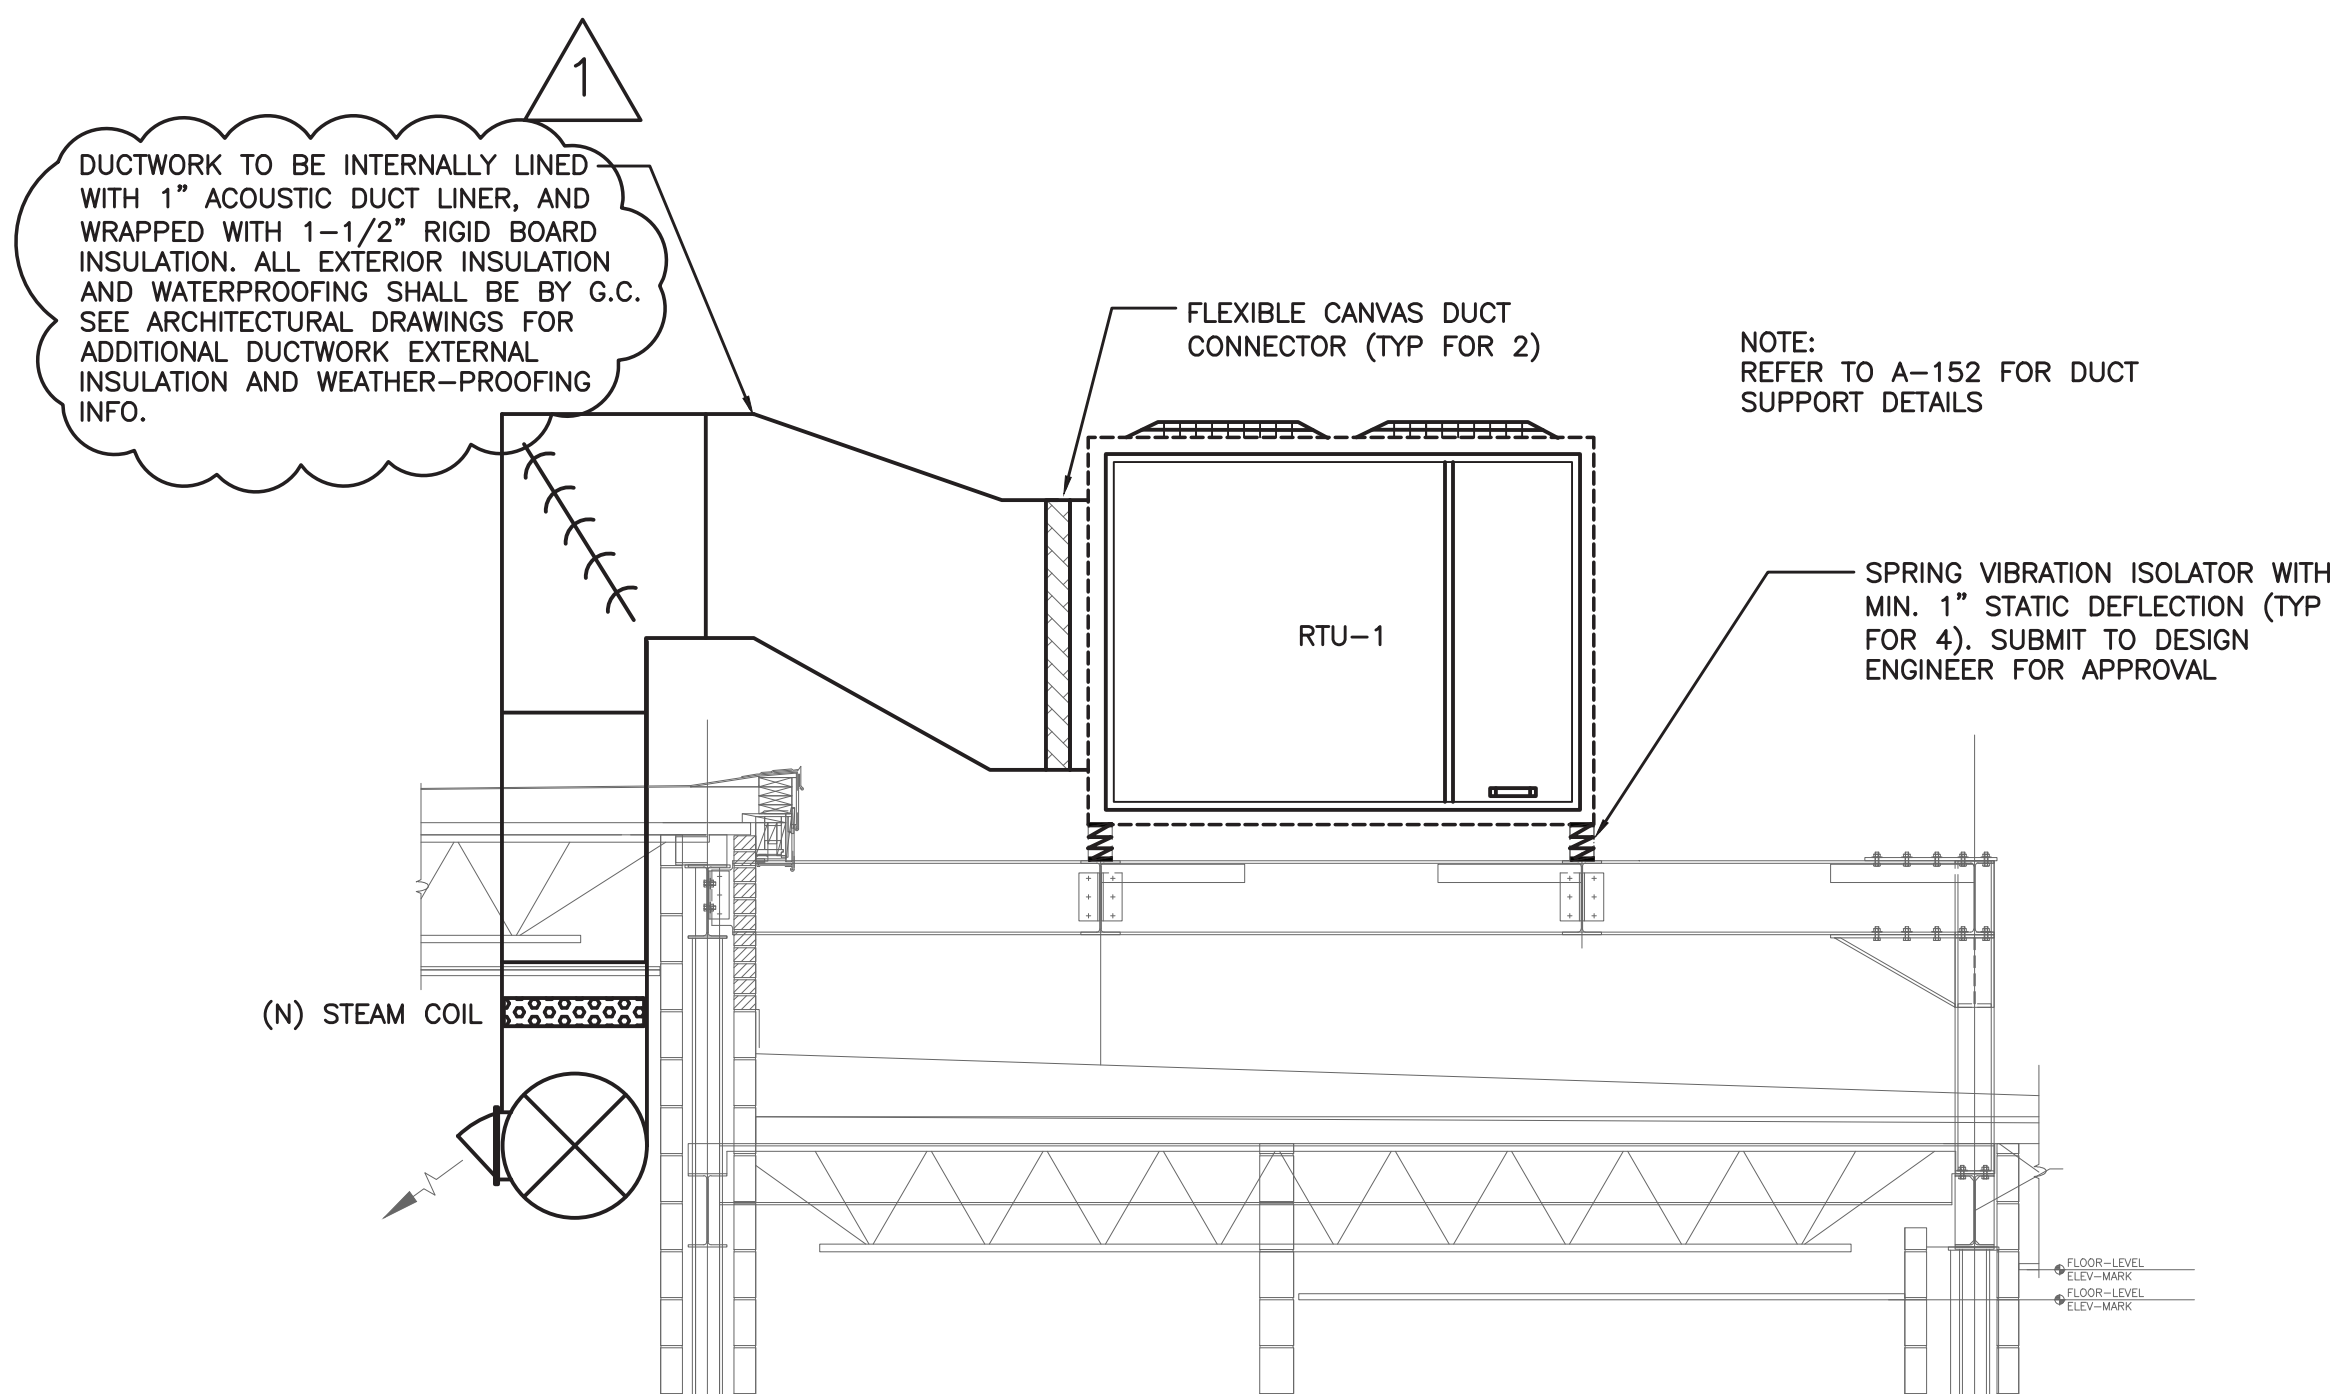


ROOFTOP UNIT INSTALLATION DETAIL
NO SCALE

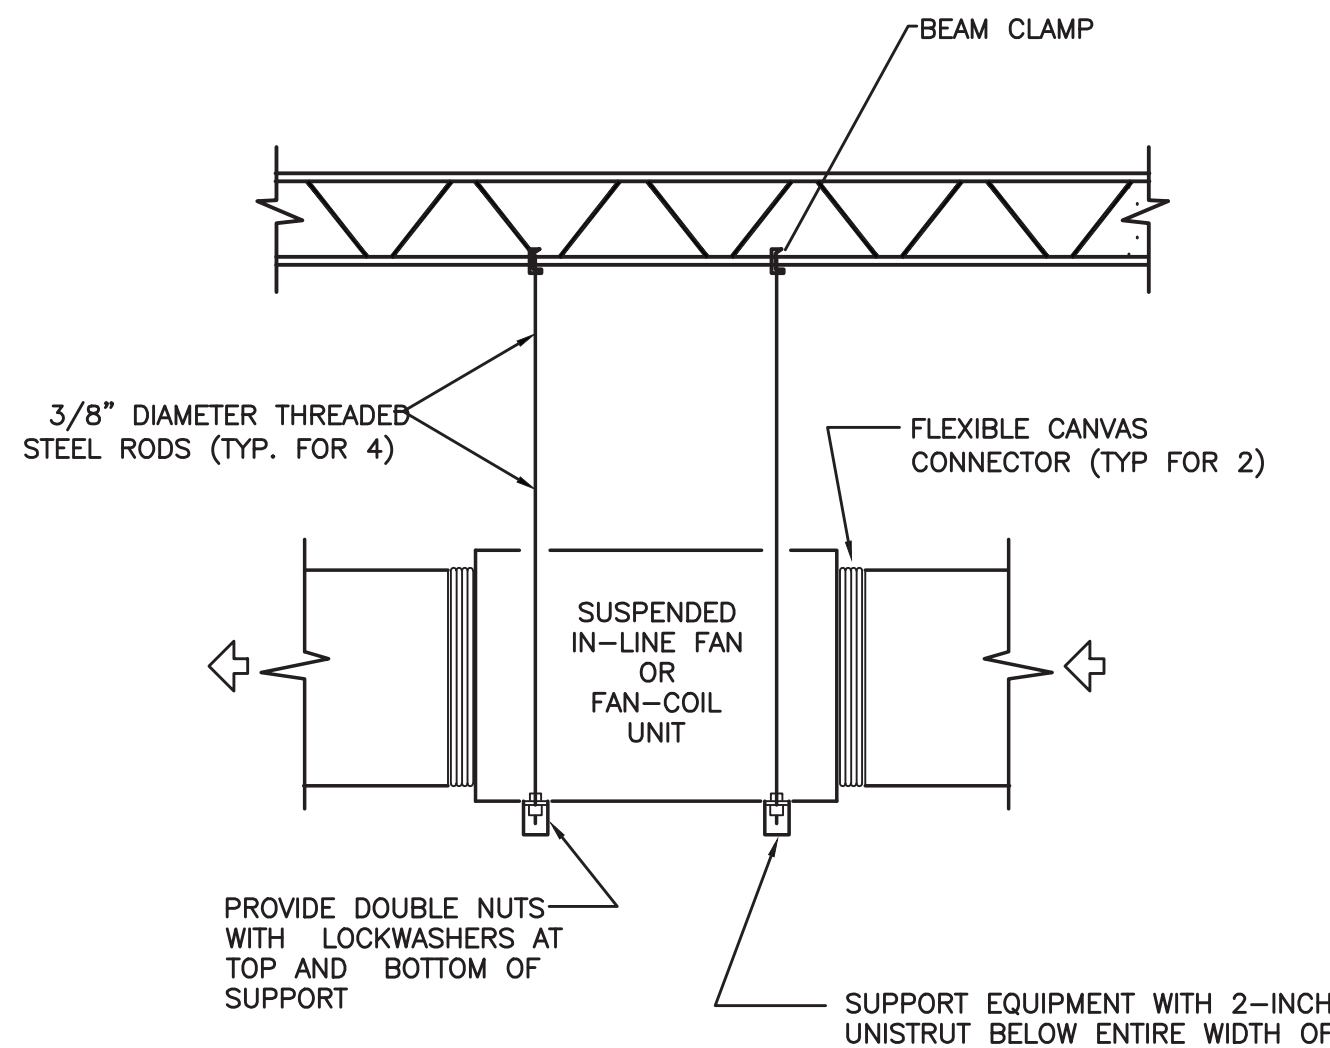


INLINE FAN SUPPORT DETAIL
TYPICAL FOR CEILING-MOUNTED FAN-COIL UNITS
AND EXHAUST FANS
NO SCALE

PLOT DATE: January 24, 2023 -- 10:34am

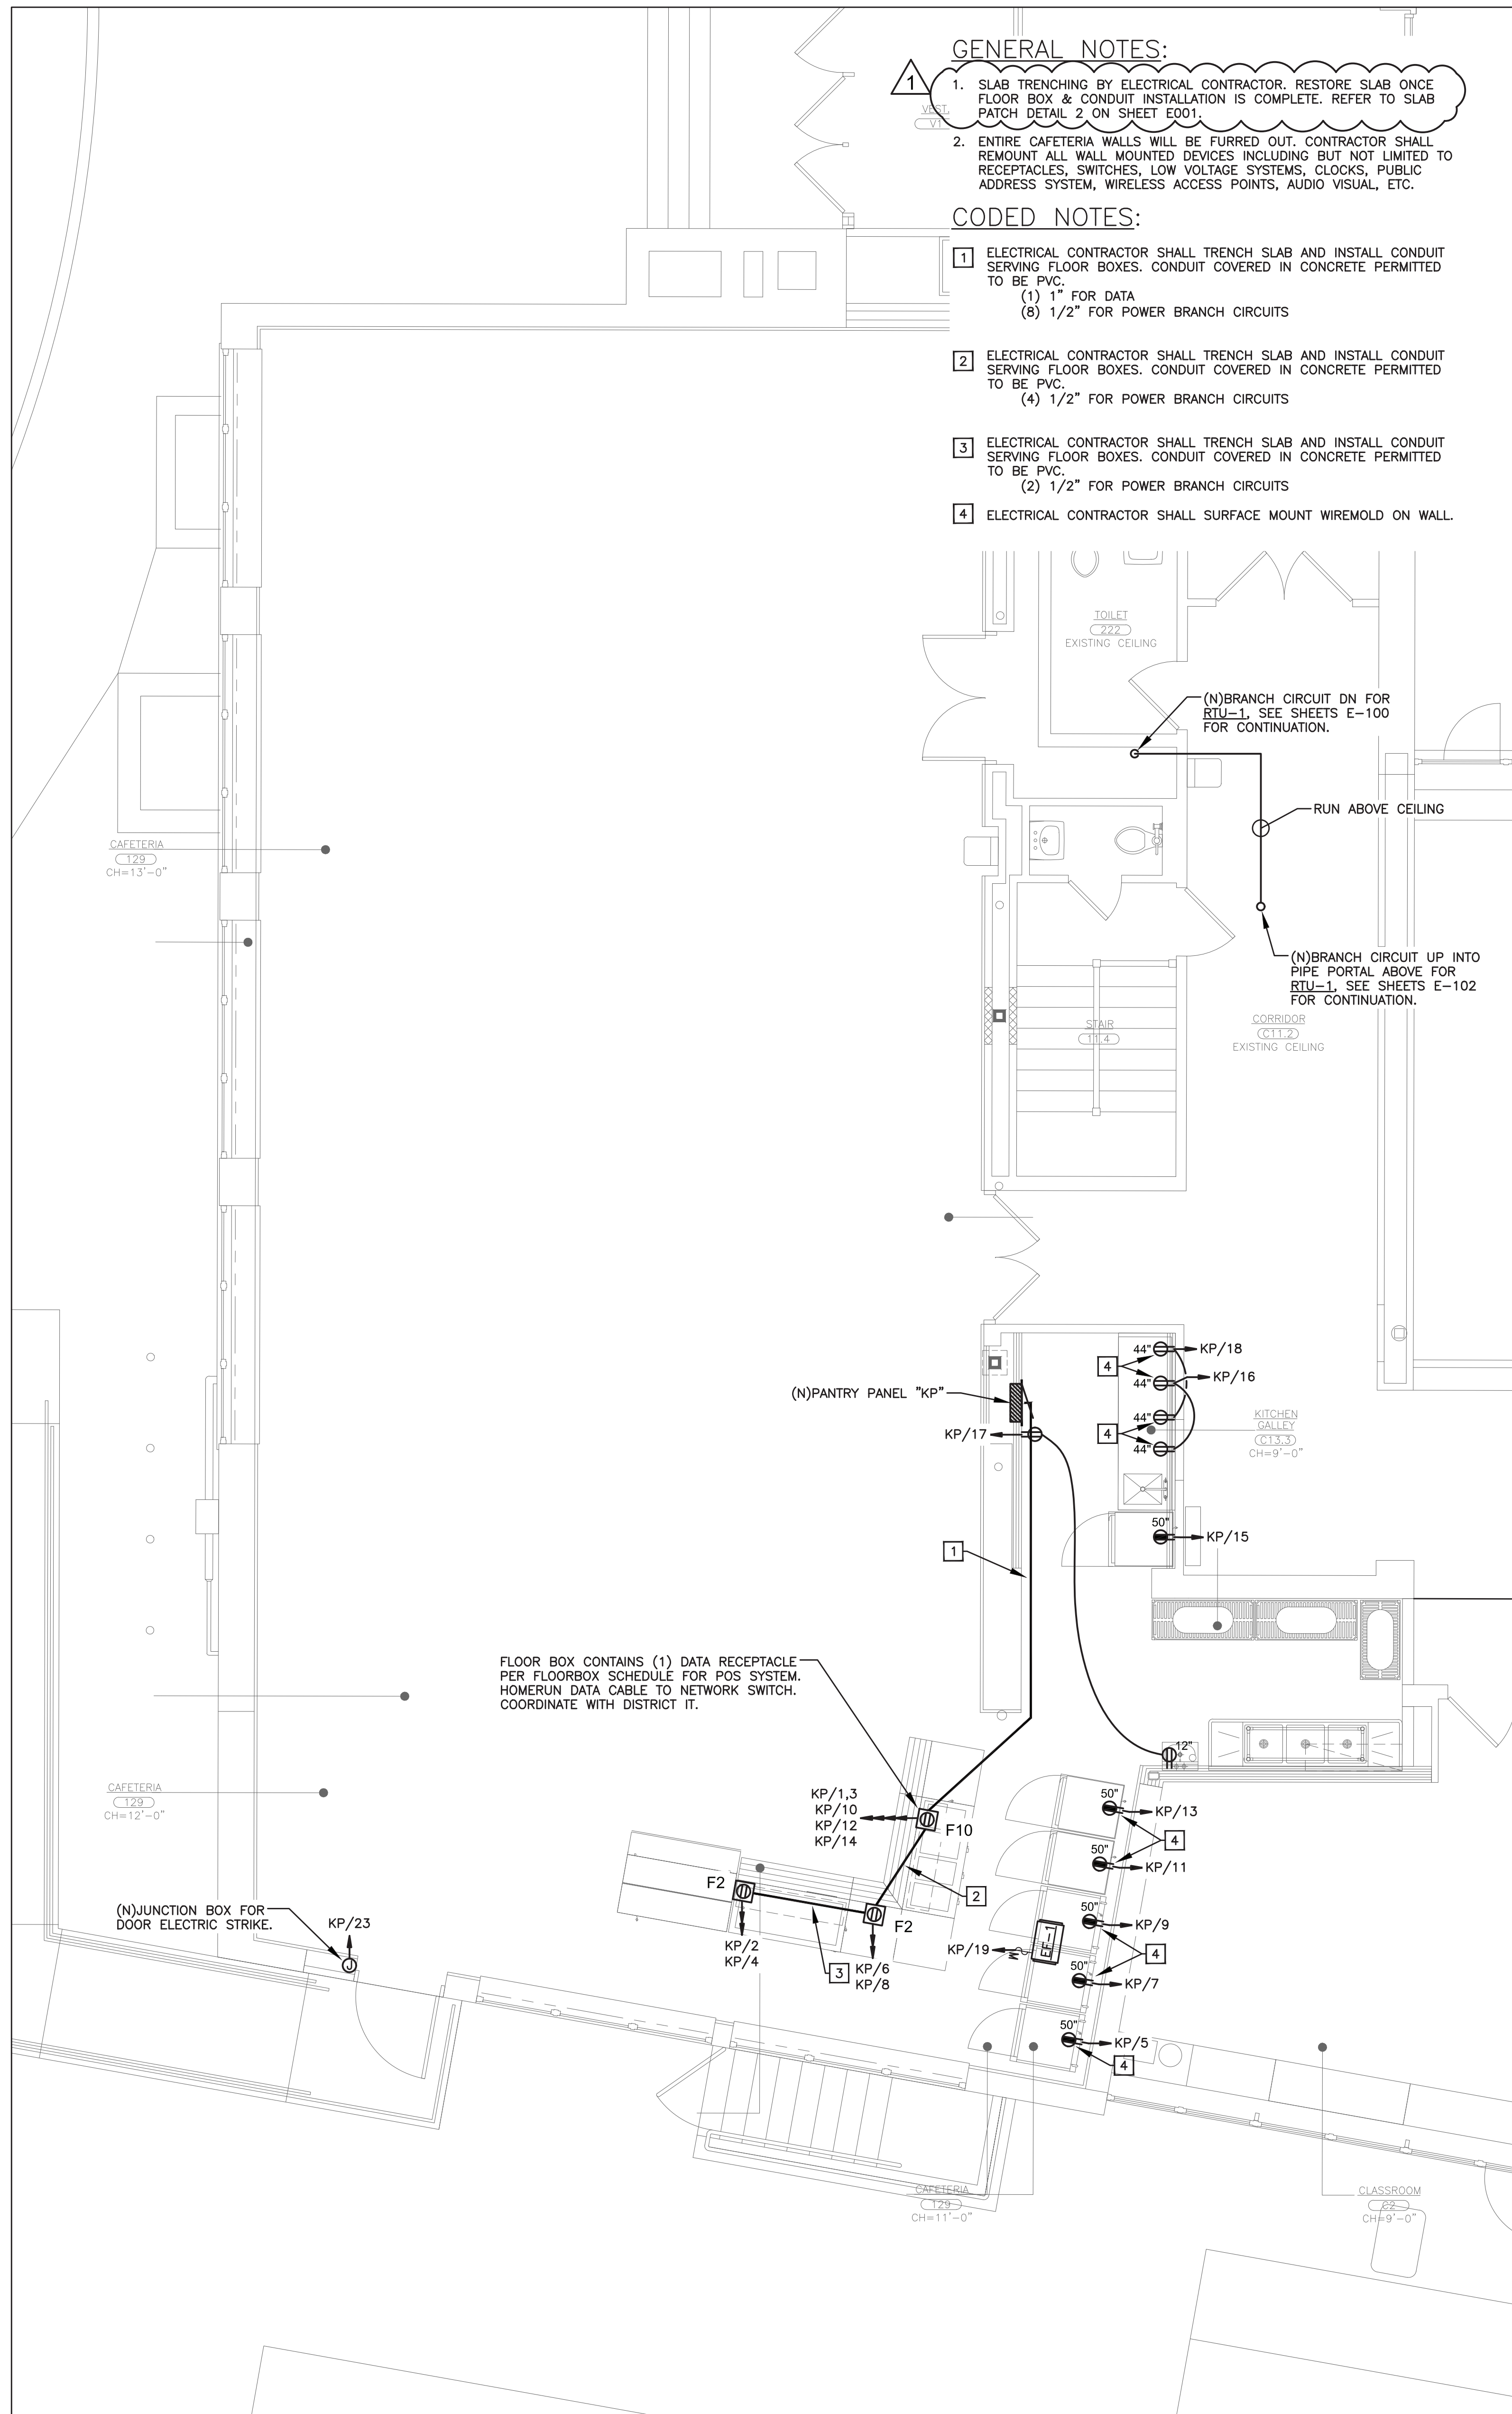

1 FIRST FLOOR ELECTRICAL PLAN
SCALE: 1/4" = 1'-0"

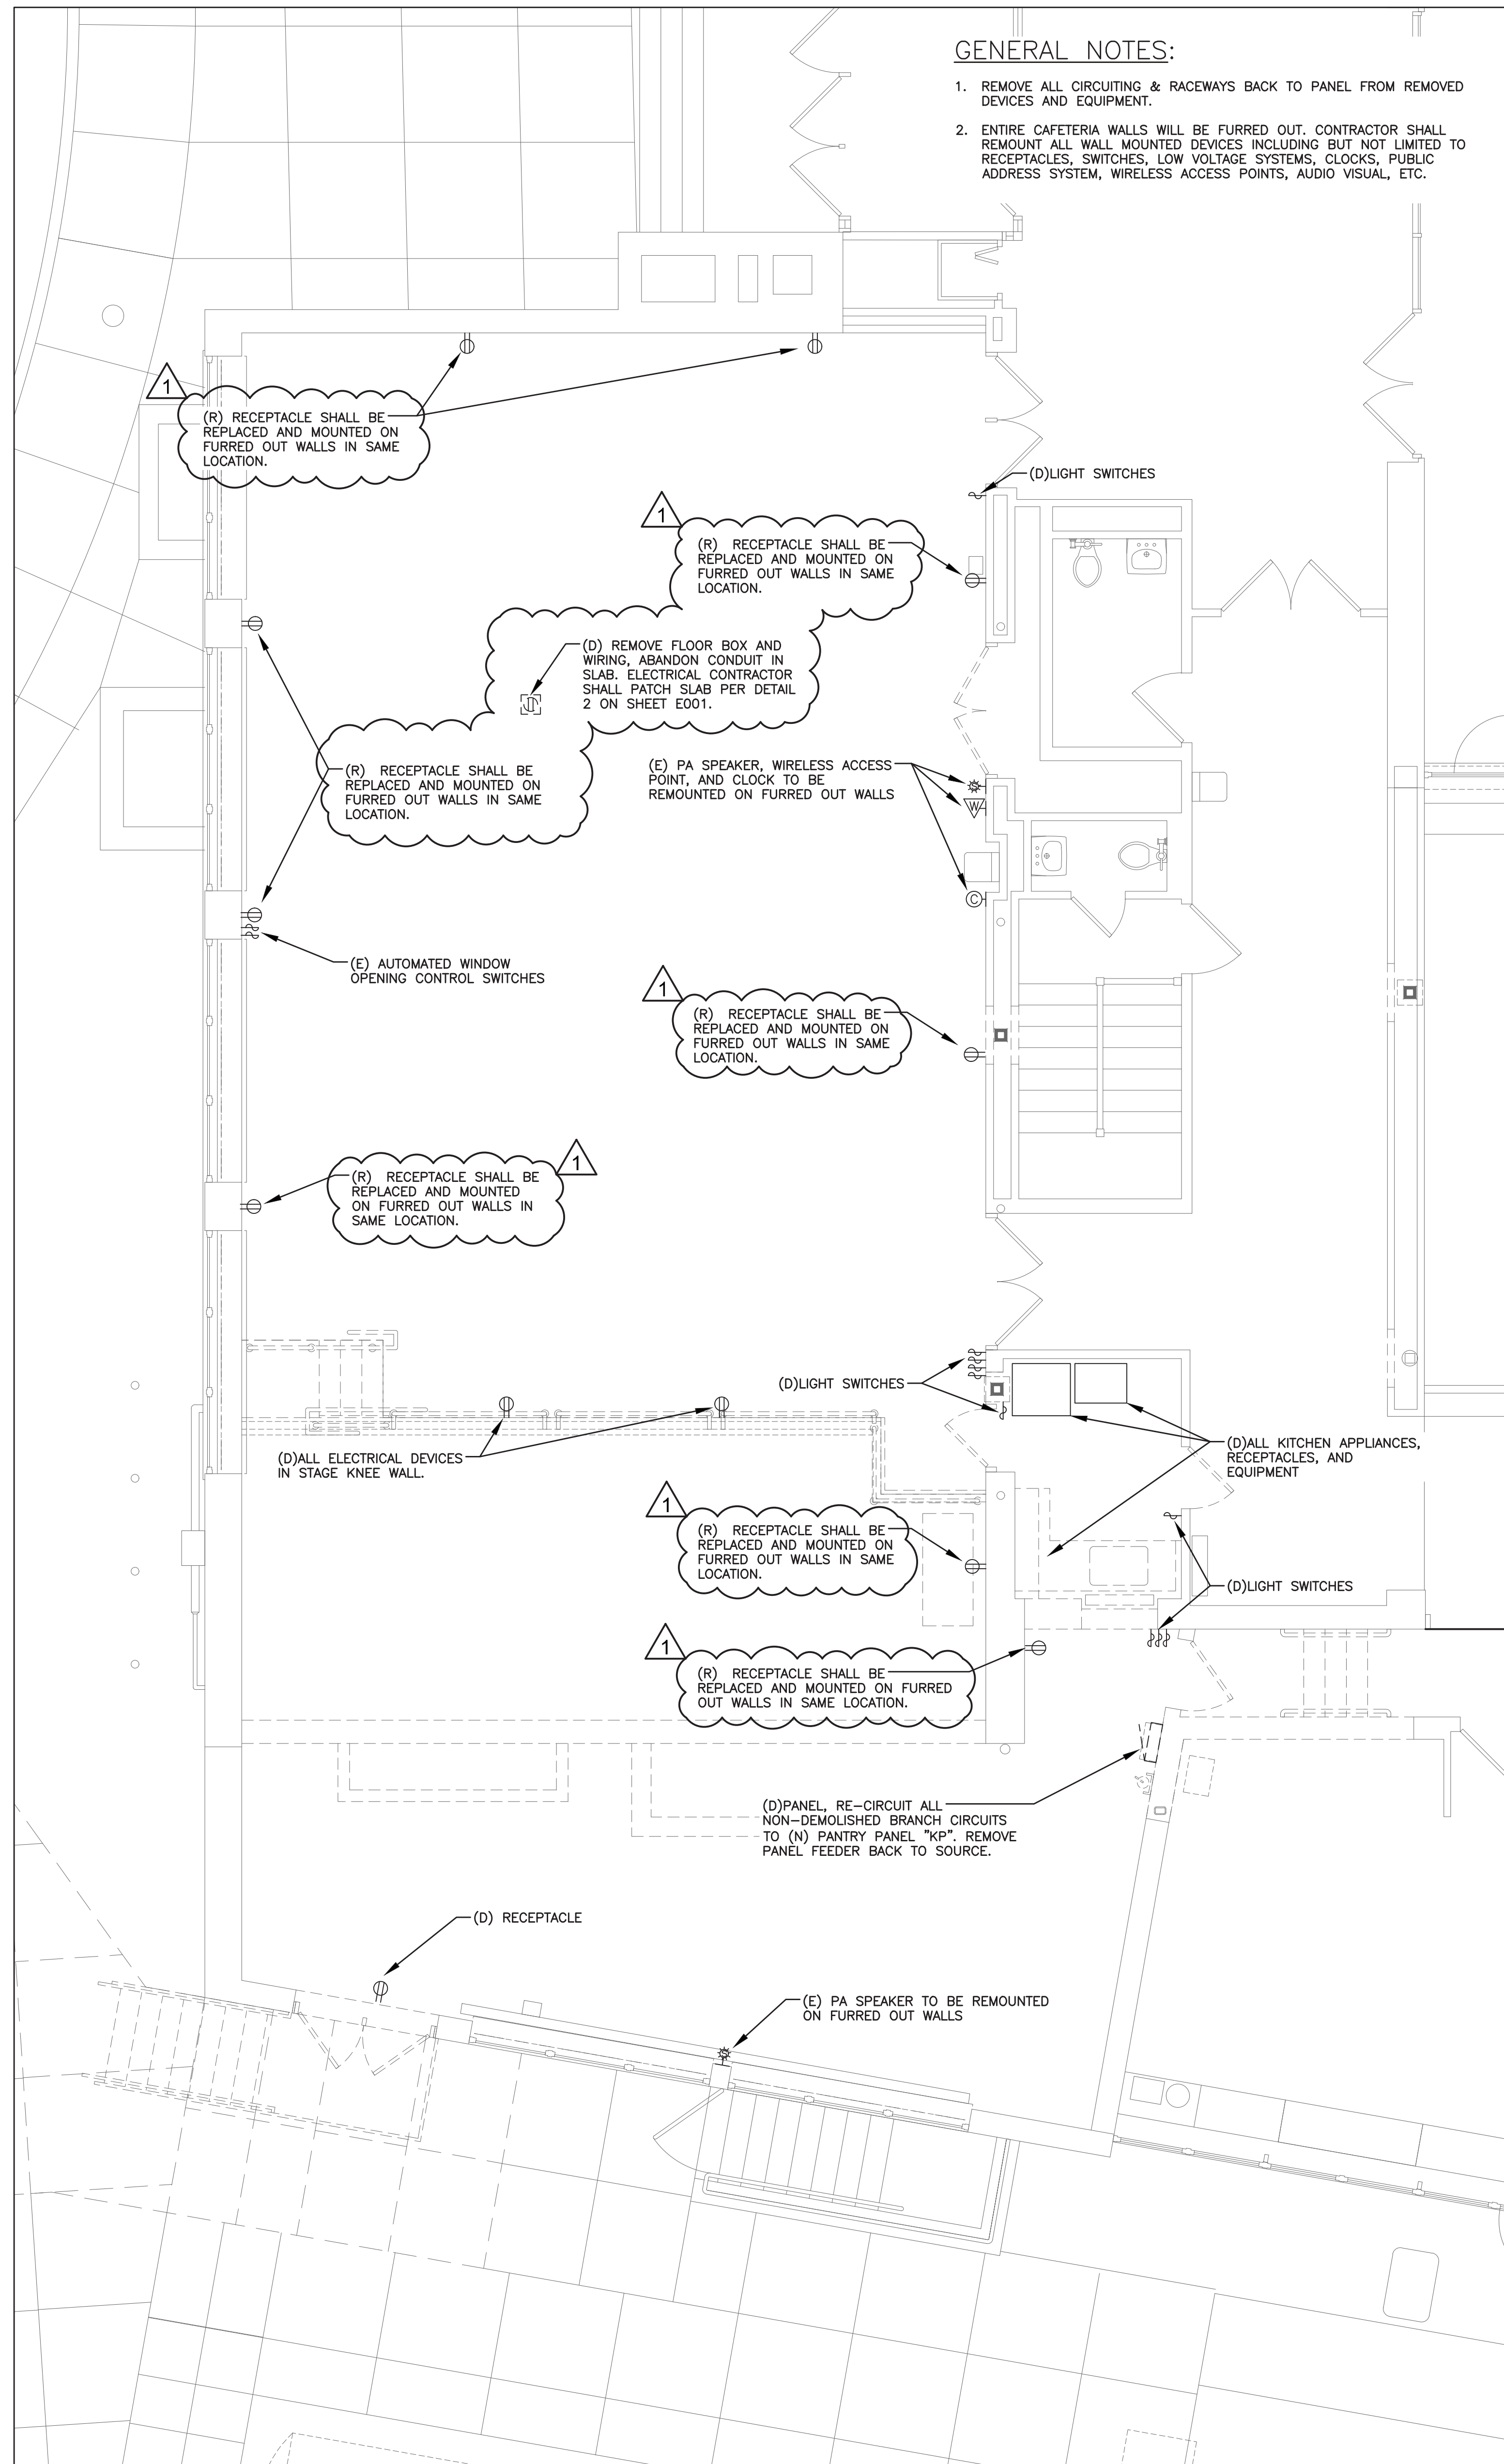

2 FIRST FLOOR ELECTRICAL REMOVALS PLAN
SCALE: 1/4" = 1'-0"

GENERAL NOTES:

1. SLAB TRENCHING BY ELECTRICAL CONTRACTOR. RESTORE SLAB ONCE FLOOR BOX & CONDUIT INSTALLATION IS COMPLETE. REFER TO SLAB PATCH DETAIL 2 ON SHEET E001.
2. ENTIRE CAFETERIA WALLS WILL BE FURRED OUT. CONTRACTOR SHALL REMOUNT ALL WALL MOUNTED DEVICES INCLUDING BUT NOT LIMITED TO RECEPTACLES, SWITCHES, LOW VOLTAGE SYSTEMS, CLOCKS, PUBLIC ADDRESS SYSTEM, WIRELESS ACCESS POINTS, AUDIO VISUAL, ETC.

CODED NOTES:

- 1 ELECTRICAL CONTRACTOR SHALL TRENCH SLAB AND INSTALL CONDUIT SERVING FLOOR BOXES. CONDUIT COVERED IN CONCRETE PERMITTED TO BE PVC.
(1) 1" FOR DATA
(8) 1/2" FOR POWER BRANCH CIRCUITS
- 2 ELECTRICAL CONTRACTOR SHALL TRENCH SLAB AND INSTALL CONDUIT SERVING FLOOR BOXES. CONDUIT COVERED IN CONCRETE PERMITTED TO BE PVC.
(4) 1/2" FOR POWER BRANCH CIRCUITS
- 3 ELECTRICAL CONTRACTOR SHALL TRENCH SLAB AND INSTALL CONDUIT SERVING FLOOR BOXES. CONDUIT COVERED IN CONCRETE PERMITTED TO BE PVC.
(2) 1/2" FOR POWER BRANCH CIRCUITS
- 4 ELECTRICAL CONTRACTOR SHALL SURFACE MOUNT WIREMOLD ON WALL.

GENERAL NOTES:

1. REMOVE ALL CIRCUITING & RACEWAYS BACK TO PANEL FROM REMOVED DEVICES AND EQUIPMENT.
2. ENTIRE CAFETERIA WALLS WILL BE FURRED OUT. CONTRACTOR SHALL REMOUNT ALL WALL MOUNTED DEVICES INCLUDING BUT NOT LIMITED TO RECEPTACLES, SWITCHES, LOW VOLTAGE SYSTEMS, CLOCKS, PUBLIC ADDRESS SYSTEM, WIRELESS ACCESS POINTS, AUDIO VISUAL, ETC.

AS PER USA CONGRESS ARCHITECTURAL WORKS COPYRIGHT PROTECTION ACT OF 1990 ALL IDEAS AND DESIGNS INCLUDING DERIVATIVES THEREOF, ALL DRAWINGS AND SPECIFICATIONS CONSTITUTE THE ORIGINAL COPYRIGHT WORK BY FULLER AND DANKELO, P.C. (F&D). THE DRAWINGS AND SPECIFICATIONS AS INSTRUMENTS OF SERVICE BY F&D ARE CREATED BY F&D FOR THIS PROJECT ONLY AND REMAIN THE PRODUCT AND PROPERTY OF F&D. ANY REPRODUCTION WITHOUT THE PRIOR CONSENT OF F&D IS PROHIBITED.

LFG
252 East Avenue
Greenville, CT 06033
(203) 866-4628 T/F
(203) 866-4019 Fax
LANDMARK
FACILITIES
GROUP, INC.

408 SHELLWOOD ROAD
ELMISTON NEW YORK, 10829
TEL: 814-898-4444 FAX: 814-898-1171
Copyright 2021 All Rights Reserved by FULLER & DANKELO, P.C.


**FULLER
D'ANGELO
P.C.**
ARCHITECTS
PLANNERS

LFG
LANDMARK
FACILITIES
GROUP, INC.
252 East Avenue
Greenville, CT 06033
(203) 866-4628 T/F
(203) 866-4019 Fax


S.E.D. CONTROL NUMBER:
GREENVILLE ELEMENTARY SCHOOL
66-04-06-03-0-001-021
SEELY PLACE ELEMENTARY SCHOOL
66-04-06-03-0-001-019

PROJECT NAME:
EDGEMONT SCHOOL DISTRICT
GREENVILLE ELEMENTARY SCHOOL
SEELY PLACE ELEMENTARY SCHOOL
PHASE 1 - HVAC & CAFETERIA
DRAWING TITLE:
FIRST FLOOR ELECTRICAL PLAN

1-24-2023	ADDENDUM 1
1-06-2023	BID
DATE	ISSUED TO
SHEET SIZE: 30"x42"	DRAWING NO. GVES E101
SCALE: AS NOTED	FILE NO. 21434.01
DRAWN BY: LFG	

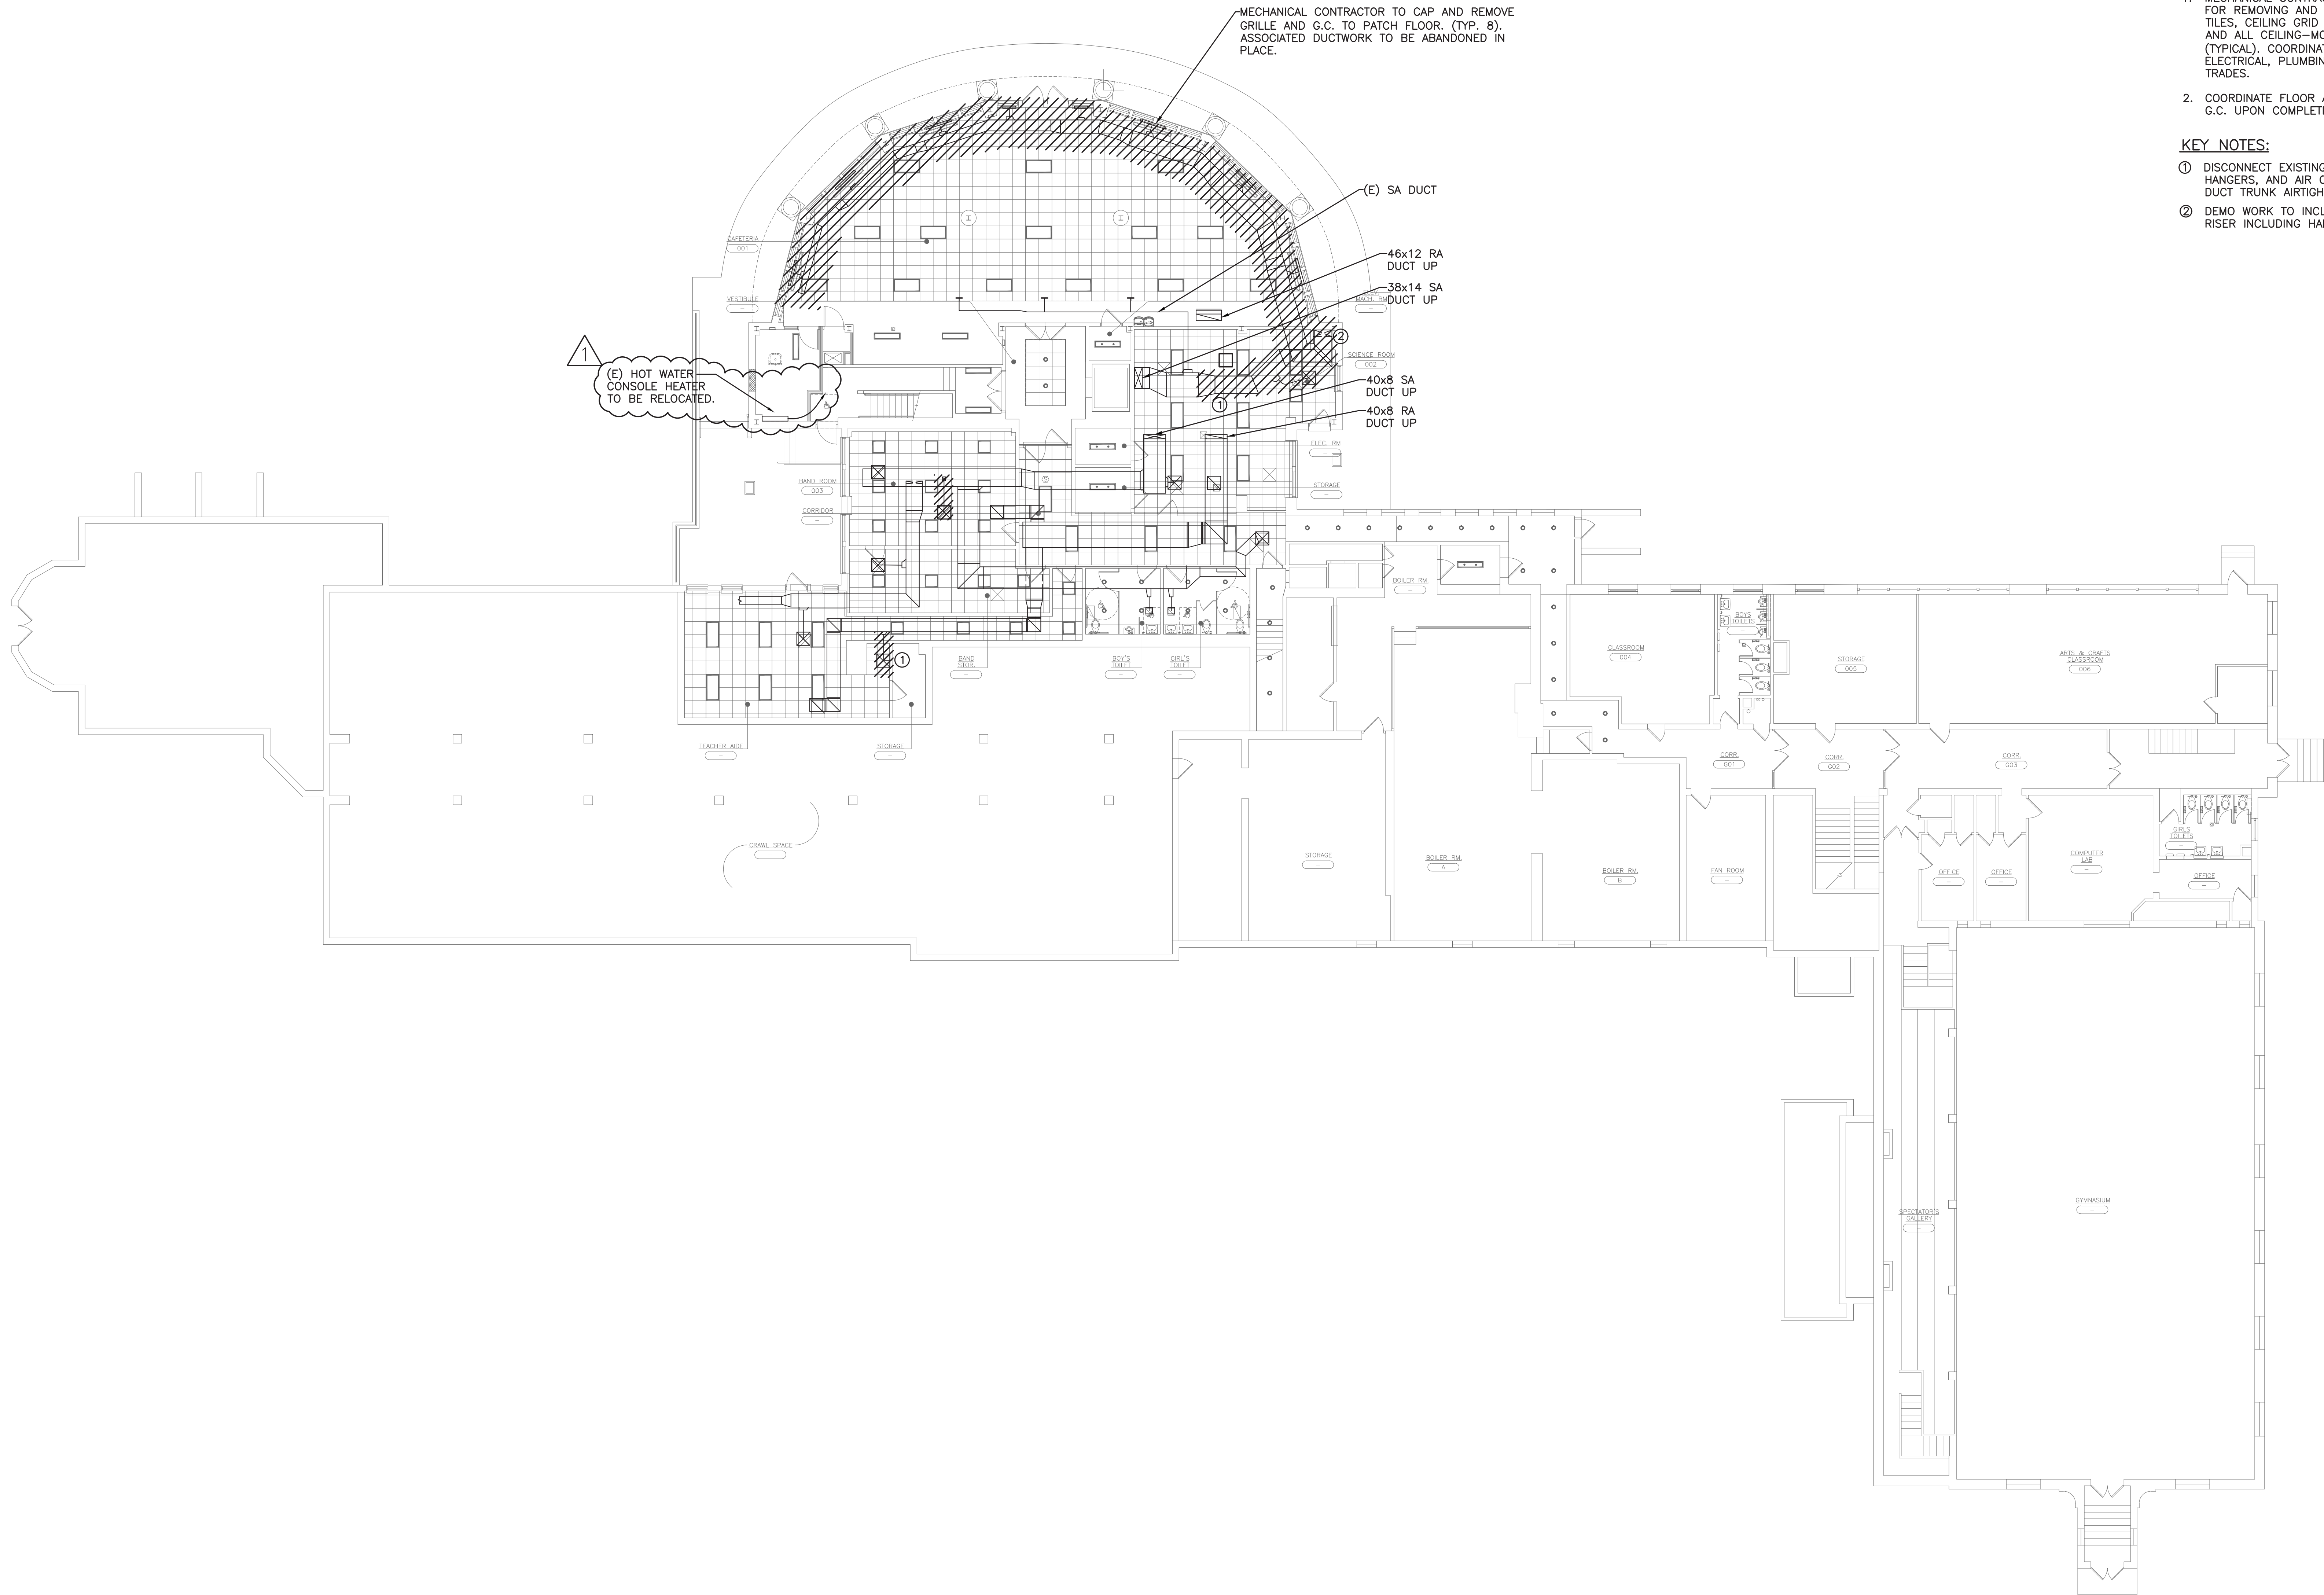

SEELY ELEMENTARY SCHOOL
MECHANICAL DEMO PLAN - LOWER LEVEL
1 SCALE: 3/32" = 1'-0"

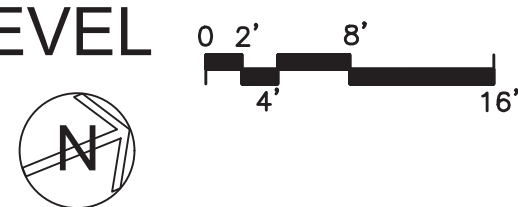

NOTES:

- MECHANICAL CONTRACTOR IS RESPONSIBLE FOR REMOVING AND RE-INSTALLING CEILING TILES, CEILING GRID SUSPENSION SYSTEM, AND ALL CEILING-MOUNTED DEVICES (TYPICAL). COORDINATE CEILING SCOPE WITH ELECTRICAL, PLUMBING, AND CONTROLS TRADES.
- COORDINATE FLOOR AND WALL PATCHING WITH G.C. UPON COMPLETION OF DEMO WORK.

KEY NOTES:

- DISCONNECT EXISTING BRANCH DUCT, HANGERS, AND AIR OUTLET. CAP AND SEAL DUCT TRUNK AIRTIGHT.
- DEMO WORK TO INCLUDE EXISTING DUCTWORK RISER INCLUDING HANGERS.

AS PER USA CONGRESS ARCHITECTURAL WORKS COPYRIGHT PROTECTION ACT OF 1990 ALL IDEAS AND DESIGNS INCLUDING DERIVATIVES THEREOF, ALL DRAWINGS AND SPECIFICATIONS CONSTITUTE THE ORIGINAL COPYRIGHT WORK BY FULLER AND D'ANGELO, P.C. (F&D). THE DRAWINGS AND SPECIFICATIONS AS INSTRUMENTS OF SERVICE BY F&D ARE CREATED BY F&D FOR THIS PROJECT ONLY AND REMAIN THE PROPERTY OF F&D. ANY REPRODUCTION WITHOUT THE PRIOR CONSENT OF F&D IS PROHIBITED.

408 CHATELAIN ROAD ELLENFIELD NEW YORK 10889
TEL: 914.898.4444 FAX: 914.898.1177
Copyright 2011 All Rights Reserved by FULLER & D'ANGELO, P.C.


FULLER
D'ANGELO
P.C.
ARCHITECTS
PLANNERS

LFG
LANDMARK
FACILITIES
GROUP, INC.
252 East Avenue
ROCKY HILL, CT 06067
(203) 866-4024 FAX
(203) 866-4019 FAX

S.E.D. CONTROL NUMBER:
GREENVILLE ELEMENTARY SCHOOL
66-04-06-03-0-008-021
SEELY PLACE ELEMENTARY SCHOOL
66-04-06-03-0-001-019

PROJECT: SEELY PLACE ELEMENTARY SCHOOL
DRAWING TITLE: MECHANICAL DEMO PLAN
LOWER LEVEL

1-24-2023	ADDENDUM #1
1-06-2023	BID
DATE	ISSUED TO
SHEET SIZE 30"x42"	DRAWING NO. SPES MD100
SCALE AS NOTED	FILE NO. 21434.01
DRAWN BY LFG	

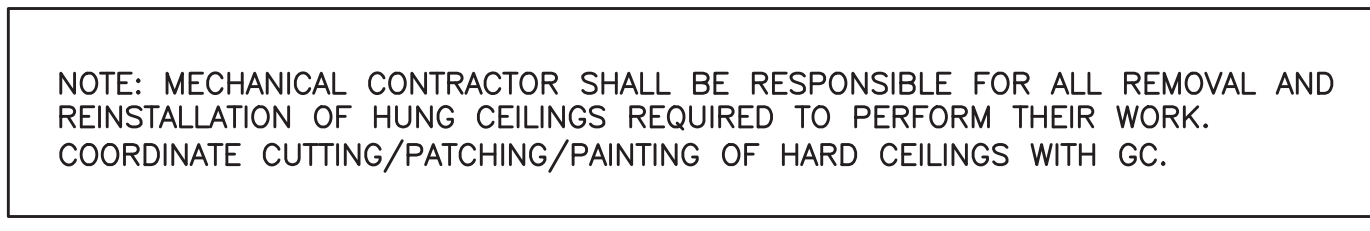


FULLER
D'ANGELO
P.C.


ARCHITECTS
PLANNERS

PROJECT TITLE	EDGEMONT SCHOOL DISTRICT GREENVILLE ELEMENTARY SCHOOL CAFETERIA RENOVATION AND RELATED WORK SEELY PLACE ELEMENTARY SCHOOL PHASE 1 - HVAC & CAFETERIA
DRAWING TITLE	LOWER LEVEL MECHANICAL PLAN


1-24-2023	ADDENDUM #1
1-06-2023	BID
DATE	ISSUED TO
SHEET SIZE 30"x42"	DRAWING NO. SPES M100
SCALE AS NOTED	
DRAWN BY LFG	FILE NO. 21434.01

- SEELY ELEMENTARY SCHOOL
MECHANICAL PLAN - LOWER LEVEL
SCALE: 3/32" = 1'-0"

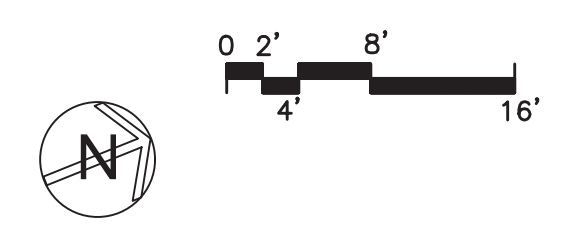

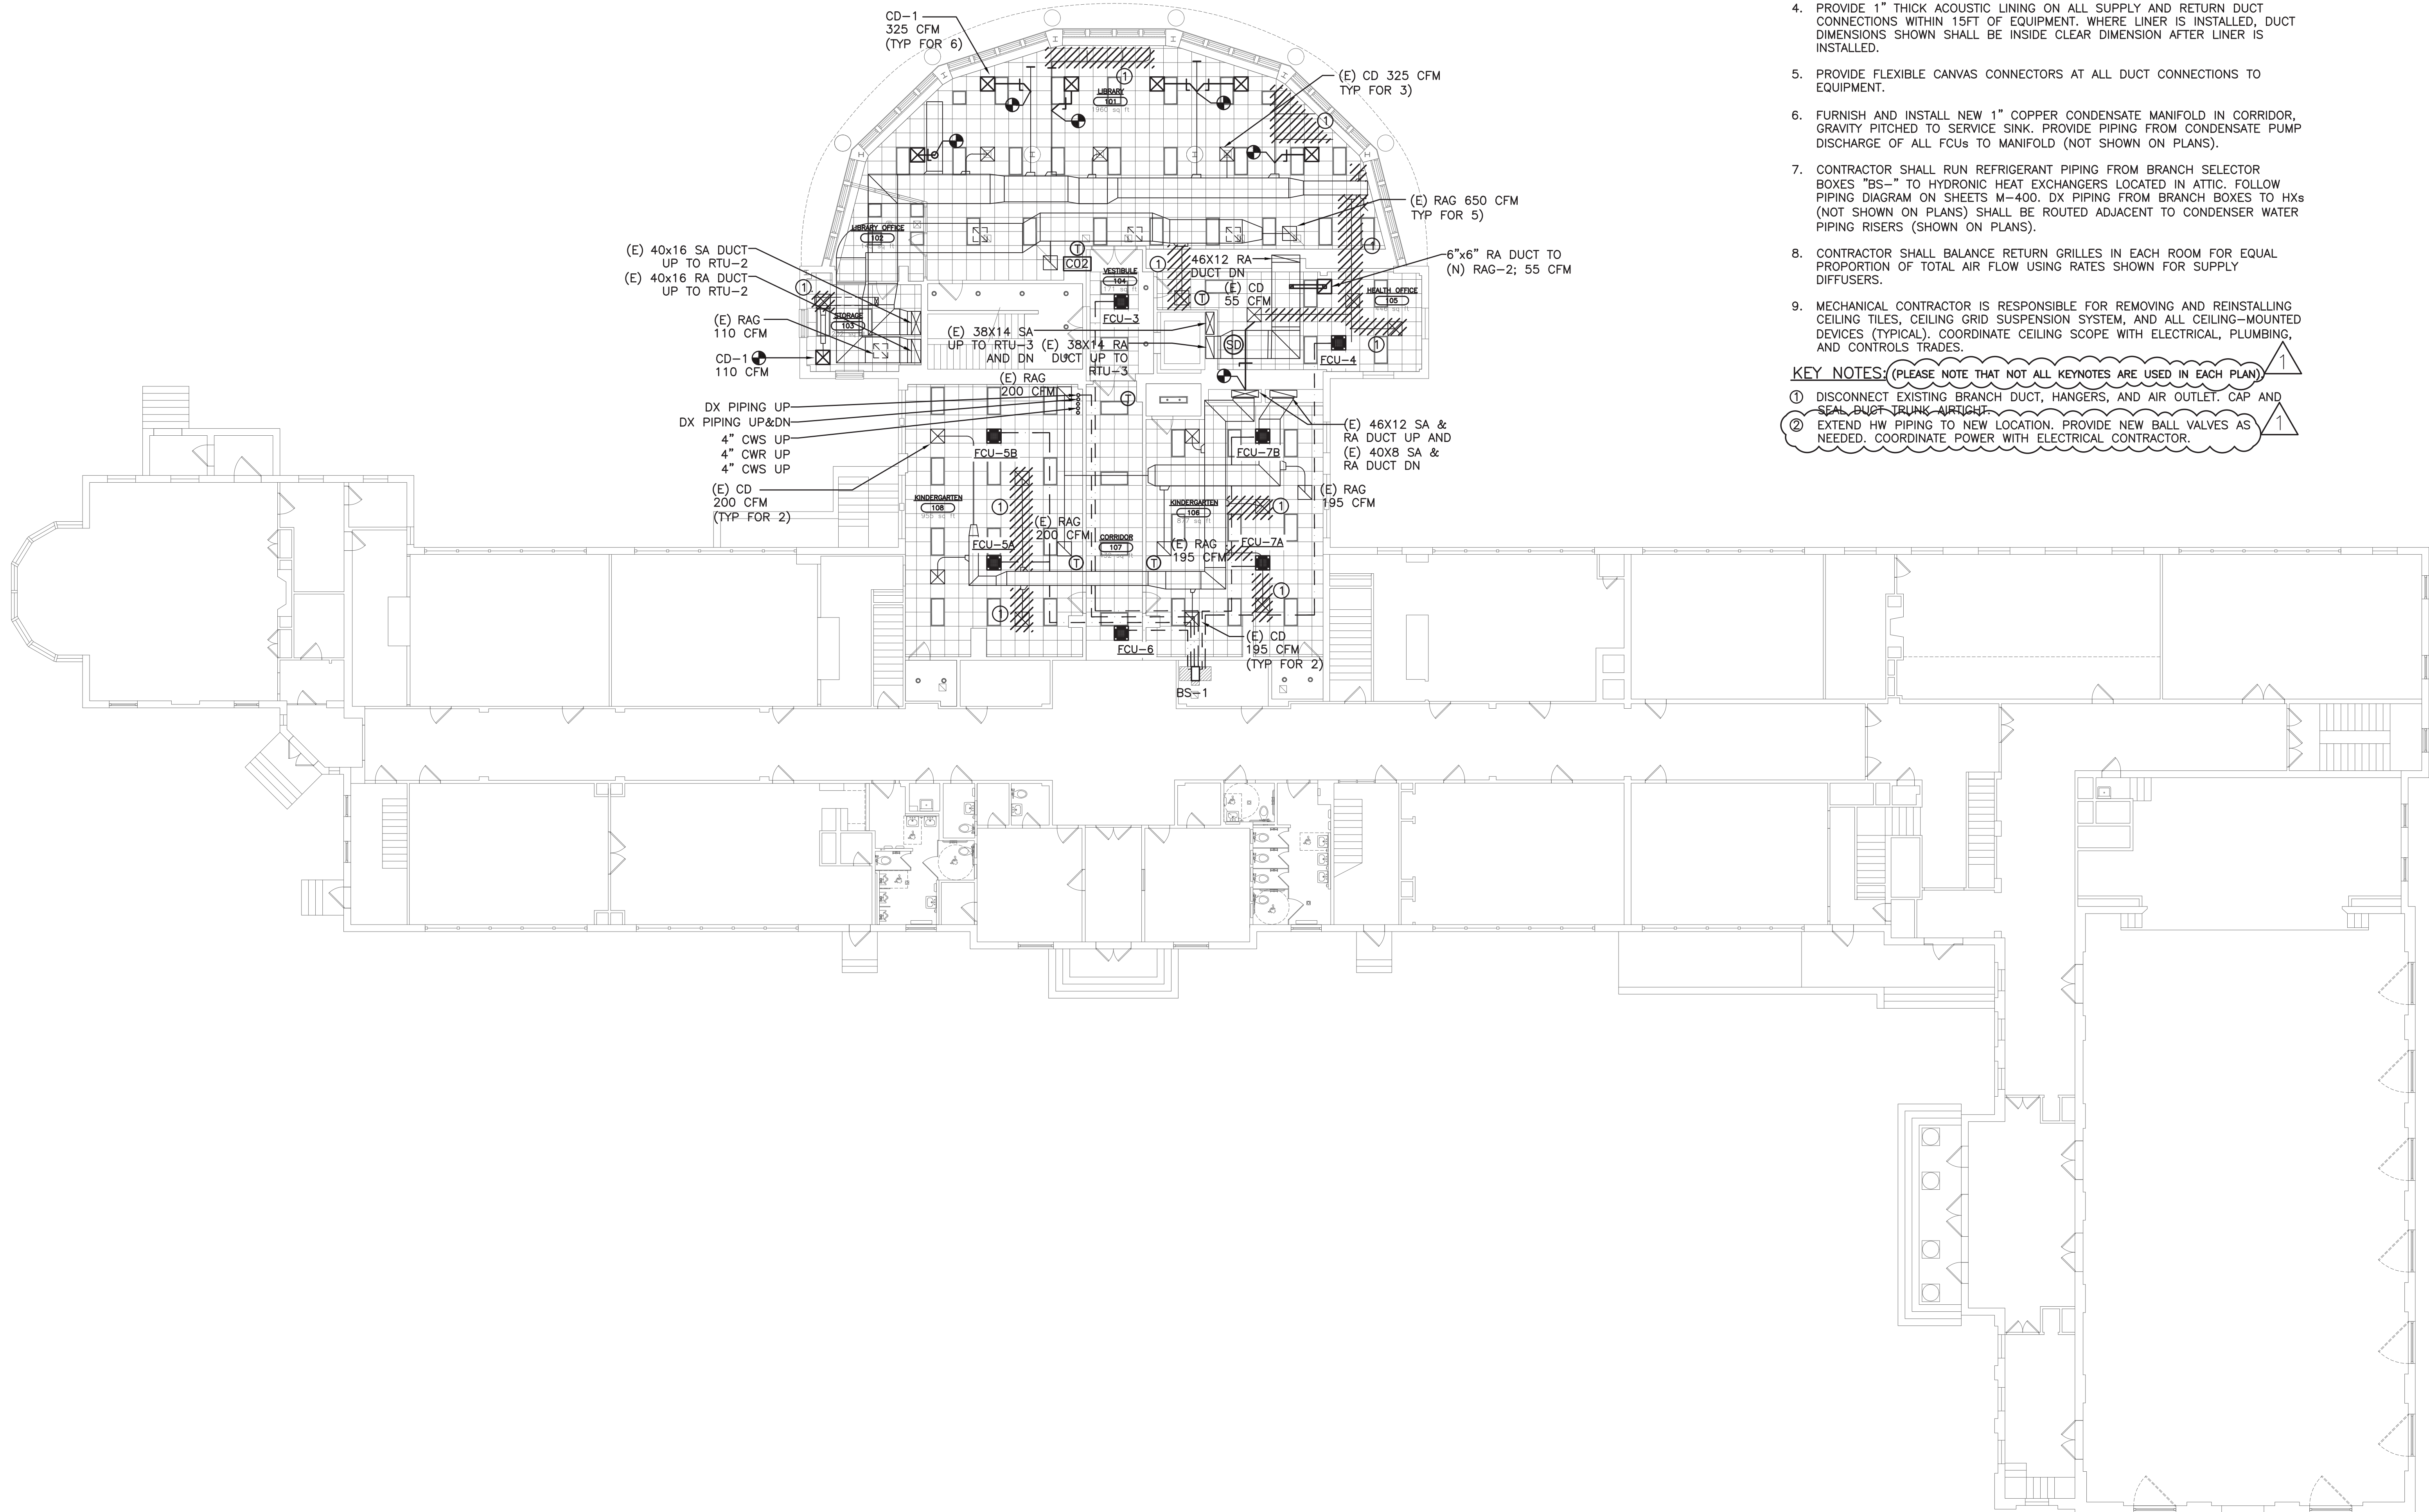

SEELY ELEMENTARY SCHOOL
MECHANICAL DEMO AND NEW WORK PLAN - FIRST FLOOR
1 SCALE: 3/32" = 1'-0"

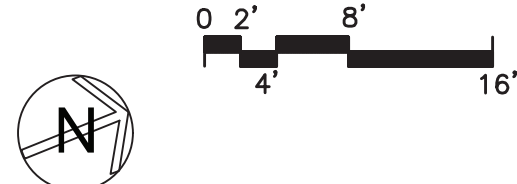

NOTES:

1. REFER TO WRITTEN (BOOK) SPECIFICATIONS FOR ADDITIONAL INFORMATION.
2. COORDINATE LOCATION OF ALL WALL MOUNTED DEVICES (IE. THERMOSTATS) WITH ARCHITECT PRIOR TO ROUGHING CABLE.
3. ALL FAN COIL UNITS SERVING A SINGLE ZONE (IE. CAFETERIA, CLASSROOM, ETC.) SHALL BE SLAVED TOGETHER TO RESPOND TO A SINGLE THERMOSTAT TIED TO THE BMS.
4. PROVIDE 1" THICK ACOUSTIC LINING ON ALL SUPPLY AND RETURN DUCT CONNECTIONS WITHIN 15FT OF EQUIPMENT. WHERE LINER IS INSTALLED, DUCT DIMENSIONS SHOWN SHALL BE INSIDE CLEAR DIMENSION AFTER LINER IS INSTALLED.
5. PROVIDE FLEXIBLE CANVAS CONNECTORS AT ALL DUCT CONNECTIONS TO EQUIPMENT.
6. FURNISH AND INSTALL NEW 1" COPPER CONDENSATE MANIFOLD IN CORRIDOR, GRAVITY PITCHED TO SERVICE SINK. PROVIDE PIPING FROM CONDENSATE PUMP DISCHARGE OF ALL FCUs TO MANIFOLD (NOT SHOWN ON PLANS).
7. CONTRACTOR SHALL RUN REFRIGERANT PIPING FROM BRANCH SELECTOR BOXES "BS-" TO HYDRONIC HEAT EXCHANGERS LOCATED IN ATTIC. FOLLOW PIPING DIAGRAM ON SHEETS M-400. DX PIPING FROM BRANCH BOXES TO HXs (NOT SHOWN ON PLANS) SHALL BE ROUTED ADJACENT TO CONDENSER WATER PIPING RISERS (SHOWN ON PLANS).
8. CONTRACTOR SHALL BALANCE RETURN GRILLES IN EACH ROOM FOR EQUAL PROPORTION OF TOTAL AIR FLOW USING RATES SHOWN FOR SUPPLY DIFFUSERS.
9. MECHANICAL CONTRACTOR IS RESPONSIBLE FOR REMOVING AND REINSTALLING CEILING TILES, CEILING GRID SUSPENSION SYSTEM, AND ALL CEILING-MOUNTED DEVICES (TYPICAL). COORDINATE CEILING SCOPE WITH ELECTRICAL, PLUMBING, AND CONTROLS TRADES.

KEY NOTES: (PLEASE NOTE THAT NOT ALL KEYNOTES ARE USED IN EACH PLAN)

- 1 DISCONNECT EXISTING BRANCH DUCT, HANGERS, AND AIR OUTLET. CAP AND SEAL BRANCH AIRWAYS.
- 2 EXTEND HW PIPING TO NEW LOCATION. PROVIDE NEW BALL VALVES AS NEEDED. COORDINATE POWER WITH ELECTRICAL CONTRACTOR.

AS PER USA CONGRESS ARCHITECTURAL WORKS COPYRIGHT PROTECTION ACT OF 1990 ALL IDEAS AND DESIGNS INCLUDING DERIVATIVES THEREOF, ALL DRAWINGS AND SPECIFICATIONS CONSTITUTE THE ORIGINAL COPYRIGHT WORK BY FULLER AND D'ANGELO, P.C. (F&D). THE DRAWINGS AND SPECIFICATIONS AS INSTRUMENTS OF SERVICE BY F&D ARE CREATED BY F&D FOR THIS PROJECT ONLY AND REMAIN THE PROPERTY OF F&D. ANY REPRODUCTION WITHOUT THE PRIOR CONSENT OF F&D IS PROHIBITED.

408 SHELLEWOOD ROAD ELLENBORO NEW YORK 12828
TEL: 814-898-4444 FAX: 814-898-1379
Copyright 2021 All Rights Reserved by FULLER & D'ANGELO, P.C.

FULLER
& D'ANGELO
P.C.
ARCHITECTS
PLANNERS

LFG
LANDMARK
FACILITIES
GROUP, INC.
252 East Avenue
Greenville, SC 29615
(253) 866-4624 FAX
(253) 866-4019 Fax



S.E.D. CONTROL NUMBER:
GREENVILLE ELEMENTARY SCHOOL
66-04-06-03-0-003-021
SEELY PLACE ELEMENTARY SCHOOL
66-04-06-03-0-001-019

PROJECT:
EDGEMONT SCHOOL DISTRICT
GREENVILLE ELEMENTARY SCHOOL
SEELY PLACE ELEMENTARY SCHOOL
PHASE 1 - HVAC & CAFETERIA
DRAWING TITLE
FIRST FLOOR MECHANICAL PLAN

1-24-2023	ADDENDUM #1
1-06-2023	BID
DATE	ISSUED TO
SHEET SIZE 30"x42"	DRAWING NO. SPES M101
SCALE AS NOTED	FILE NO. 21434.01
DRAWN BY LFG	

SEELY ELEMENTARY SCHOOL
MECHANICAL DEMO AND NEW WORK PLAN - SECOND FLOOR

1 SCALE: 3/32" = 1'-0"

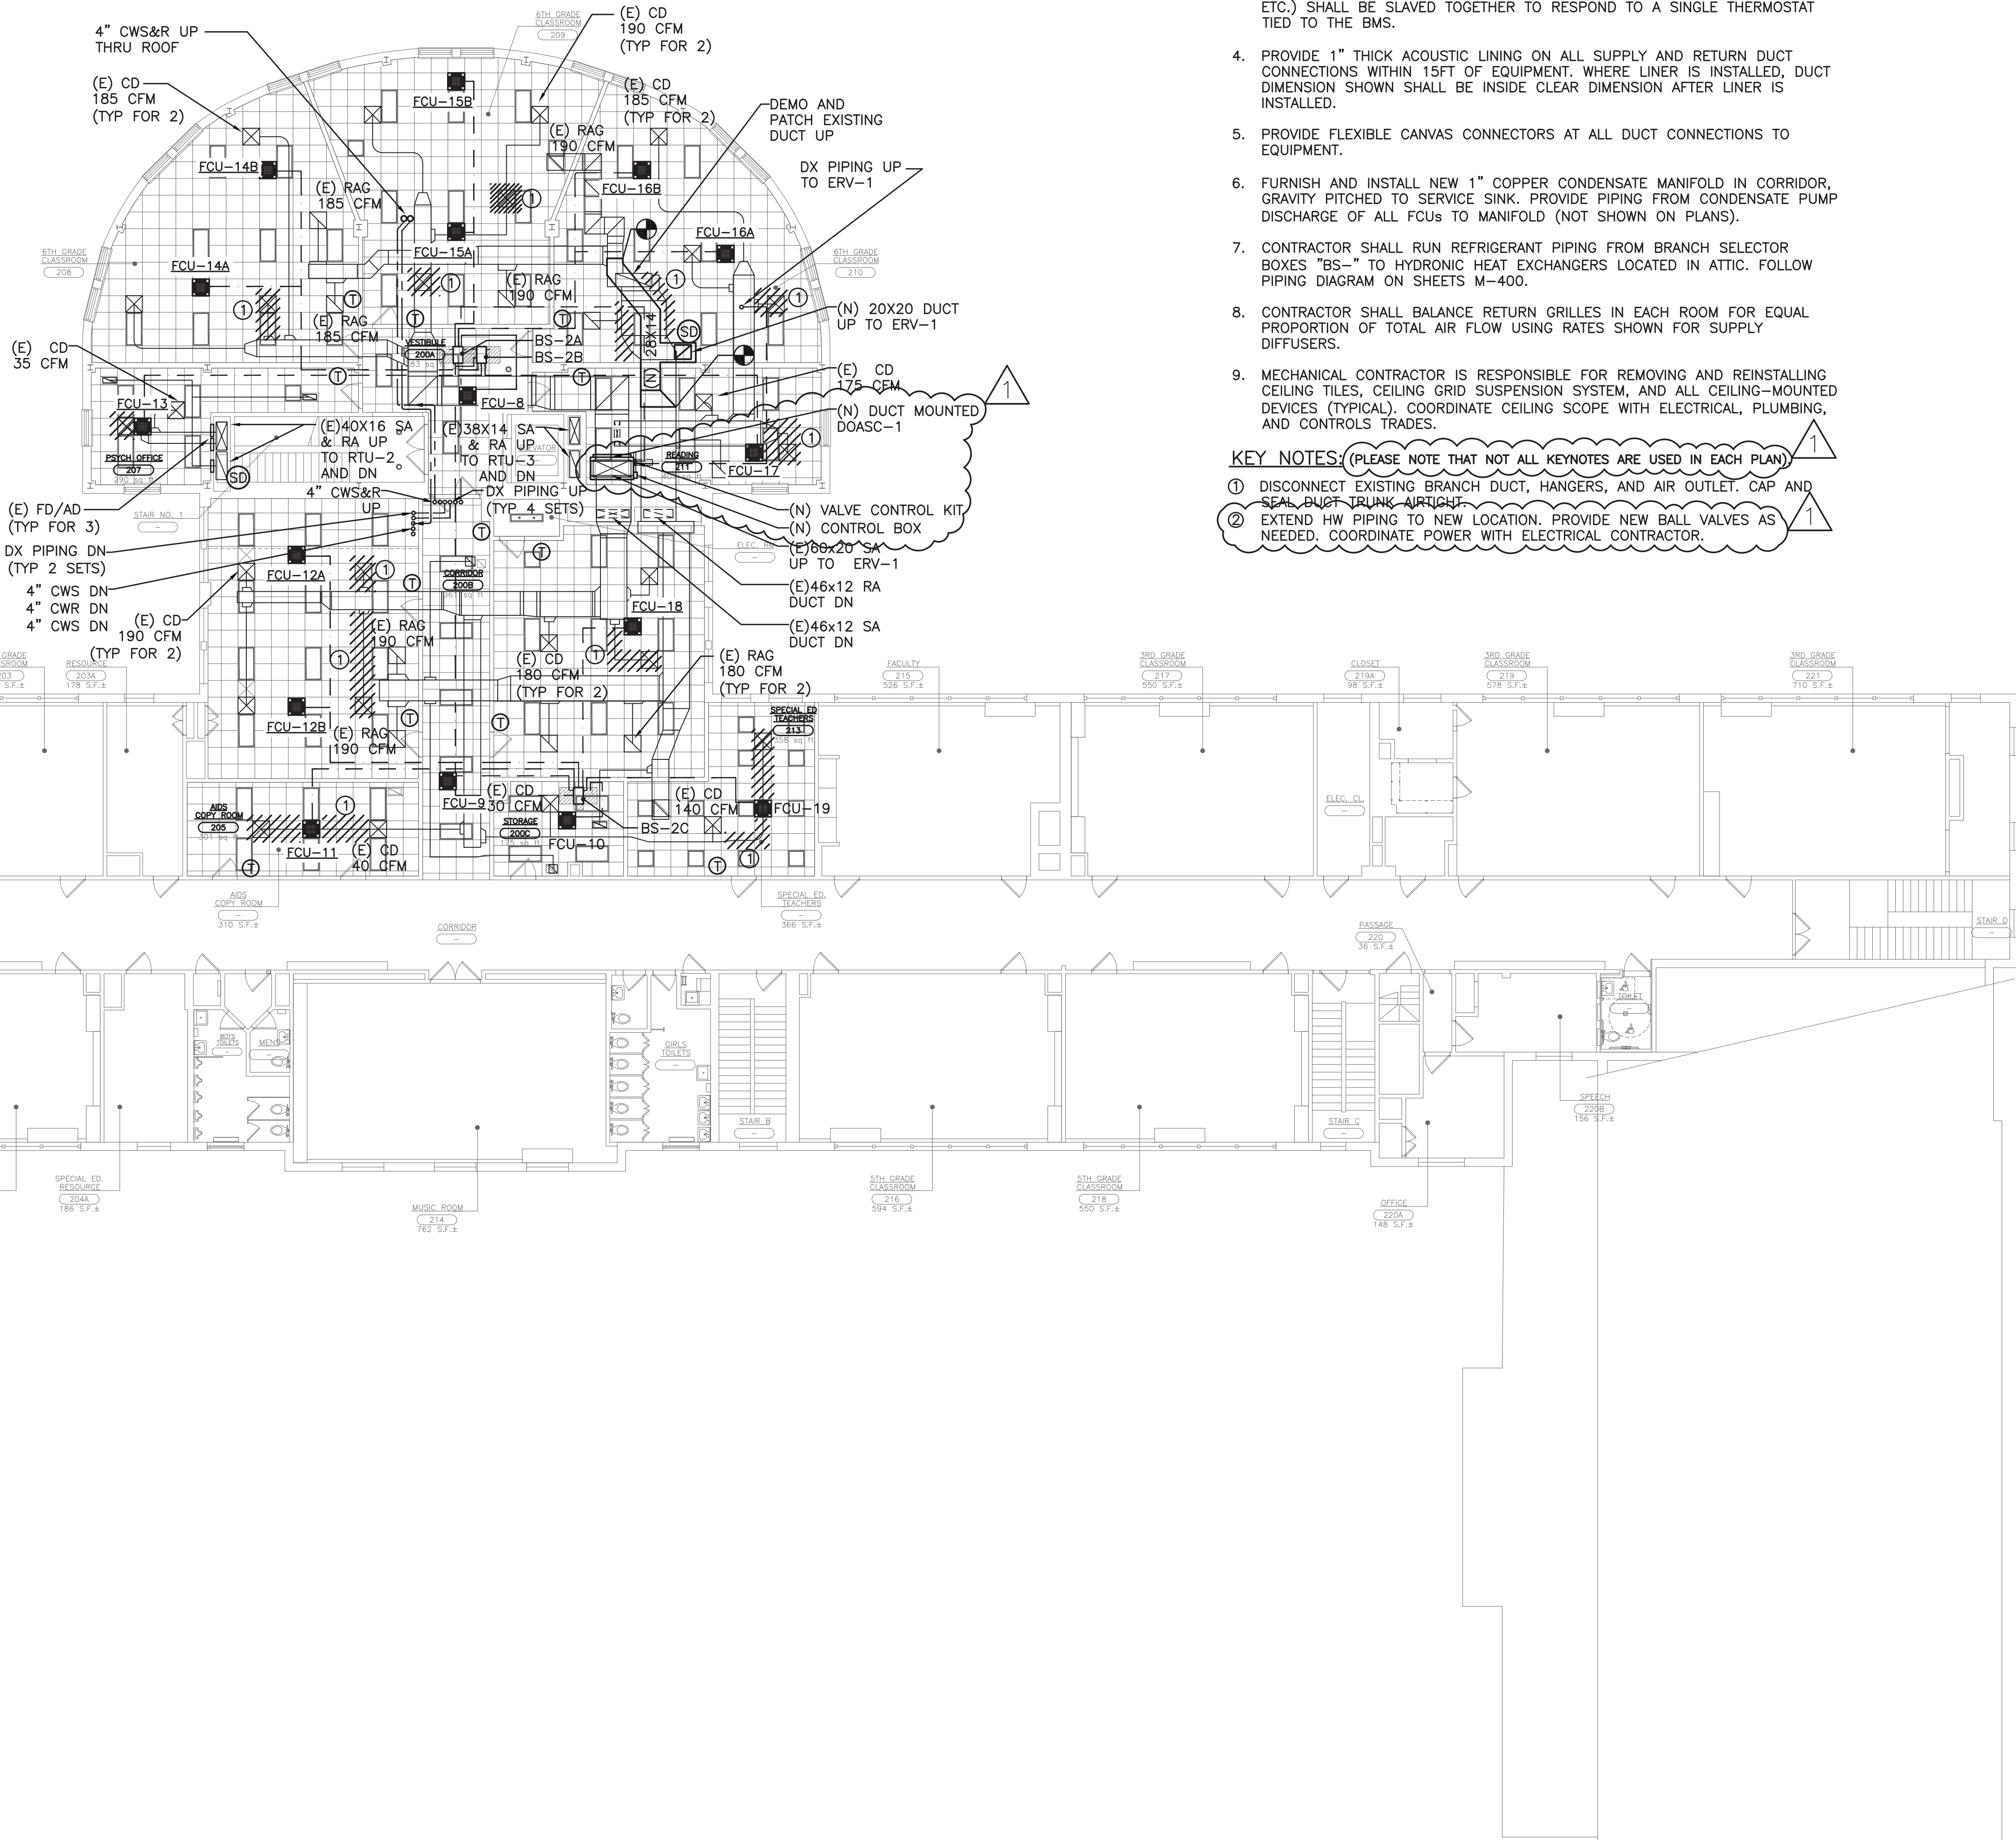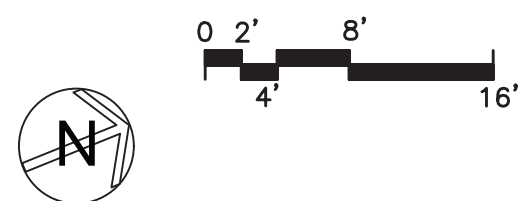

NOTES:

- REFER TO WRITTEN (BOOK) SPECIFICATIONS FOR ADDITIONAL INFORMATION.
- COORDINATE LOCATION OF ALL WALL MOUNTED DEVICES (IE. THERMOSTATS) WITH ARCHITECT PRIOR TO ROUGHING CABLE.
- ALL FAN COIL UNITS SERVING A SINGLE ZONE (IE. CAFETERIA, CLASSROOM, ETC.) SHALL BE SLAVED TOGETHER TO RESPOND TO A SINGLE THERMOSTAT TIED TO THE BMS.
- PROVIDE 1" THICK ACOUSTIC LINING ON ALL SUPPLY AND RETURN DUCT CONNECTIONS WITHIN 15FT OF EQUIPMENT. WHERE LINER IS INSTALLED, DUCT DIMENSION SHOWN SHALL BE INSIDE CLEAR DIMENSION AFTER LINER IS INSTALLED.
- PROVIDE FLEXIBLE CANVAS CONNECTORS AT ALL DUCT CONNECTIONS TO EQUIPMENT.
- FURNISH AND INSTALL NEW 1" COPPER CONDENSATE MANIFOLD IN CORRIDOR, GRAVITY PITCHED TO SERVICE SINK. PROVIDE PIPING FROM CONDENSATE PUMP DISCHARGE OF ALL FCUs TO MANIFOLD (NOT SHOWN ON PLANS).
- CONTRACTOR SHALL RUN REFRIGERANT PIPING FROM BRANCH SELECTOR BOXES "BS-" TO HYDRONIC HEAT EXCHANGERS LOCATED IN ATTIC. FOLLOW PIPING DIAGRAM ON SHEETS M-400.
- CONTRACTOR SHALL BALANCE RETURN GRILLES IN EACH ROOM FOR EQUAL PROPORTION OF TOTAL AIR FLOW USING RATES SHOWN FOR SUPPLY DIFFUSERS.
- MECHANICAL CONTRACTOR IS RESPONSIBLE FOR REMOVING AND REINSTALLING CEILING TILES, CEILING GRID SUSPENSION SYSTEM, AND ALL CEILING-MOUNTED DEVICES (TYPICAL). COORDINATE CEILING SCOPE WITH ELECTRICAL, PLUMBING, AND CONTROLS TRADES.

KEY NOTES: (PLEASE NOTE THAT NOT ALL KEYNOTES ARE USED IN EACH PLAN)

- DISCONNECT EXISTING BRANCH DUCT, HANGERS, AND AIR OUTLET. CAP AND SEAL DUCT TRUNK AIRTIGHT.
- EXTEND HW PIPING TO NEW LOCATION. PROVIDE NEW BALL VALVES AS NEEDED. COORDINATE POWER WITH ELECTRICAL CONTRACTOR.

AS PER USA CONGRESS ARCHITECTURAL WORKS COPYRIGHT PROTECTION ACT OF 1990 ALL IDEAS AND DESIGNS INCLUDING DERIVATIVES THEREOF, ALL DRAWINGS AND SPECIFICATIONS CONSTITUTE THE ORIGINAL COPYRIGHT WORK BY FULLER AND D'ANGELO, P.C. (F&D). THE DRAWINGS AND SPECIFICATIONS AS INSTRUMENTS OF SERVICE BY F&D ARE CREATED BY F&D FOR THIS PROJECT ONLY AND REMAIN THE PROPERTY OF F&D. ANY REPRODUCTION WITHOUT THE PRIOR CONSENT OF F&D IS PROHIBITED.

408 E. CHERRYWOOD ROAD ELLENBURG, NY 12828
TEL: 518-898-4444 FAX: 518-898-1171
Copyright 2023 All Rights Reserved by Fuller & D'Angelo, P.C.

FULLER
D'ANGELO
P.C.
ARCHITECTS
PLANNERS

LFG
LANDMARK
FACILITIES
GROUP, INC.
252 East Avenue
Greenville, SC 29615
(203) 866-4624 FAX
(203) 866-4015 FAX


S.E.D. CONTROL NUMBER:
GREENVILLE ELEMENTARY SCHOOL
66-04-06-03-0-008-021
SEELY PLACE ELEMENTARY SCHOOL
66-04-06-03-0-001-019

PROJECT: SEELY PLACE ELEMENTARY SCHOOL
DRAWING TITLE: SECOND FLOOR MECHANICAL PLAN
DRAWING NO.: 21434.01

1-24-2023	ADDENDUM #1
1-06-2023	BID
DATE	ISSUED TO
SHEET SIZE 30"x42"	DRAWING NO. SPES M102
SCALE AS NOTED	FILE NO. 21434.01
DRAWN BY LFG	

PLOT DATE: January 24, 2023 -- 10:54am

FILE: N:\Edgemont School District\Seely Place Elementary Phase 1\ACAD\Mechanical\SPES_M001_200_BID Addendum 1.dwg

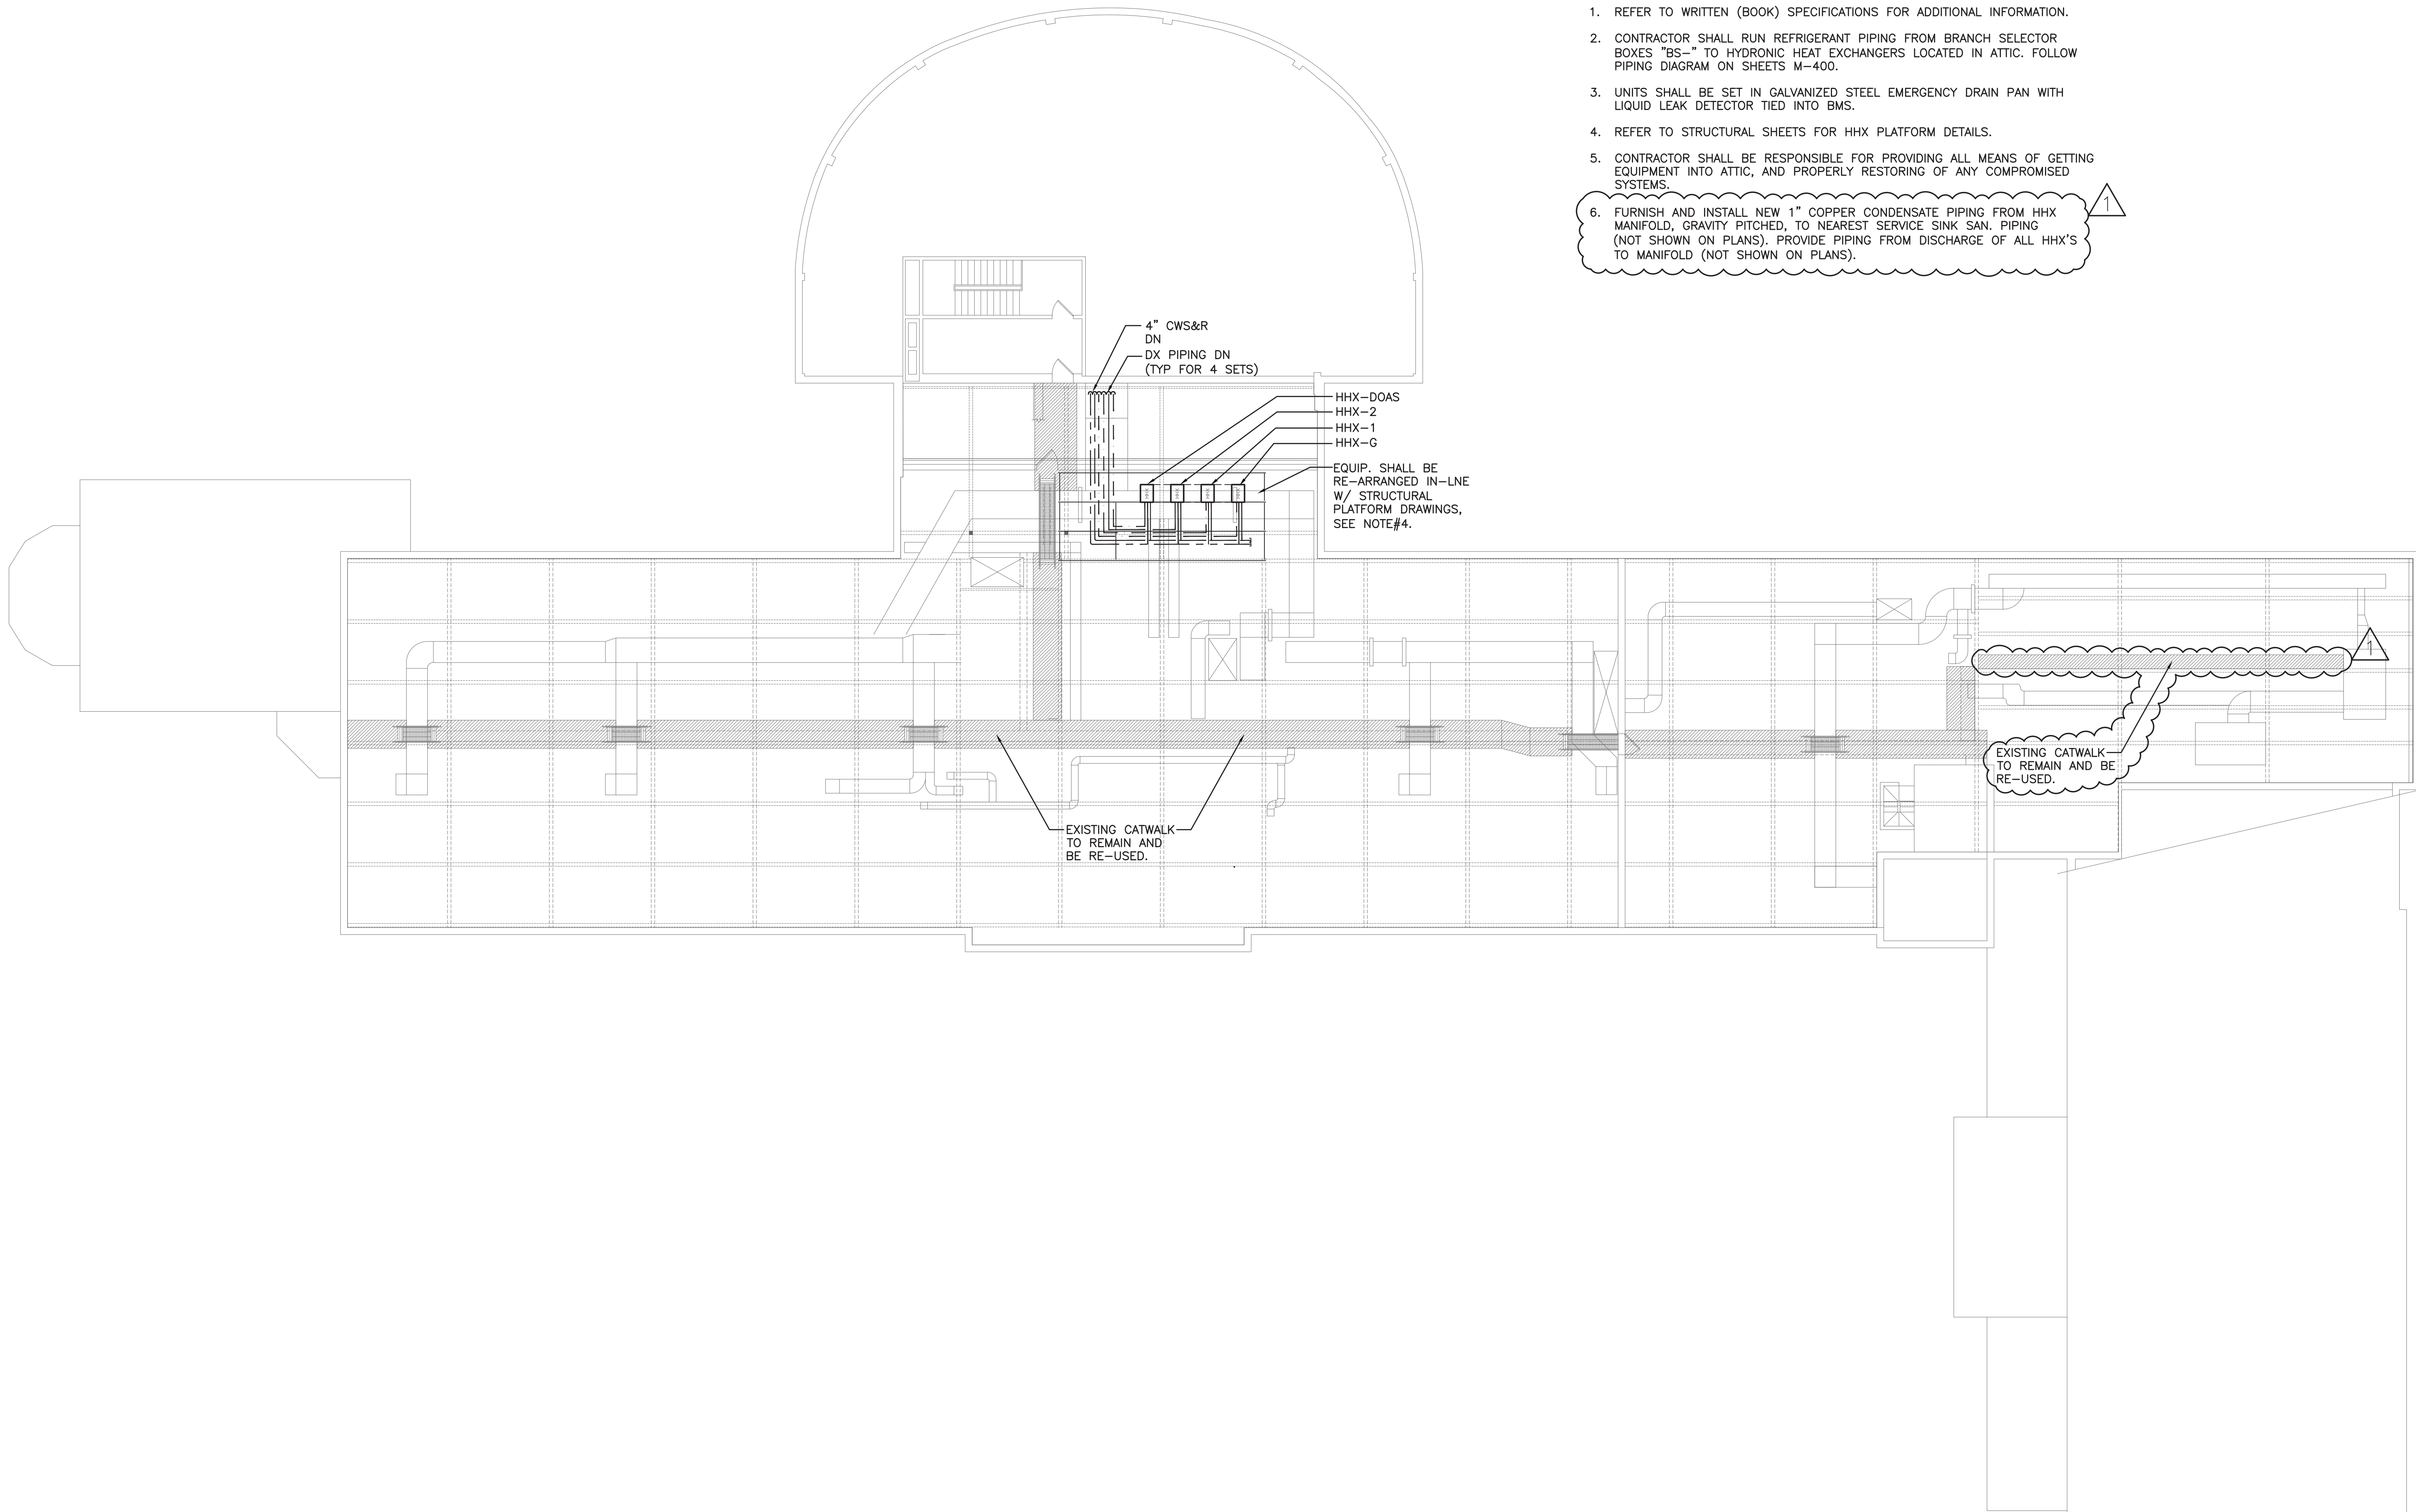


NOTES:

1. REFER TO WRITTEN (BOOK) SPECIFICATIONS FOR ADDITIONAL INFORMATION.
2. CONTRACTOR SHALL RUN REFRIGERANT PIPING FROM BRANCH SELECTOR BOXES "BS-" TO HYDRONIC HEAT EXCHANGERS LOCATED IN ATTIC. FOLLOW PIPING DIAGRAM ON SHEETS M-400.
3. UNITS SHALL BE SET IN GALVANIZED STEEL EMERGENCY DRAIN PAN WITH LIQUID LEAK DETECTOR TIED INTO BMS.
4. REFER TO STRUCTURAL SHEETS FOR HHX PLATFORM DETAILS.
5. CONTRACTOR SHALL BE RESPONSIBLE FOR PROVIDING ALL MEANS OF GETTING EQUIPMENT INTO ATTIC, AND PROPERLY RESTORING OF ANY COMPROMISED SYSTEMS.
6. FURNISH AND INSTALL NEW 1" COPPER CONDENSATE PIPING FROM HHX MANIFOLD, GRAVITY PITCHED, TO NEAREST SERVICE SINK SAN. PIPING (NOT SHOWN ON PLANS). PROVIDE PIPING FROM DISCHARGE OF ALL HHX'S TO MANIFOLD (NOT SHOWN ON PLANS).

SEELY ELEMENTARY SCHOOL

MECHANICAL PLAN - ATTIC

SCALE: 3/32" = 1'-0"

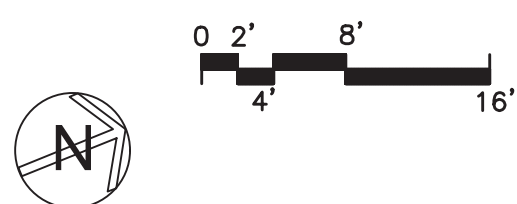

AS PER USA CONGRESS ARCHITECTURAL WORKS COPYRIGHT PROTECTION ACT OF 1990 ALL IDEAS AND DESIGNS INCLUDING DERIVATIVES THEREOF, ALL DRAWINGS AND SPECIFICATIONS CONSTITUTE THE ORIGINAL COPYRIGHT WORK BY FULLER AND D'ANGELO, P.C. (F&D). THE DRAWINGS AND SPECIFICATIONS AS INSTRUMENTS OF SERVICE BY F&D ARE CREATED BY F&D FOR THIS PROJECT ONLY AND REMAIN THE PRODUCT AND PROPERTY OF F&D. ANY REPRODUCTION WITHOUT THE PRIOR CONSENT OF F&D IS PROHIBITED.

408 SHELLWOOD ROAD ELMBROOK NEW YORK 10523
TEL: 914.898-4444 FAX: 914.898-1171
Copyright 2021 All Rights Reserved by FULLER & D'ANGELO, P.C.

FULLER
&
D'ANGELO
P.C.
ARCHITECTS
PLANNERS

LFG
LANDMARK
FACILITIES
GROUP, INC.
252 East Avenue
New Rochelle, NY 10801
(203) 866-4024 FAX
(203) 866-4019



S.E.D. CONTROL NUMBER:
GREENVILLE ELEMENTARY SCHOOL
66-04-06-03-0-001-021
SEELY PLACE ELEMENTARY SCHOOL
66-04-06-03-0-001-019

PROJECT NAME:
EDGEMONT SCHOOL DISTRICT
GREENVILLE ELEMENTARY SCHOOL
SEELY PLACE ELEMENTARY SCHOOL
PHASE 1 - HVAC & CAFETERIA
DRAWING TITLE:
ATTIC MECHANICAL PLAN

1-24-2023	ADDENDUM #1
1-06-2023	BID
DATE	ISSUED TO
SHEET SIZE: 30"x42"	DRAWING NO. SPES M103
SCALE: AS NOTED	FILE NO. 21434.01
DRAWN BY: LFG	

NOTES:

1. REFER TO WRITTEN (BOOK) SPECIFICATIONS FOR ADDITIONAL INFORMATION.
2. MAINTAIN MANUFACTURER'S RECOMMENDED SERVICE CLEARANCES TO ALL EQUIPMENT ON ROOF. DO NOT OBSTRUCT CLEARANCE WITH DUCTWORK OR OTHER OBJECTS.
3. ROOF PENETRATIONS FOR CW PIPING, GAS PIPING, ELECTRICAL POWER AND CONTROL WIRING SHALL BE MADE USING "SIGRIST PIPE CHASE HOUSINGS" AS MANUFACTURED BY ALTA PRODUCTS. SEE DETAIL ON DRAWING M203. PROVIDE SUBMITTAL FOR ENGINEERING REVIEW WITH HOUSING CONFIGURED FOR EACH INDIVIDUAL ROOF PENETRATION.
4. EXISTING ROOF DECK SHALL BE CONSIDERED CONCRETE UNLESS OTHERWISE NOTED.

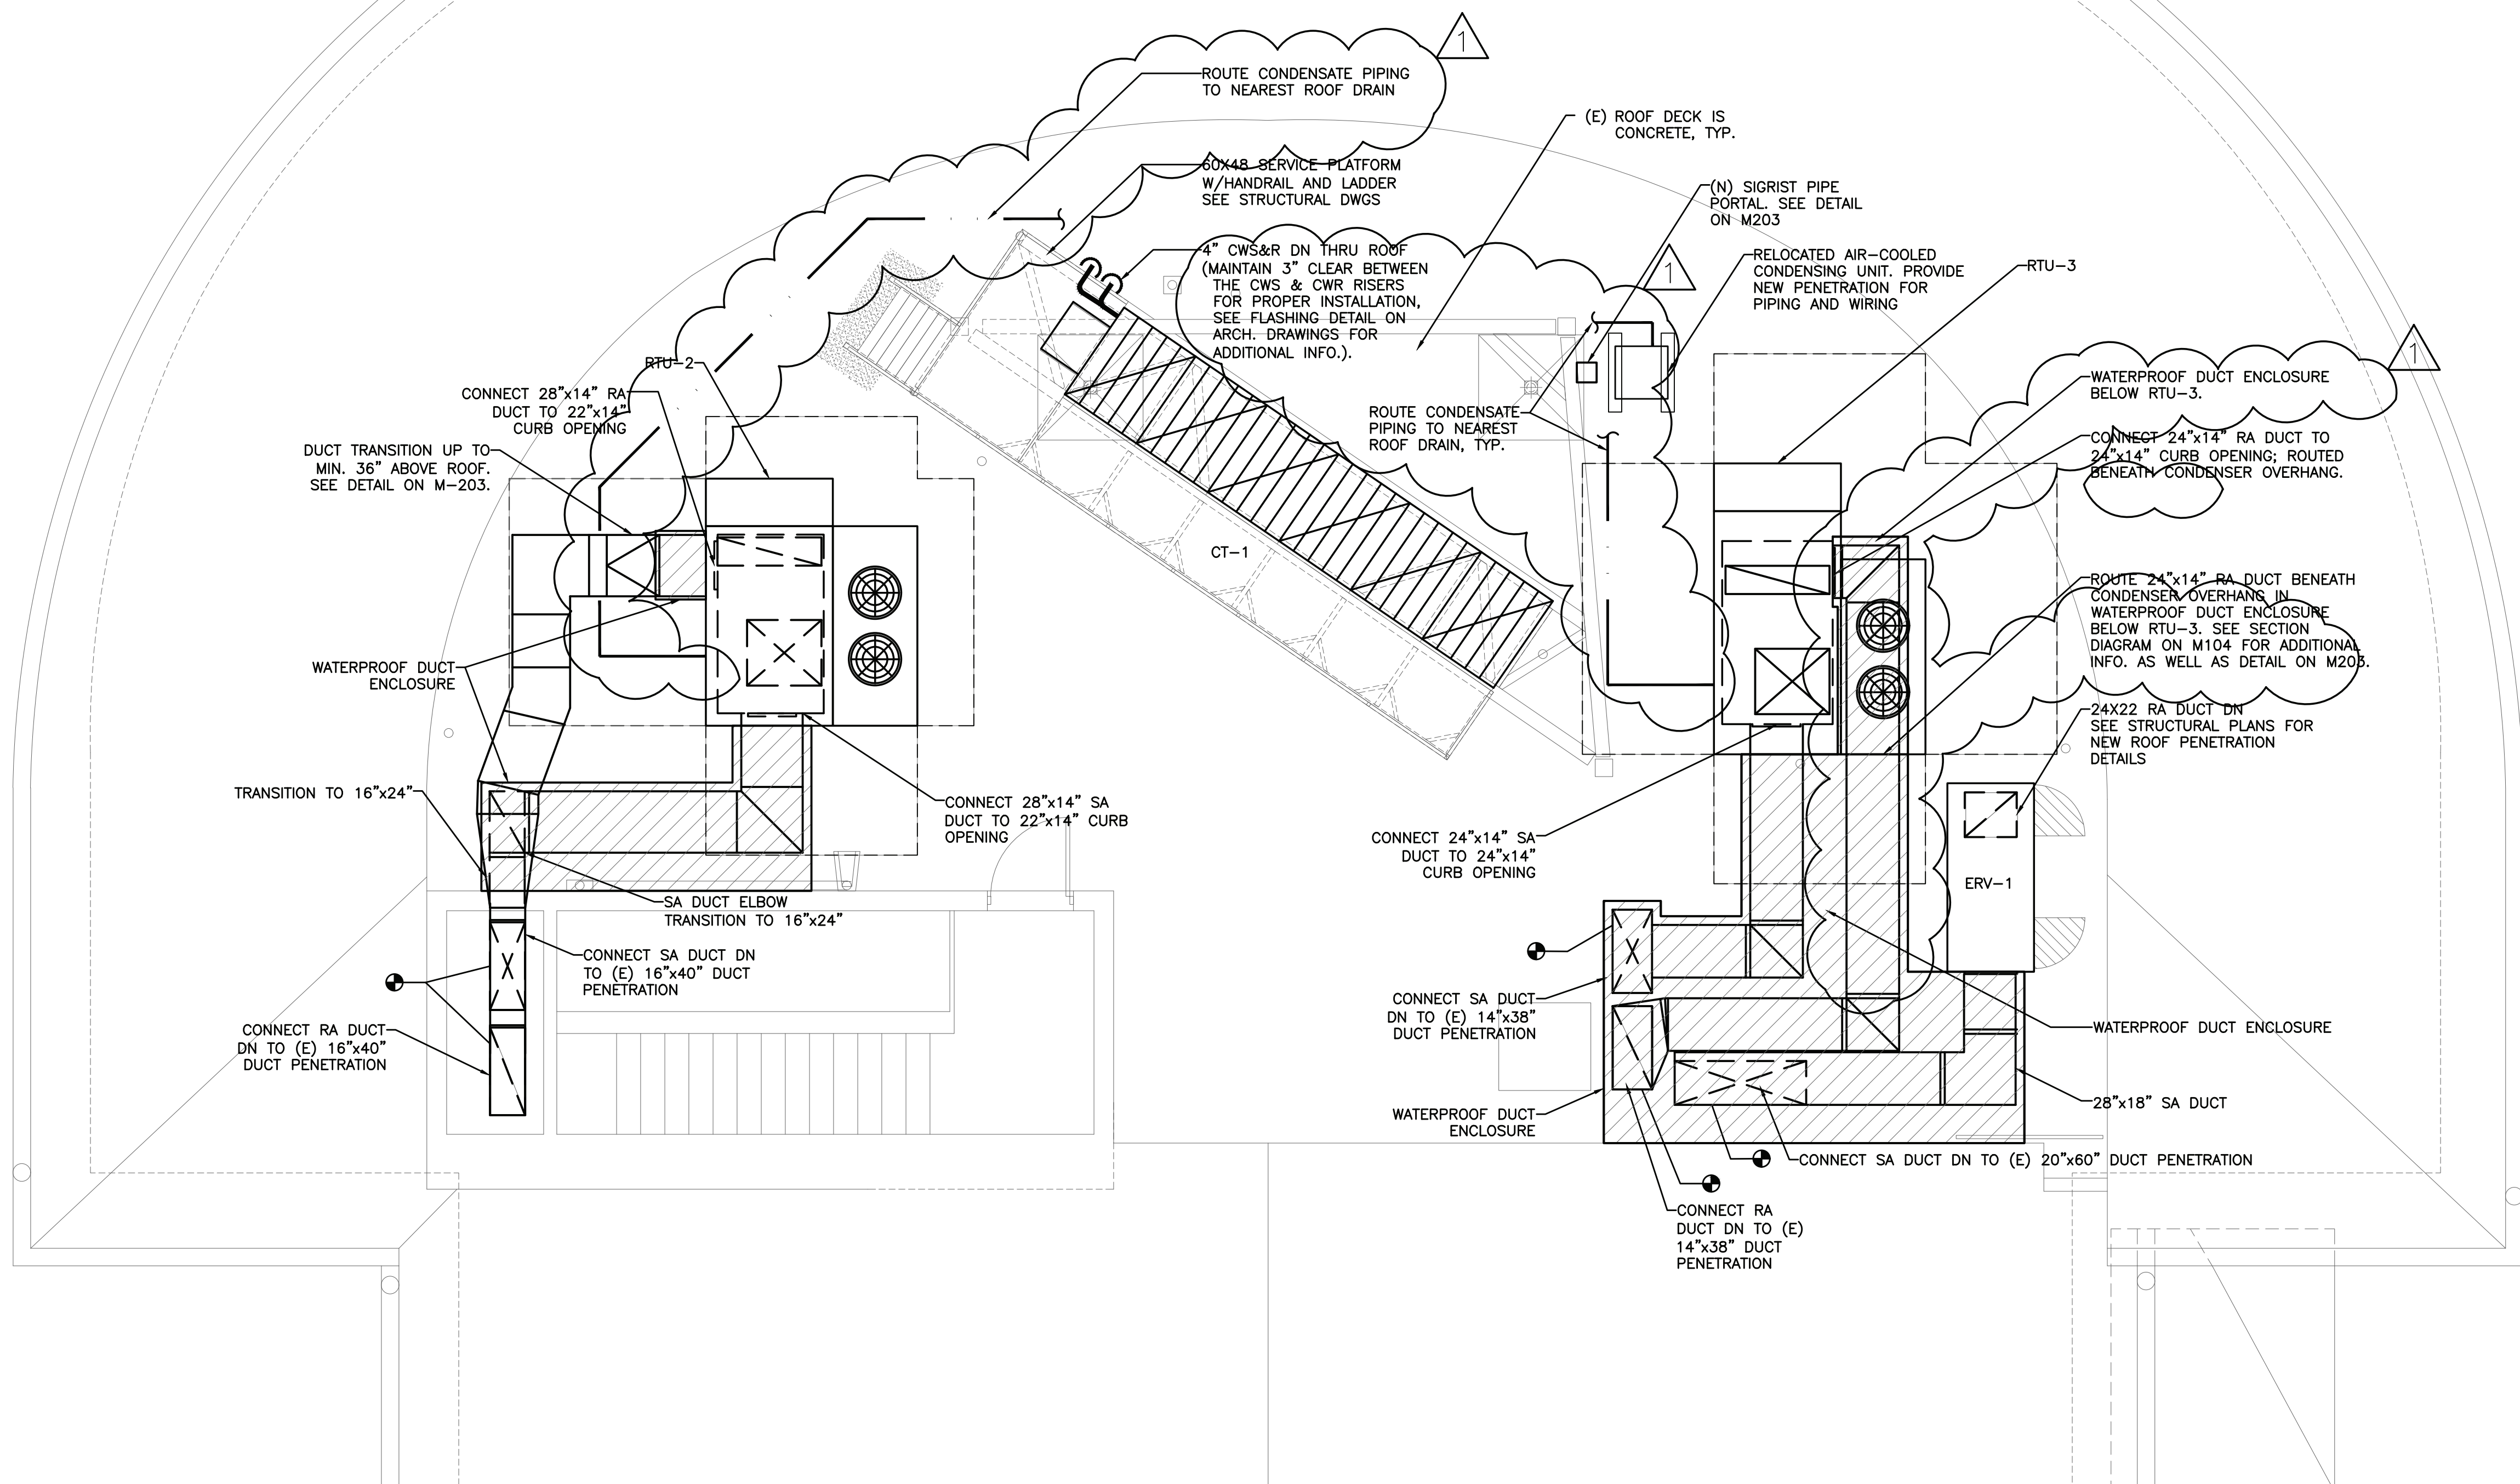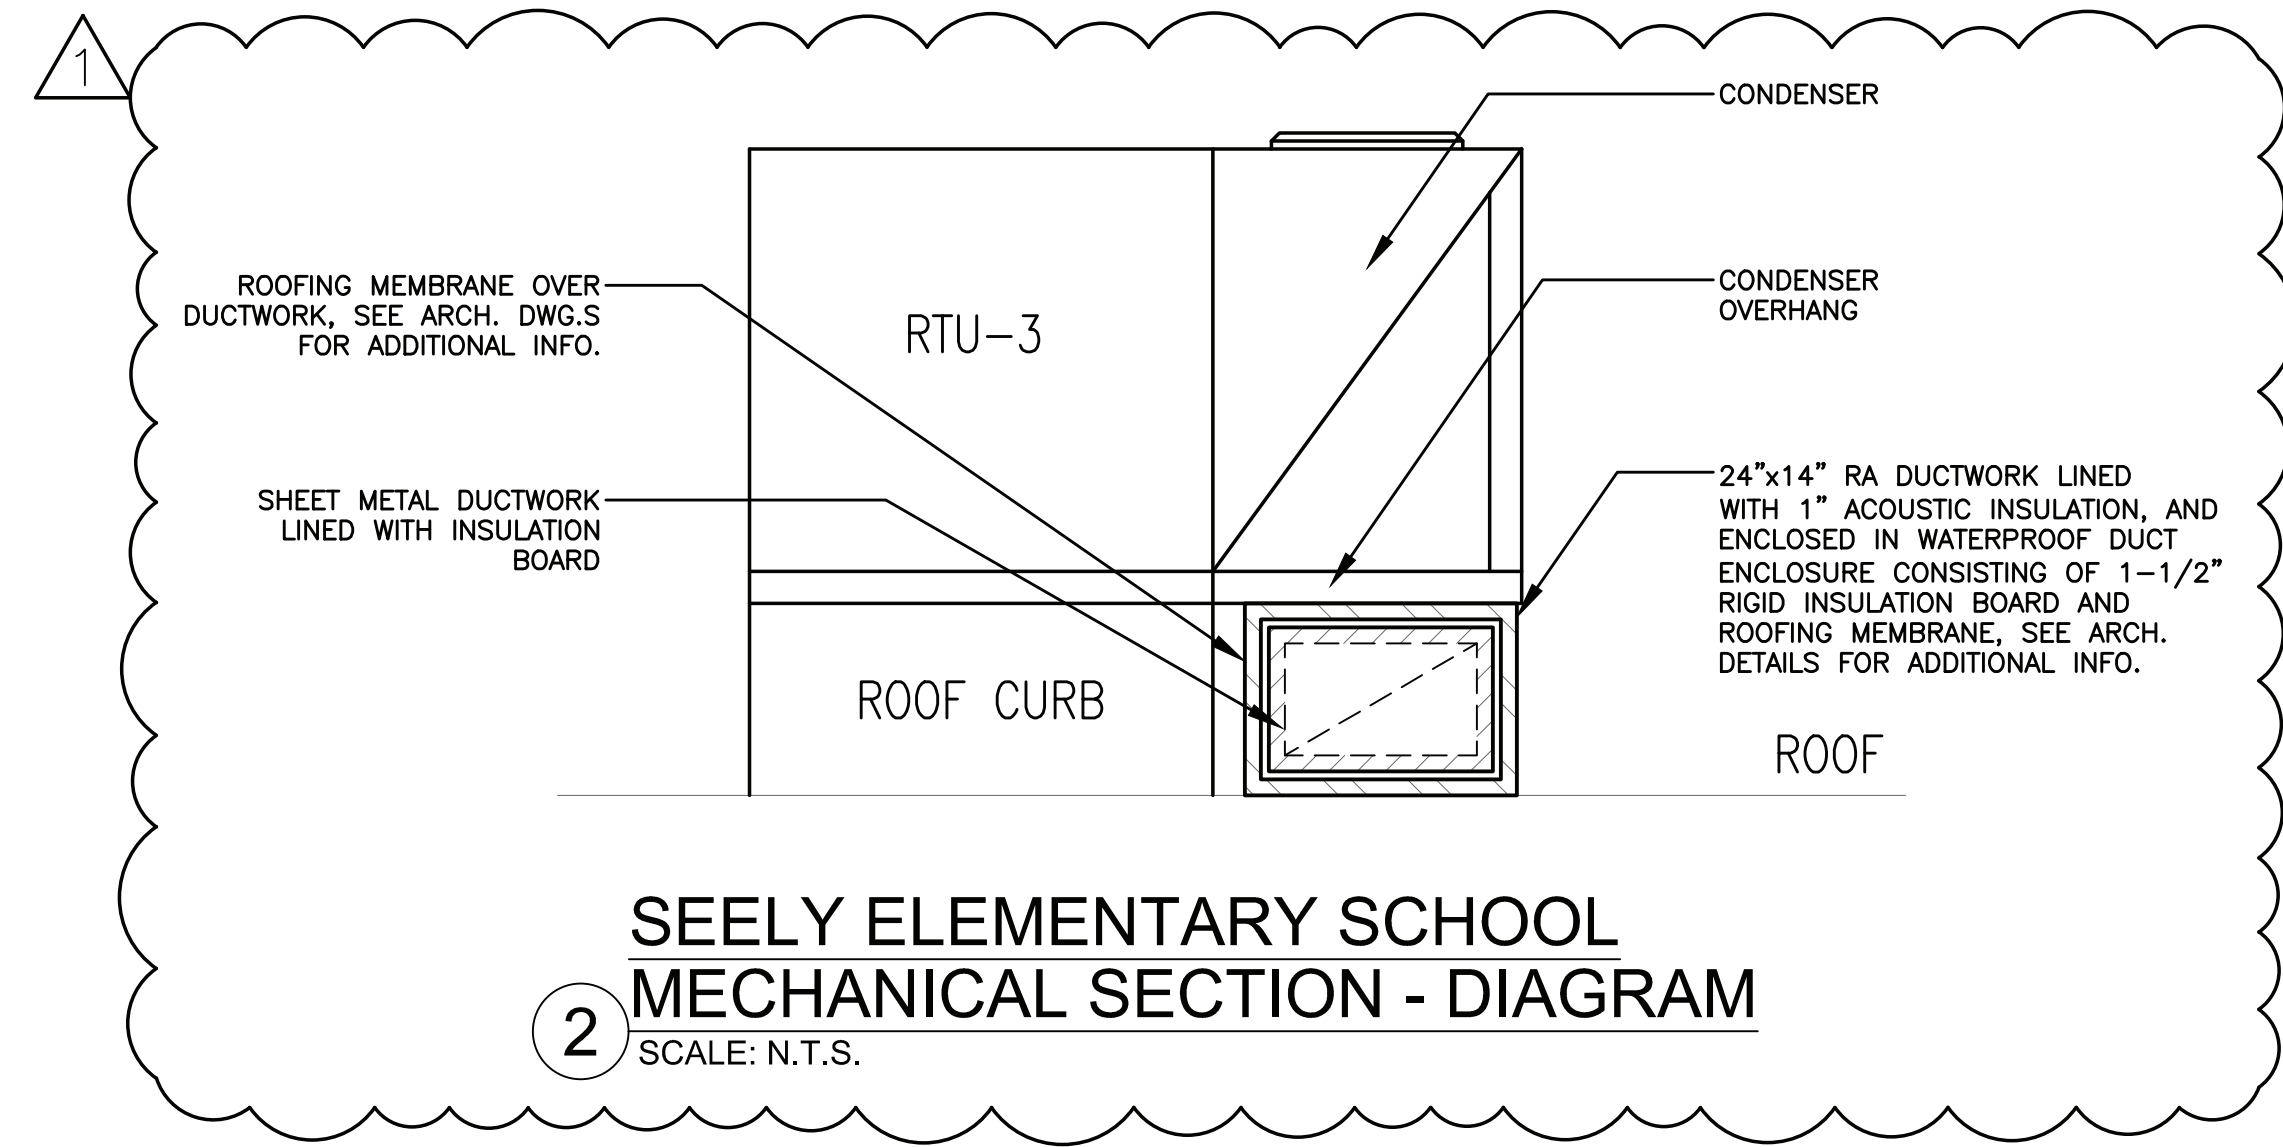

AS PER USA CONGRESS ARCHITECTURAL WORKS COPYRIGHT PROTECTION ACT OF 1990 ALL IDEAS AND DESIGNS INCLUDING DERIVATIVES THEREOF, ALL DRAWINGS AND SPECIFICATIONS CONSTITUTE THE ORIGINAL COPYRIGHT WORK BY FULLER AND D'ANGELO, P.C. (F&D). THE DRAWINGS AND SPECIFICATIONS AS INSTRUMENTS OF SERVICE BY F&D ARE CREATED BY F&D FOR THIS PROJECT ONLY AND REMAIN THE PROPERTY OF F&D. ANY REPRODUCTION WITHOUT THE PRIOR CONSENT OF F&D IS PROHIBITED.

408 SHELLEWORTH ROAD ELLENZBURG NEW YORK 12828
TEL: 814-898-4444 FAX: 814-898-1171
Copyright 2007, All Rights Reserved to Fuller & D'Angelo, P.C.

FULLER
D'ANGELO
P.C.
ARCHITECTS
PLANNERS

LFG
LANDMARK
FACILITIES
GROUP, INC.
252 East Avenue
Greenville, SC 29615
(203) 866-4024 FAX
(203) 866-4015 FAX

S.E.D. CONTROL NUMBER:
GREENVILLE ELEMENTARY SCHOOL
66-04-06-03-0-001-021
SEELY PLACE ELEMENTARY SCHOOL
66-04-06-03-0-001-019


PROJECT:
EDGEMONT SCHOOL DISTRICT
GREENVILLE ELEMENTARY SCHOOL
SEELY PLACE ELEMENTARY SCHOOL
PHASE 1 - HVAC & CAFETERIA

DRAWING TITLE:
ROOF MECHANICAL PLAN

1-08-2023	ADDENDUM #1
1-06-2023	BID
DATE	ISSUED TO
SHEET SIZE: 30"x42"	DRAWING NO. SPES M104
SCALE: AS NOTED	FILE NO. 21434.01
DRAWN BY: LFG	

PLOT DATE: January 24, 2023 -- 10:55am

FILE: N:\Edgemont School District\Seely Place Elementary Phase 1\ACAD\Mechanical\SPES_M001_200_BID Addendum 1.dwg

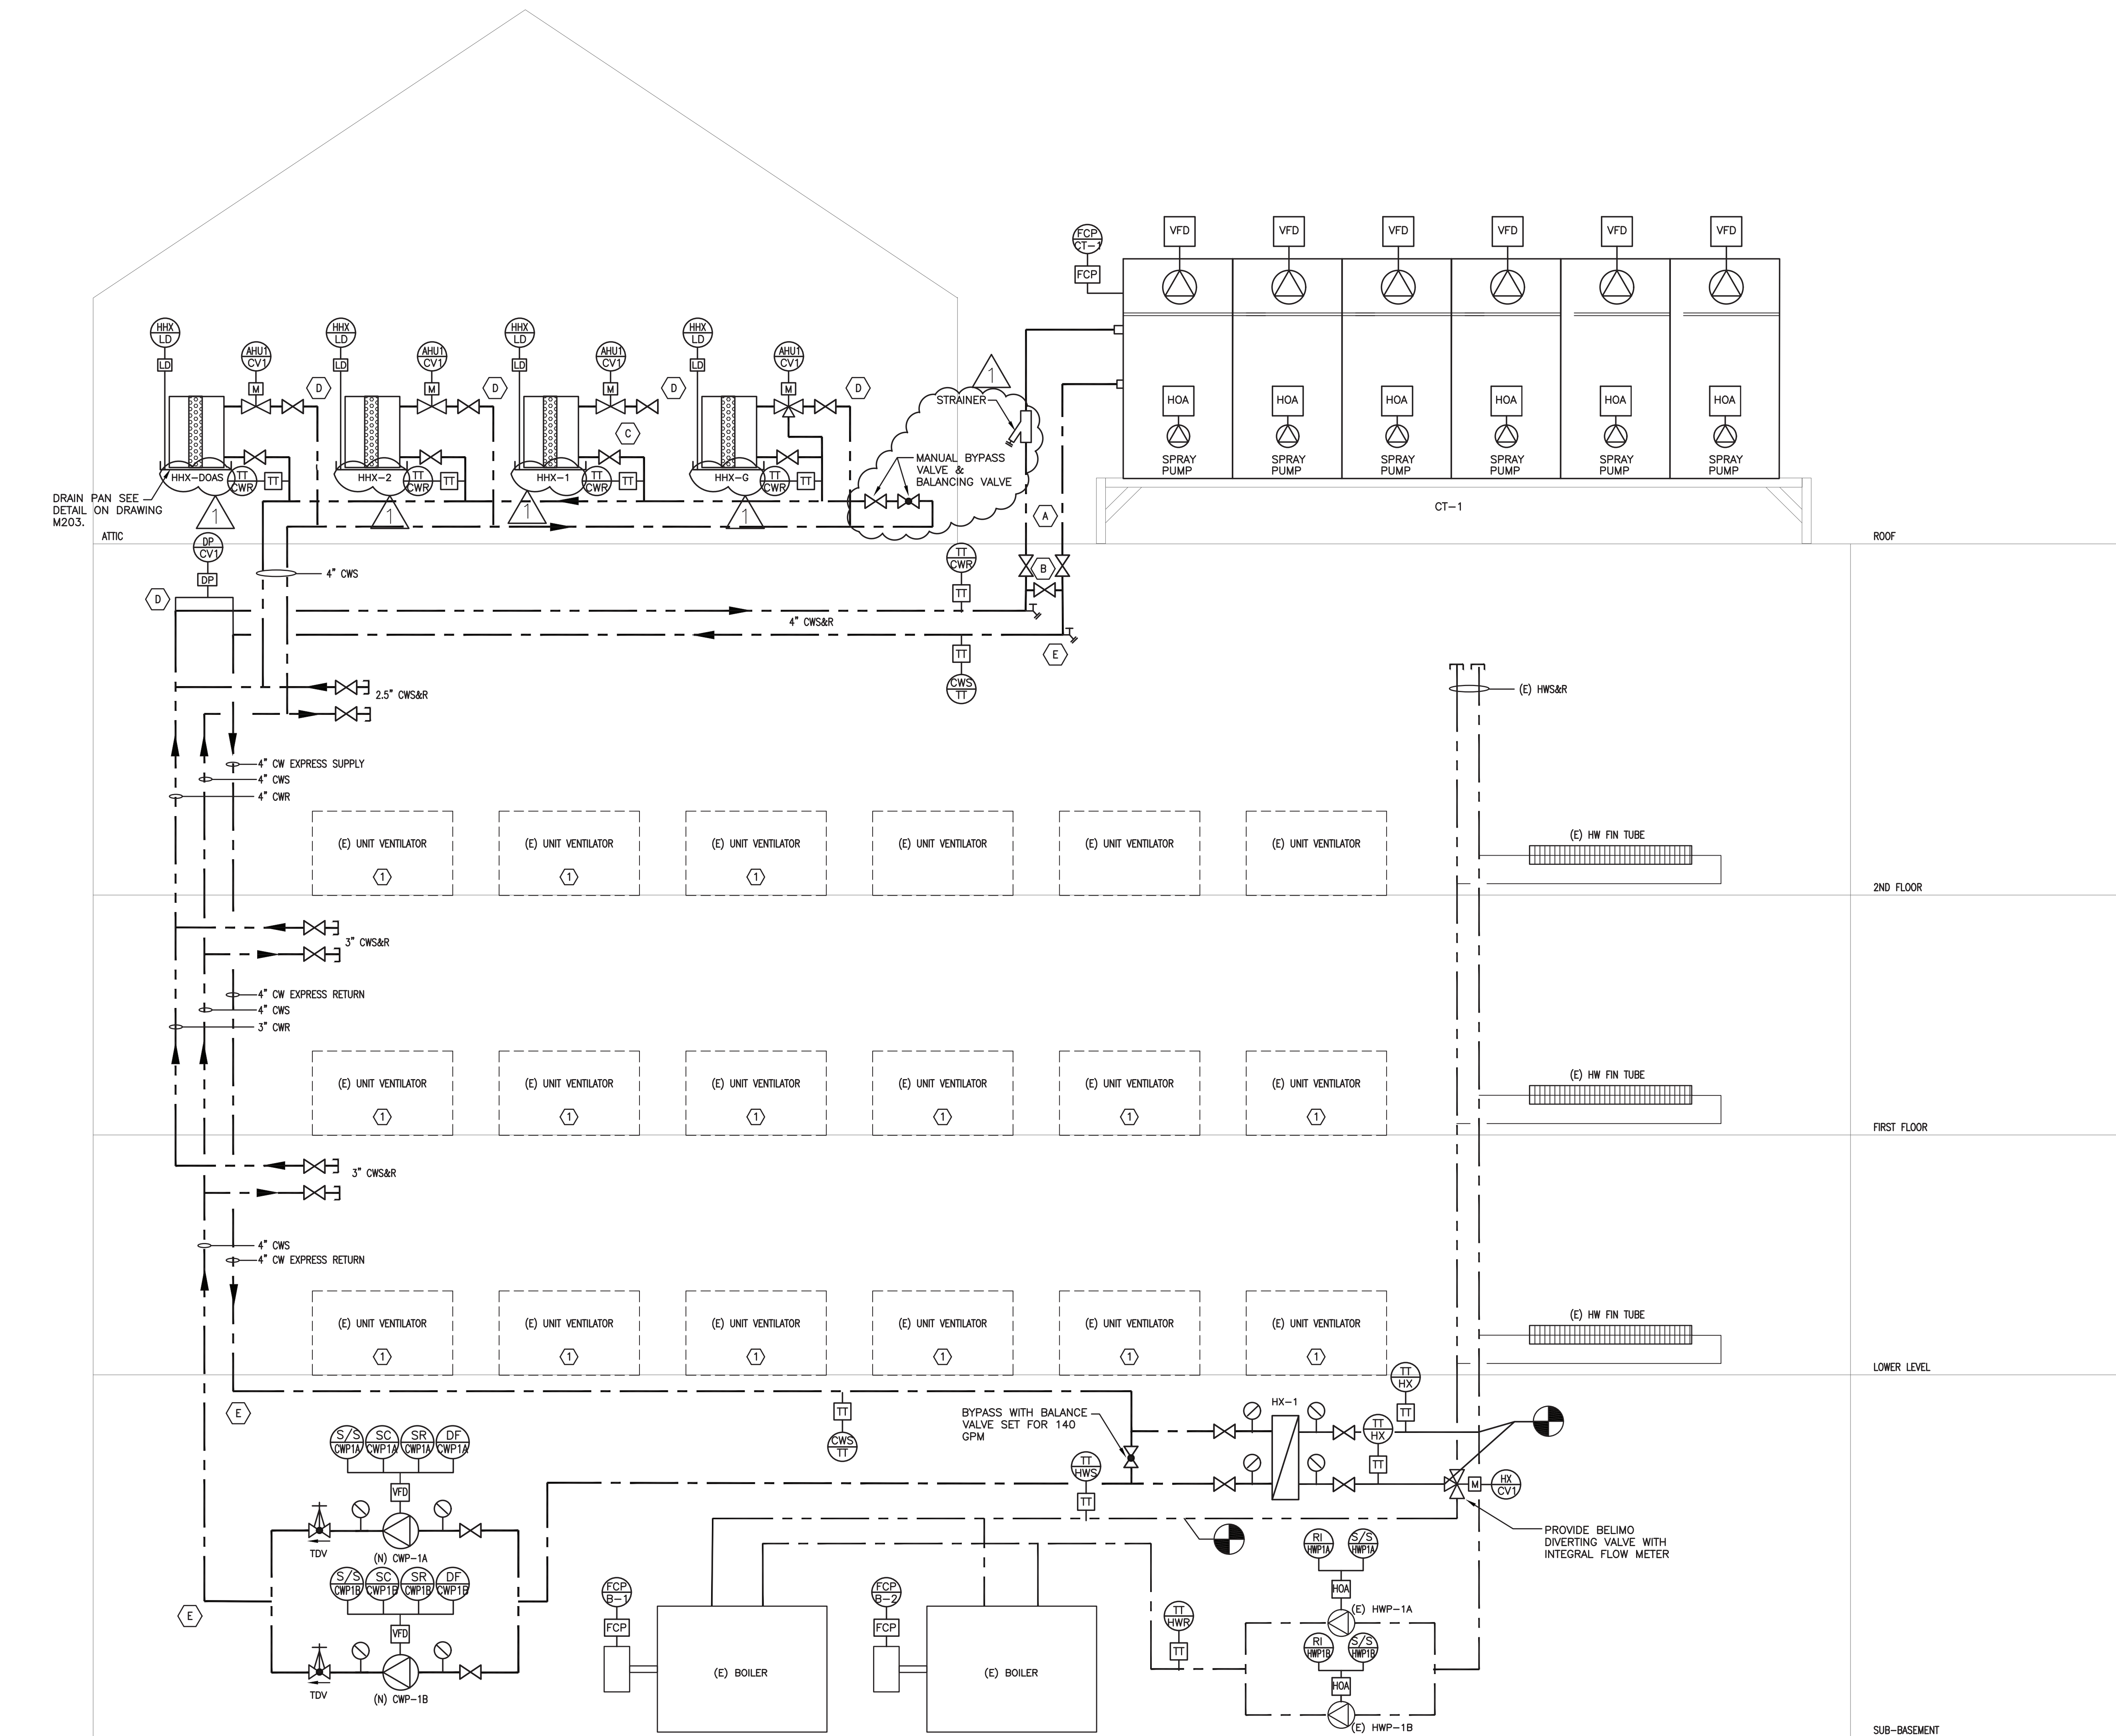

KEY NOTES:

- (A) CW PIPING SHALL TRANSITION FROM SCHED 40 STEEL TO POLYPROPYLENE DIRECTLY BELOW THE ROOF. ALL PIPING ABOVE ROOF LINE SHALL BE POLYPROPYLENE WITH HEAT FUSION JOINTS. PIPING SELECTION IS BASED ON AQUATHERM PP-R.
- (B) PROVIDE MANUAL BYPASS VALVE BELOW ROOF, DIRECTLY BELOW COOLING TOWER.
- (C) AT EACH HYDRONIC HEAT EXCHANGER PROVIDE (2) ISOLATION VALVES, (1) MOTORIZED CONTROL VALVE AND (1) AUTOMATIC BALANCE VALVE.
- (D) PROVIDE AUTOMATIC AIR VENTS AT TOP OF RISERS
- (E) PROVIDE MANUAL DRAINS AT BOTTOM OF RISERS.

GENERAL CONTROL PANEL NOTE:

NETWORK CONTROL PANEL SHALL HAVE 200% CAPACITY TO OFFER SALABILITY IN-ORDER TO ACCOMMODATE FUTURE "PHASE-2" WORK.

AS PER USA CONGRESS ARCHITECTURAL WORKS COPYRIGHT PROTECTION ACT OF 1990 ALL IDEAS AND DESIGNS INCLUDING DERIVATIVES THEREOF, ALL DRAWINGS AND SPECIFICATIONS CONSTITUTE THE ORIGINAL COPYRIGHT WORK BY FULLER AND DANKELO, P.C. (F&D). THE DRAWINGS AND SPECIFICATIONS AS INSTRUMENTS OF SERVICE BY F&D ARE CREATED BY F&D FOR THIS PROJECT ONLY AND REMAIN THE PRODUCT AND PROPERTY OF F&D. ANY REPRODUCTION WITHOUT THE PRIOR CONSENT OF F&D IS PROHIBITED.

408 SHELLEWOOD ROAD ELLENBORO NEW YORK 12828
TEL: 814.898.4444 FAX: 814.898.1171
Copyright 2023 All Rights Reserved FULLER & DANKELO, P.C.


FULLER
D'ANGELO
P.C.
ARCHITECTS
PLANNERS

LFG
LANDMARK
FACILITIES
GROUP, INC.
252 East Avenue
Greenville, SC 29601
(253) 866-4024 FAX
(253) 866-4019 FAX


S.E.D. CONTROL NUMBER:
GREENVILLE ELEMENTARY SCHOOL
66-04-06-03-0-001-021
SEELY PLACE ELEMENTARY SCHOOL
66-04-06-03-0-001-019

PROJECT:
EDGEMONT SCHOOL DISTRICT
GREENVILLE ELEMENTARY SCHOOL
SEELY PLACE ELEMENTARY SCHOOL
PHASE 1 - HVAC & CRETERIA
DRAWING TITLE
MECHANICAL PIPING & CONTROLS
DIAGRAM


1-24-2023	ADDENDUM #1
1-06-2023	BID
DATE	ISSUED TO
SHEET SIZE 30"x42"	DRAWING NO. SPES M200
SCALE AS NOTED	FILE NO. 21434.01
DRAWN BY LFG	

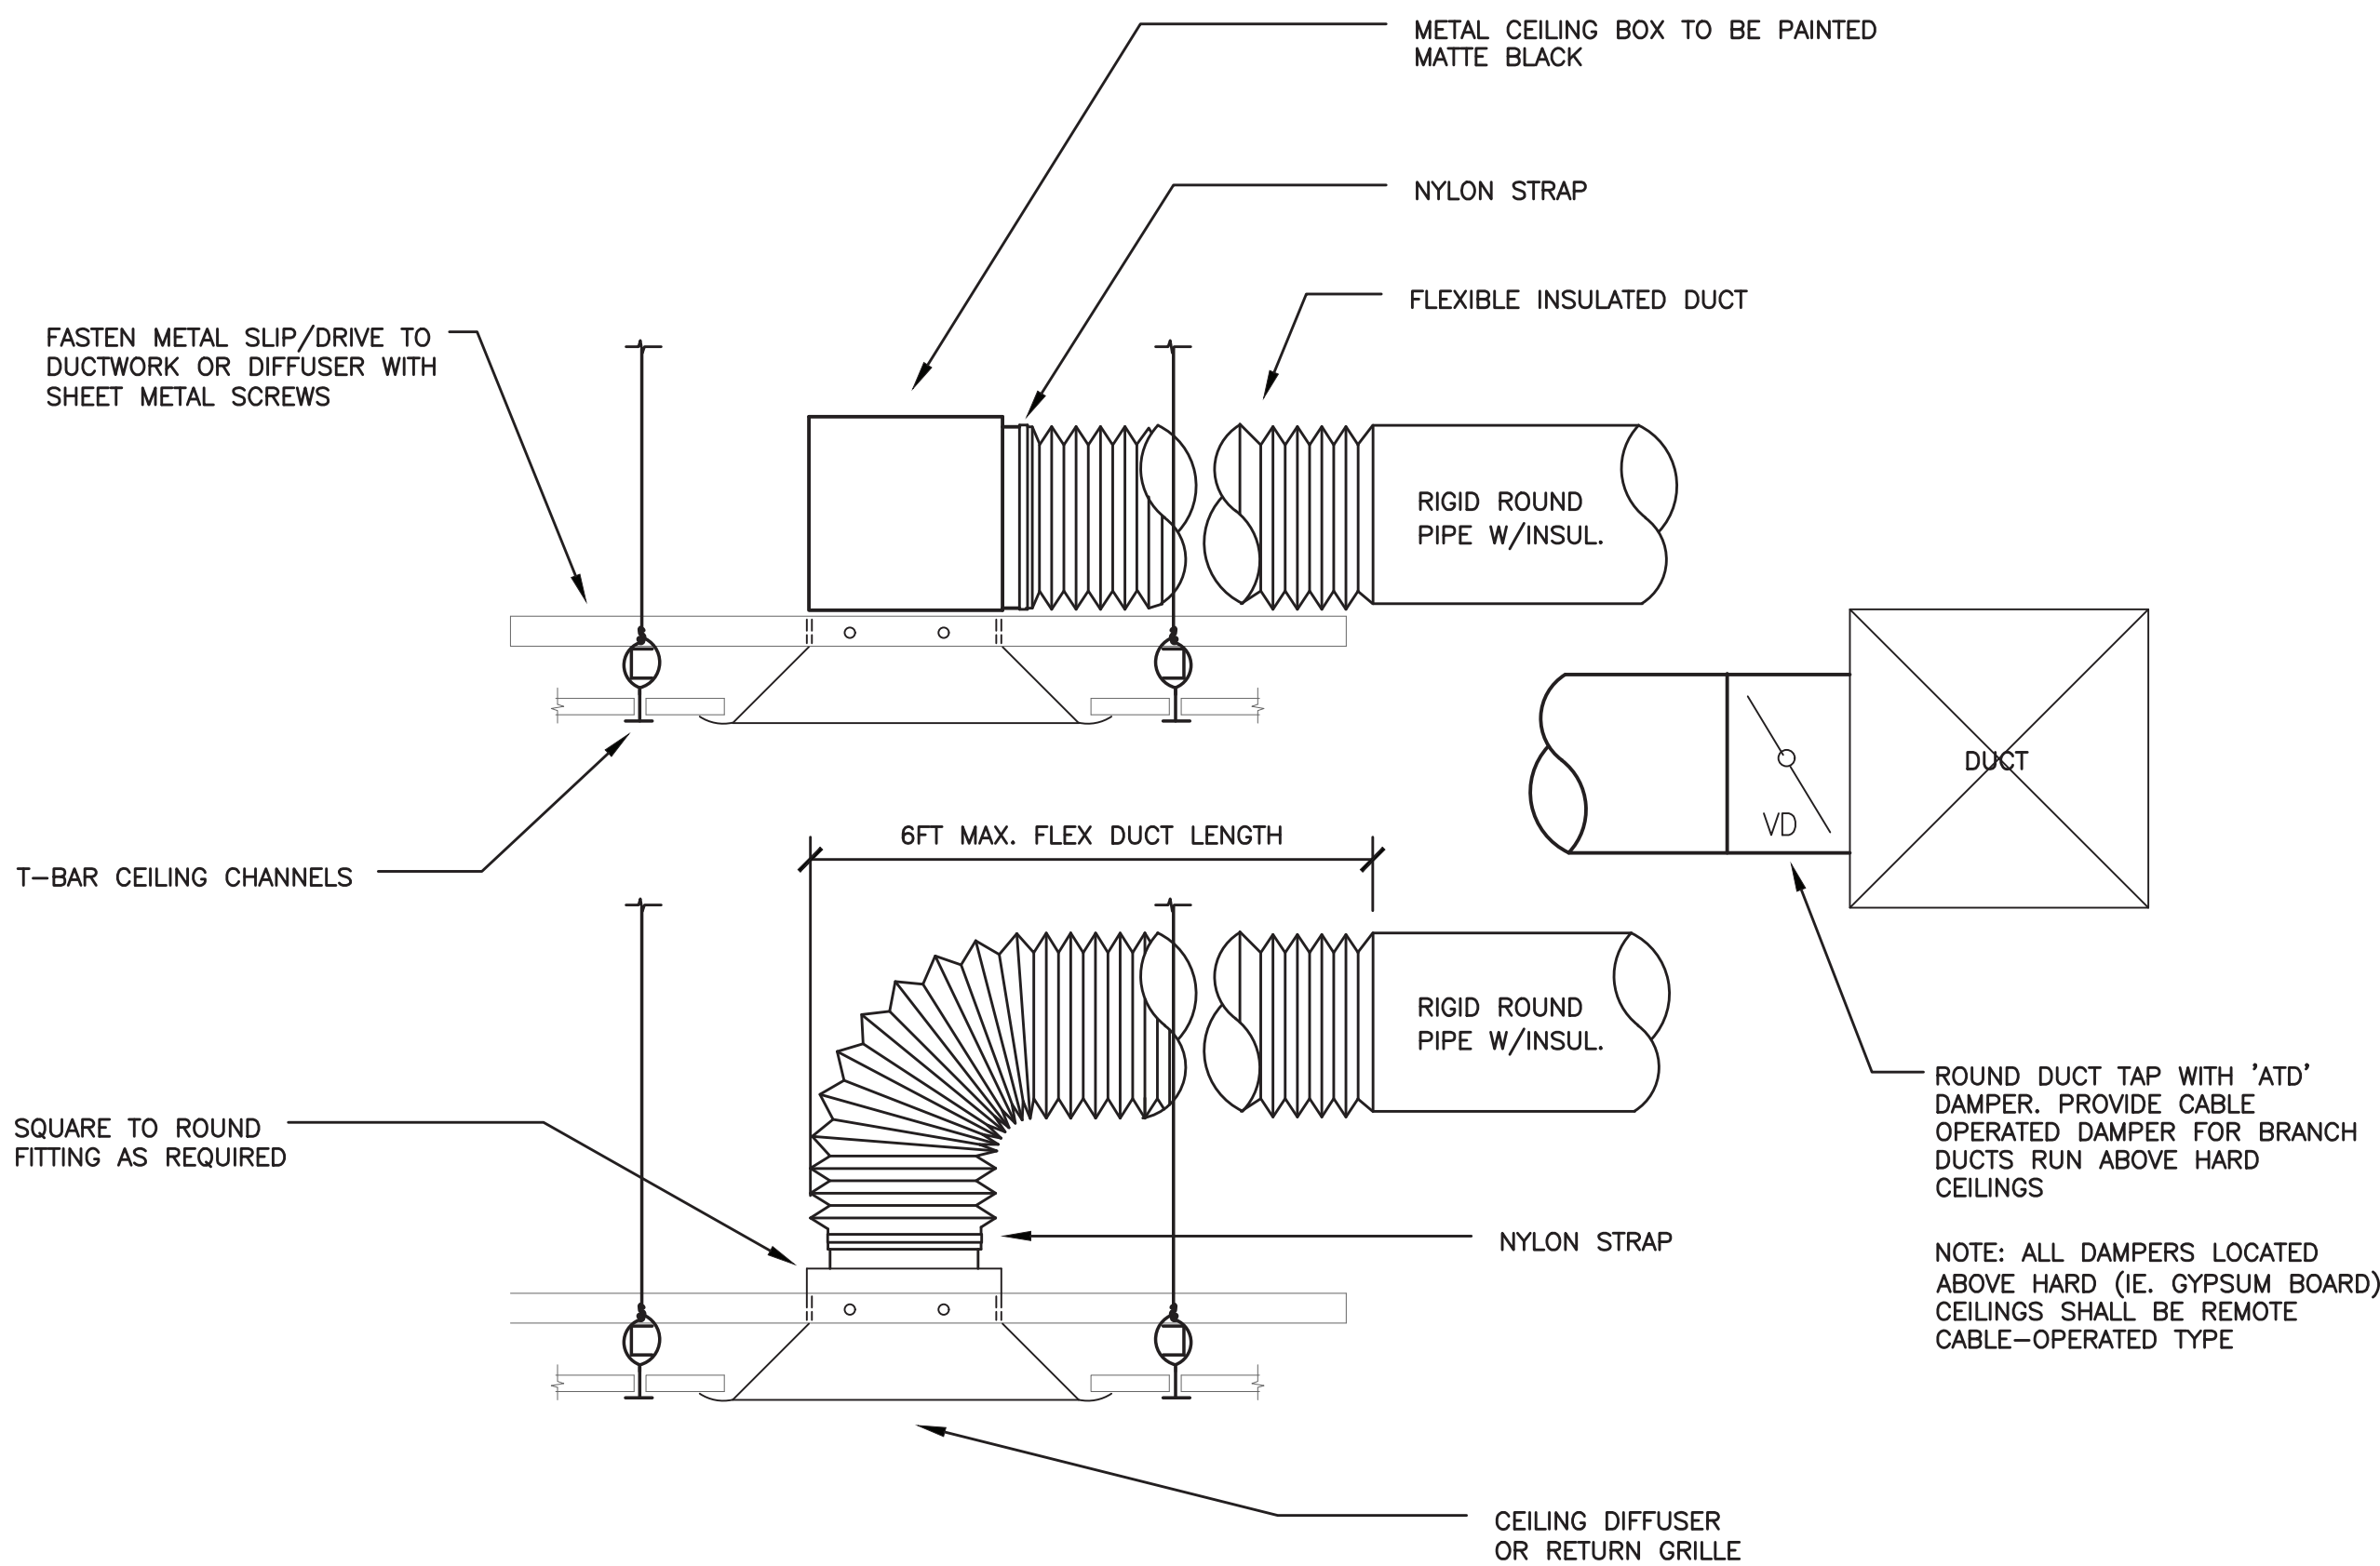


BRANCH DUCT DETAIL
NOT TO SCALE

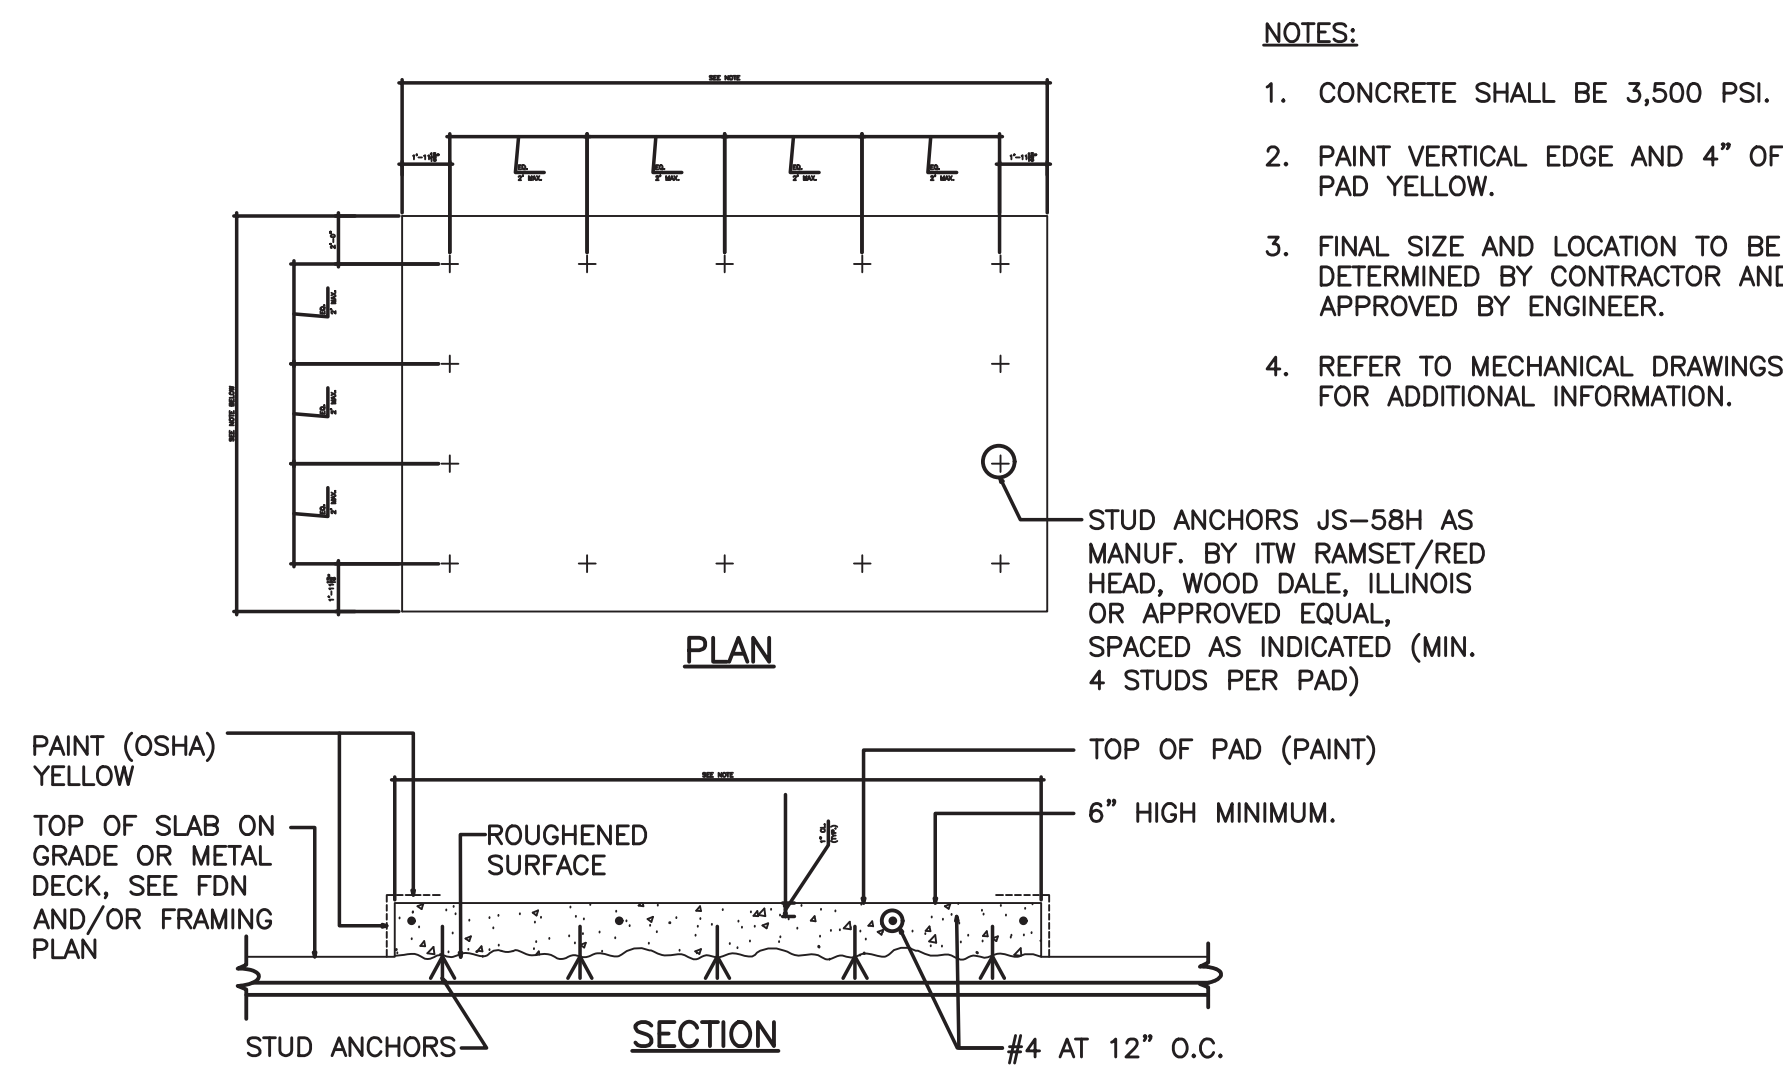

CONCRETE EQUIPMENT PAD
NO SCALE

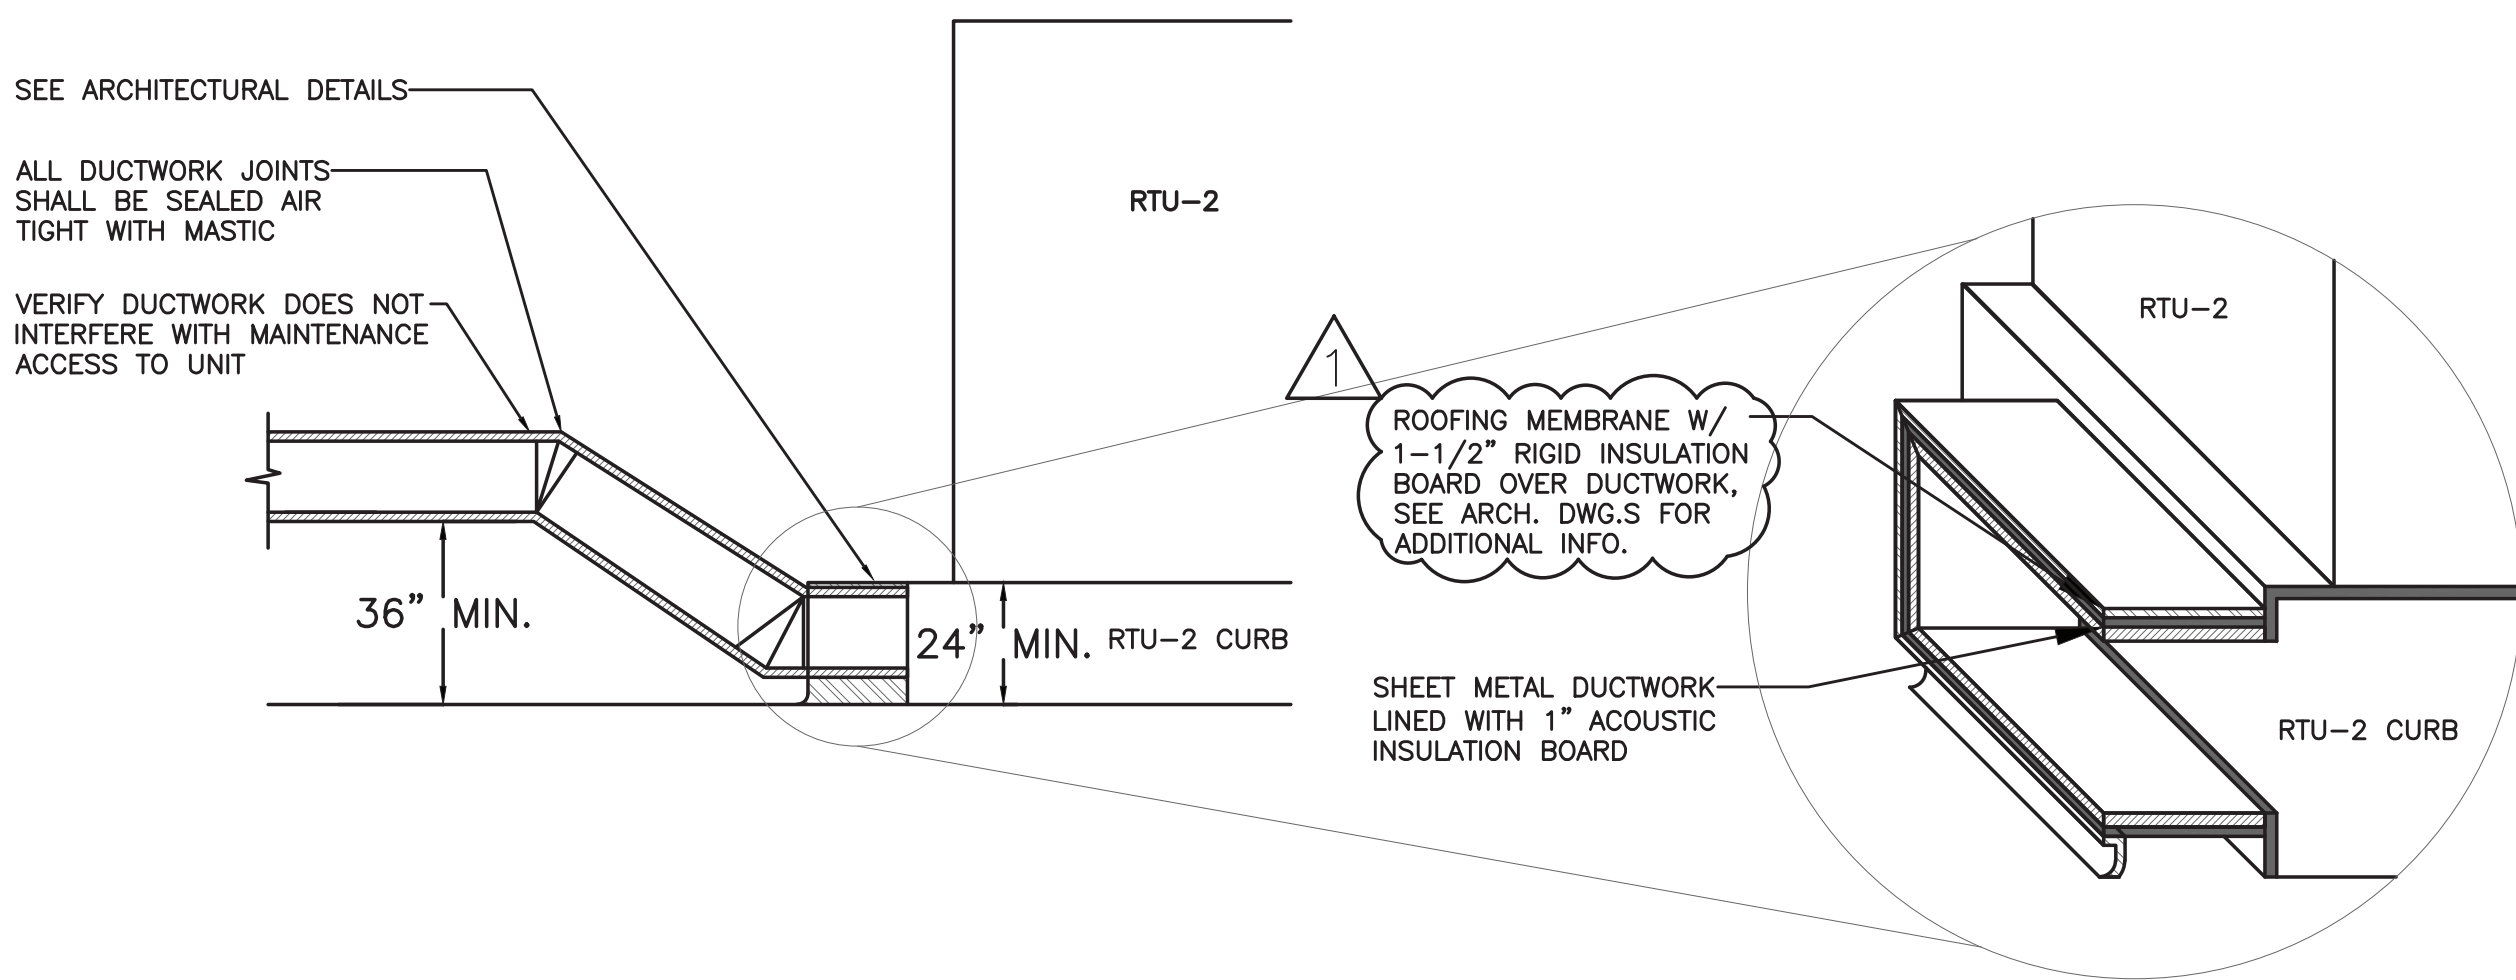

RTU-2 RETURN DUCTWORK DETAIL
NO SCALE

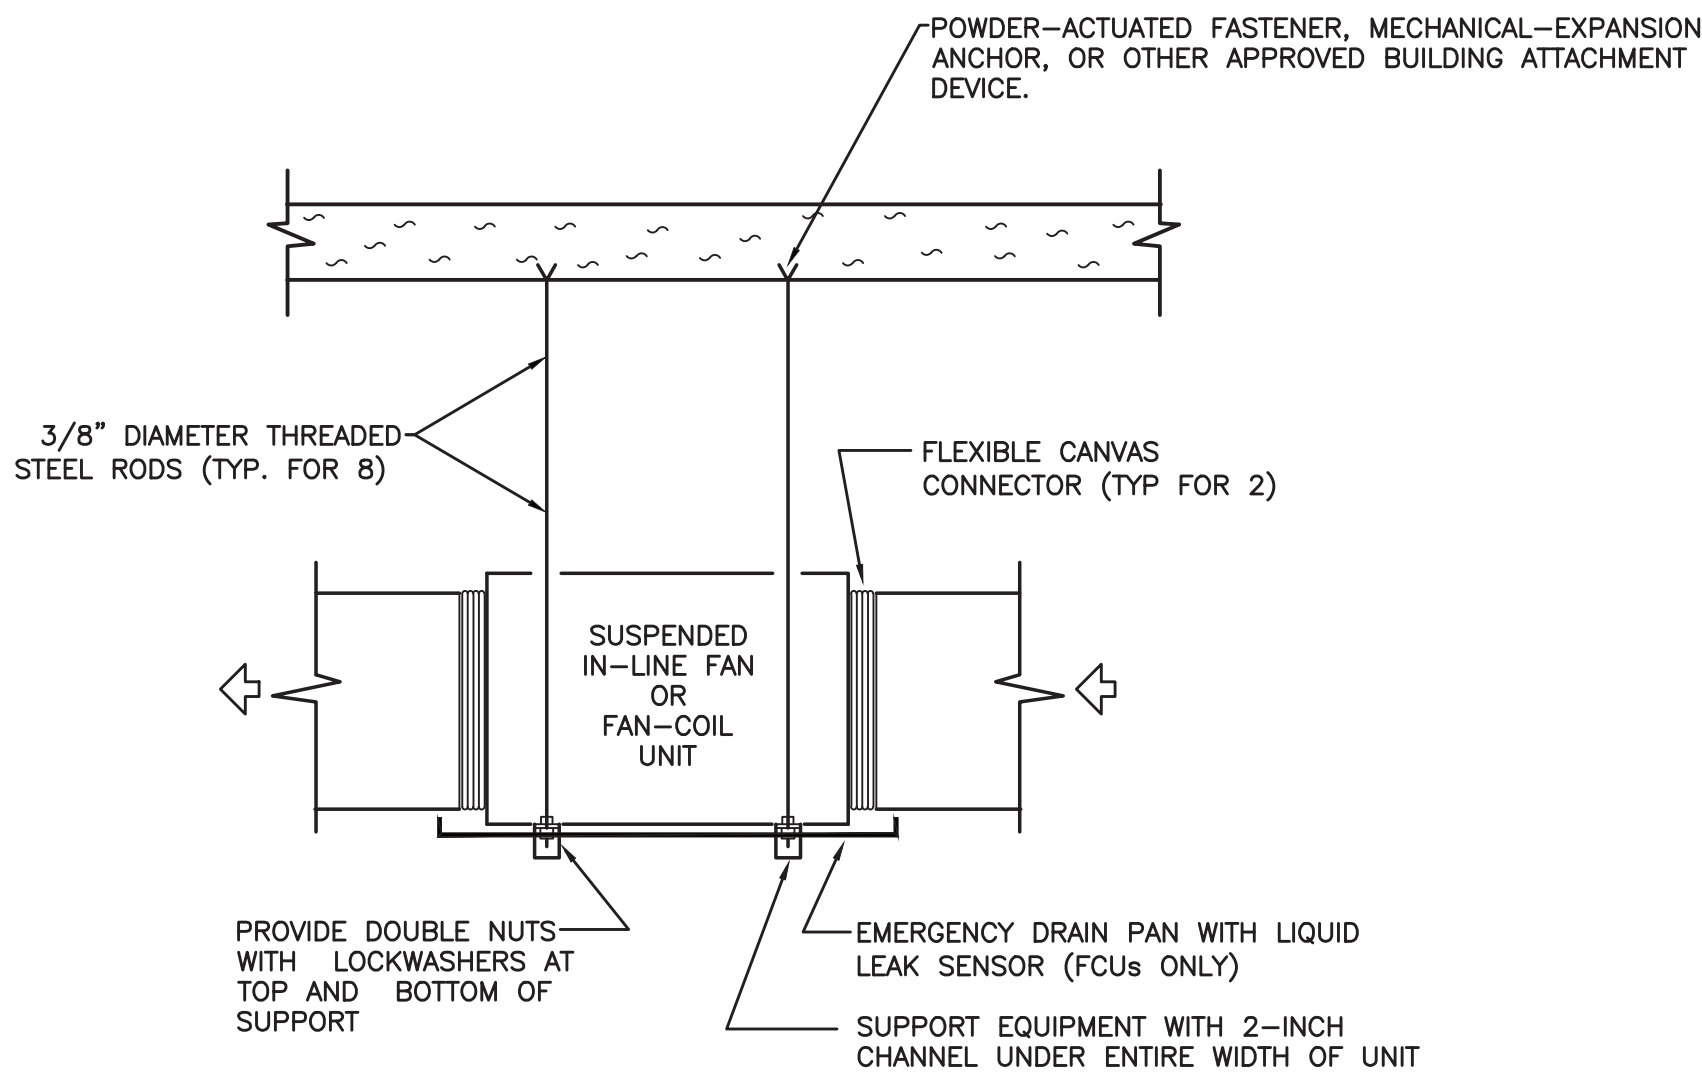

SUSPENDED EQUIPMENT DETAIL
TYPICAL FOR CEILING-MOUNTED FAN-COIL UNITS
AND EXHAUST FANS
NO SCALE


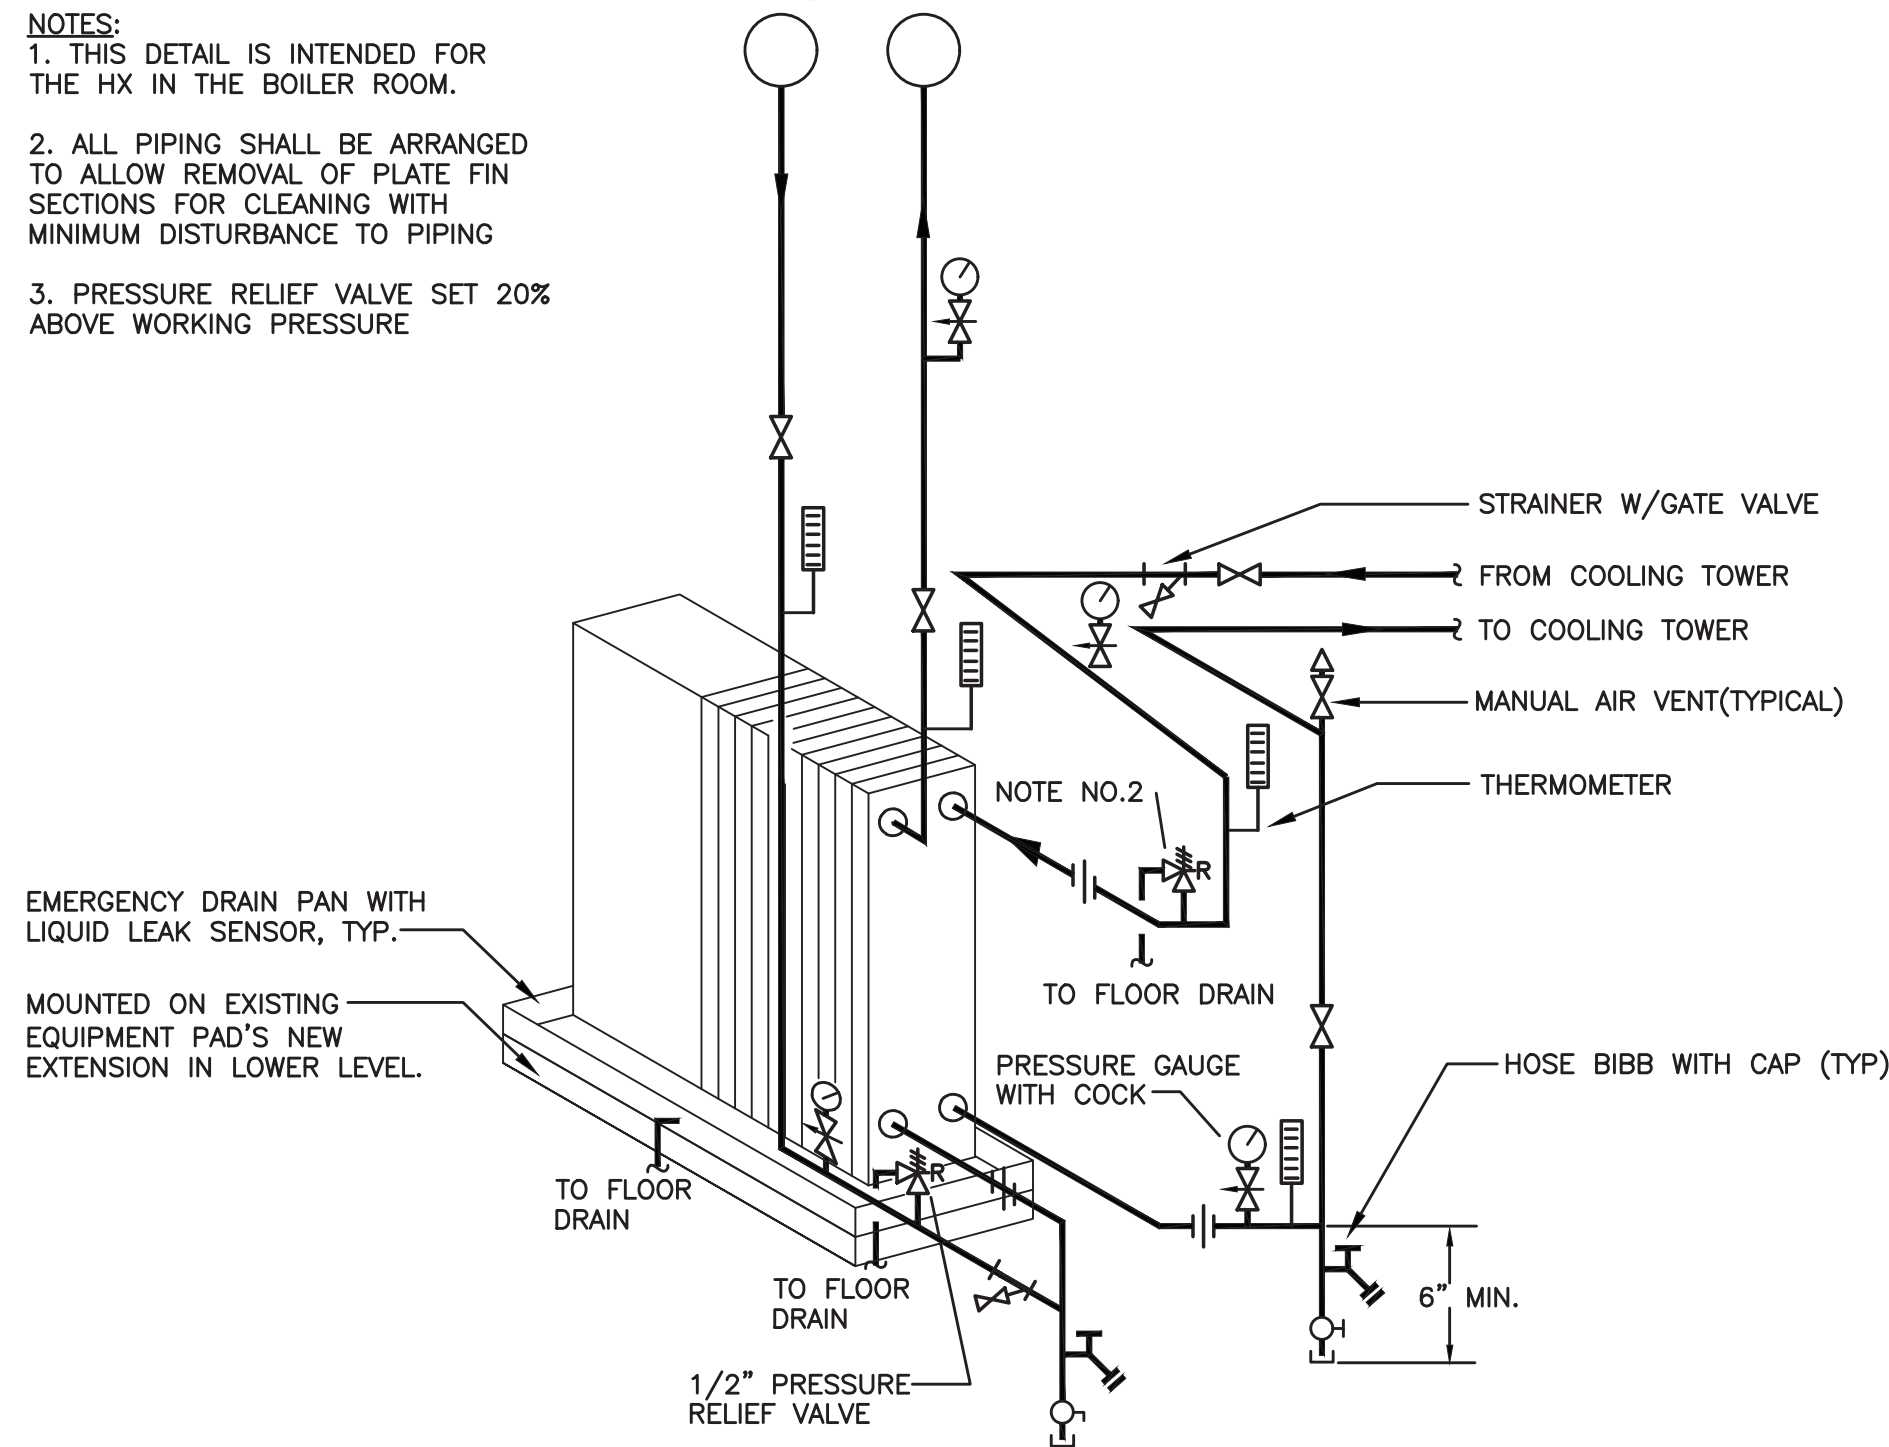


PLATE FRAME HEAT EXCHANGER PIPING (HX-1)
NO SCALE

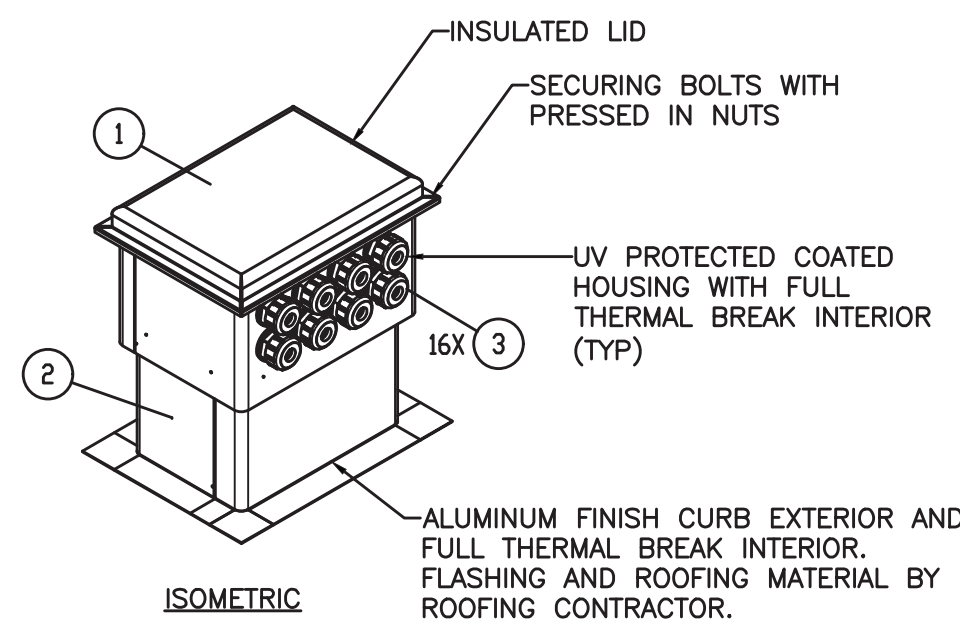

PIPE PORTAL DETAIL
NO SCALE

ITEM NO.	NOMENCLATURE	PART NUMBER	QTY.
1	MEDIUM HOUSING	AL-201412	1
2	MEDIUM CURB 14" TALL	AL-1014C	1
3	SIGRIST EXIT SEAL	N/A	16

AS PER USA CONGRESS ARCHITECTURAL WORKS COPYRIGHT PROTECTION ACT OF 1990 ALL IDEAS AND DESIGNS INCLUDING DERIVATIVES THEREOF, ALL DRAWINGS AND SPECIFICATIONS CONSTITUTE THE ORIGINAL COPYRIGHT WORK BY FULLER AND DANKELO, P.C. (F&D). THE DRAWINGS AND SPECIFICATIONS AS INSTRUMENTS OF SERVICE BY F&D ARE CREATED BY F&D FOR THIS PROJECT ONLY AND REMAIN THE PROPERTY OF F&D. ANY REPRODUCTION WITHOUT THE PRIOR CONSENT OF F&D IS PROHIBITED.

408 SHELLEWOOD ROAD ELmhurst, IL 60120
TEL: 815.898.4444 FAX: 815.898.1171
Copyright 2021 All Rights Reserved by FULLER & DANKELO, P.C.

FULLER
& DANKELO
P.C.
ARCHITECTS
PLANNERS

LFG
LANDMARK
FACILITIES
GROUP, INC.
252 East Avenue
Suite 200
Chicago, IL 60601
(312) 866-4024 FAX
(312) 866-4015

S.E.D. CONTROL NUMBER:
GREENVILLE ELEMENTARY SCHOOL
66-04-06-03-0-001-021
SEELY PLACE ELEMENTARY SCHOOL
66-04-06-03-0-001-019

PROJECT
EDGEMONT SCHOOL DISTRICT
GREENVILLE ELEMENTARY SCHOOL
SEELY PLACE ELEMENTARY SCHOOL
PHASE 1 - HVAC & CATERIA

DRAWING TITLE
MECHANICAL DETAILS

1-24-2023	ADDENDUM #1
1-06-2023	BID
DATE	ISSUED TO
SHEET SIZE 30"x42"	DRAWING NO. SPES M203
SCALE AS NOTED	FILE NO. 21434.01
DRAWN BY LFG	


$\triangle 1$ ACK

AIR FL	
TOTAL	

BRANCH DUCT SCHEDULE

1

E	G	I	N

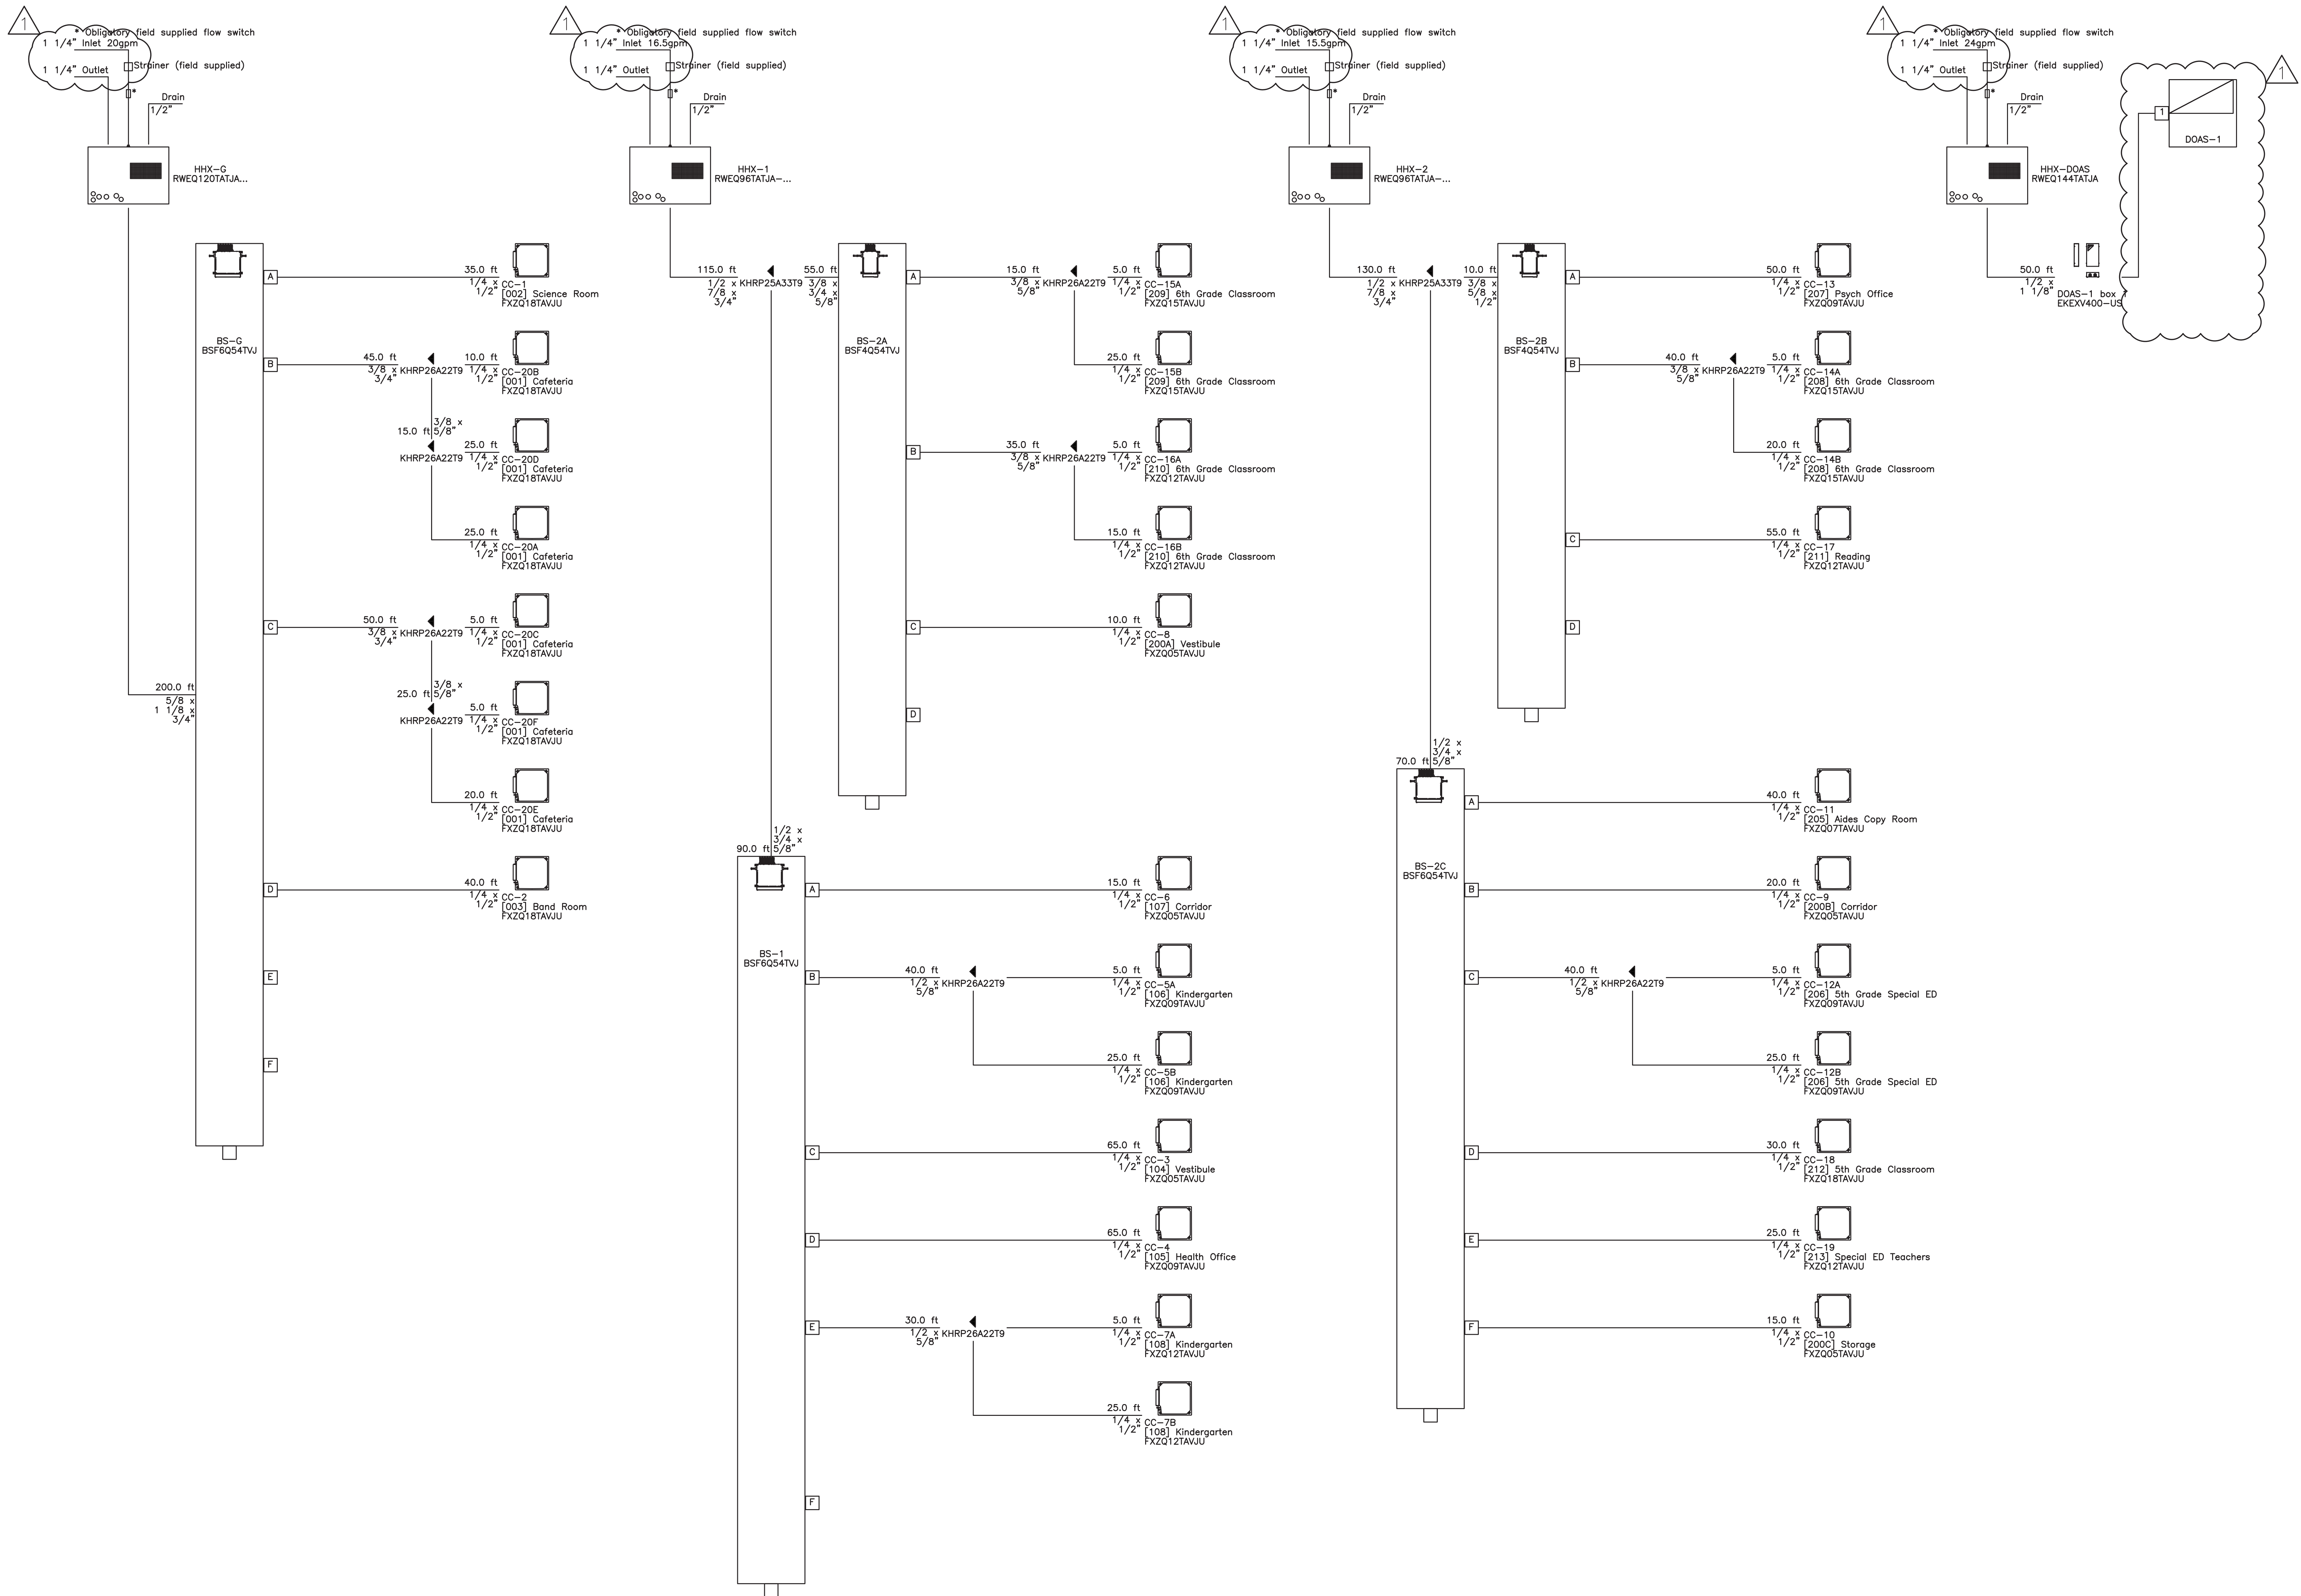

AS PER USA CONGRESS ARCHITECTURAL WORKS COPYRIGHT PROTECTION ACT OF 1990 ALL IDEAS AND DESIGNS INCLUDING DERIVATIVES THEREOF, ALL DRAWINGS AND SPECIFICATIONS CONSTITUTE THE ORIGINAL COPYRIGHT WORK BY FULLER AND DANSELO, P.C. (F&D). THE DRAWINGS AND SPECIFICATIONS AS INSTRUMENTS OF SERVICE BY F&D ARE CREATED BY F&D FOR THIS PROJECT ONLY AND REMAIN THE PRODUCT AND PROPERTY OF F&D. ANY REPRODUCTION WITHOUT THE PRIOR CONSENT OF F&D IS PROHIBITED.

408 SHELLEWOOD ROAD ELMBROOK NEW YORK 10829
TEL: 914.898.4444 FAX: 914.898.1717
Copyright 2021 All Rights Reserved by FULLER & DANSELO, P.C.

FULLER
DANSELO
P.C.
ARCHITECTS
PLANNERS


LFG
LANDMARK
FACILITIES
GROUP, INC.
252 East Avenue
Greenville, SC 29615
(253) 866-4024
(253) 866-4019 Fax

S.E.D. CONTROL NUMBER:
GREENVILLE ELEMENTARY SCHOOL
66-04-06-03-0-001-021
SEELY PLACE ELEMENTARY SCHOOL
66-04-06-03-0-001-019

PROJECT:
EDGEMONT SCHOOL DISTRICT
GREENVILLE ELEMENTARY SCHOOL
SEELY PLACE ELEMENTARY SCHOOL
PHASE 1 - HVAC & CAFETERIA

DRAWING TITLE
MECHANICAL PIPING DIAGRAMS

1-24-2023	ADDENDUM #1
1-06-2023	BID
DATE	ISSUED TO
SHEET SIZE 30"x42"	DRAWING NO. SPES M400
SCALE AS NOTED	FILE NO. 21434.01
DRAWN BY LFG	

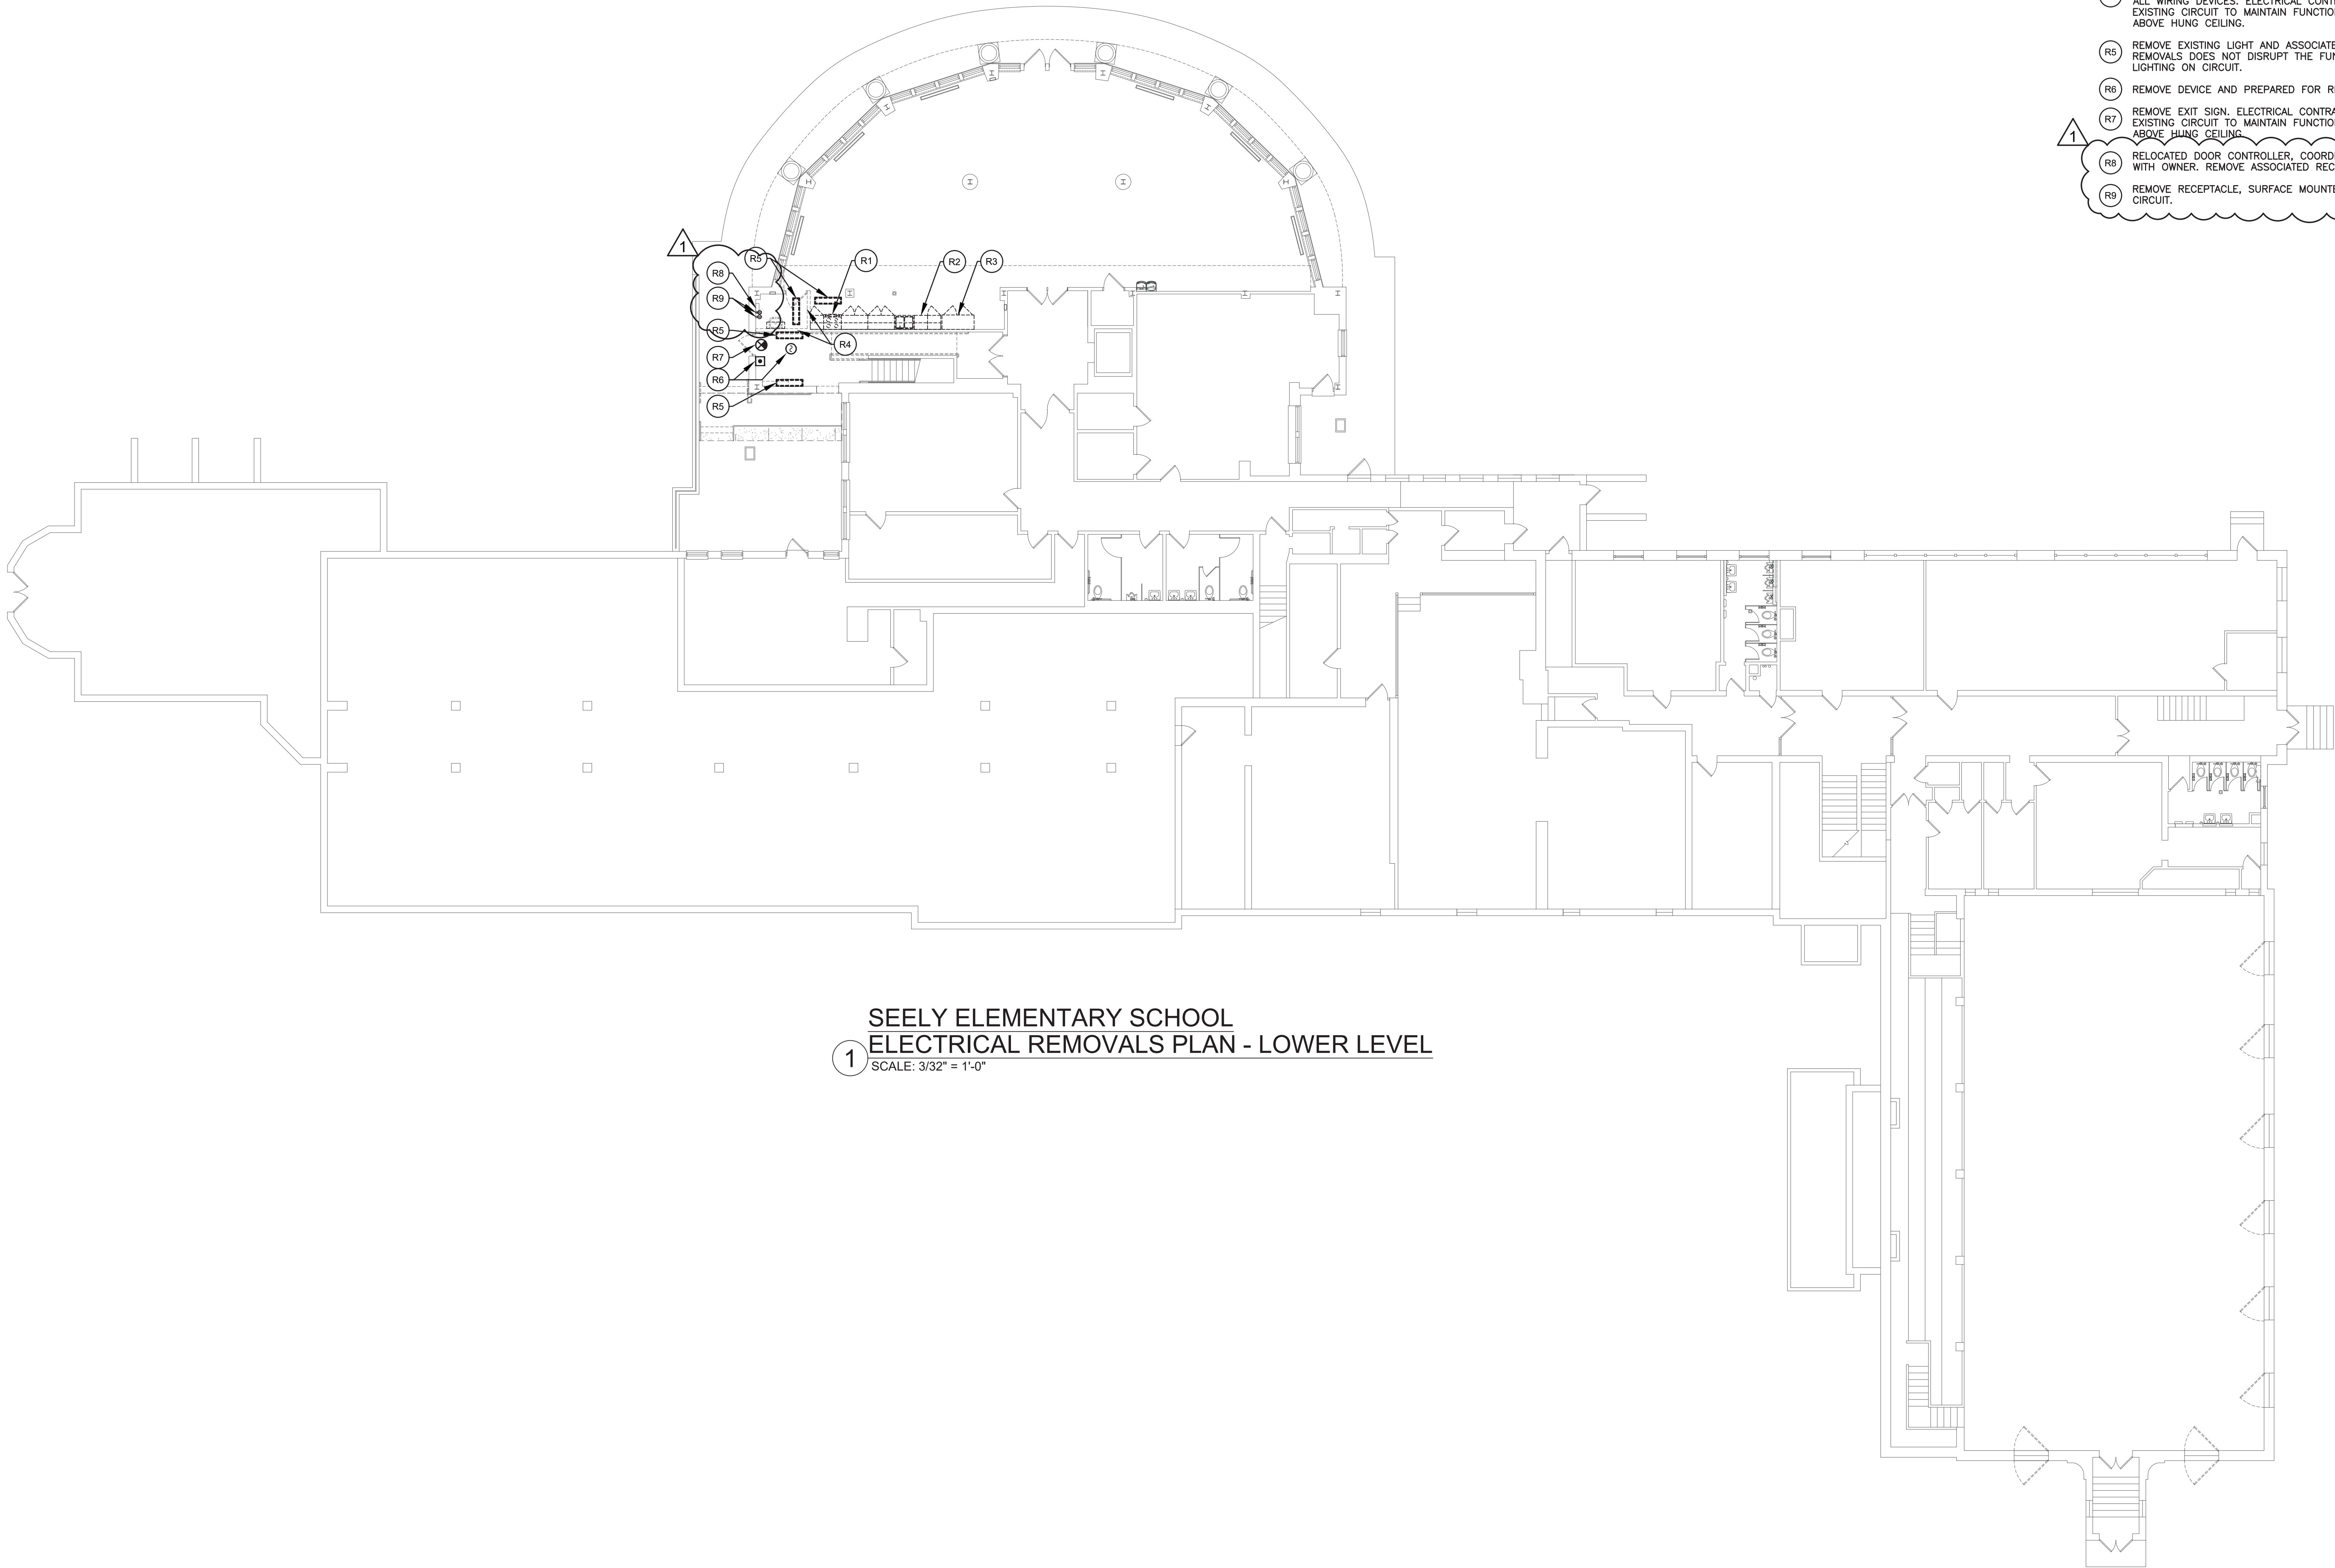

SEELY ELEMENTARY SCHOOL
ELECTRICAL REMOVALS PLAN - LOWER LEVEL
1 SCALE: 3/32" = 1'-0"

GENERAL NOTES:

1. ELECTRICAL CONTRACTOR RESPONSIBLE FOR REMOVING AND REINSTALLING CEILING TILE AND SUSPENSION SYSTEM AND ALL CEILING MOUNTED DEVICES. (TYPICAL)
2. DASHED WALLS ARE REMOVED BY GC.

REMOVAL NOTES:

- R1 ELECTRICAL CONTRACTOR SHALL REMOVE WIRING DEVICE AND CIRCUIT FOR ELECTRIC RANGE BACK TO PANEL.
- R2 ELECTRICAL CONTRACTOR SHALL REMOVE WIRING DEVICE AND CIRCUIT FOR DISHWASHER BACK TO PANEL.
- R3 ELECTRICAL CONTRACTOR SHALL REMOVE WIRING DEVICE AND CIRCUIT FOR FOOD SERVICE EQUIPMENT BACK TO PANEL.
- R4 WALLS REMOVED BY GC. ELECTRICAL CONTRACTOR SHALL REMOVE ALL WIRING DEVICES. ELECTRICAL CONTRACTOR SHALL REWIRING THE EXISTING CIRCUIT TO MAINTAIN FUNCTIONALITY. PLACE ALL SPLICES ABOVE HUNG CEILING.
- R5 REMOVE EXISTING LIGHT AND ASSOCIATED CONTROL DEVICES. ENSURE REMOVALS DOES NOT DISRUPT THE FUNCTIONALITY OF THE REMAINING LIGHTING ON CIRCUIT.
- R6 REMOVE DEVICE AND PREPARED FOR RELOCATION PER FA100.
- R7 REMOVE EXIT SIGN. ELECTRICAL CONTRACTOR SHALL REWIRING THE EXISTING CIRCUIT TO MAINTAIN FUNCTIONALITY. PLACE ALL SPLICES ABOVE HUNG CEILING.
- R8 RELOCATED DOOR CONTROLLER, COORDINATE NEW LOCATION IN FIELD WITH OWNER. REMOVE ASSOCIATED RECEPTACLE AND CIRCUIT.
- R9 REMOVE RECEPTACLE, SURFACE MOUNTED RACEWAY, AND ASSOCIATED CIRCUIT.

AS PER USA CONGRESS ARCHITECTURAL WORKS COPYRIGHT PROTECTION ACT OF 1990 ALL IDEAS AND DESIGNS INCLUDING DERIVATIVES THEREOF, ALL DRAWINGS AND SPECIFICATIONS CONSTITUTE THE ORIGINAL COPYRIGHT WORK BY FULLER AND DANIELO, P.C. (F&D). THE DRAWINGS AND SPECIFICATIONS AS INSTRUMENTS OF SERVICE BY F&D ARE CREATED BY F&D FOR THIS PROJECT ONLY AND REMAIN THE PROPERTY OF F&D. ANY REPRODUCTION WITHOUT THE PRIOR CONSENT OF F&D IS PROHIBITED.

408 CHILWORTH ROAD ELLENFIELD NEW YORK 10828
TEL: 914-898-4444 FAX: 914-898-1179
Copyright 2021 by Fuller and DanieLO, P.C.

FULLER
DANIELO
P.C.
ARCHITECTS
PLANNERS

LFG
LANDMARK
FACILITIES
GROUP, INC.
252 East Avenue
Greenville, SC 29605
(253) 866-4020
(253) 866-4019 Fax

S.E.D. CONTROL NUMBER:
GREENVILLE ELEMENTARY SCHOOL
66-04-06-03-0-001-021
SEELY PLACE ELEMENTARY SCHOOL
66-04-06-03-0-001-019

PROJECT:
EDGEMONT SCHOOL DISTRICT
GREENVILLE ELEMENTARY SCHOOL
SEELY PLACE ELEMENTARY SCHOOL
PHASE 1 - HVAC & CATERIA

DRAWING TITLE:
BASEMENT ELECTRICAL
REMOVALS PLAN

1-24-2023	ADDENDUM 1
1-06-2023	BID
DATE	ISSUED TO
SHEET SIZE 30"x42"	DRAWING NO. SPES ER100
SCALE AS NOTED	FILE NO. 21434.01
DRAWN BY LFG	

- 1
- REMOVAL NOTES:
- R1

ELECTRICAL CONTRACTOR SHALL REMOVE UNIT, DISCONNECT AND CIRCUIT BACK TO PANEL "HVAC-1". REMOVE ANY ASSOCIATED DUCT SMOKE DETECTORS AND CONTROL REALYS.
- R2

ELECTRICAL CONTRACTOR SHALL ASSIST MECHANICAL CONTRACTOR IN MOVING EXISTING CONDENSING UNIT. MOVE, DISCONNECT AND CIRCUIT. RE-CIRCUIT FROM INTERIOR THROUGH NEW PIPE PORTAL, PROVIDE WIRING AND CONDUIT AS NEEDED.

1

SEELY ELEMENTARY SCHOOL
ELECTRICAL REMOVALS PLAN - ROOF

SCALE: 3/32" = 1'-0"

AS PER USA CONGRESS ARCHITECTURAL WORKS COPYRIGHT PROTECTION ACT OF 1990 ALL IDEAS AND DESIGNS INCLUDING DERIVATIVES THEREOF, ALL DRAWINGS AND SPECIFICATIONS CONSTITUTE THE ORIGINAL COPYRIGHT WORK BY FULLER D'ANGELO, P.C. (F&D). THE DRAWINGS AND SPECIFICATIONS AS INSTRUMENTS OF SERVICE BY F&D ARE CREATED BY F&D FOR THIS PROJECT ONLY AND REMAIN THE PROPERTY OF F&D. ANY REPRODUCTION WITHOUT THE PRIOR CONSENT OF F&D IS PROHIBITED.

408 CHERRYWOOD ROAD ELLENFIELD NEW YORK 10888
TEL: 914-898-4444 FAX: 914-898-1177
Copyright 2021 by Rylee Bennett Fuller D'Angelo P.C.

FULLER
D'ANGELO
P.C.
ARCHITECTS
PLANNERS

LFG
LANDMARK
FACILITIES
GROUP, INC.
252 East Avenue
New Rochelle, NY 10801
(203) 866-4629 FAX
(203) 866-4019 Fax

S.E.D. CONTROL NUMBER:
GREENVILLE ELEMENTARY SCHOOL
66-04-06-03-0-001-021
SEELY PLACE ELEMENTARY SCHOOL
66-04-06-03-0-001-019



PROJECT NAME:
EDGEMONT SCHOOL DISTRICT
GREENVILLE ELEMENTARY SCHOOL
SEELY PLACE ELEMENTARY SCHOOL
PHASE 1 - HVAC & CATERIA

DRAWING TITLE:
ROOF ELECTRICAL REMOVALS
PLAN


1-24-2023	ADDENDUM 1
1-06-2023	BID
DATE	ISSUED TO
SHEET SIZE 30"x42"	DRAWING NO. SPES ER104
SCALE AS NOTED	FILE NO. 21434.01
DRAWN BY LFG	

1. ELECTRICAL CONTRACTOR RESPONSIBLE FOR REMOVING AND REINSTALLING CEILING TILE AND SUSPENSION SYSTEM AND ALL CEILING MOUNTED DEVICES. (TYPICAL)
2. SLAB TRENCHING BY ELECTRICAL CONTRACTOR. RESTORE SLAB ONCE FLOOR BOX & CONDUIT INSTALLATION IS COMPLETE. REFER TO SLAB PATCH DETAIL 2 ON SHEET E001.

- 1 DISCONNECT SWITCH, VARIABLE FREQUENCY DRIVE, OR MOTOR STARTER FURNISHED BY MECHANICAL CONTRACTOR, INSTALLED & WIRED BY ELECTRICAL CONTRACTOR.
- 2 CONTRACTOR SHALL TRENCH SLAB AND INSTALL CONDUIT SERVING FLOOR BOXES. CONDUIT COVERED IN CONCRETE PERMITTED TO BE PVC.
 - (1) 1" FOR DATA
 - (6) 1/2" FOR POWER BRANCH CIRCUITS
- 3 CONTRACTOR SHALL TRENCH SLAB AND INSTALL CONDUIT SERVING FLOOR BOXES. CONDUIT COVERED IN CONCRETE PERMITTED TO BE PVC.
 - (2) 1/2" FOR POWER BRANCH CIRCUITS
- 4 WALL FURRED OUT BY GC FOR ELECTRICAL AND PLUMBING.
- 5 NEW EXIT SIGNS, CIRCUIT TO EXISTING EXIT SIGN CIRCUIT.
- 6 CONTRACTOR SHALL USE WIREMOLD ON EXISTING WALL.
- 7 POWER & DATA FLOORBOX "F10". REFER TO FLOORBOX SCHEDULE ON SHEET SPES E001, FOR REQUIRED FLOORBOX, COVER, DEVICE PLATES, AND WIRING DEVICES.
- 8 POWER FLOORBOX "F2". REFER TO FLOORBOX SCHEDULE ON SHEET SPES E001FOR REQUIRED FLOORBOX, COVER, DEVICE PLATES, AND WIRING DEVICES.

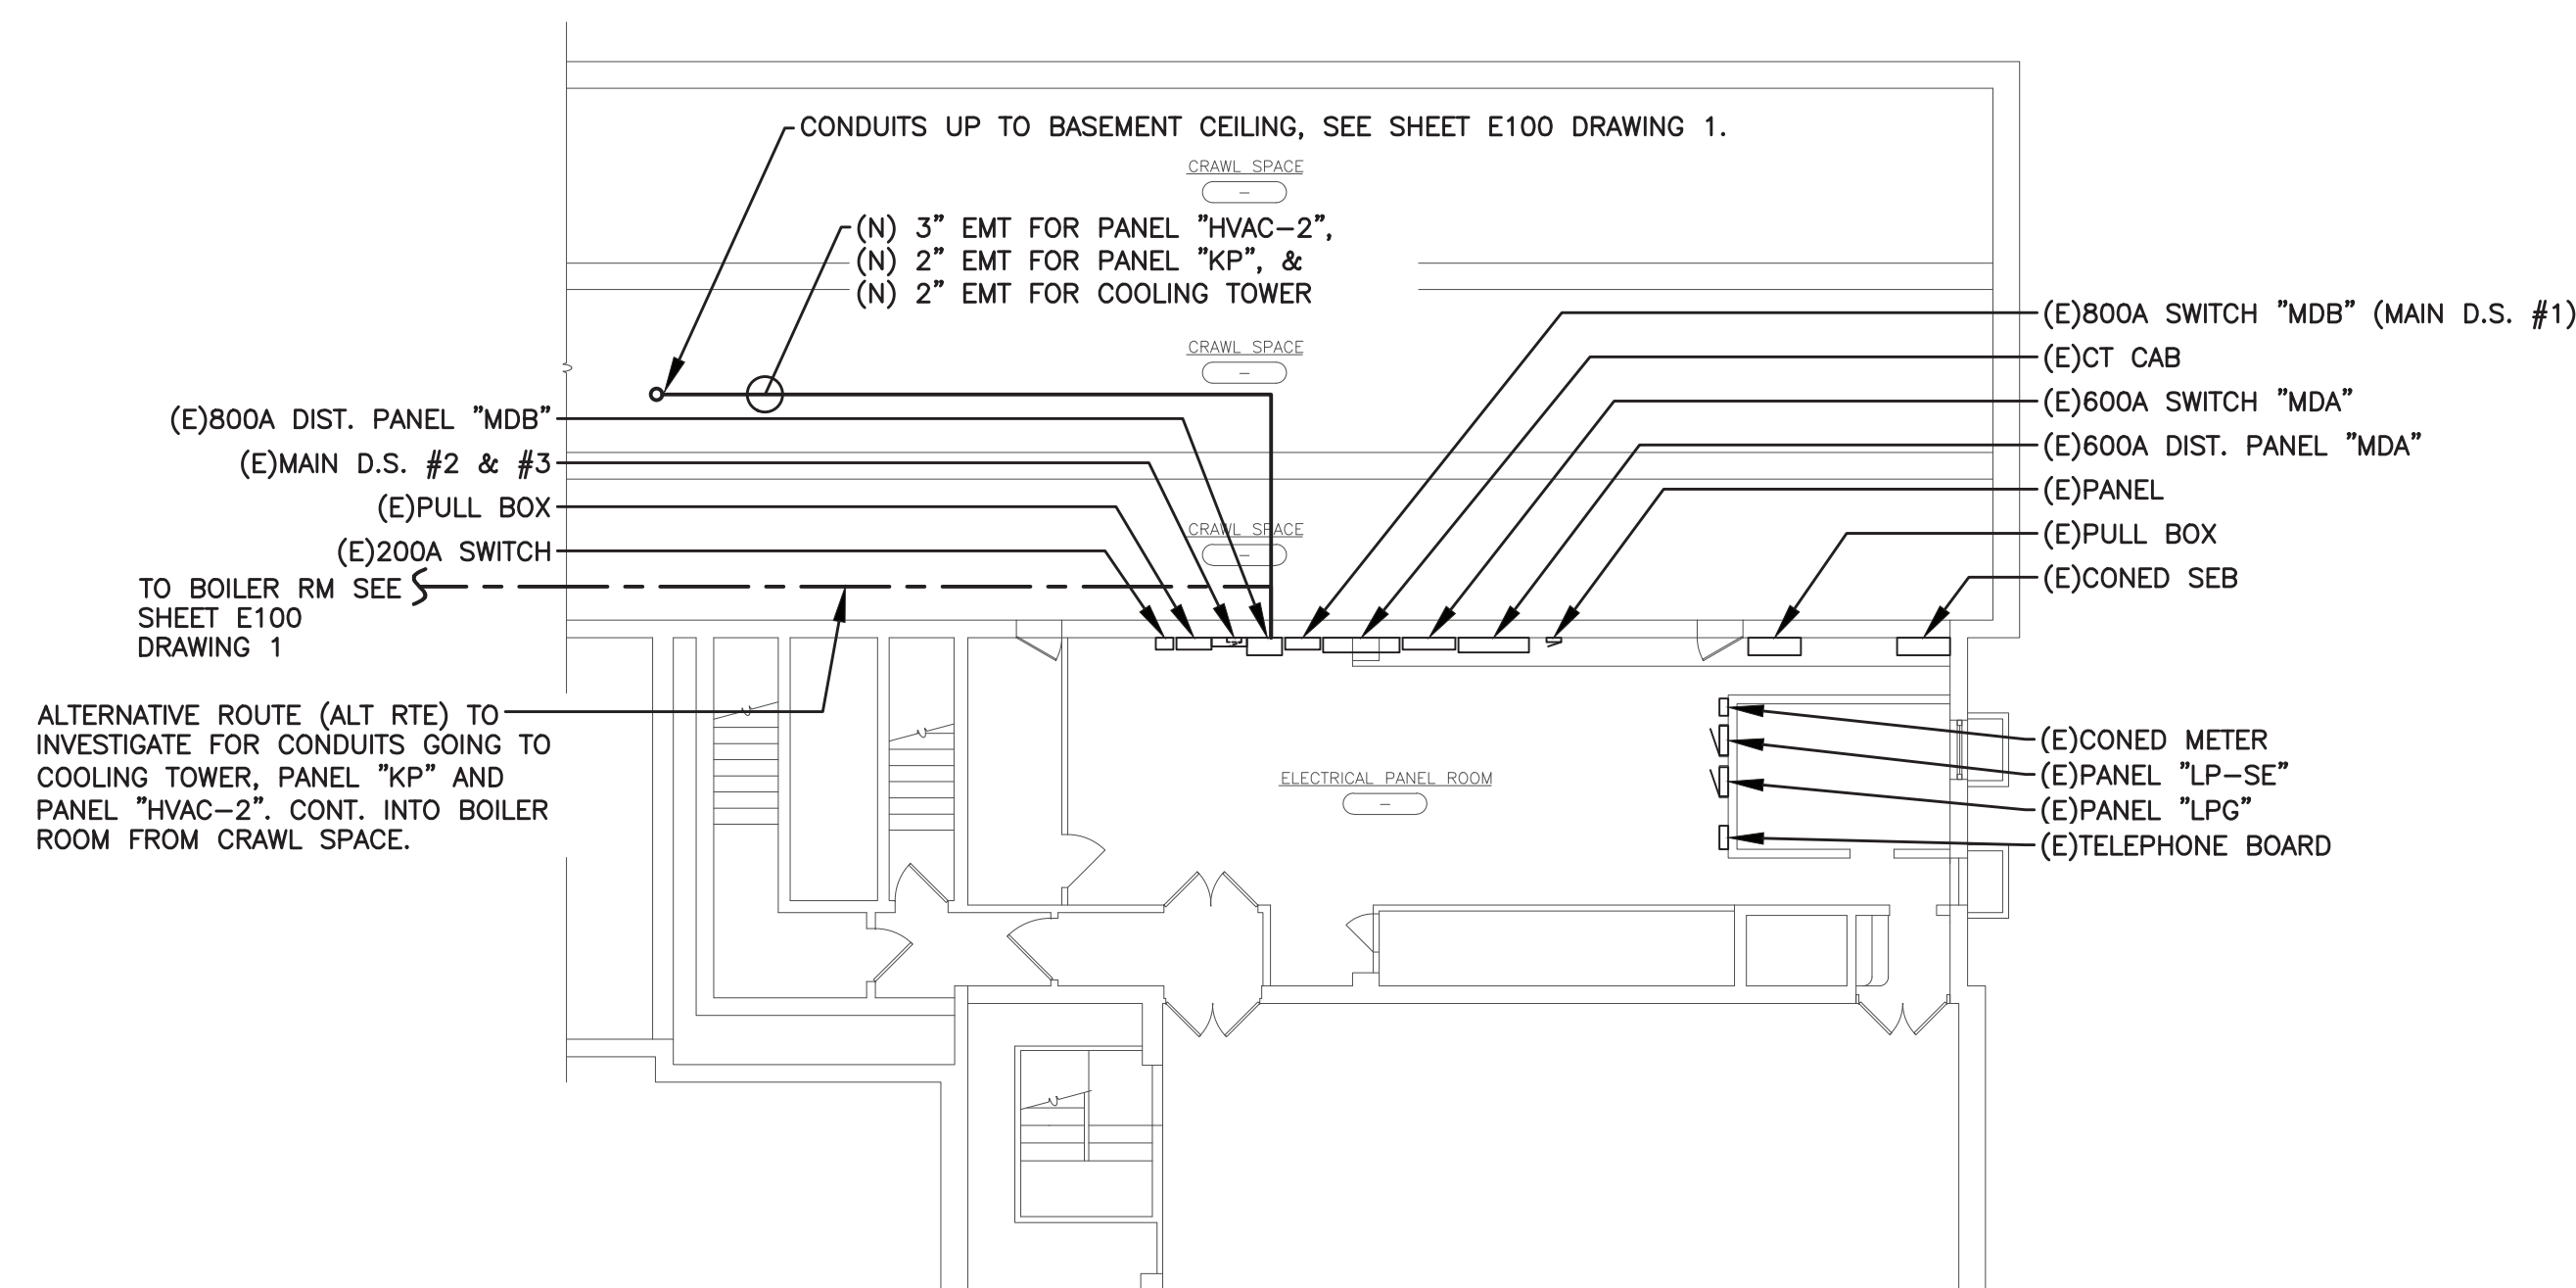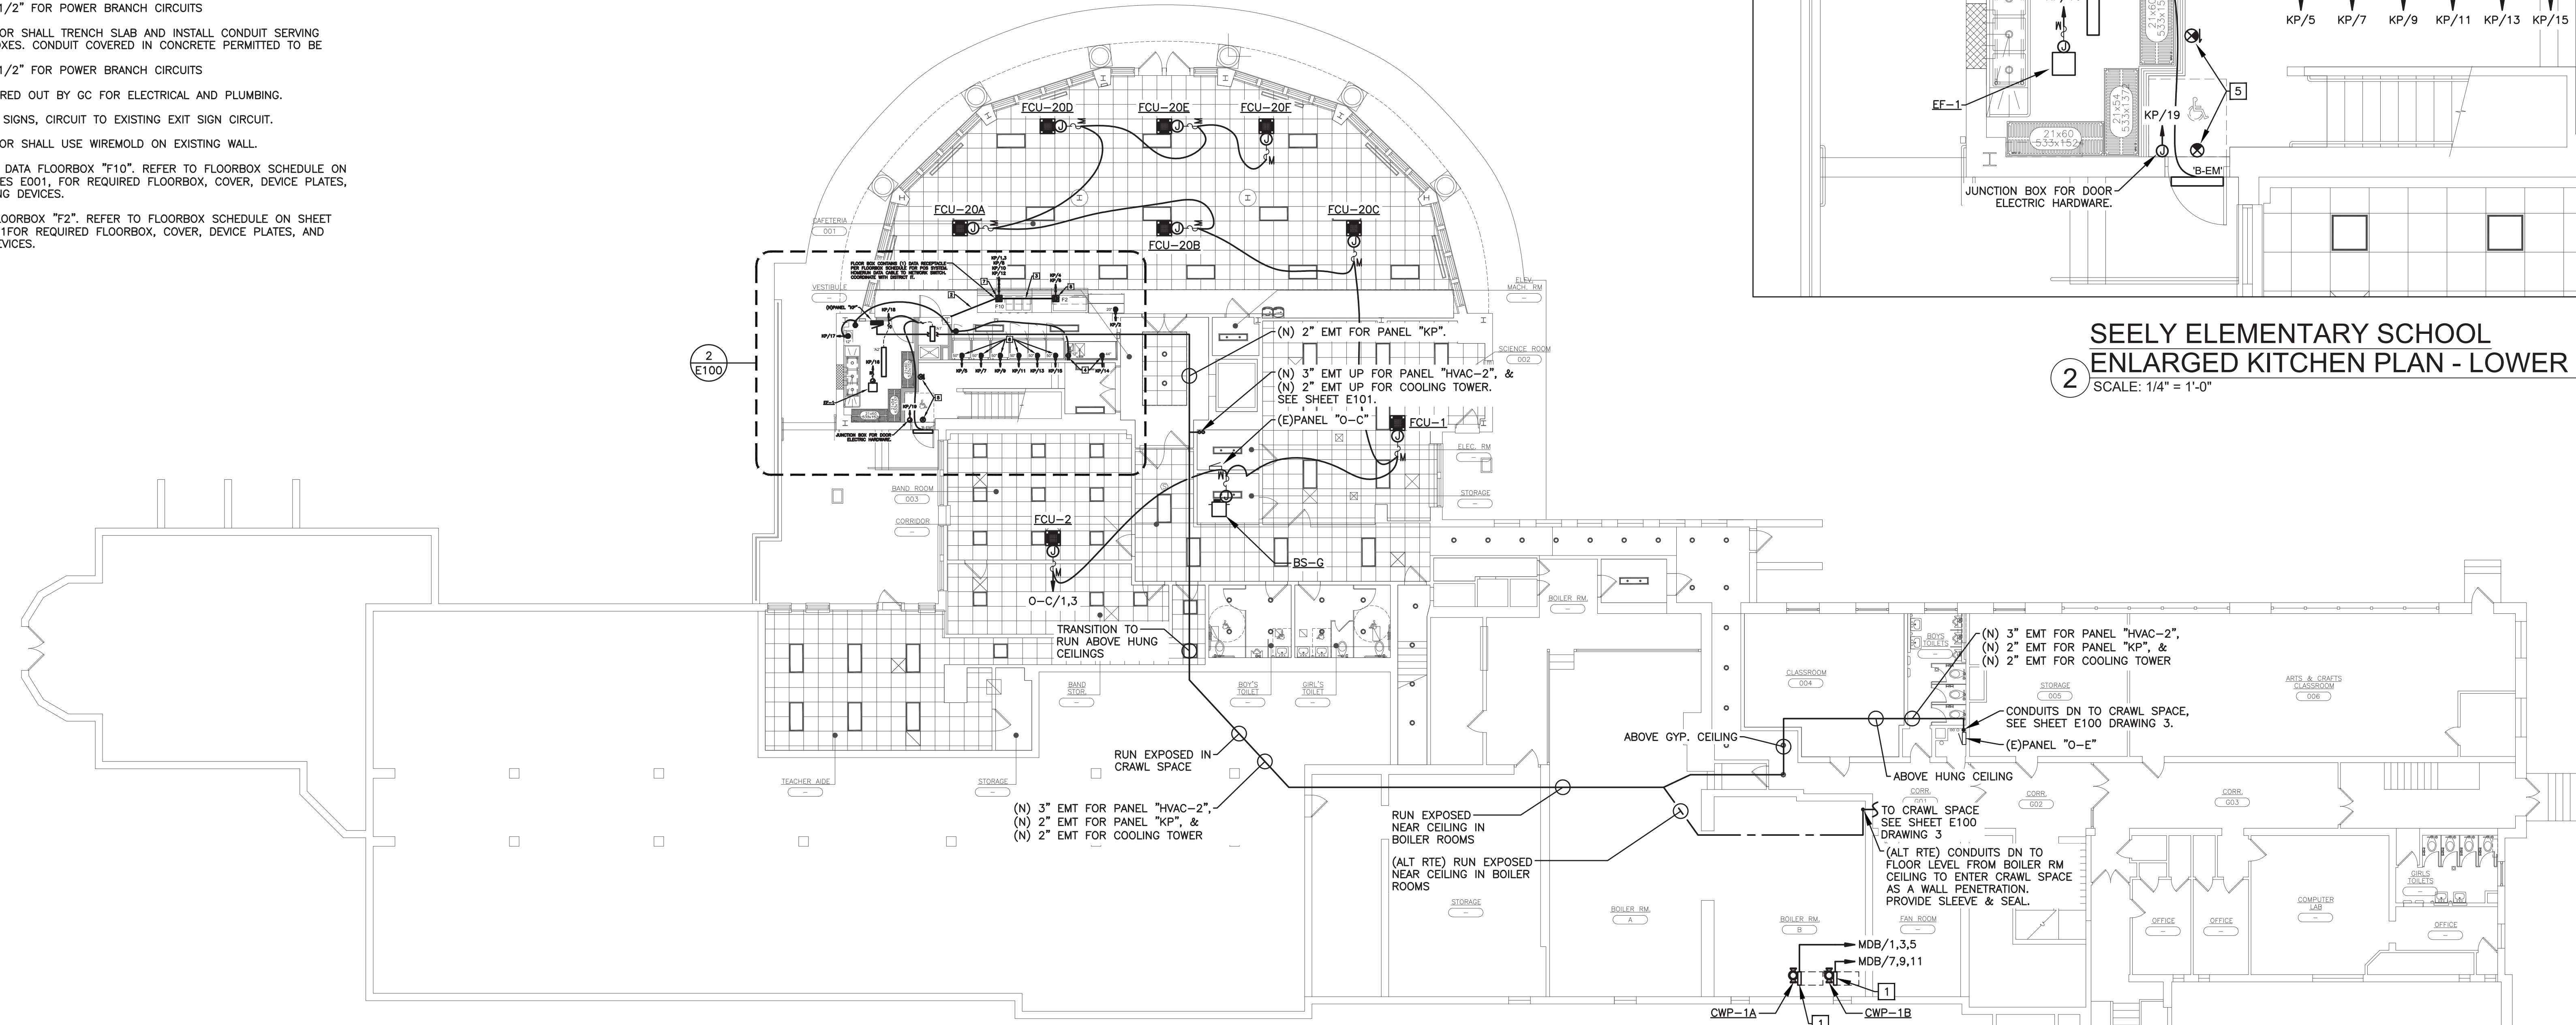

SEELY ELEMENTARY SCHOOL
ELECTRICAL PLAN - SUB BASEMENT
3 SCALE: 3/32" = 1'-0"

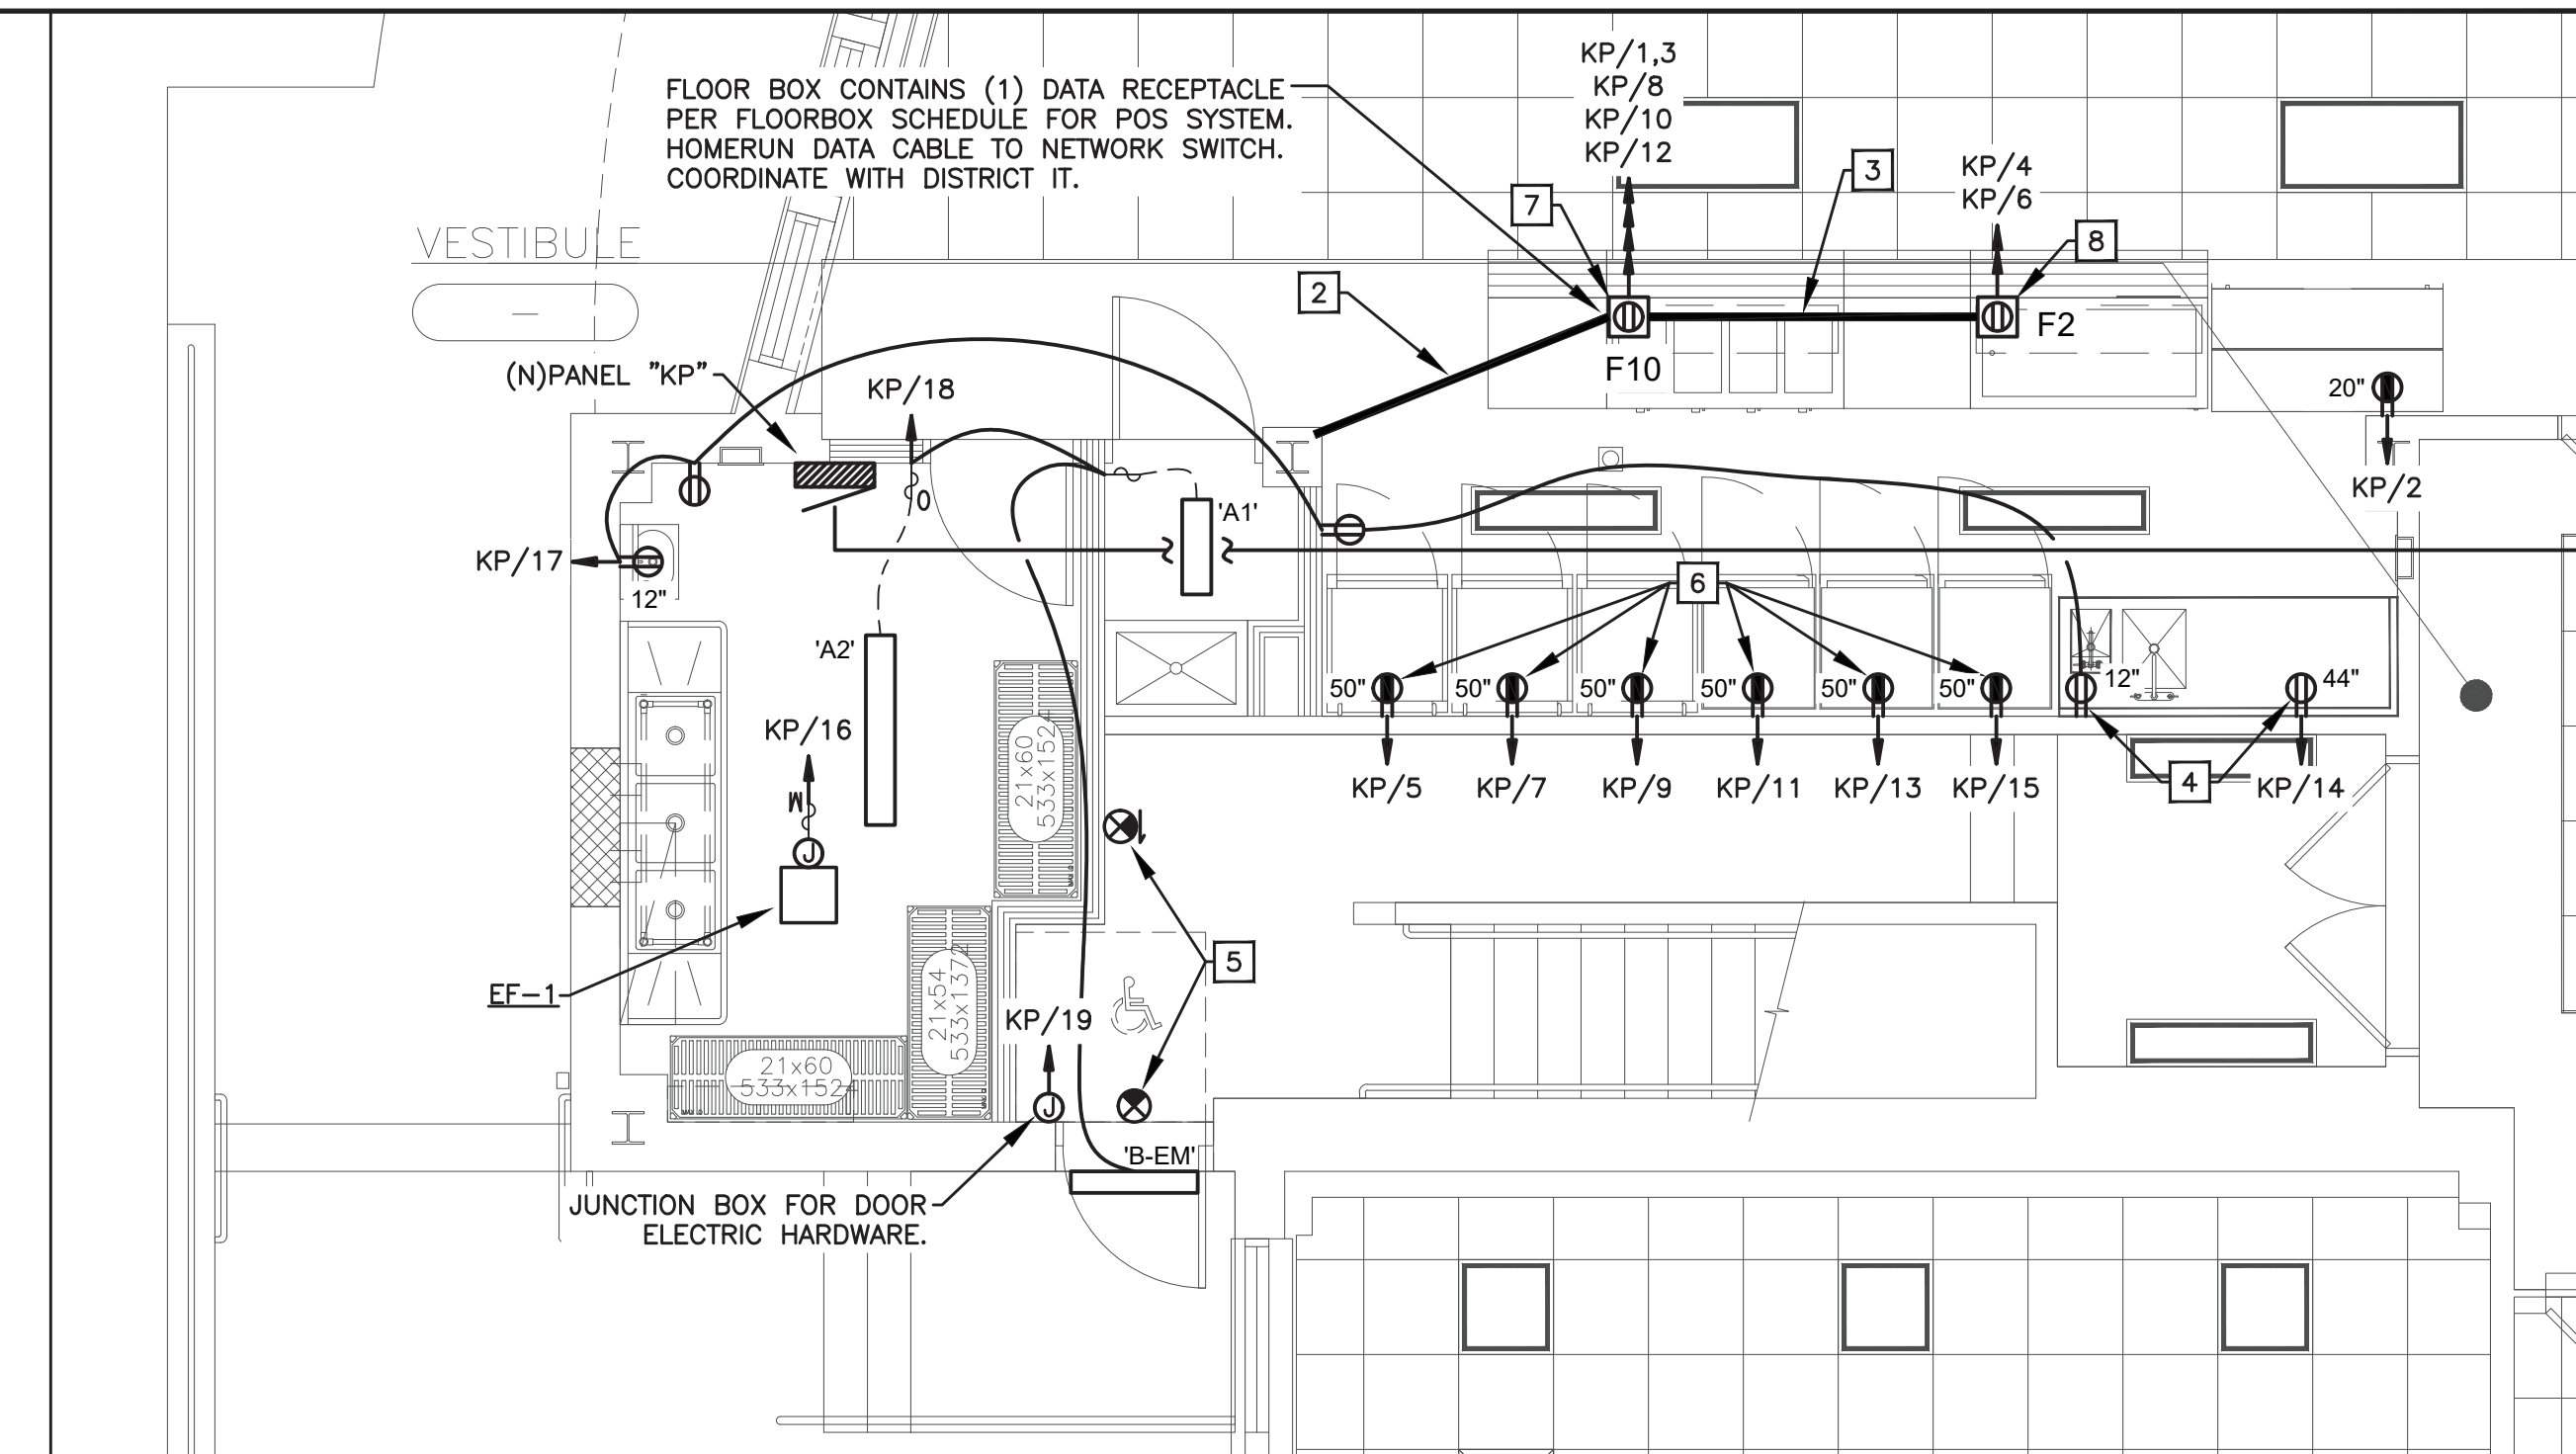

SEELY ELEMENTARY SCHOOL
ENLARGED KITCHEN PLAN - LOWER LEVEL
2 SCALE: 1/4" = 1'-0"

AS PER U.S. CONGRESS ARCHITECTURAL WORKS COPYRIGHT PROTECTION ACT OF 1990 ALL IDEAS AND DESIGNS INCLUDING DERIVATIVES THEREOF, ALL DRAWINGS AND SPECIFICATIONS CONSTITUTE THE ORIGINAL COPYRIGHT WORK BY FULLER AND D'ANGELO, P.C. (F&D). THE DRAWINGS AND SPECIFICATIONS AS INSTRUMENTS OF SERVICE BY F&D ARE CREATED BY F&D FOR THIS PROJECT ONLY AND REMAIN THE PRODUCT AND PROPERTY OF F&D. ANY REPRODUCTION WITHOUT THE PRIOR CONSENT OF F&D IS PROHIBITED.

1435 KNOXWOOD ROAD ELMSFORD NEW YORK 10523
TEL 914.898-4444 FAX 914.898.1717
WWW.FULLERANDERSON.COM
Copyright 2001. All Rights Reserved. ELLI BE L'Y NGSON & P.C.

LFG
LANDMARK
FACILITIES
GROUP, INC.

552 East Avenue
Norwalk, CT 06855
(203) 866-4626 Tel
(203) 866-8019 Fax

S.E.D. CONTROL NUMBER:
REENVILLE ELEMENTARY SCHOOL
66-04-06-03-0-008-021
EELY PLACE ELEMENTARY SCHOOL
66-04-06-03-0-001-019

EDGEMONT SCHOOL DISTRICT
GREENVILLE ELEMENTARY SCHOOL
CAFETERIA RENOVATION AND RELATED WORK
SEELY PLACE ELEMENTARY SCHOOL
PHASE 1 - HVAC & CAFETERIA

DRAWING TITLE


**BASEMENT AND SUB-BASEMENT
ELECTRICAL PLAN**

1-24-2023	ADDENDUM 1
1-06-2023	BID
DATE	ISSUED TO


SHEET SIZE 30"x42"	DRAWING NO. SPES E100
SCALE AS NOTED	FILE NO. 21434.01
DRAWN BY LFG	

PLOT DATE: January 24, 2023 -- 11:05am


FILE: \\fjgdc\Codfiles\Edgemont School District\Seely Place Elementary Phase I\ACAD\Electrical\SPES_Electrical.dwg

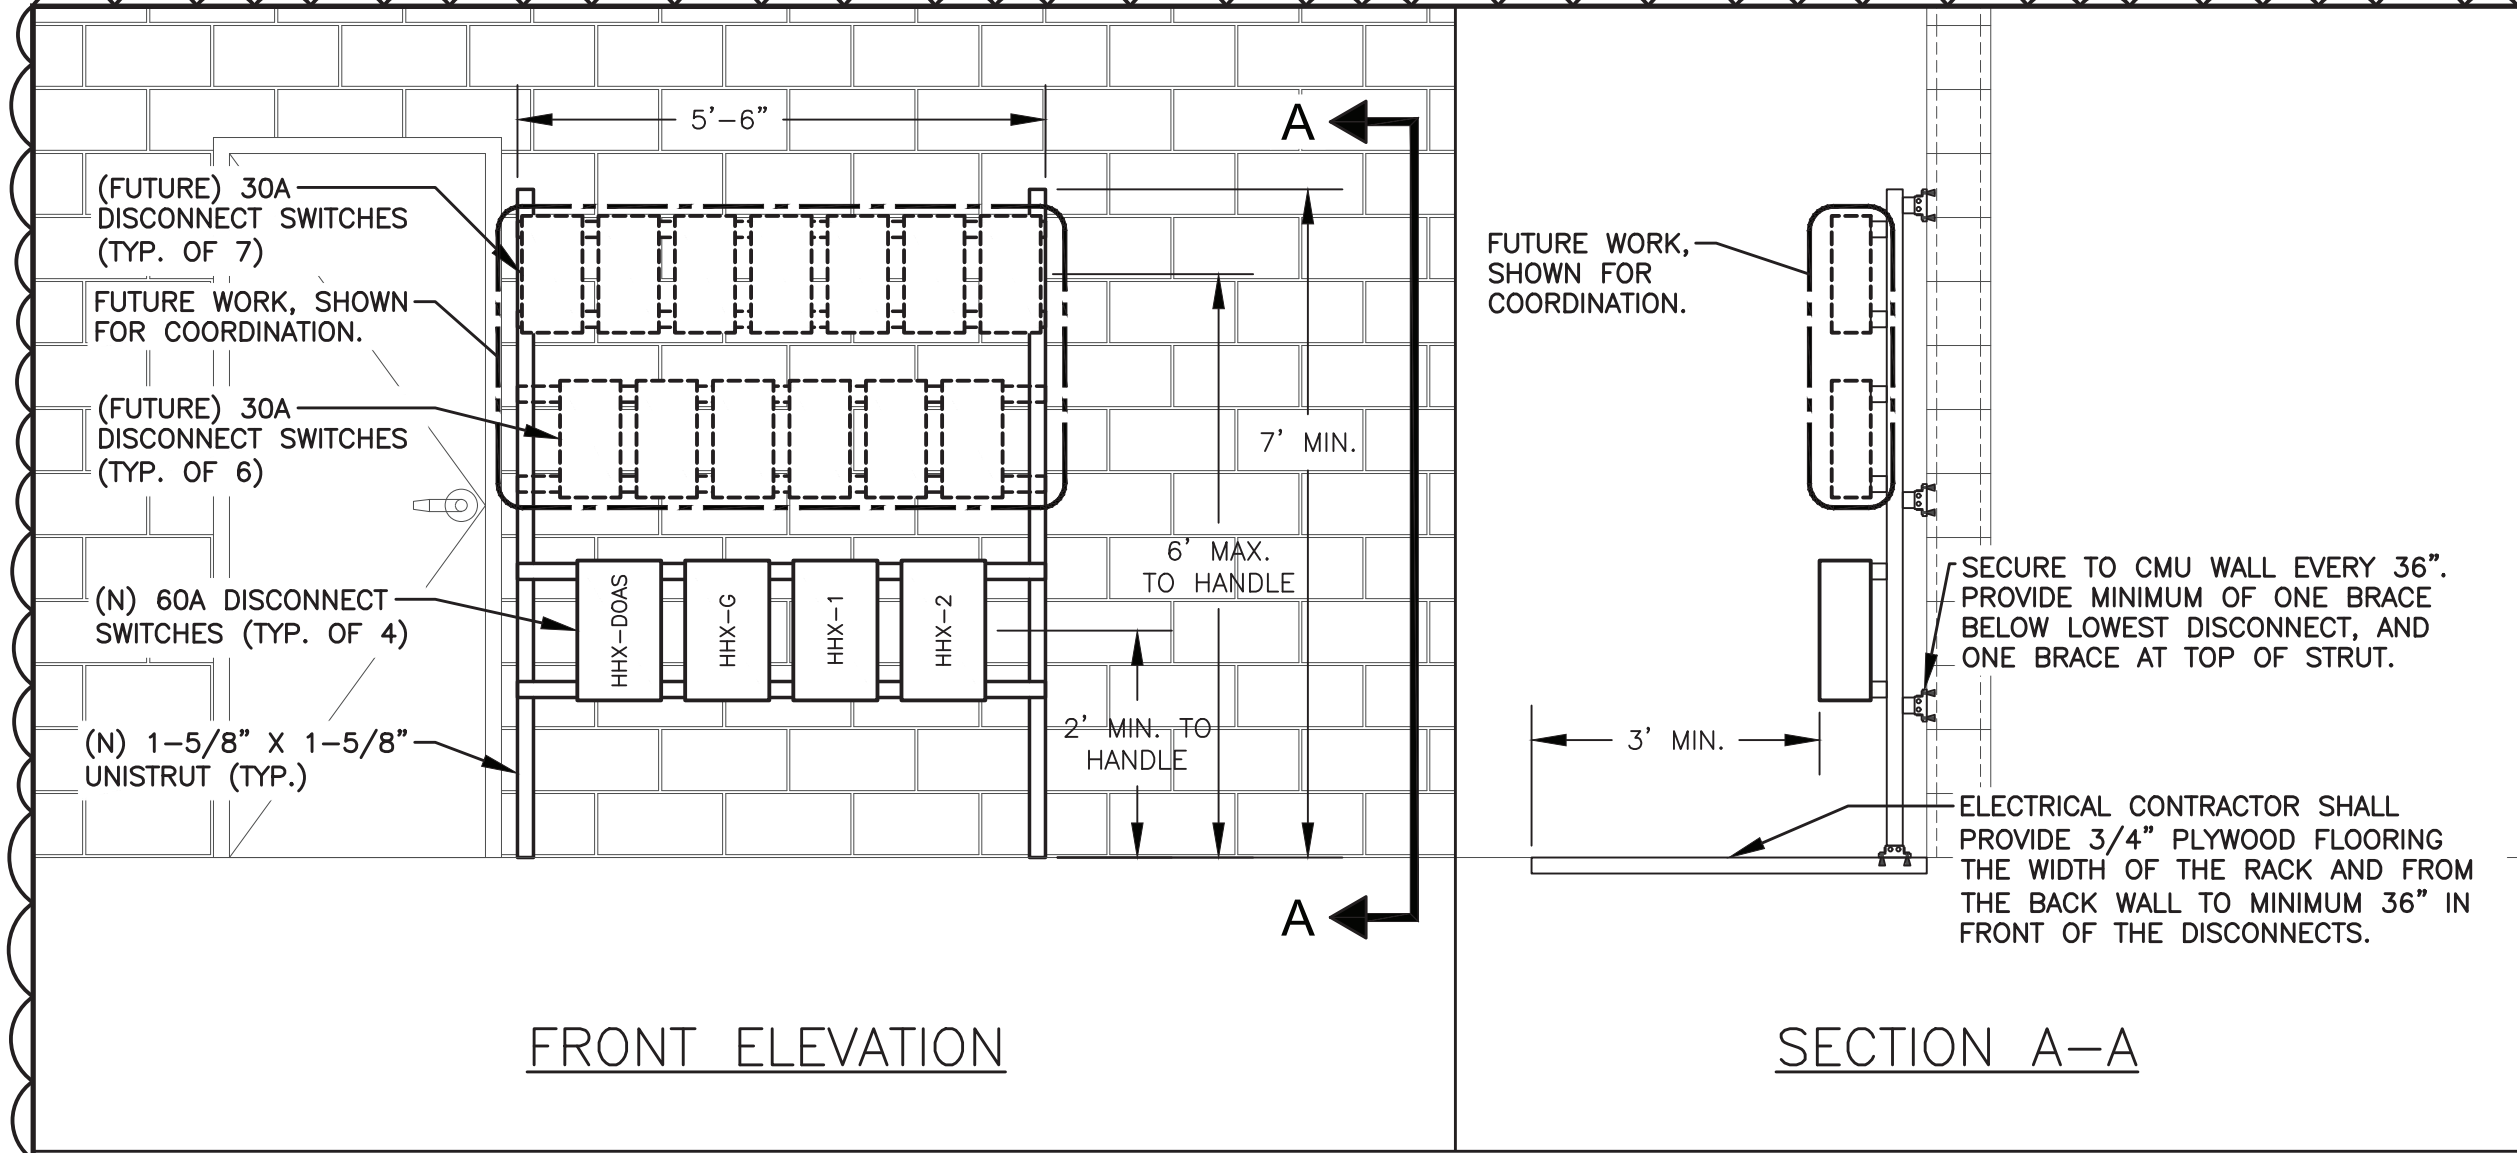

2 DISCONNECT UNISTRUT RACK DETAIL
SCALE: 1/2" = 1'-0"

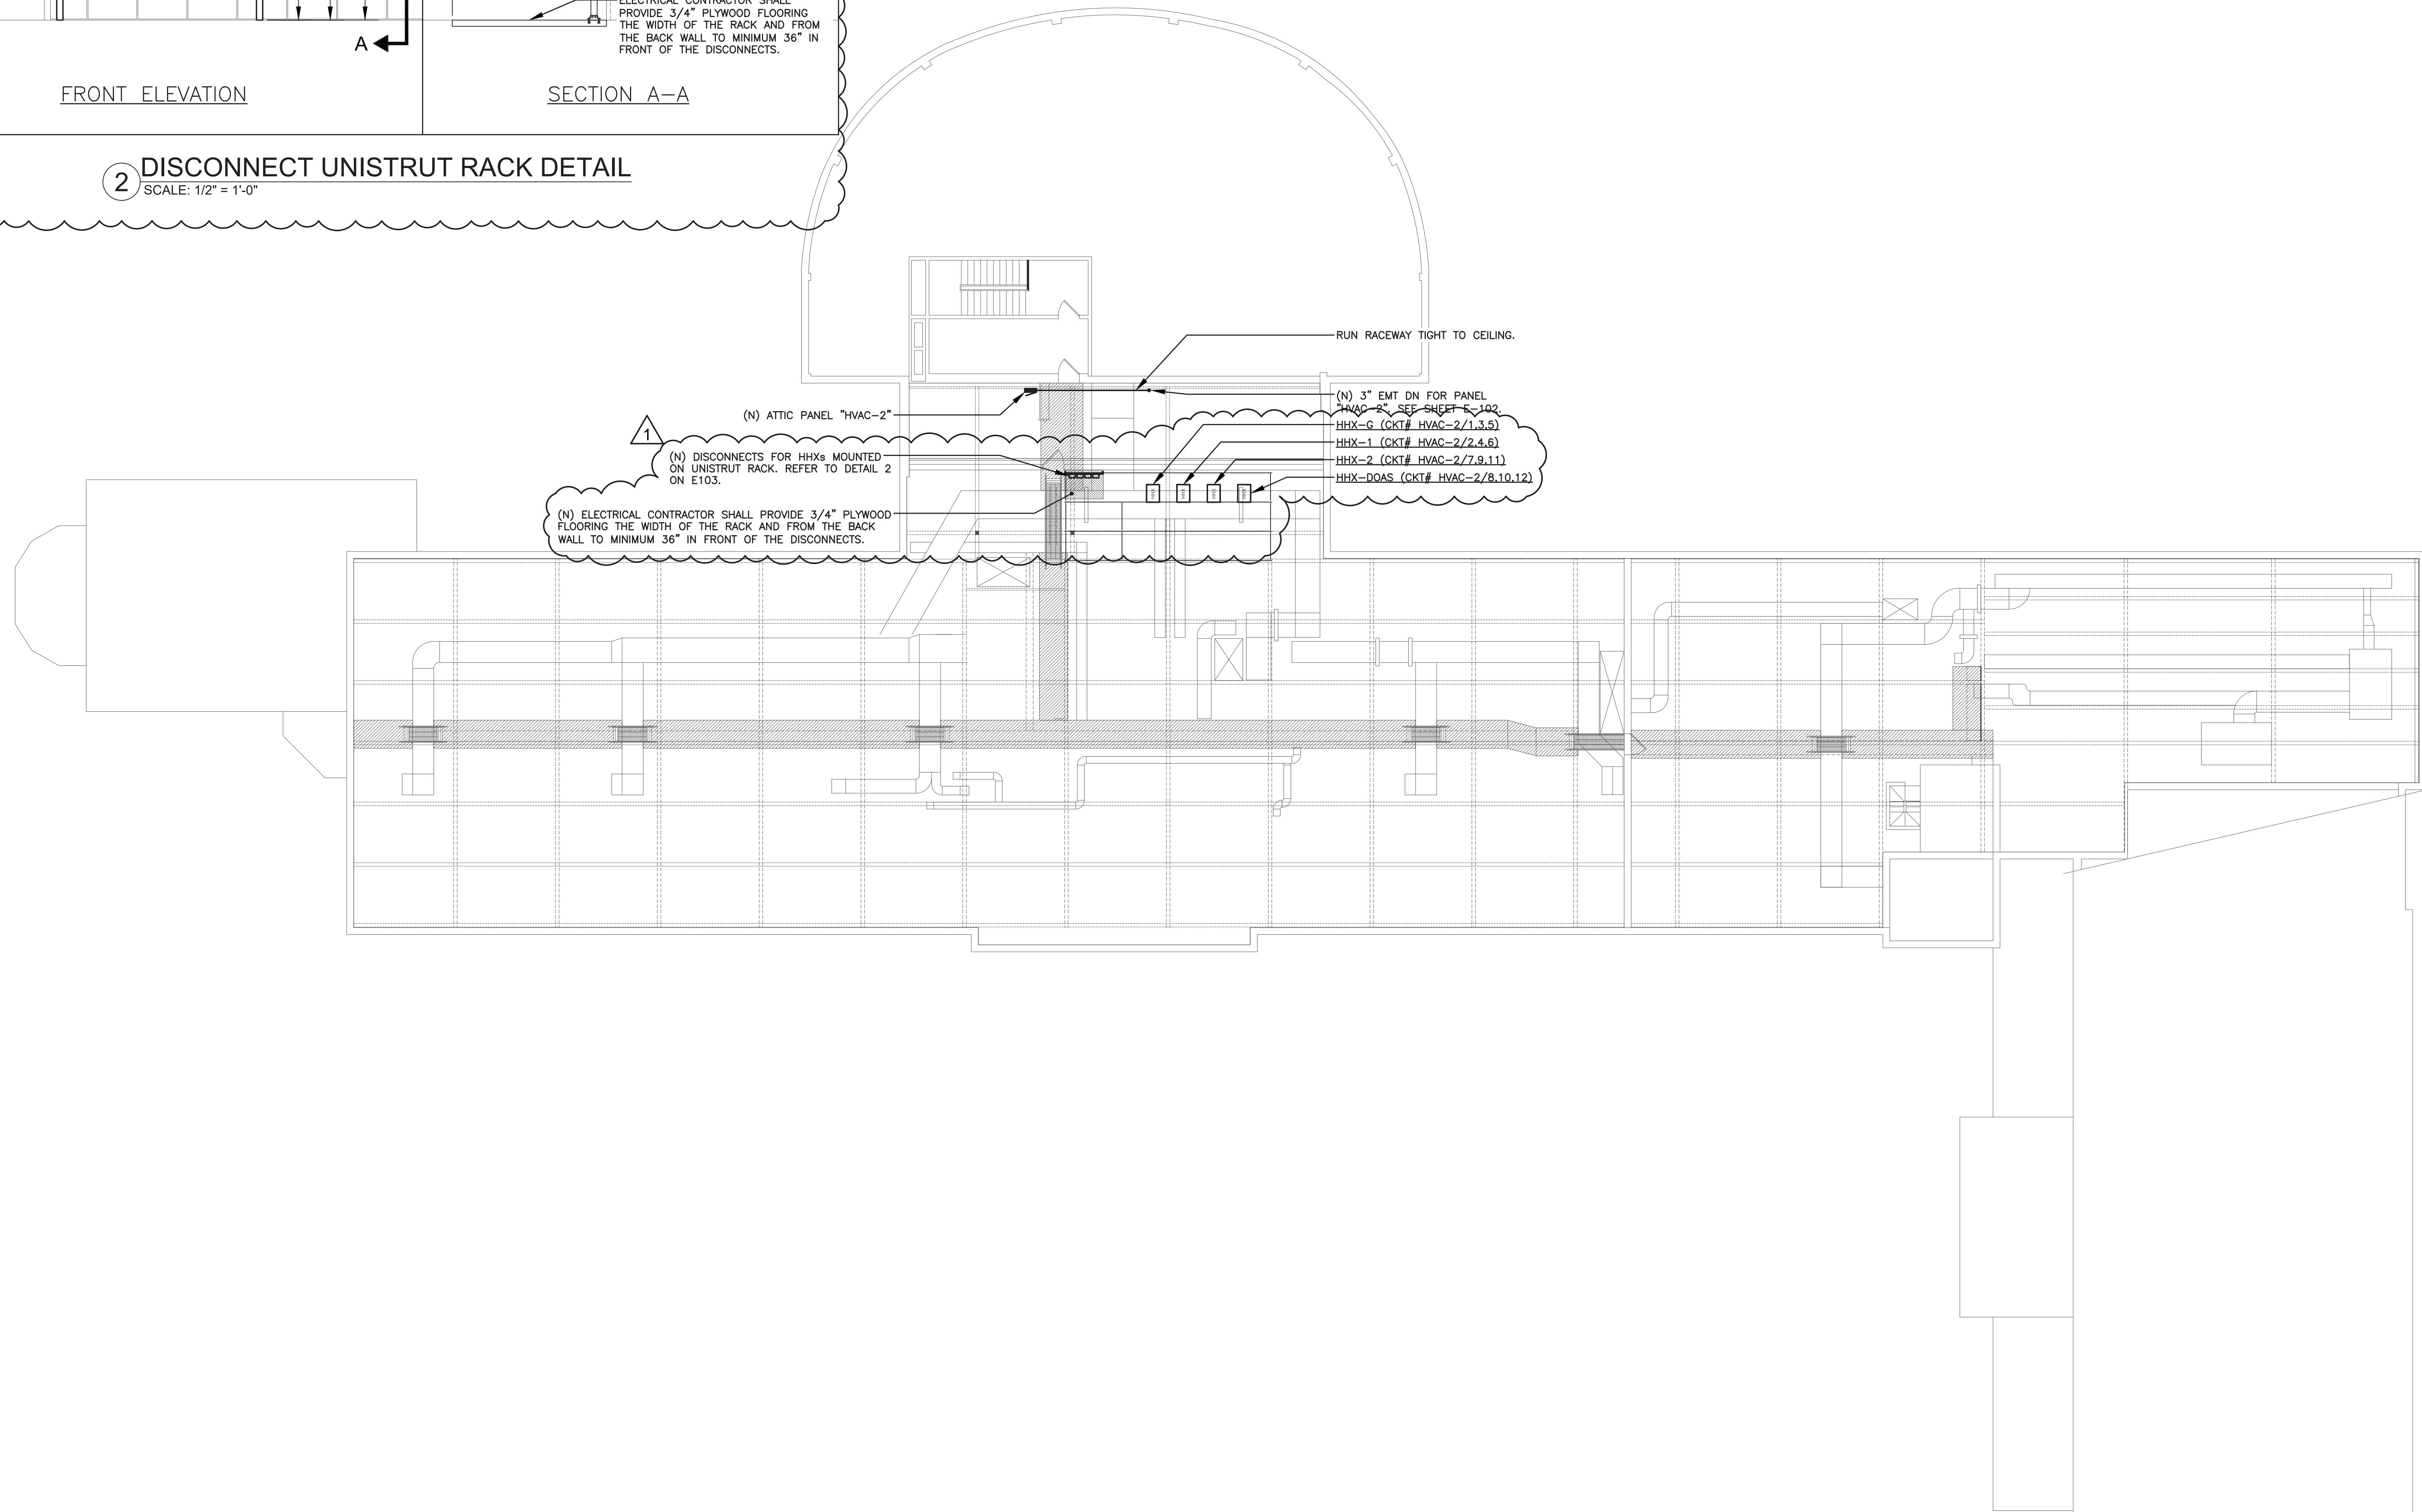

1 SEELY ELEMENTARY SCHOOL
ELECTRICAL PLAN - ATTIC
SCALE: 3/32" = 1'-0"

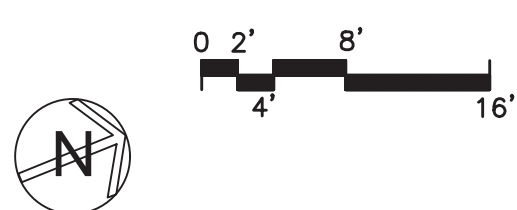

GENERAL NOTES:

1. ELECTRICAL CONTRACTOR RESPONSIBLE FOR REMOVING AND REINSTALLING CEILING TILE AND SUSPENSION SYSTEM AND ALL CEILING MOUNTED DEVICES. (TYPICAL)
2. ELECTRICAL CONTRACTOR SHALL BE RESPONSIBLE FOR PROVIDING ALL MEANS OF GETTING EQUIPMENT INTO ATTIC, PLANKING FOR ACCESS, AND PROPERLY RESTORING OF ANY COMPROMISED SYSTEMS.

AS PER USA CONGRESS ARCHITECTURAL WORKS COPYRIGHT PROTECTION ACT OF 1990 ALL IDEAS AND DESIGNS INCLUDING DERIVATIVES THEREOF, ALL DRAWINGS AND SPECIFICATIONS CONSTITUTE THE ORIGINAL COPYRIGHT WORK BY FULLER AND DANIELO, P.C. (F&D). THE DRAWINGS AND SPECIFICATIONS AS INSTRUMENTS OF SERVICE BY F&D ARE CREATED BY F&D FOR THIS PROJECT ONLY AND REMAIN THE PRODUCT AND PROPERTY OF F&D. ANY REPRODUCTION WITHOUT THE PRIOR CONSENT OF F&D IS PROHIBITED.

48 HOLLWOOD ROAD ELLENHURST NEW YORK 11033
TEL 914.898-4444 FAX 914.898-1919
WWW.FULLERDANGELO.COM
Copyright 2021 All Rights Reserved FULLER & DANIELO, P.C.

FULLER
DANGELO
P.C.
ARCHITECTS
PLANNERS

LFG
LANDMARK
FACILITIES
GROUP, INC.
252 East Avenue
Greenville, SC 29615
(253) 866-4626 FAX
(253) 866-8019 Fax

S.E.D. CONTROL NUMBER:
GREENVILLE ELEMENTARY SCHOOL
66-04-06-03-0-008-021
SEELY PLACE ELEMENTARY SCHOOL
66-04-06-03-0-001-019

PROJECT NAME:
EDGEMONT SCHOOL DISTRICT
GREENVILLE ELEMENTARY SCHOOL
SEELY PLACE ELEMENTARY SCHOOL
PHASE 1 - HVAC & CRETERIA

DRAWING TITLE:
ATTIC ELECTRICAL PLAN


1-24-2023	ADDENDUM 1
1-06-2023	BID
DATE	ISSUED TO
SHEET SIZE 30"x42"	DRAWING NO. SPES E103
SCALE AS NOTED	FILE NO. 21434.01
DRAWN BY LFG	

GENERAL NOTES:

1. ELECTRICAL CONTRACTOR RESPONSIBLE FOR REMOVING AND REINSTALLING CEILING TILE AND SUSPENSION SYSTEM AND ALL CEILING MOUNTED DEVICES. (TYPICAL)
2. ALL ROOF PENETRATIONS SHALL BE BY ROOFING CONTRACTOR.
3. ALL CONDUIT EXPOSED ON ROOF SHALL BE RIGID GALVANIZED STEEL U.N.O.. SUPPORT CONDUIT ABOVE ROOF LEVEL PER NEC.


CODED NOTES:

- 1 UNUSED
- 2 CONDUIT UP WITHIN CURB INTO EQUIPMENT. ELECTRICAL CONTRACTOR SHALL WIRE FACTORY FURNISHED NON-FUSED DISCONNECT SWITCH.
- 3 CONTRACTOR SHALL WIRE GFCI RECEPTACLE ON UNIT TO PANEL HVAC-1 CKT#30. ROUTE POWER THROUGH CURB.
- 4 PIPE PORTAL PROVIDED BY OTHERS, ROUTE CONDUIT THROUGH PIPE PORTAL.
- 5 FACTORY PROVIDED DISCONNECT SWITCH.

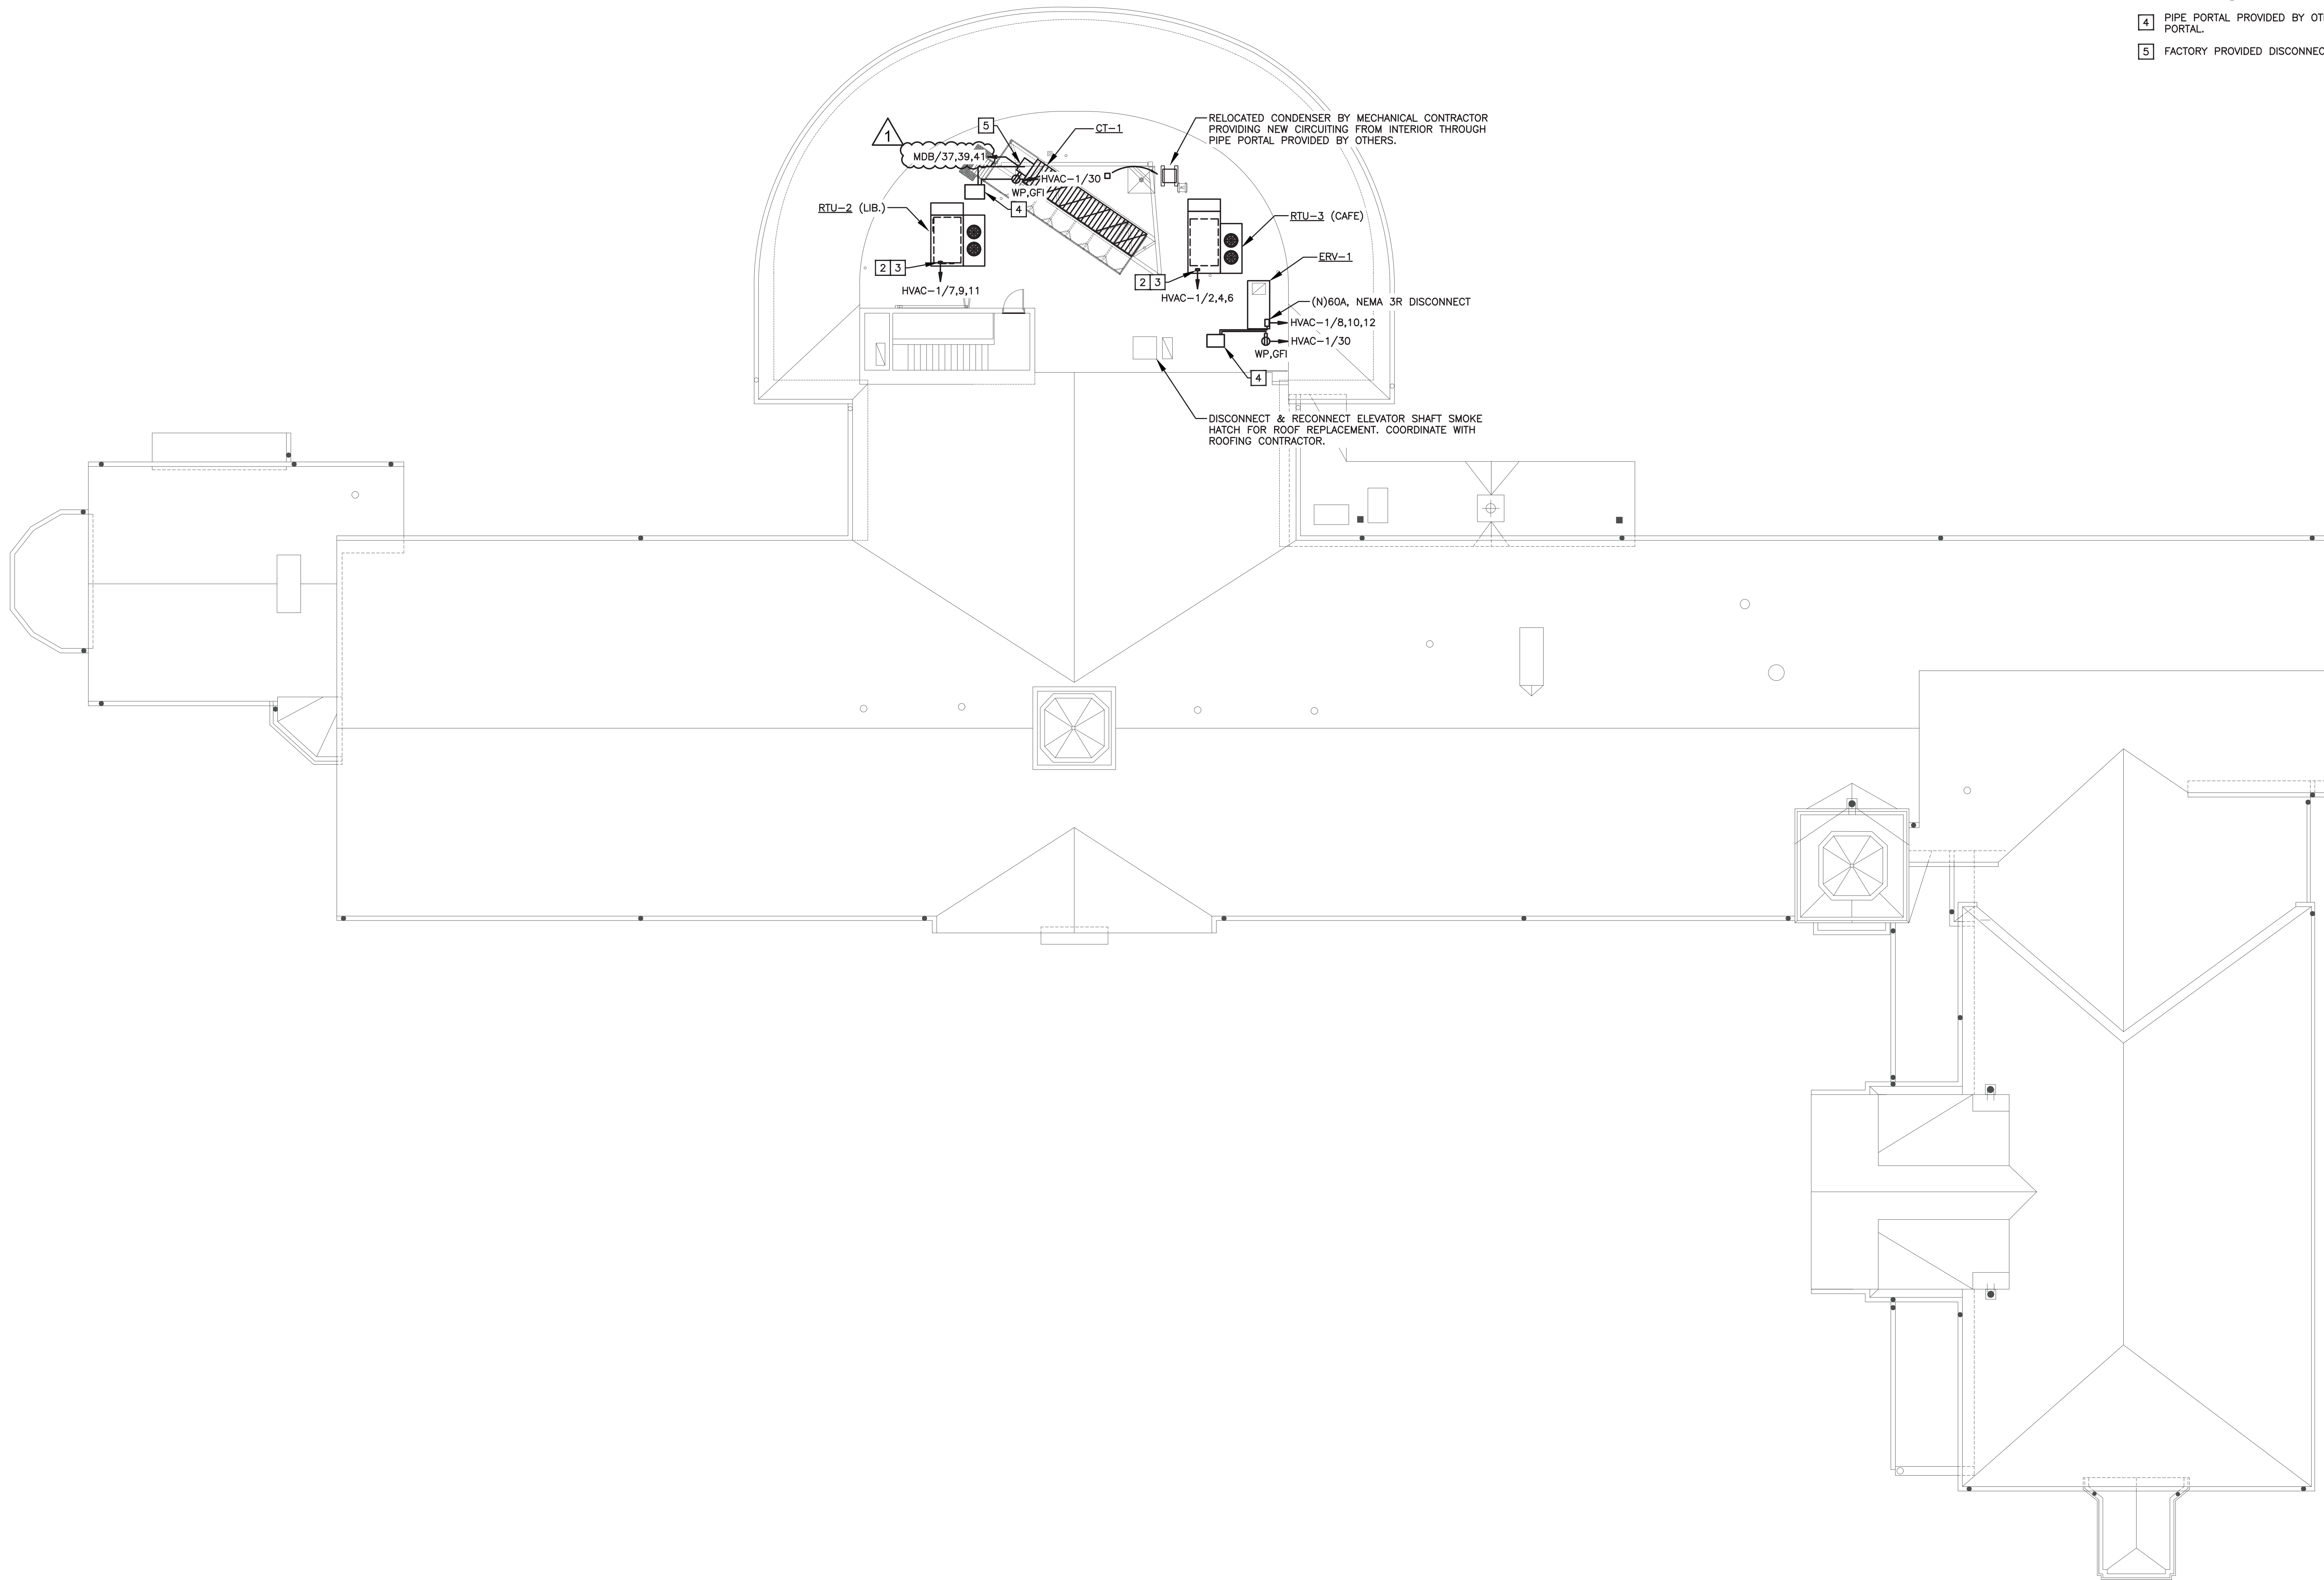

SEELY ELEMENTARY SCHOOL
ELECTRICAL PLAN - ROOF

1 SCALE: 3/32" = 1'-0"

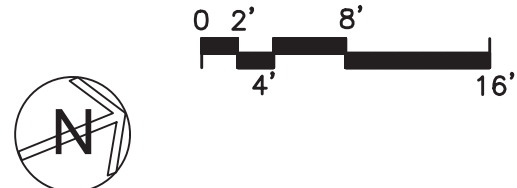

AS PER USA CONGRESS ARCHITECTURAL WORKS COPYRIGHT PROTECTION ACT OF 1990 ALL IDEAS AND DESIGNS INCLUDING DERIVATIVES THEREOF, ALL DRAWINGS AND SPECIFICATIONS CONSTITUTE THE ORIGINAL COPYRIGHT WORK BY FULLER AND D'ANGELO, P.C. (F&D). THE DRAWINGS AND SPECIFICATIONS AS INSTRUMENTS OF SERVICE BY F&D ARE CREATED BY F&D FOR THIS PROJECT ONLY AND REMAIN THE PROPERTY OF F&D. ANY REPRODUCTION WITHOUT THE PRIOR CONSENT OF F&D IS PROHIBITED.

48 SHOLLYWOOD ROAD ELLENBORO NEW YORK 12833
TEL 814-898-4444 FAX 814-898-1917
Copyright 2001 by Fuller & Angelo, P.C.

FULLER
D'ANGELO
P.C.
ARCHITECTS
PLANNERS

LFG
LANDMARK
FACILITIES
GROUP, INC.
252 East Avenue
Greenville, SC 29615
(253) 866-4628 FAX
(253) 866-4019 Fax

S.E.D. CONTROL NUMBER:
GREENVILLE ELEMENTARY SCHOOL
66-04-06-03-0-001-021
SEELY PLACE ELEMENTARY SCHOOL
66-04-06-03-0-001-019

PROJECT:
EDGEMONT SCHOOL DISTRICT
GREENVILLE ELEMENTARY SCHOOL
SEELY PLACE ELEMENTARY SCHOOL
PHASE 1 - HVAC & CATERIA

DRAWING TITLE:
ROOF ELECTRICAL PLAN

1-24-2023	ADDENDUM 1
1-06-2023	BID
DATE	ISSUED TO
SHEET SIZE 30"x42"	DRAWING NO. SPES E104
SCALE AS NOTED	FILE NO. 21434.01
DRAWN BY LFG	