



CONDENSATE TRAP DETAIL
DRAW-THRU UNIT
NO SCALE


- NOTES:
1. ALLOW SUFFICIENT SPACE BELOW DRAIN PAN FOR TRAP.
 2. PITCH DRAIN FOR PROPER RUN-OFF.
 3. MANUALLY PRIME FILL TRAP BEFORE START-UP TO FORM INITIAL DRAIN SEAL.
 4. SUPPORT LENGTHY DRAIN LINES TO PREVENT SAG AND CONDENSATE OVERFLOW.
 5. FOR PIPING ON ROOF, ROUTE CONDENSATE PIPING TO WITHIN 5FT OF ROOF DRAIN.

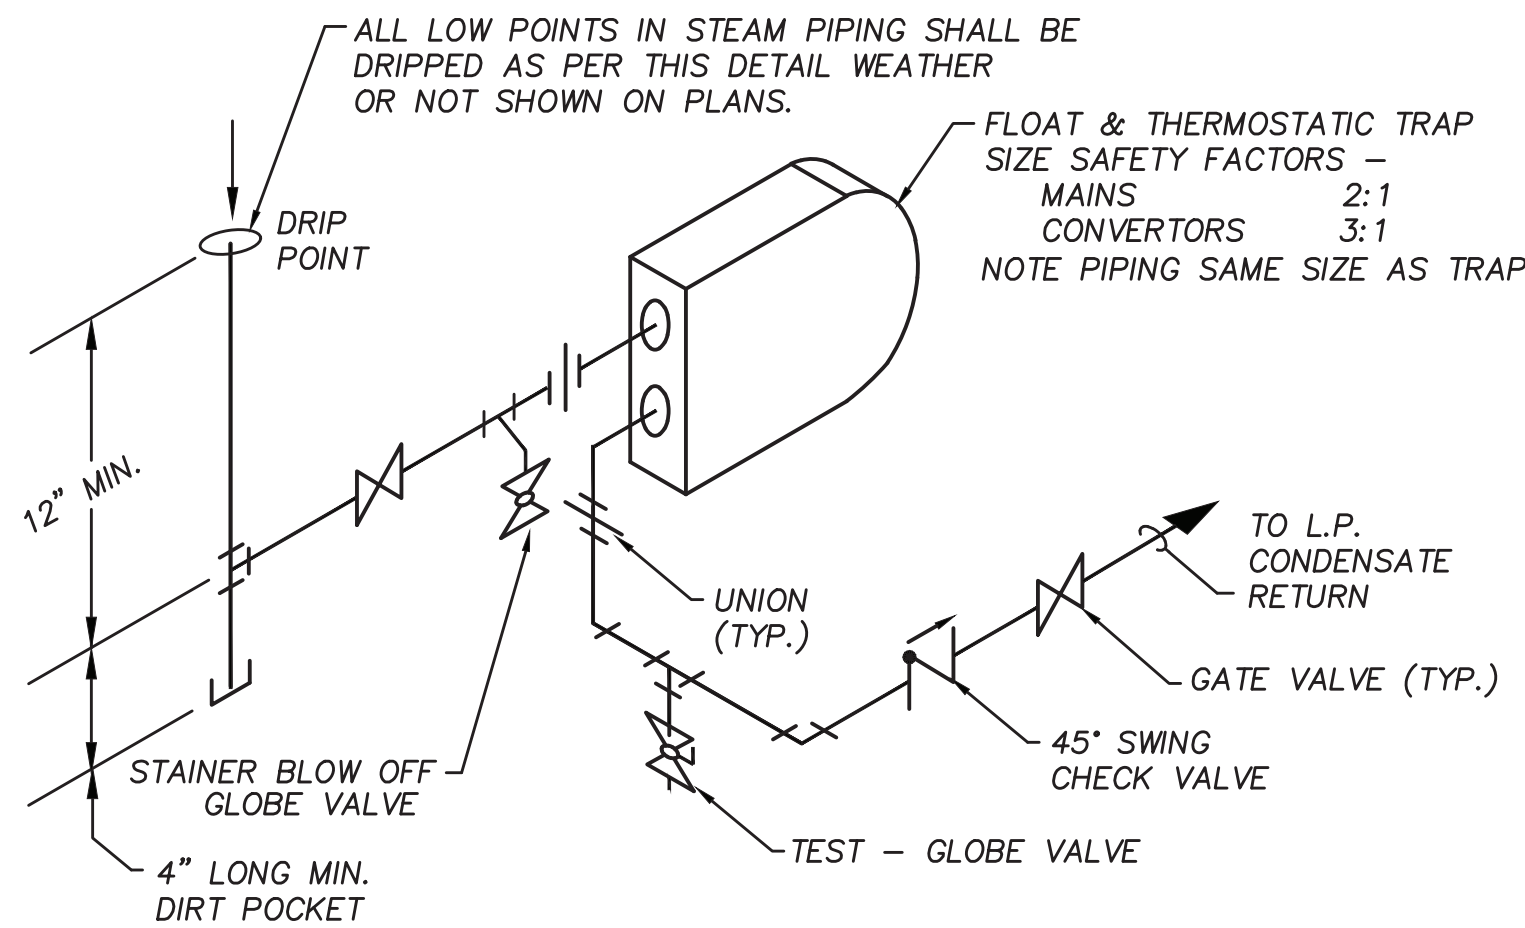

LOW PRESSURE STEAM MAIN DRIP DETAIL
N.T.S.

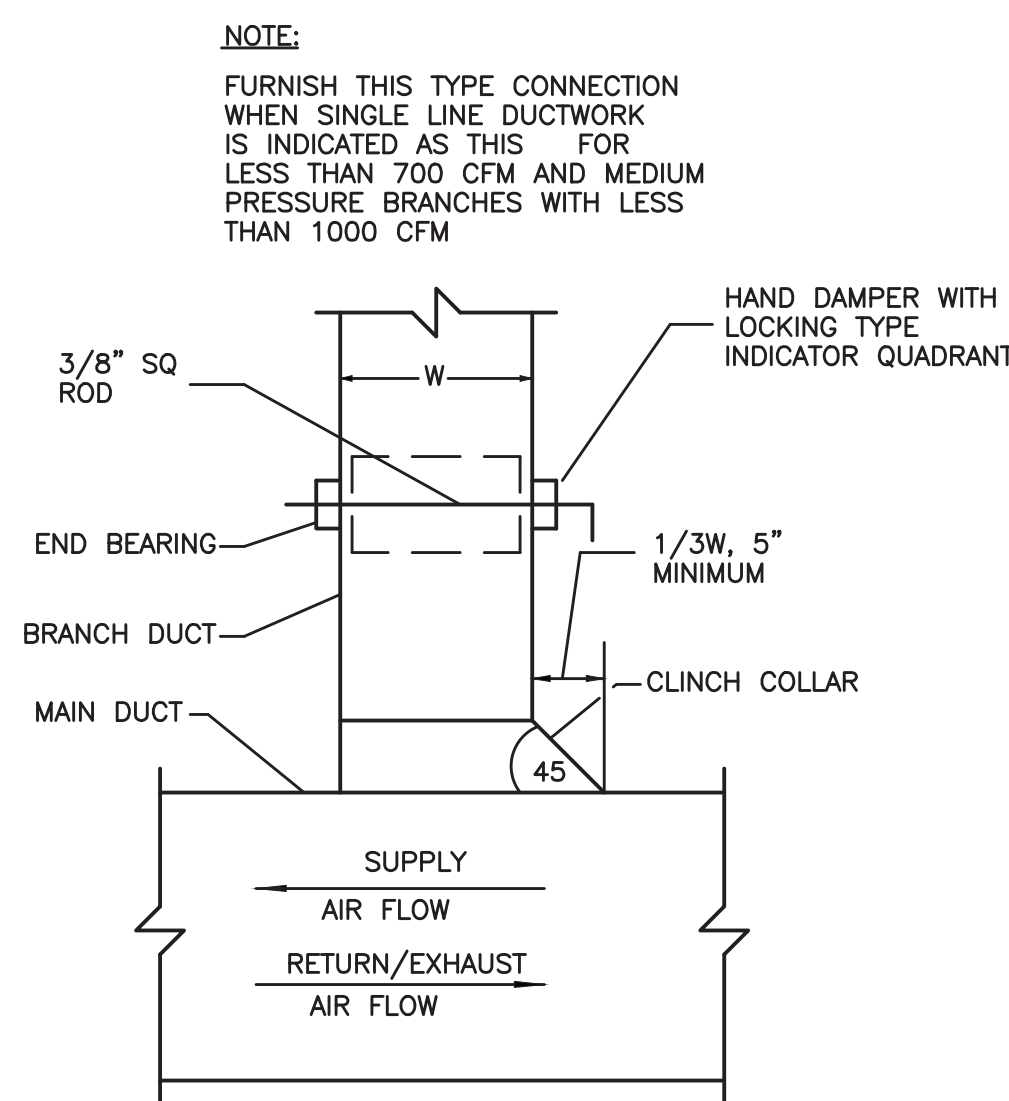


RECTANGULAR DUCT TAP
NO SCALE

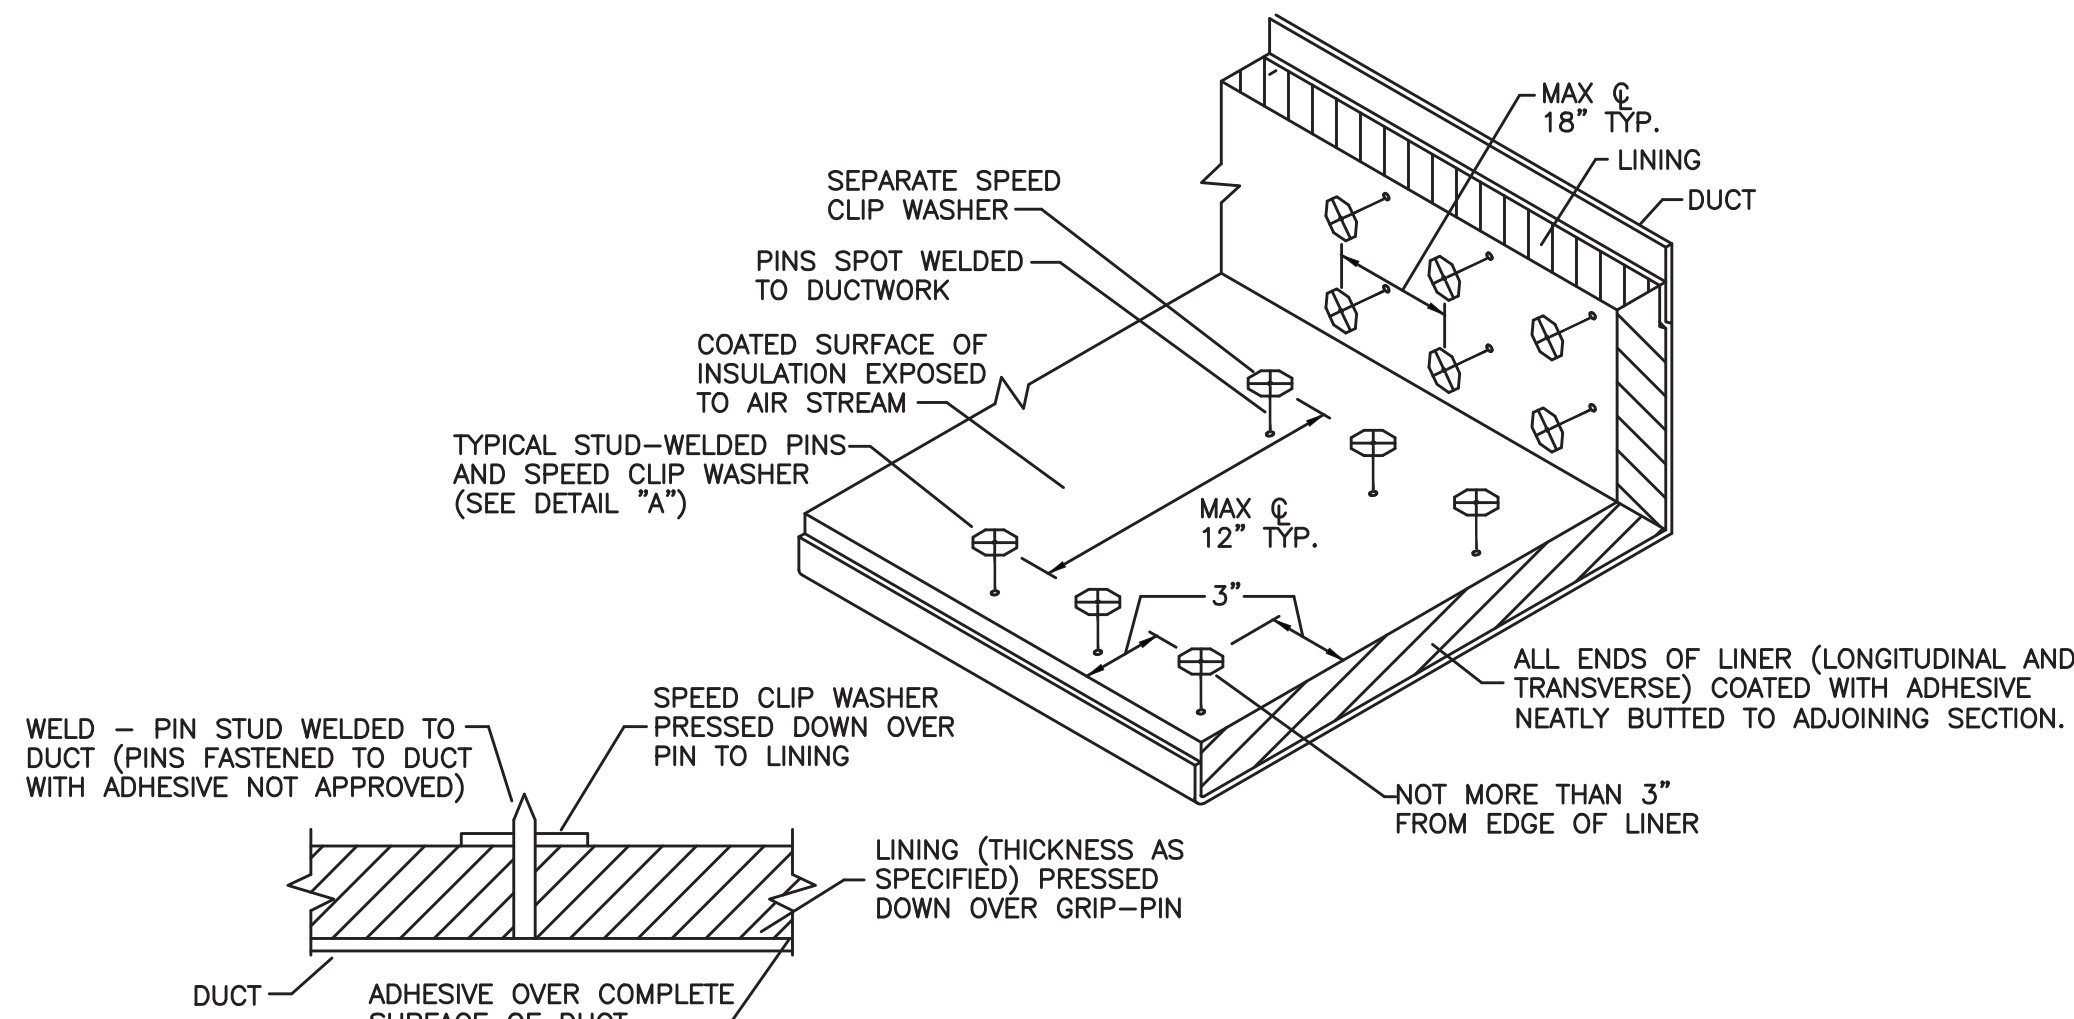


DETAIL 'A'
SOUND LINING INSTALLATION DETAIL
NO SCALE

- NOTES:
1. ALL DUCTS SHOWN TO BE ACOUSTICALLY UNED SHALL BE LINED WITH 1" THICK 3 LB. DENSITY INSULATION UNLESS OTHERWISE NOTED.

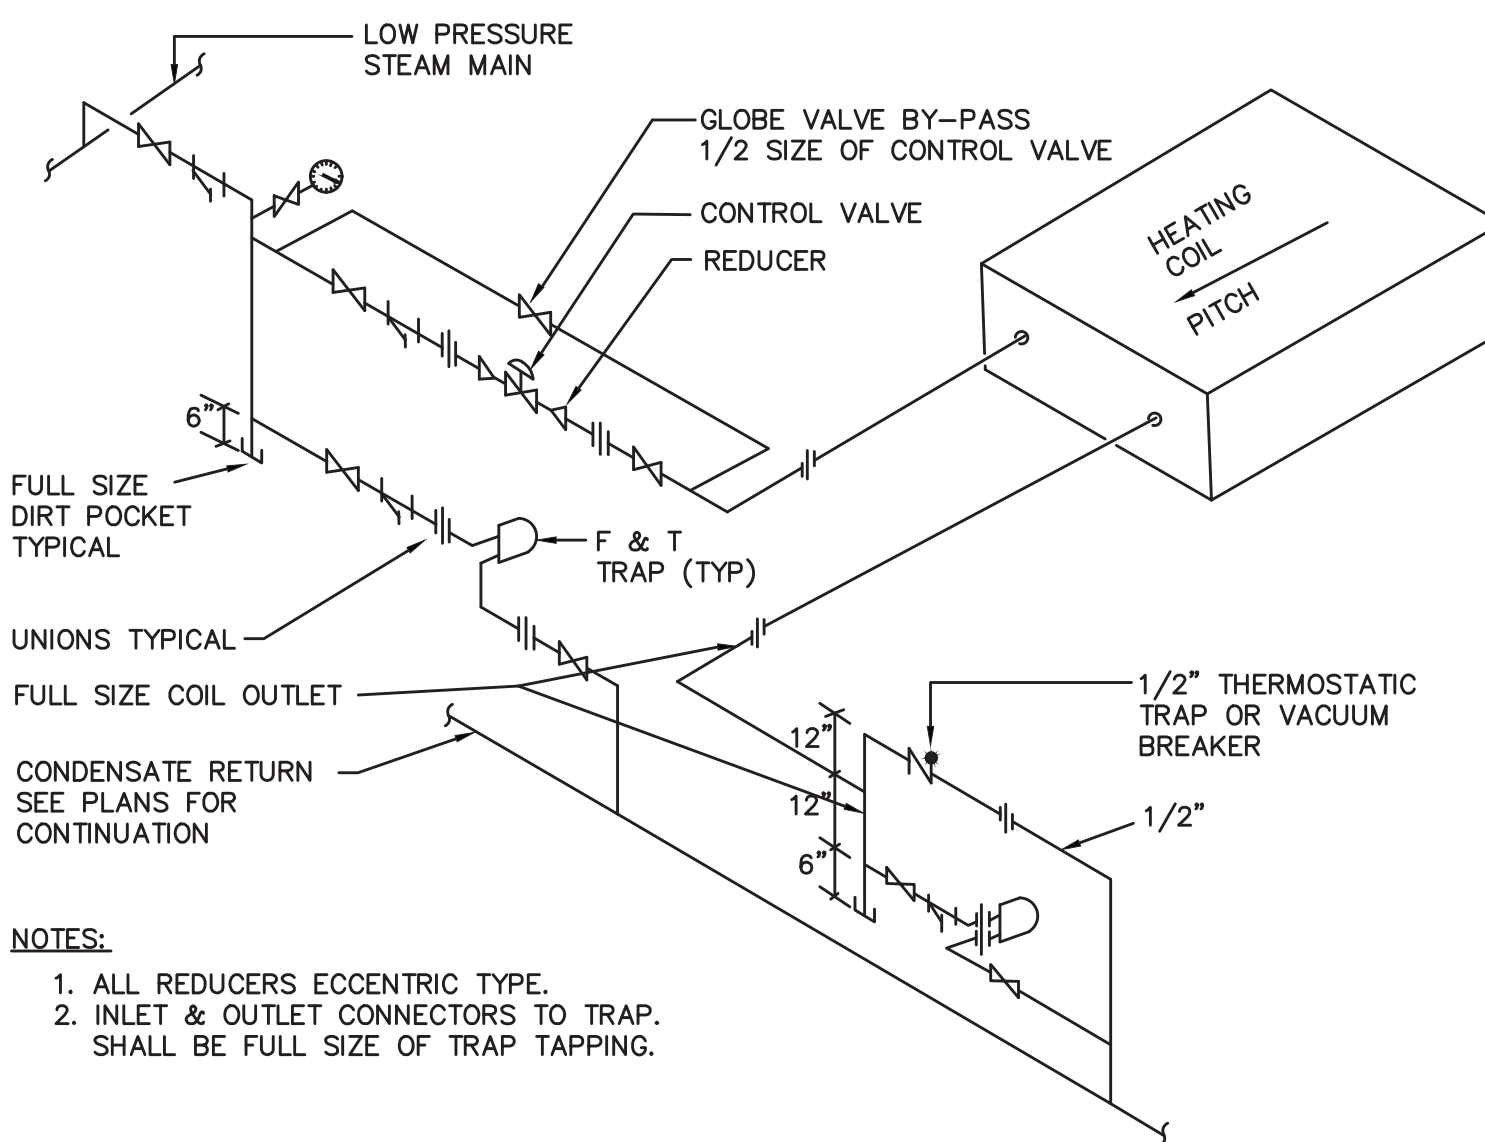


HORIZONTAL STEAM HEATING COIL PIPING
N.T.S.

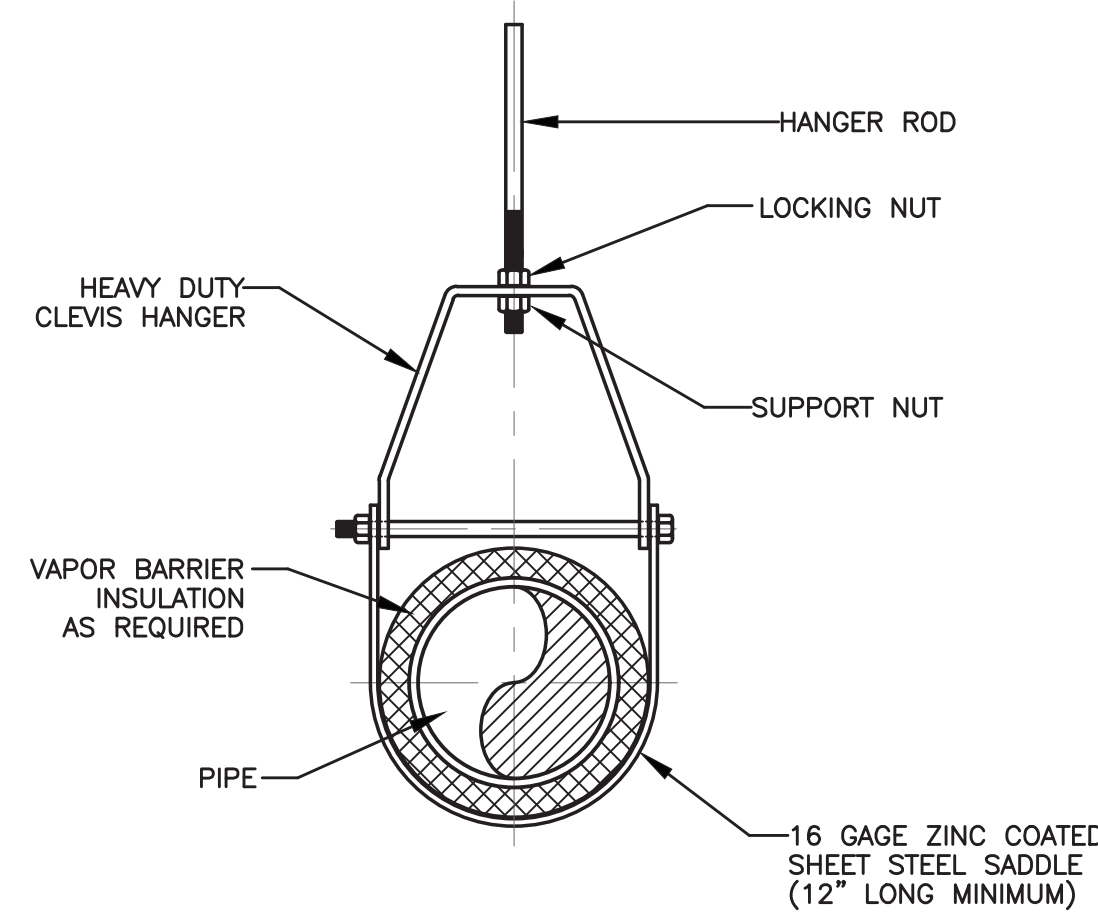


HANGER ROD SCHEDULE			
PIPE SIZE	ROD SIZE	PIPE SIZE	ROD SIZE
UP TO 2"	3/8" DIA.	4" THRU 5"	5/8" DIA.
2 1/2" THRU 3"	1/2" DIA.	6" THRU 12"	7/8" DIA.

CLEVIS HANGER
HORIZONTAL RUNS

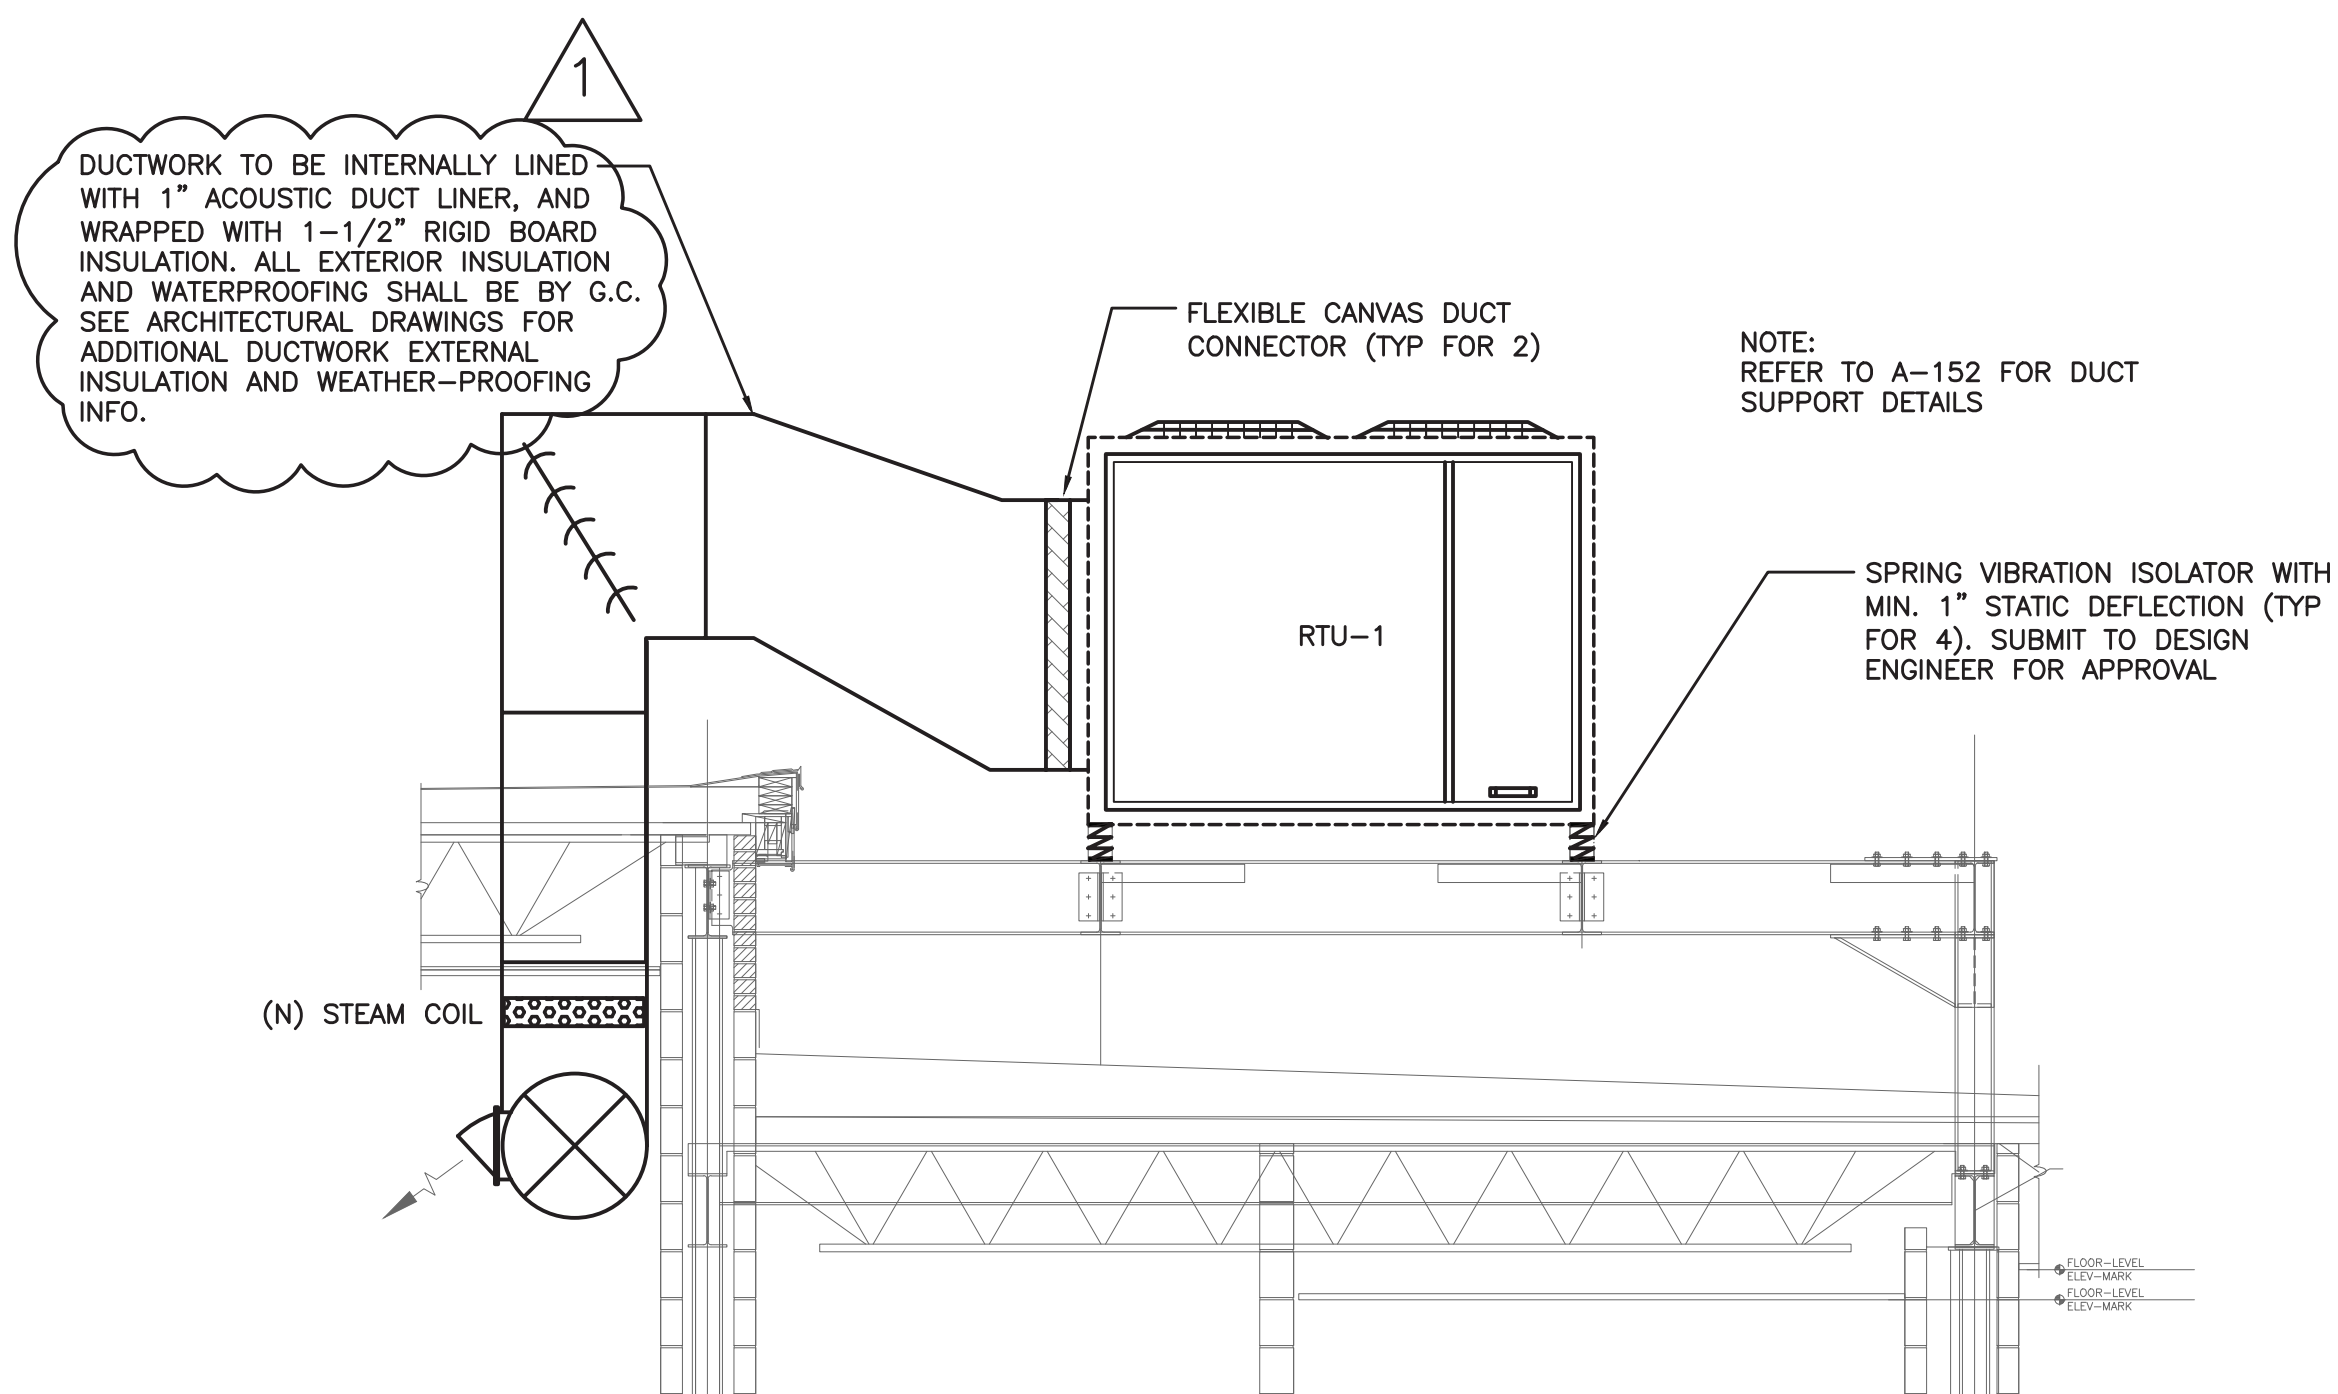

ROOFTOP UNIT INSTALLATION DETAIL
NO SCALE

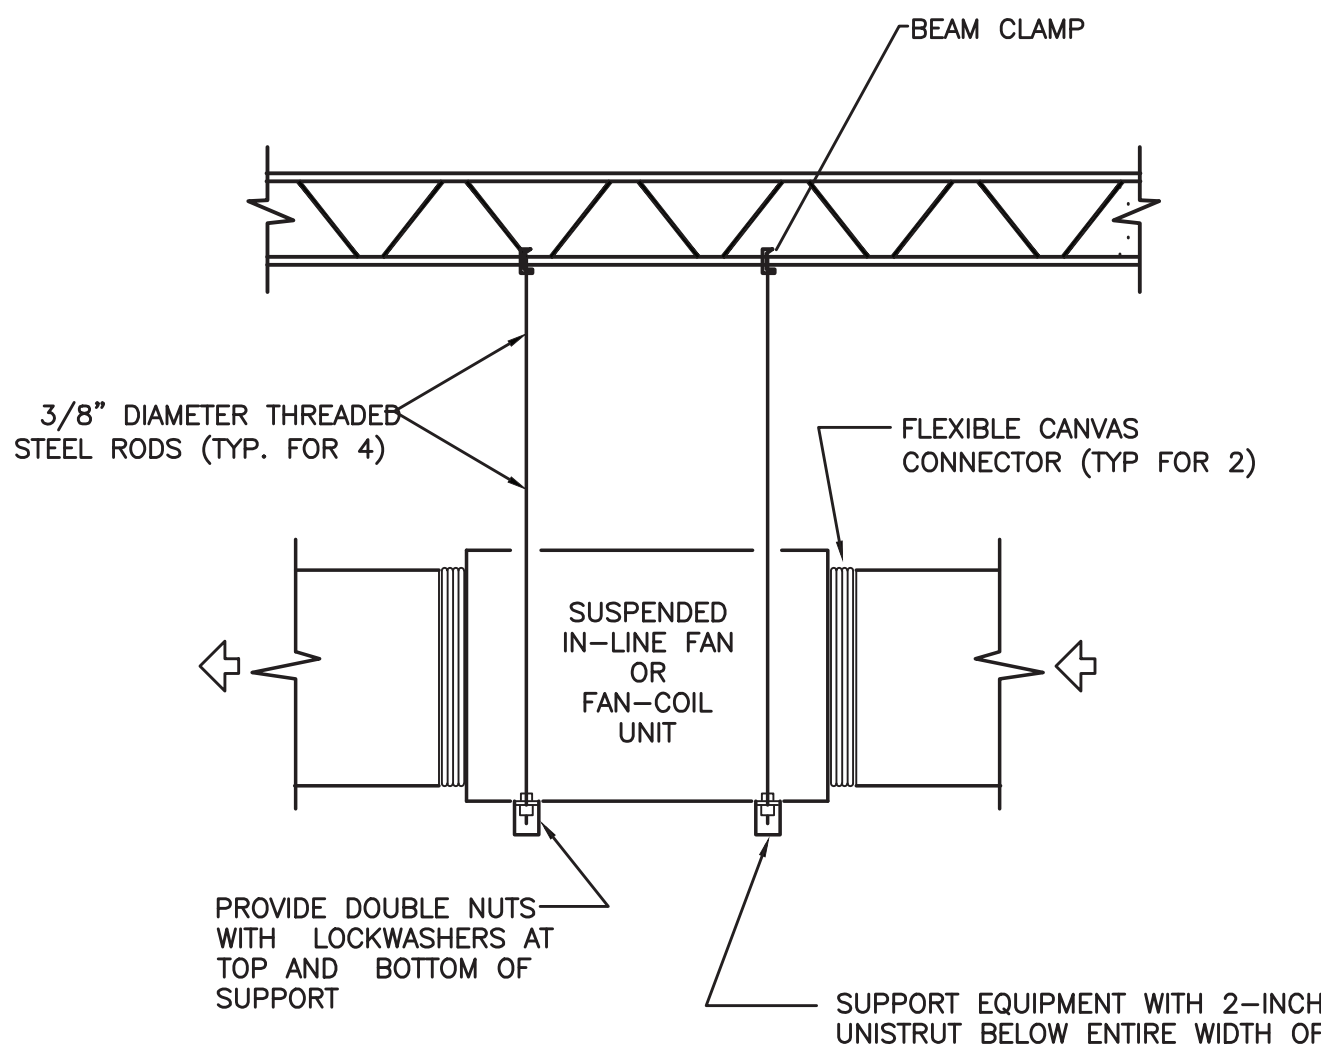

INLINE FAN SUPPORT DETAIL
TYPICAL FOR CEILING-MOUNTED FAN-COIL UNITS
AND EXHAUST FANS
NO SCALE

AS PER USA CONGRESS ARCHITECTURAL WORKS COPYRIGHT PROTECTION ACT OF 1990 ALL IDEAS AND DESIGNS INCLUDING DERIVATIVES THEREOF, ALL DRAWINGS AND SPECIFICATIONS CONSTITUTE THE ORIGINAL COPYRIGHT WORK BY FULLER AND DANKELO, P.C. (F&D). THE DRAWINGS AND SPECIFICATIONS AS INSTRUMENTS OF SERVICE BY F&D ARE CREATED BY F&D FOR THIS PROJECT ONLY AND REMAIN THE PROPERTY OF F&D. ANY REPRODUCTION WITHOUT THE PRIOR CONSENT OF F&D IS PROHIBITED.

LFG
252 East Avenue
Newark, CT 06655
(203) 866-4623 T/F
(203) 866-4019 Fax
LANDMARK
FACILITIES
GROUP, INC.

408 SHELLWATER ROAD ELLENFIELD NEW YORK 10888 FAX: 914-888-4444
TEL: 914-888-4444
Copyright 2021 All Rights Reserved by FULLER & DANKELO, P.C.

**FULLER
D'ANGELO
P.C.**
ARCHITECTS
PLANNERS

LFG
LANDMARK
FACILITIES
GROUP, INC.
252 East Avenue
Newark, CT 06655
(203) 866-4623 T/F
(203) 866-4019 Fax

S.E.D. CONTROL NUMBER:
GREENVILLE ELEMENTARY SCHOOL
66-04-05-03-0-004-021
SEELY PLACE ELEMENTARY SCHOOL
66-04-06-03-0-001-019

PROJECT:
EDGEMONT SCHOOL DISTRICT
GREENVILLE ELEMENTARY SCHOOL
SEELY PLACE ELEMENTARY SCHOOL
PHASE 1 - HVAC & CAFETERIA
DRAWING TITLE:
MECHANICAL DETAILS

1-24-2023 ADDENDUM #1
1-06-2023 BID
DATE ISSUED TO

SHEET SIZE:
30"x42"
SCALE:
AS NOTED
DRAWING NO.
GVES
M200

DRAWN BY:
LFG
FILE NO.
21434.01