


PLOT DATE: January 24, 2023 -- 11:08am

FILE: N:\Edgemont School District\Seely Place Elementary Phase 1\ACAD\Electrical\SPES_Removals.dwg

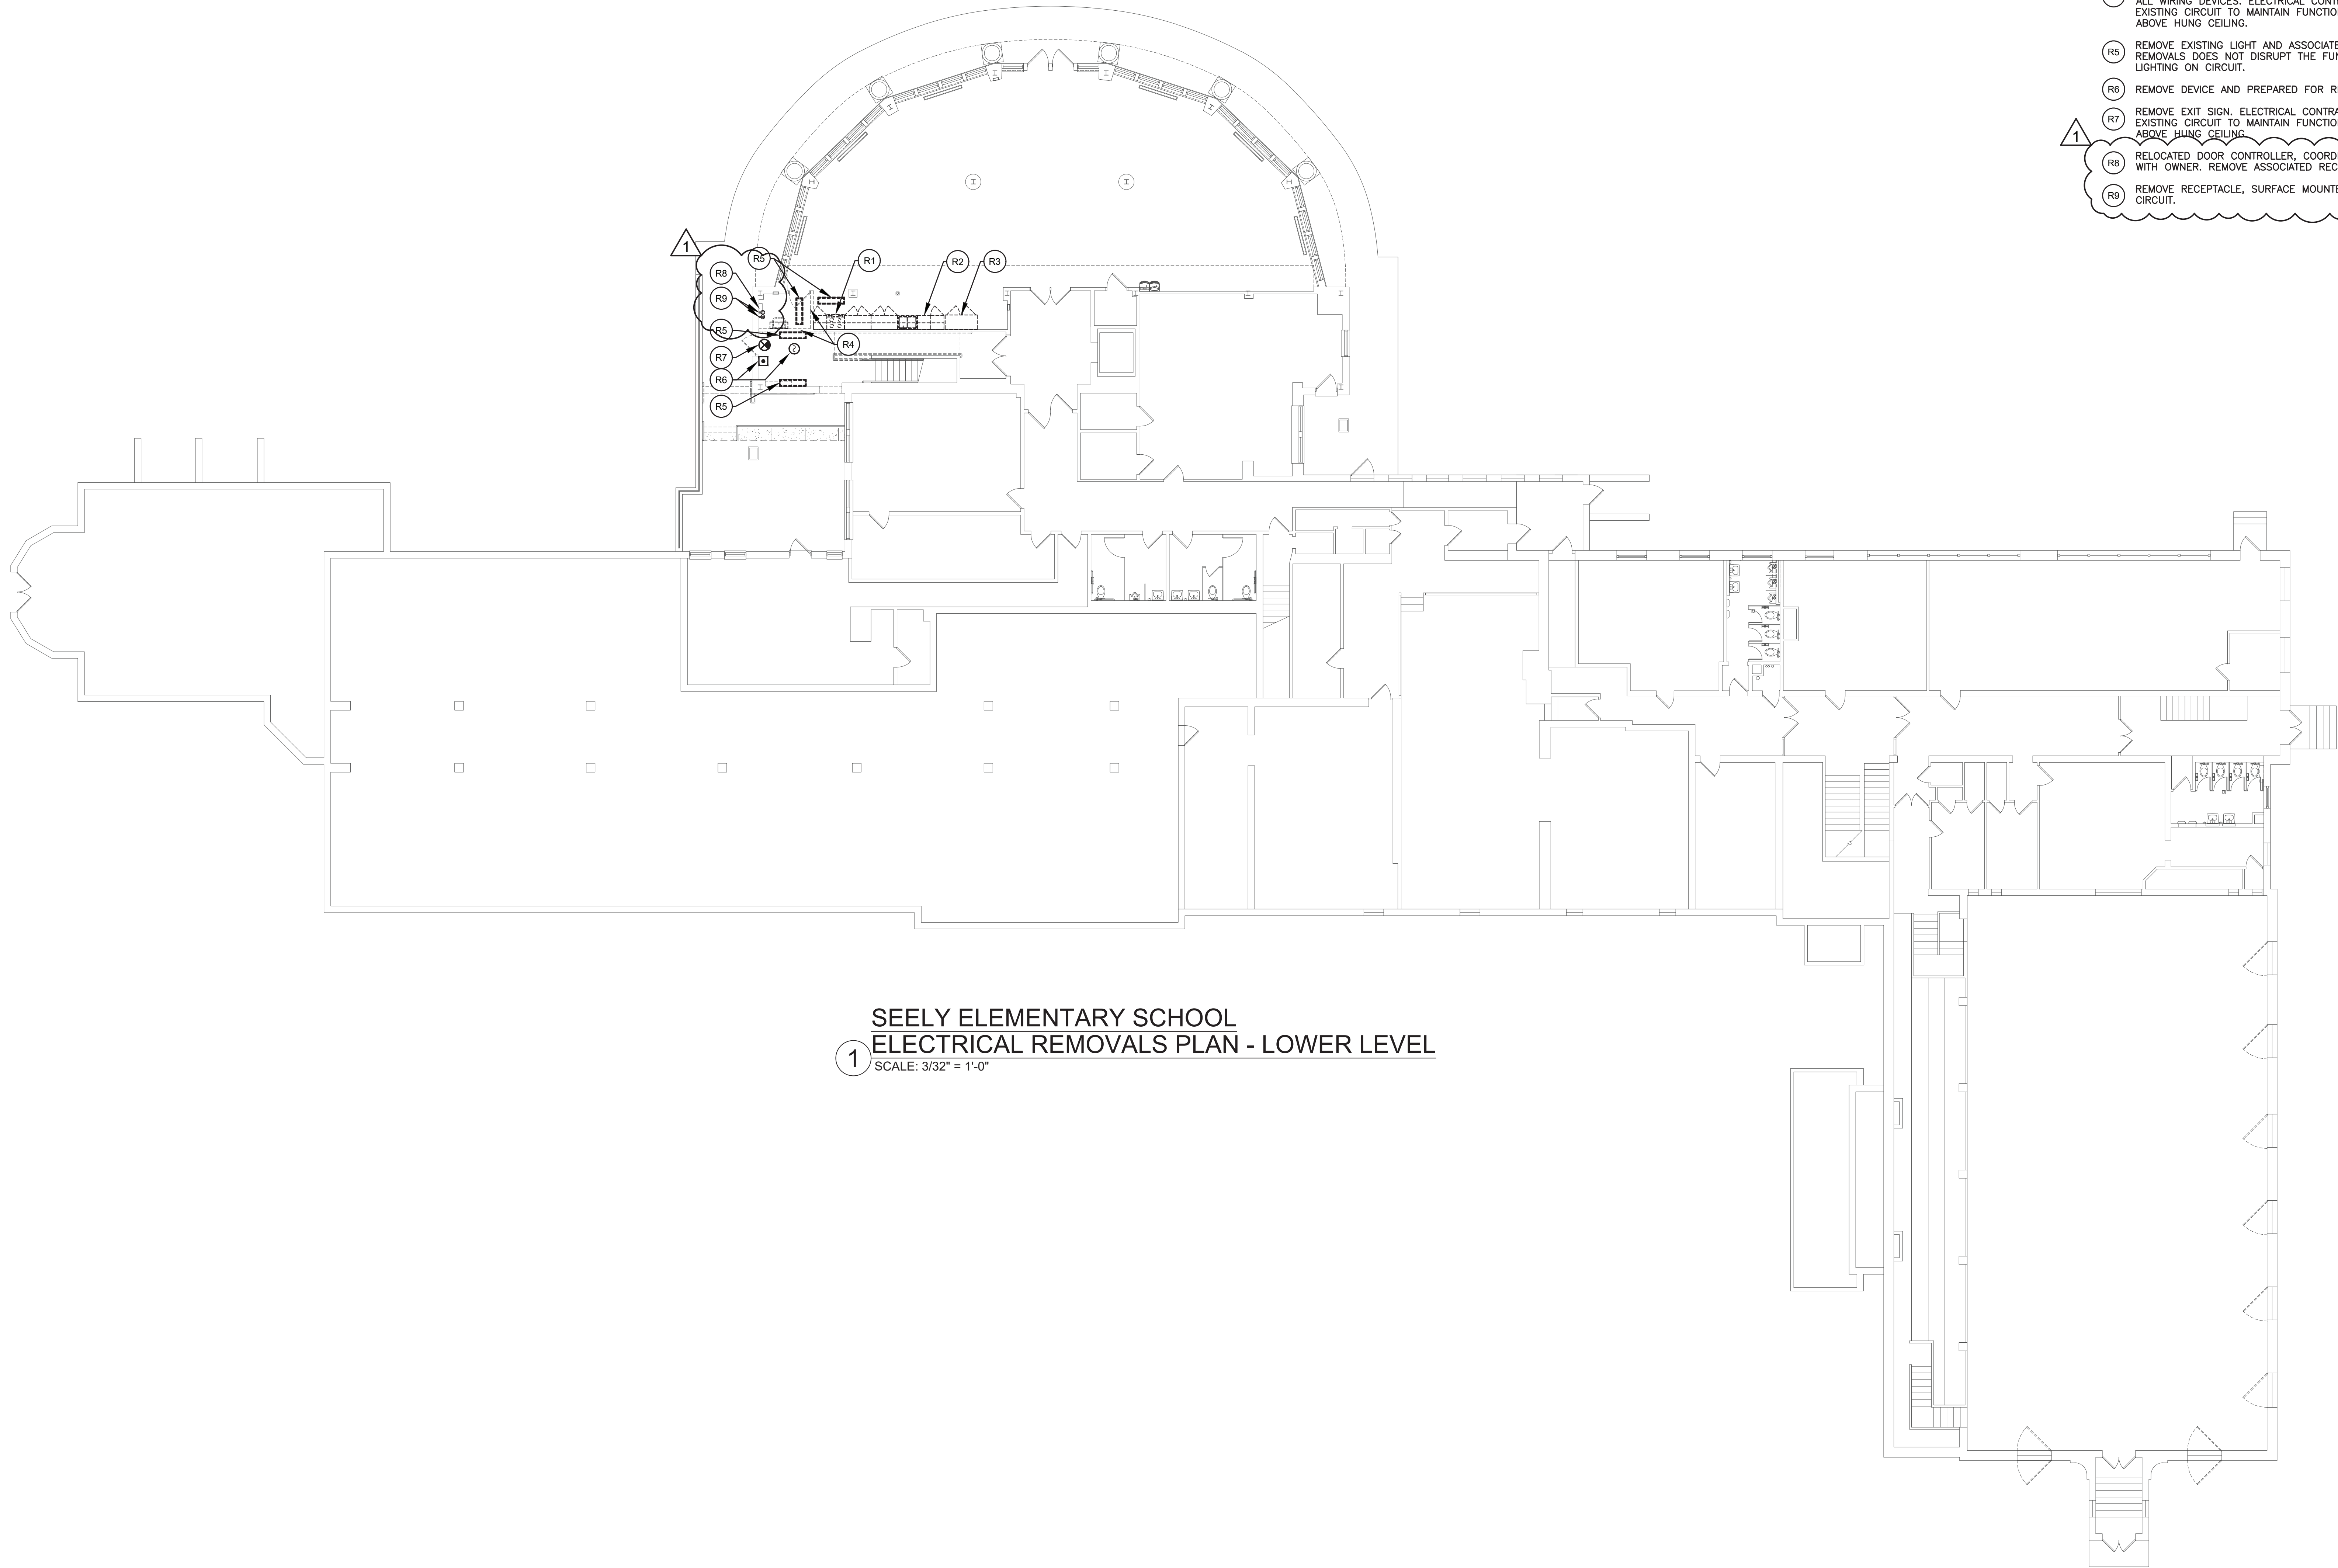

SEELY ELEMENTARY SCHOOL
ELECTRICAL REMOVALS PLAN - LOWER LEVEL
1 SCALE: 3/32" = 1'-0"

GENERAL NOTES:

1. ELECTRICAL CONTRACTOR RESPONSIBLE FOR REMOVING AND REINSTALLING CEILING TILE AND SUSPENSION SYSTEM AND ALL CEILING MOUNTED DEVICES. (TYPICAL)
2. DASHED WALLS ARE REMOVED BY GC.

REMOVAL NOTES:

- R1 ELECTRICAL CONTRACTOR SHALL REMOVE WIRING DEVICE AND CIRCUIT FOR ELECTRIC RANGE BACK TO PANEL.
- R2 ELECTRICAL CONTRACTOR SHALL REMOVE WIRING DEVICE AND CIRCUIT FOR DISHWASHER BACK TO PANEL.
- R3 ELECTRICAL CONTRACTOR SHALL REMOVE WIRING DEVICE AND CIRCUIT FOR FOOD SERVICE EQUIPMENT BACK TO PANEL.
- R4 WALLS REMOVED BY GC. ELECTRICAL CONTRACTOR SHALL REMOVE ALL WIRING DEVICES. ELECTRICAL CONTRACTOR SHALL REWIRING THE EXISTING CIRCUIT TO MAINTAIN FUNCTIONALITY. PLACE ALL SPLICES ABOVE HUNG CEILING.
- R5 REMOVE EXISTING LIGHT AND ASSOCIATED CONTROL DEVICES. ENSURE REMOVALS DOES NOT DISRUPT THE FUNCTIONALITY OF THE REMAINING LIGHTING ON CIRCUIT.
- R6 REMOVE DEVICE AND PREPARED FOR RELOCATION PER FA100.
- R7 REMOVE EXIT SIGN. ELECTRICAL CONTRACTOR SHALL REWIRING THE EXISTING CIRCUIT TO MAINTAIN FUNCTIONALITY. PLACE ALL SPLICES ABOVE HUNG CEILING.
- R8 RELOCATED DOOR CONTROLLER, COORDINATE NEW LOCATION IN FIELD WITH OWNER. REMOVE ASSOCIATED RECEPTACLE AND CIRCUIT.
- R9 REMOVE RECEPTACLE, SURFACE MOUNTED RACEWAY, AND ASSOCIATED CIRCUIT.

AS PER USA CONGRESS ARCHITECTURAL WORKS COPYRIGHT PROTECTION ACT OF 1990 ALL IDEAS AND DESIGNS INCLUDING DERIVATIVES THEREOF, ALL DRAWINGS AND SPECIFICATIONS CONSTITUTE THE ORIGINAL COPYRIGHT WORK BY FULLER D'ANGELO, P.C. (F&D). THE DRAWINGS AND SPECIFICATIONS AS INSTRUMENTS OF SERVICE BY F&D ARE CREATED BY F&D FOR THIS PROJECT ONLY AND REMAIN THE PROPERTY OF F&D. ANY REPRODUCTION WITHOUT THE PRIOR CONSENT OF F&D IS PROHIBITED.

408 CHILWORTH ROAD ELLENFIELD NEW YORK 10828
TEL: 914-898-4444 FAX: 914-898-1179
Copyright 2001 by Fuller D'Angelo P.C.

FULLER
D'ANGELO
P.C.
ARCHITECTS
PLANNERS

LFG
LANDMARK
FACILITIES
GROUP, INC.
252 East Avenue
Greenville, SC 29605
(253) 866-4020 FAX
(253) 866-4019 FAX


S.E.D. CONTROL NUMBER:
GREENVILLE ELEMENTARY SCHOOL
66-04-06-03-0-008-021
SEELY PLACE ELEMENTARY SCHOOL
66-04-06-03-0-001-019

PROJECT:
EDGEMONT SCHOOL DISTRICT
GREENVILLE ELEMENTARY SCHOOL
SEELY PLACE ELEMENTARY SCHOOL
PHASE 1 - HVAC & CATERIA

DRAWING TITLE:
BASEMENT ELECTRICAL
REMOVALS PLAN

1-24-2023	ADDENDUM 1
1-06-2023	BID
DATE	ISSUED TO
SHEET SIZE 30"x42"	DRAWING NO. SPES ER100
SCALE AS NOTED	FILE NO. 21434.01
DRAWN BY LFG	

- 1 REMOVAL NOTES:
- R1 ELECTRICAL CONTRACTOR SHALL REMOVE UNIT, DISCONNECT AND CIRCUIT BACK TO PANEL "HVAC-1". REMOVE ANY ASSOCIATED DUCT SMOKE DETECTORS AND CONTROL REALYS.
- R2 ELECTRICAL CONTRACTOR SHALL ASSIST MECHANICAL CONTRACTOR IN MOVING EXISTING CONDENSING UNIT. MOVE, DISCONNECT AND CIRCUIT. RE-CIRCUIT FROM INTERIOR THROUGH NEW PIPE PORTAL, PROVIDE WIRING AND CONDUIT AS NEEDED.

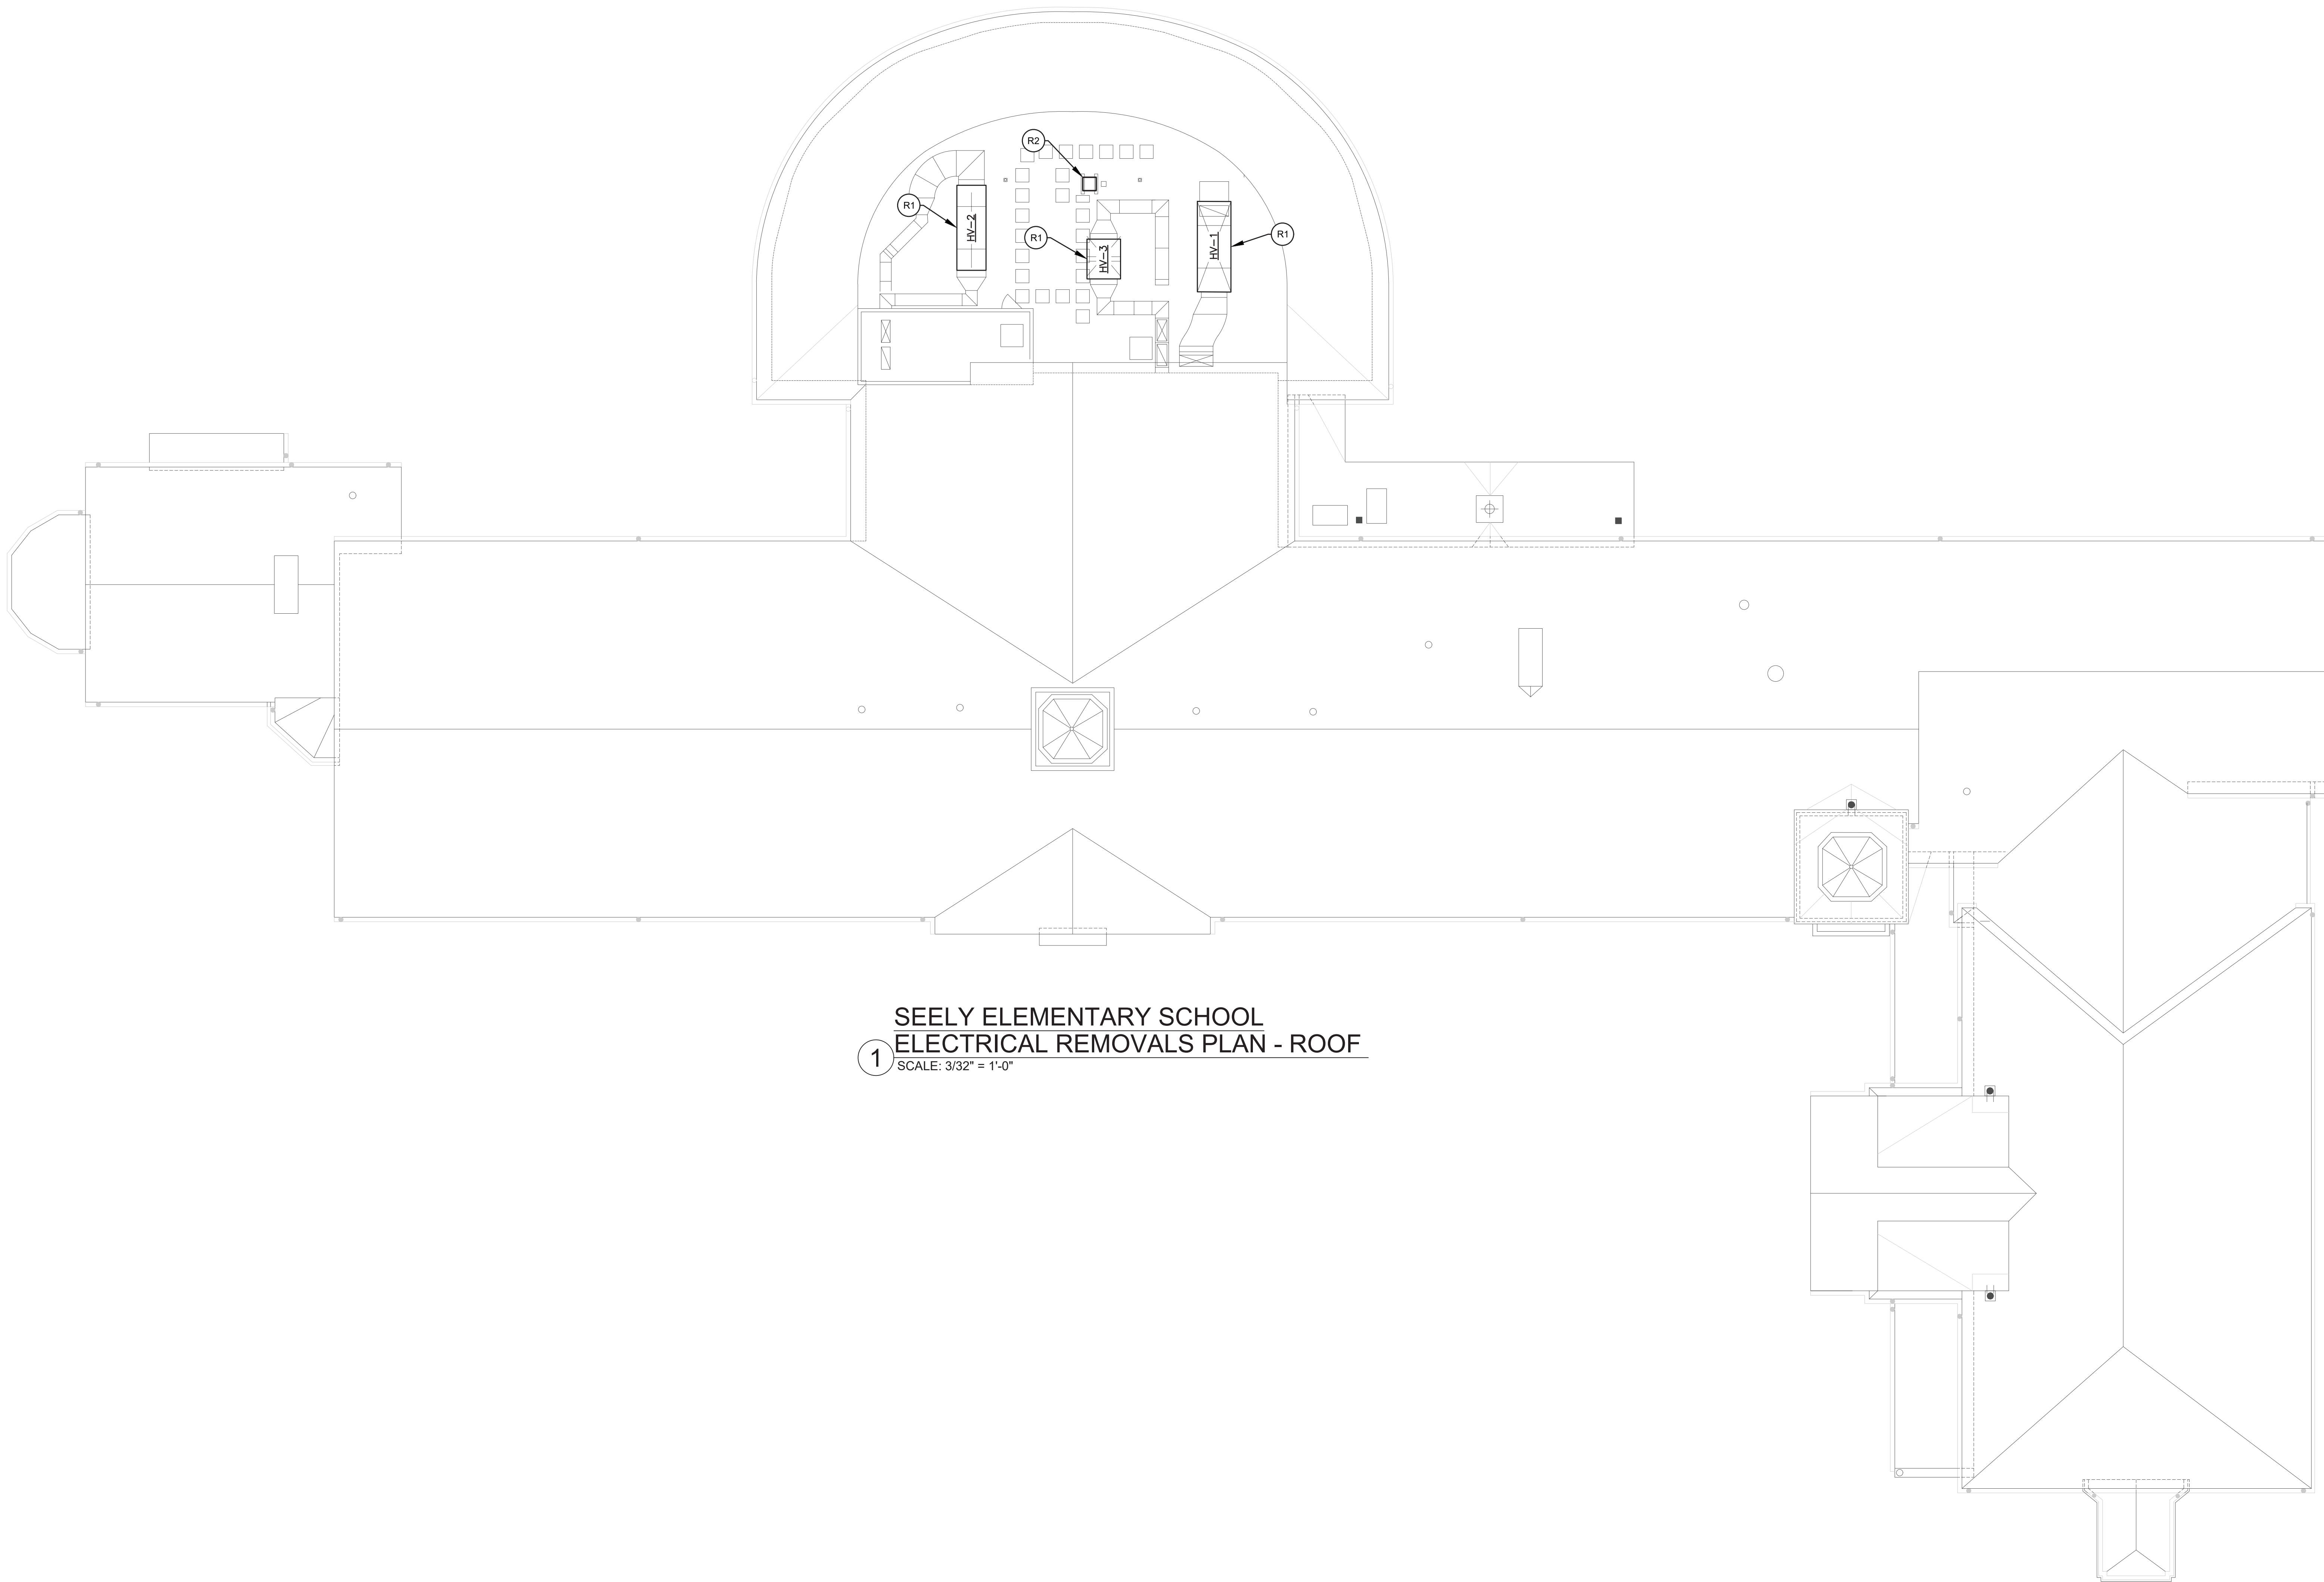

1 SEELY ELEMENTARY SCHOOL
ELECTRICAL REMOVALS PLAN - ROOF
SCALE: 3/32" = 1'-0"

AS PER USA CONGRESS ARCHITECTURAL WORKS COPYRIGHT PROTECTION ACT OF 1990 ALL IDEAS AND DESIGNS INCLUDING DERIVATIVES THEREOF, ALL DRAWINGS AND SPECIFICATIONS CONSTITUTE THE ORIGINAL COPYRIGHT WORK BY FULLER D'ANGELO, P.C. (F&D). THE DRAWINGS AND SPECIFICATIONS AS INSTRUMENTS OF SERVICE BY F&D ARE CREATED BY F&D FOR THIS PROJECT ONLY AND REMAIN THE PROPERTY OF F&D. ANY REPRODUCTION WITHOUT THE PRIOR CONSENT OF F&D IS PROHIBITED.

408 CHERRYWOOD ROAD ELLENFIELD NEW YORK 10888
TEL: 914-898-4444 FAX: 914-898-1177
Copyright 2001 by Fuller D'Angelo P.C.

FULLER
D'ANGELO
P.C.
ARCHITECTS
PLANNERS

LFG
LANDMARK
FACILITIES
GROUP, INC.
252 East Avenue
New Rochelle, NY 10801
(203) 866-4626 FAX
(203) 866-4019 Fax

S.E.D. CONTROL NUMBER:
GREENVILLE ELEMENTARY SCHOOL
66-04-06-03-0-009-021
SEELY PLACE ELEMENTARY SCHOOL
66-04-06-03-0-001-019



PROJECT:
EDGEMONT SCHOOL DISTRICT
GREENVILLE ELEMENTARY SCHOOL
SEELY PLACE ELEMENTARY SCHOOL
PHASE 1 - HVAC & CATERIA

DRAWING TITLE:
ROOF ELECTRICAL REMOVALS
PLAN


1-24-2023	ADDENDUM 1
1-06-2023	BID
DATE	ISSUED TO
SHEET SIZE 30"x42"	DRAWING NO. SPES ER104
SCALE AS NOTED	FILE NO. 21434.01
DRAWN BY LFG	

1. ELECTRICAL CONTRACTOR RESPONSIBLE FOR REMOVING AND REINSTALLING CEILING TIE AND SUSPENSION SYSTEM AND ALL CEILING MOUNTED DEVICES. (TYPICAL)
2. SLAB TRENCHING BY ELECTRICAL CONTRACTOR. RESTORE SLAB ONCE FLOOR BOX & CONDUIT INSTALLATION IS COMPLETE. REFER TO SLAB PATCH DETAIL 2 ON SHEET E001.

- 1 DISCONNECT SWITCH, VARIABLE FREQUENCY DRIVE, OR MOTOR STARTER FURNISHED BY MECHANICAL CONTRACTOR, INSTALLED & WIRED BY ELECTRICAL CONTRACTOR.
- 2 CONTRACTOR SHALL TRENCH SLAB AND INSTALL CONDUIT SERVING FLOOR BOXES. CONDUIT COVERED IN CONCRETE PERMITTED TO BE PVC.
 - (1) 1" FOR DATA
 - (6) 1/2" FOR POWER BRANCH CIRCUITS
- 3 CONTRACTOR SHALL TRENCH SLAB AND INSTALL CONDUIT SERVING FLOOR BOXES. CONDUIT COVERED IN CONCRETE PERMITTED TO BE PVC.
 - (2) 1/2" FOR POWER BRANCH CIRCUITS
- 4 WALL FURRED OUT BY GC FOR ELECTRICAL AND PLUMBING.
- 5 NEW EXIT SIGNS, CIRCUIT TO EXISTING EXIT SIGN CIRCUIT.
- 6 CONTRACTOR SHALL USE WIREMOLD ON EXISTING WALL.
- 7 POWER & DATA FLOORBOX "F10". REFER TO FLOORBOX SCHEDULE ON SHEET SPES E001, FOR REQUIRED FLOORBOX, COVER, DEVICE PLATES, AND WIRING DEVICES.
- 8 POWER FLOORBOX "F2". REFER TO FLOORBOX SCHEDULE ON SHEET SPES E001FOR REQUIRED FLOORBOX, COVER, DEVICE PLATES, AND WIRING DEVICES.

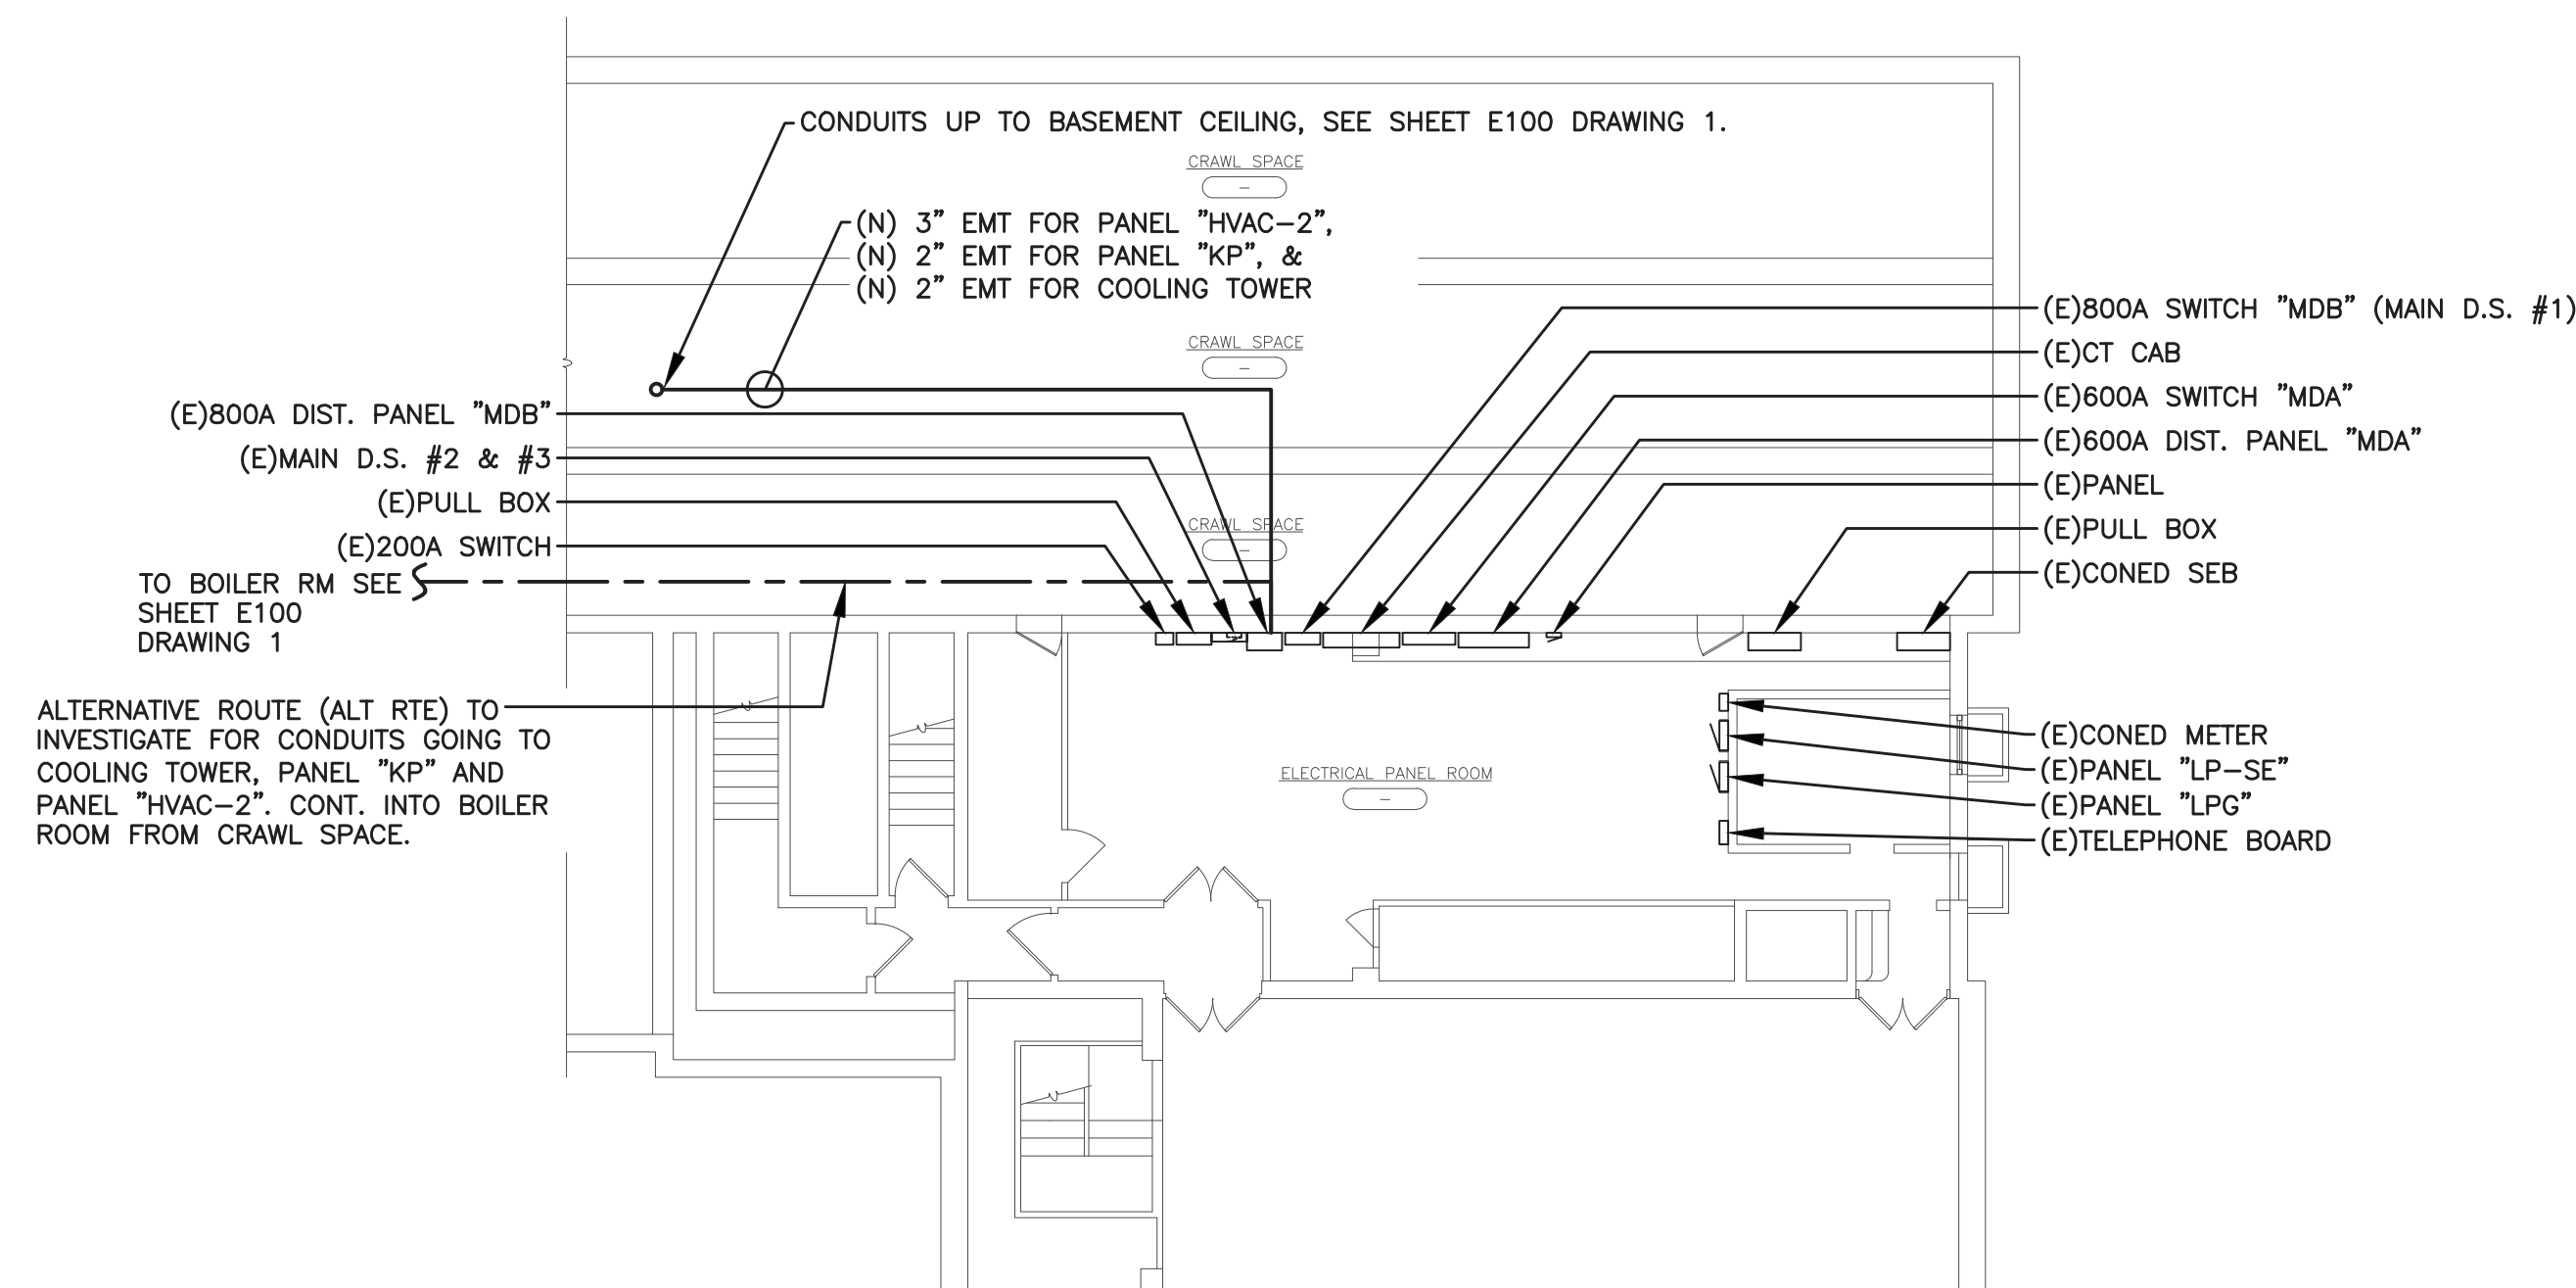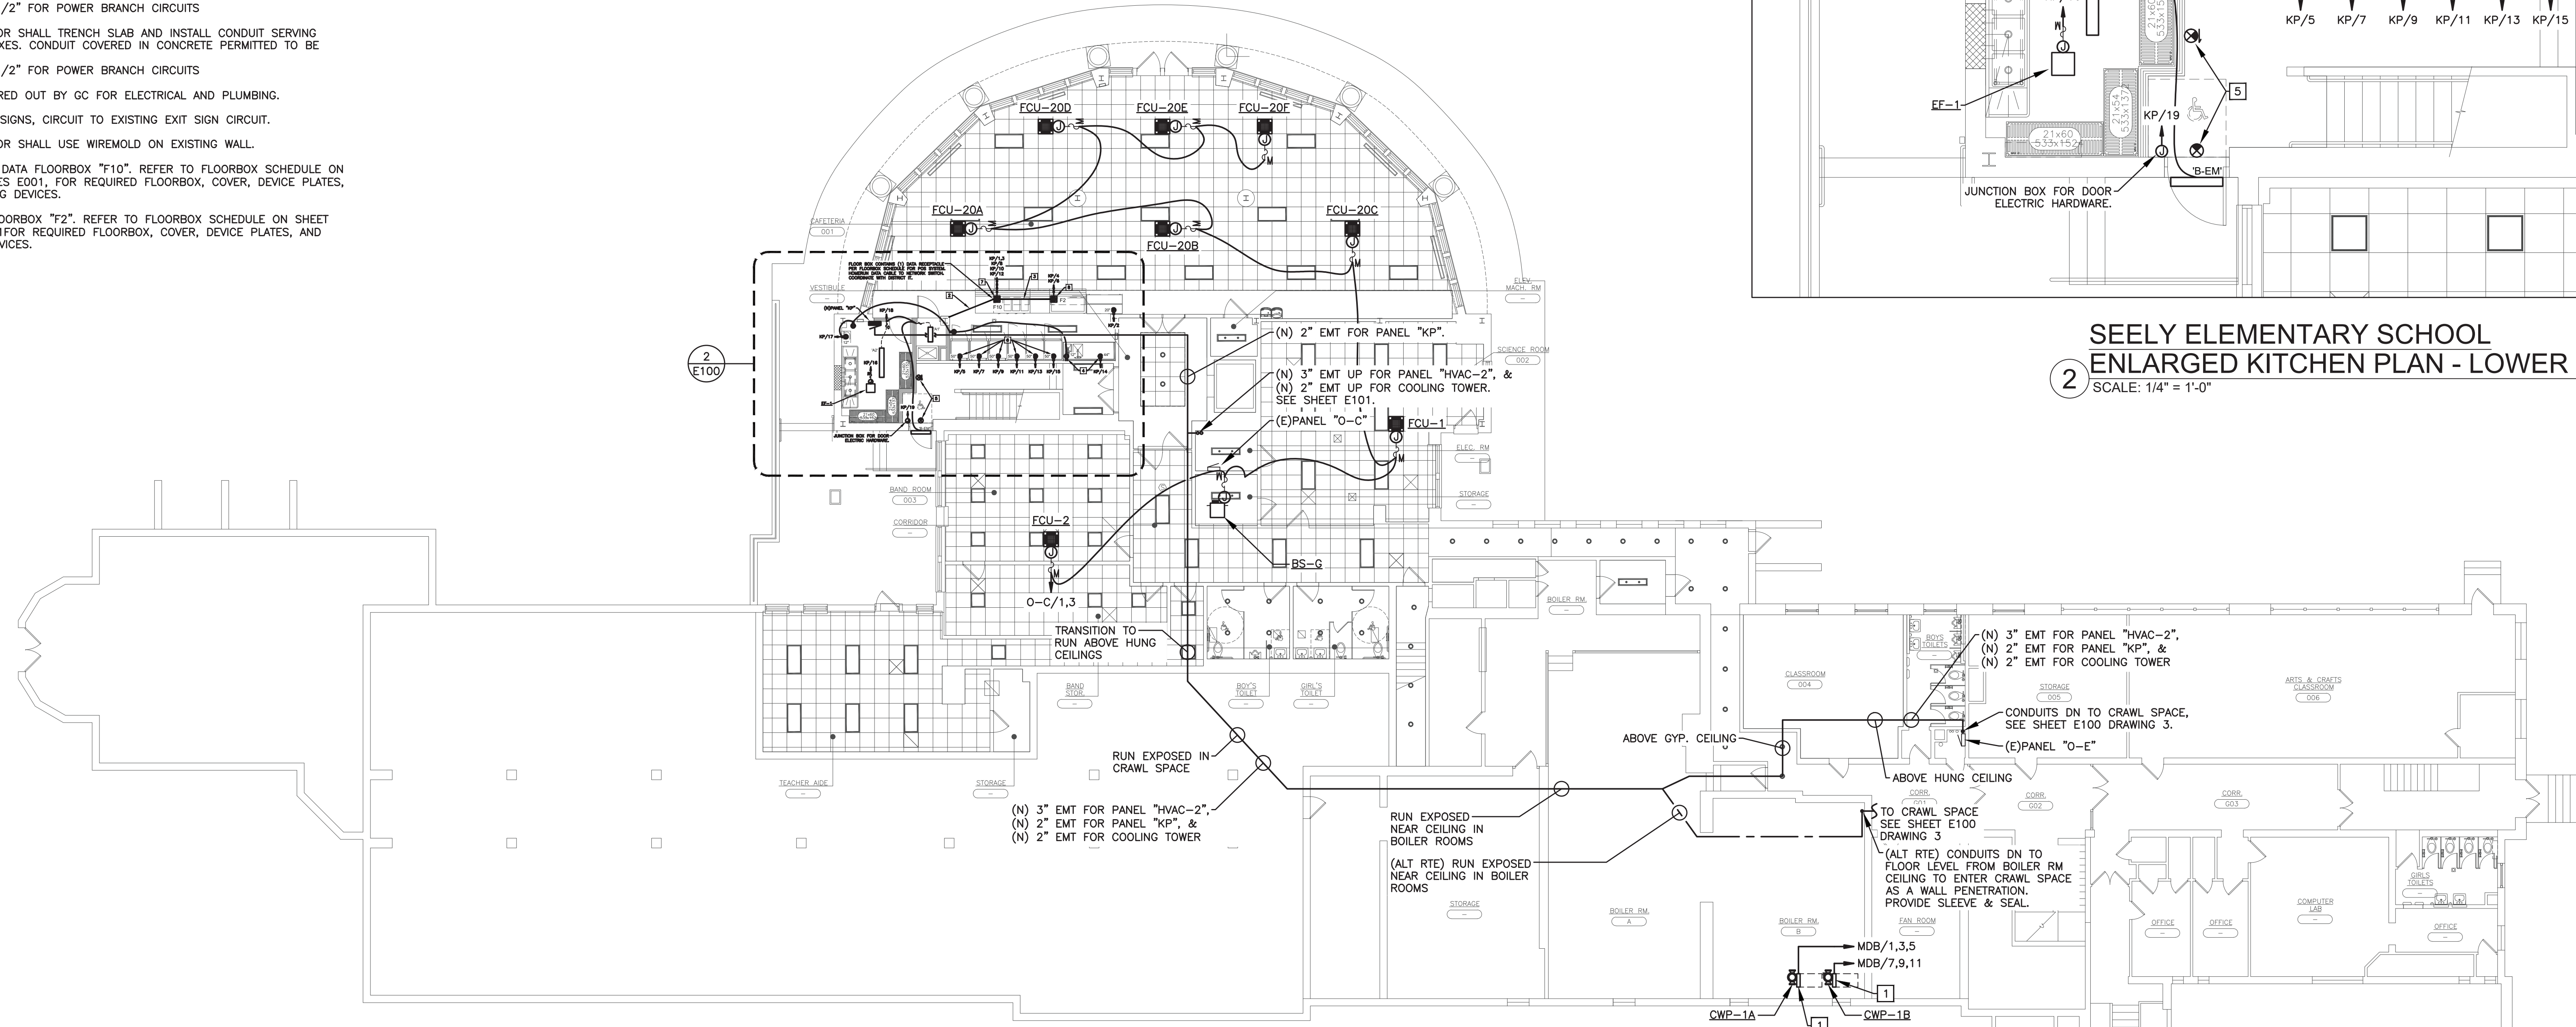

SEELY ELEMENTARY SCHOOL
ELECTRICAL PLAN - SUB BASEMENT
3 SCALE: 3/32" = 1'-0"

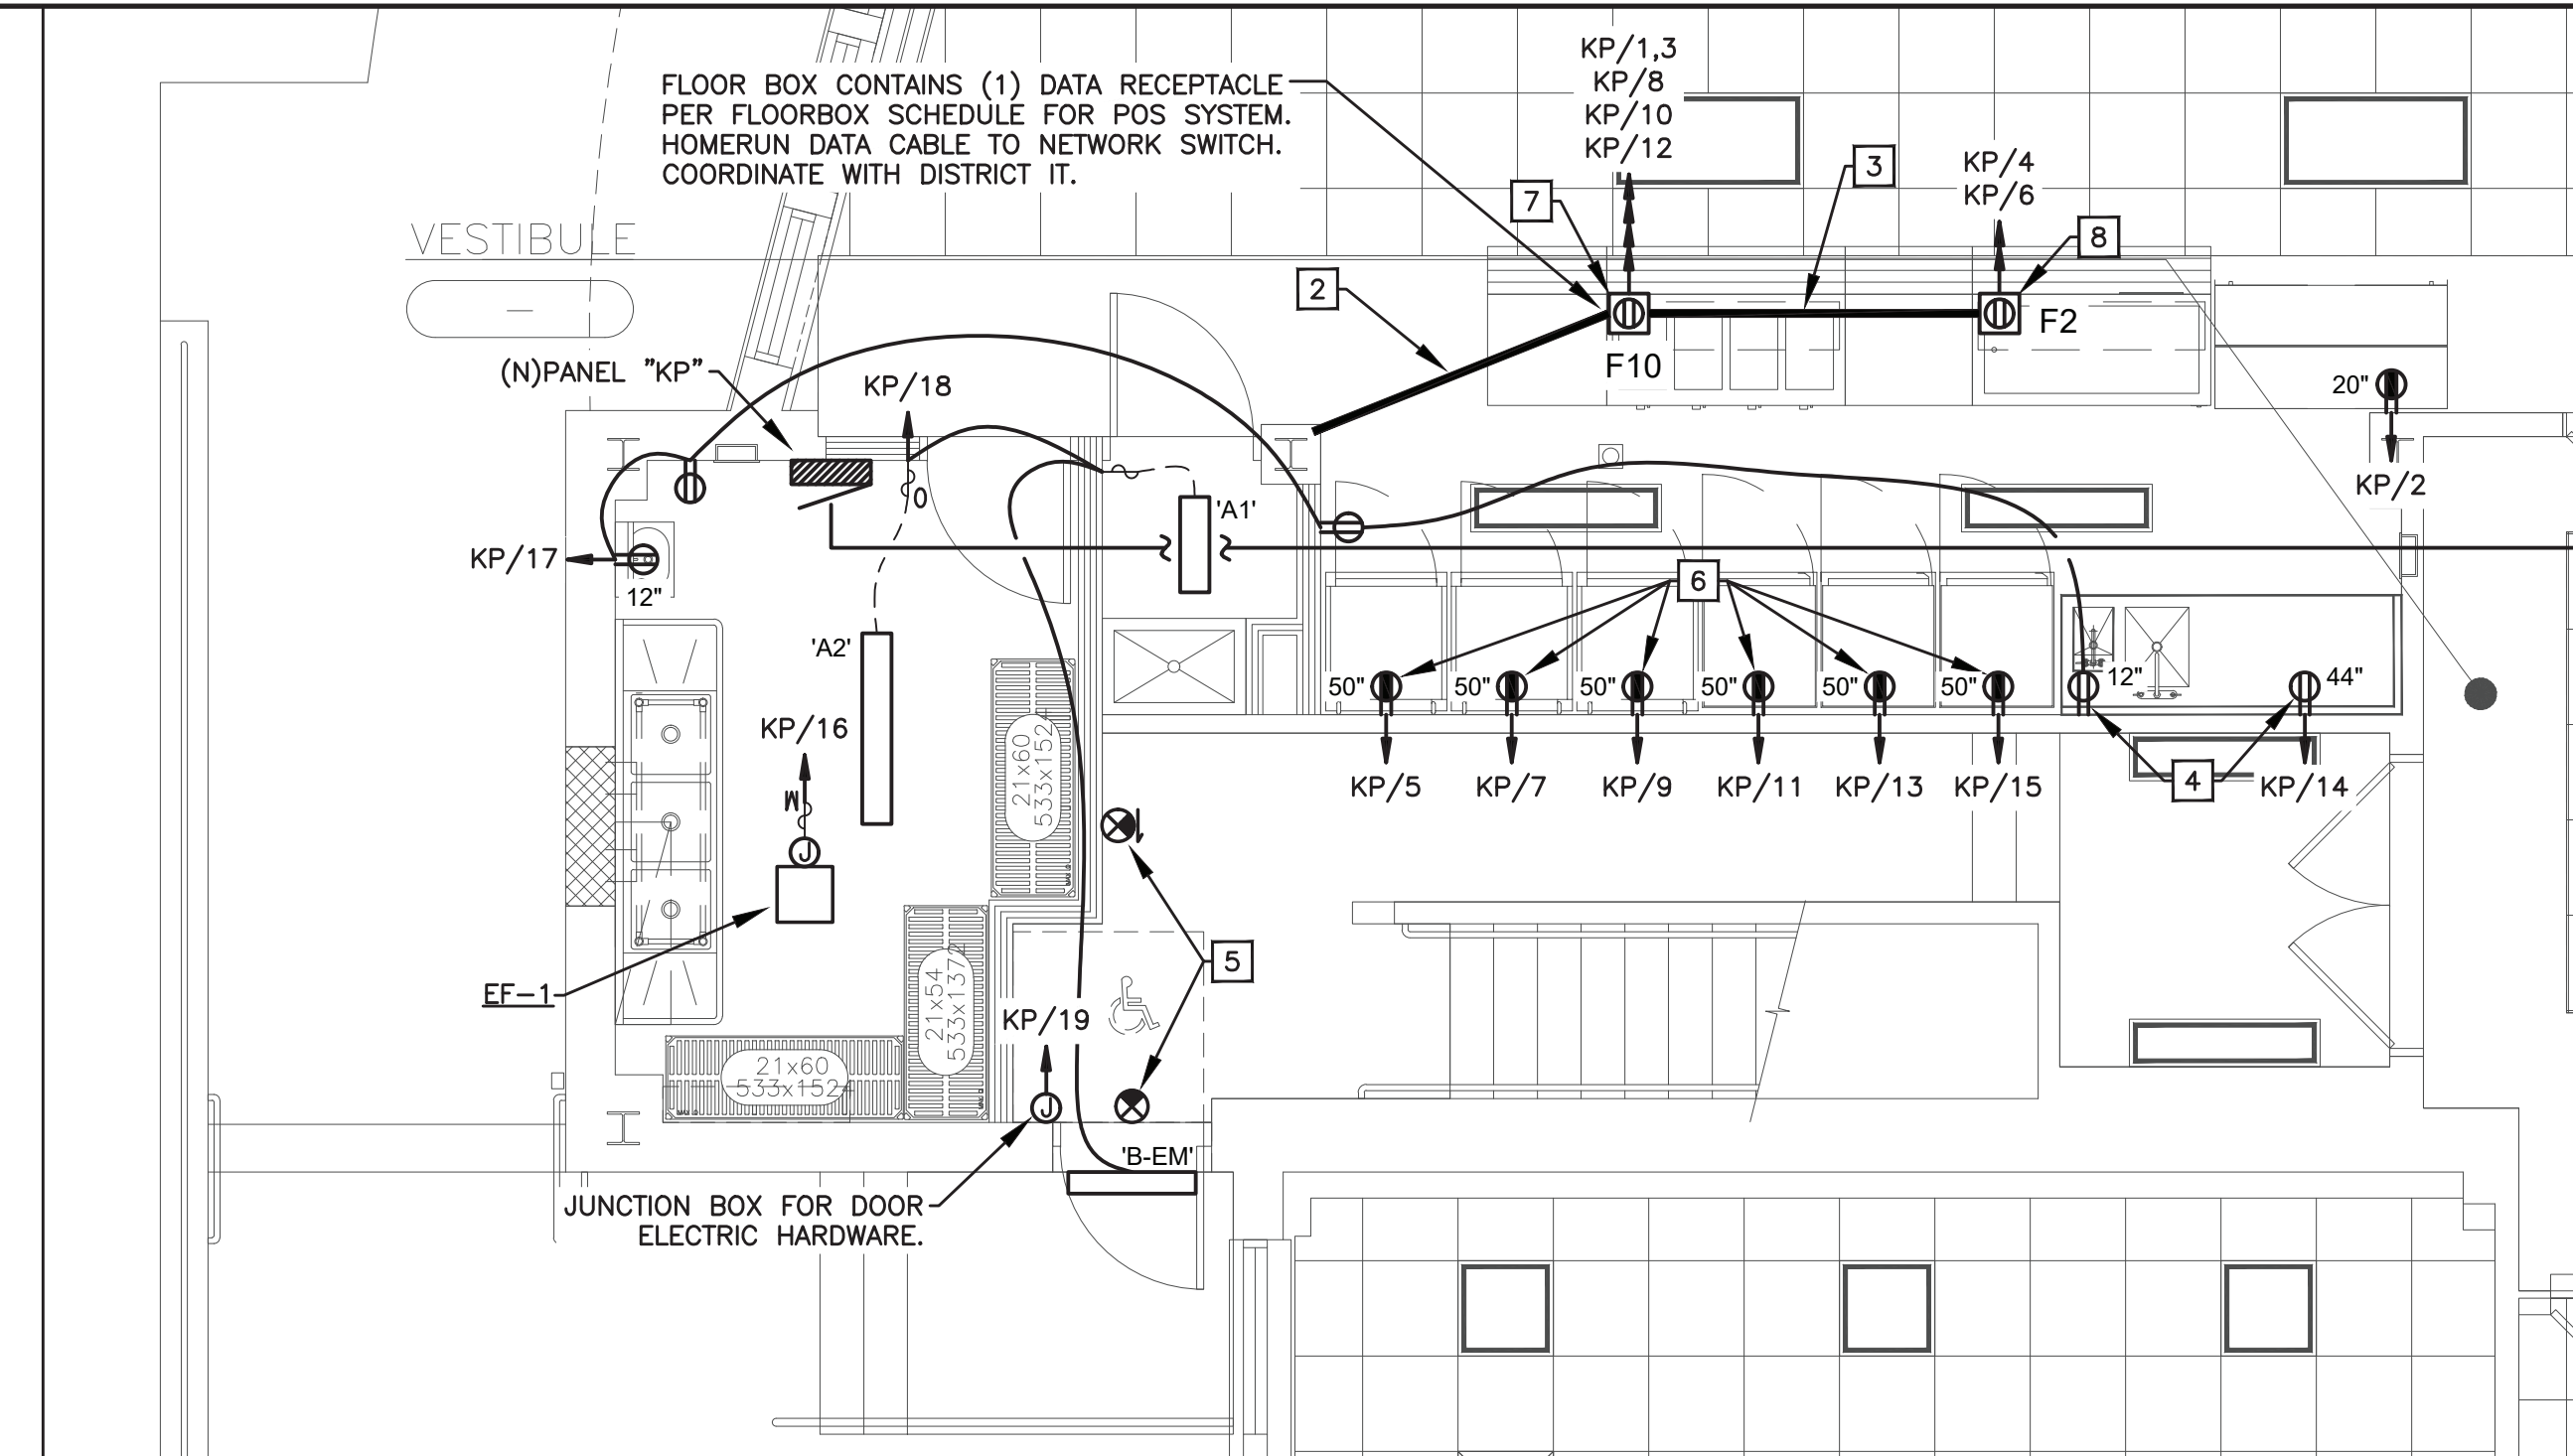

SEELY ELEMENTARY SCHOOL
ENLARGED KITCHEN PLAN - LOWER LEVEL
2 SCALE: 1/4" = 1'-0"

AS PER USA CONGRESS ARCHITECTURAL WORKS COPYRIGHT PROTECTION ACT OF 1990 ALL IDEAS AND SPECIFICATIONS DERIVATIVES THEREOF, ALL DRAWINGS AND DESIGNS CONSTITUTE THE ORIGINAL COPYRIGHT WORK BY FULLER AND D'ANGELO, P.C. (F&D). THE DRAWINGS AND SPECIFICATIONS AS PART OF THIS PROJECT ARE CREATED BY F&D FOR THIS PROJECT ONLY AND REMAIN THE PRODUCT AND PROPERTY OF F&D. ANY REPRODUCTION WITHOUT THE PRIOR CONSENT OF F&D IS PROHIBITED.

1435 KNOXWOOD ROAD ELMSFORD NEW YORK 10523
TEL 914.892.4444 FAX 914.892.1717
WWW.FULLERDANCELOCOM

LFG
LANDMARK
FACILITIES
GROUP, INC.

352 East Avenue
Norwalk, CT 06855
(203) 866-4626 Tel
(203) 866-8019 Fax


S.E.D. CONTROL NUMBER:
GREENVILLE ELEMENTARY SCHOOL
66-04-06-03-0-008-021
SEELY PLACE ELEMENTARY SCHOOL
66-04-06-03-0-001-019

PROJECT TITLE EDGEMONT SCHOOL DISTRICT GREENVILLE ELEMENTARY SCHOOL CAFETERIA RENOVATION AND RELATED WORK SEESELY PLACE ELEMENTARY SCHOOL PHASE 1 - HVAC & CAFETERIA	DRAWING TITLE BASEMENT AND SUB-BASEMENT ELECTRICAL PLAN
---	---


1-24-2023	ADDENDUM 1
1-06-2023	BID
DATE	ISSUED TO
SHEET SIZE 30"x42"	DRAWING NO. SPES E100
SCALE AS NOTED	
DRAWN BY LFG	FILE NO. 21434.01

PLOT DATE: January 24, 2023 -- 11:05am


FILE: \\fjgdc\Codfiles\Eldgemont School District\Seely Place Elementary Phase I\ACAD\Electrical\SPES_Electrical.dwg

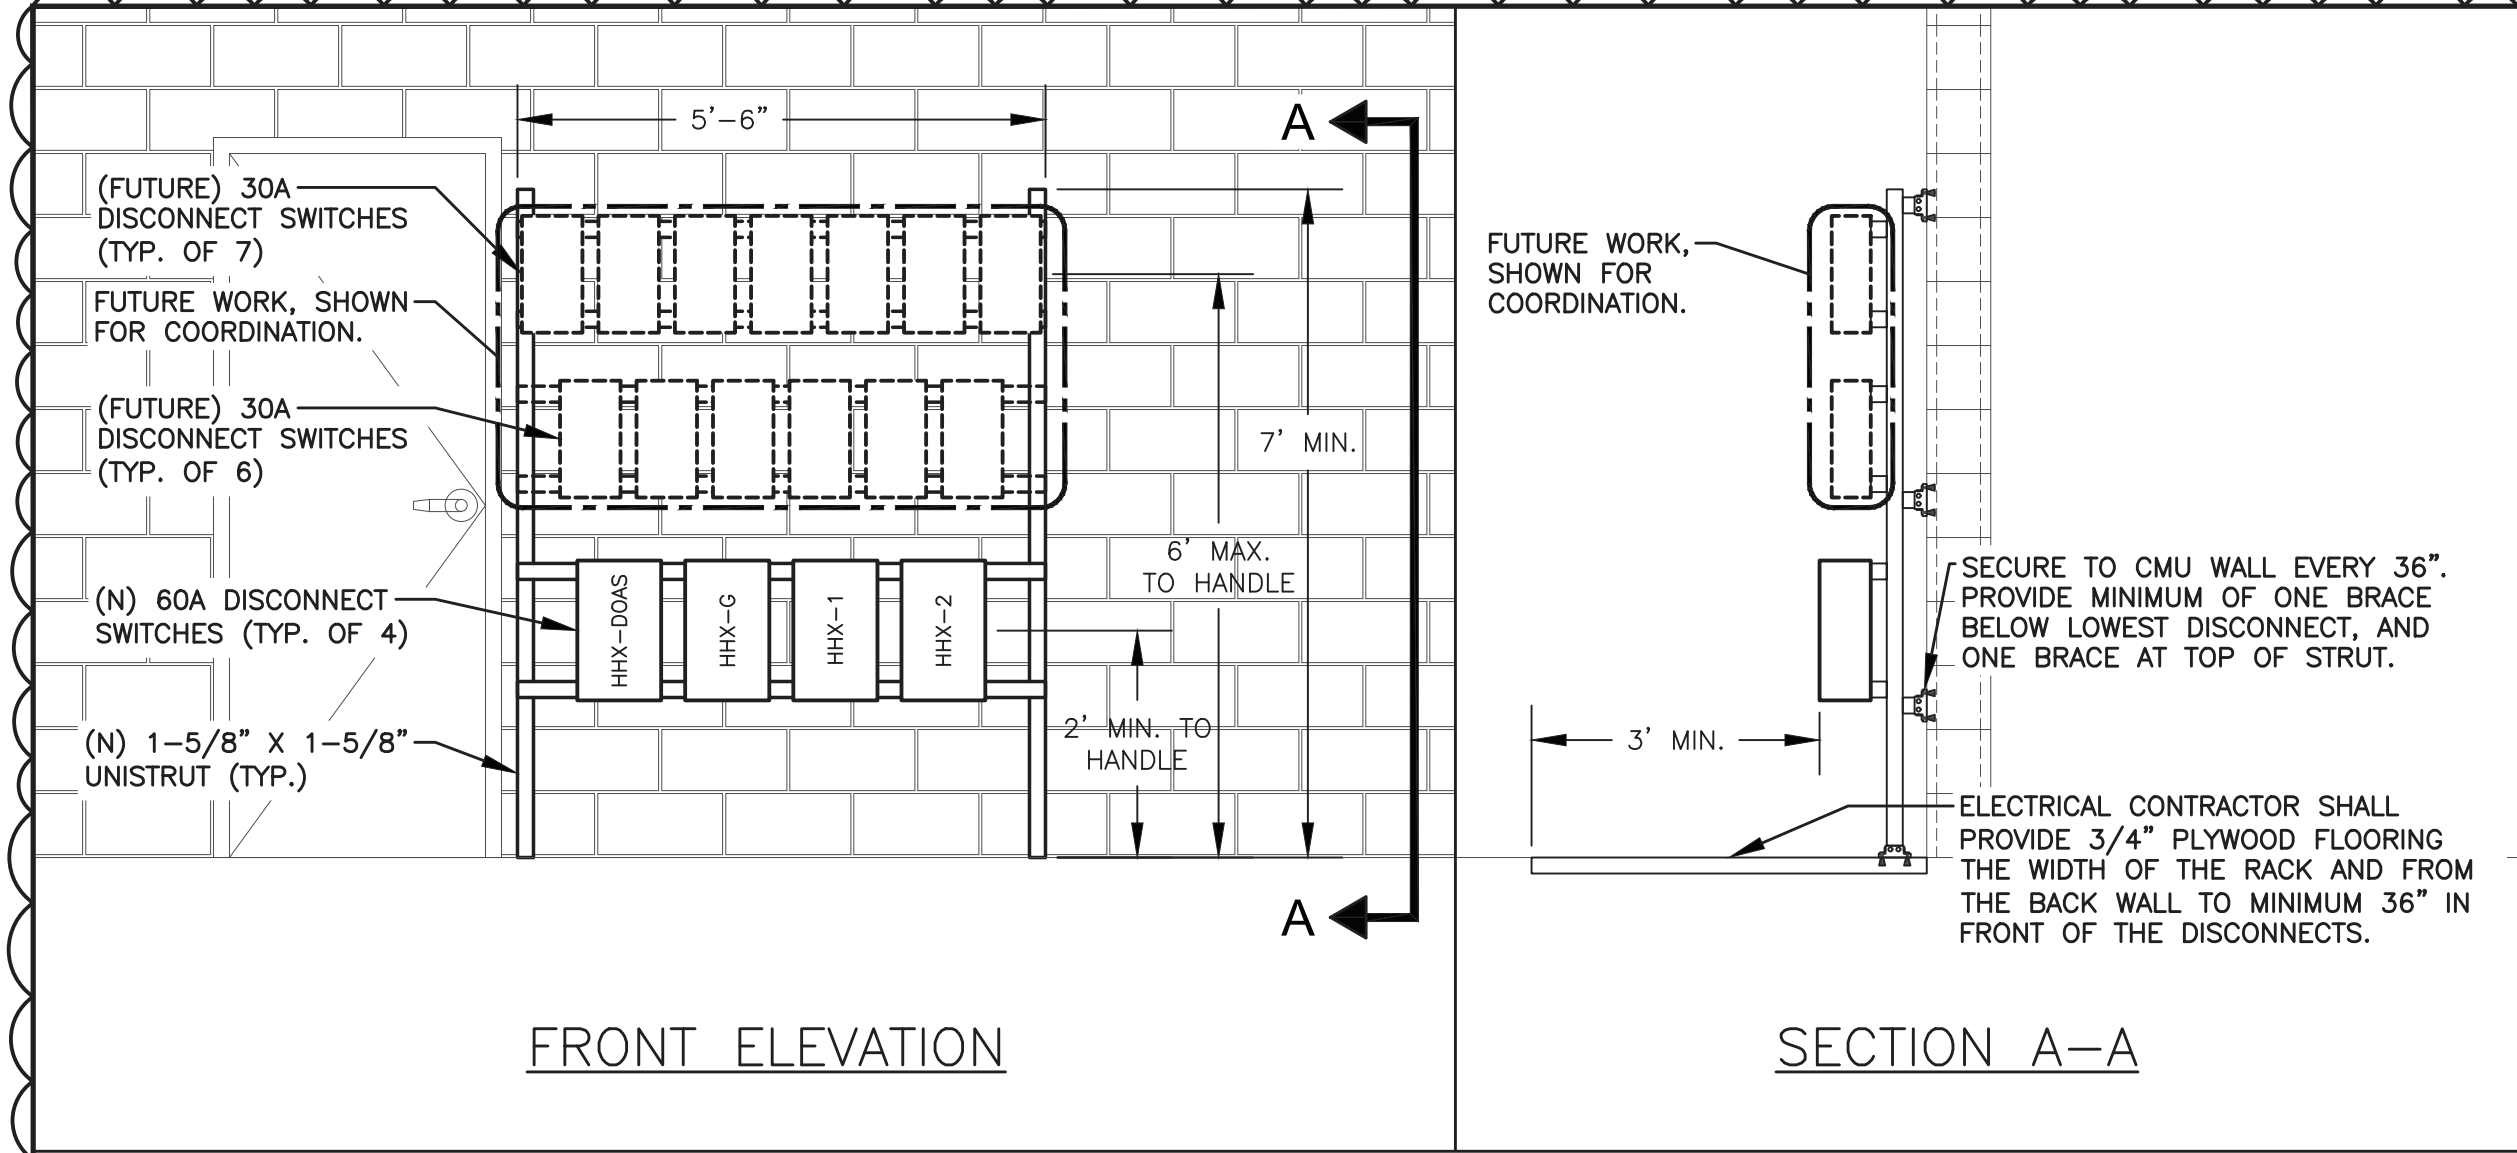

2 DISCONNECT UNISTRUT RACK DETAIL
SCALE: 1/2" = 1'-0"

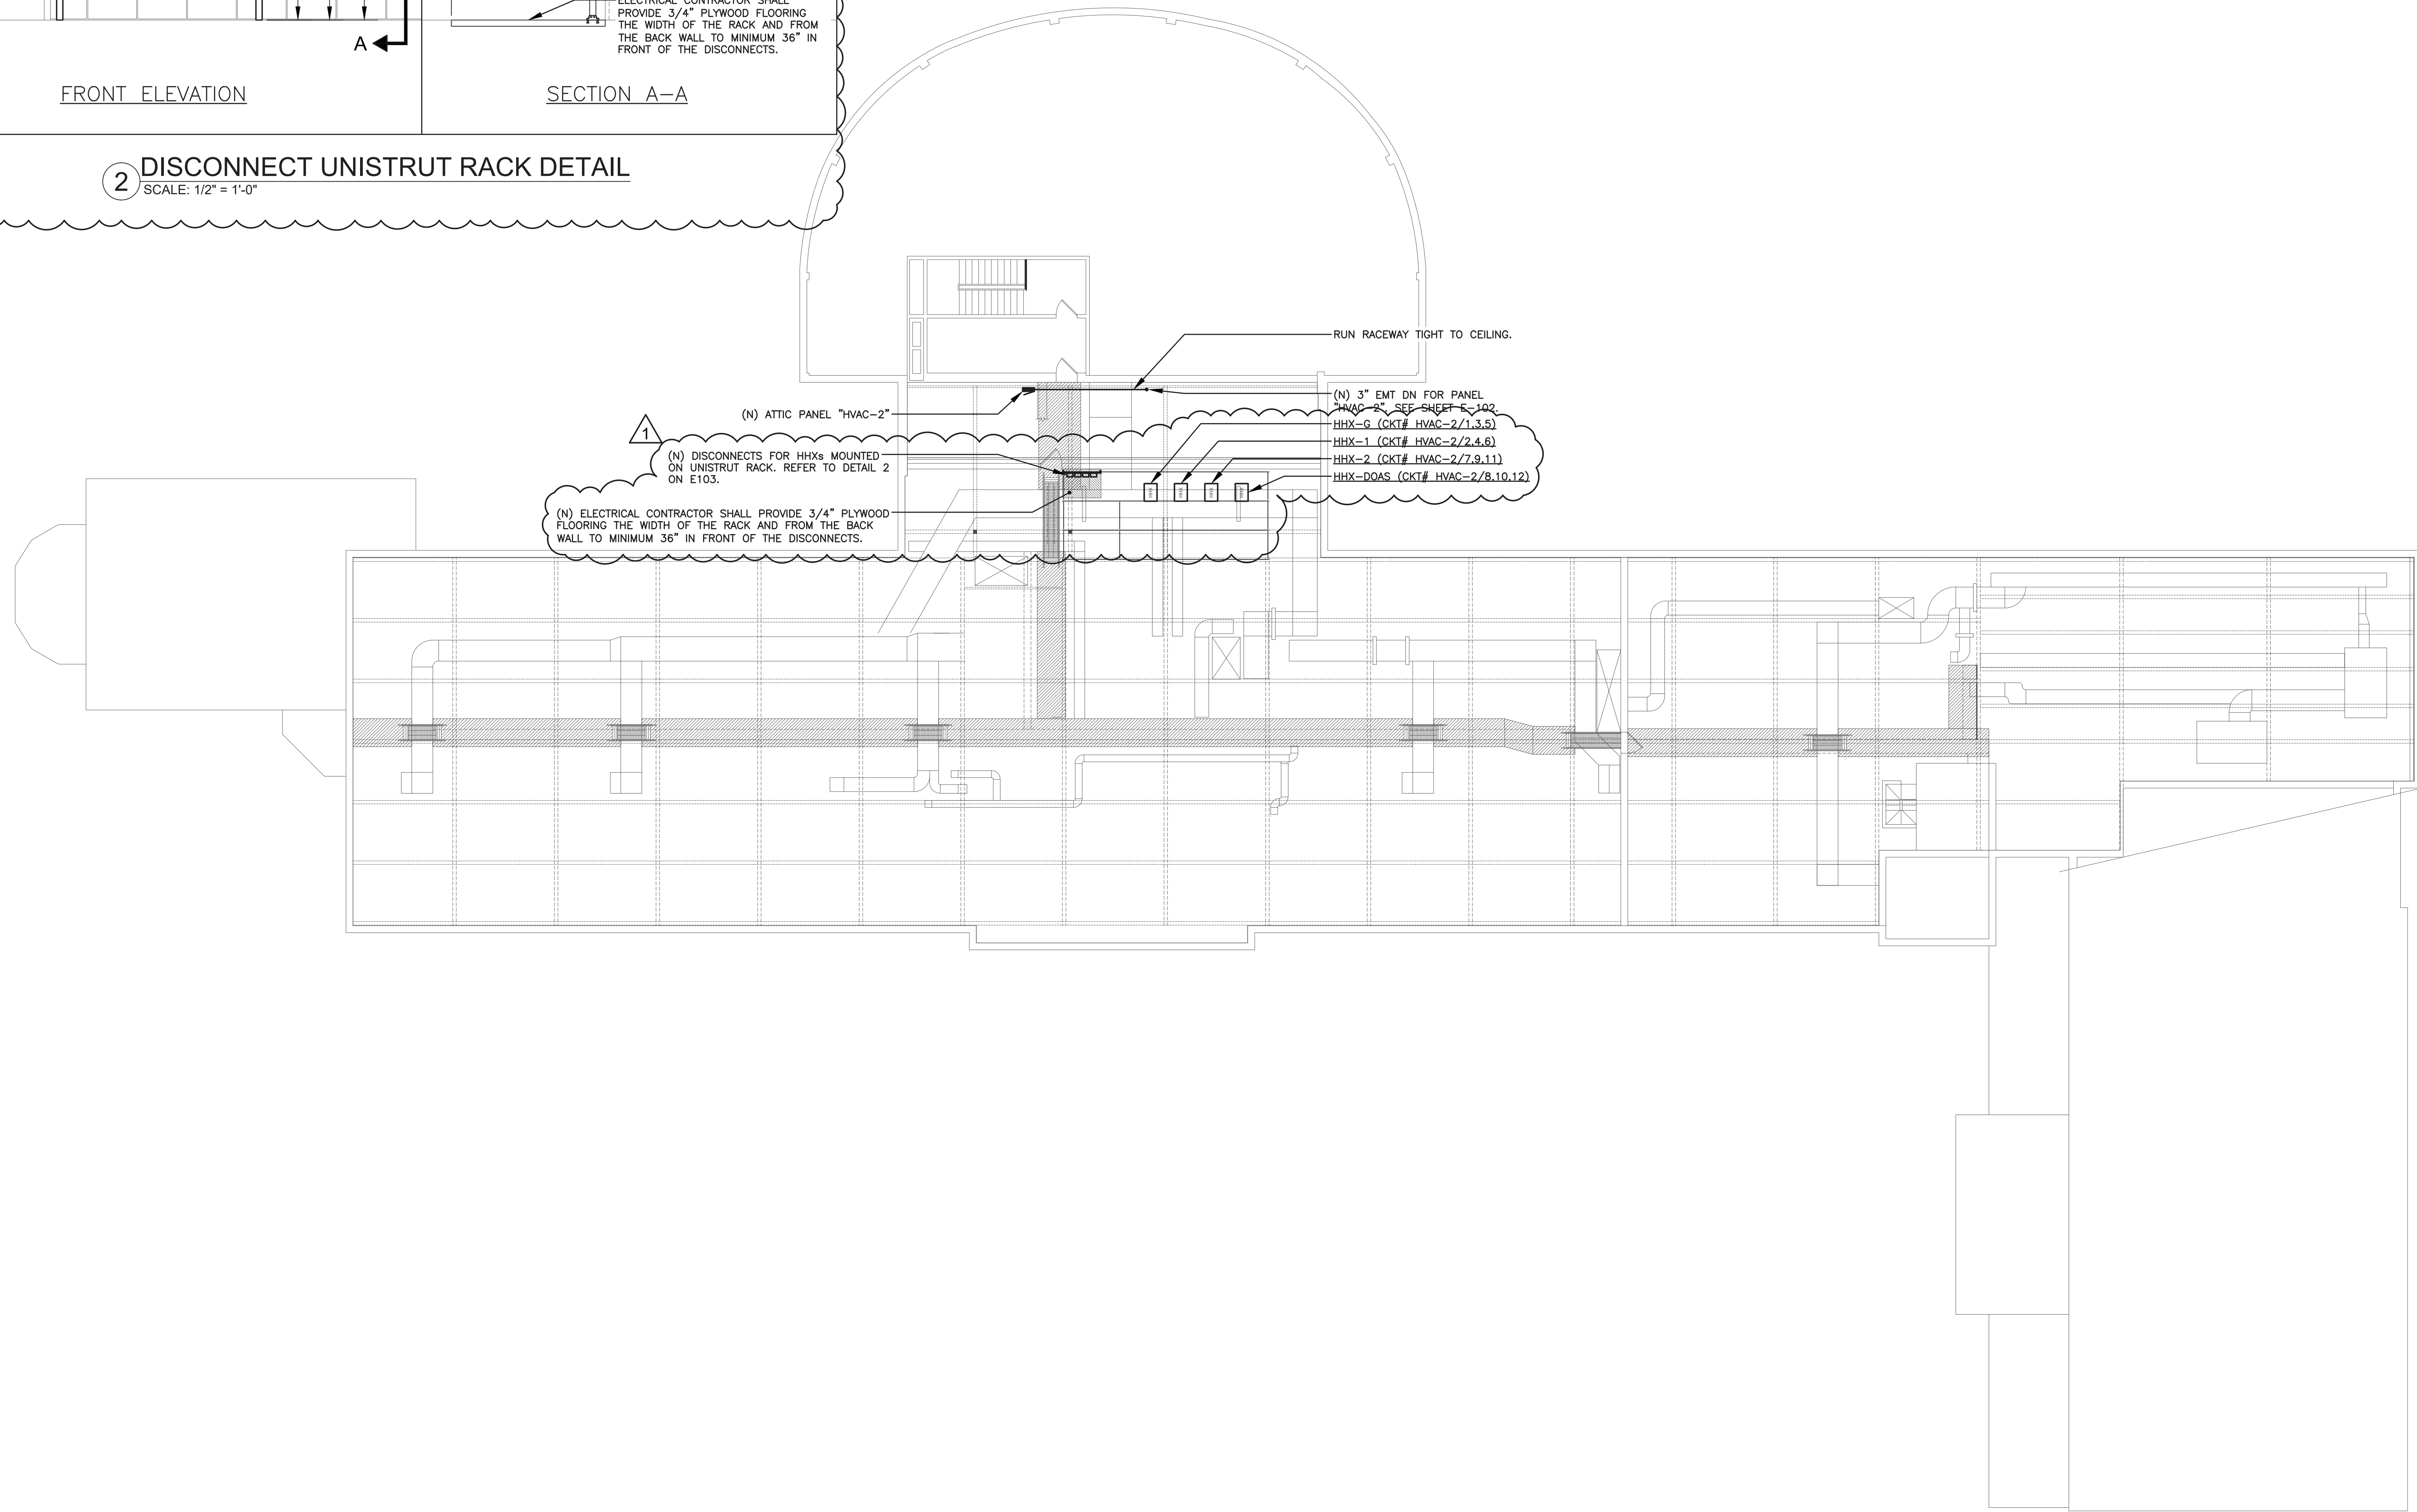

1 SEELY ELEMENTARY SCHOOL
ELECTRICAL PLAN - ATTIC
SCALE: 3/32" = 1'-0"

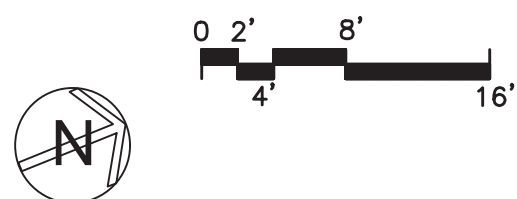

GENERAL NOTES:

1. ELECTRICAL CONTRACTOR RESPONSIBLE FOR REMOVING AND REINSTALLING CEILING TILE AND SUSPENSION SYSTEM AND ALL CEILING MOUNTED DEVICES. (TYPICAL)
2. ELECTRICAL CONTRACTOR SHALL BE RESPONSIBLE FOR PROVIDING ALL MEANS OF GETTING EQUIPMENT INTO ATTIC, PLANKING FOR ACCESS, AND PROPERLY RESTORING OF ANY COMPROMISED SYSTEMS.

AS PER USA CONGRESS ARCHITECTURAL WORKS COPYRIGHT PROTECTION ACT OF 1990 ALL IDEAS AND DESIGNS INCLUDING DERIVATIVES THEREOF, ALL DRAWINGS AND SPECIFICATIONS CONSTITUTE THE ORIGINAL COPYRIGHT WORK BY FULLER AND DANIELO, P.C. (F&D). THE DRAWINGS AND SPECIFICATIONS AS THIS PROJECT ONLY AND REMAIN THE PROPERTY OF F&D. ANY REPRODUCTION WITHOUT THE PRIOR CONSENT OF F&D IS PROHIBITED.

48 HOLLWOOD ROAD ELLENFIELD NEW YORK 10883
TEL 914.898-4444 FAX 914.898-1919
Copyright 2021 by Fuller and Danieleski, P.C.

FULLER
DANIELO
P.C.
ARCHITECTS
PLANNERS

LFG
LANDMARK
FACILITIES
GROUP, INC.
252 East Avenue
Greenville, SC 29615
(253) 866-4628 FAX
(253) 866-8019 Fax

S.E.D. CONTROL NUMBER:
GREENVILLE ELEMENTARY SCHOOL
66-04-06-03-0-008-021
SEELY PLACE ELEMENTARY SCHOOL
66-04-06-03-0-001-019

PROJECT:
EDGEMONT SCHOOL DISTRICT
GREENVILLE ELEMENTARY SCHOOL
SEELY PLACE ELEMENTARY SCHOOL
PHASE 1 - HVAC & CRETERIA
DRAWING TITLE:
ATTIC ELECTRICAL PLAN


1-24-2023	ADDENDUM 1
1-06-2023	BID
DATE	ISSUED TO
SHEET SIZE 30"x42"	DRAWING NO. SPES E103
SCALE AS NOTED	FILE NO. 21434.01
DRAWN BY LFG	

GENERAL NOTES:

1. ELECTRICAL CONTRACTOR RESPONSIBLE FOR REMOVING AND REINSTALLING CEILING TILE AND SUSPENSION SYSTEM AND ALL CEILING MOUNTED DEVICES. (TYPICAL)
2. ALL ROOF PENETRATIONS SHALL BE BY ROOFING CONTRACTOR.
3. ALL CONDUIT EXPOSED ON ROOF SHALL BE RIGID GALVANIZED STEEL U.N.O.. SUPPORT CONDUIT ABOVE ROOF LEVEL PER NEC.


CODED NOTES:

- 1 UNUSED
- 2 CONDUIT UP WITHIN CURB INTO EQUIPMENT. ELECTRICAL CONTRACTOR SHALL WIRE FACTORY FURNISHED NON-FUSED DISCONNECT SWITCH.
- 3 CONTRACTOR SHALL WIRE GFCI RECEPTACLE ON UNIT TO PANEL HVAC-1 CKT#30. ROUTE POWER THROUGH CURB.
- 4 PIPE PORTAL PROVIDED BY OTHERS, ROUTE CONDUIT THROUGH PIPE PORTAL.
- 5 FACTORY PROVIDED DISCONNECT SWITCH.

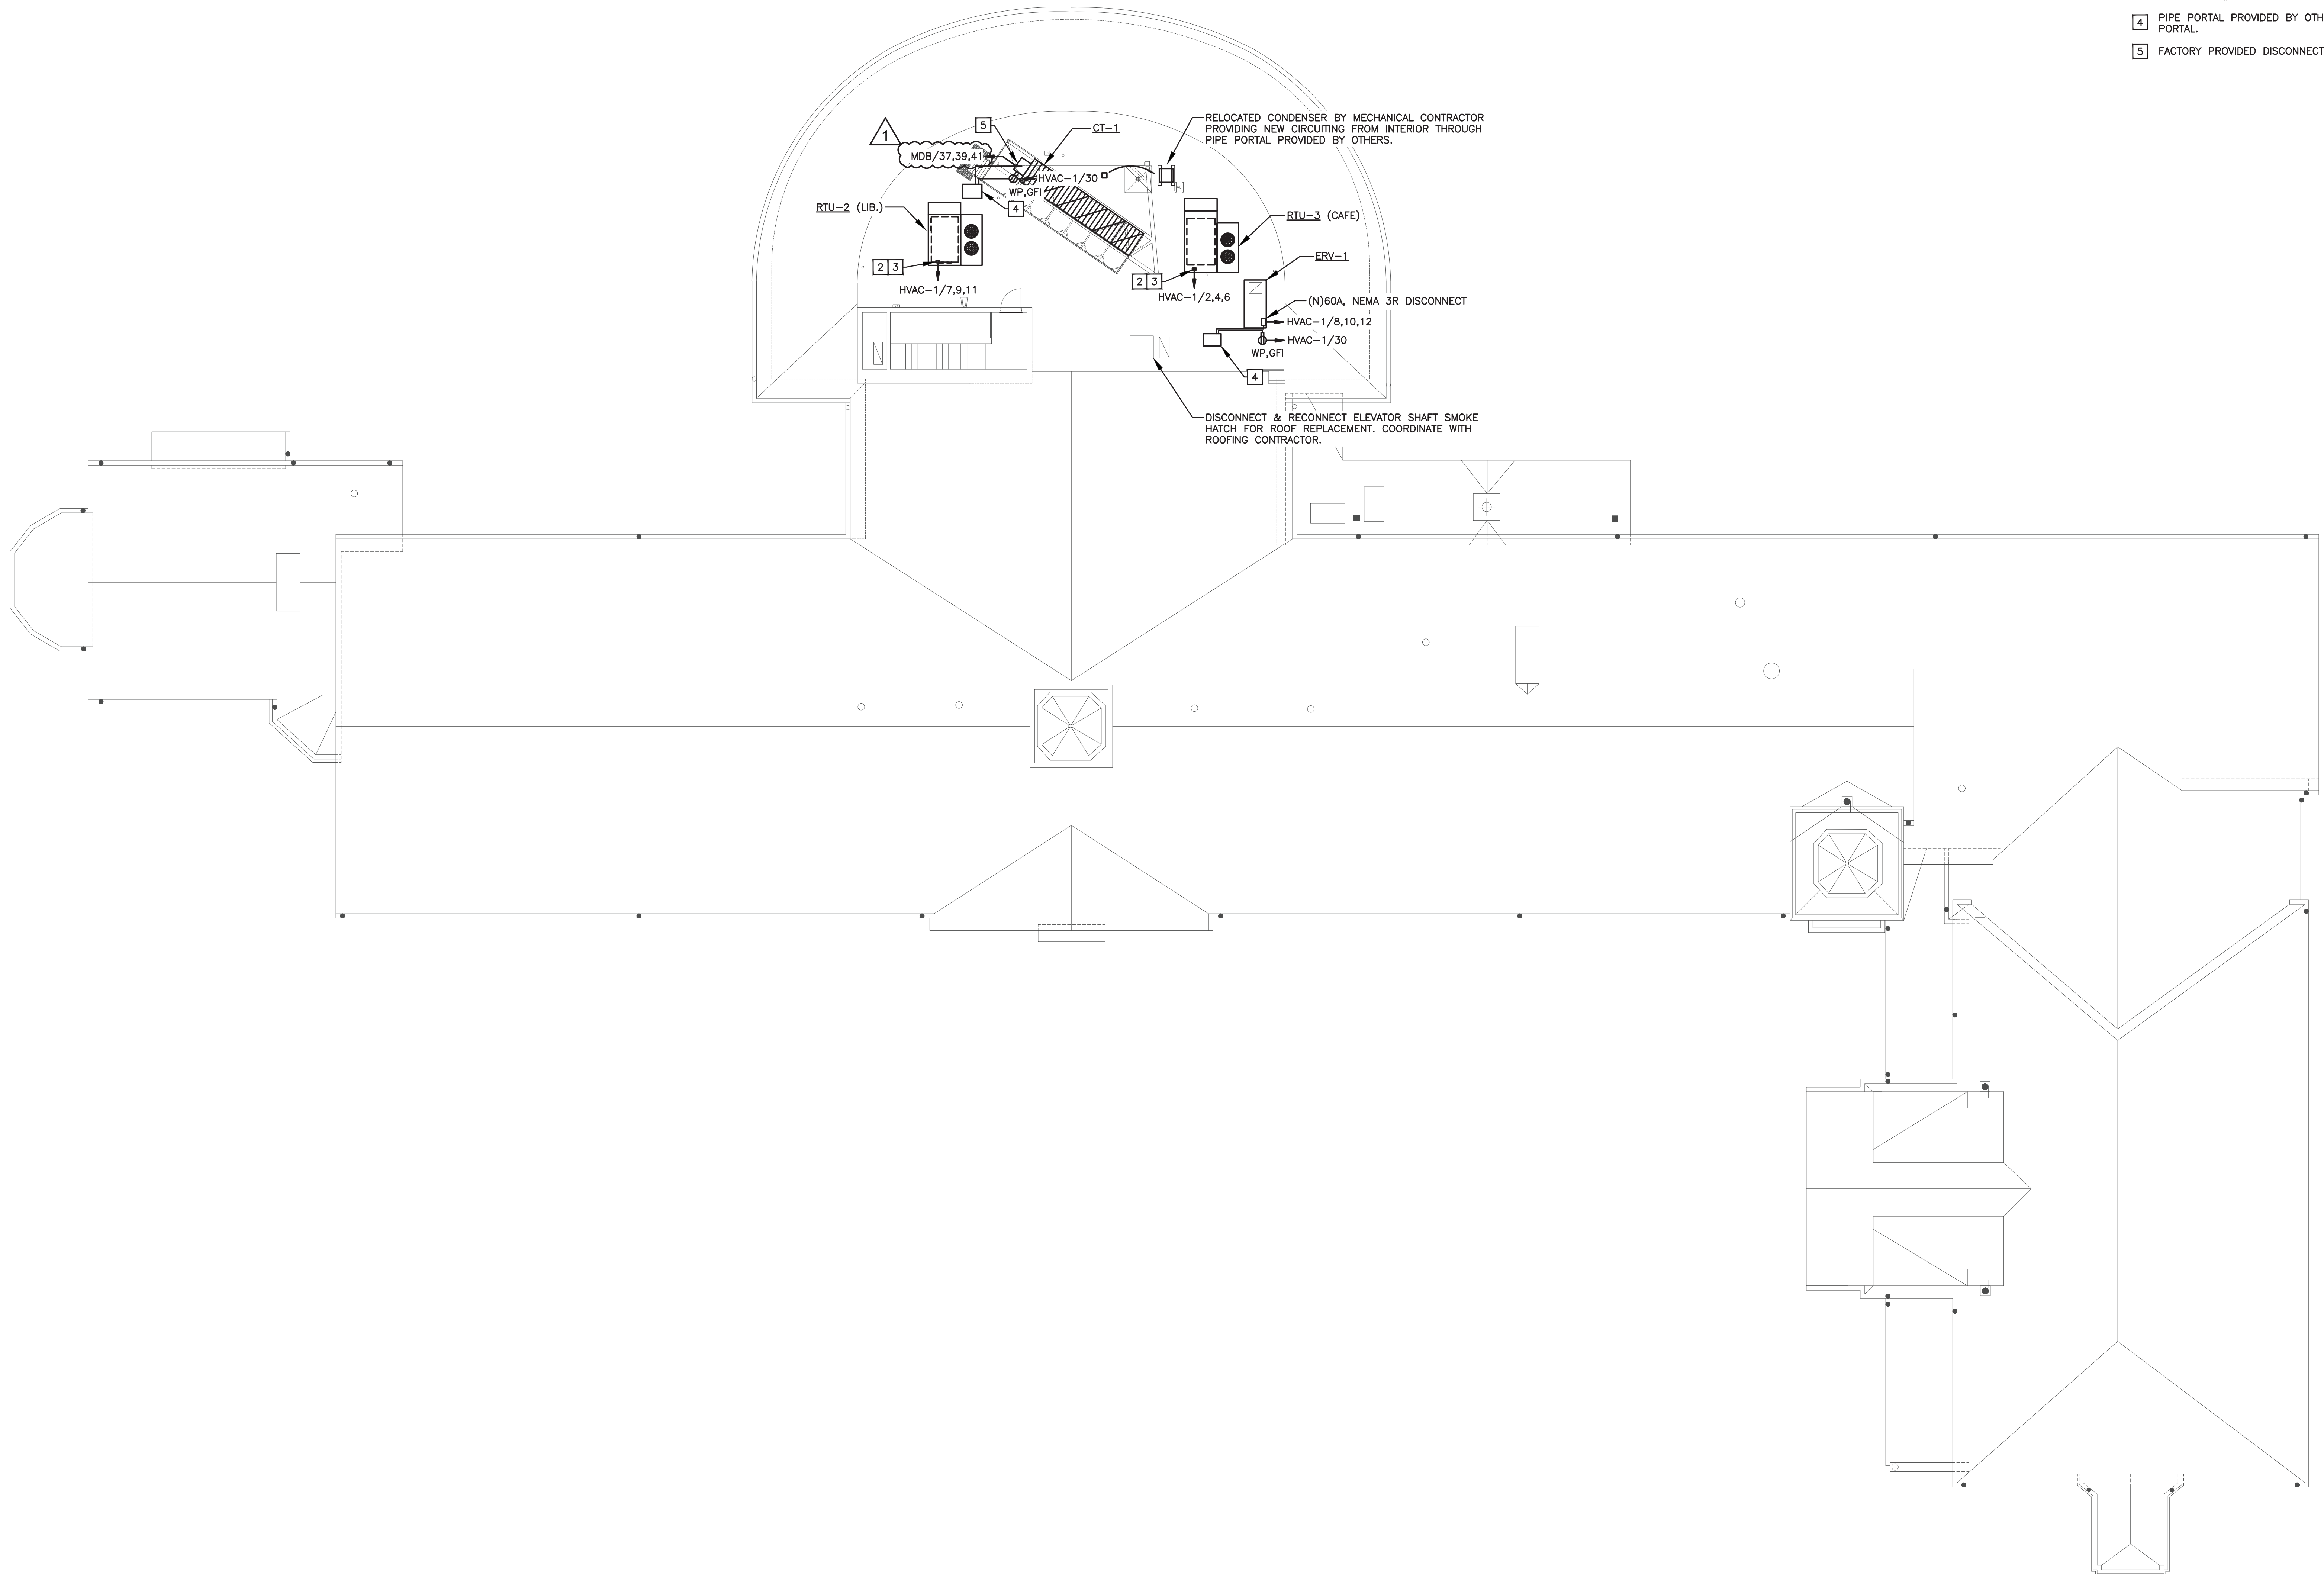

SEELY ELEMENTARY SCHOOL
ELECTRICAL PLAN - ROOF

1 SCALE: 3/32" = 1'-0"

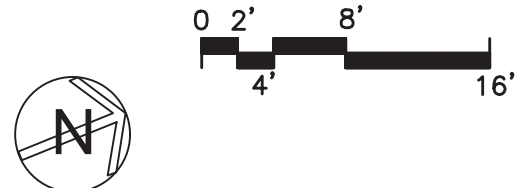

AS PER USA CONGRESS ARCHITECTURAL WORKS COPYRIGHT PROTECTION ACT OF 1990 ALL IDEAS AND DESIGNS INCLUDING DERIVATIVES THEREOF, ALL DRAWINGS AND SPECIFICATIONS CONSTITUTE THE ORIGINAL COPYRIGHT WORK BY FULLER AND D'ANGELO, P.C. (F&D). THE DRAWINGS AND SPECIFICATIONS AS INSTRUMENTS OF SERVICE BY F&D ARE CREATED BY F&D FOR THIS PROJECT ONLY AND REMAIN THE PROPERTY OF F&D. ANY REPRODUCTION WITHOUT THE PRIOR CONSENT OF F&D IS PROHIBITED.

48 SHOLLYWOOD ROAD ELLENBORO NEW YORK 12823
TEL 814-898-4444 FAX 814-898-1917
Copyright 2001 by Fuller & Angelo, P.C.

FULLER
D'ANGELO
P.C.
ARCHITECTS
PLANNERS

LFG
LANDMARK
FACILITIES
GROUP, INC.
252 East Avenue
Greenville, SC 29615
(253) 866-4628 FAX
(253) 866-4019 Fax

S.E.D. CONTROL NUMBER:
GREENVILLE ELEMENTARY SCHOOL
66-04-06-03-0-008-021
SEELY PLACE ELEMENTARY SCHOOL
66-04-06-03-0-001-019

PROJECT:
EDGEMONT SCHOOL DISTRICT
GREENVILLE ELEMENTARY SCHOOL
SEELY PLACE ELEMENTARY SCHOOL
PHASE 1 - HVAC & CAFETERIA
DRAWING TITLE:
ROOF ELECTRICAL PLAN

1-24-2023	ADDENDUM 1
1-06-2023	BID
DATE	ISSUED TO
SHEET SIZE 30"x42"	DRAWING NO. SPES E104
SCALE AS NOTED	FILE NO. 21434.01
DRAWN BY LFG	