

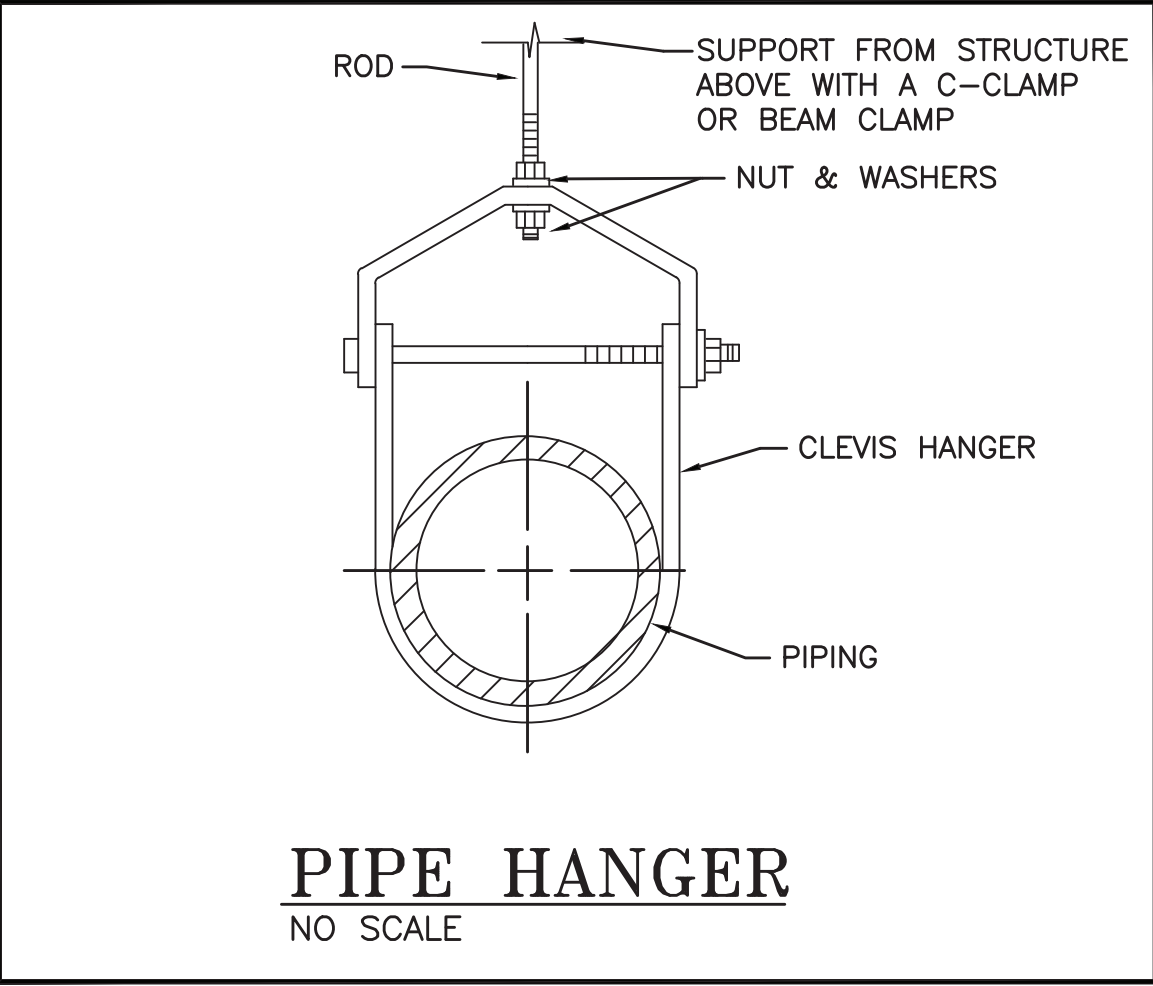
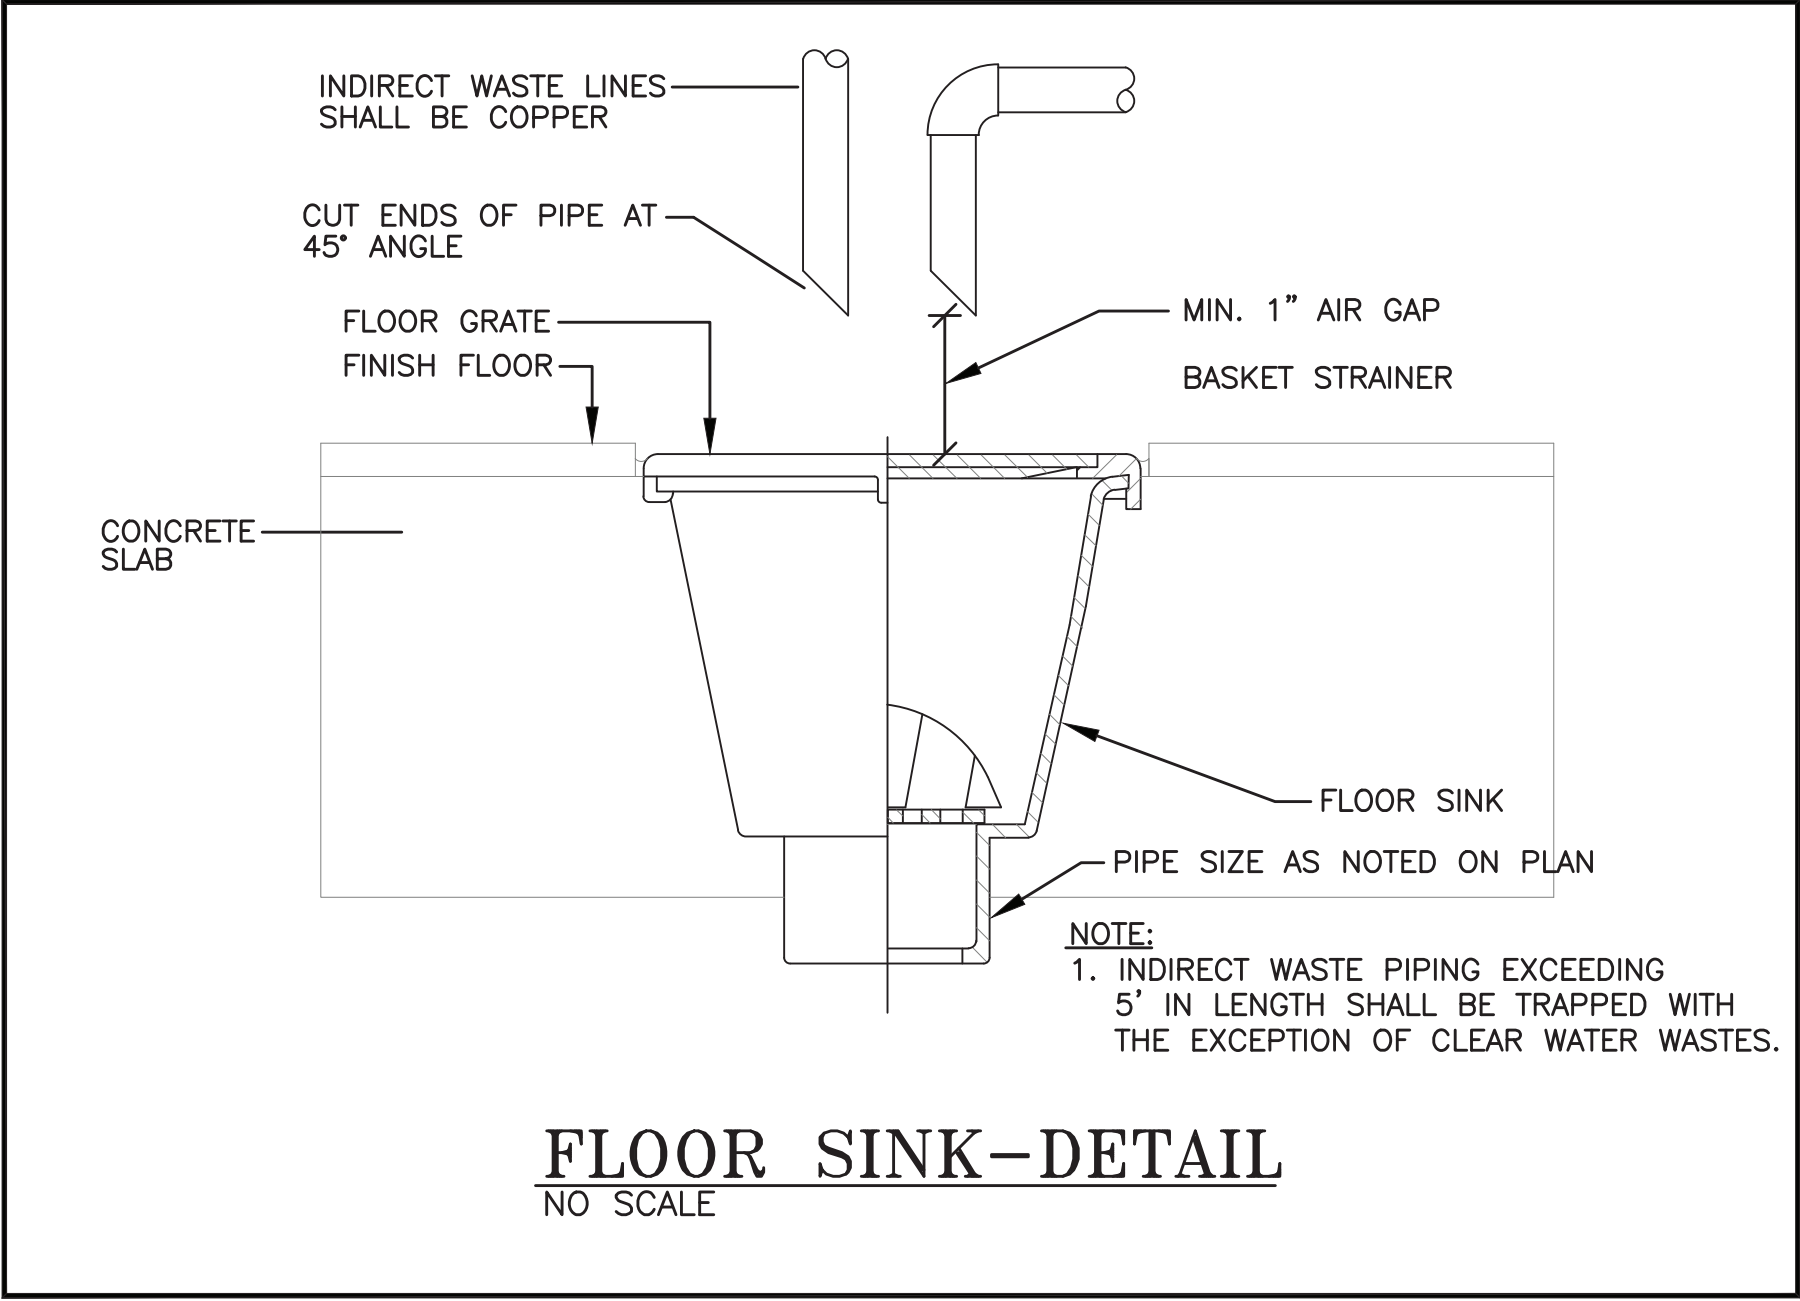


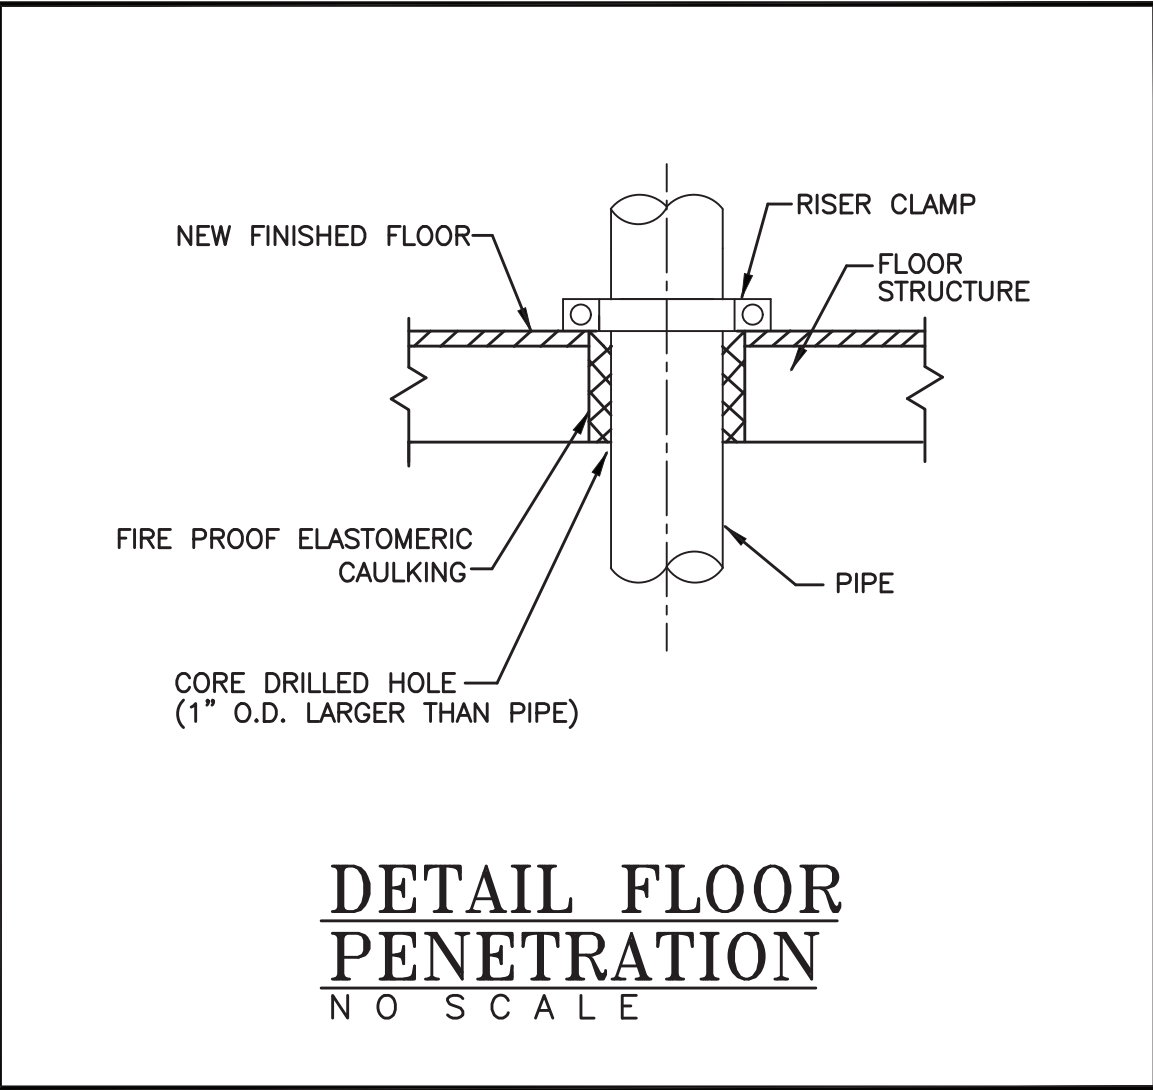



PLUMBING SYMBOL LIST	
SYMBOL	DESCRIPTION
---	NOTE: NOT ALL SYMBOLS ARE USED
---	EXISTING PIPING TO REMAIN
-X-X-X-X-	EXISTING PIPING TO BE REMOVED
---	SANITARY PIPE BELOW FLOOR/SLAB (SAN)
---	SANITARY PIPE ABOVE FLOOR/SLAB (SAN)
---	VENT PIPE (V)
---	COLD WATER PIPING
---	HOT WATER PIPING
---	DIRECTION OF FLOW
---	PIPE RISE OR UP THRU SLAB
---	PIPE DROP OR DOWN THRU SLAB
---	BOTTOM OF PIPE TAKE-OFF CONNECTION
---	TOP OF PIPE TAKE-OFF CONNECTION
---	P-TRAP
---	CAP PIPE OUTLET
---	CLEANOUT (CO)
---	UNION
---	VALVE IN RISE / VERTICAL
---	POINT OF NEW CONNECTION
---	FLOOR DRAIN
---	FLOOR SINK

PLUMBING ABBREVIATION LIST	
SYMBOL	DESCRIPTION
AFF	ABOVE FINISHED FLOOR
CO	CLEANOUT
CW	COLD WATER
CLG	CEILING
CONN	CONNECT
DN	DOWN (PENETRATES FLOOR SLAB)
DR	DRAIN
DPCO	DECK PLATE CLEANOUT
EX	EXISTING
EL	ELEVATION
FL	FLOOR
HW	HOT WATER
IW	INDIRECT WASTE
MIN	MINIMUM
NTS	NOT TO SCALE
SAN	SANITARY
GW	GREASE WASTE
TYP	TYPICAL
UP	UP (PENETRATES FLOOR SLAB)
V or VNT	VENT
VIF	VERIFY IN FIELD
W	WASTE
WCO	WALL CLEANOUT

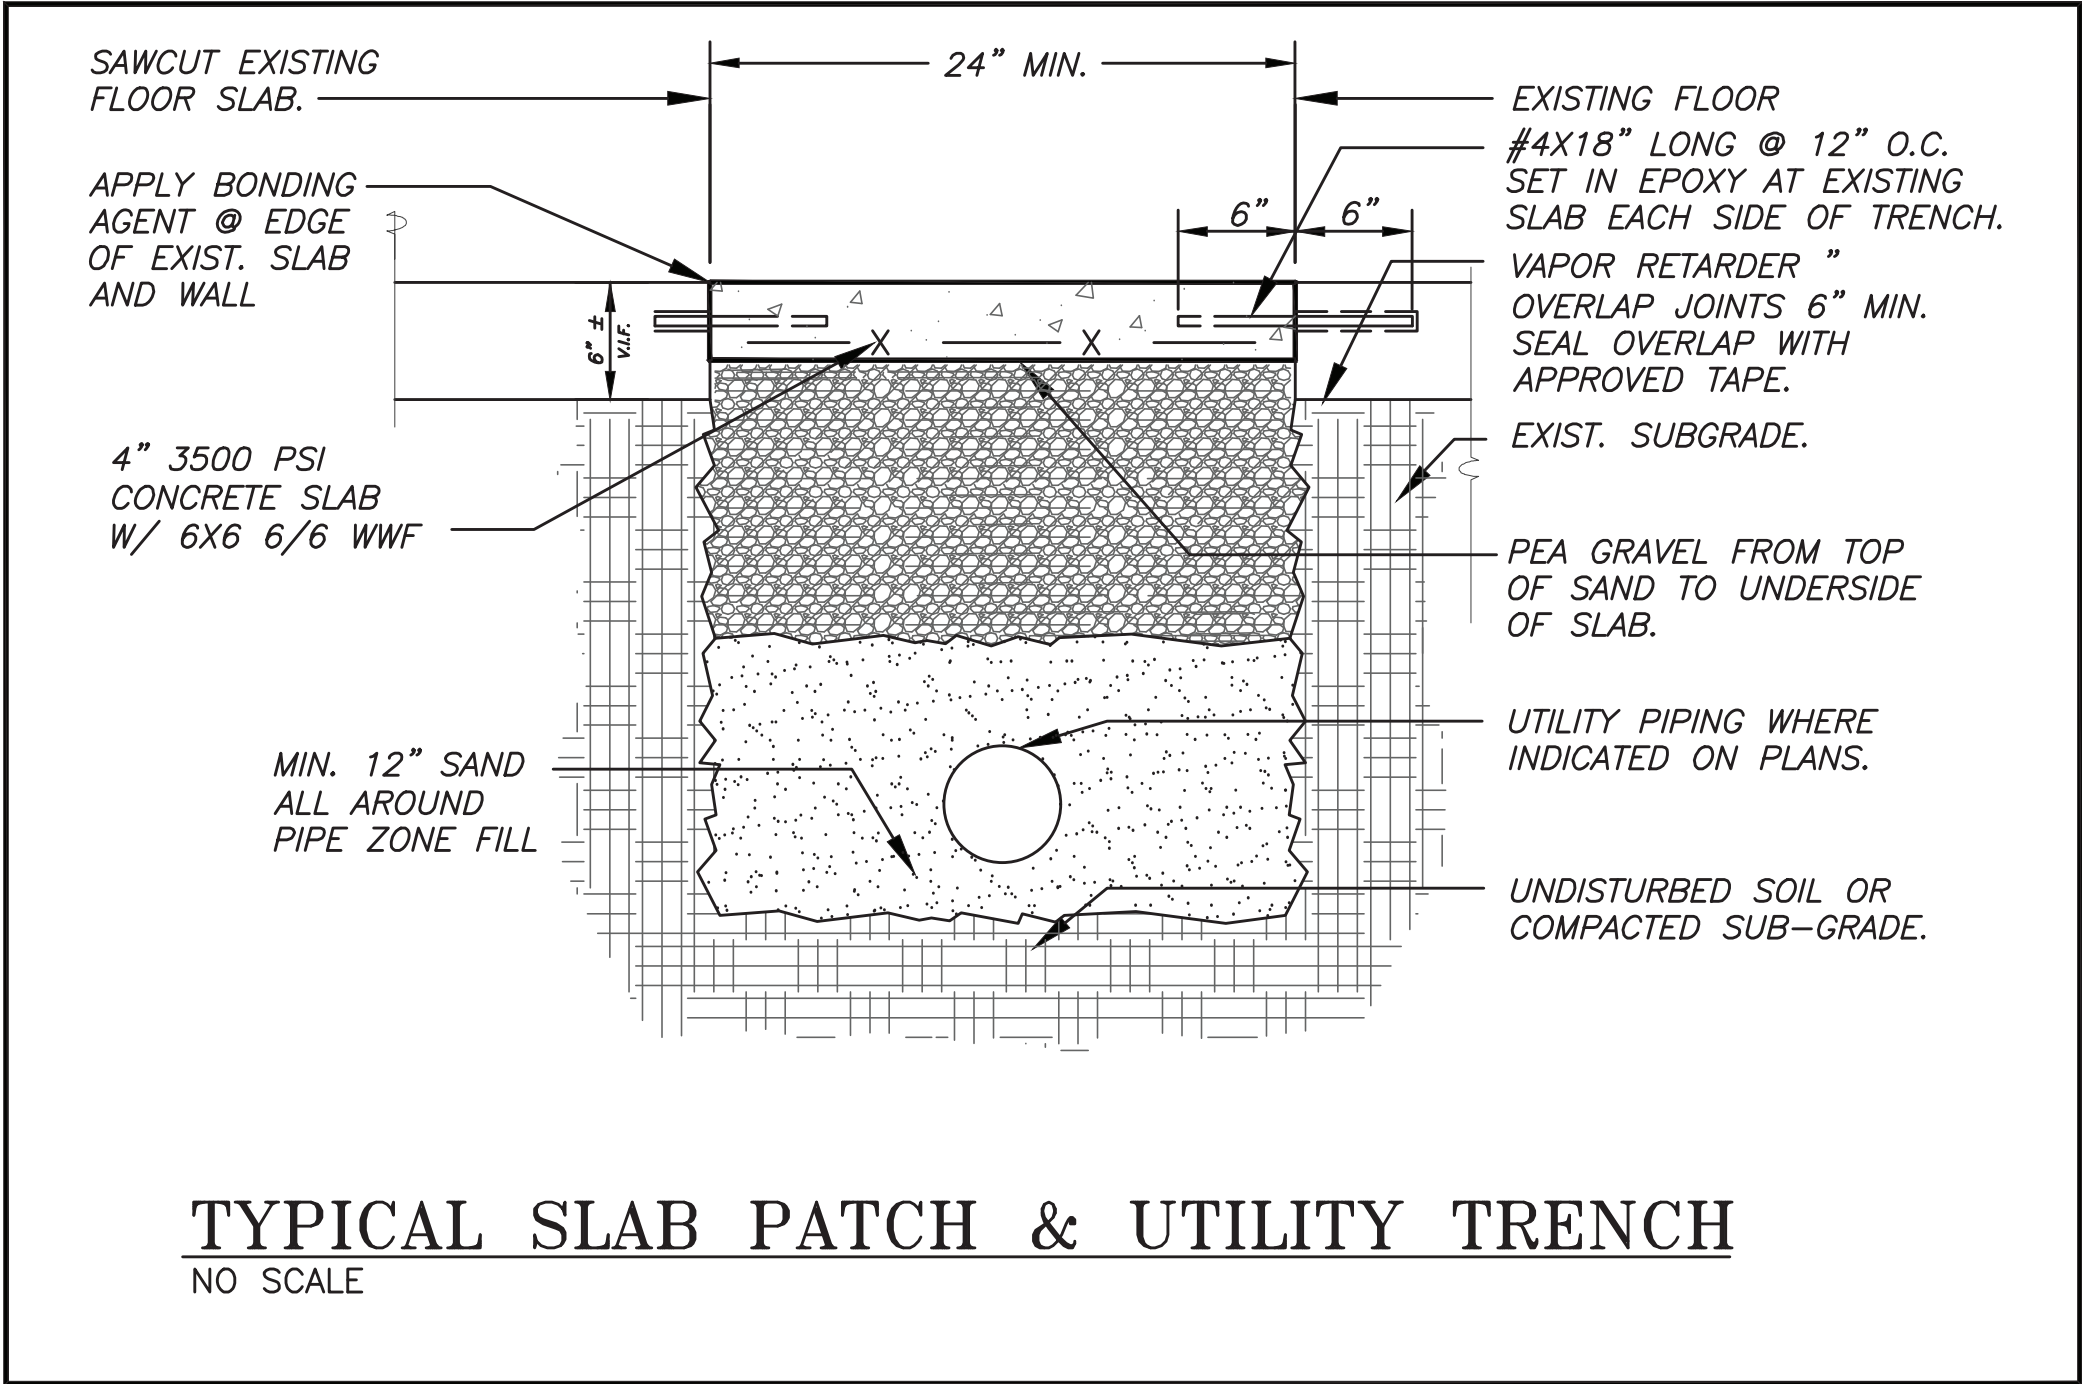

PLUMBING EQUIPMENT SCHEDULE

ED-1	FLOOR DRAIN: ZURN MODEL #ZN-415-P, W/TYP 'B' STRAINER, 3" OUTLET, CAST IRON W/ 1/2" PRIMER TAP CONNECTION.
FS-1	FLOOR SINK: ZURN MODEL Z1752-NH4-Y-2, 12"x12" SQUARE TOP, 10" SUMP DEPTH, TYPE 304 STAINLESS STEEL LIGHT-DUTY SANI-FLOW RECEPTOR WITH NON-TILT, LOOSE SET FULL GRATE WITH 1/2" SQUARE OPENINGS AND ANTI-SPLASH STAINLESS STEEL INTERIOR DOME STRAINER
EQO	FLOOR CLEANOUT: ZURN MODEL #Z-1440-ZN-T, CAST IRON W/POLISHED BRONZE TOP ACCESS COVER. SIZE AS INDICATED ON DRAWINGS. INSTALL PER MANUFACTURERS RECOMMENDATIONS.
WCO	WALL CLEANOUT: ZURN MODEL #Z-1440-VP-ZN, CAST IRON W/POLISHED BRONZE TOP VANDAL PROOF ACCESS COVER. SIZE AS INDICATED ON DRAWINGS. INSTALL PER MANUFACTURERS RECOMMENDATIONS.
RPZ-1	REDUCED PRESSURE PRINCIPLE BACKFLOW PREVENTER ASSEMBLY: WATTS CO. MODEL #LP909-QT-NPT, 1", (2) QUARTER-TURN VALVES. INSTALL PER MANUFACTURERS RECOMMENDATIONS.
FDC-1	FUNNEL DRAIN: ZURN MODEL #ZN181-FS-C-SS-NH, 6" DIAMETER CORNICE DRAIN, DURA-COATED W/ZURN MODEL #Z1724, 6" DIAMETER FUNNEL, STAINLESS STEEL AND SECURING SCREWS

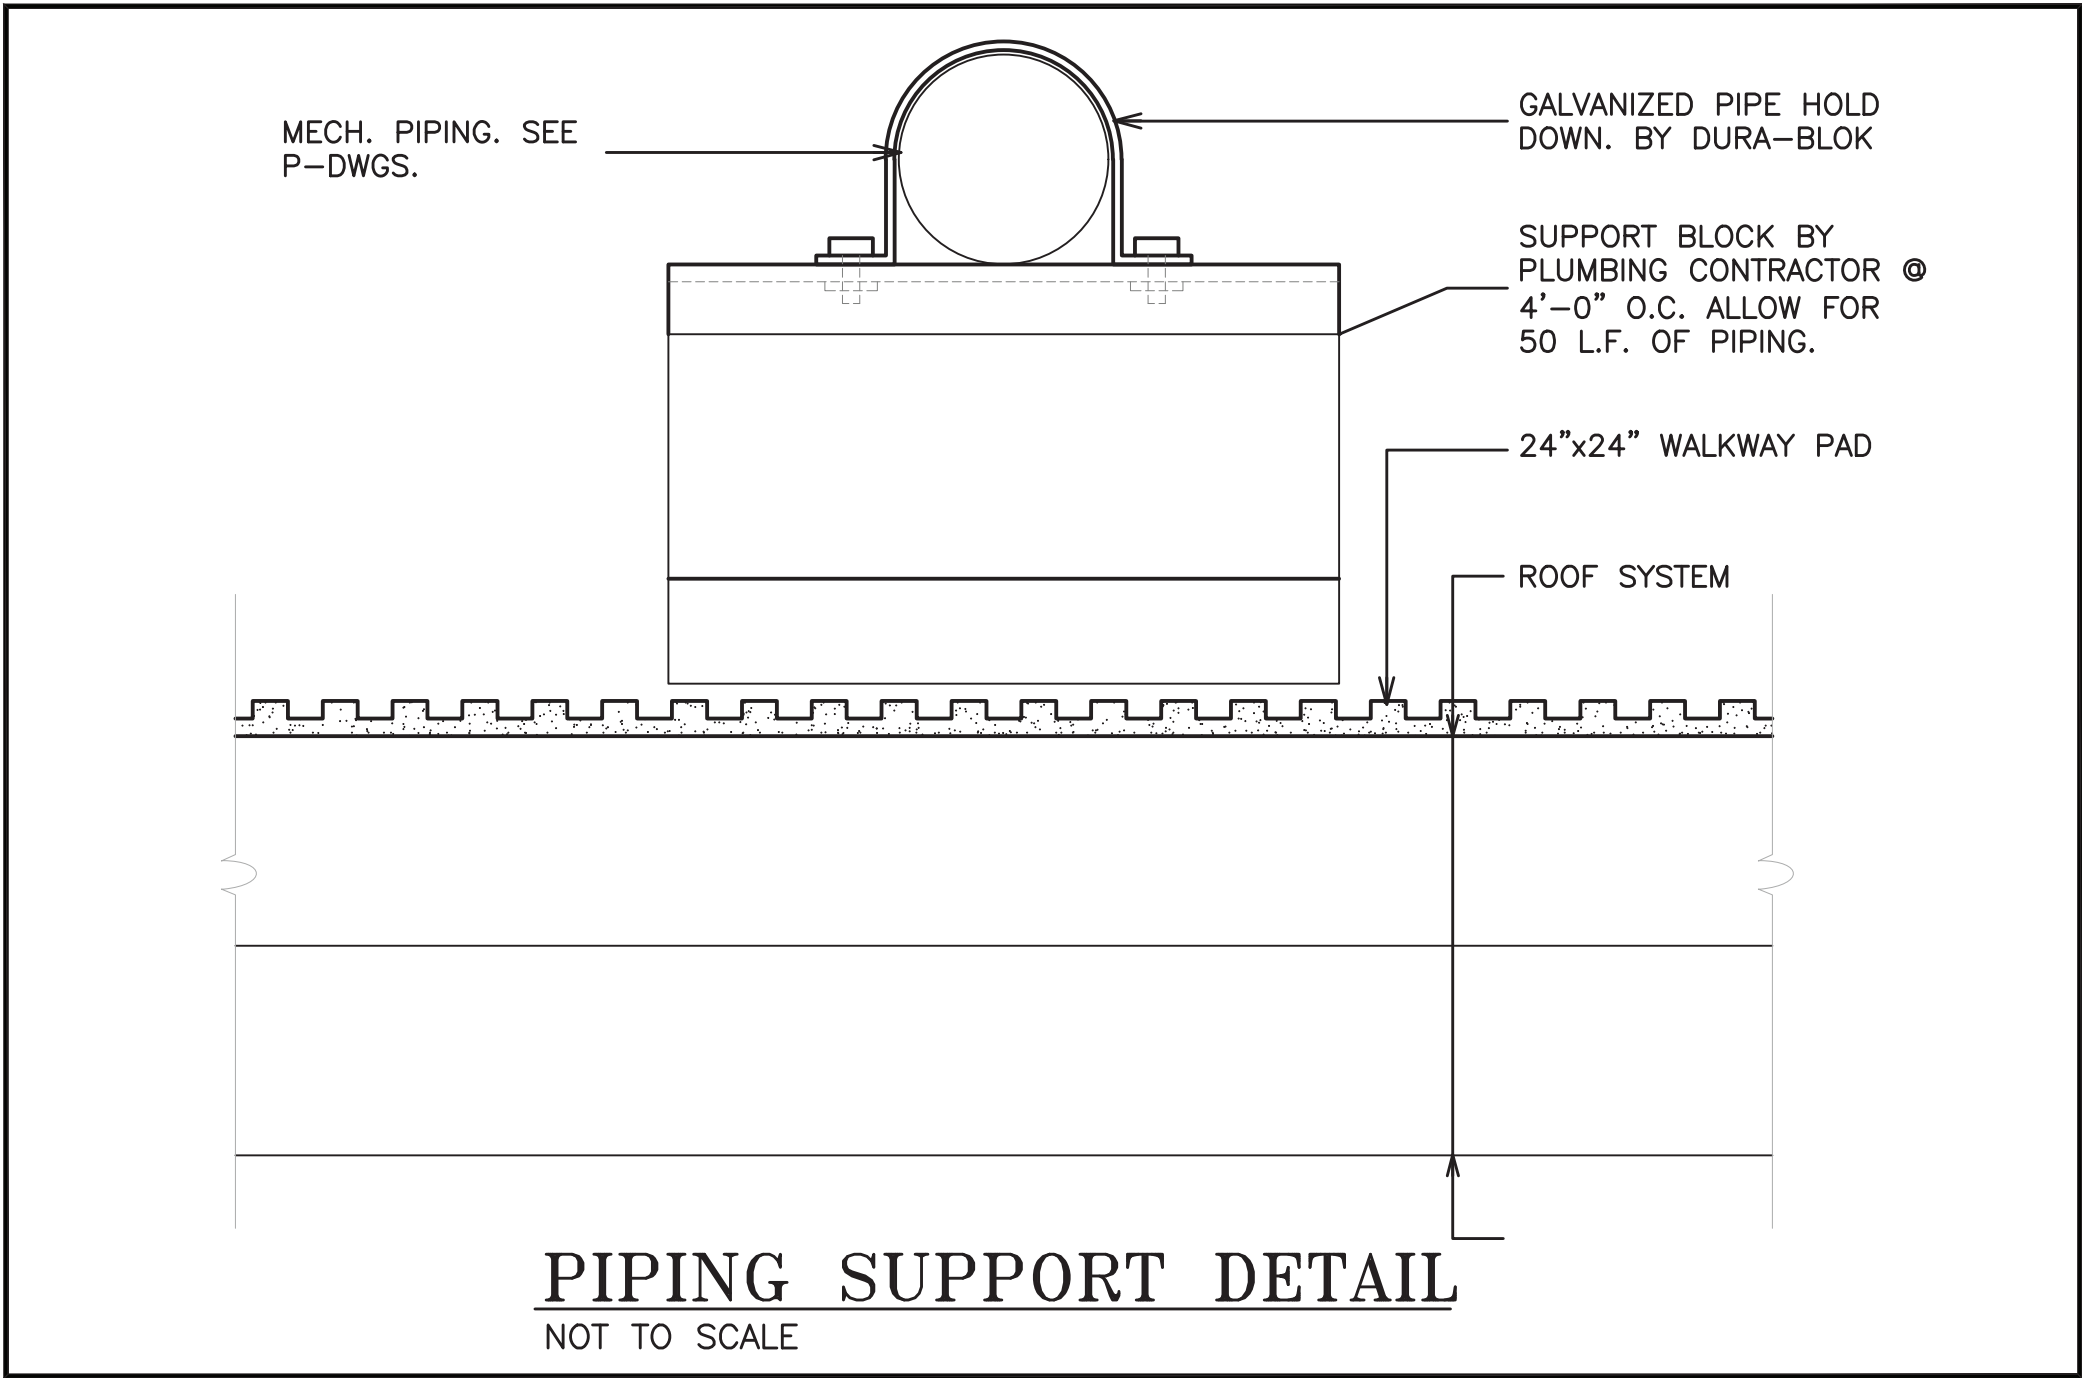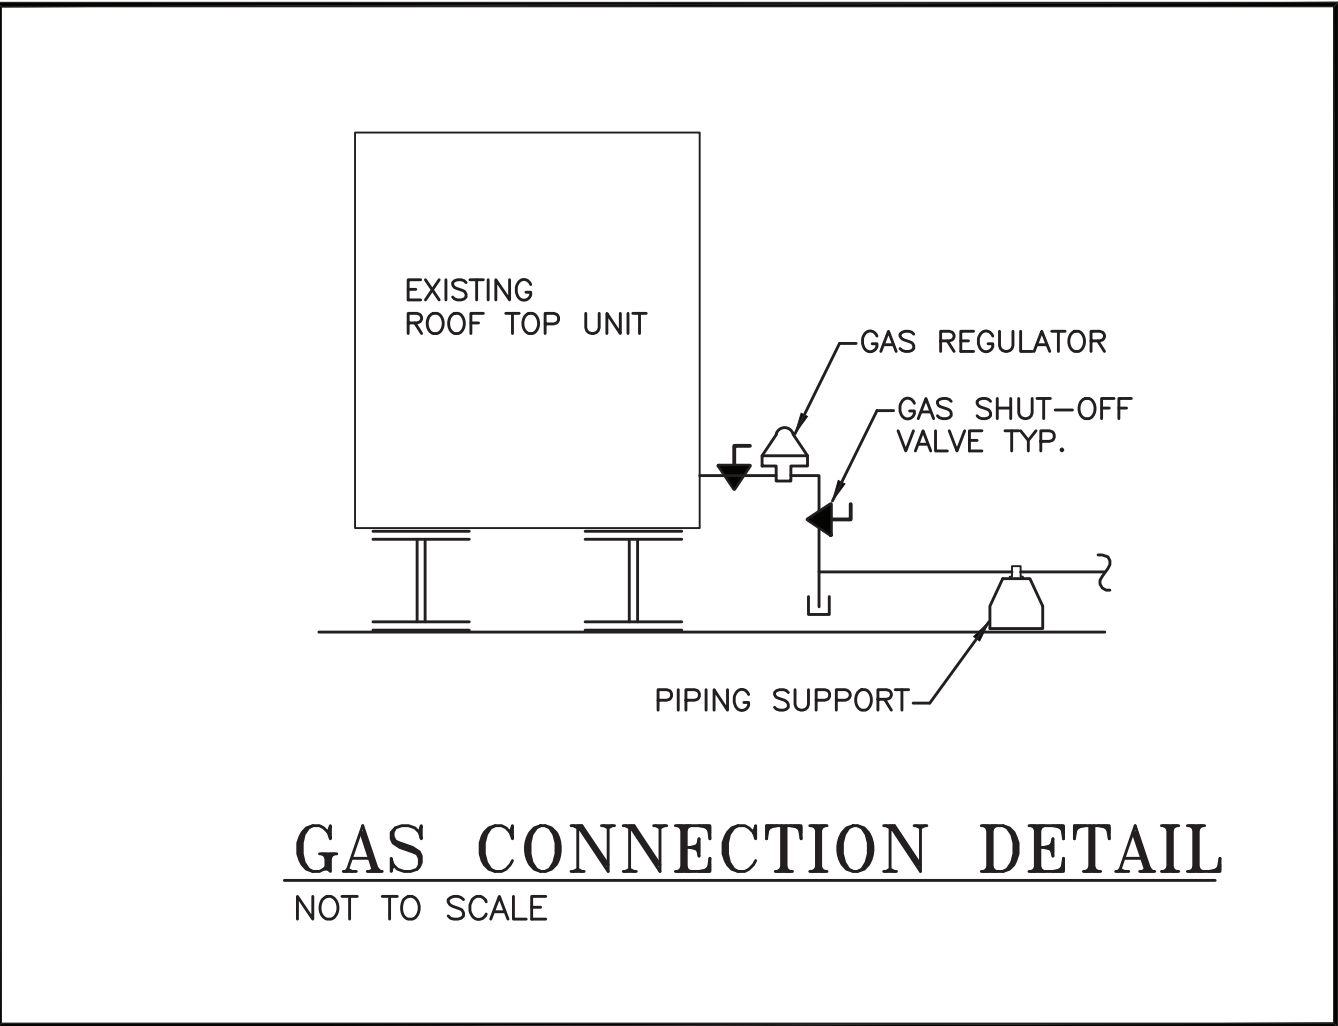

AS PER USA CONGRESS ARCHITECTURAL WORKS COPYRIGHT PROTECTION ACT OF 1990 ALL IDEAS AND DESIGNS INCLUDING DERIVATIVES THEREOF, ALL DRAWINGS AND SPECIFICATIONS CONSTITUTE THE ORIGINAL COPYRIGHT WORK BY FULLER AND D'ANGELO, P.C. (F&D). THE DRAWINGS AND SPECIFICATIONS AS INSTRUMENTS OF SERVICE BY F&D ARE CREATED BY F&D FOR THIS PROJECT ONLY AND REMAIN THE PROPERTY OF F&D. ANY REPRODUCTION WITHOUT THE PRIOR CONSENT OF F&D IS PROHIBITED.

48 INGLEWOOD ROAD
ELMWOOD NEW YORK 10823
TEL 914-898-4444 FAX 914-898-1717
WWW.FULLERDANGELO.COM
Copyright 2021 by Fuller & Angelo, P.C.

FULLER
D'ANGELO
P.C.
ARCHITECTS
PLANNERS


LFG
LANDMARK
FACILITIES
GROUP, INC.
252 East Avenue
SEELY PLACE
(203) 866-4628 FAX
(203) 866-4019 Fax

S.E.D. CONTROL NUMBER:
GREENVILLE ELEMENTARY SCHOOL
66-04-06-03-0-008-021
SEELY PLACE ELEMENTARY SCHOOL
66-04-06-03-0-001-019


PROJECT:
EDGEMONT SCHOOL DISTRICT
GREENVILLE ELEMENTARY SCHOOL
SEELY PLACE ELEMENTARY SCHOOL
PHASE 1 - HVAC & CATERIA

DRAWING TITLE:
PLUMBING SYMBOLS,
ABBREVIATIONS, SCHEDULES
& DETAILS


1-06-2023	BID
DATE	ISSUED TO
SHEET SIZE 30"x42"	DRAWING NO. SPES P001
SCALE AS NOTED	FILE NO. 21434.01
DRAWN BY LFG	

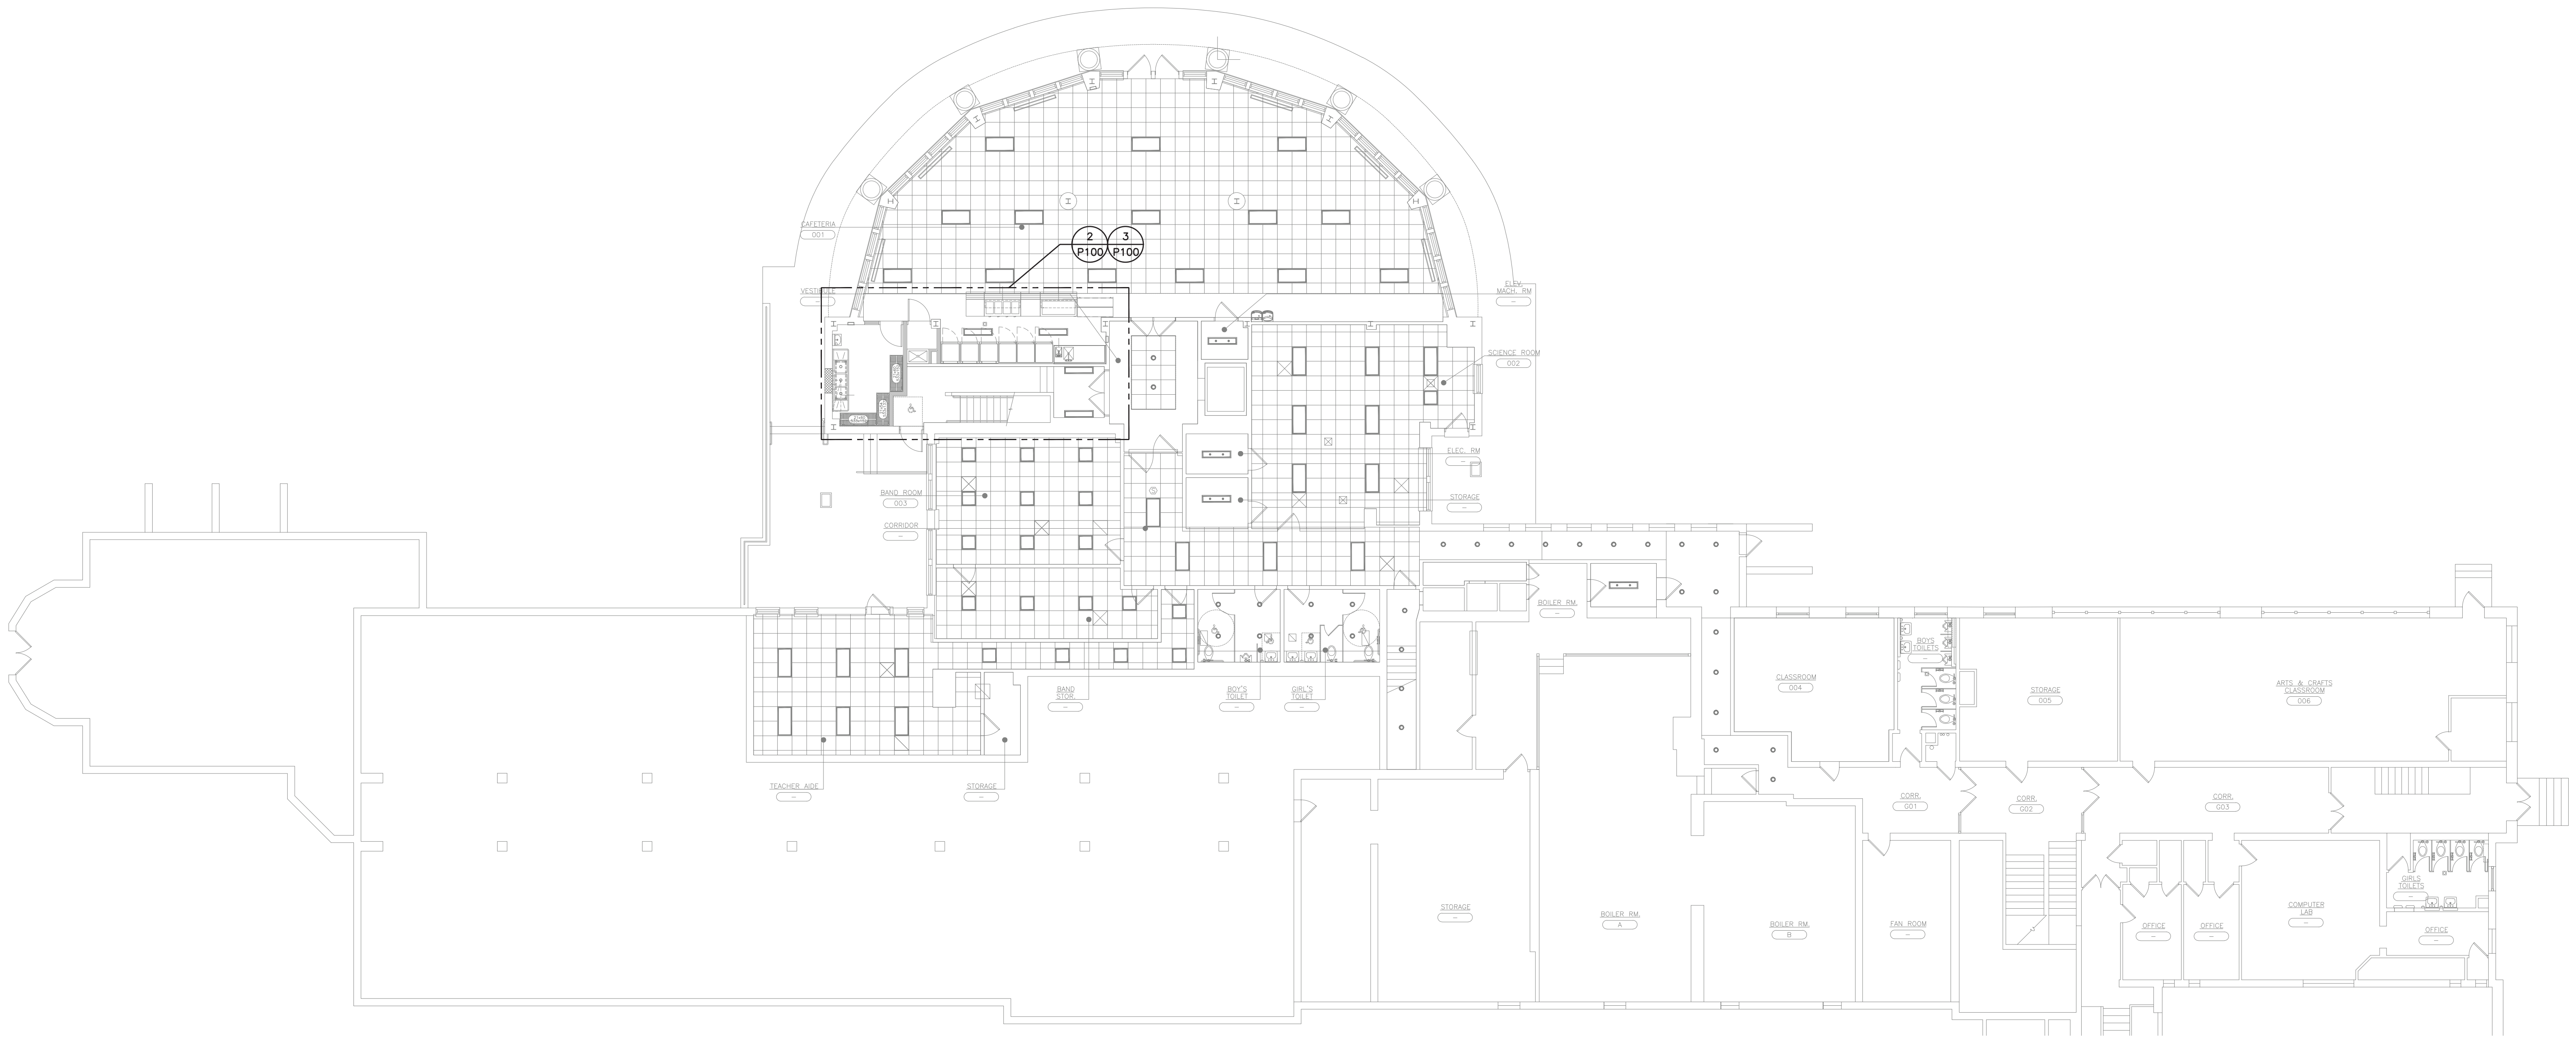

SEELY ELEMENTARY SCHOOL
LOWER LEVEL PLUMBING PLAN
1 SCALE: 3/32" = 1'-0"

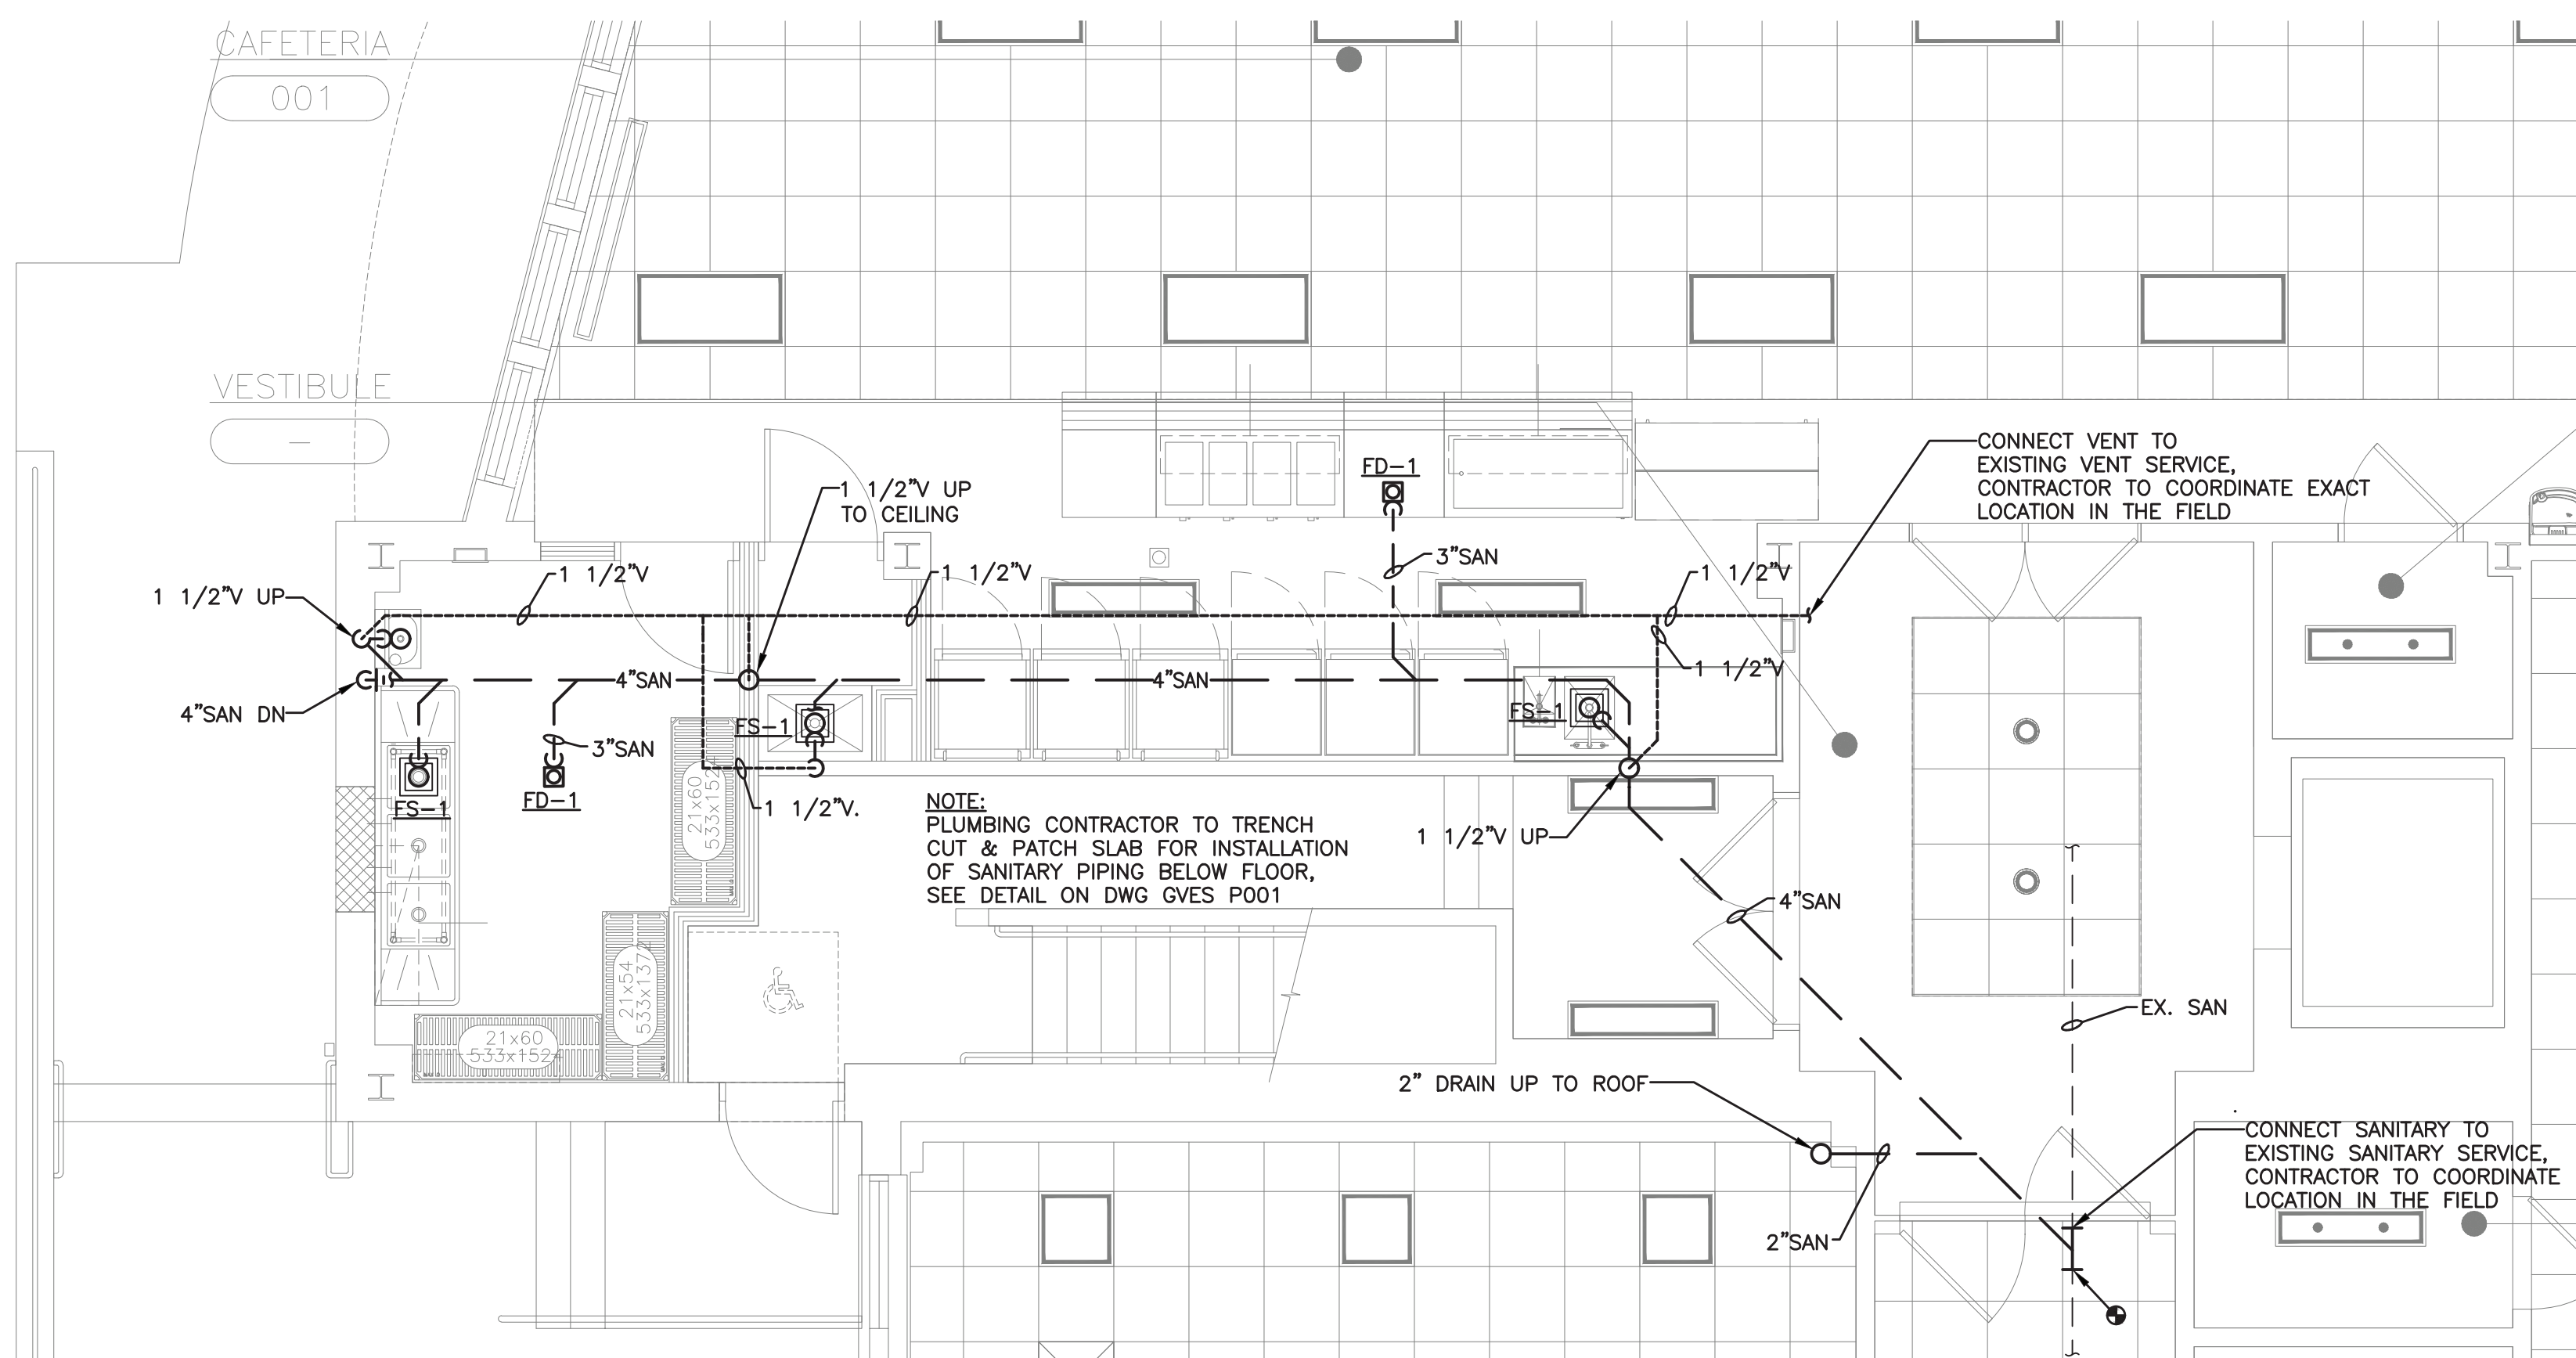

SEELY ELEMENTARY SCHOOL PART
LOWER LEVEL SANITARY & VENT PLUMBING PLAN
2 SCALE: 1/4" = 1'-0"

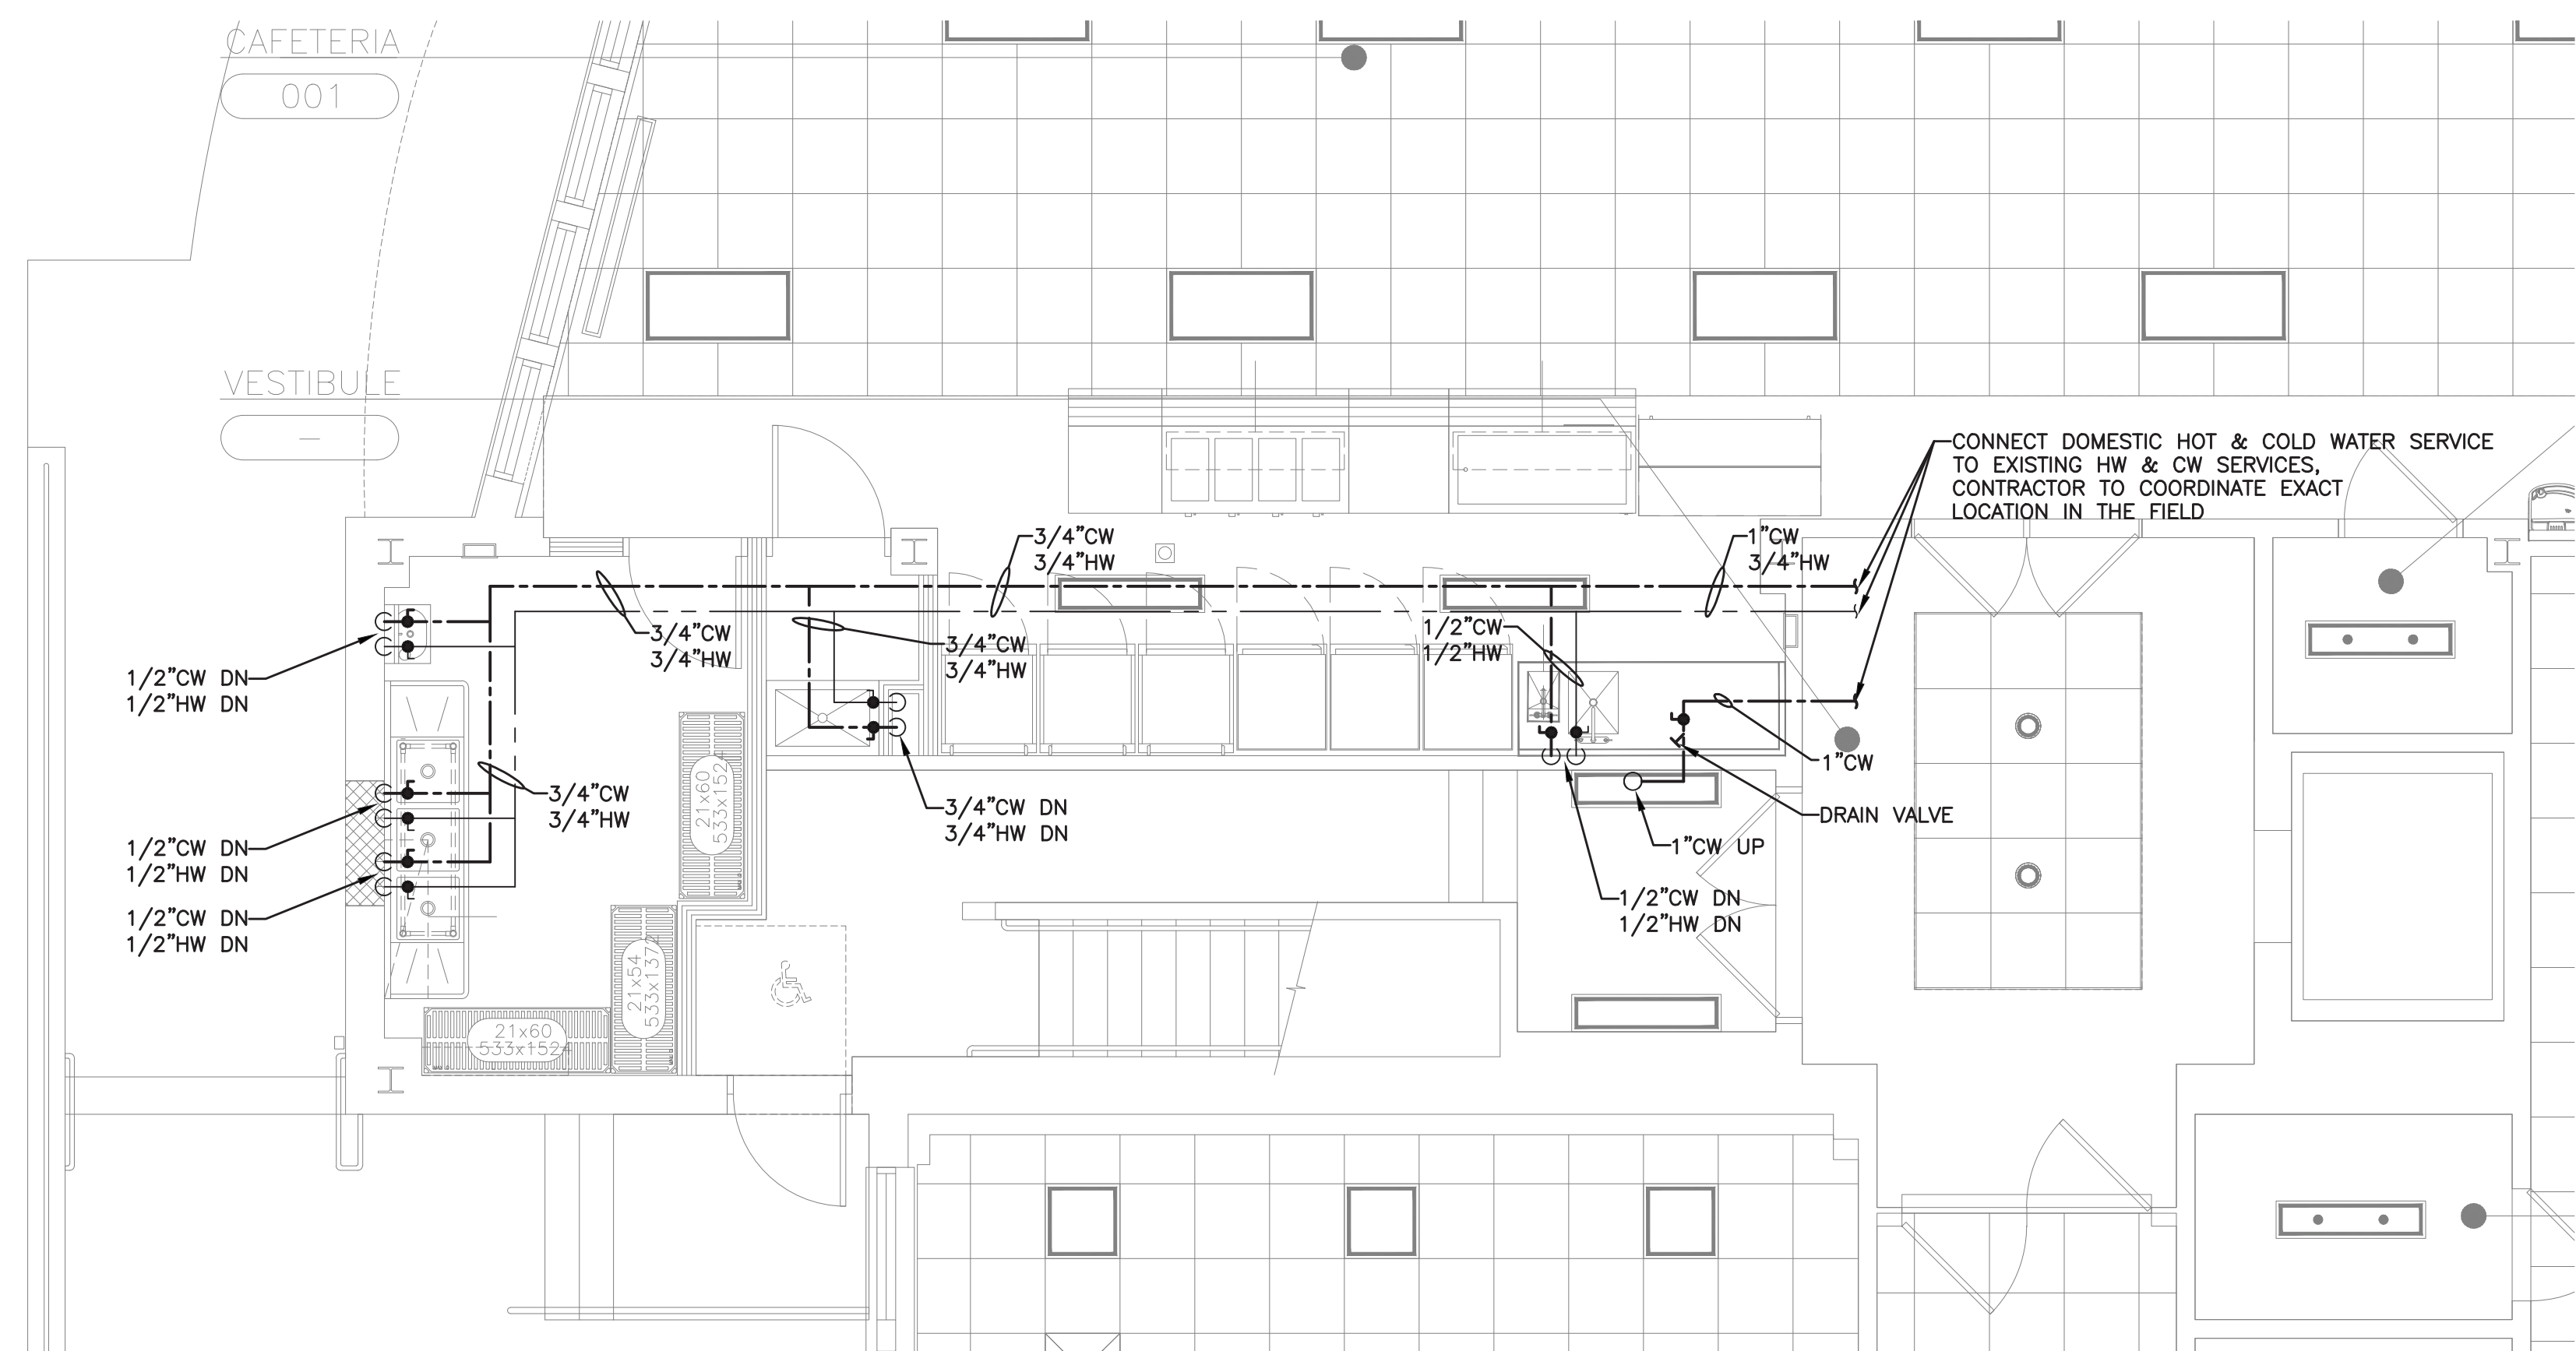

SEELY ELEMENTARY SCHOOL PART
LOWER LEVEL DOMESTIC WATER PLUMBING PLAN
3 SCALE: 1/4" = 1'-0"

PLOT DATE: December 21, 2022 3:31 pm

FILE: N:\Edgemont School District\Seely Place Elementary Phase 1\ACAD\Plumbing\SPES_Plumbing...dwg

AS PER USA CONGRESS ARCHITECTURAL WORKS COPYRIGHT PROTECTION ACT OF 1990 ALL IDEAS AND DESIGNS INCLUDING DERIVATIVES THEREOF, ALL DRAWINGS AND SPECIFICATIONS CONSTITUTE THE ORIGINAL COPYRIGHT WORK BY FULLER AND DANKELO, P.C. (F&D). THE DRAWINGS AND SPECIFICATIONS AS INSTRUMENTS OF SERVICE BY F&D ARE CREATED BY F&D FOR THIS PROJECT ONLY AND REMAIN THE PROPERTY OF F&D. ANY REPRODUCTION WITHOUT THE PRIOR CONSENT OF F&D IS PROHIBITED.

438 SHILLWOOD ROAD ELLENFIELD NEW YORK 10883
TEL 914-888-4444 FAX 914-888-1917
Copyright 2001 by Fuller and Dankelo, P.C.


FULLER
DANKELO
P.C.
ARCHITECTS
PLANNERS

LFG
LANDMARK
FACILITIES
GROUP, INC.
252 East Avenue
New York, NY 10002
(212) 666-6200
(212) 666-6019 Fax

S.E.D. CONTROL NUMBER:
GREENVILLE ELEMENTARY SCHOOL
66-04-06-03-008-021
SEELY PLACE ELEMENTARY SCHOOL
66-04-06-03-001-019


PROJECT NAME:
EDGEMONT SCHOOL DISTRICT
GREENVILLE ELEMENTARY SCHOOL
SEELY PLACE ELEMENTARY SCHOOL
PHASE 1 - HVAC & CAFETERIA
DRAWING TITLE:
BASEMENT PLUMBING PLANS

1-06-2023	BID
DATE	ISSUED TO
SHEET SIZE 30"x42"	DRAWING NO. SPES P100
SCALE AS NOTED	FILE NO. 21434.01
DRAWN BY LFG	

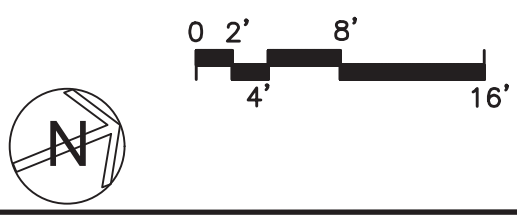


PLOT DATE: December 21, 2022 - 2:49pm

FILE: N:\Edgemont School District\Seely Place Elementary Phase 1\ACAD\Plumbing\SPES_Plumbing...dwg

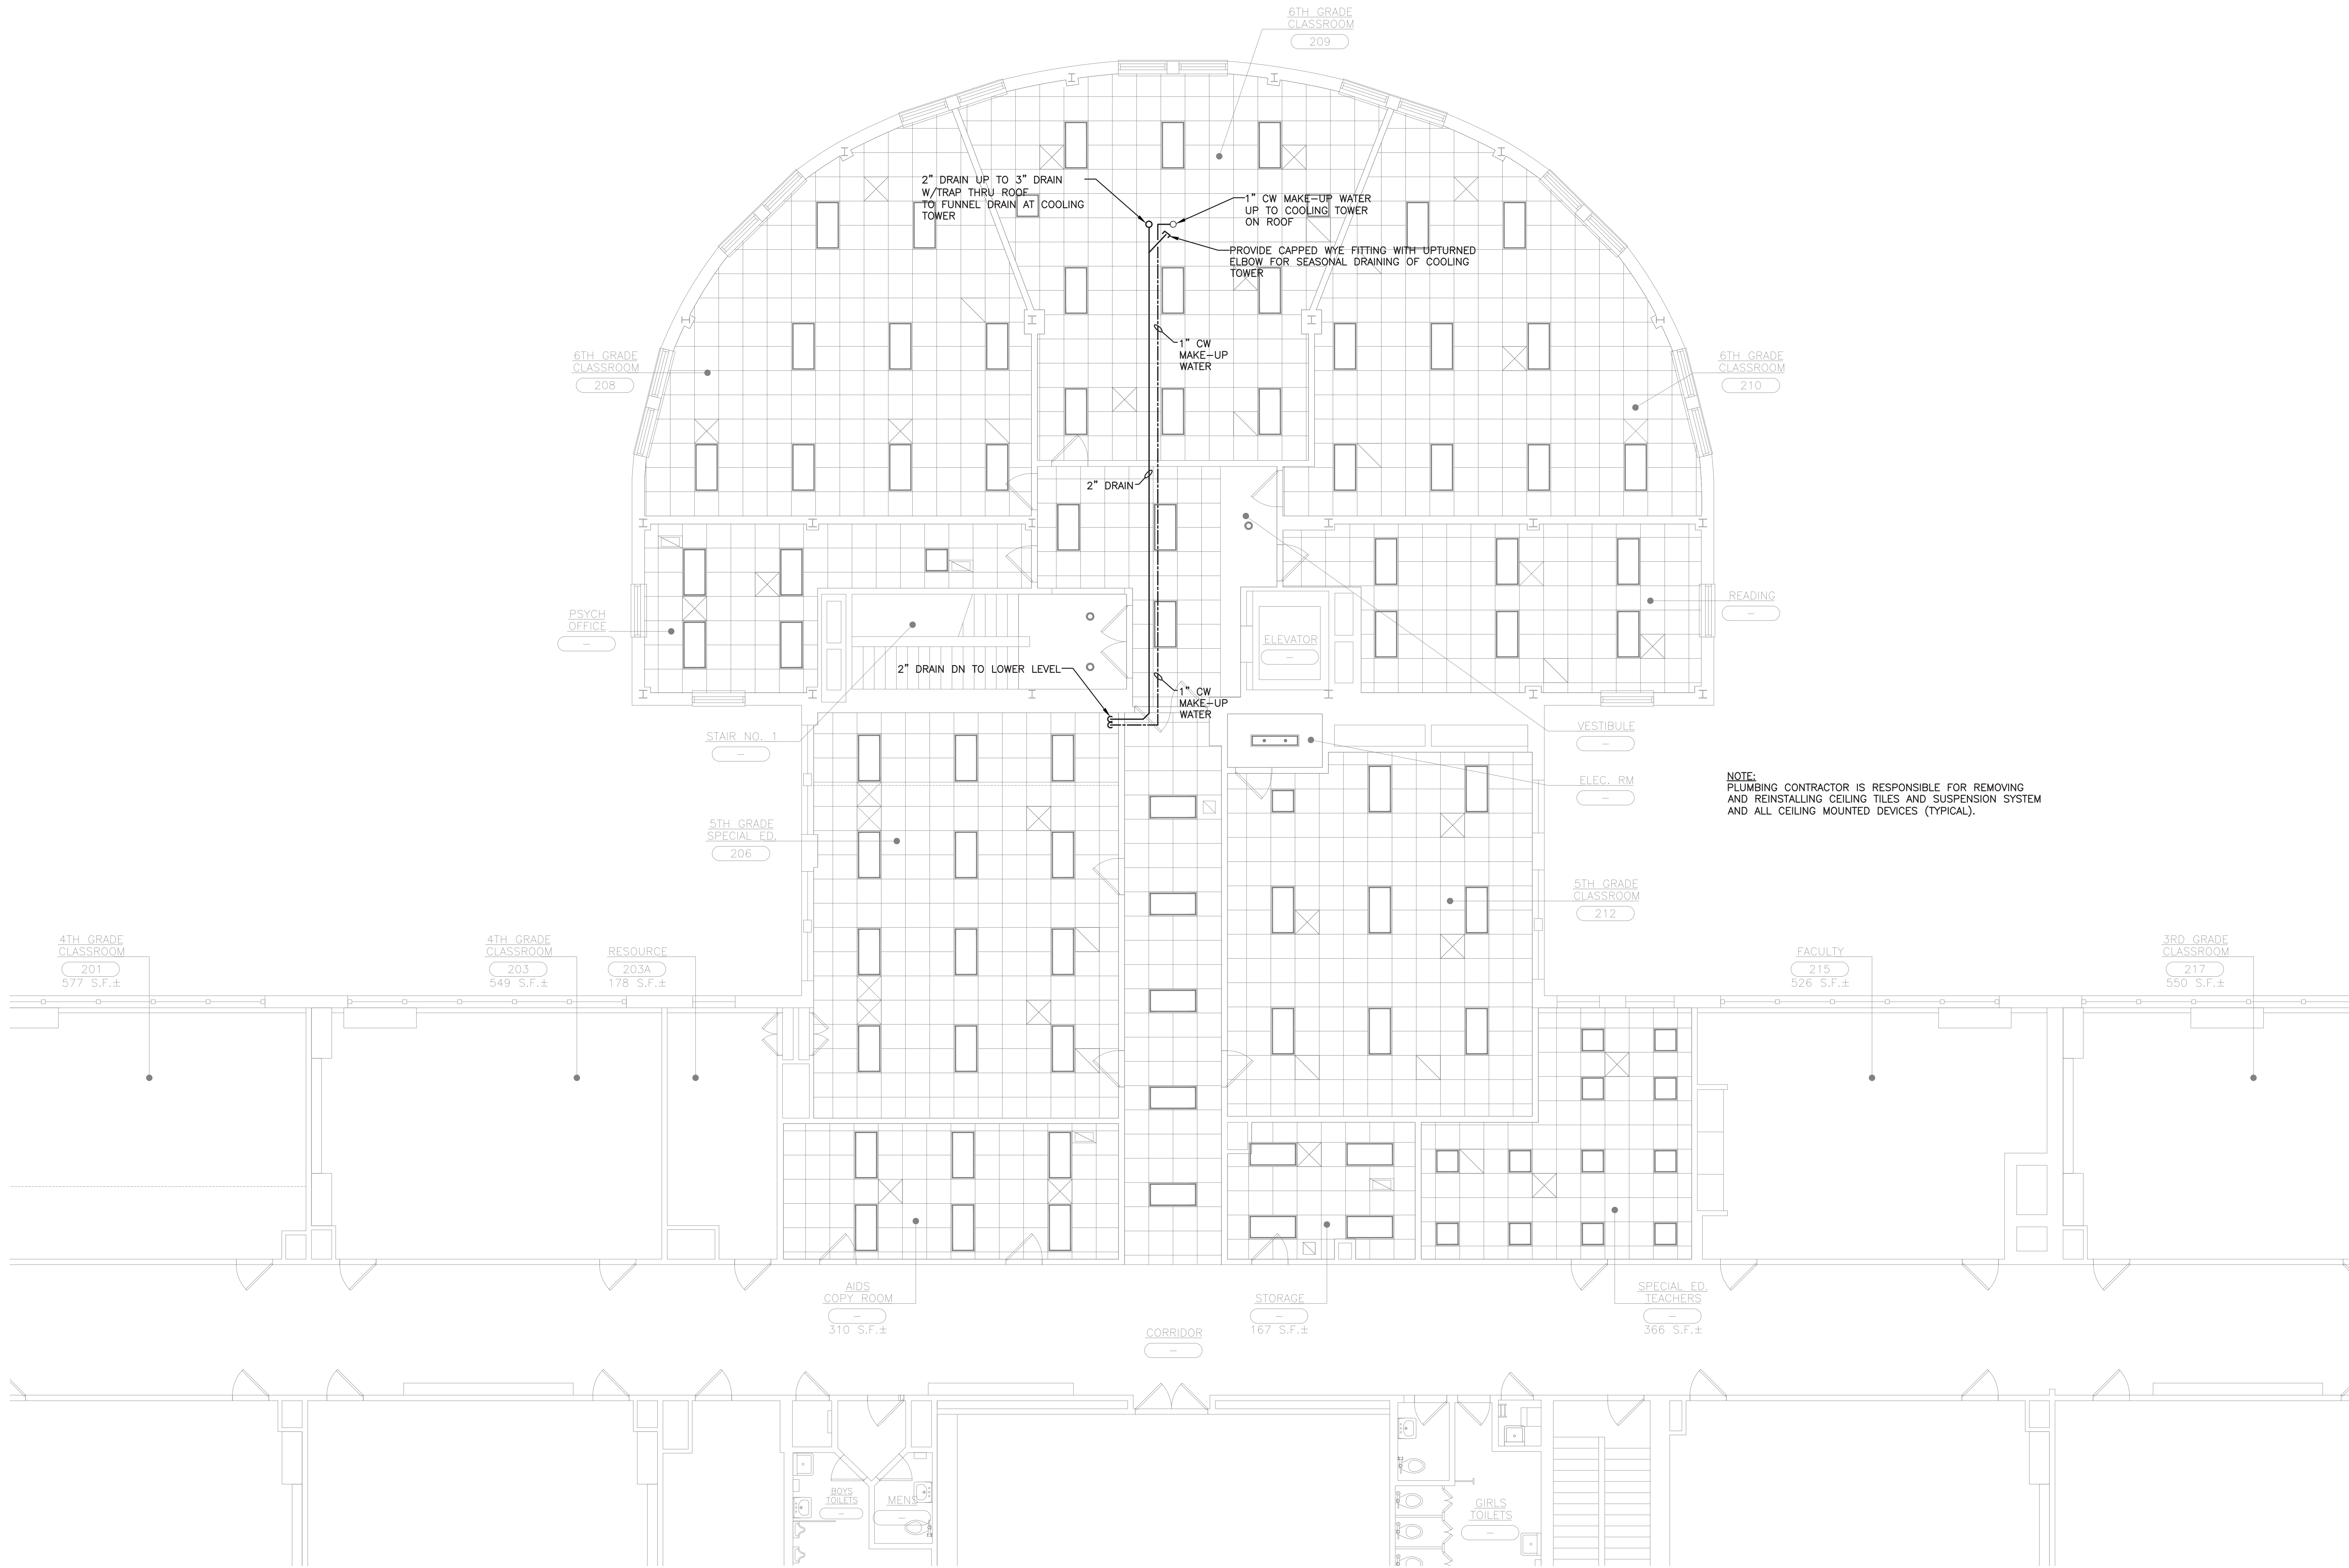

SEELY ELEMENTARY SCHOOL PART
2 SECOND FLOOR PLUMBING PLAN
SCALE: 3/16" = 1'-0"

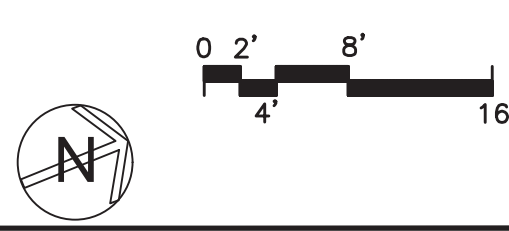

AS PER USA CONGRESS ARCHITECTURAL WORKS COPYRIGHT PROTECTION ACT OF 1990 ALL IDEAS AND DESIGNS INCLUDING DERIVATIVES THEREOF, ALL DRAWINGS AND SPECIFICATIONS CONSTITUTE THE ORIGINAL COPYRIGHT WORK BY FULLER AND DANIELO, P.C. (F&D). THE DRAWINGS AND SPECIFICATIONS AS INSTRUMENTS OF SERVICE BY F&D ARE CREATED BY F&D FOR THIS PROJECT ONLY AND REMAIN THE PROPERTY AND PROPERTY OF F&D. ANY REPRODUCTION WITHOUT THE PRIOR CONSENT OF F&D IS PROHIBITED.


FULLER
DANIELO
P.C.
ARCHITECTS
PLANNERS

LFG
LANDMARK
FACILITIES
GROUP, INC.
252 East Avenue
Greenville, SC 29605
(253) 866-4028
(253) 866-4019 fax


S.E.D. CONTROL NUMBER:
GREENVILLE ELEMENTARY SCHOOL
66-04-06-03-0-001-021
SEELY PLACE ELEMENTARY SCHOOL
66-04-06-03-0-001-019

PROJECT:
EDGEMONT SCHOOL DISTRICT
GREENVILLE ELEMENTARY SCHOOL
SEELY PLACE ELEMENTARY SCHOOL
PHASE 1 - HVAC & CATERIA
DRAWING TITLE:
SECOND FLOOR PLUMBING PLANS


1-06-2023	BID
DATE	ISSUED TO
SHEET SIZE 30"x42"	DRAWING NO. SPES P101
SCALE AS NOTED	FILE NO. 21434.01
DRAWN BY LFG	

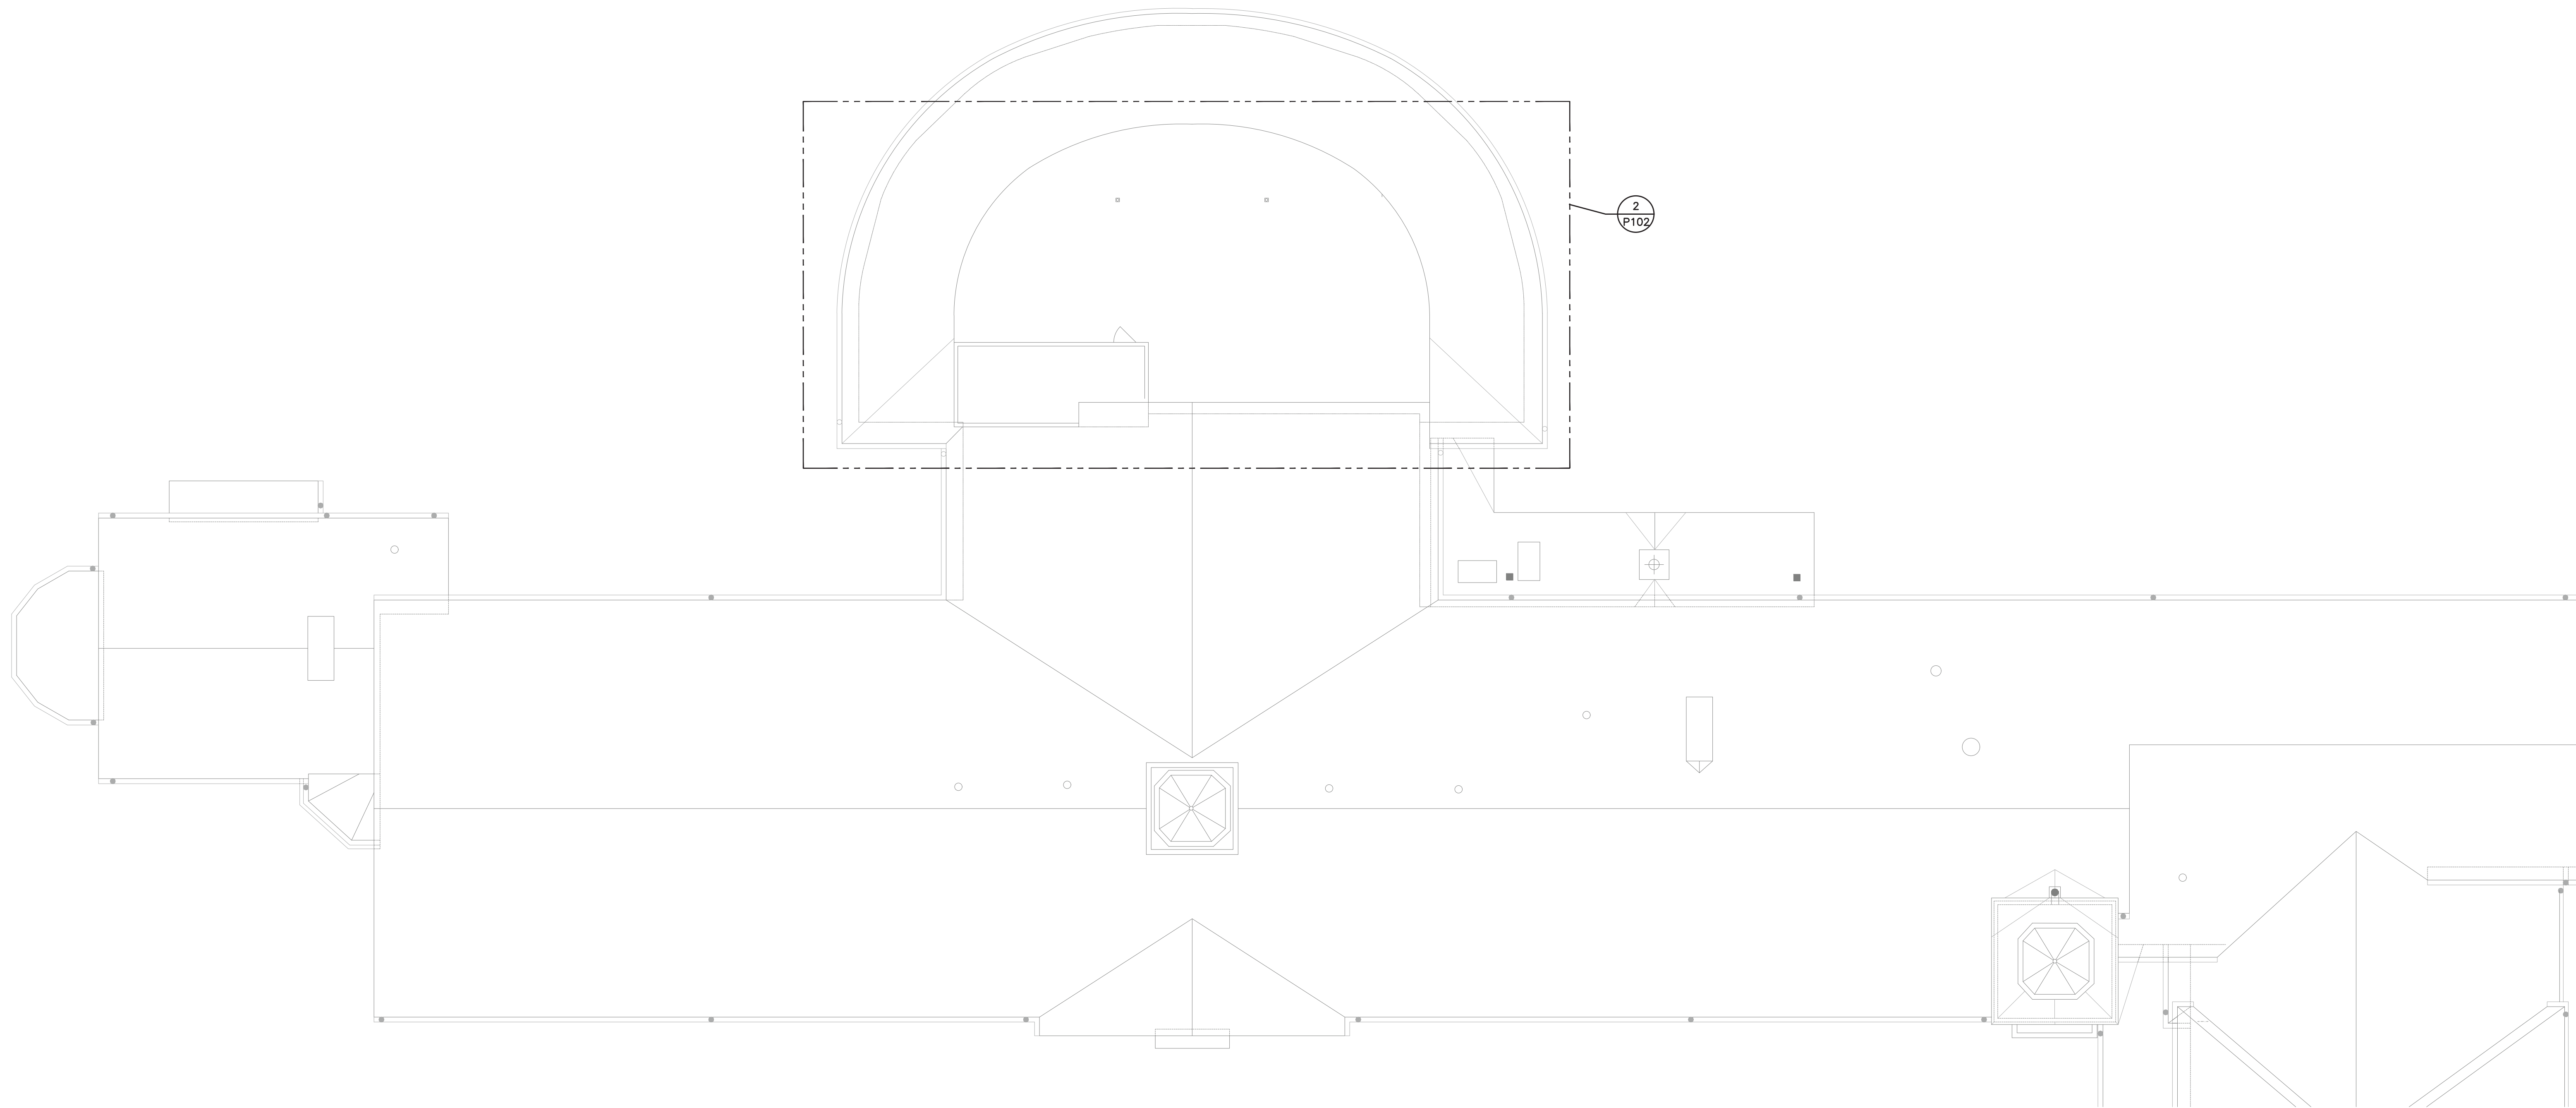

1 SEELY ELEMENTARY SCHOOL
ROOF PLUMBING PLAN
SCALE: 3/32" = 1'-0"

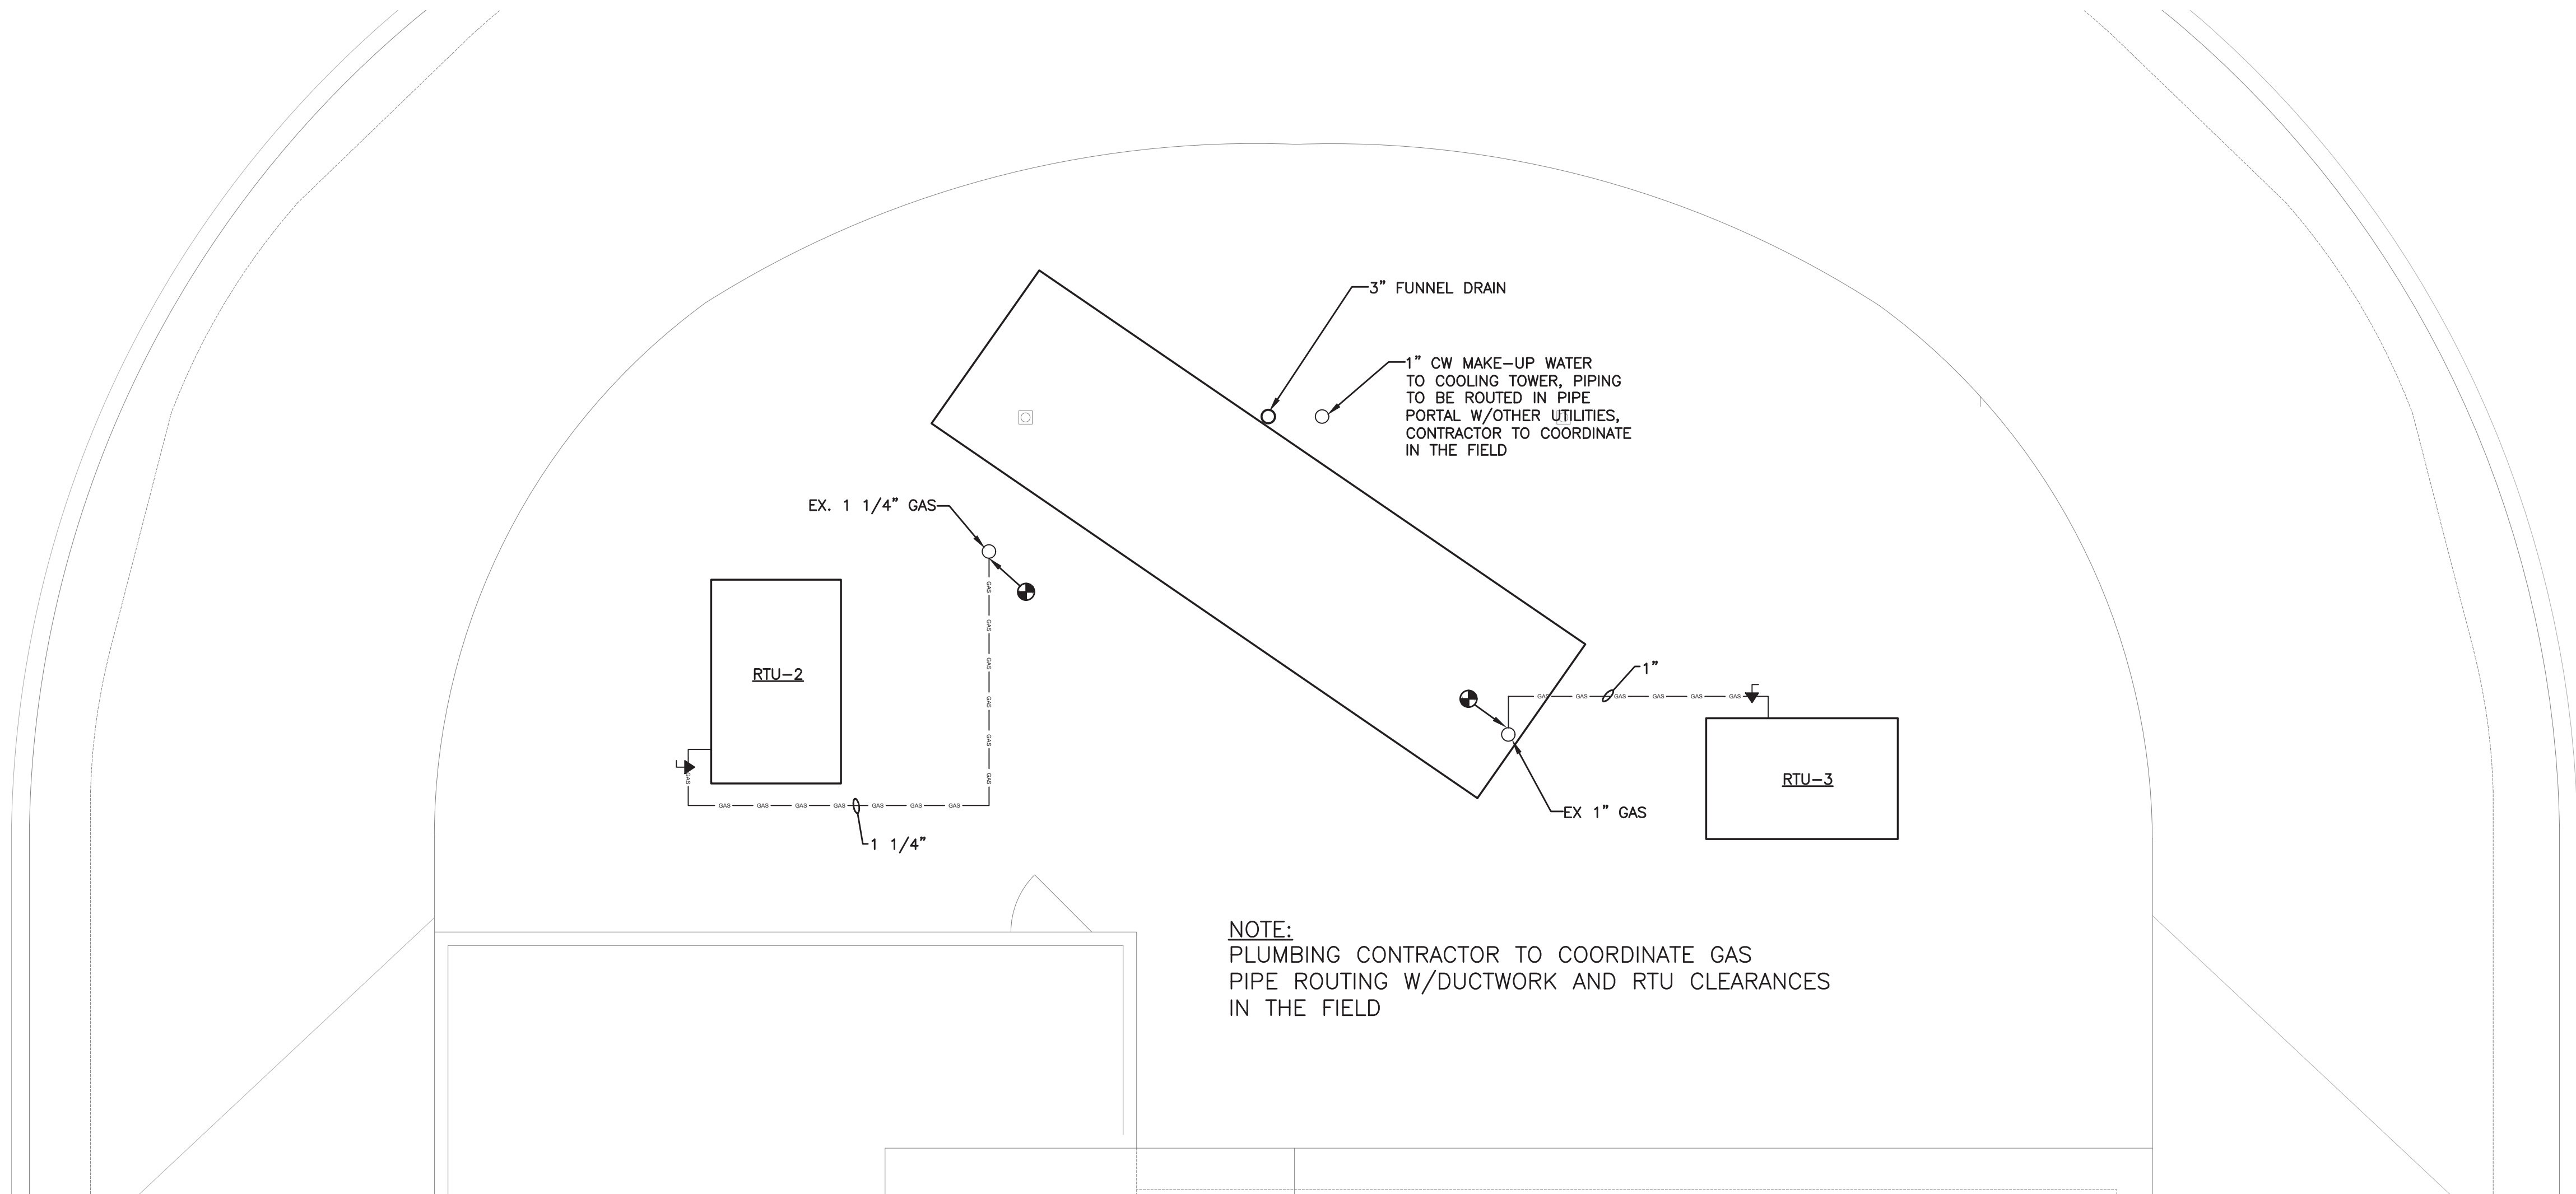

2 SEELY ELEMENTARY SCHOOL PART
ROOF PLUMBING PLAN
SCALE: 1/4" = 1'-0"

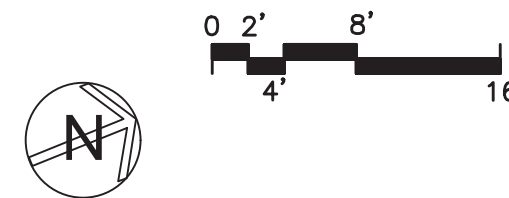

PLOT DATE: December 21, 2022 - 2:50pm

FILE: N:\Edgemont School District\Seely Place Elementary Phase 1\ACAD\Plumbing\SPES_Plumbing...dwg

AS PER USA CONGRESS ARCHITECTURAL WORKS COPYRIGHT PROTECTION ACT OF 1990 ALL IDEAS AND DESIGNS INCLUDING DERIVATIVES THEREOF, ALL DRAWINGS AND SPECIFICATIONS CONSTITUTE THE ORIGINAL COPYRIGHT WORK BY FULLER AND D'ANGELO, P.C. (F&D). THE DRAWINGS AND SPECIFICATIONS AS INSTRUMENTS OF SERVICE BY F&D ARE CREATED BY F&D FOR THIS PROJECT ONLY AND REMAIN THE PROPERTY OF F&D. ANY REPRODUCTION WITHOUT THE PRIOR CONSENT OF F&D IS PROHIBITED.

48 SHOLLYWOOD ROAD ELLENFIELD NEW YORK 10883
TEL 914-888-4444 FAX 914-888-1919
WWW.FULLERDANGELO.COM
Copyright 2021 by Fuller & Angelo, P.C.

FULLER
& D'ANGELO
P.C.
ARCHITECTS
PLANNERS

LFG
LANDMARK
FACILITIES
GROUP, INC.
252 East Avenue
New York, NY 10002
(212) 866-4628 FAX
(212) 866-4019 Fax

S.E.D. CONTROL NUMBER:
GREENVILLE ELEMENTARY SCHOOL
66-04-06-03-0-001-021
SEELY PLACE ELEMENTARY SCHOOL
66-04-06-03-0-001-019

PROJECT NAME:
EDGEMONT SCHOOL DISTRICT
GREENVILLE ELEMENTARY SCHOOL
SEELY PLACE ELEMENTARY SCHOOL
PHASE 1 - HVAC & CAFETERIA
DRAWING TITLE:
ROOF PLUMBING PLANS

DATE	1-06-2023	DRAWING NO.	SPES P102
SHEET SIZE	30"x42"	FILE NO.	21434.01
SCALE	AS NOTED		
DRAWN BY	LFG		